



D.2 MANSARD ROOF FRAMING DETAIL  
S300 SCALE: 1" = 1'-0"

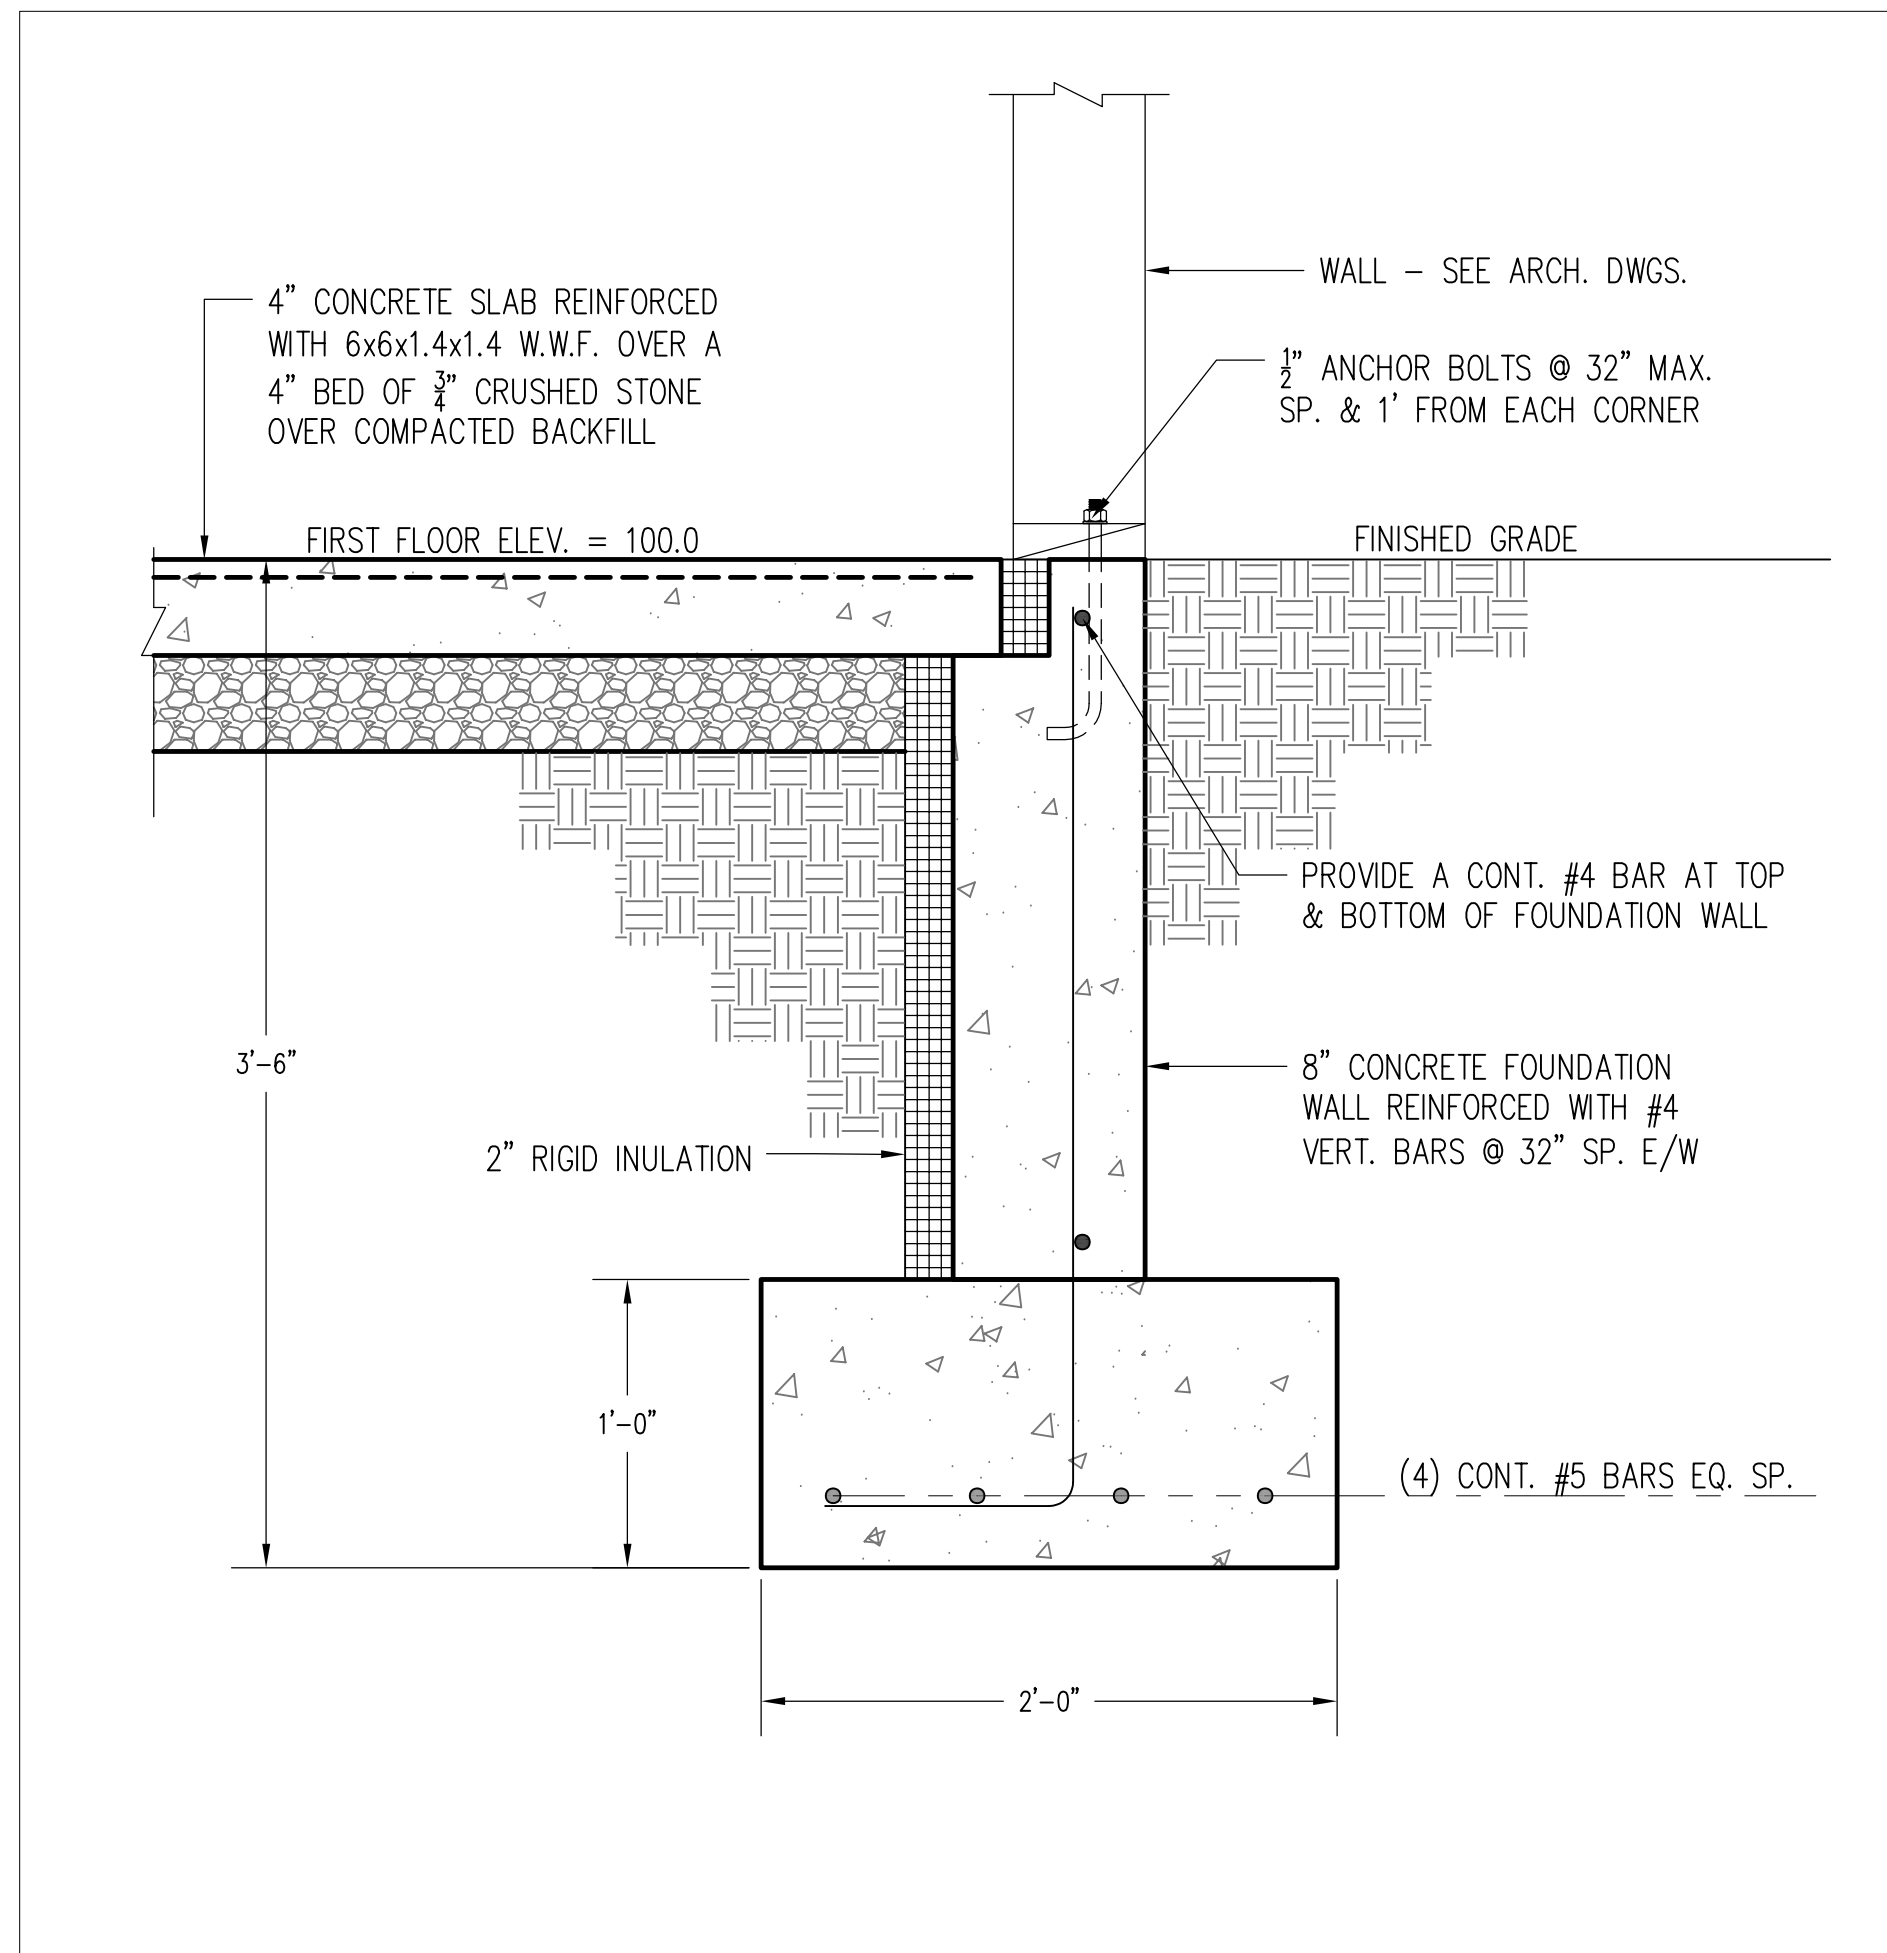

S.1 COOLING AREA FOUNDATION DETAIL  
S200 SCALE: 1-1/2" = 1'-0"

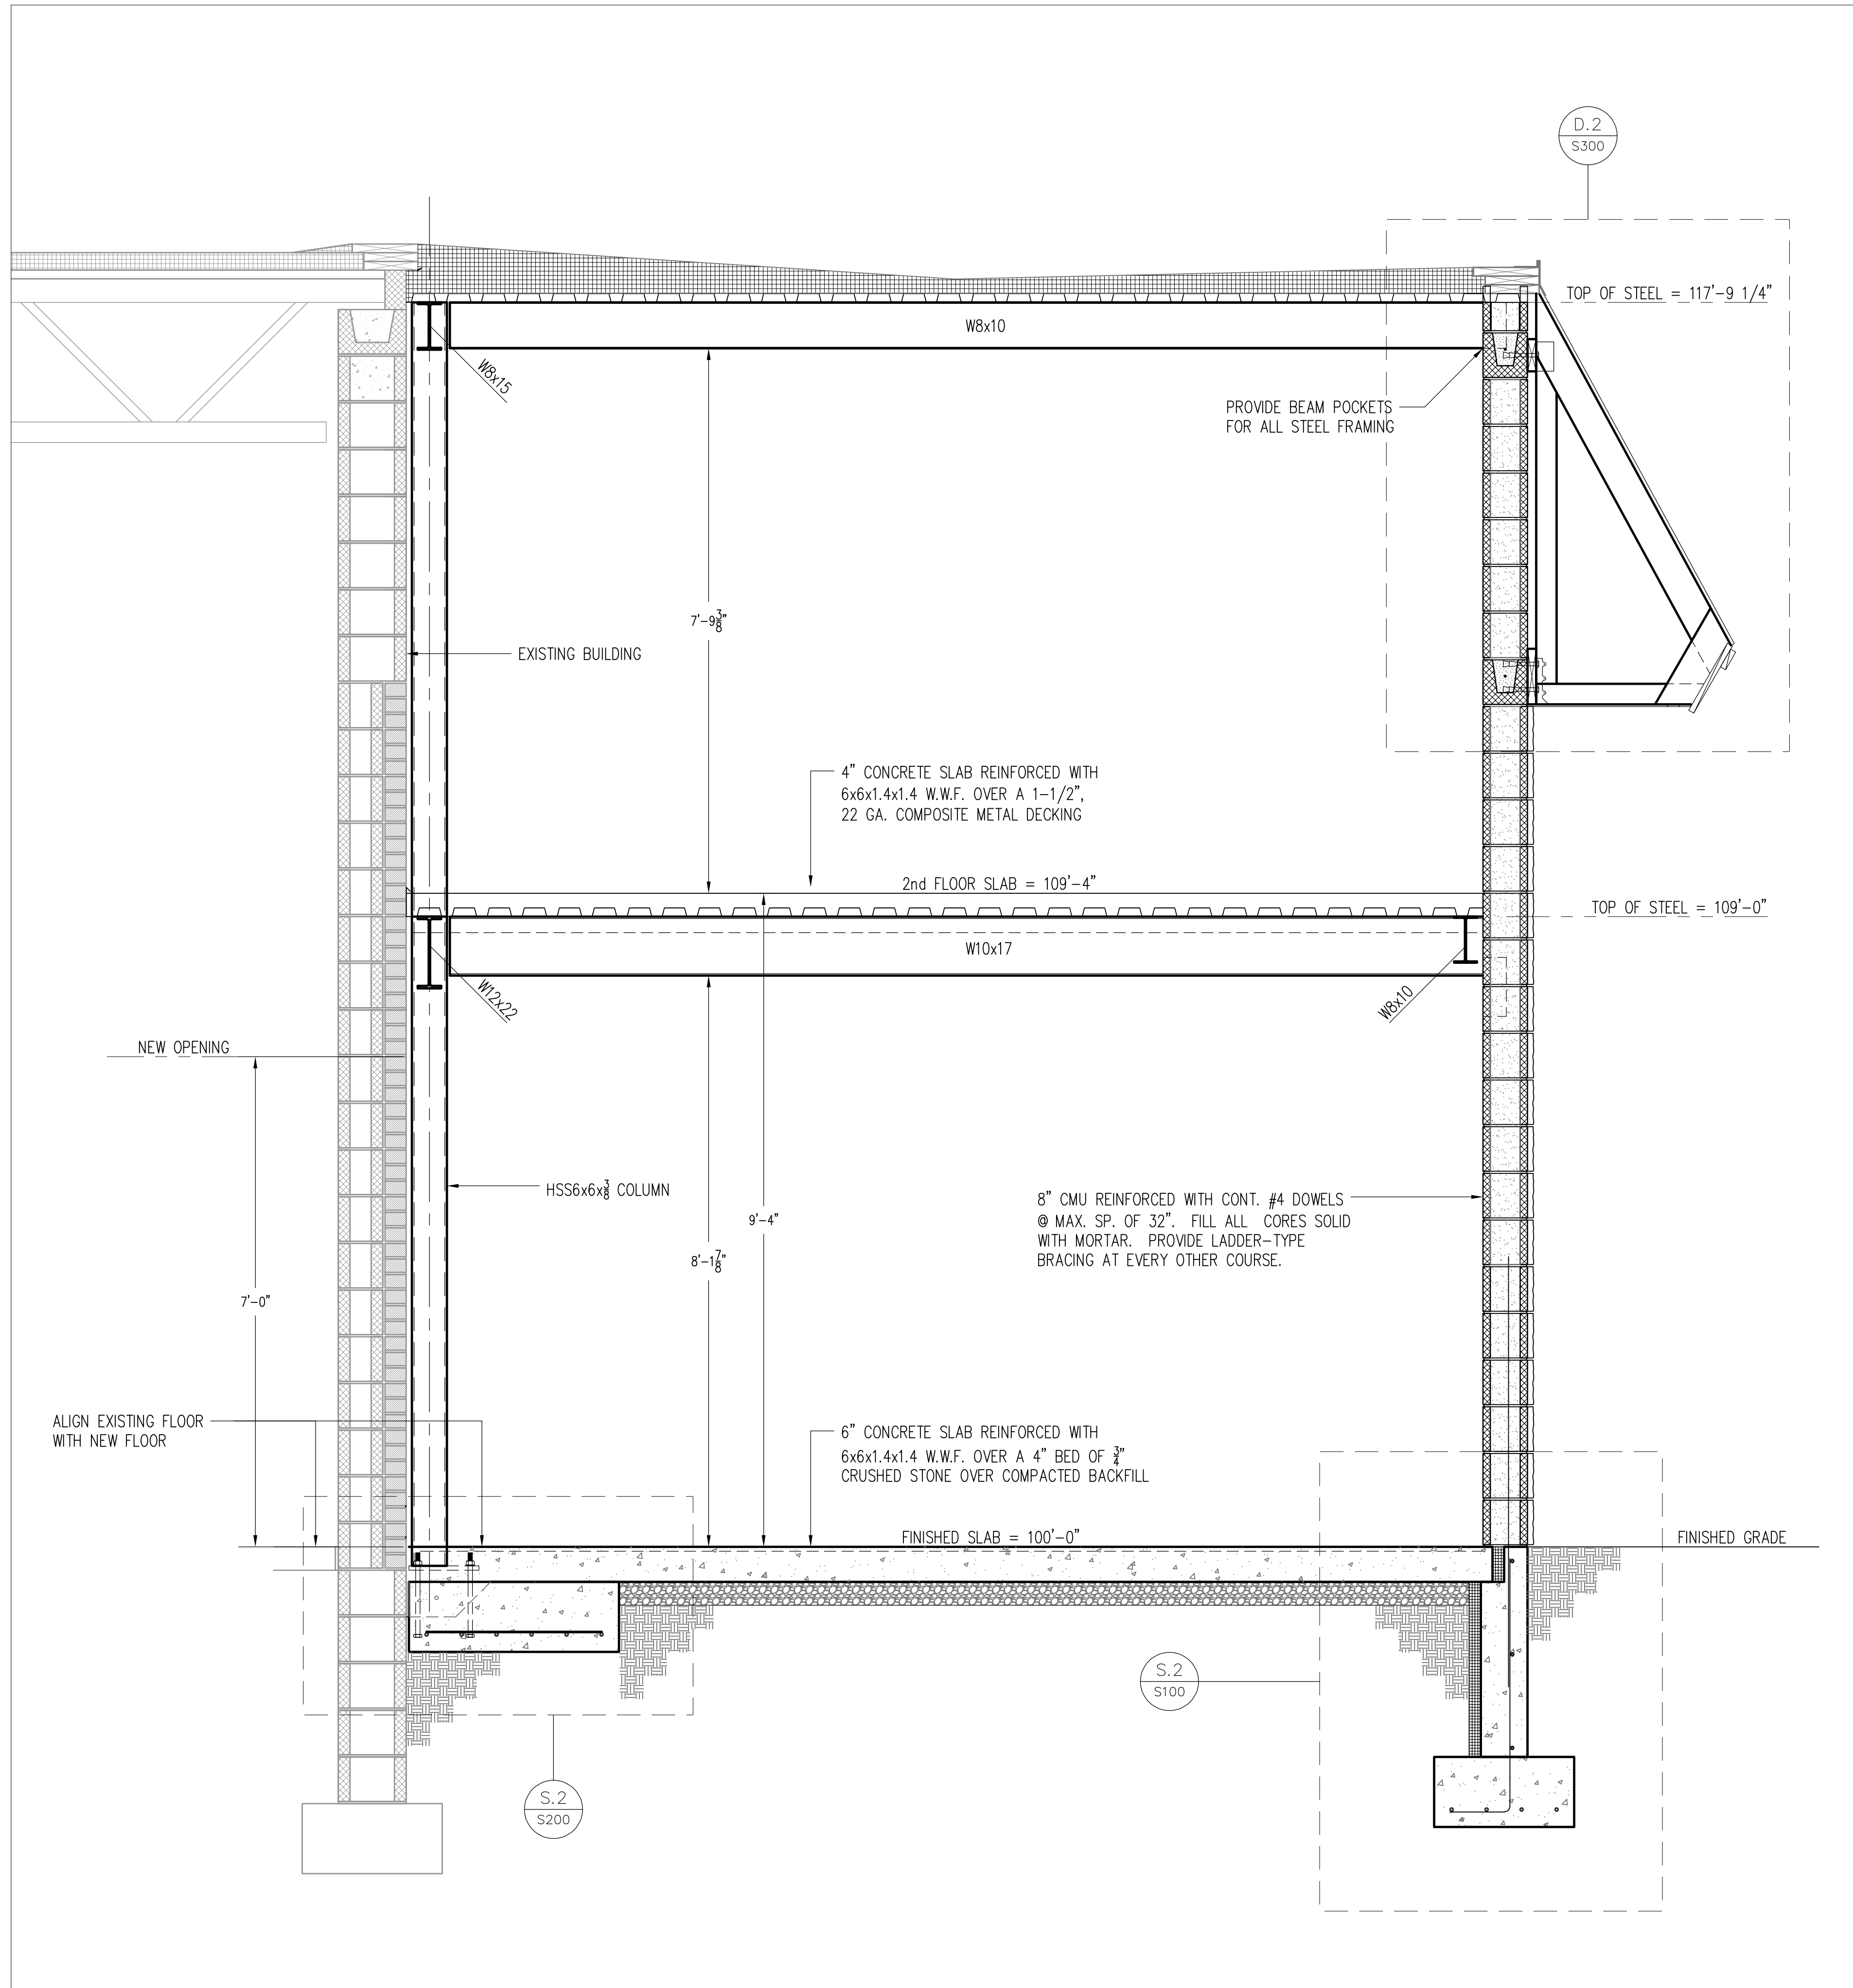

D.1 SECOND FLOOR FRAMING PLAN - TOP OF STEEL 108'-5"  
S200 SCALE: 1/8" = 1'-0"

FRAMING NOTES:

- ALL TOP OF STEEL ELEVATIONS SHOWN ON THE FRAMING PLANS.
- DENOTES SPAN OF 1-1/2" TYPE B, 22 GA. DECK.
- ALL FLOOR DECKING TO BE INSTALLED WITH HILTI X-HSN 24 PAF USING A  $\frac{3}{4}$ " CONNECTION PATTERN TO ROOF FRAMING OR OTHER SUPPORTS WITH #10 SIDELAP SCREWS. THERE SHALL BE A MIN. OF 2" OF DECK END BEARING LENGTH.
- ALL WIDE FLANGE BEAMS SHALL BE ASTM-A572 OR ASTM A992 GRADE 50 (50 KSI).
- PROVIDE FRAME AROUND ALL OPENINGS LARGER THAN 8".
- THE GC/CM SHALL COORDINATE ALL OPENINGS WITH ARCHITECTURAL, MECHANICAL, ELECTRICAL AND PLUMBING DRAWINGS AND TYPICAL DETAILS.
- REFER TO ARCHITECTURAL DRAWINGS FOR DIMENSIONS NOT SHOWN.
- SEE TYPICAL DETAILS FOR INFORMATION NOT REFERENCED ON PLANS.
- REFER TO GENERAL NOTES FOR ADDITIONAL INFORMATION.

IT IS A VIOLATION OF NEW YORK STATE EDUCATION LAW FOR ANY PERSONS TO ALTER THESE PLANS, SPECIFICATIONS, OR REPORTS IN ANY WAY, UNLESS ACTING UNDER THE DIRECTION OF A LICENSED PROFESSIONAL ENGINEER OR LAND SURVEYOR.

Mark A. Day, PE	
Revisions	
Project No.	JOB No. License No. 069646
<b>DAY STOKOSA</b> ENGINEERING P.C.	
3 Van Wyck Lane Suite 2 Wappingers Falls, New York (845)-223-3202	
PROJECT Peekskill Firehouse Kitchen Incubator 701 Washington Street City of Peekskill Westchester County, New York	
DRAWING Structural Section	
SCALE As Noted	DRAWN BY MAD
DATE 06-12-24	CHECKED BY MAD
S300	