

PEEKSKILL FIREHOUSE KITCHEN INCUBATOR


City of Peekskill (Owner)
701 Washington Street
Peekskill, New York 10566
S-B-L: 32.20-9-1
City of Peekskill - Westchester County

DRAFT CONSTRUCTION DOCUMENT - NOT FOR PERMIT OR CONSTRUCTION

Date: September 17, 2024

Revisions:

E2.01

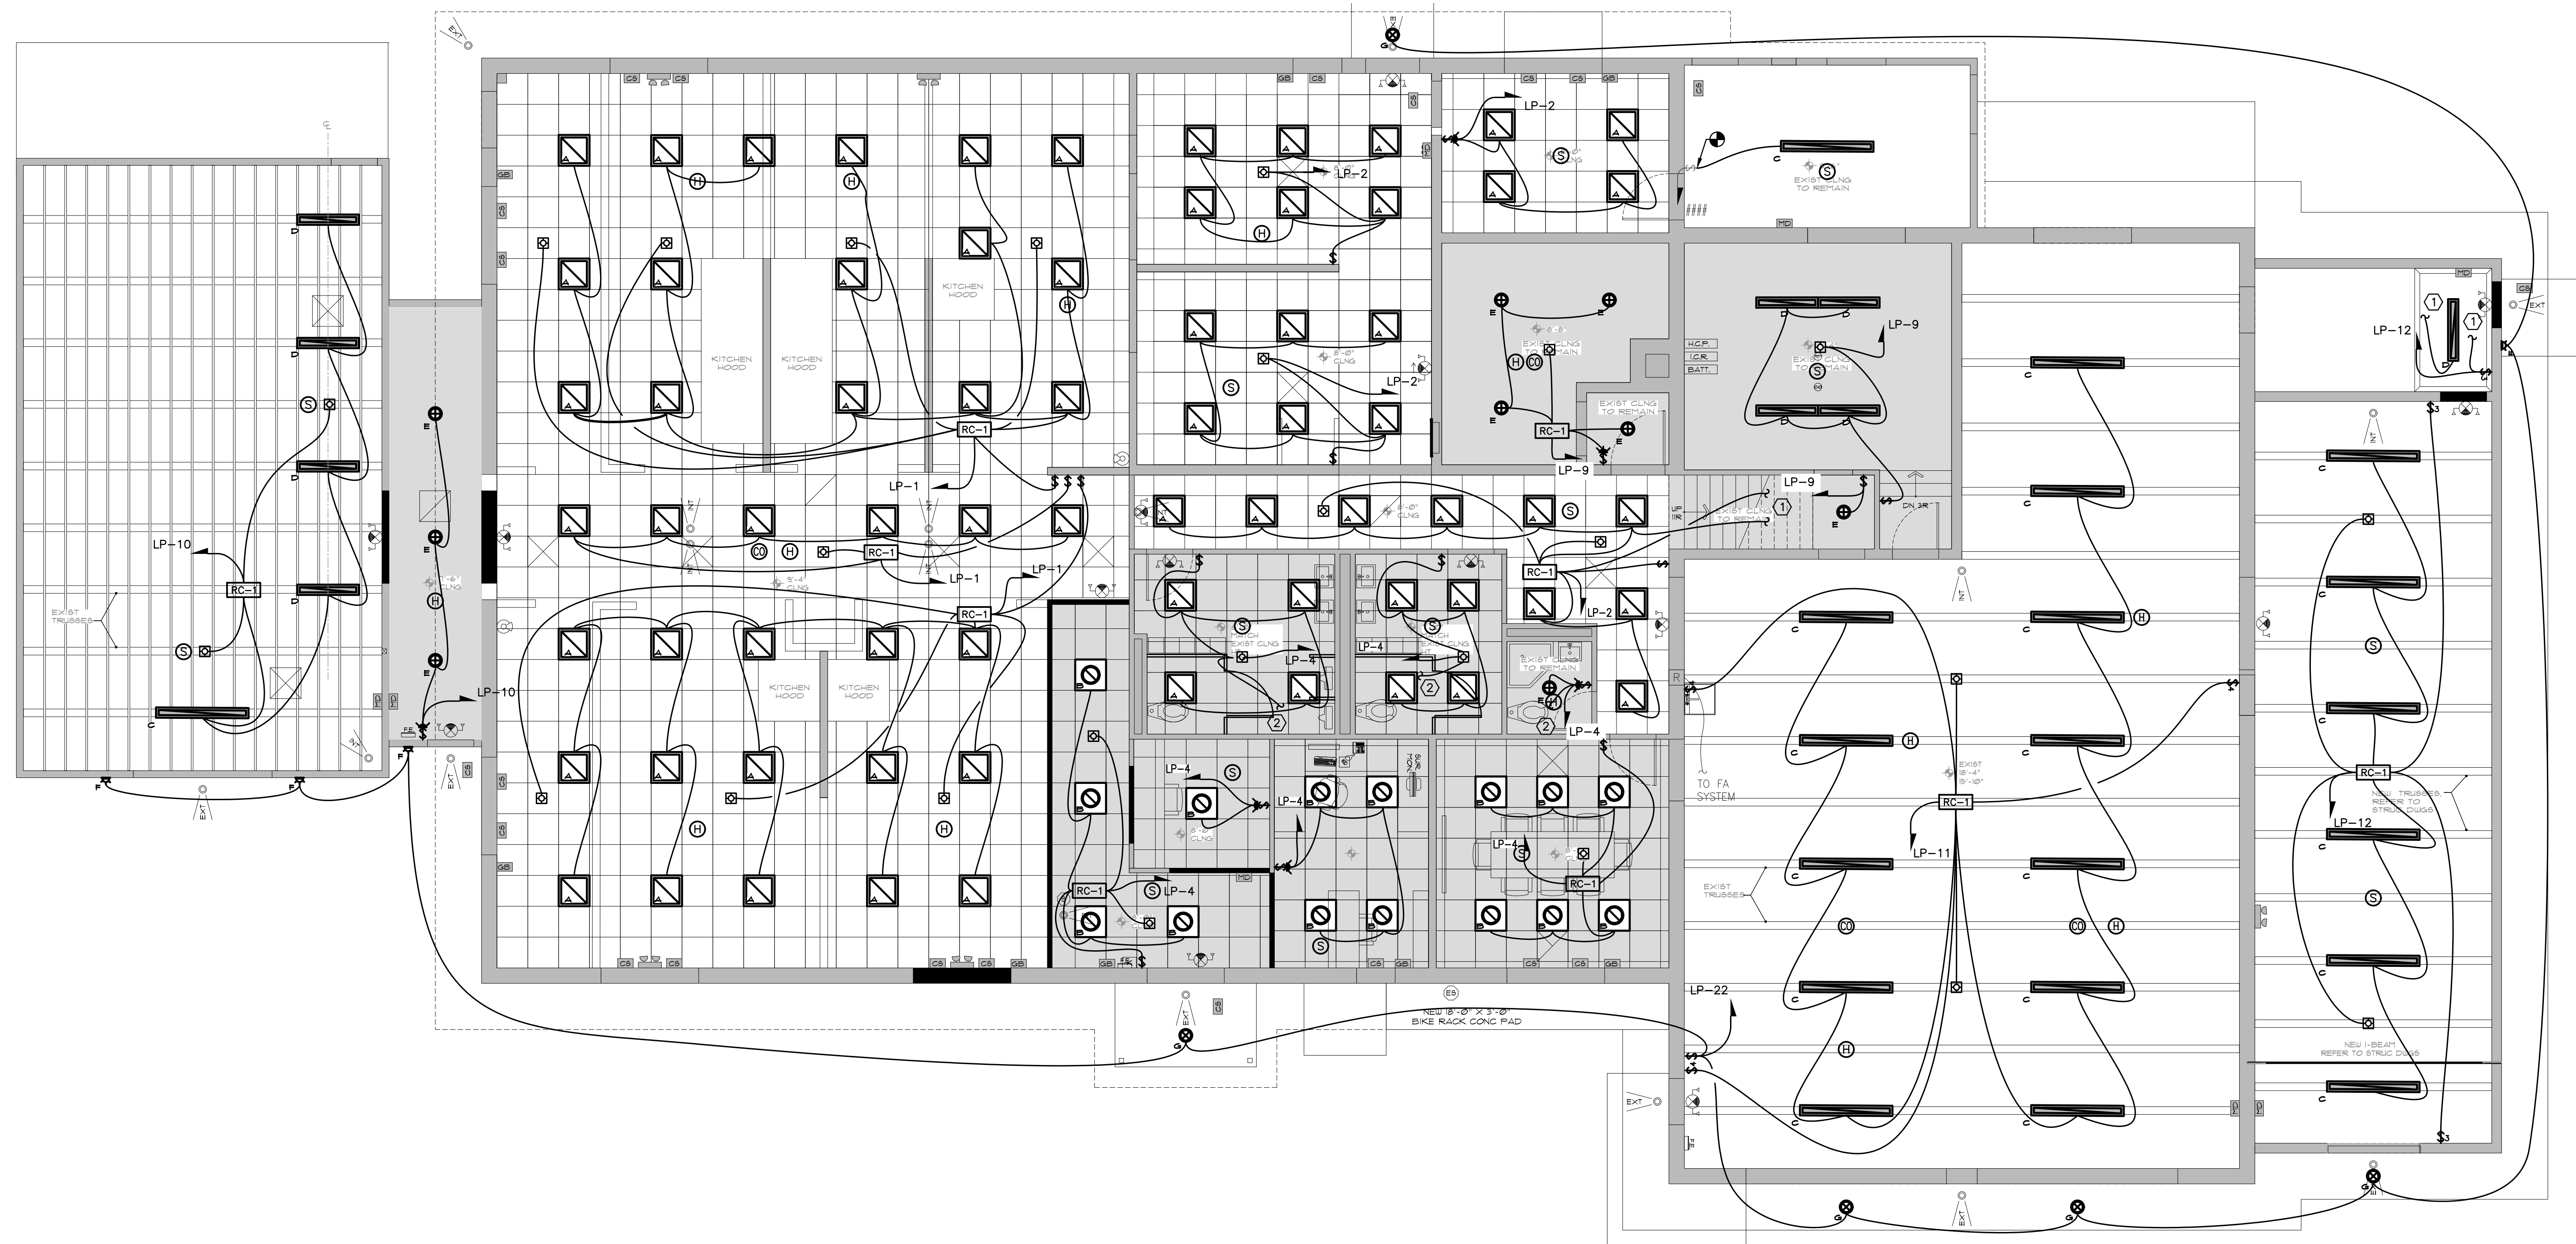

1 ELECTRICAL: CONSTRUCTION FIRST FLOOR LIGHTING & FIRE ALARM PLAN

SCALE: 3/16"=1'-0"

NEW WORK KEYED NOTES:

- ① SEE E2.02 FOR CONTINUATION.
② TO E1.01 FOR CONTINUATION.



NOTE: CONTRACTOR SHALL MARK OUT AND LOCATE ALL UNDERGROUND UTILITIES AND STRUCTURES ON THE PREMISES. NO ADDITIONAL COMPENSATION SHALL BE PROVIDED FOR ALTERATIONS TO DESIGN PLANS DUE TO LACK OF LOCATING. CONTRACTOR SHALL BE RESPONSIBLE FOR PAYING FOR RE-LOCATING OR DAMAGES RESULTING FROM LACK OF LOCATING.

UNAUTHORIZED ALTERATION OR ADDITION TO A PLAN BEARING A LICENSED PROFESSIONAL ENGINEER'S SEAL IS A VIOLATION OF SECTION 7209, SUB-DIVISION 2 OF THE N.Y. STATE EDUCATION LAW. FELLENGER ENGINEERING, LLP CERTIFICATE OF AUTHORIZATION #: 0017795

FELLENGER III
ENGINEERING LLP

www.fellp.com

22 Mulberry St., Suite 2A,
Middletown, NY 10940
t 845-343-1481 fx 845-343-4986

181 Church St., Suite 100,
Poughkeepsie, NY 12601
t 845-454-9704 fx 855-320-8735

DESIGNED BY: RW DRAWN BY: WPB APPROVED BY: EDF FE PROJECT #: 23-369

