
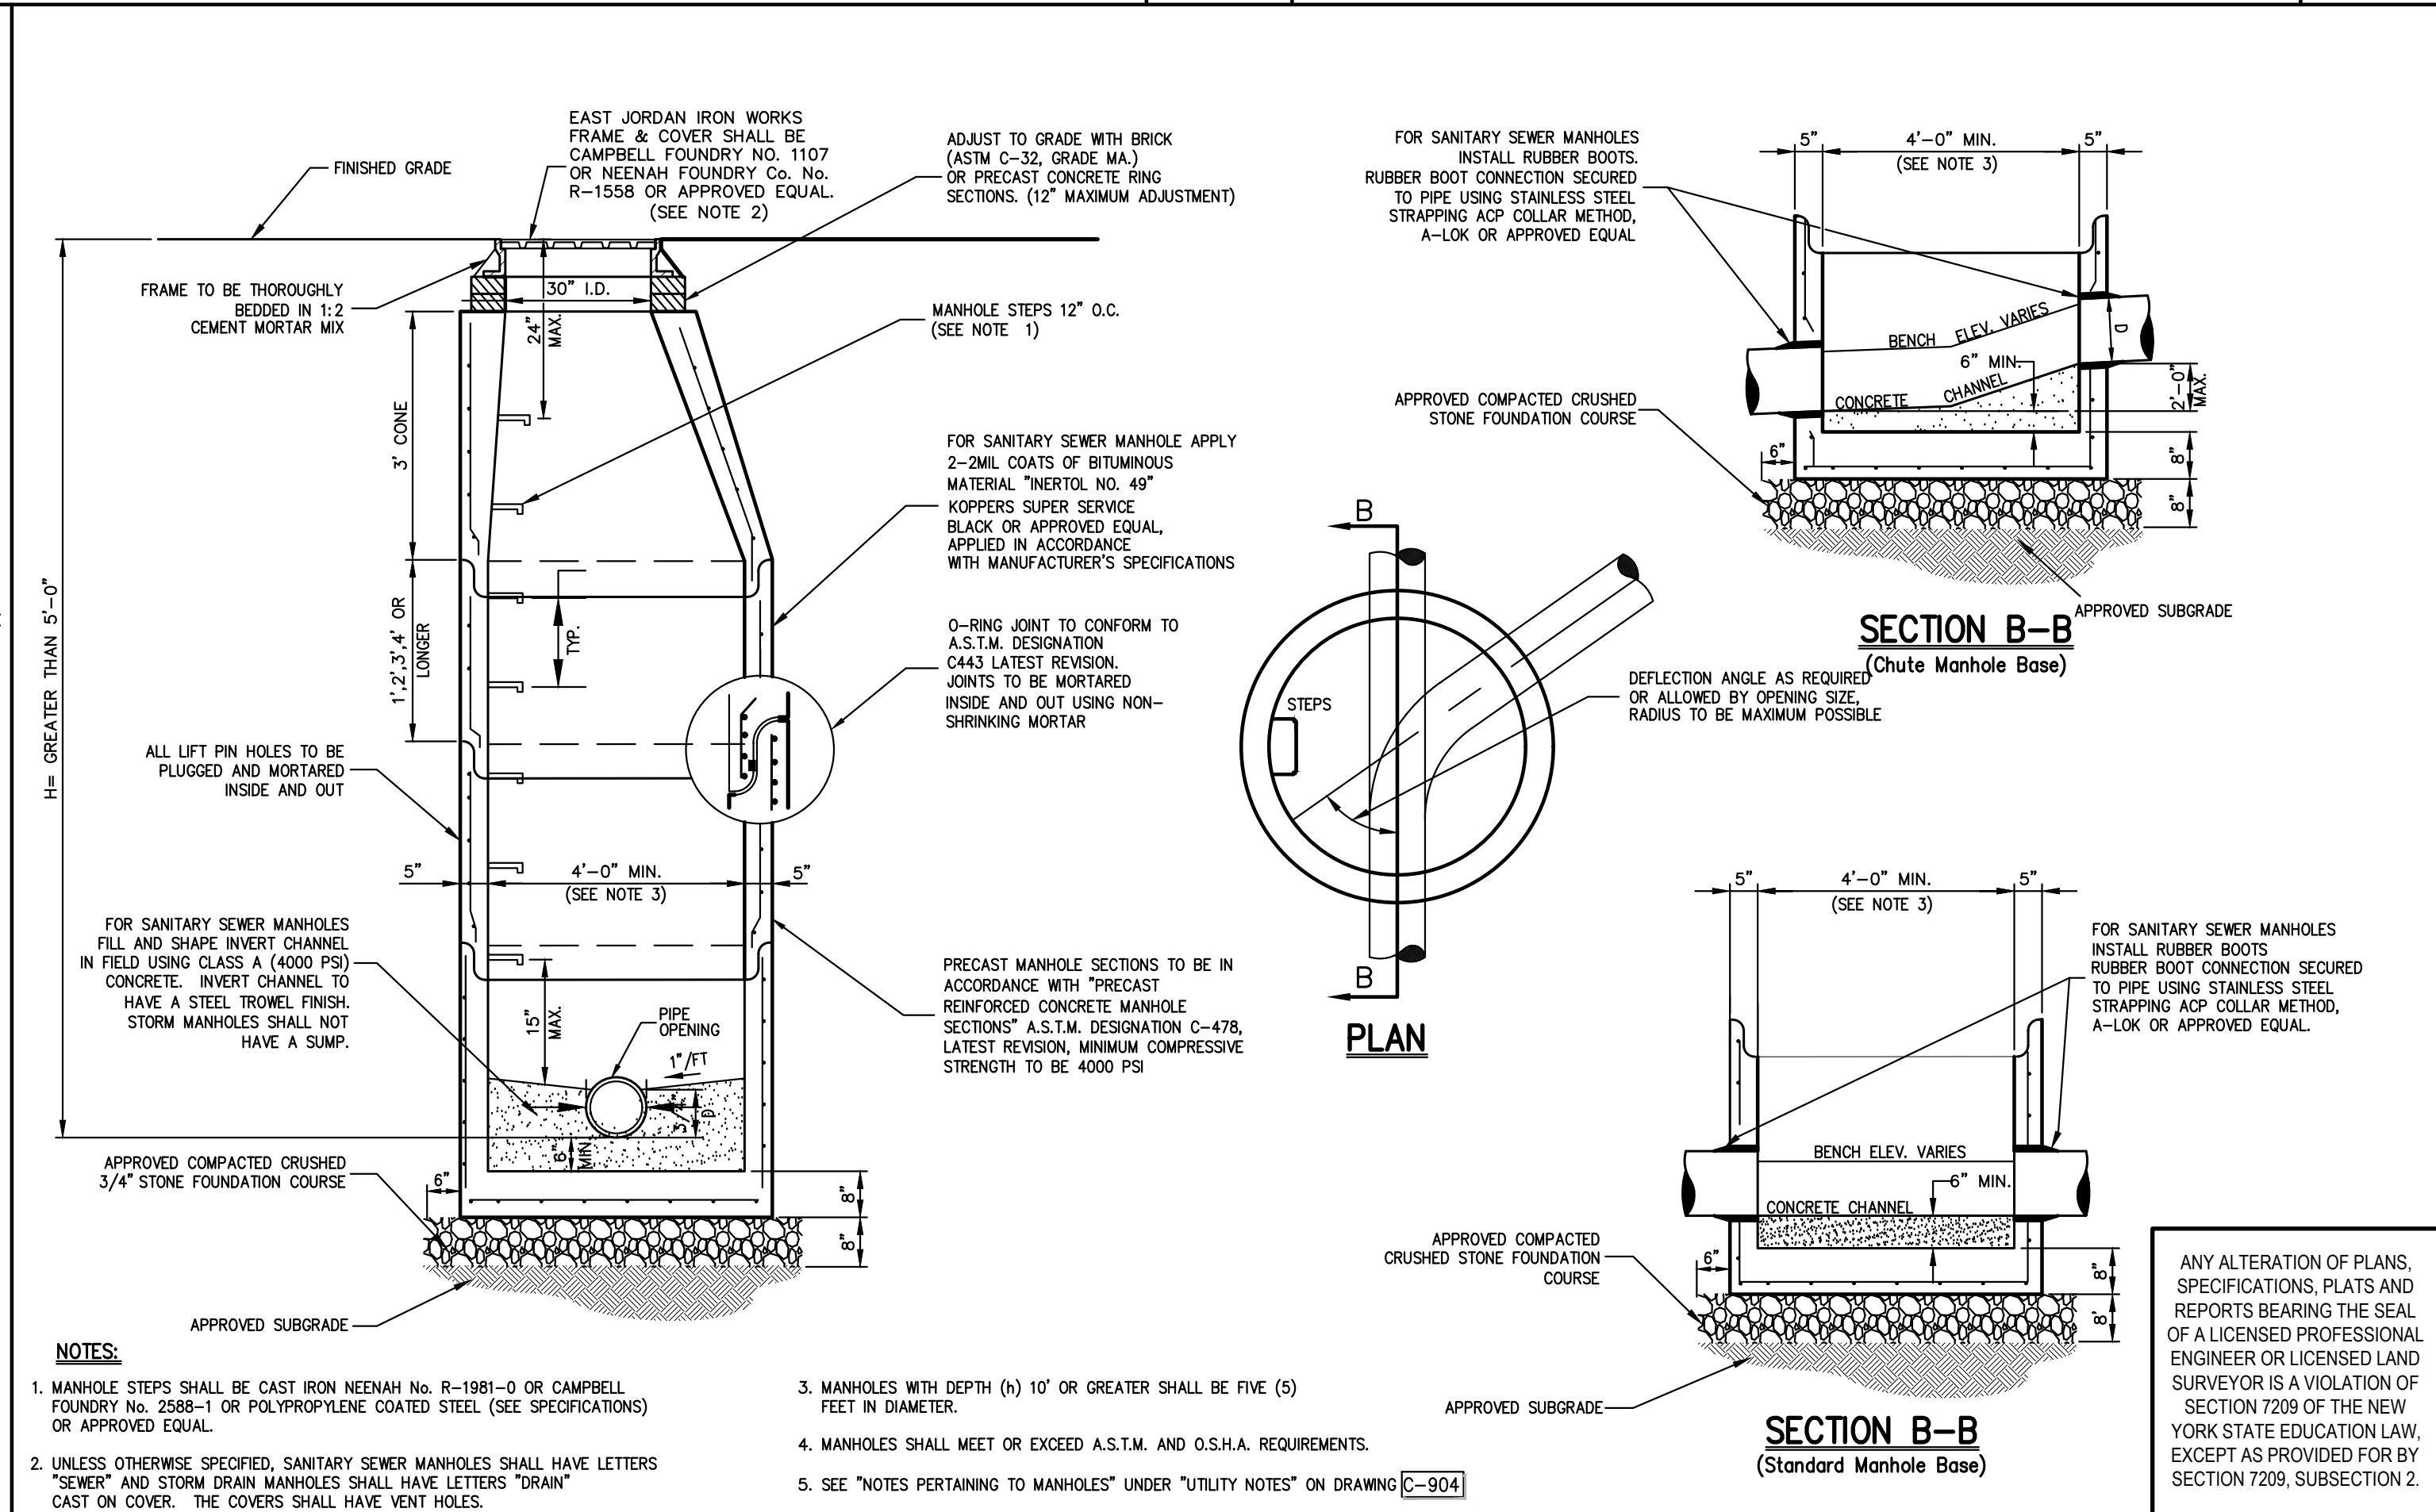
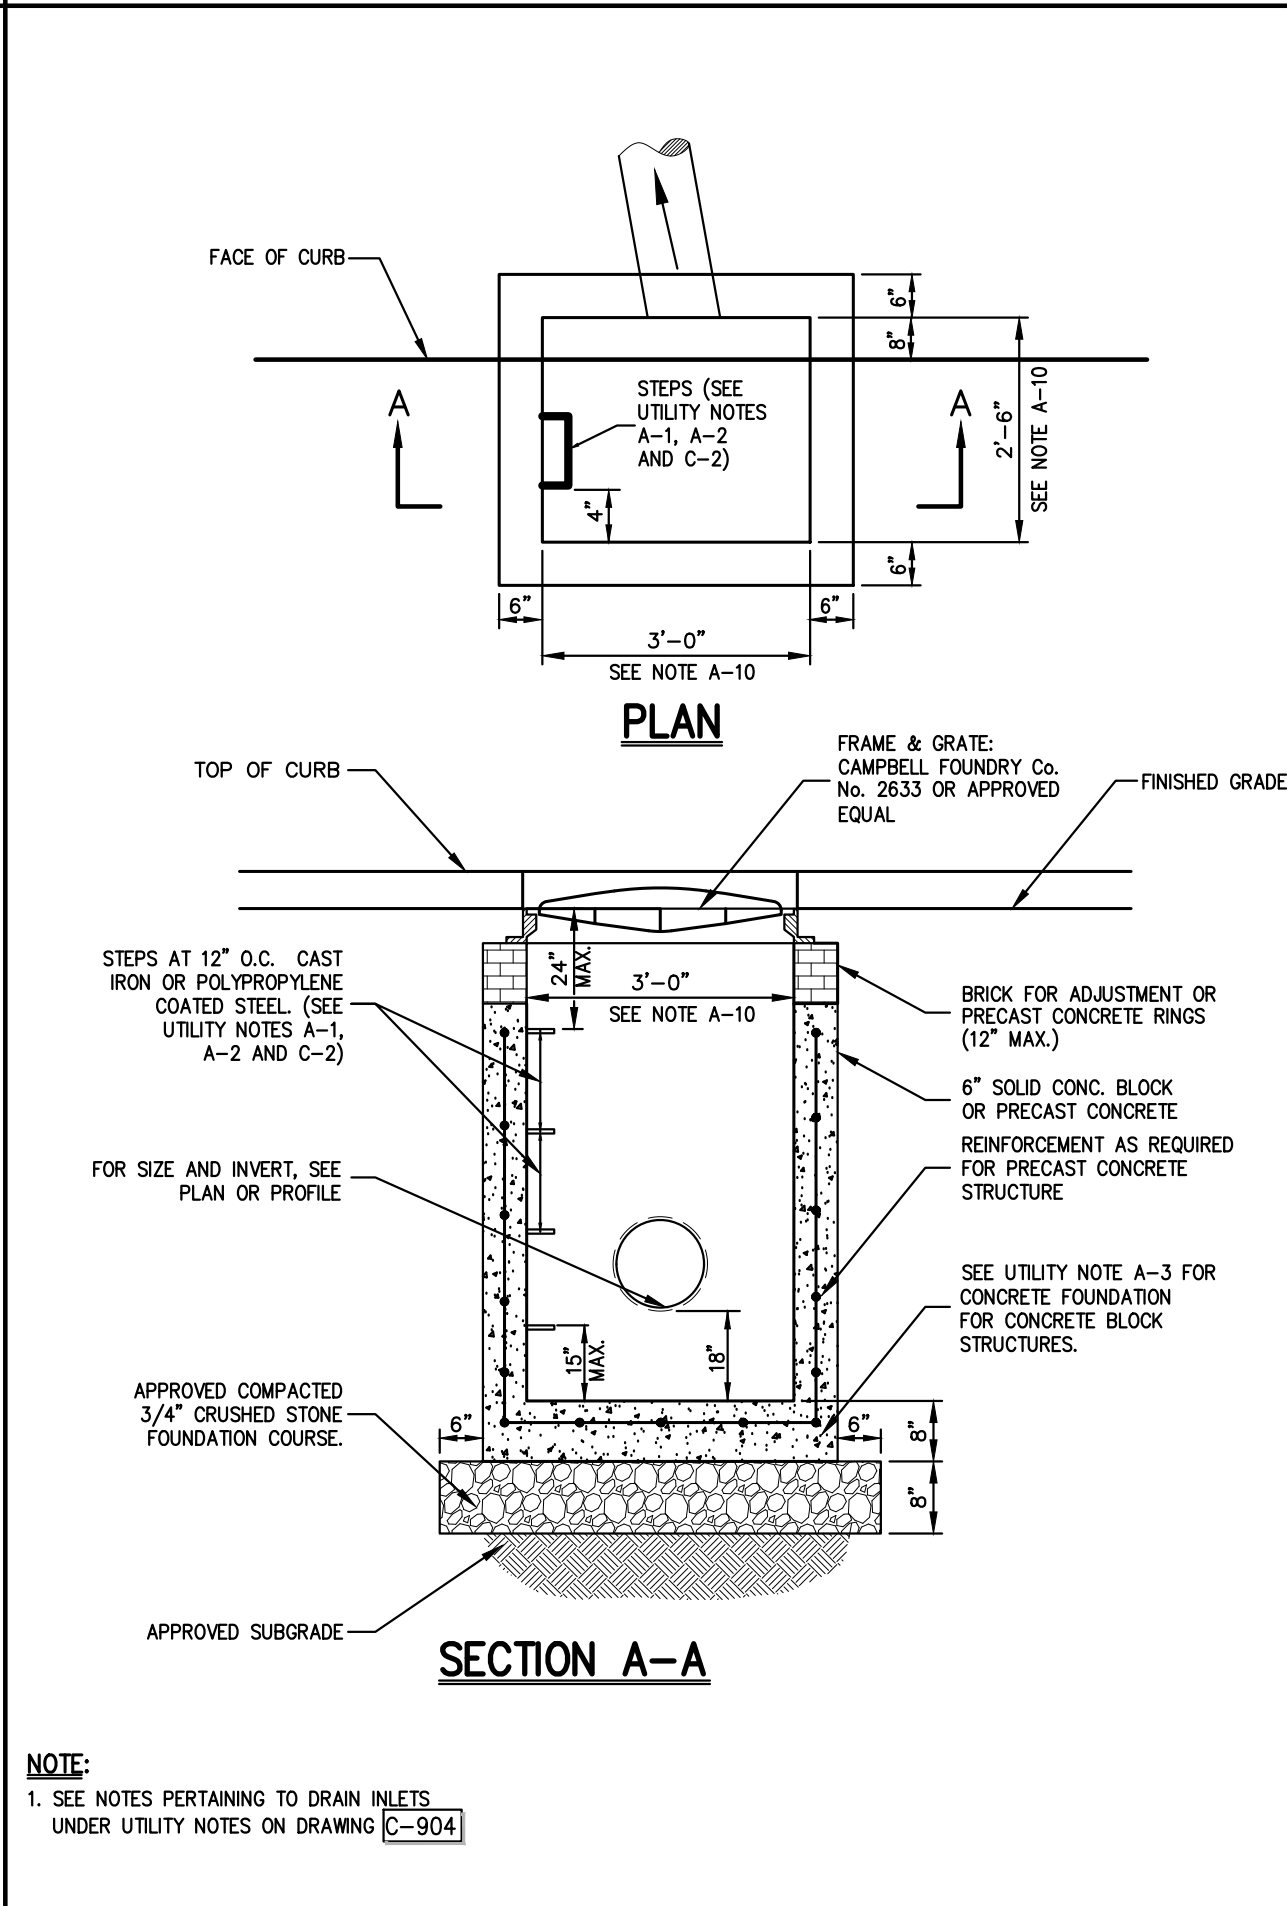


TYPE II TRENCH

CONCRETE WASHOUT

ROLLED EROSION CONTROL MATTING

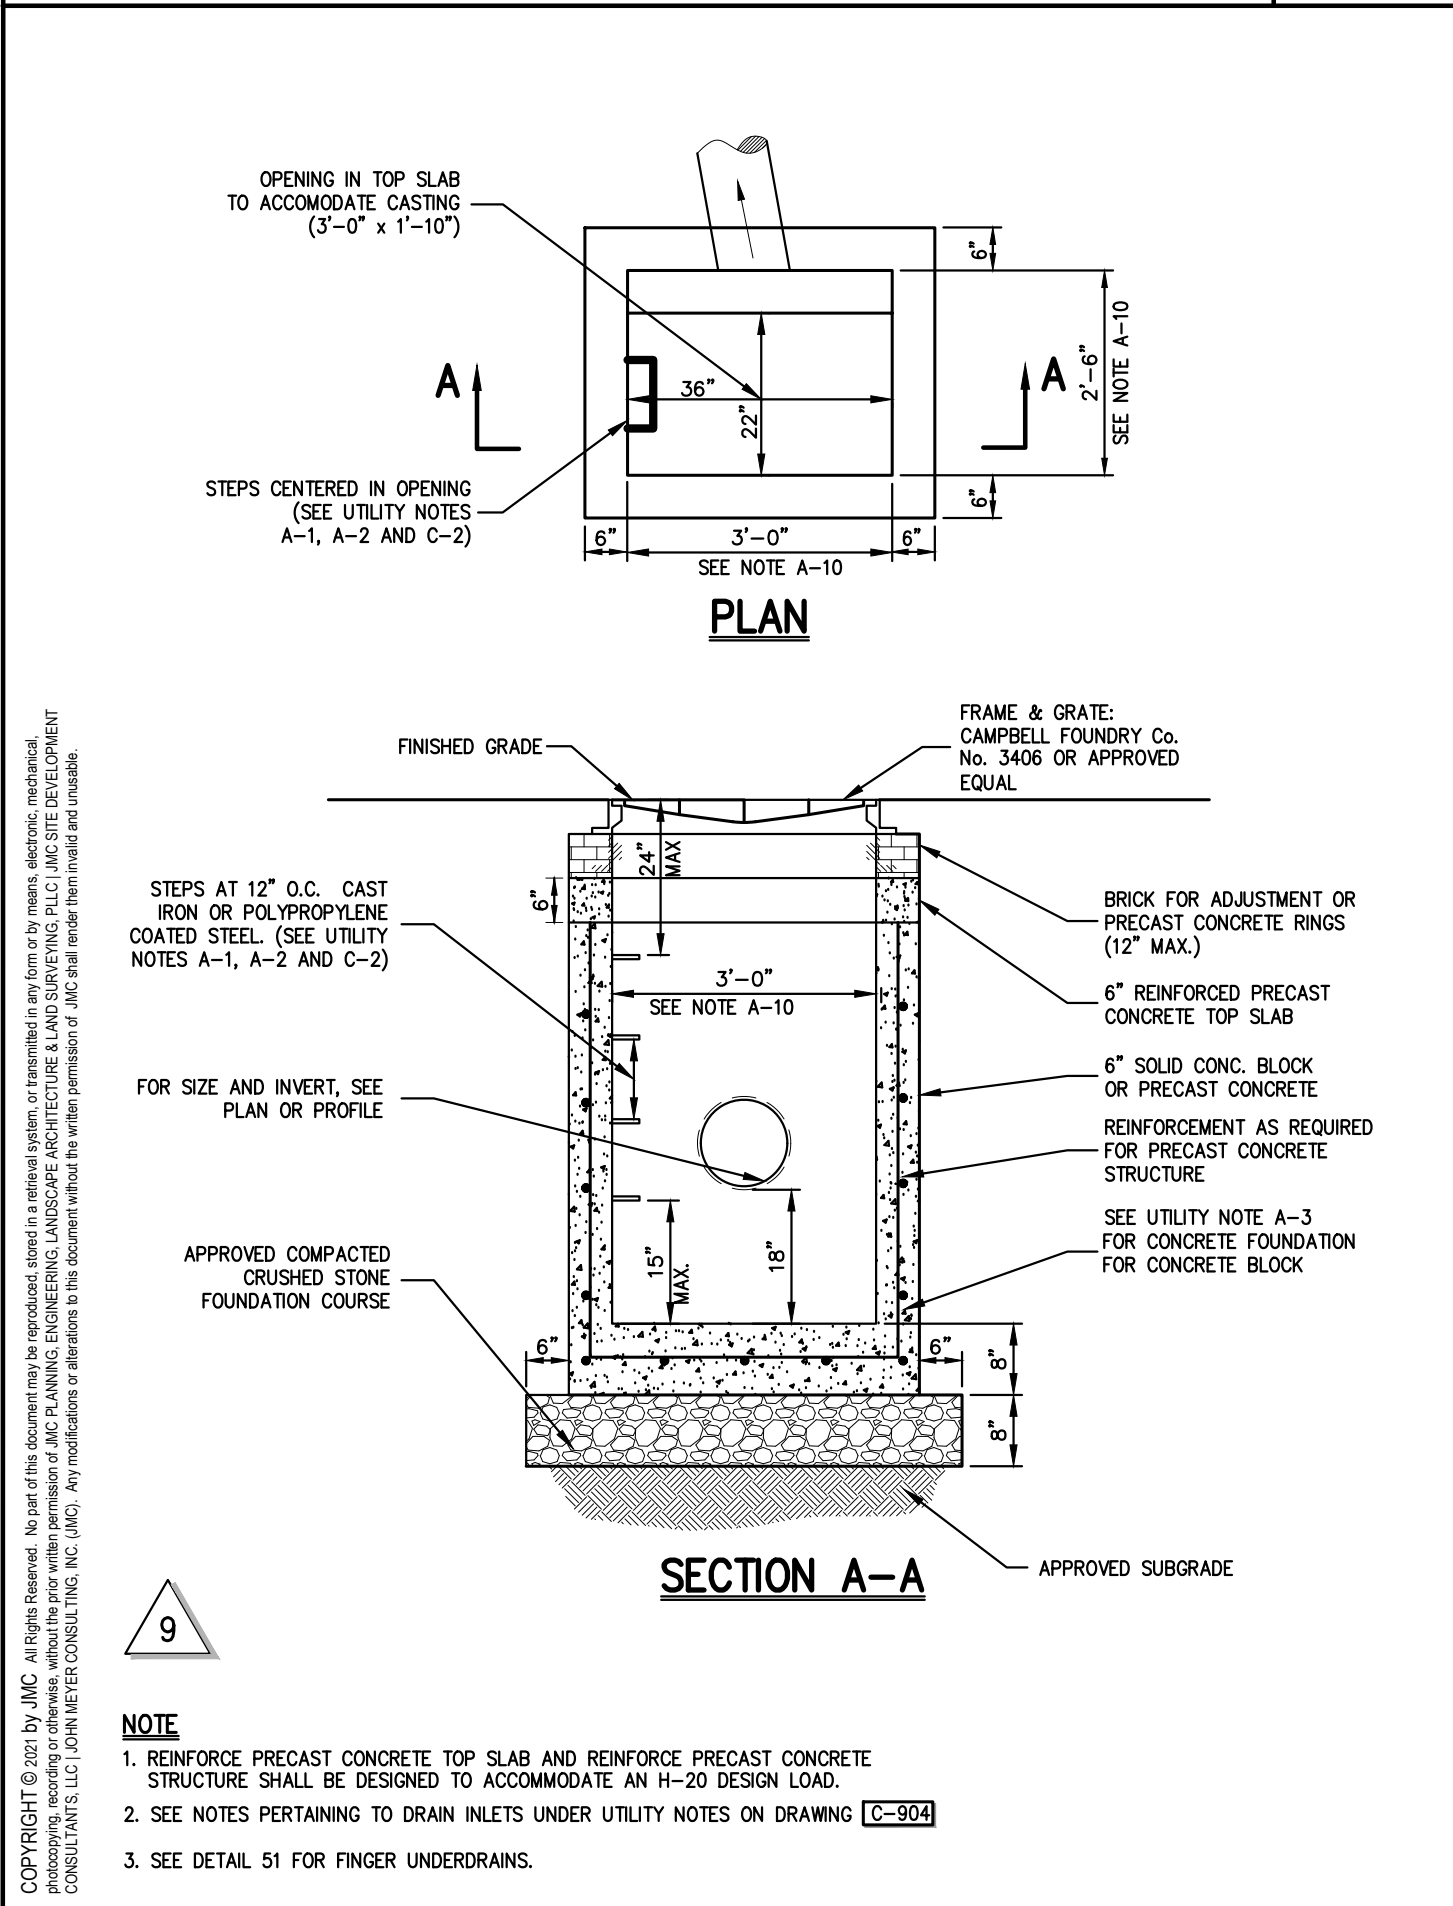

DRAIN INLET (TYPE DI)

DRAIN INLET (TYPE CI)

MANHOLE (TYPE B)

(H > 5'-0") < 10'-0")

ARCHITECT
di Domenico + Partners LLP
Architecture
Landscape Architecture
Planning
3743 Crescent Street, 3rd Floor
Long Island City, New York 11101
Tel 212-337-0400
Fax 212-337-3567

CIVIL PLANNING ENGINEER
JMC
JMC Planning Engineering Landscape
Architecture & Land Surveying, PLLC
120 Bedford Road
Armonk, New York 10504
Tel 914-273-5225
Fax 914-273-2102

MEP ENGINEER
Burns
BURNS ENGINEERING, PC.
1261 Broadway, Suite 708
New York, New York 10001
Tel 212-962-3503

STRUCTURAL ENGINEER
GEI
GEI50
1385 Broadway, 20th FL.
New York, New York 10018
Tel 212-687-8282

MANHATTAN BEER DISTRIBUTORS
20 DUNNIGAN DRIVE
SUFFERN, NEW YORK

REV	DESCRIPTION	DATE
1	REISSUED PER PB COMMENTS	07.16.20
2	REISSUED PER PB COMMENTS	08.21.20
3	REISSUED PER PB COMMENTS	09.17.20
4	REISSUED PER PB COMMENTS	10.20.20
5	FOR PLANNING BOARD APPROVAL	04.09.21
6	REISSUED PER ENGINEER COMMENTS	05.10.21
7	ISSUED FOR DOB SUBMISSION	09.10.21
8	ISSUED FOR BID	10.15.21
9	REVISED BID/PERMIT SET	02.25.22
10	REVISED/ISSUED FOR CONSTRUCTION	10.19.22

DRAWN BY: DC
CHECKED BY: JPM/JAR
APPROVED BY: DL
DATE: 1.16.2020
SCALE: N.T.S.
ISSUE:

DRAWING TITLE:
CONSTRUCTION DETAILS
DWG NUMBER:
C-901
JMC PROJECT: 19005-1
SCR NO:
DWG FILE: 19005-02141.SCD