

NOTES:

1. REFER TO CONTRACT DRAWING [E-001](#) FOR ELECTRICAL LEGEND, ABBREVIATIONS, GENERAL NOTES, AND DRAWING LIST.
2. REFER TO CONTRACT DRAWINGS [E-701](#), [E-702](#), AND [E-703](#) FOR ELECTRICAL ONE-LINE DIAGRAM.
3. ALL MECHANICAL UNITS SHOWN ON THIS PLAN ON LOCATED ON THE ROOF OF THE 2ND FLOOR MEZZANINE. REFER TO MECHANICAL CONTRACT DRAWINGS FOR EXACT LOCATION AND REQUIREMENTS OF MECHANICAL EQUIPMENT.

ARCHITECT

di Domenico + Partners LLP

Architecture
Landscape Architecture
Planning
3743 Crescent Street, 3rd Floor
Long Island City, New York 11101
Tel 212-337-0400
Fax 212-337-3567

CIVIL PLANNING ENGINEER

JMC

JMC Planning Engineering Landscape
Architecture & Land Surveying, PLLC
120 Bedford Road
Armonk, New York 10504
Tel 914-273-5225
Fax 914-273-2102

MEP ENGINEER

Burns

BURNS ENGINEERING, PC.
1261 Broadway, Suite 708
New York, New York 10001
Tel 212-962-3503

STRUCTURAL ENGINEER


GEI

GEI50
1385 Broadway, 20th FL
New York, New York 10018
Tel 212-687-8282
Consultants



MANHATTAN BEER DISTRIBUTORS
20 DUNNIGAN DRIVE
SUFFERN, NEW YORK

KEY PLAN

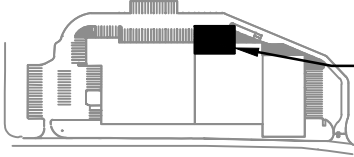

AREA OF
WORK


REV	DESCRIPTION	DATE
	ISSUED FOR DOB SUBMISSION	09/10/2021
	ISSUED FOR BID	10/15/2021
	ISSUED FOR PROGRESS	01/18/2022
	ISSUED FOR BID	08/30/2022

DRAWN BY :	M.DIMATTIA
CHECKED BY :	B.NEMCHEK
APPROVED BY :	J.MIZRAHI
DATE :	09/10/21
SCALE :	AS NOTED

DRAWING TITLE :
MECHANICAL POWER PLAN -
2ND MEZZANINE

DWG NUMBER :

E-304

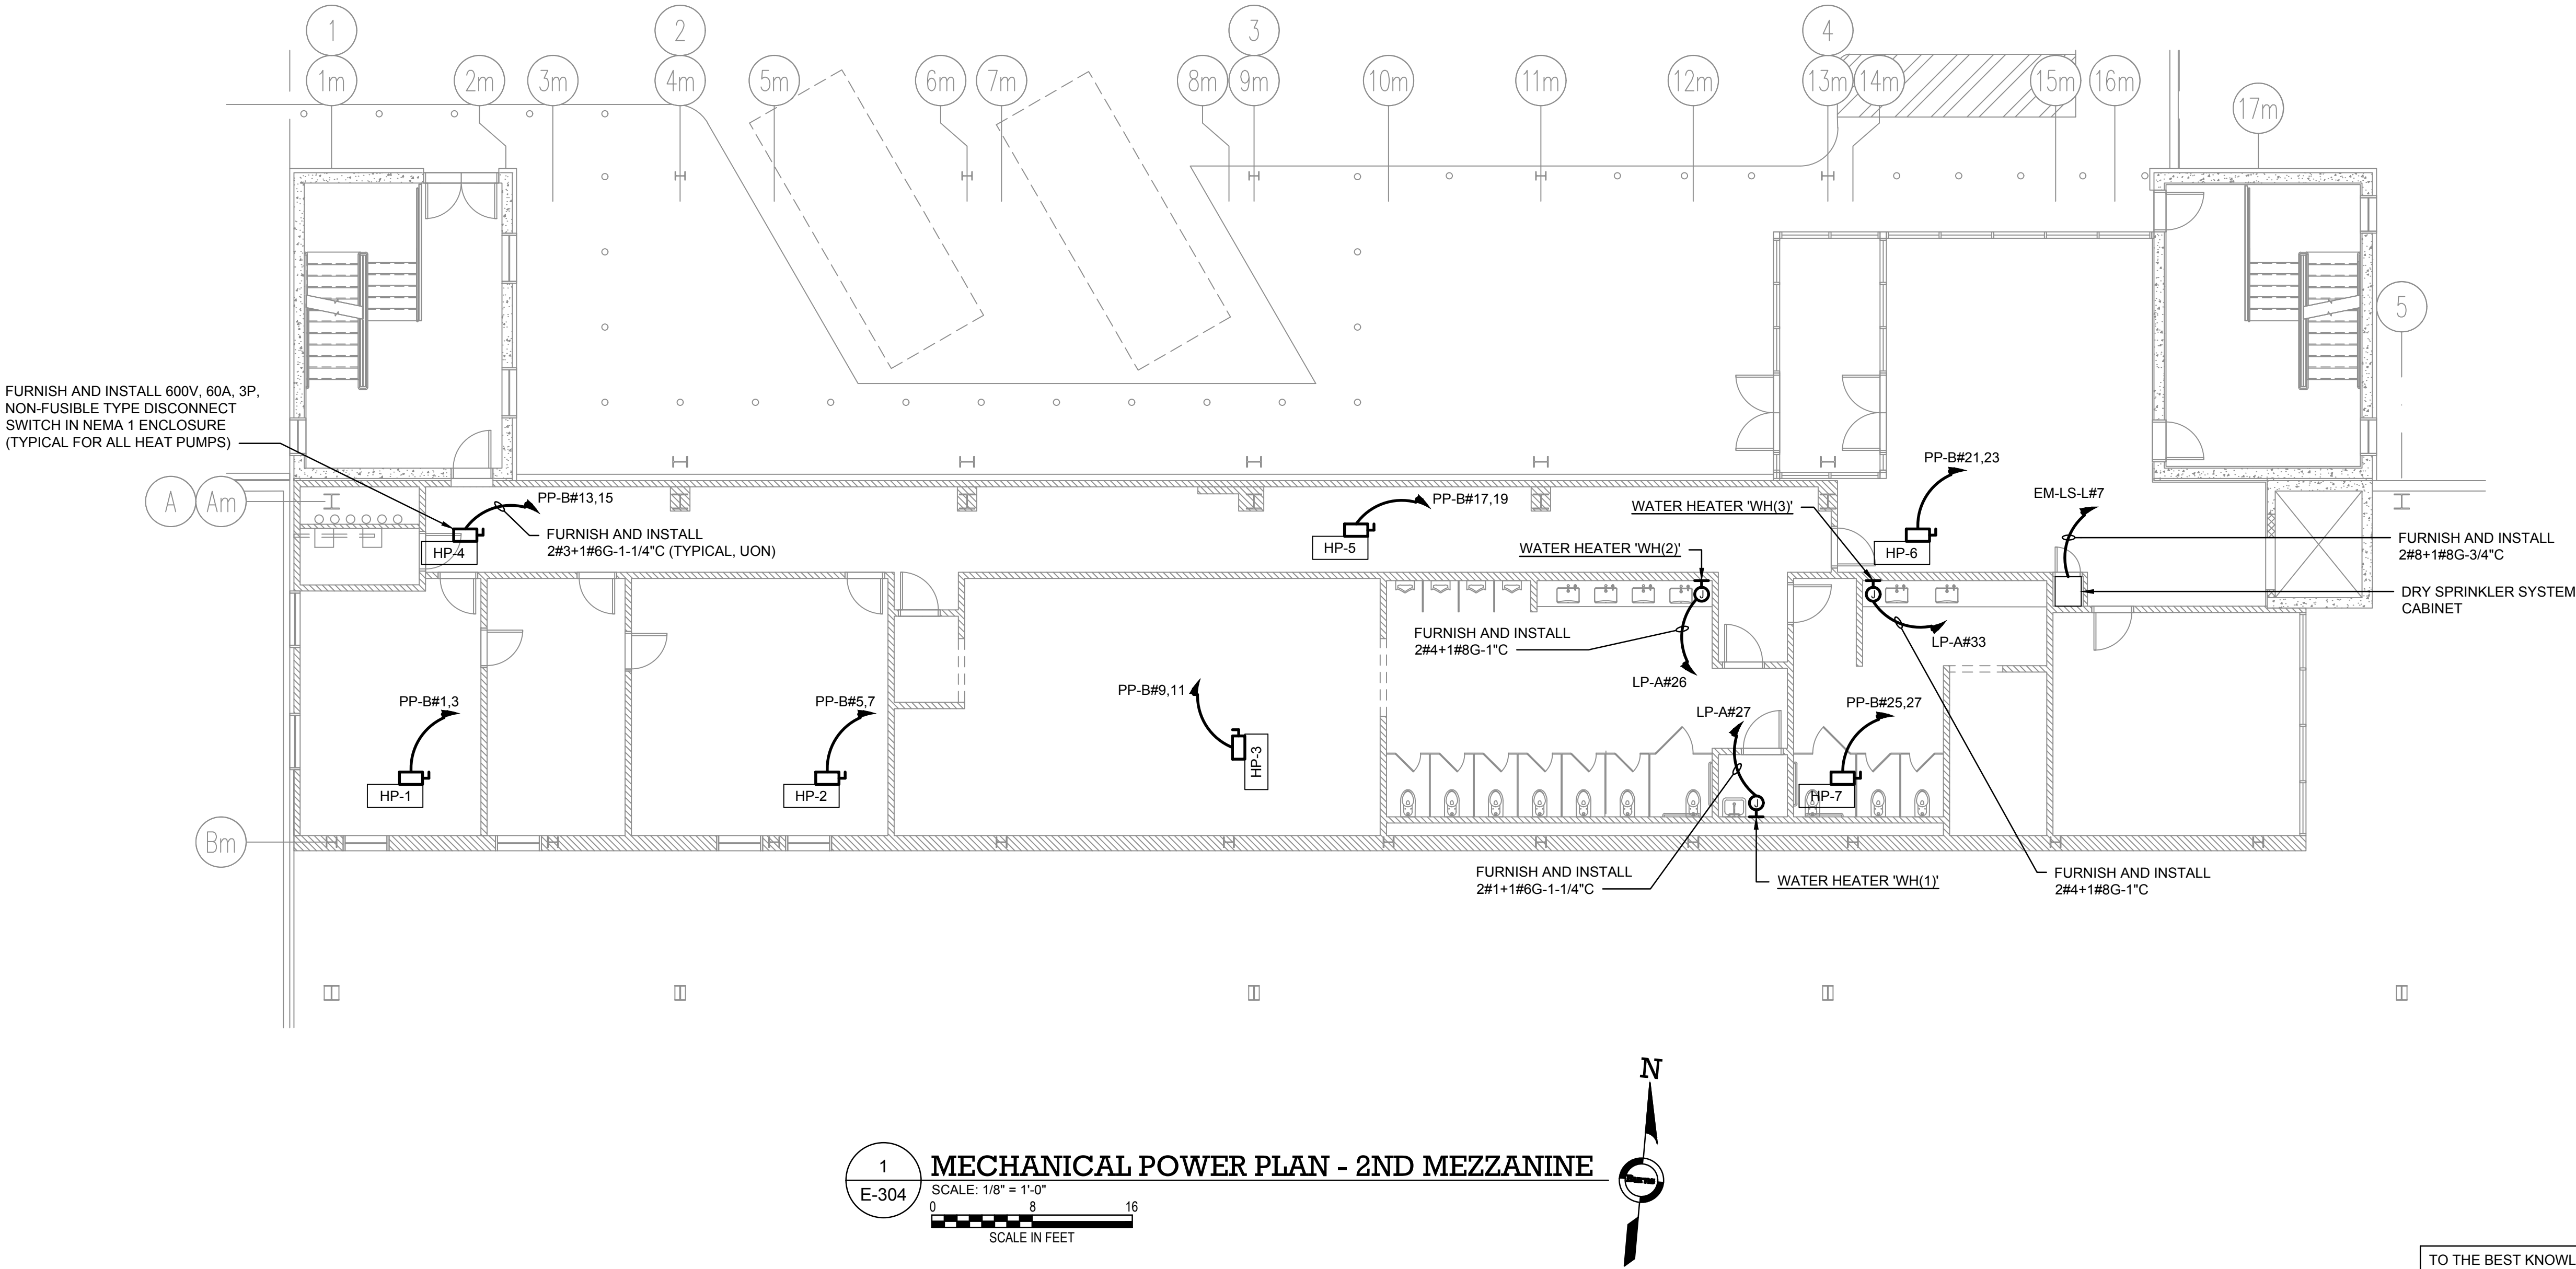

TO THE BEST KNOWLEDGE, BELIEF AND PROFESSIONAL JUDGEMENT,
THESE PLANS AND SPECIFICATIONS ARE IN COMPLIANCE WITH THE 2020
ENERGY CONSERVATION CONSTRUCTION CODE OF NEW YORK STATE.