




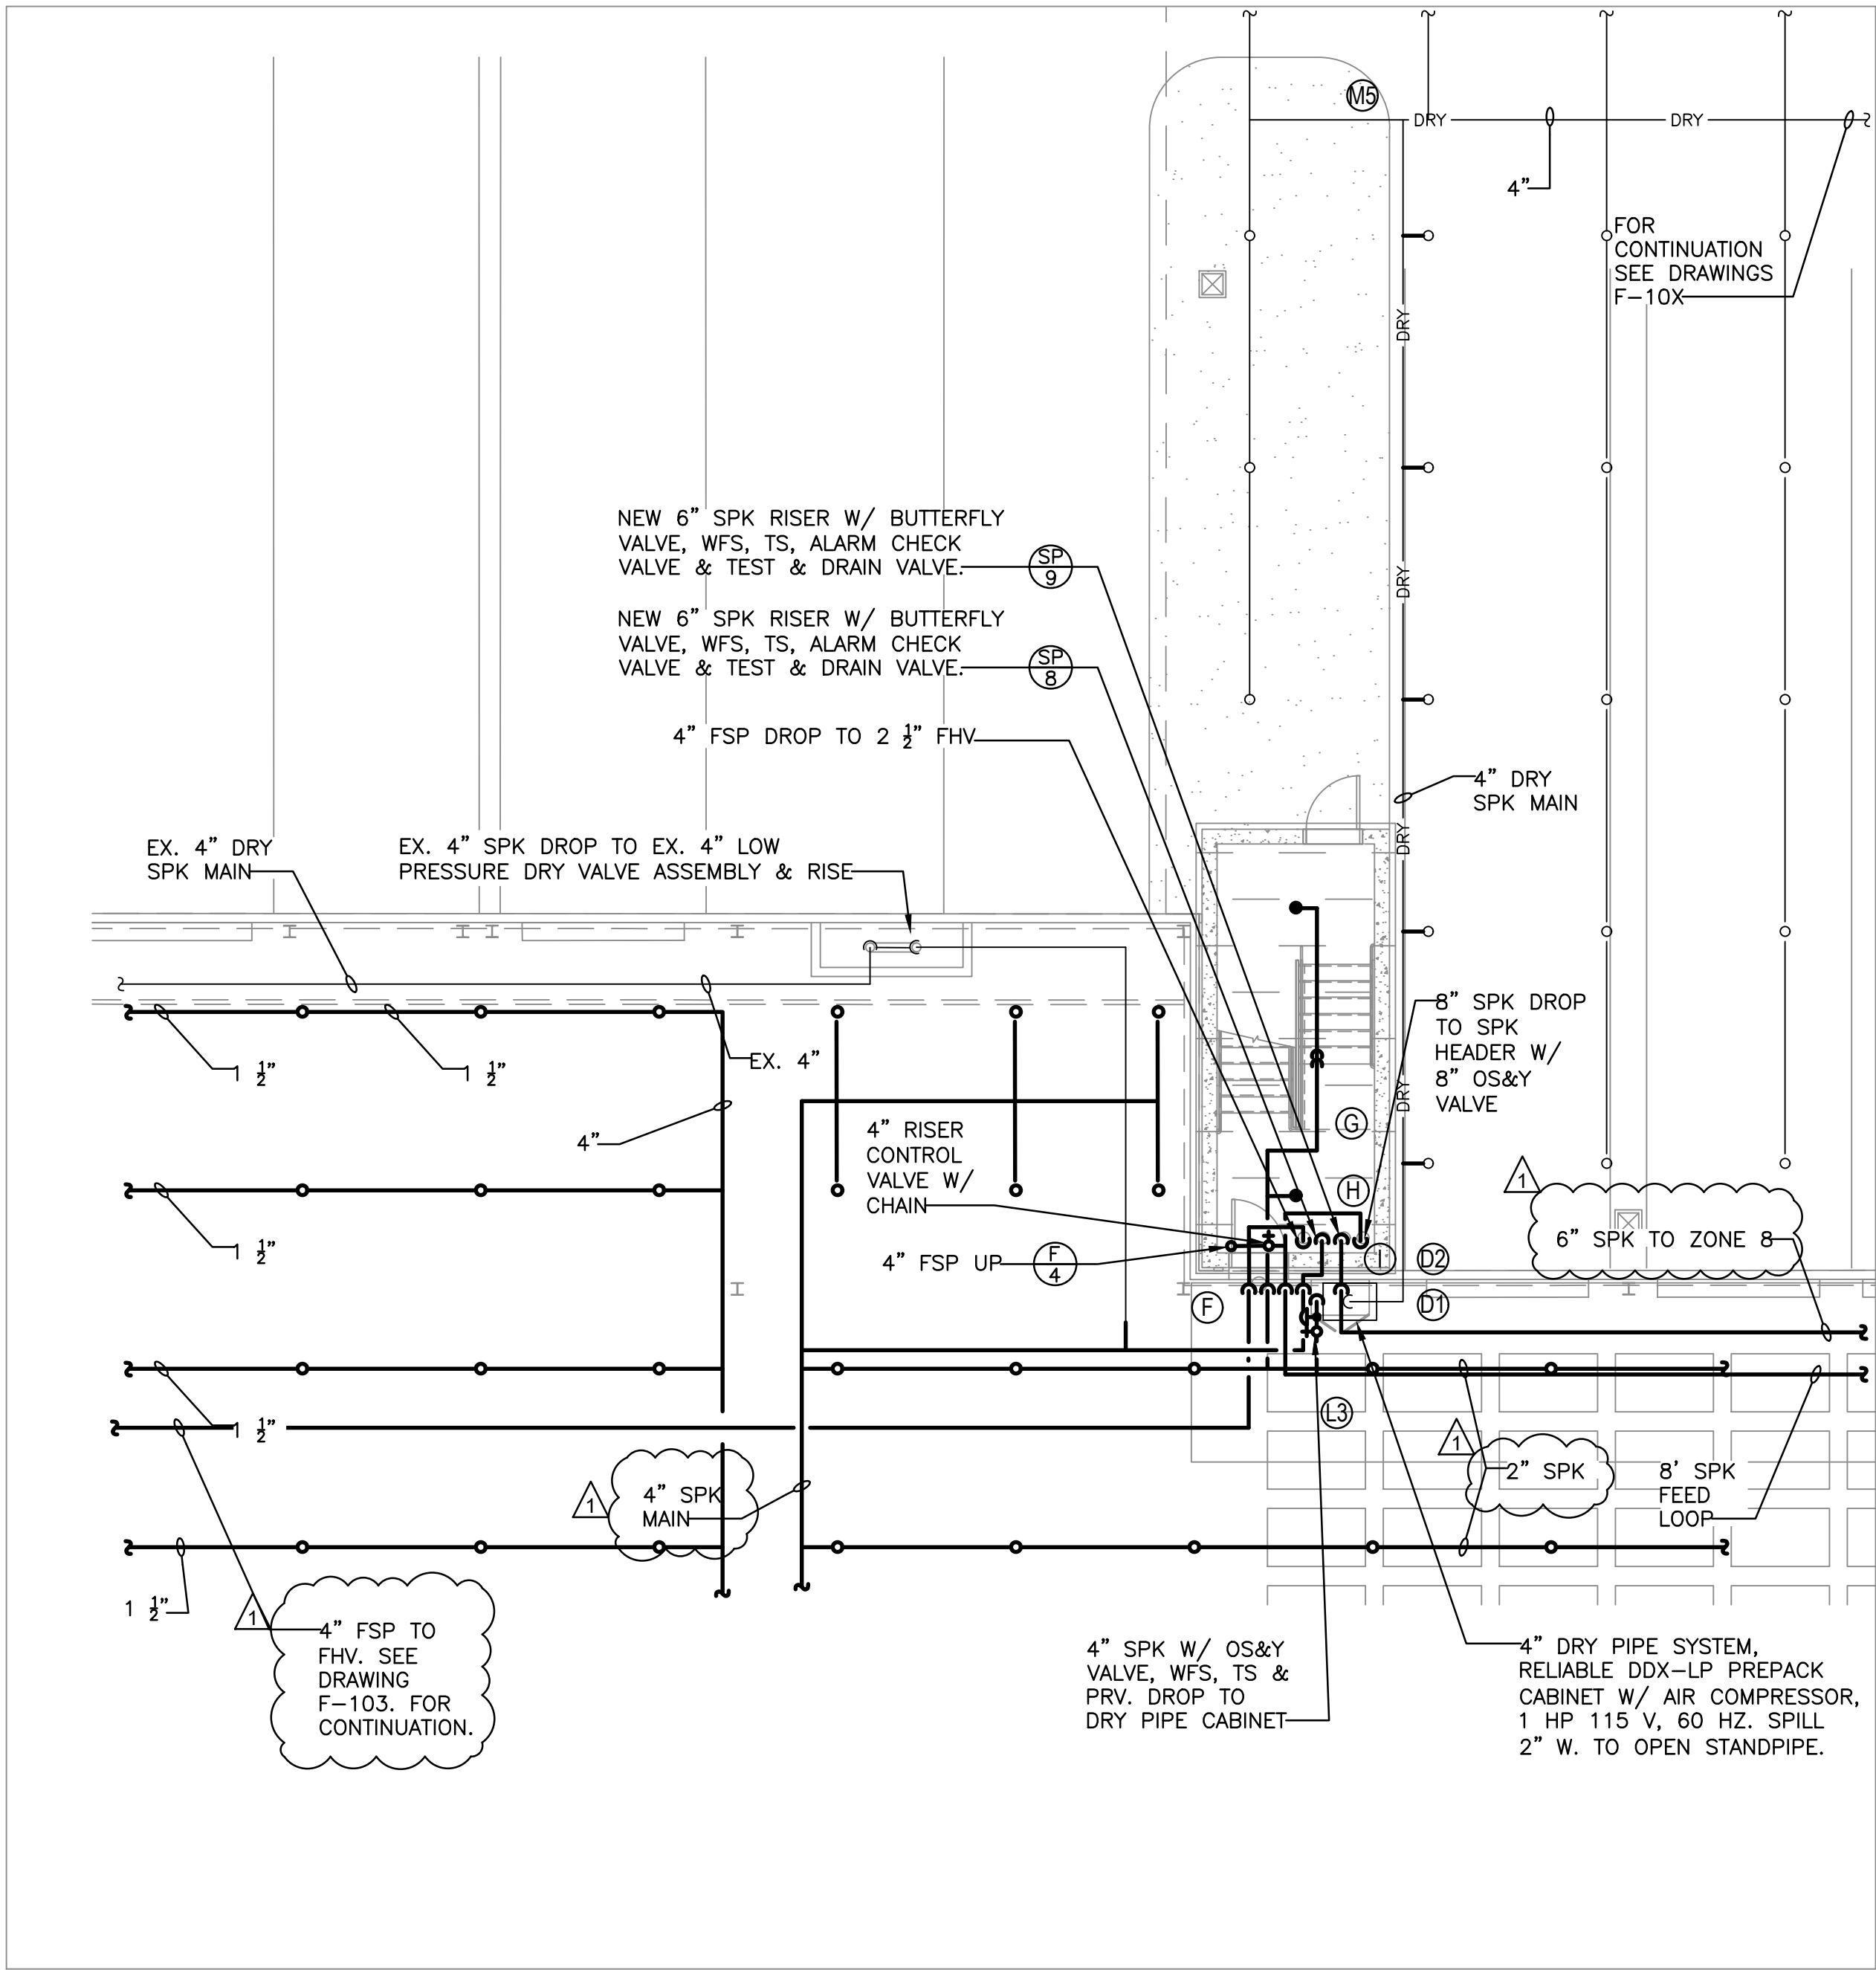


1 FIRE PROTECTION STAIR A PART PLAN
F-402 1/8" = 1'-0"

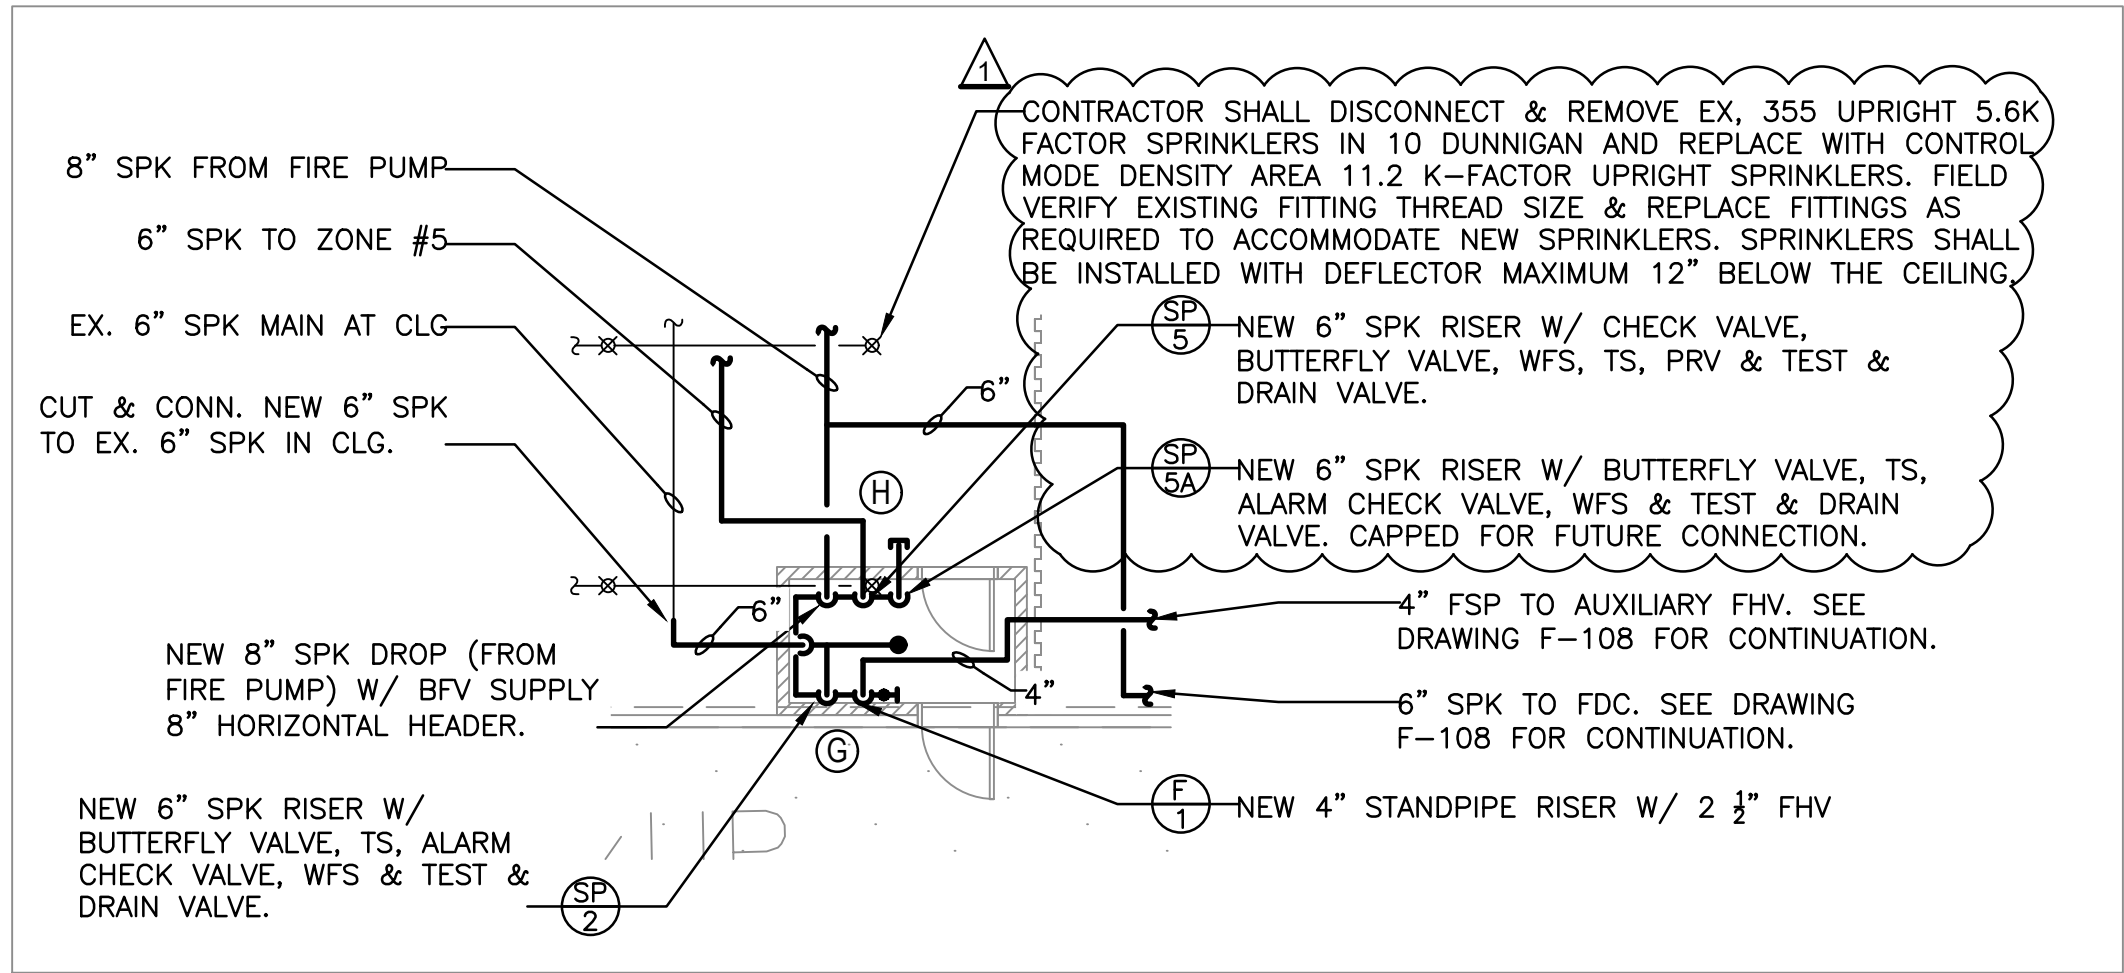


2 SPRINKLER RISER ROOM 111 - PART PLAN
F-402 1/8" = 1'-0"

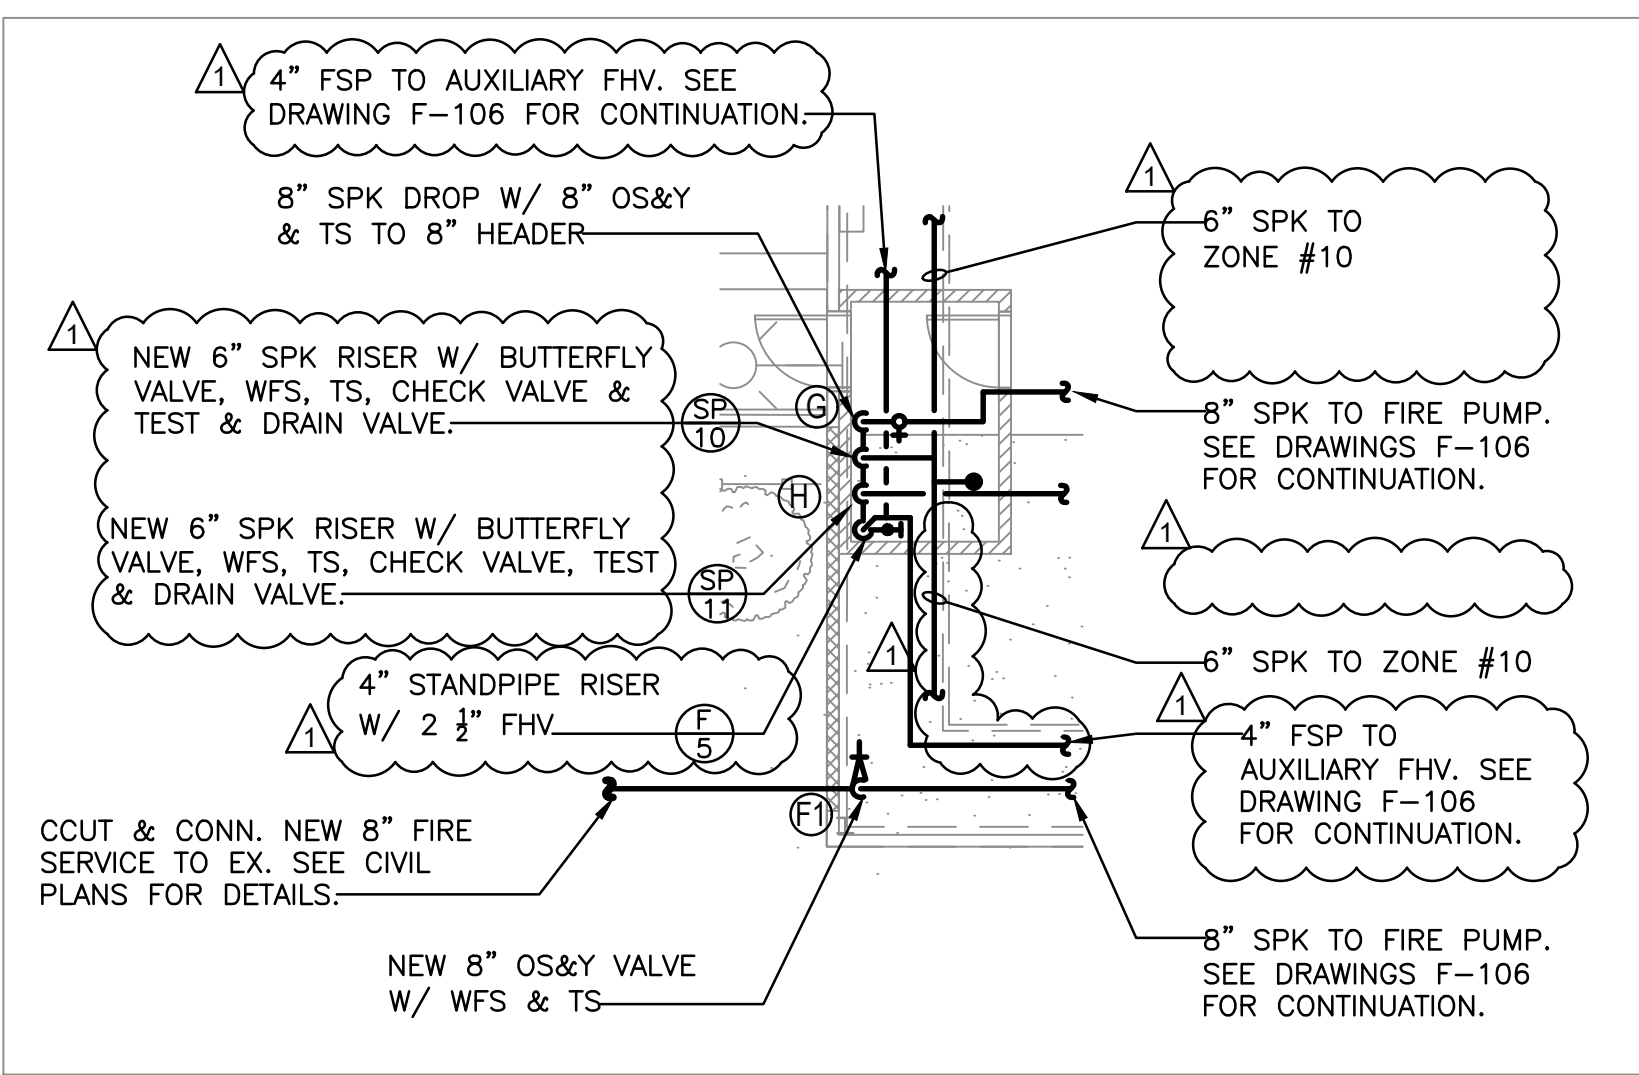

3 SPRINKLER RISER CLOSET 118 PART PLAN
F-402 1/8" = 1'-0"

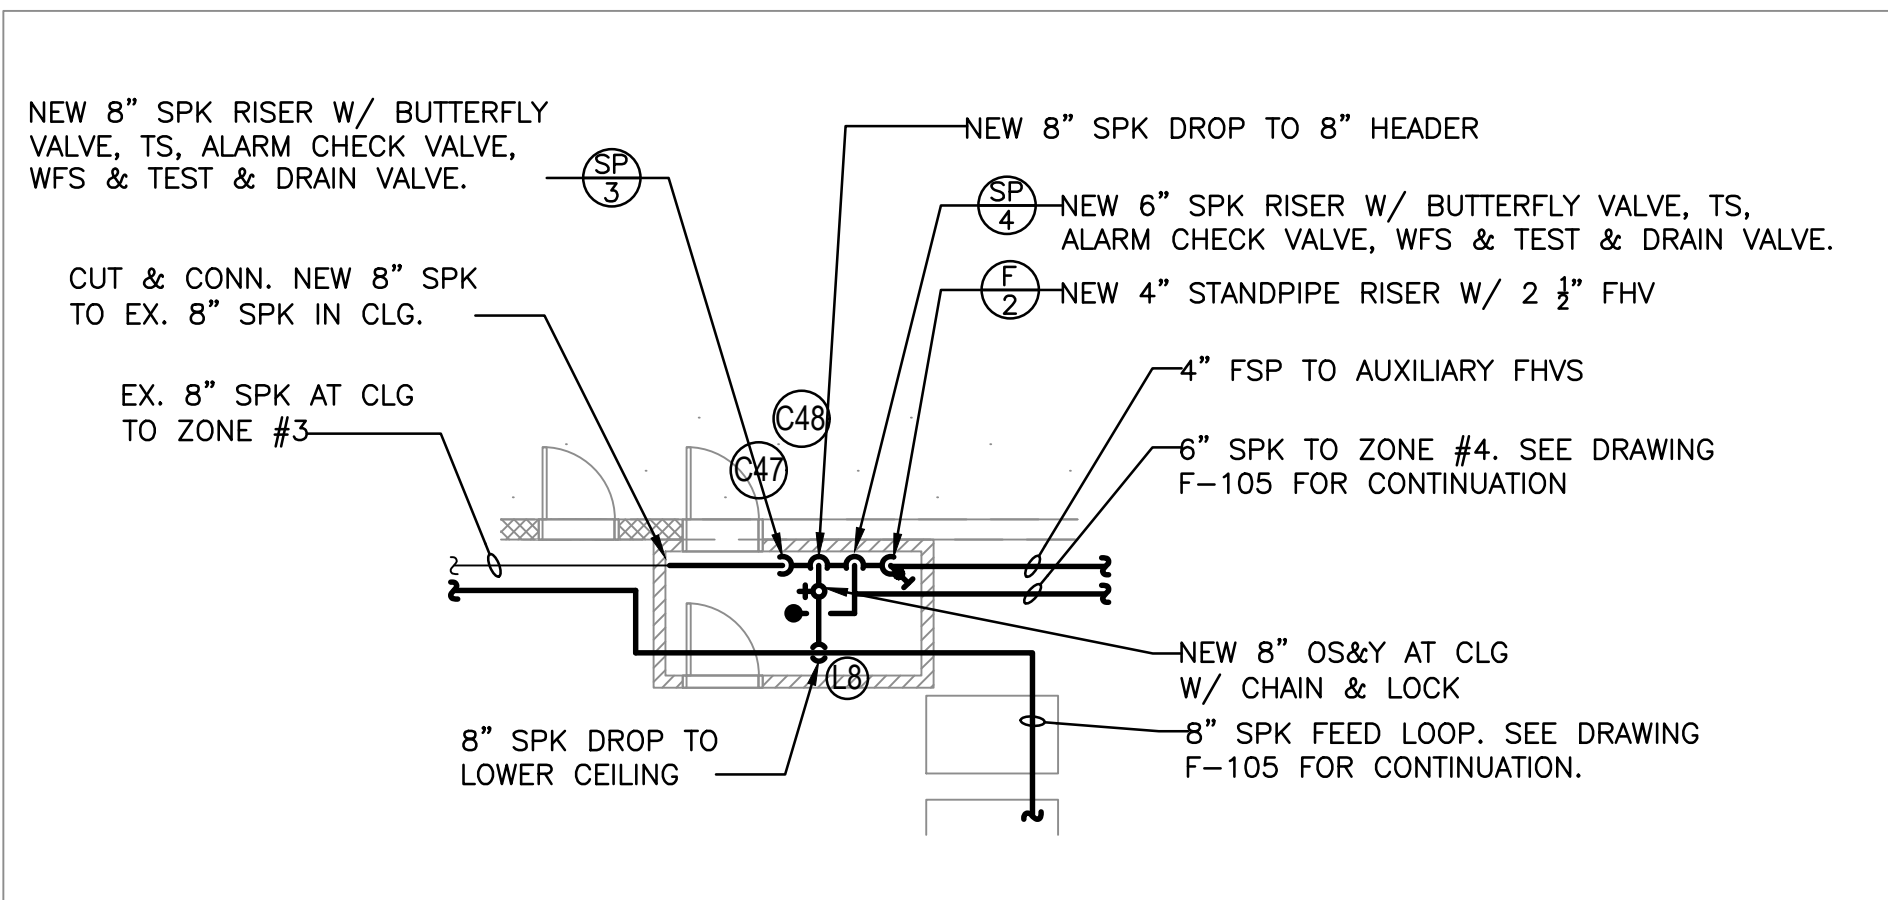

4 SPRINKLER RISER ROOM 109 - PART PLAN
F-402 1/8" = 1'-0"

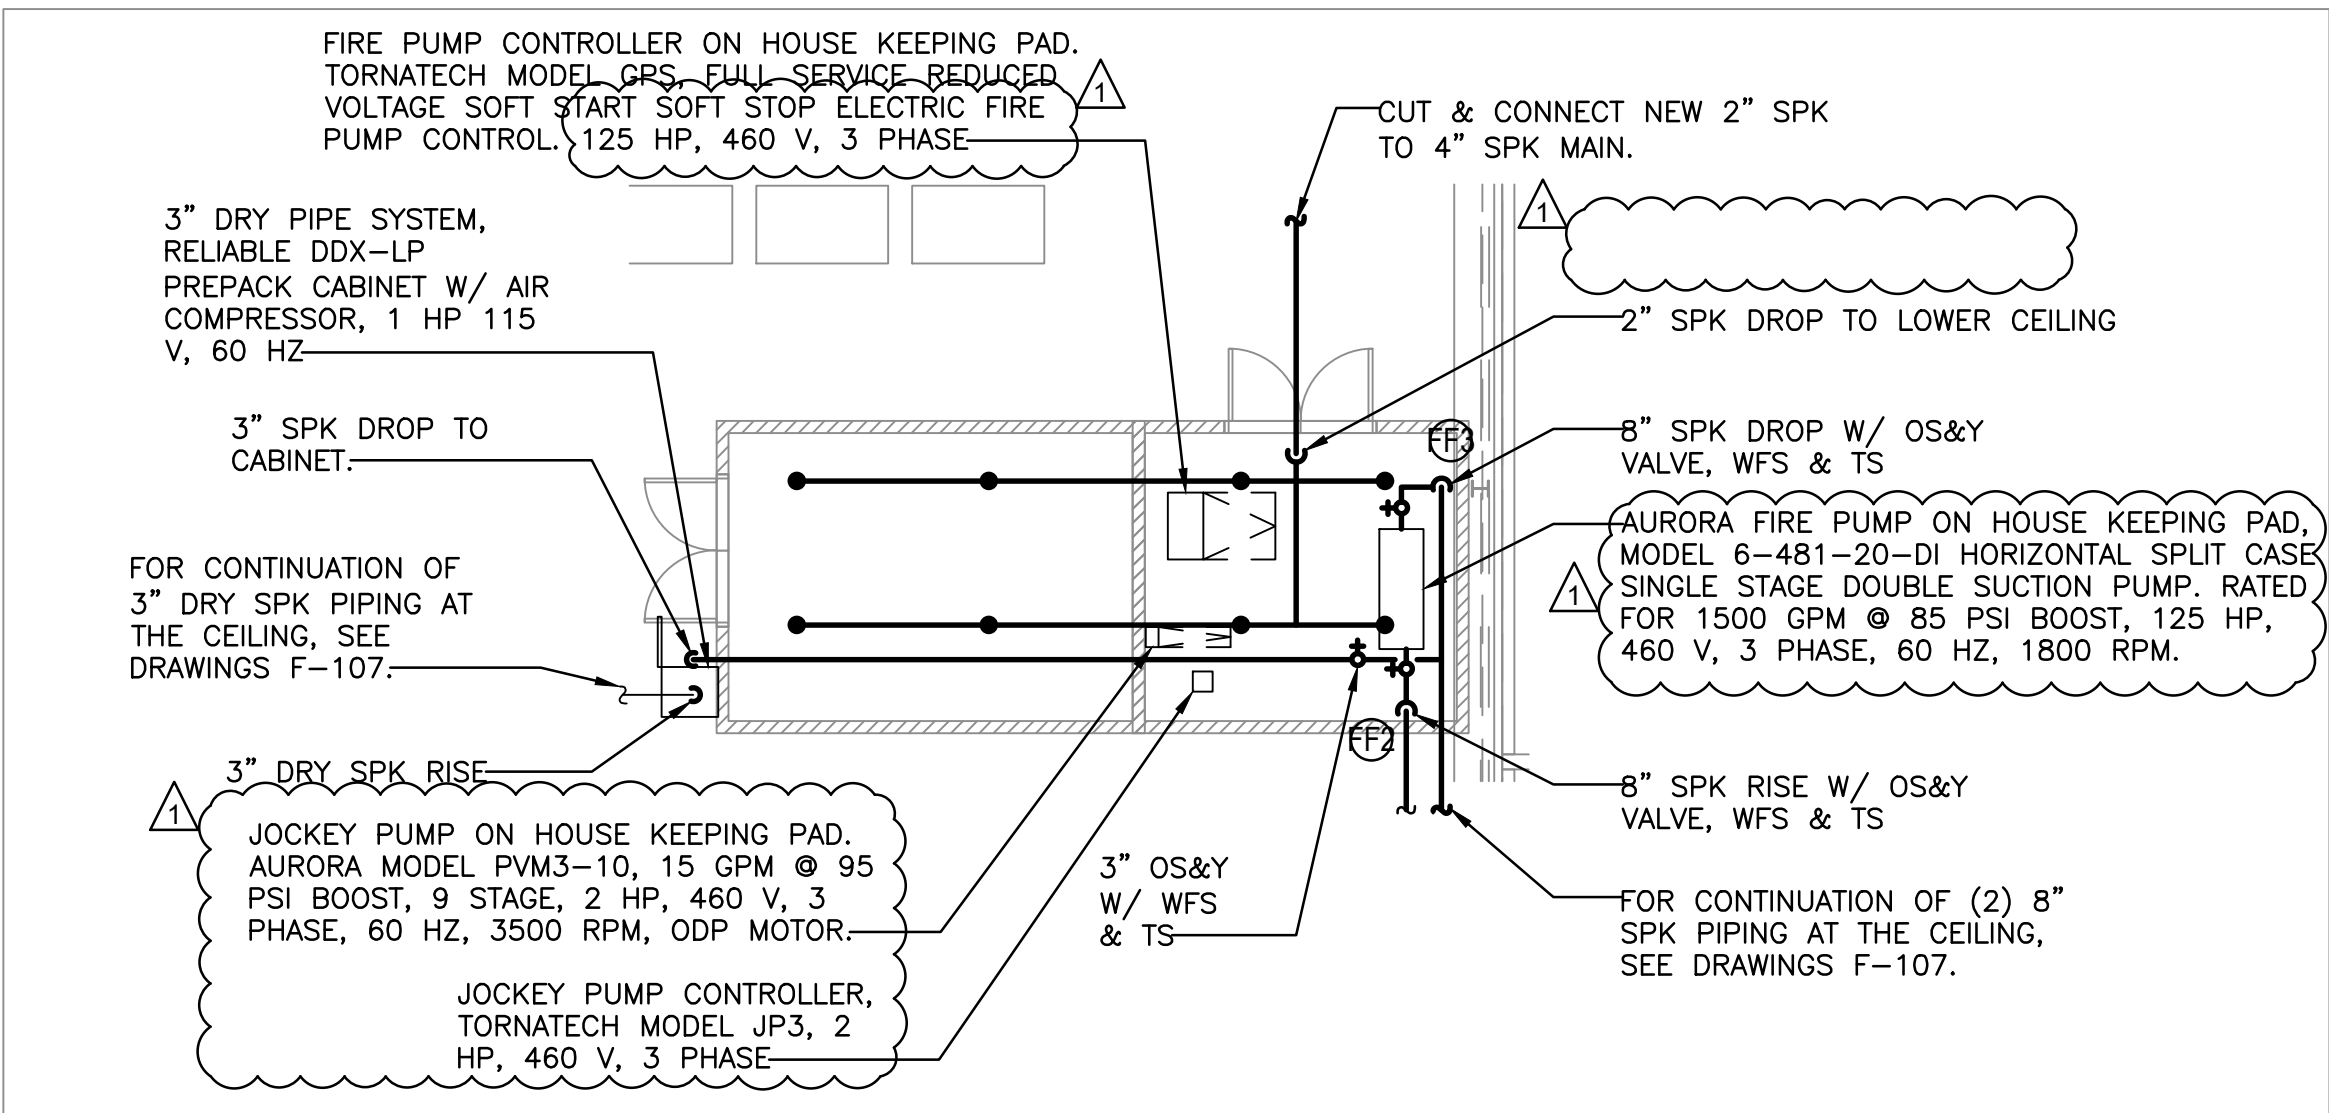

5 FIRE PUMP ROOM PART PLAN
F-402 1/8" = 1'-0"

TO THE BEST KNOWLEDGE, BELIEF AND PROFESSIONAL JUDGEMENT, THESE PLANS AND SPECIFICATIONS ARE IN COMPLIANCE WITH THE 2020 ENERGY CONSERVATION CONSTRUCTION CODE OF NEW YORK STATE.

ARCHITECT
di Domenico + Partners LLP
Architecture
Landscape Architecture
Planning
3743 Crescent Street, 3rd Floor
Long Island City, New York 11101
Tel 212-337-0400
Fax 212-337-3567

CIVIL PLANNING ENGINEER
JMC
JMC Planning Engineering Landscape
Architecture & Land Surveying, PLLC
120 Bedford Road
Armonk, New York 10504
Tel 914-273-5225
Fax 914-273-2102

MEP ENGINEER
Burns
BURNS ENGINEERING, PC.
1261 Broadway, Suite 708
New York, New York 10001
Tel 212-962-3503

STRUCTURAL ENGINEER
GEI
GEI50
1385 Broadway, 20th FL
New York, New York 10018
Tel 212-687-8282



MANHATTAN BEER DISTRIBUTORS
20 DUNNIGAN DRIVE
SUFFERN, NEW YORK

KEY PLAN

REV	DESCRIPTION	DATE
	ISSUED FOR DOB SUBMISSION	09/10/2021
	ISSUED FOR BID	10/15/2021
Δ	ISSUED FOR PROGRESS	01/18/2022

DRAWN BY :	M.ESPINAL
CHECKED BY :	J.CLARK
APPROVED BY :	J.MIZRAHI
DATE :	04/16/21
SCALE :	SEE PLANS

DRAWING TITLE :
**FIRE PROTECTION
PART PLANS**

DWG NUMBER :	F-402
--------------	-------