


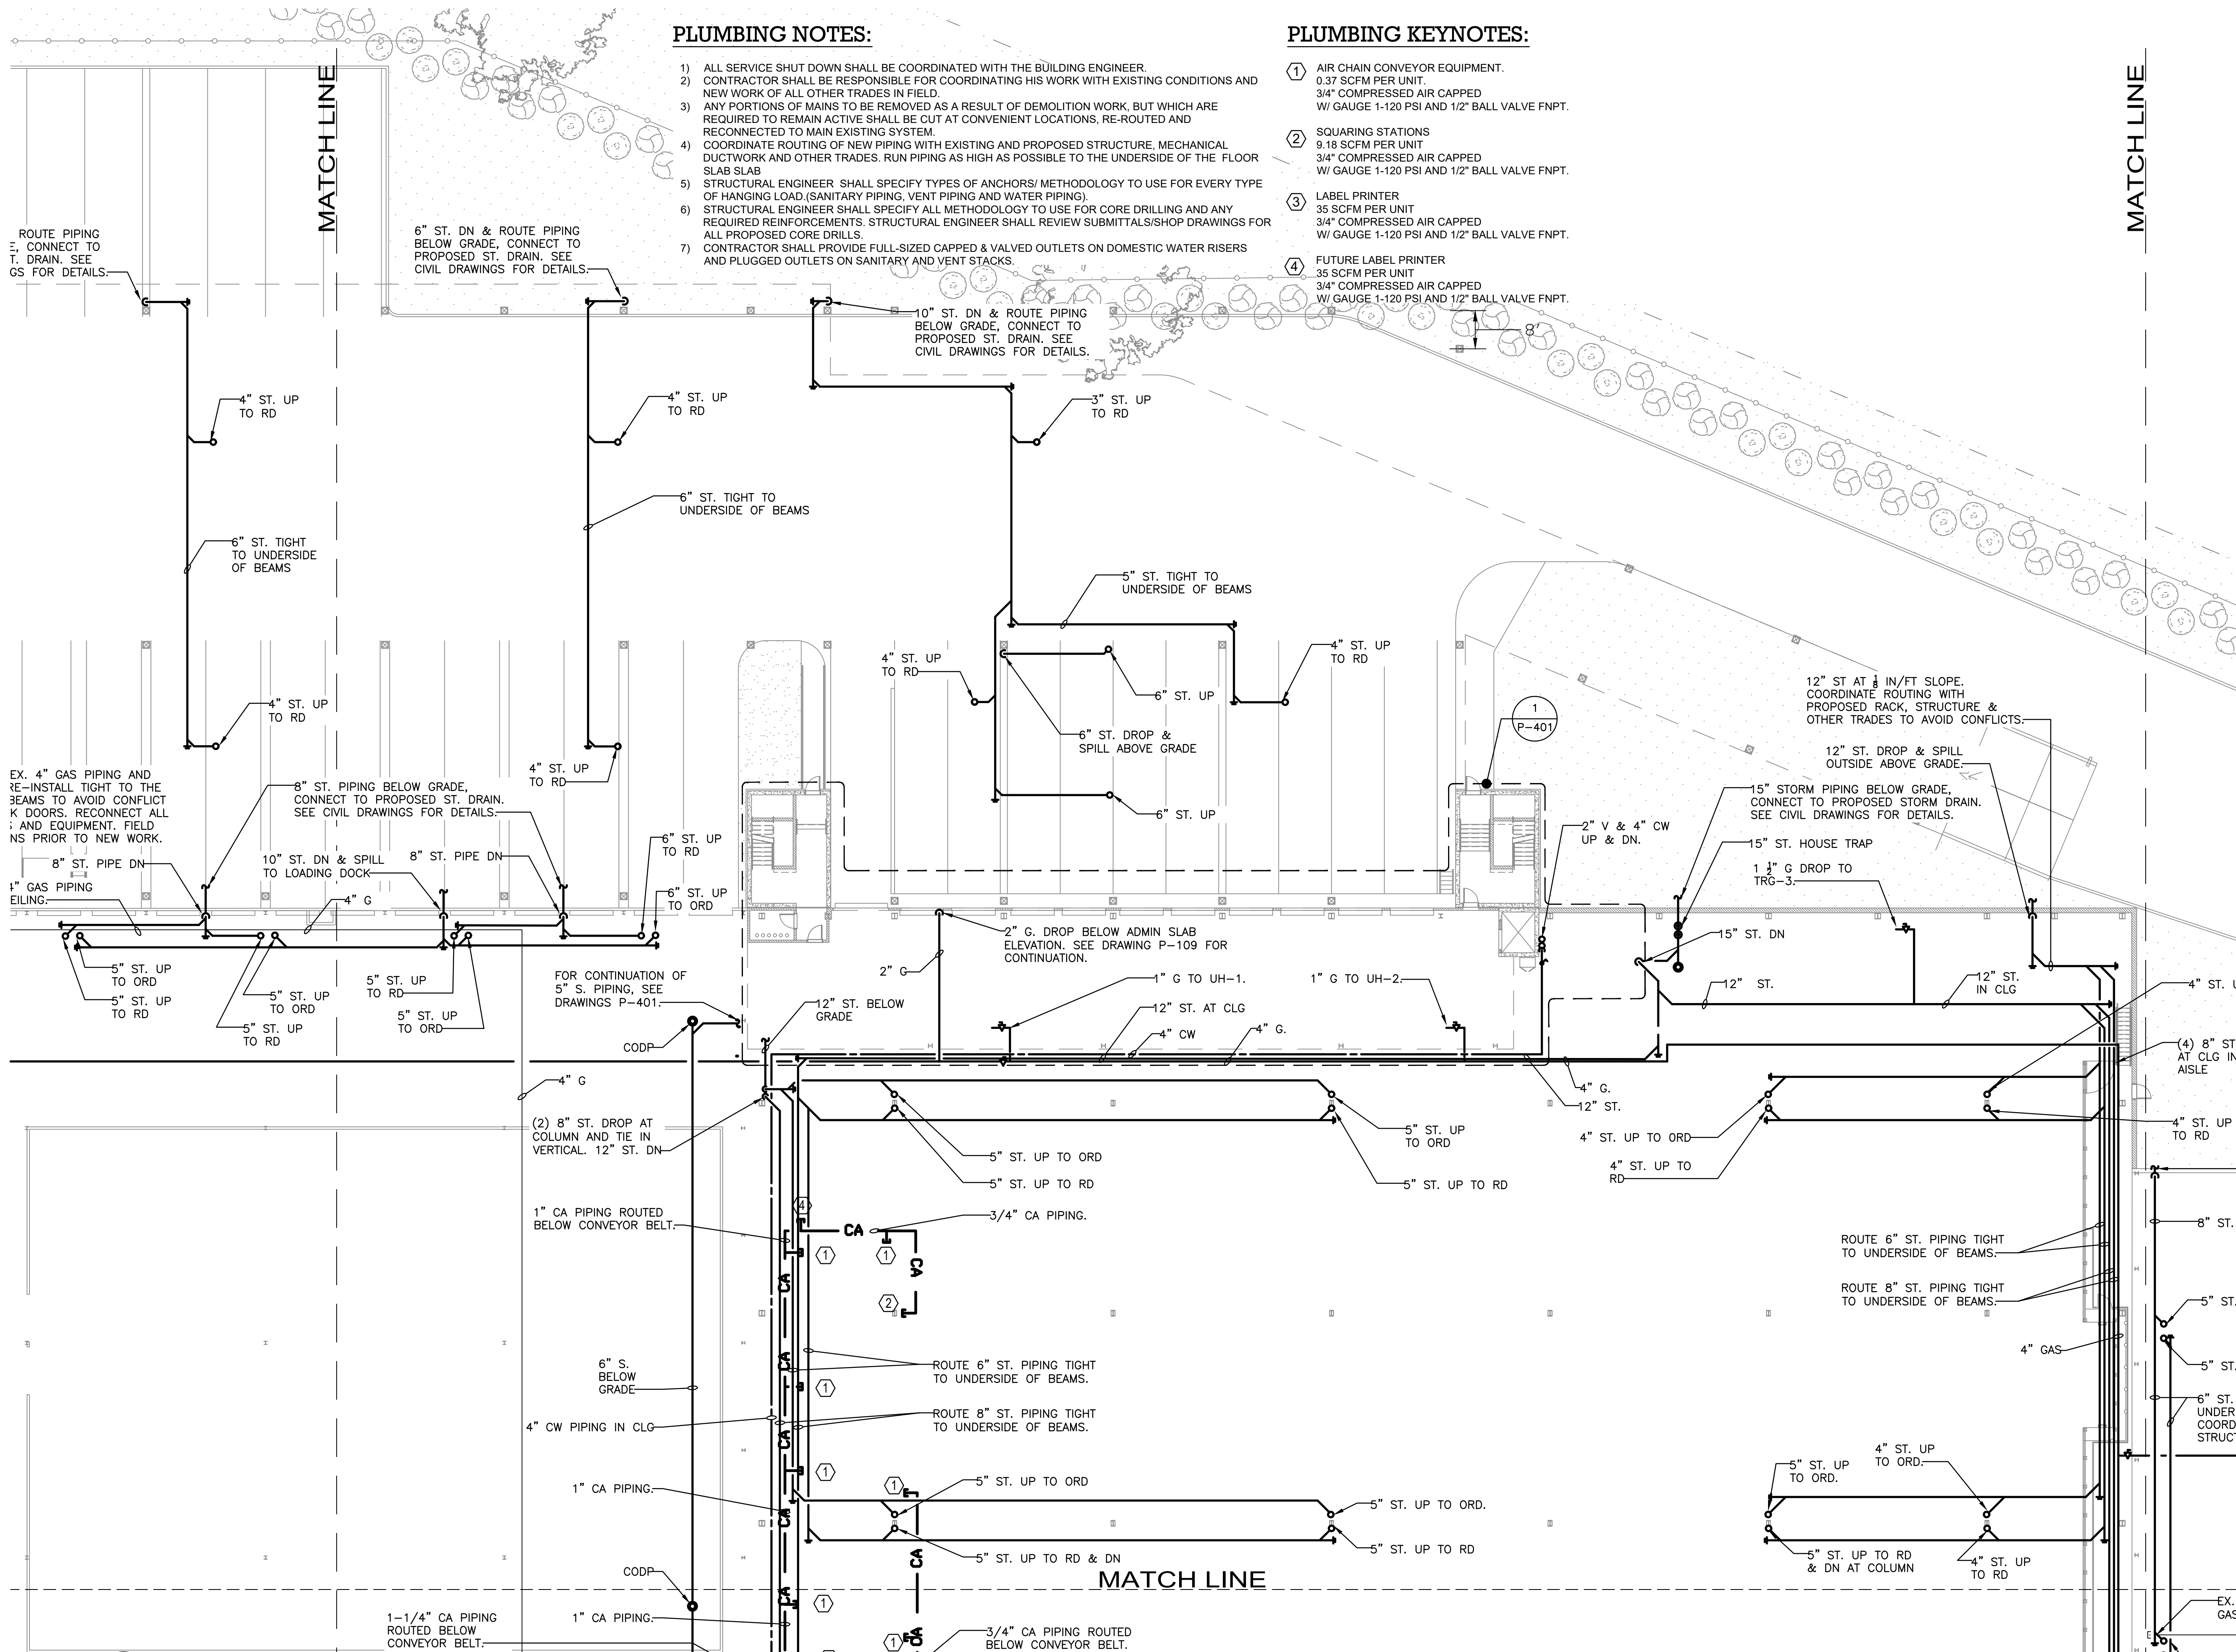

PLUMBING NOTES:

- 1) ALL SERVICE SHUT DOWN SHALL BE COORDINATED WITH THE BUILDING ENGINEER.
- 2) CONTRACTOR SHALL BE RESPONSIBLE FOR COORDINATING HIS WORK WITH EXISTING CONDITIONS AND NEW WORK OF ALL OTHER TRADES IN FIELD.
- 3) ANY PORTIONS OF MAINS TO BE REMOVED AS A RESULT OF DEMOLITION WORK, BUT WHICH ARE REQUIRED TO REMAIN ACTIVE SHALL BE CUT AT CONVENIENT LOCATIONS, RE-ROUTED AND RECONNECTED TO MAIN EXISTING SYSTEM.
- 4) COORDINATE ROUTING OF NEW PIPING WITH EXISTING AND PROPOSED STRUCTURE, MECHANICAL DUCTWORK AND OTHER TRADES. RUN PIPING AS HIGH AS POSSIBLE TO THE UNDERSIDE OF THE FLOOR SLAB SLAB.
- 5) STRUCTURAL ENGINEER SHALL SPECIFY TYPES OF ANCHORS/ METHODOLOGY TO USE FOR EVERY TYPE OF HANGING LOAD.(SANITARY PIPING, VENT PIPING AND WATER PIPING).
- 6) STRUCTURAL ENGINEER SHALL SPECIFY ALL METHODOLOGY TO USE FOR CORE DRILLING AND ANY REQUIRED REINFORCEMENTS. STRUCTURAL ENGINEER SHALL REVIEW SUBMITTALS/SHOP DRAWINGS FOR ALL PROPOSED CORE DRILLS.
- 7) CONTRACTOR SHALL PROVIDE FULL-SIZED CAPPED & VALVED OUTLETS ON DOMESTIC WATER RISERS AND PLUGGED OUTLETS ON SANITARY AND VENT STACKS.

PLUMBING KEYNOTES:

- 1) AIR CHAIN CONVEYOR EQUIPMENT.
0.37 SCFM PER UNIT.
3/4" COMPRESSED AIR CAPPED
W/ GAUGE 1-120 PSI AND 1/2" BALL VALVE FNPT.
- 2) SQUARING STATIONS
9.18 SCFM PER UNIT
3/4" COMPRESSED AIR CAPPED
W/ GAUGE 1-120 PSI AND 1/2" BALL VALVE FNPT.
- 3) LABEL PRINTER
35 SCFM PER UNIT
3/4" COMPRESSED AIR CAPPED
W/ GAUGE 1-120 PSI AND 1/2" BALL VALVE FNPT.
- 4) FUTURE LABEL PRINTER
35 SCFM PER UNIT
3/4" COMPRESSED AIR CAPPED
W/ GAUGE 1-120 PSI AND 1/2" BALL VALVE FNPT.

ARCHITECT
di Domenico + Partners LLP
Architecture
Landscape Architecture
Planning
3743 Crescent Street, 3rd Floor
Long Island City, New York 11101
Tel 212-337-0400
Fax 212-337-3567

CIVIL PLANNING ENGINEER
JMC
JMC Planning Engineering Landscape
Architecture & Land Surveying, PLLC
120 Bedford Road
Armonk, New York 10504
Tel 914-273-5225
Fax 914-273-2102

MEP ENGINEER
Burns
BURNS ENGINEERING, PC.
1261 Broadway, Suite 708
New York, New York 10001
Tel 212-962-3503

STRUCTURAL ENGINEER
GEI
GEI50
1385 Broadway, 20th FL
New York, New York 10018
Tel 212-687-8282



MANHATTAN BEER DISTRIBUTORS
20 DUNNIGAN DRIVE
SUFFERN, NEW YORK

KEY PLAN

REV	DESCRIPTION	DATE
	ISSUED FOR DOB SUBMISSION	09/10/2021
	ISSUED FOR BID	10/15/2021
Δ	ISSUED FOR PROGRESS	01/18/2022
	ISSUED FOR BID	08/30/2022

DRAWN BY: M.ESPINAL
CHECKED BY: J.CLARK
APPROVED BY: J.MIZRAHI
DATE: 04/16/21
SCALE: 1/16" = 1'-0"

PLUMBING L1 FLOOR PLAN
QUADRANT 2

DWG NUMBER:

P-102

TO THE BEST KNOWLEDGE, BELIEF AND PROFESSIONAL JUDGEMENT,
THESE PLANS AND SPECIFICATIONS ARE IN COMPLIANCE WITH THE 2020
ENERGY CONSERVATION CONSTRUCTION CODE OF NEW YORK STATE.