



PLUMBING NOTES:

- ALL SERVICE SHUT DOWN SHALL BE COORDINATED WITH THE BUILDING ENGINEER.
- CONTRACTOR TO FIELD VERIFY THE EXACT SIZE AND LOCATION OF EXISTING WET COLUMN RISERS/STACKS PRIOR TO ANY CONNECTIONS.
- PLUMBING CONTRACTOR TO FIELD VERIFY EXACT SIZE AND LOCATION OF ALL EXISTING RISERS AND BRANCH PIPING PRIOR TO ANY WORK.
- CONTRACTOR SHALL BE RESPONSIBLE FOR COORDINATING HIS WORK WITH EXISTING CONDITIONS AND NEW WORK OF ALL OTHER TRADES IN FIELD.
- COORDINATE ROUTING OF NEW PIPING AND WITH EXISTING STRUCTURE, EXISTING MECHANICAL DUCTWORK AND OTHER TRADES. RUN PIPING AS HIGH AS POSSIBLE TO THE UNDERSIDE OF THE FLOOR SLAB ABOVE.
- STRUCTURAL ENGINEER SHALL SPECIFY TYPES OF ANCHORS/ METHODOLOGY TO USE FOR EVERY TYPE OF HANGING LOAD. (SANITARY PIPING, VENT PIPING AND WATER PIPING).
- STRUCTURAL ENGINEER SHALL SPECIFY ALL METHODOLOGY TO USE FOR CORE DRILLING AND ANY REQUIRED REINFORCEMENTS. STRUCTURAL ENGINEER SHALL REVIEW SUBMITTALS/SHOP DRAWINGS FOR ALL PROPOSED CORE DRILLS.
- REFER TO ARCHITECTURAL DRAWING FOR PLUMBING FIXTURE SCHEDULE.
- MINIMUM SPACE REQUIREMENT INSIDE STUD WALL FOR WALL HUNG WATER CLOSET CARRIER SHALL BE 11"- 14" (SINGLE WATER CLOSET) AND 16"-24" BACK TO BACK WATER CLOSET.
- ALL LAVATORIES SHALL BE EQUIPPED WITH THERMOSTATIC MIXING VALVES IF TEMPERATURE EXCEEDS 110 DEG. F.
- CONTRACTOR SHALL PROVIDE FULL-SIZED CAPPED & VALVED OUTLETS ON DOMESTIC WATER RISERS AND PLUGGED OUTLETS ON SANITARY AND VENT STACKS.

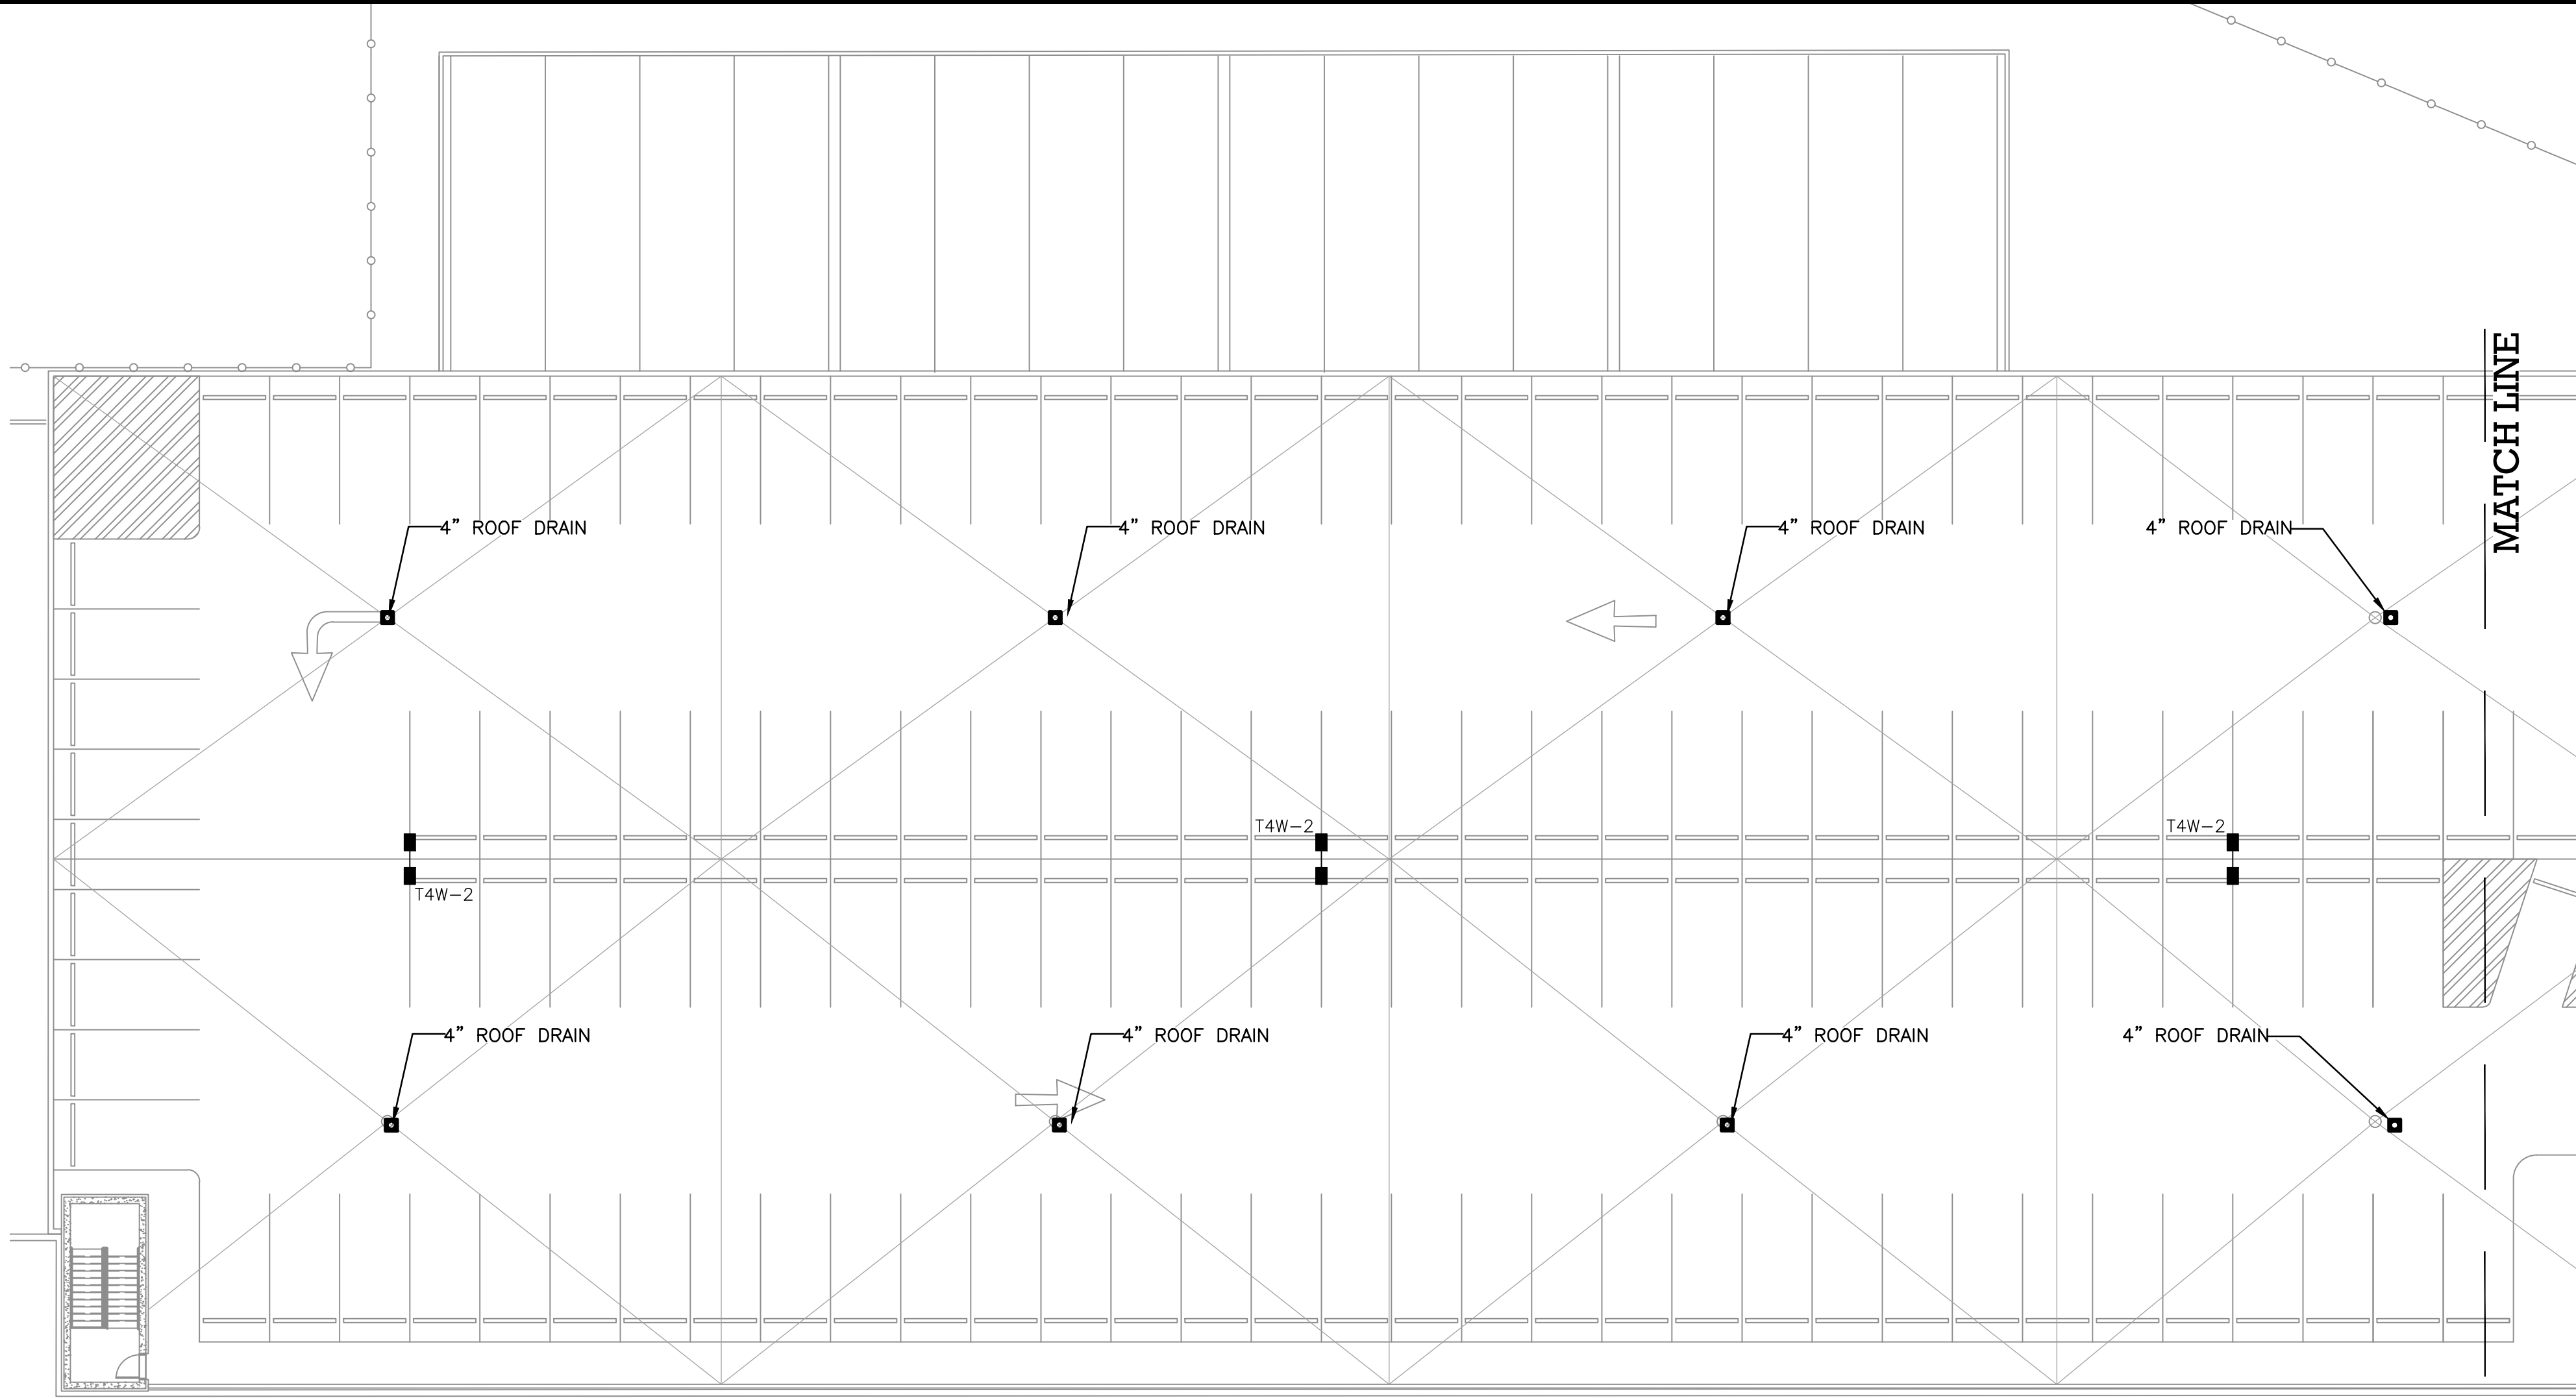

1 PARKING DECK PART PLAN
P-108 1/16" = 1'-0"

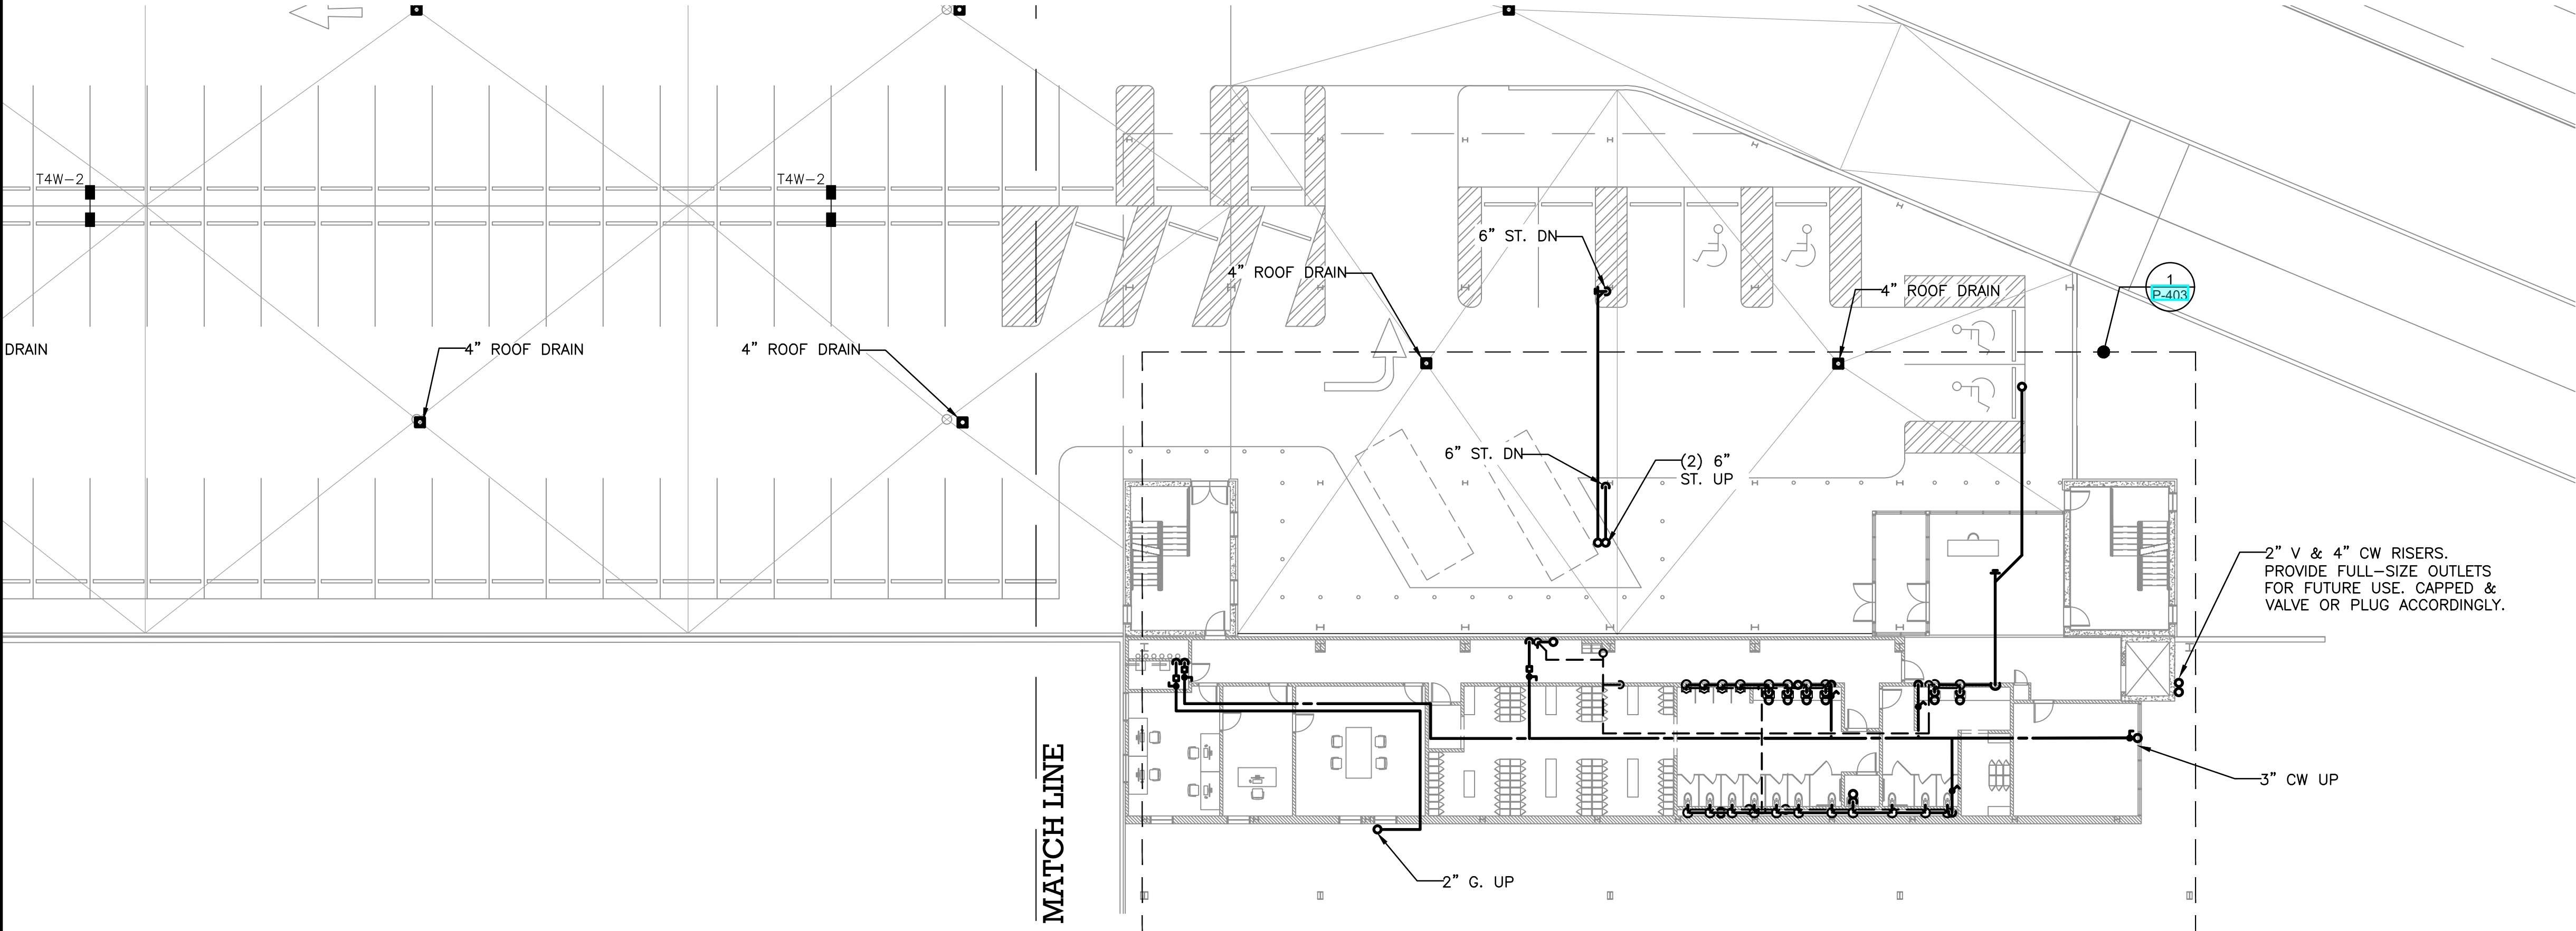

2 PARKING DECK PART PLAN
P-108 1/16" = 1'-0"



TO THE BEST KNOWLEDGE, BELIEF AND PROFESSIONAL JUDGEMENT, THESE PLANS AND SPECIFICATIONS ARE IN COMPLIANCE WITH THE 2020 ENERGY CONSERVATION CONSTRUCTION CODE OF NEW YORK STATE.

ARCHITECT
di Domenico + Partners LLP
Architecture
Landscape Architecture
Planning
3743 Crescent Street, 3rd Floor
Long Island City, New York 11101
Tel 212-337-0400
Fax 212-337-3567

CIVIL PLANNING ENGINEER
JMC
JMC Planning Engineering Landscape
Architecture & Land Surveying, PLLC
120 Bedford Road
Armonk, New York 10504
Tel 914-273-5225
Fax 914-273-2102

MEP ENGINEER
Burns
BURNS ENGINEERING, PC.
1261 Broadway, Suite 708
New York, New York 10001
Tel 212-962-3503

STRUCTURAL ENGINEER
GEI
GEI50
1385 Broadway, 20th FL
New York, New York 10018
Tel 212-687-8282



MANHATTAN BEER DISTRIBUTORS
20 DUNNIGAN DRIVE
SUFFERN, NEW YORK

KEY PLAN

REV	DESCRIPTION	DATE
	ISSUED FOR DOB SUBMISSION	09/10/2021
	ISSUED FOR BID	10/15/2021
	ISSUED FOR PROGRESS	01/18/2022
	ISSUED FOR BID	08/30/2022

DRAWN BY :	M.ESPINAL
CHECKED BY :	J.CLARK
APPROVED BY :	J.MIZRAHI
DATE :	04/16/21
SCALE :	1/8" = 1'-0"

DRAWING TITLE :
PLUMBING L3 FLOOR PLAN

DWG NUMBER :
P-108