



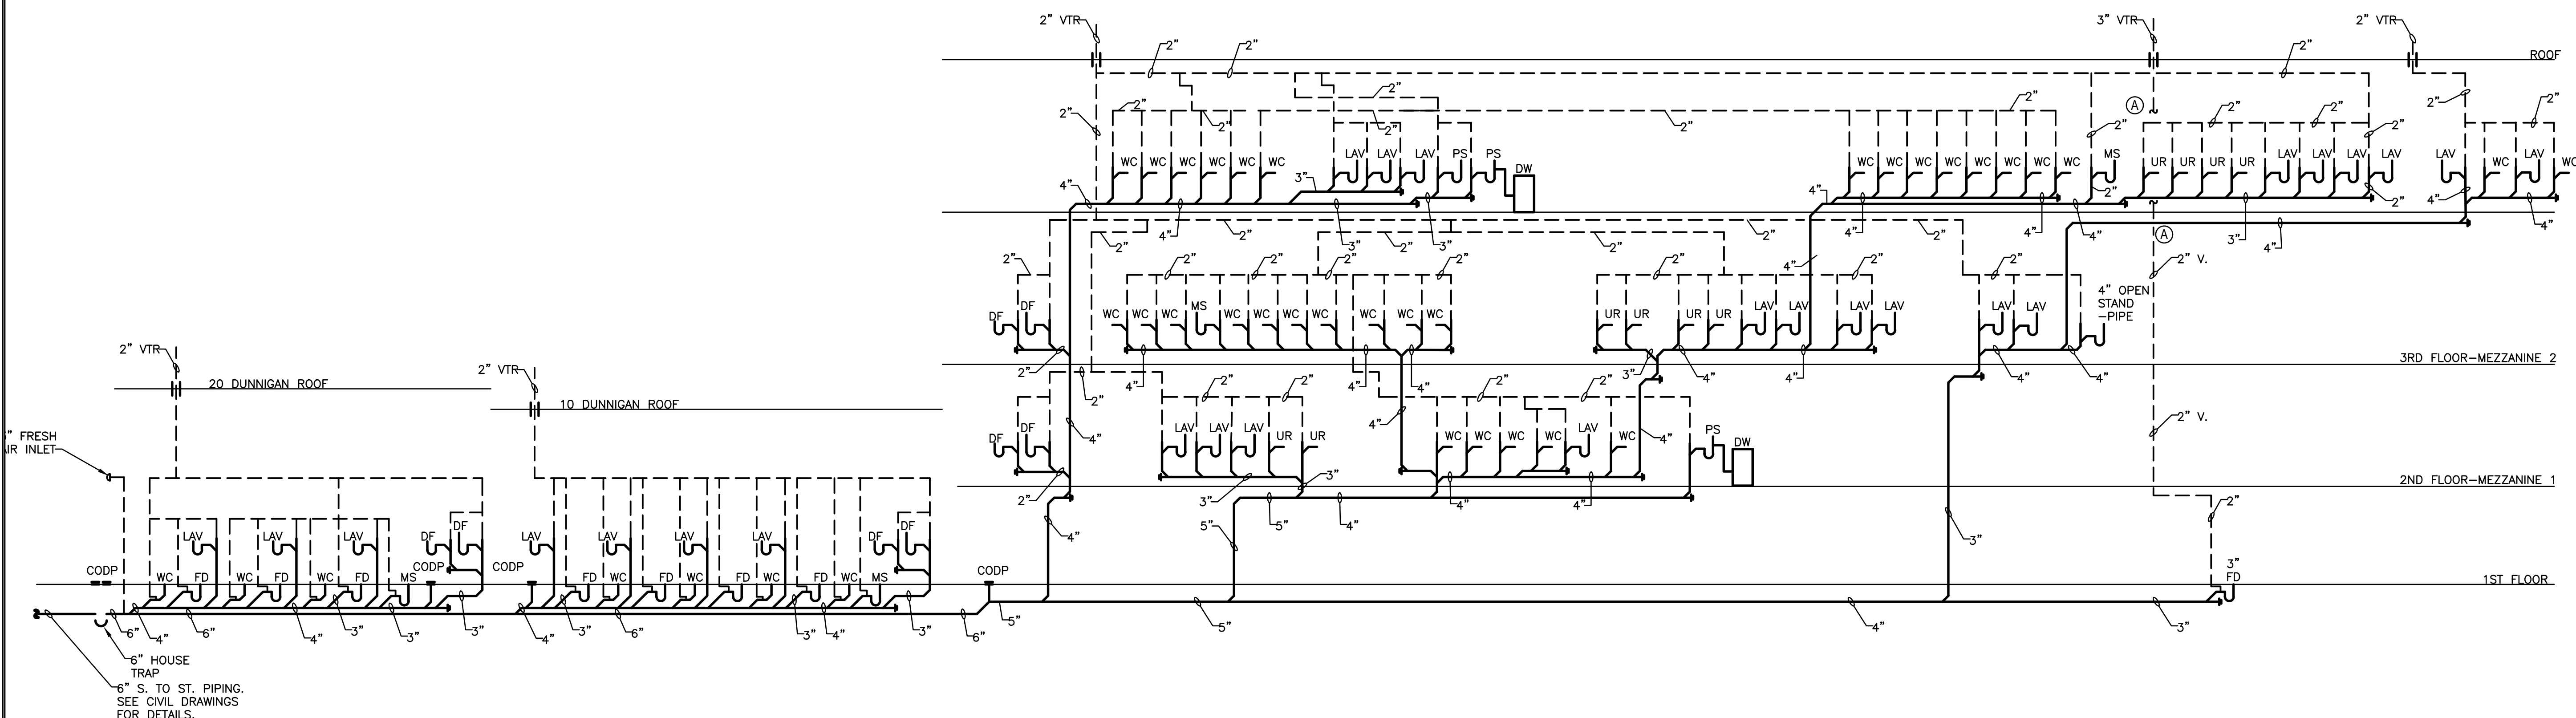

1  
P-702

**SANITARY RISER DIAGRAM**  
NOT TO SCALE

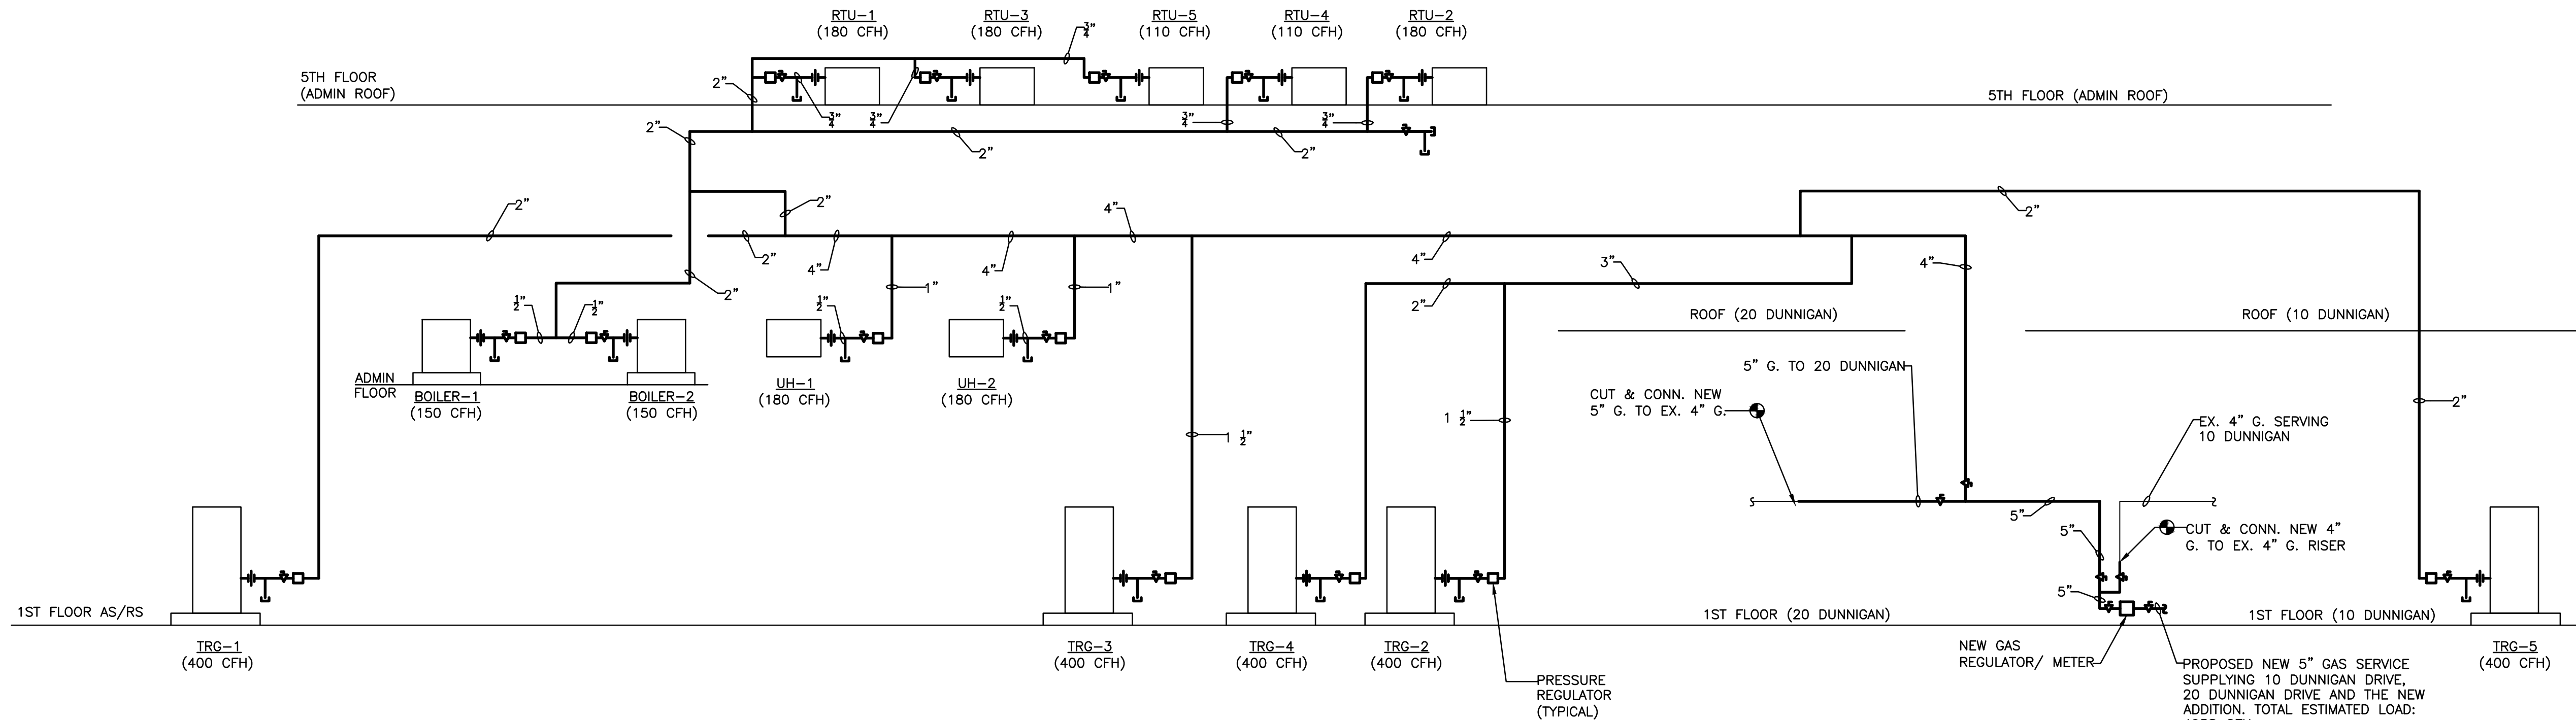

2  
P-702

**GAS RISER DIAGRAM**  
NOT TO SCALE

TO THE BEST KNOWLEDGE, BELIEF AND PROFESSIONAL JUDGEMENT,  
THESE PLANS AND SPECIFICATIONS ARE IN COMPLIANCE WITH THE 2020  
ENERGY CONSERVATION CONSTRUCTION CODE OF NEW YORK STATE.

ARCHITECT  
**di Domenico + Partners LLP**  
Architecture  
Landscape Architecture  
Planning  
3743 Crescent Street, 3rd Floor  
Long Island City, New York 11101  
Tel 212-337-0400  
Fax 212-337-3567

CIVIL PLANNING ENGINEER  
**JMC**  
JMC Planning Engineering Landscape  
Architecture & Land Surveying, PLLC  
120 Bedford Road  
Armonk, New York 10504  
Tel 914-273-5225  
Fax 914-273-2102

MEP ENGINEER  
**Burns**  
BURNS ENGINEERING, PC.  
1261 Broadway, Suite 708  
New York, New York 10001  
Tel 212-962-3503

STRUCTURAL ENGINEER  
**GEI**  
GEI50  
1385 Broadway, 20th FL  
New York, New York 10018  
Tel 212-687-8282



**MANHATTAN BEER DISTRIBUTORS**  
20 DUNNIGAN DRIVE  
SUFFERN, NEW YORK

KEY PLAN

| REV | DESCRIPTION               | DATE       |
|-----|---------------------------|------------|
|     | ISSUED FOR DOB SUBMISSION | 09/10/2021 |
|     | ISSUED FOR BID            | 10/15/2021 |
| Δ   | ISSUED FOR PROGRESS       | 01/18/2022 |
|     | ISSUED FOR BID            | 08/30/2022 |

|               |              |
|---------------|--------------|
| DRAWN BY :    | M.ESPINAL    |
| CHECKED BY :  | J.CLARK      |
| APPROVED BY : | J.MIZRAHI    |
| DATE :        | 04/16/21     |
| SCALE :       | NOT TO SCALE |

DRAWING TITLE :  
**PLUMBING SANITARY AND GAS  
RISER DIAGRAM**

DWG NUMBER :  
**P-702**