
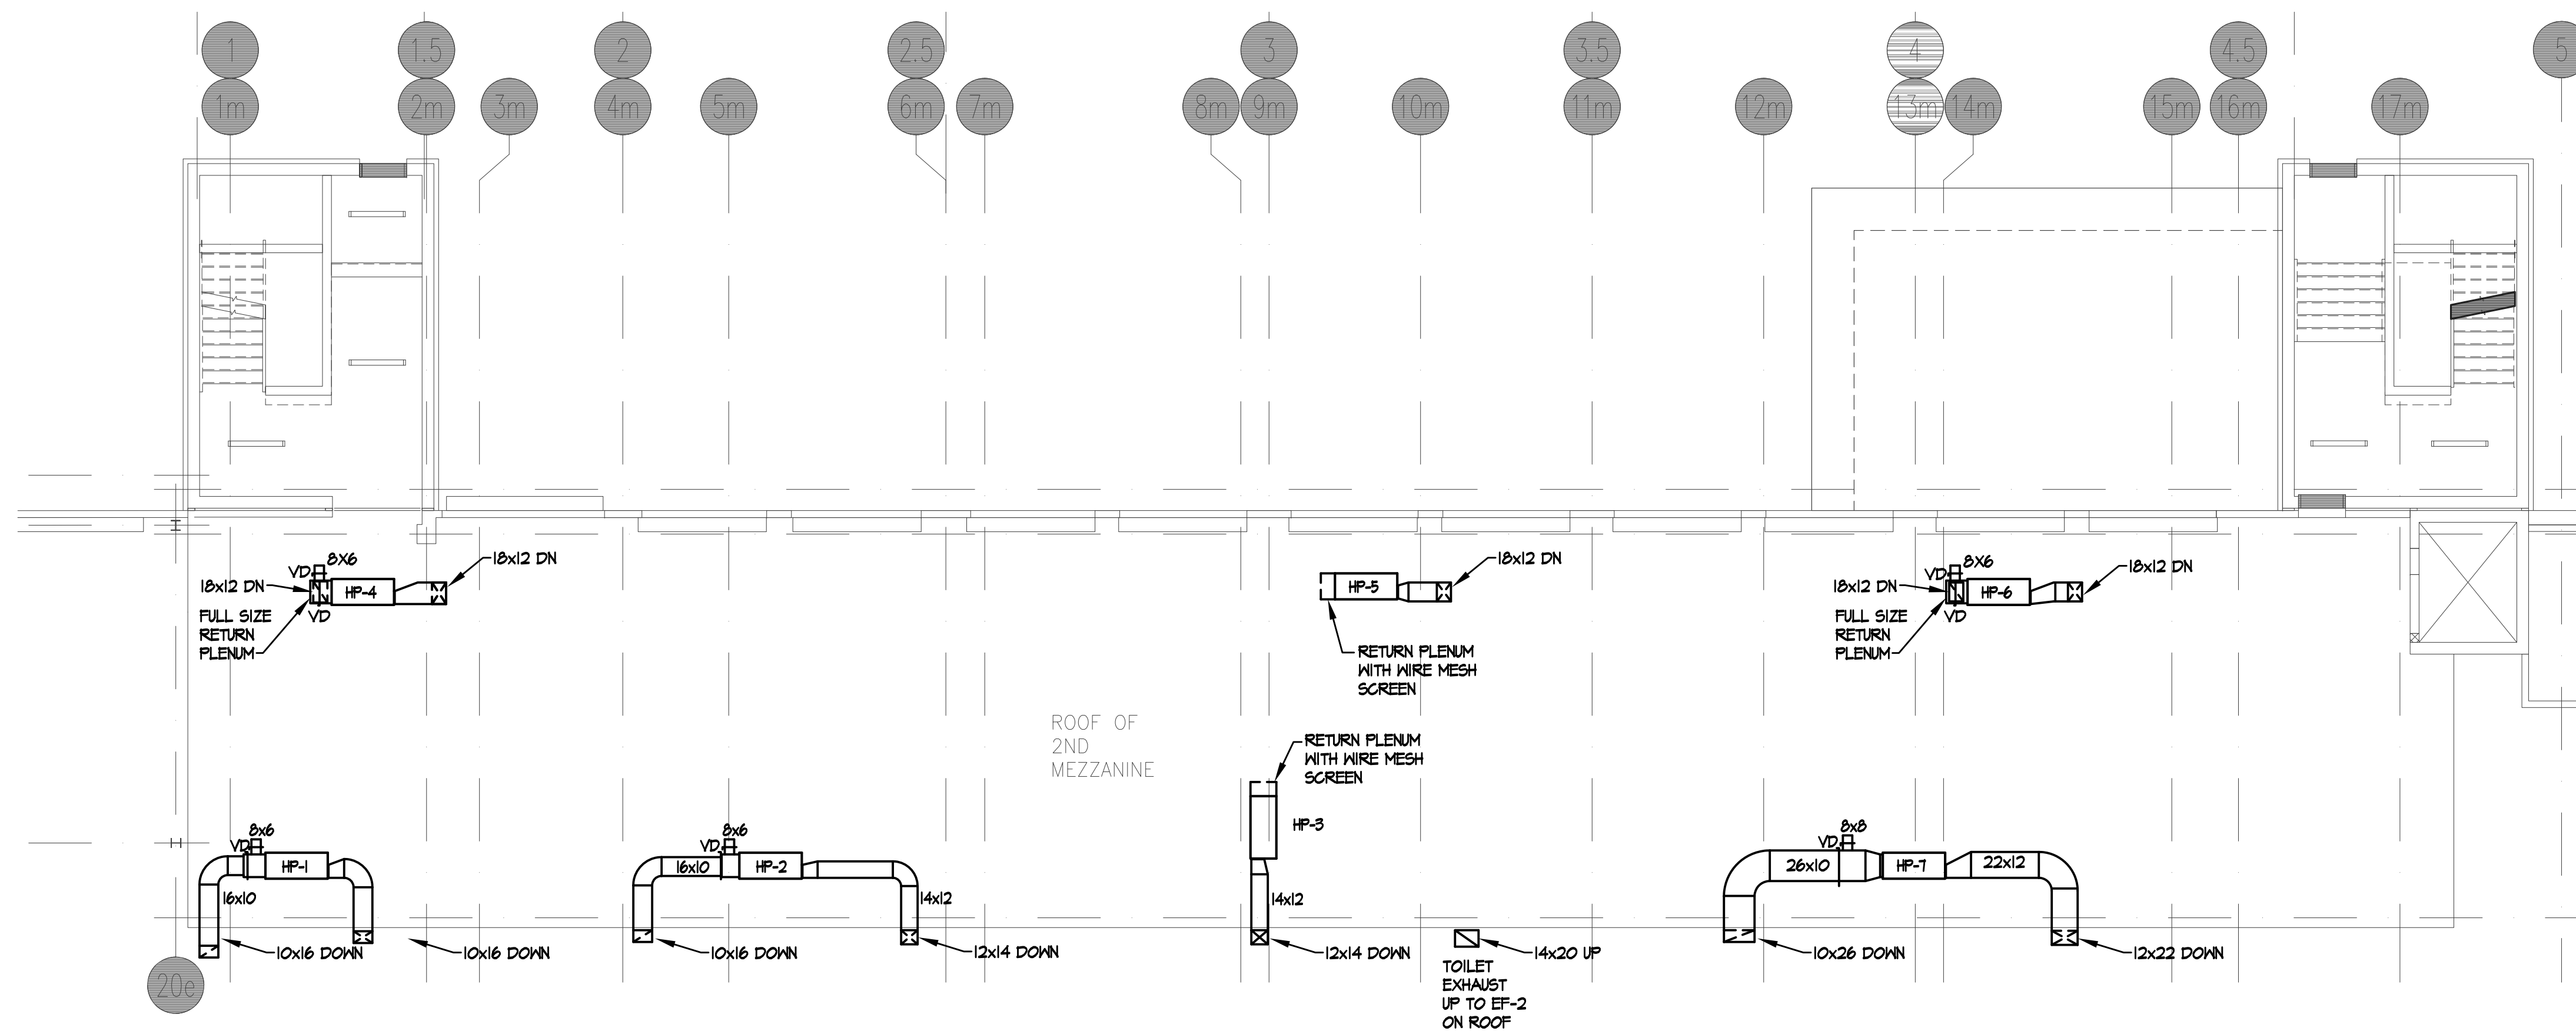


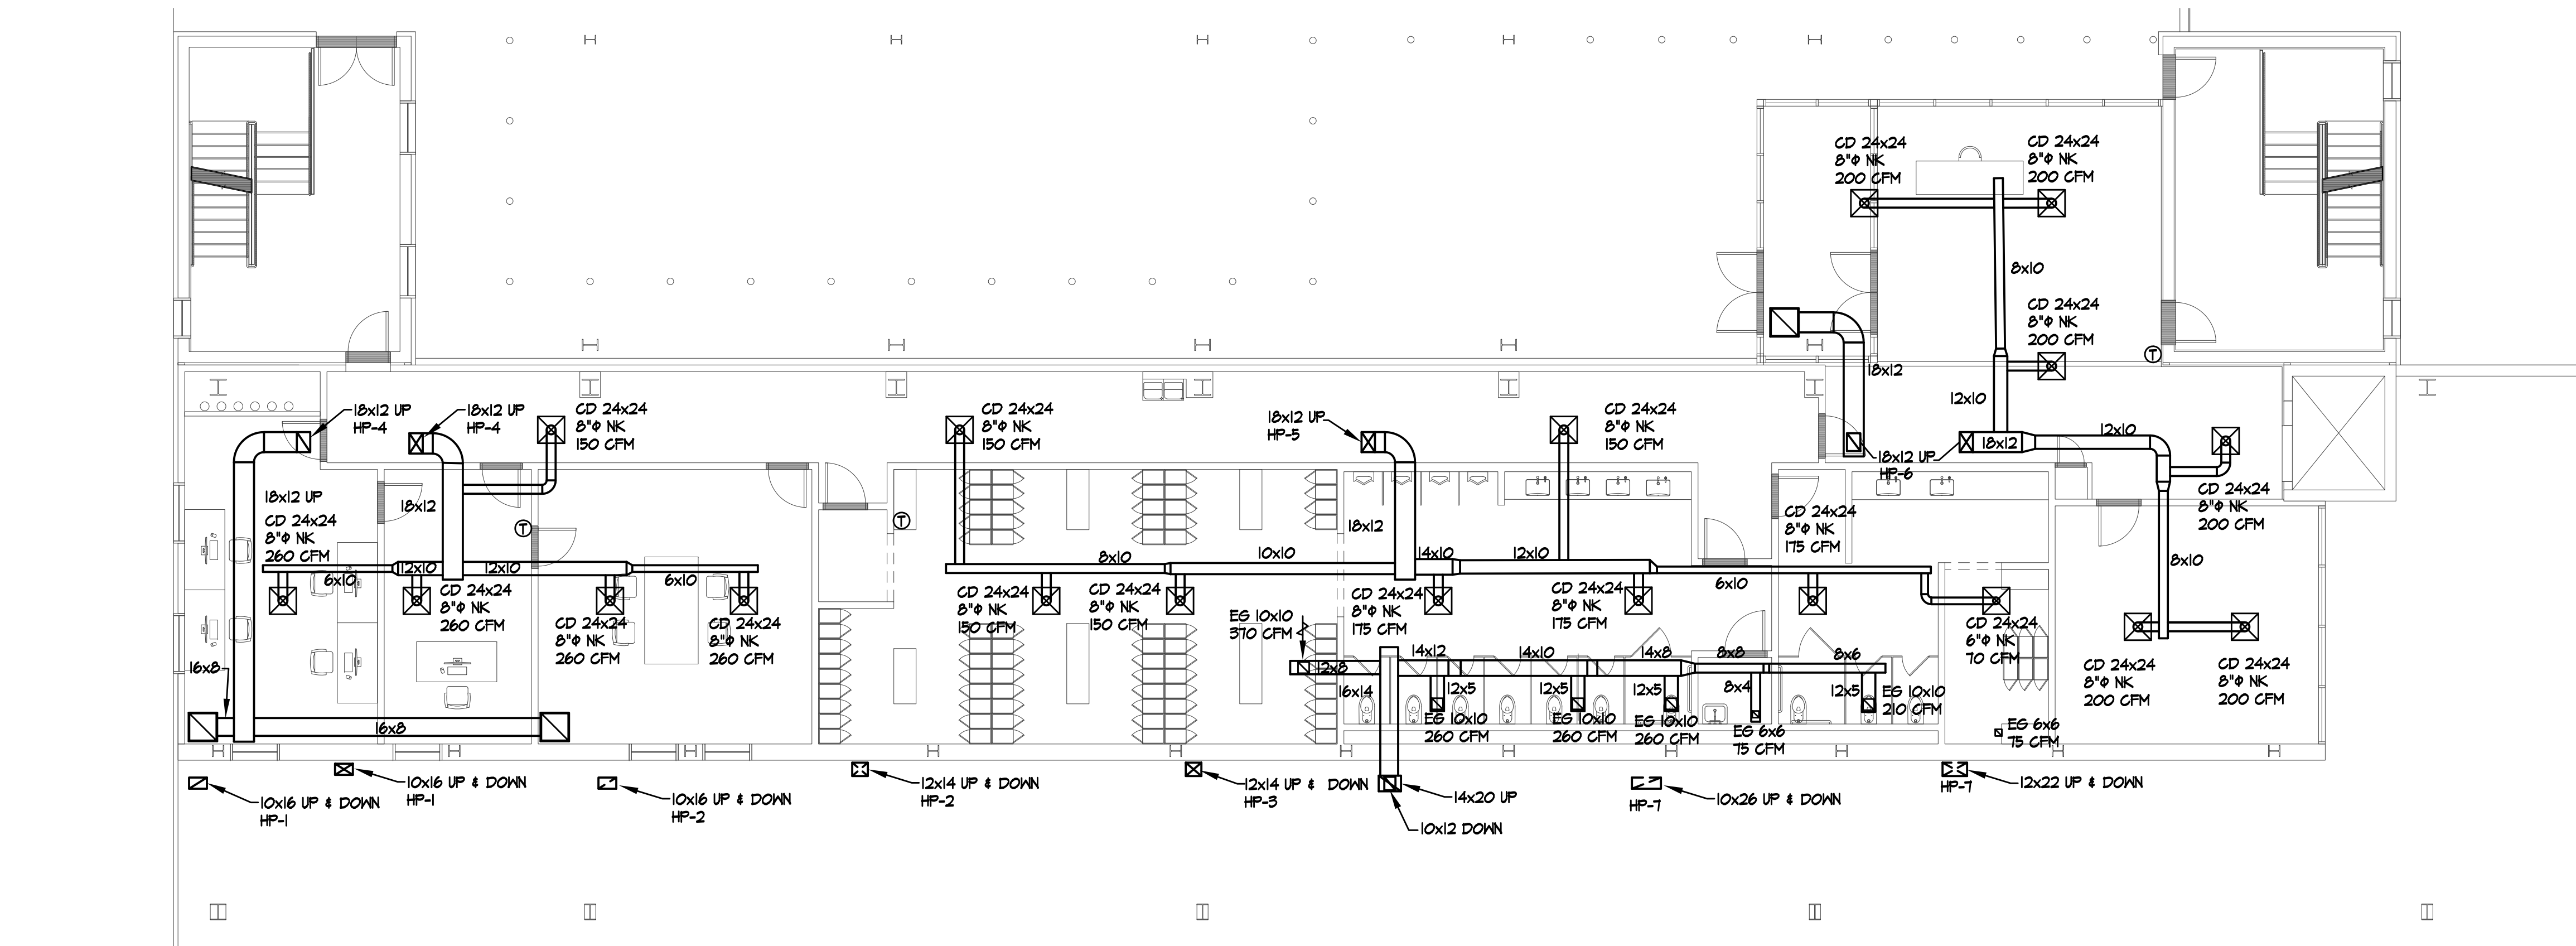

2	8/24/22	GENERAL REVISION
1	7/12/22	ISSUED FOR CONSTRUCTION
ISSUE	DATE	DESCRIPTION
PROJECT		MANHATTAN BEER DISTRIBUTORS 20 DUNNIGAN DRIVE SUFFERN, NEW YORK
DRAWING TITLE		PROPOSED 2ND MEZZANINE HVAC PLAN
APA Air Professional Associates, LLC Heating Air Conditioning 39 FIELDS LANE, NORTH SALEM, NY 10550		DRAWN BY: JLS SCALE: 1/8"=1'-0" DATE: 4/15/22
		DRAWING NO. M-2