


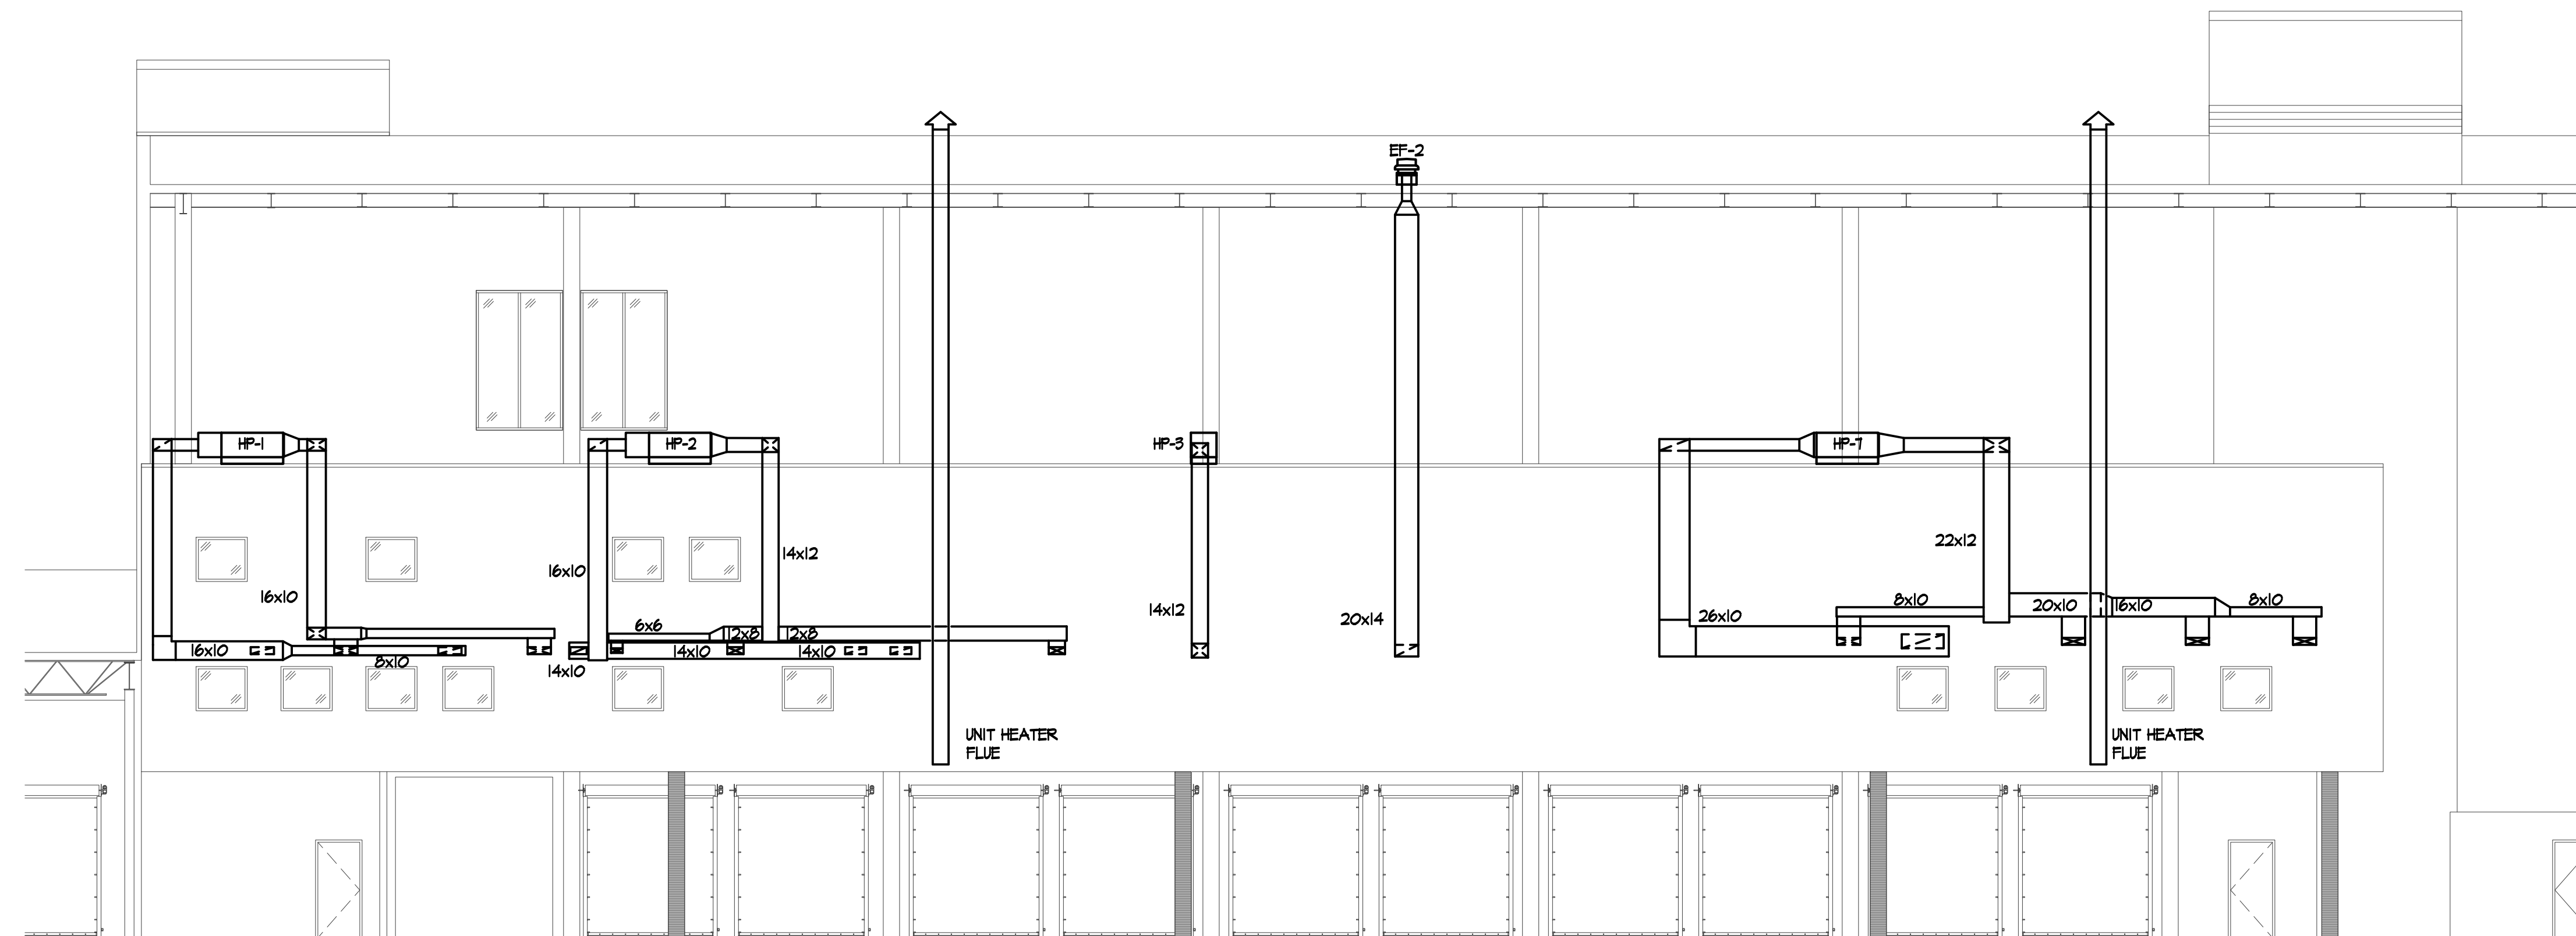

MEZZANINE ELEVATION
SCALE: 1/8"=1'-0"

2	8/24/22	GENERAL REVISION
1	7/12/22	ISSUED FOR CONSTRUCTION
ISSUE	DATE:	DESCRIPTION
PROJECT		MANHATTAN BEER DISTRIBUTORS 20 DUNNIGAN DRIVE SUFFERN, NEW YORK
DRAWING TITLE		MEZZANINE ELEVATION HVAC PLAN
 Air Professional Associates, LLC Heating Air Conditioning 39 FIELDS LANE, NORTH SALEM, NY 10560		DRAWN BY: JLS SCALE: 1/8"=1'-0" DATE: 6/20/22
		DRAWING NO. M-6