



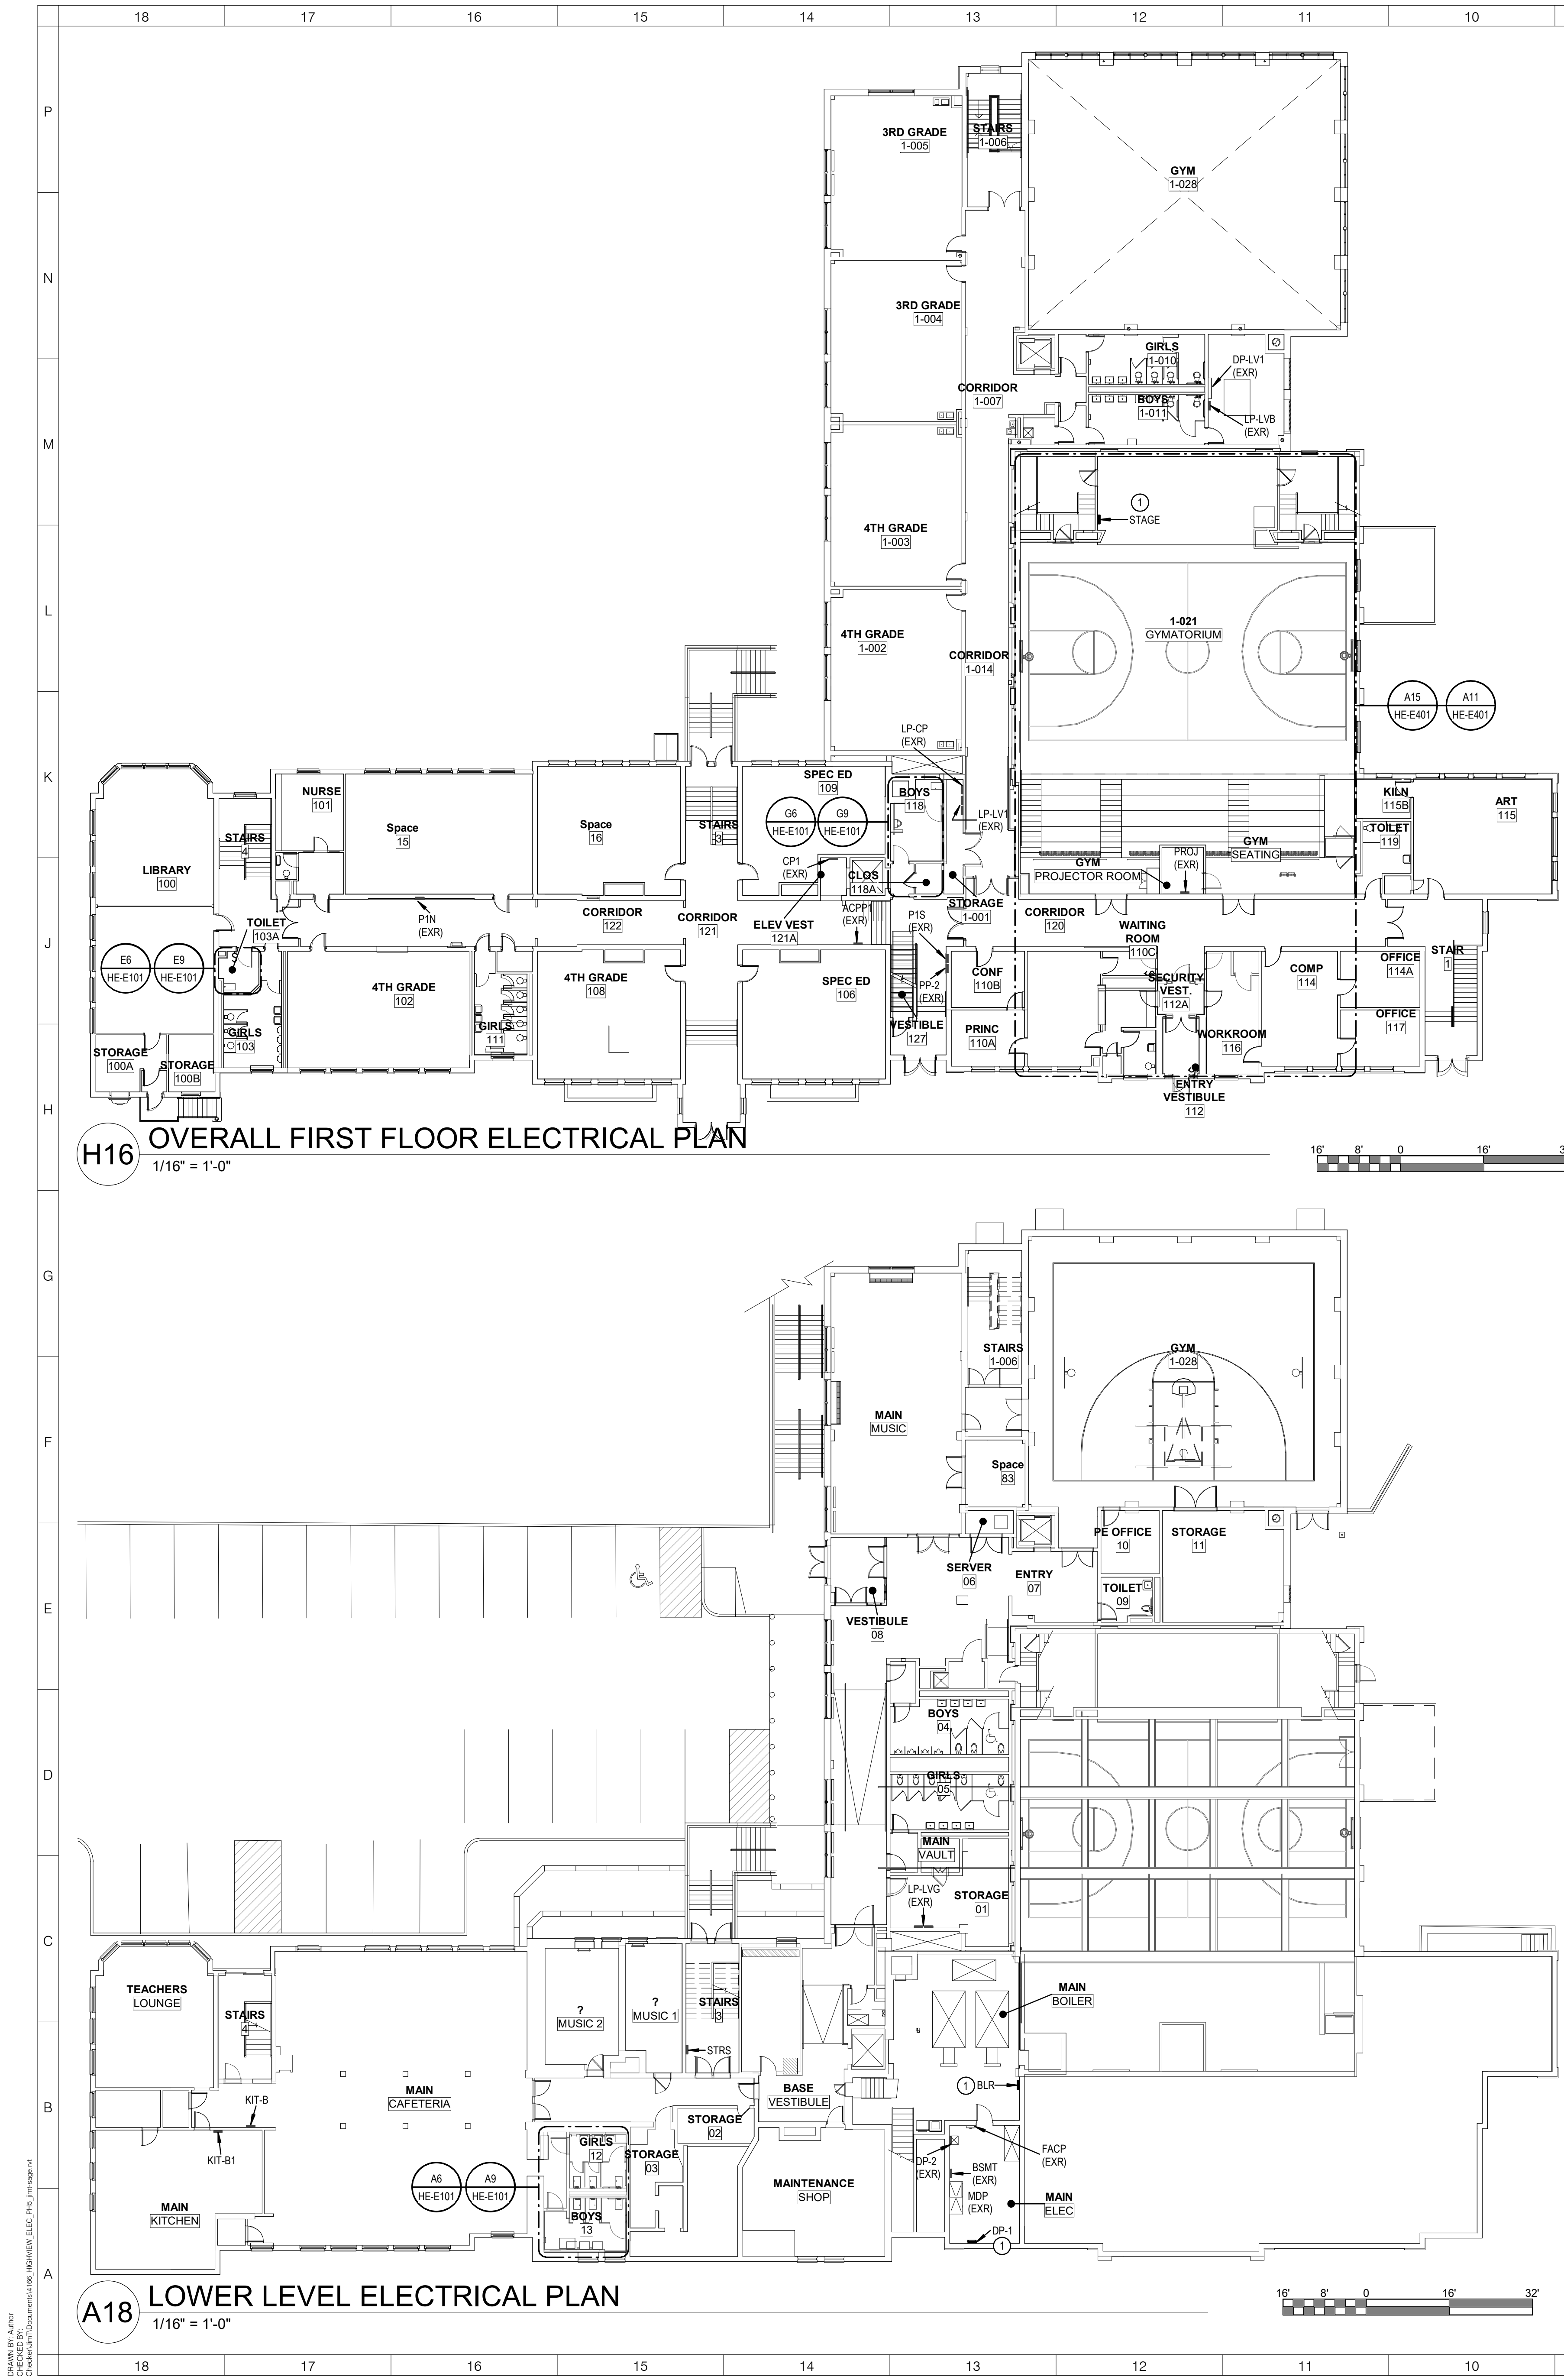


- GENERAL NOTES:
- SEE HE-E001 FOR GENERAL PROJECT NOTES.
- KEYED NOTES:
- REPLACE PANEL. SEE RISER DIAGRAM PANEL SCHEDULE DRAWINGS FOR MORE INFORMATION.
 - CONNECT TO EXISTING LIGHTING CIRCUIT THAT FEEDS AREA.
 - PROVIDE EMERGENCY LIGHTING UNIT "ELU" AND CONNECT TO EXISTING CIRCUIT THAT FEEDS LIGHTING AHEAD OF SWITCHING.

LIGHTING CONTROL NARRATIVE:


- WHERE SHOWN WITH WALL MOUNTED VACANCY SENSORS, LIGHTS ARE MANUAL ON, AUTOMATIC OFF AFTER 20 MINUTES WHEN NO MOTION IS DETECTED.
- FOR BATHROOMS WITH CEILING MOUNTED OCCUPANCY SENSORS, LIGHTS ARE AUTOMATIC ON TO 100%, AUTOMATIC OFF AFTER 20 MINUTES, WITH MANUAL WALL CONTROL.
- FOR LOUNGES WITH CEILING MOUNTED OCCUPANCY SENSORS, LIGHTS ARE AUTOMATIC ON TO 50%, AUTOMATIC OFF AFTER 20 MINUTES, WITH MANUAL WALL CONTROL DIMMER.
- FOR CORRIDORS WITH CEILING MOUNTED OCCUPANCY SENSORS, LIGHTS ARE AUTOMATIC ON TO 100%, AUTOMATIC OFF AFTER 20 MINUTES, WITH MANUAL WALL CONTROL ON/OFF.

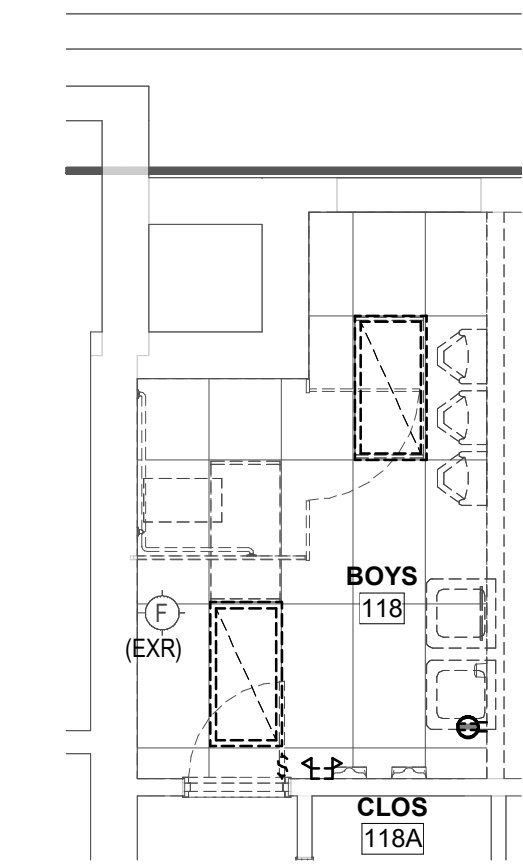


ENLARGED FIRST FLOOR BATHROOM REMOVALS

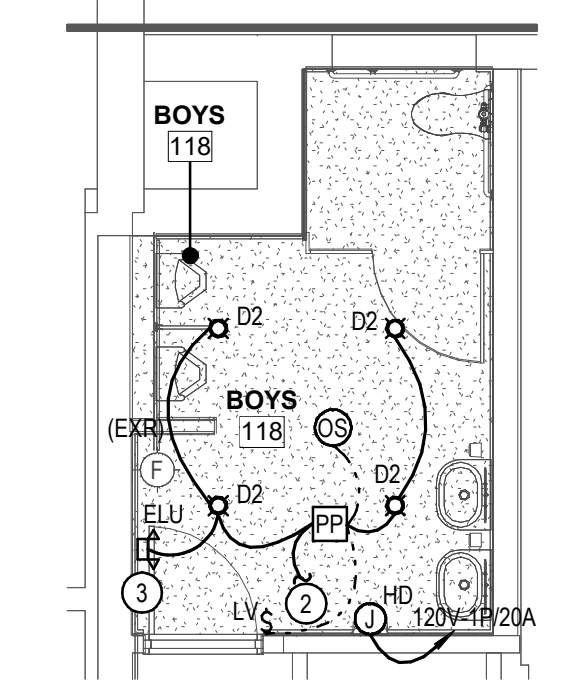


ENLARGED FIRST FLOOR BATHROOM PLAN

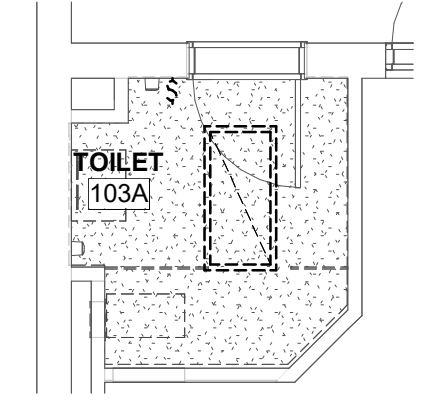


ENLARGED FIRST FLOOR FACULTY BATHROOM REMOVALS

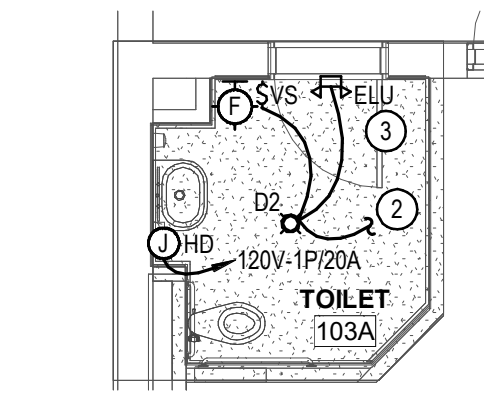

ENLARGED FIRST FLOOR FACULTY BATHROOM PLAN

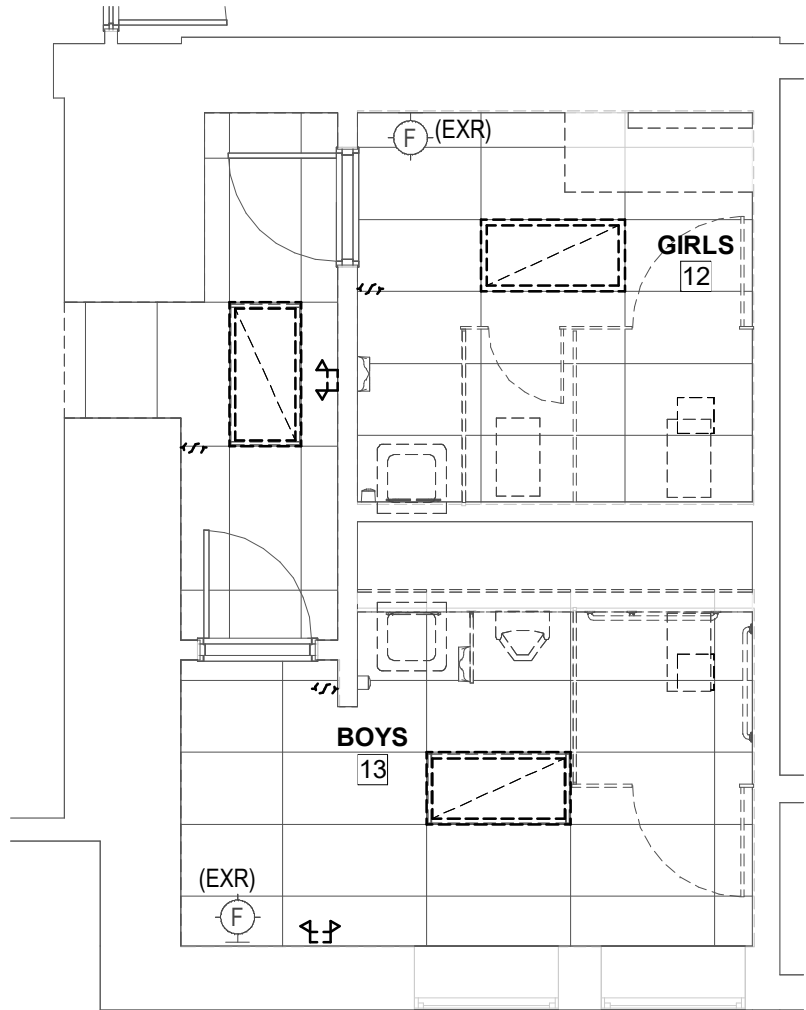

ENLARGED CAFETERIA BATHROOM REMOVALS

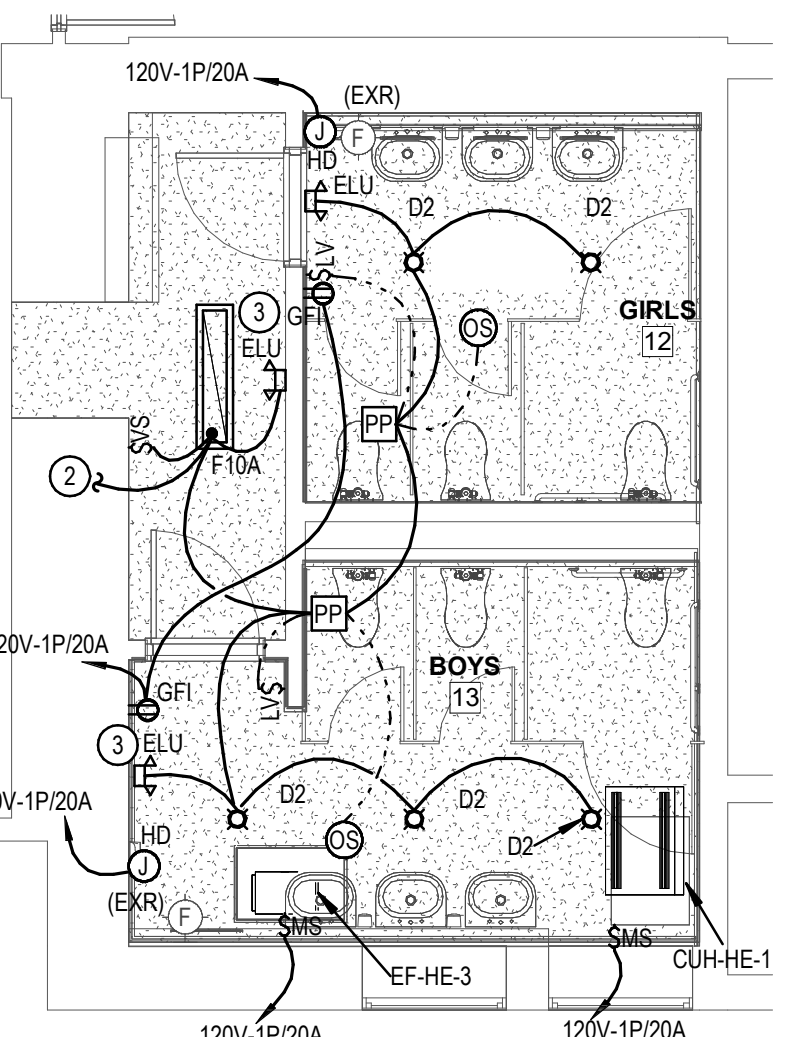

ENLARGED CAFETERIA BATHROOM PLAN

ARCHITECT

ksqdesign

NEW YORK OKLAHOMA

KSQ Design
215 W 40th Street 15th Floor
New York, NY 10018
646.435.0660 office
www.ksqdesign.com

Owner
Nanuet Union Free School District
101 Church Street
Nanuet, NY 10954
845.627.9880
www.nanuetd.org

Structural Engineer
Clapper Structural Engineering
160 Partition Street
Saugerties, NY 12477
845.943.9801
www.clapperstructural.com

MEP Engineer
Sage Engineering Associates, LLP
9 Columbia Circle
Albany, NY 12203
518.453.6091
www.sagegrp.com
NEW YORK STATE LICENSE NO. 00000000000000000000

Environmental Engineer
Quest Environmental Solutions
1376 Route 9
Wappingers Falls, NY 12590
845.298.6251
www.qualityenv.com

Construction Manager
Jacobs
One Penn Plaza
24th Floor, Suite 2400
New York, NY 10119
646.906.6550
www.jacobs.com

PROFESSIONAL ENGINEER
REGISTRATION EXPIRES: 10/31/2023

NANUET

NUFSD BOND PROJECT PHASE 5 - HIGHVIEW

■ SED#50-01-08-03-0-002-020 (HIGHVIEW ES)
□ SED#50-01-08-03-7-001-002 (Maintenance)
□ SED#50-01-08-03-7-012-004 (OEC)
□ SED#50-01-08-03-0-001-028 (MILLER ES)
□ SED#50-01-08-03-0-004-022 (BARR MS)


Highview Elementary School
24 Highview Ave
Nanuet, NY 10954

OEC Building
135 Convent Rd
Nanuet, NY 10954

Maintenance Building
103 Church St.
Nanuet, NY 10954

Miller Elementary School
50 Blauvelt Rd Unit 1
Nanuet, NY 10954

A MacArthur Barr Middle School
143 Church St
Nanuet, NY 10954

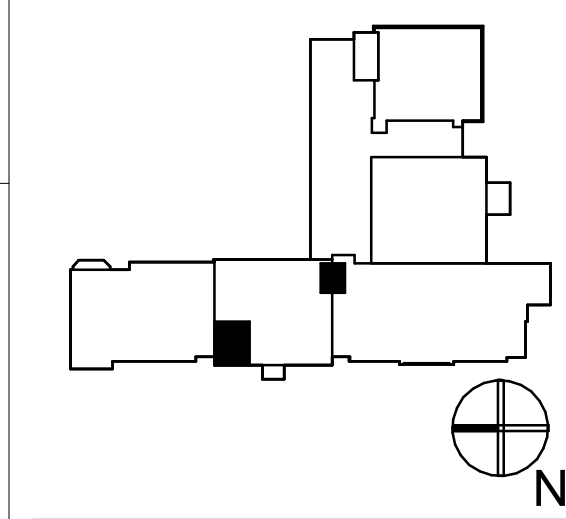

REVISIONS

No.	Description	Date
1	SED ADD #1	11/06/24

ISSUED: BID SET
DATE: 06/21/2024
SCALE: AS NOTED
SHEET NAME: OVERALL LOWER LEVEL AND FIRST FLOOR ELECTRICAL PLANS
SHEET NUMBER:

HE-E101