



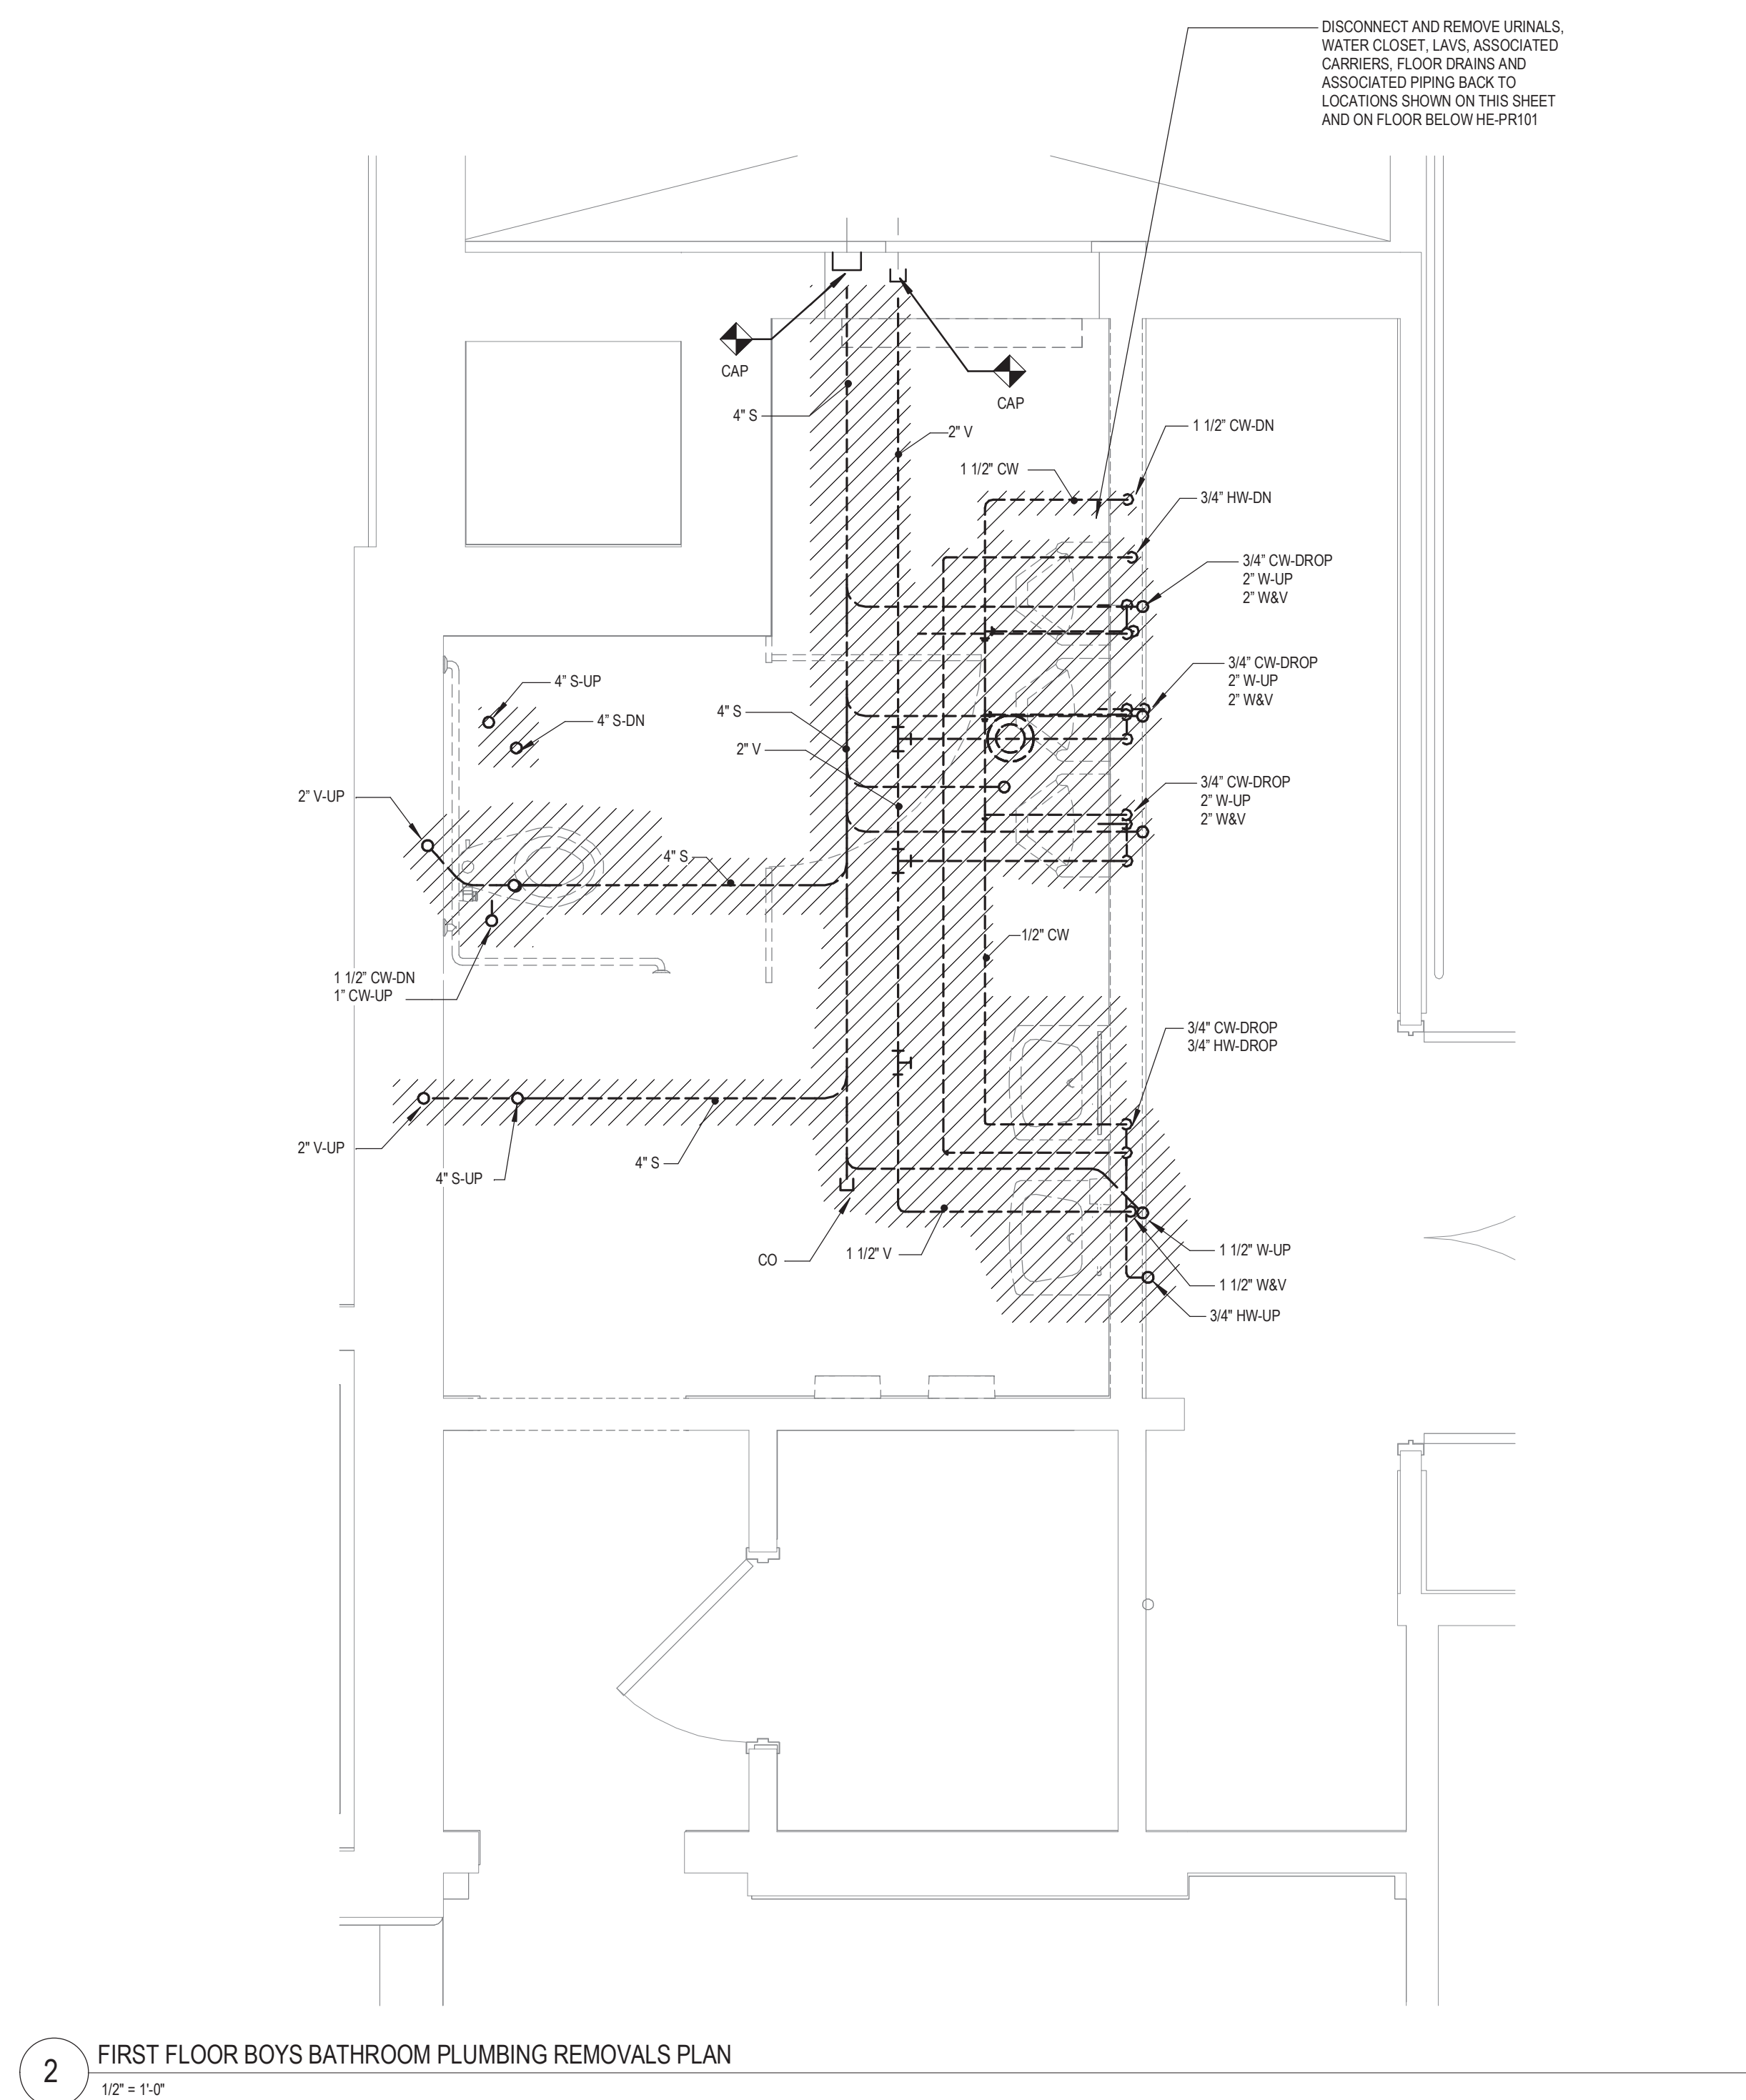

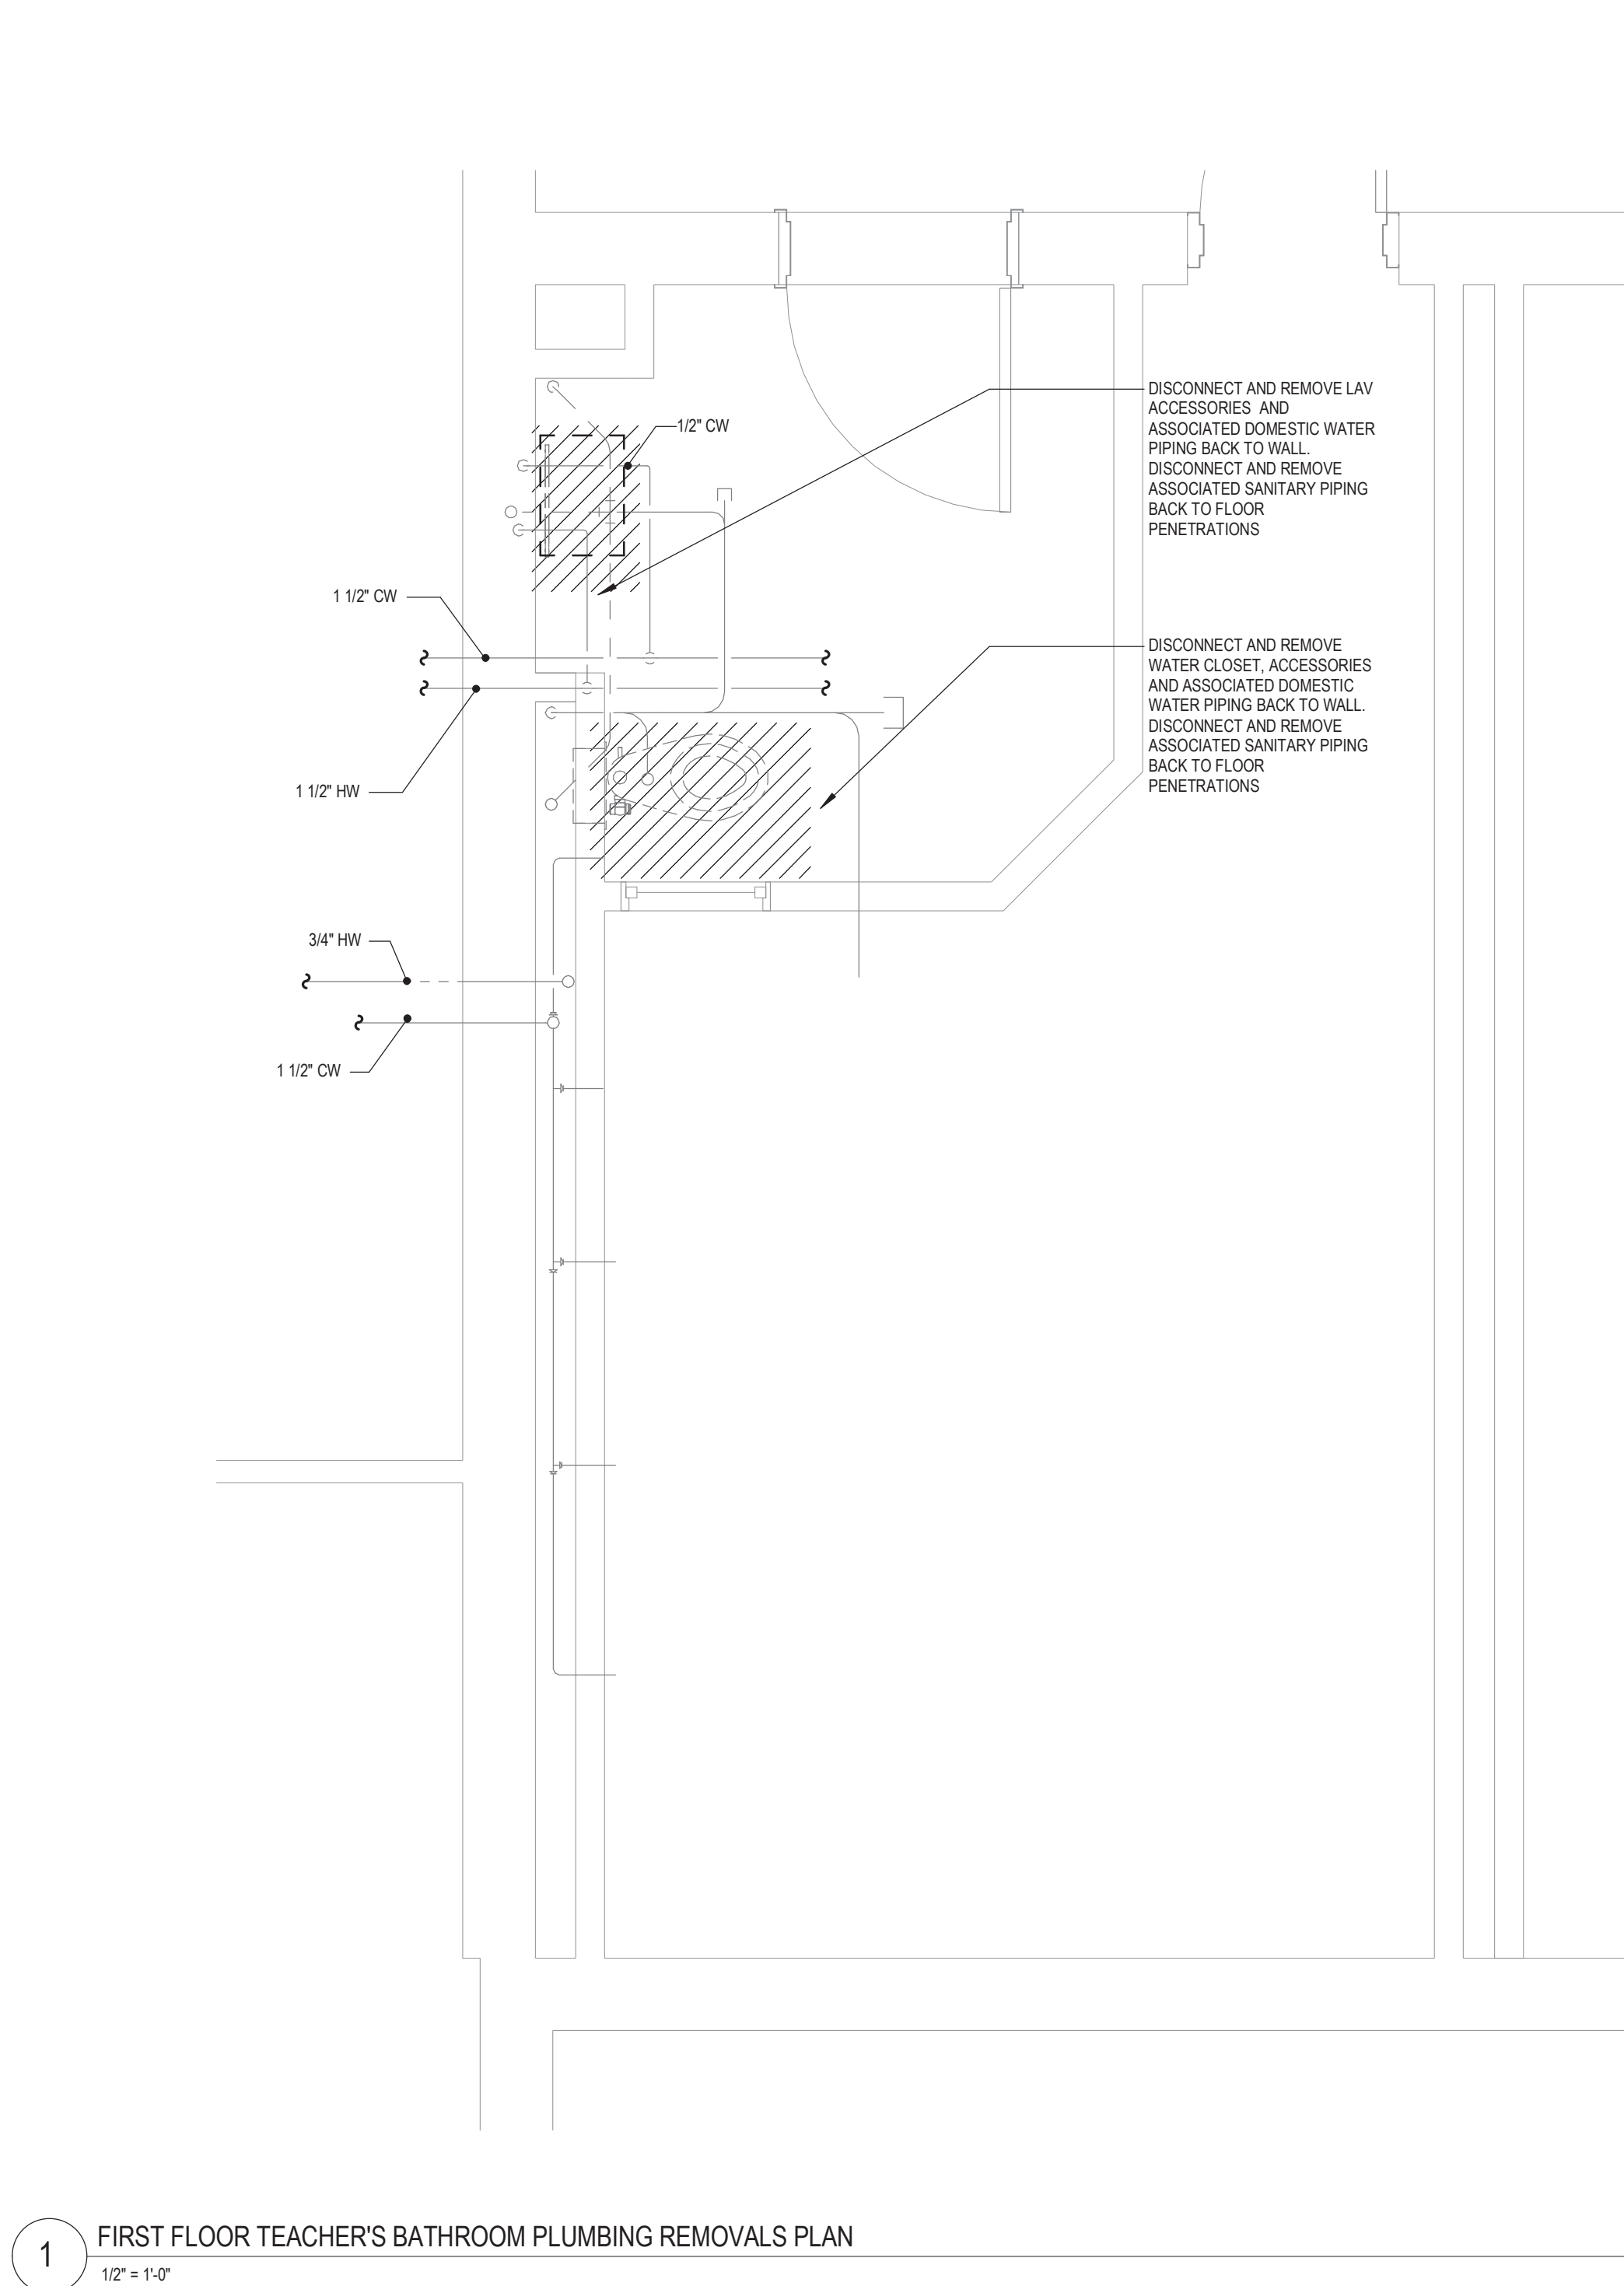



PLUMBING FIXTURE SCHEDULE										
1. OR APPROVED EQUAL										
TAG	TYPE	BASIS OF DESIGN MANUFACTURER	MODEL	CONNECTION SIZE					REMARKS	
				CW	HW	W	IW	V		
DECO	DECK PLATE CLEANOUT	ZURN	Z1420			2"				
FD-1	FLOOR DRAIN	ZURN	Z4158			2"		2"	PROVIDE TRAP SEAL	
LAV-1	LAV WALL HUNG	KOHLER	K-2007	1/2"	1/2"	1 1/2"		1 1/2"	[WITH FAUCET EAF-100 WITH PLUG. SEE ARCHITECTURAL FOR FINAL MOUNTING HEIGHTS]	
LAV-2	LAV WALL HUNG (ADA)	KOHLER	K-2007	1/2"	1/2"	1 1/2"		1 1/2"	[WITH FAUCET EAF-100 WITH PLUG. SEE ARCHITECTURAL FOR FINAL MOUNTING HEIGHTS]	
UR-1	URINAL	KOHLER	K-4991-E1	3/4"		2"		2"	[WITH FLUSH VALVE SLOAN ECOS 186 HW]	
WC-1	WATER CLOSET WALL HUNG	ZURN	Z5615	1"		4"		2"	[WITH FLUSH VALVE SLOAN ECOS 111 (HW). SEE ARCHITECTURAL FOR FINAL MOUNTING HEIGHTS]	
WC-2	WATER CLOSET WALL HUNG (ADA)	ZURN	Z5615	1"		4"		2"	[WITH FLUSH VALVE SLOAN ECOS 111 (HW). SEE ARCHITECTURAL FOR FINAL MOUNTING HEIGHTS]	
WC-4	WATER CLOSET FLOOR MOUNTED	ZURN	Z5655-BWL1	1"		4"		2"	[WITH FLUSH VALVE SLOAN ECOS 111 (HW)]	

WATER HAMMER ARRESTOR						
	MODEL NUMBER					
SHOKTROL Z1700	100	200	300	400	500	600
FIXTURE RATING	1-11	12-32	33-60	61-113	114-154	155-330
TAG	WHA-A	WHA-B	WHA-C	WHA-D	WHA-E	WHA-F

CIRCULATOR PUMP SCHEDULE								
1. CIRCULATING HOT WATER PUMP, STAINLESS STEEL, NSF-61 RATED.								
TAG	LOCATION	TYPE	CAPACITY	HEAD (FT. W.C.)	ELECTRICAL DATA		BASIS OF DESIGN MFG. AND MODEL	REMARKS
					VOLTS	PH		
RP-1	BOILER ROOM	CARTRIDGE CIRCULATOR	2 GPM	2	115	1	1/40	TACO 003B

3 FLOOR DRAIN WITH ABOVE FLOOR PIPING DETAIL
12" ± 1'-0"

2 INLINE PUMP INSTALLATION DETAIL
12" ± 1'-0"




1 PIPE TRENCH DETAIL
N.T.S.


ABBREVIATIONS LEGEND

AFF	ABOVE FINISHED FLOOR
AFG	ABOVE FINISHED GRADE
AVG	AVERAGE
BF	BELOW FINISHED FLOOR
BSP	BRAKE HORSEPOWER
BOP	BOTTOM OF PIPE
BTM	BOTTOM
BTUH	BRITISH THERMAL UNITS/HOUR
CAP	CAPACITY
CO	CLEAN OUT
CONT	CONTINUATION
CW	DOMESTIC COLD WATER
DCW	DOMESTIC COLD WATER
DA	DIAMETER
DN	DOWN
DPO	DECK PLATE CLEAN OUT
DWG	DRAWING
ES	EMERGENCY EYE WASH/SHOWER STATION
ET	EXPANSION TANK
EWT	ENTERING WATER TEMPERATURE
EXIST	EXISTING
F	DEGREES FAHRENHEIT
FAI	FRESH AIR INTAKE
FD	FLOOR DRAIN
FLA	FULL LOAD AMPS
FLR	FLOOR
FT	FEET
FT OR	FEET OR
G	GAS
GAL	GALLON
GPH	GALLONS PER HOUR
GPM	GALLONS PER MINUTE
HS	HOSE BIBB
HP	HORSEPOWER
HR	HOUR
HW	DOMESTIC HOT WATER
HWR	HOT WATER RECIRCULATION
HZ	HERTZ
IN OR	INCHES
INT	INTERNAL
IW	INDIRECT WASTE
KSK	KITCHEN SINK
KW	KILOWATT
L	LENGTH
LAV	LAVATORY
LAT	LEAVING AIR TEMPERATURE
LBS	POUNDS
LF	LINEAR FOOT
LWT	LEAVING WATER TEMPERATURE
MBH	THOUSAND BTU/H
MD	MOTORIZED DAMPER
MIN	MINIMUM
MAX	MAXIMUM
N/A	NOT APPLICABLE
NC	NORMALLY CLOSED
MFG	MANUFACTURER
MS	MIDDLE SCHOOL
MV	ELECTRONIC MIXING VALVE
NO	NORMALLY OPEN
NOL	NON OVERLOADING
P	PUMP
PC	PLUMBING CONTRACTOR
PD	PRESSURE DROP
PH	PHASE
PPM	PARTS PER MILLION
PSI	POUNDS PER SQUARE INCH
PSIG	POUNDS PER SQUARE INCH GAUGE
RD	ROOF DRAIN
RL	ROOF LEADER
RO	ROOF OVERFLOW DRAIN
RP	RECIRCULATION PUMP
RPM	REVOLUTIONS PER MINUTE
RPZ	REDUCED PRESSURE ZONE
RTV	GAS FRED ROOF-TOP UNIT
S OR SAN	SANITARY
SF	SQUARE FOOT
SH	SHOWER
SK	SINK
SR	SHORT RADIUS
SS	SERVICE SINK/JANITOR'S SINK
ST	STORM PIPING
TEMP	TEMPERATURE
TV	THERMOSTATIC MIXING VALVE
TYP	TYPICAL
UR	URINAL
V	VENT
VERT	VERTICAL
VTR	VENT THRU ROOF
W	WASTE
WC	WATER CLOSET
WCO	WALL CLEAN-OUT
WH	WATER-HEATER
WHA	WATER HAMMER ARRESTOR


PLUMBING LEGEND

---	COLD WATER PIPING (CW)
---	HOT WATER PIPING (HW)
---	HOT WATER RECIRC PIPING (HWR)
---	SANITARY ABOVE GRADE
---	SANITARY BELOW GRADE
---	NATURAL GAS PIPING
---	WASTE PIPING
---	90 DEGREE PIPE ELBOW DOWN
---	PIPE RISER UP SYMBOL
---	BRANCH PIPE CONNECTOR OFF BOTTOM OF PIPING MAIN
---	PIPE CAP
---	MID-PIPE DOWN
---	PIPE BREAK
---	PIPE DOWN WITH VALVE IN VERTICAL
---	UNION
---	CLEAN OUT
---	PIPING/EQUIPMENT REMOVALS
---	CHECK VALVE
---	SHUTOFF BALL VALVE
---	PRESSURE REDUCING VALVE
---	PLUG VALVE
---	PUMP
---	FLOOR DRAIN
---	CLEANOUT DECKPLATE
---	GATE VALVE
---	BUTTERFLY VALVE
---	BALANCE VALVE
---	PIPE REDUCER
---	POINT OF REMOVAL
---	POINT OF CONNECTION

   


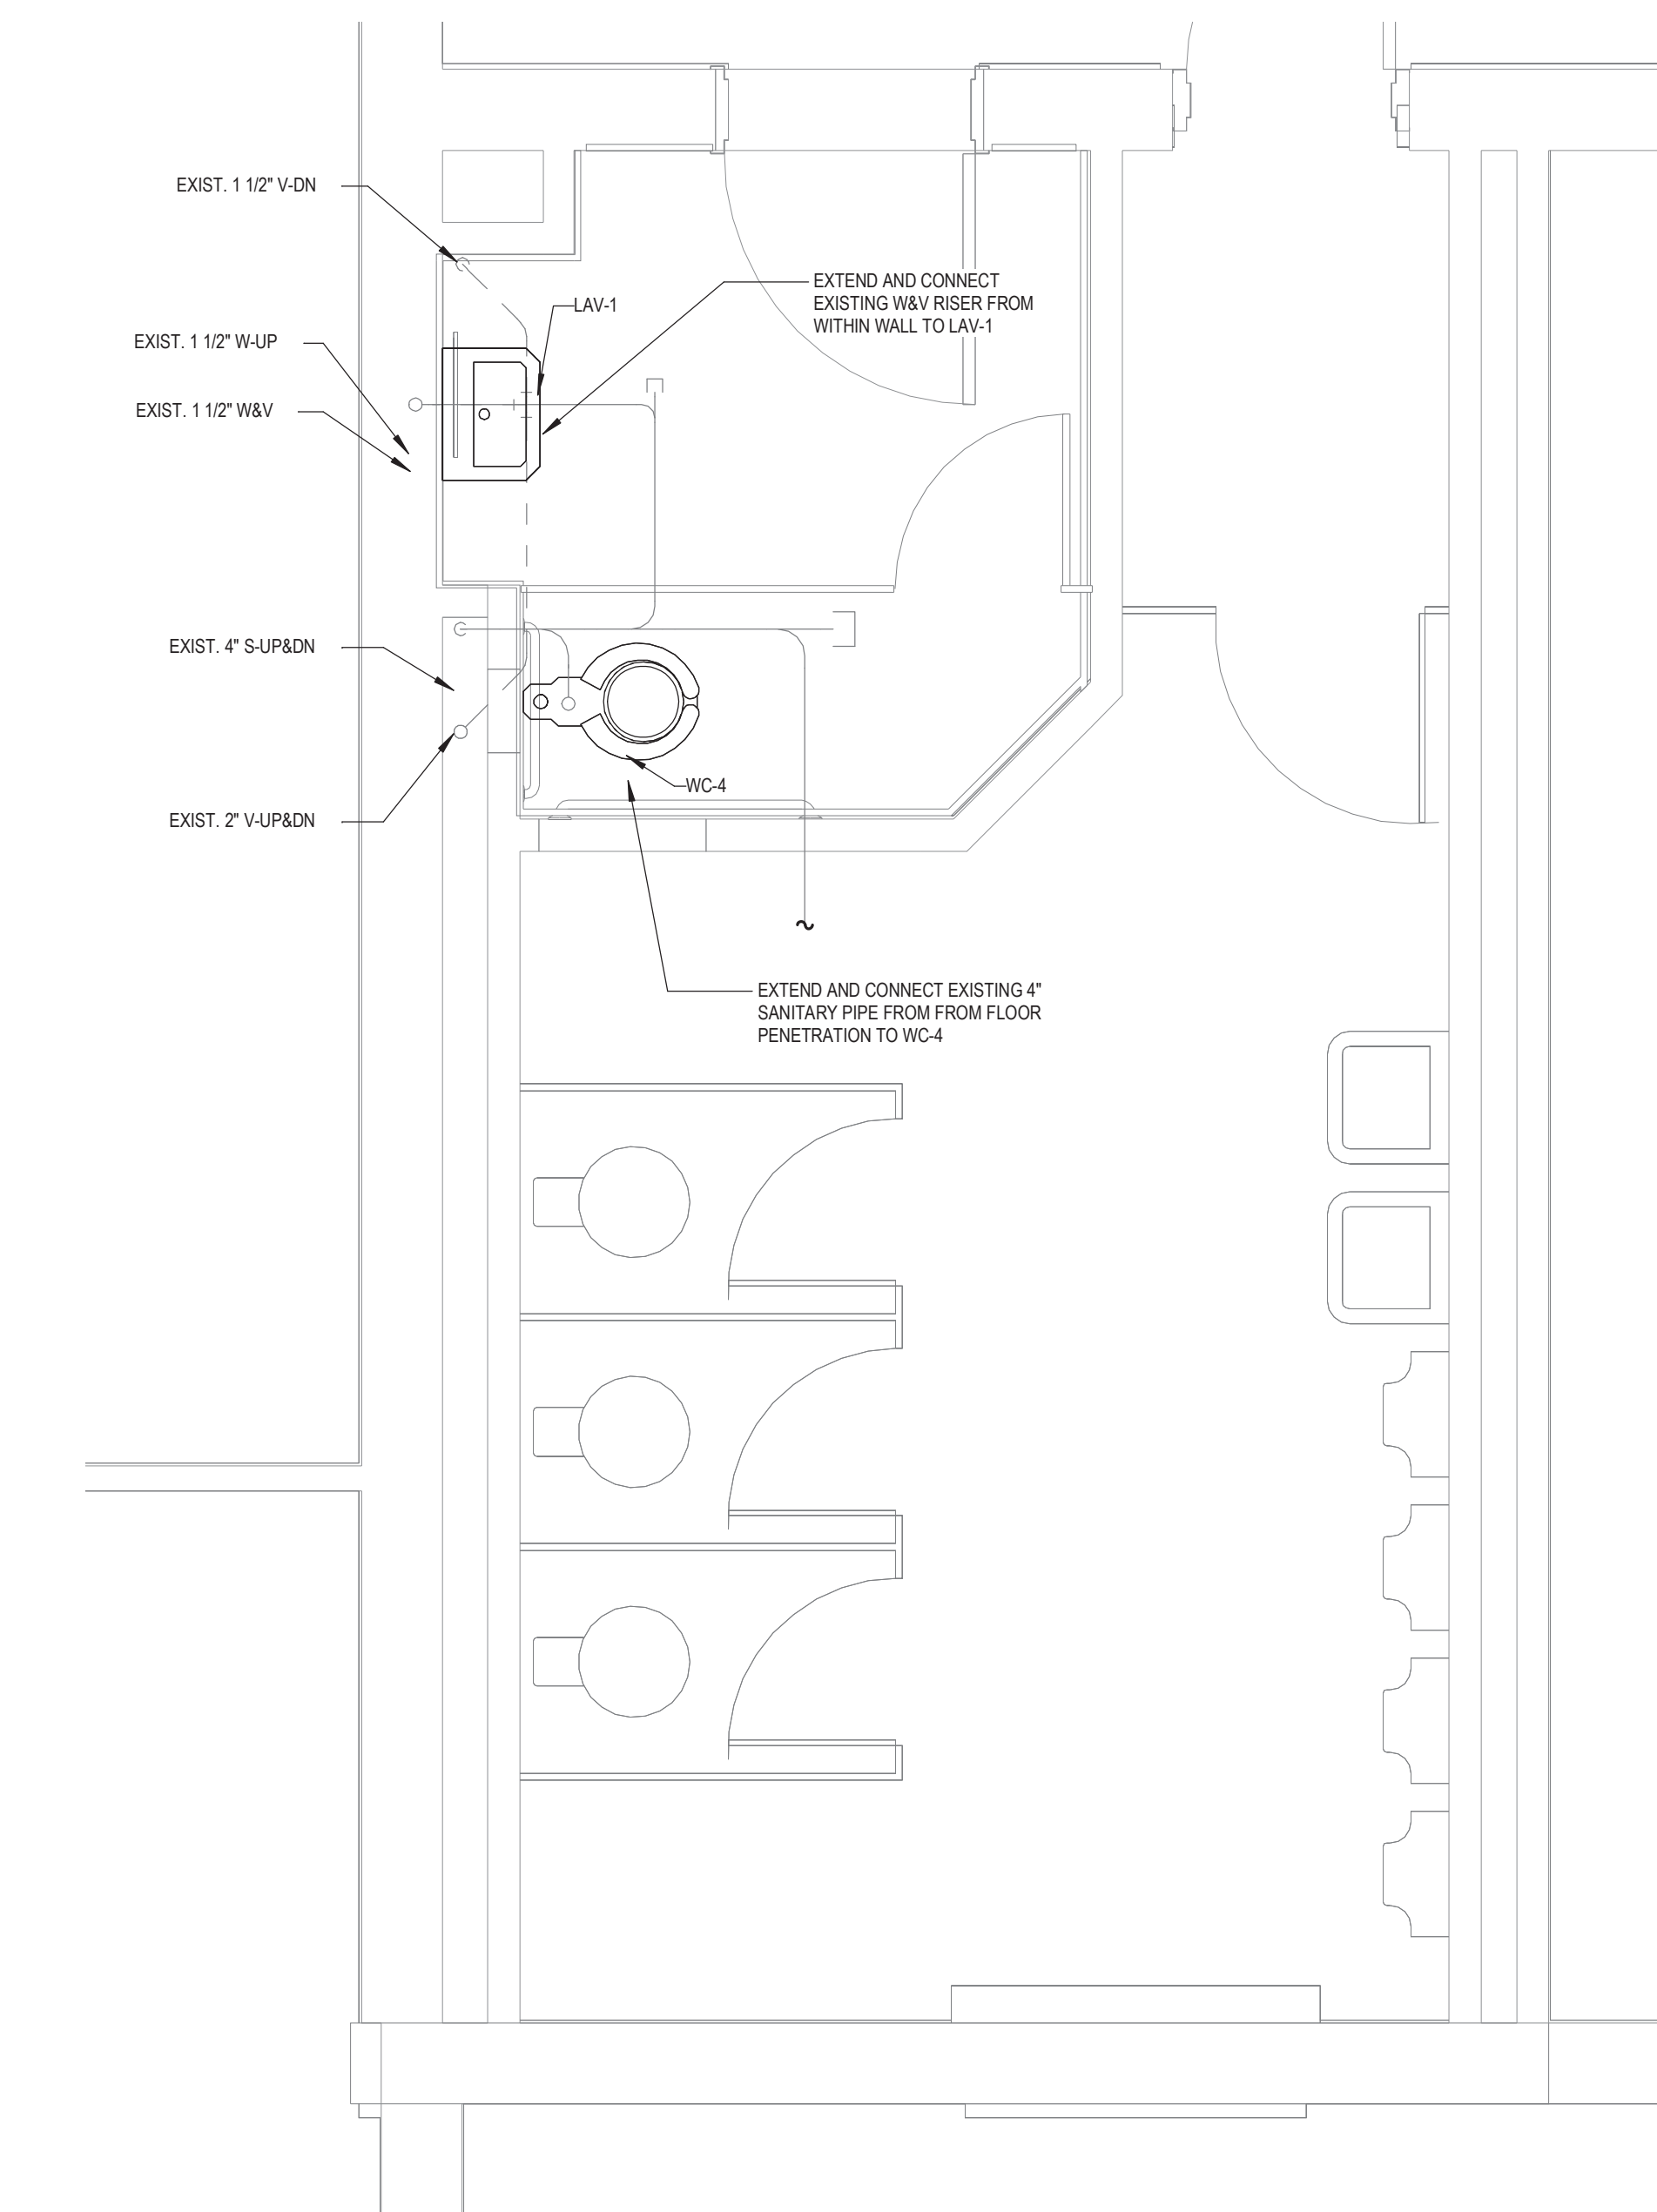

1 FIRST FLOOR TEACHER'S BATHROOM SANITARY AND VENT INSTALLATION PLAN
1/2" = 1'-0"

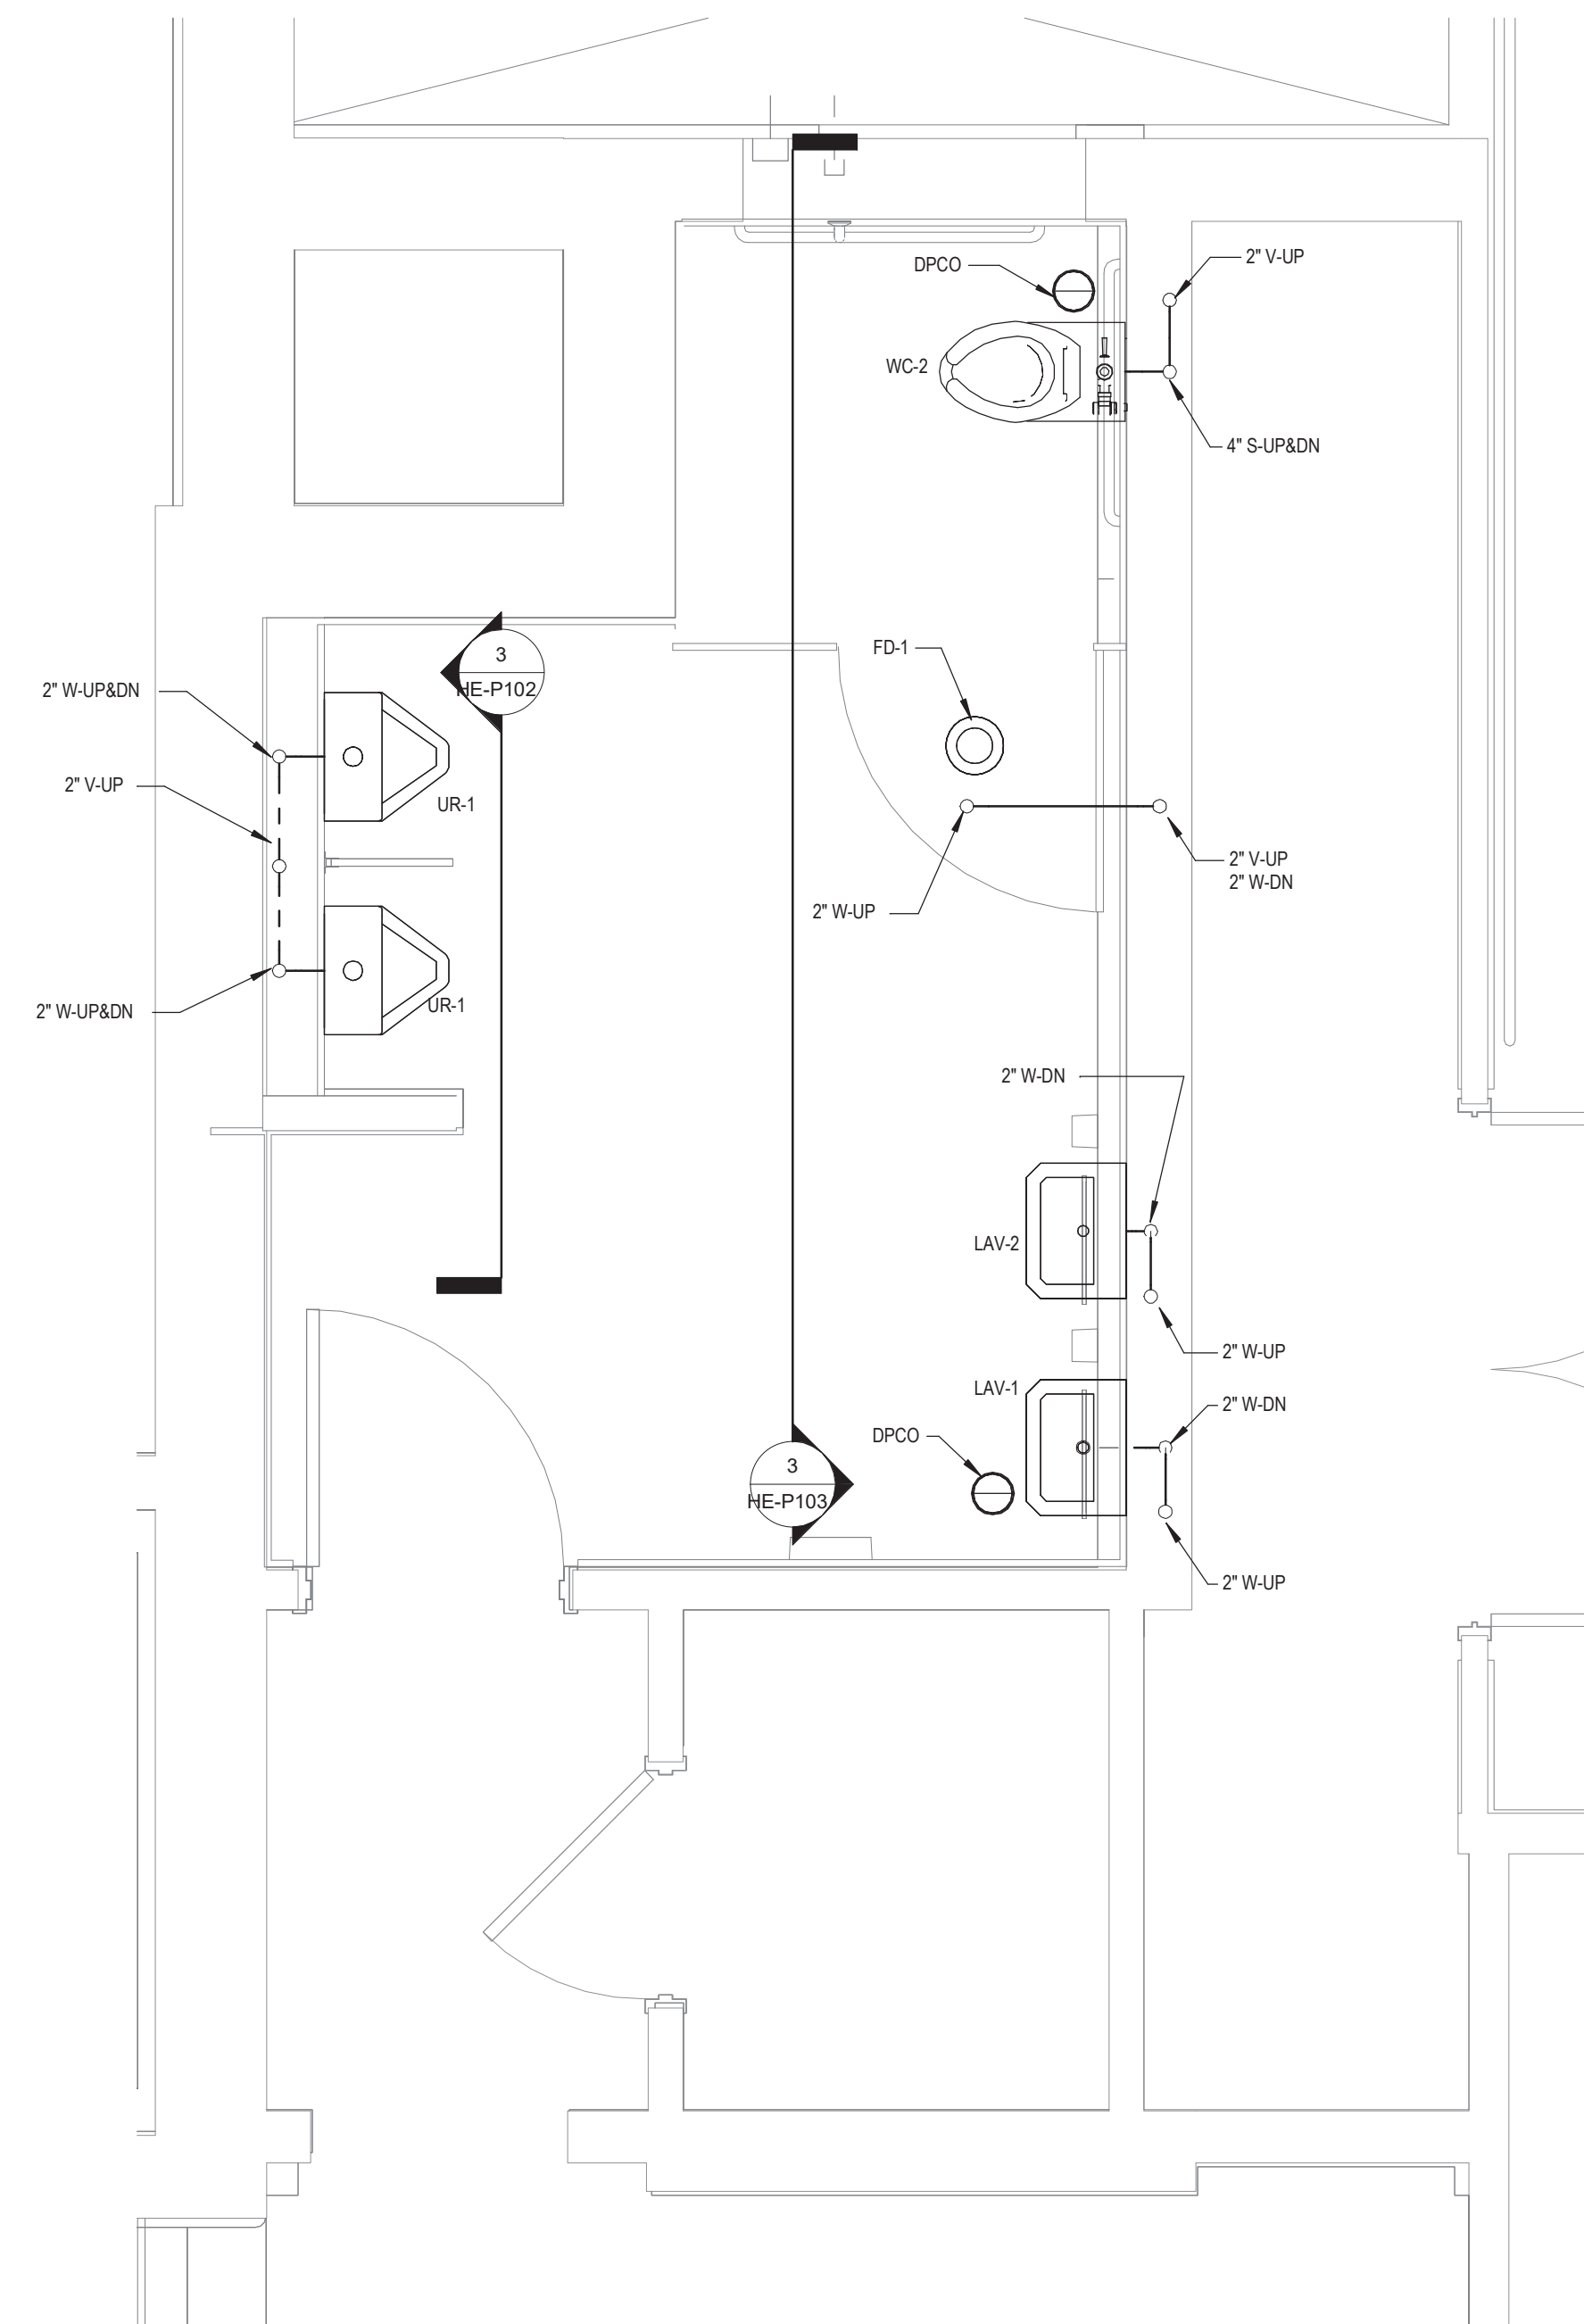

2 FIRST FLOOR BOYS BATHROOM SANITARY AND VENT INSTALLATION PLAN
1/2" = 1'-0"

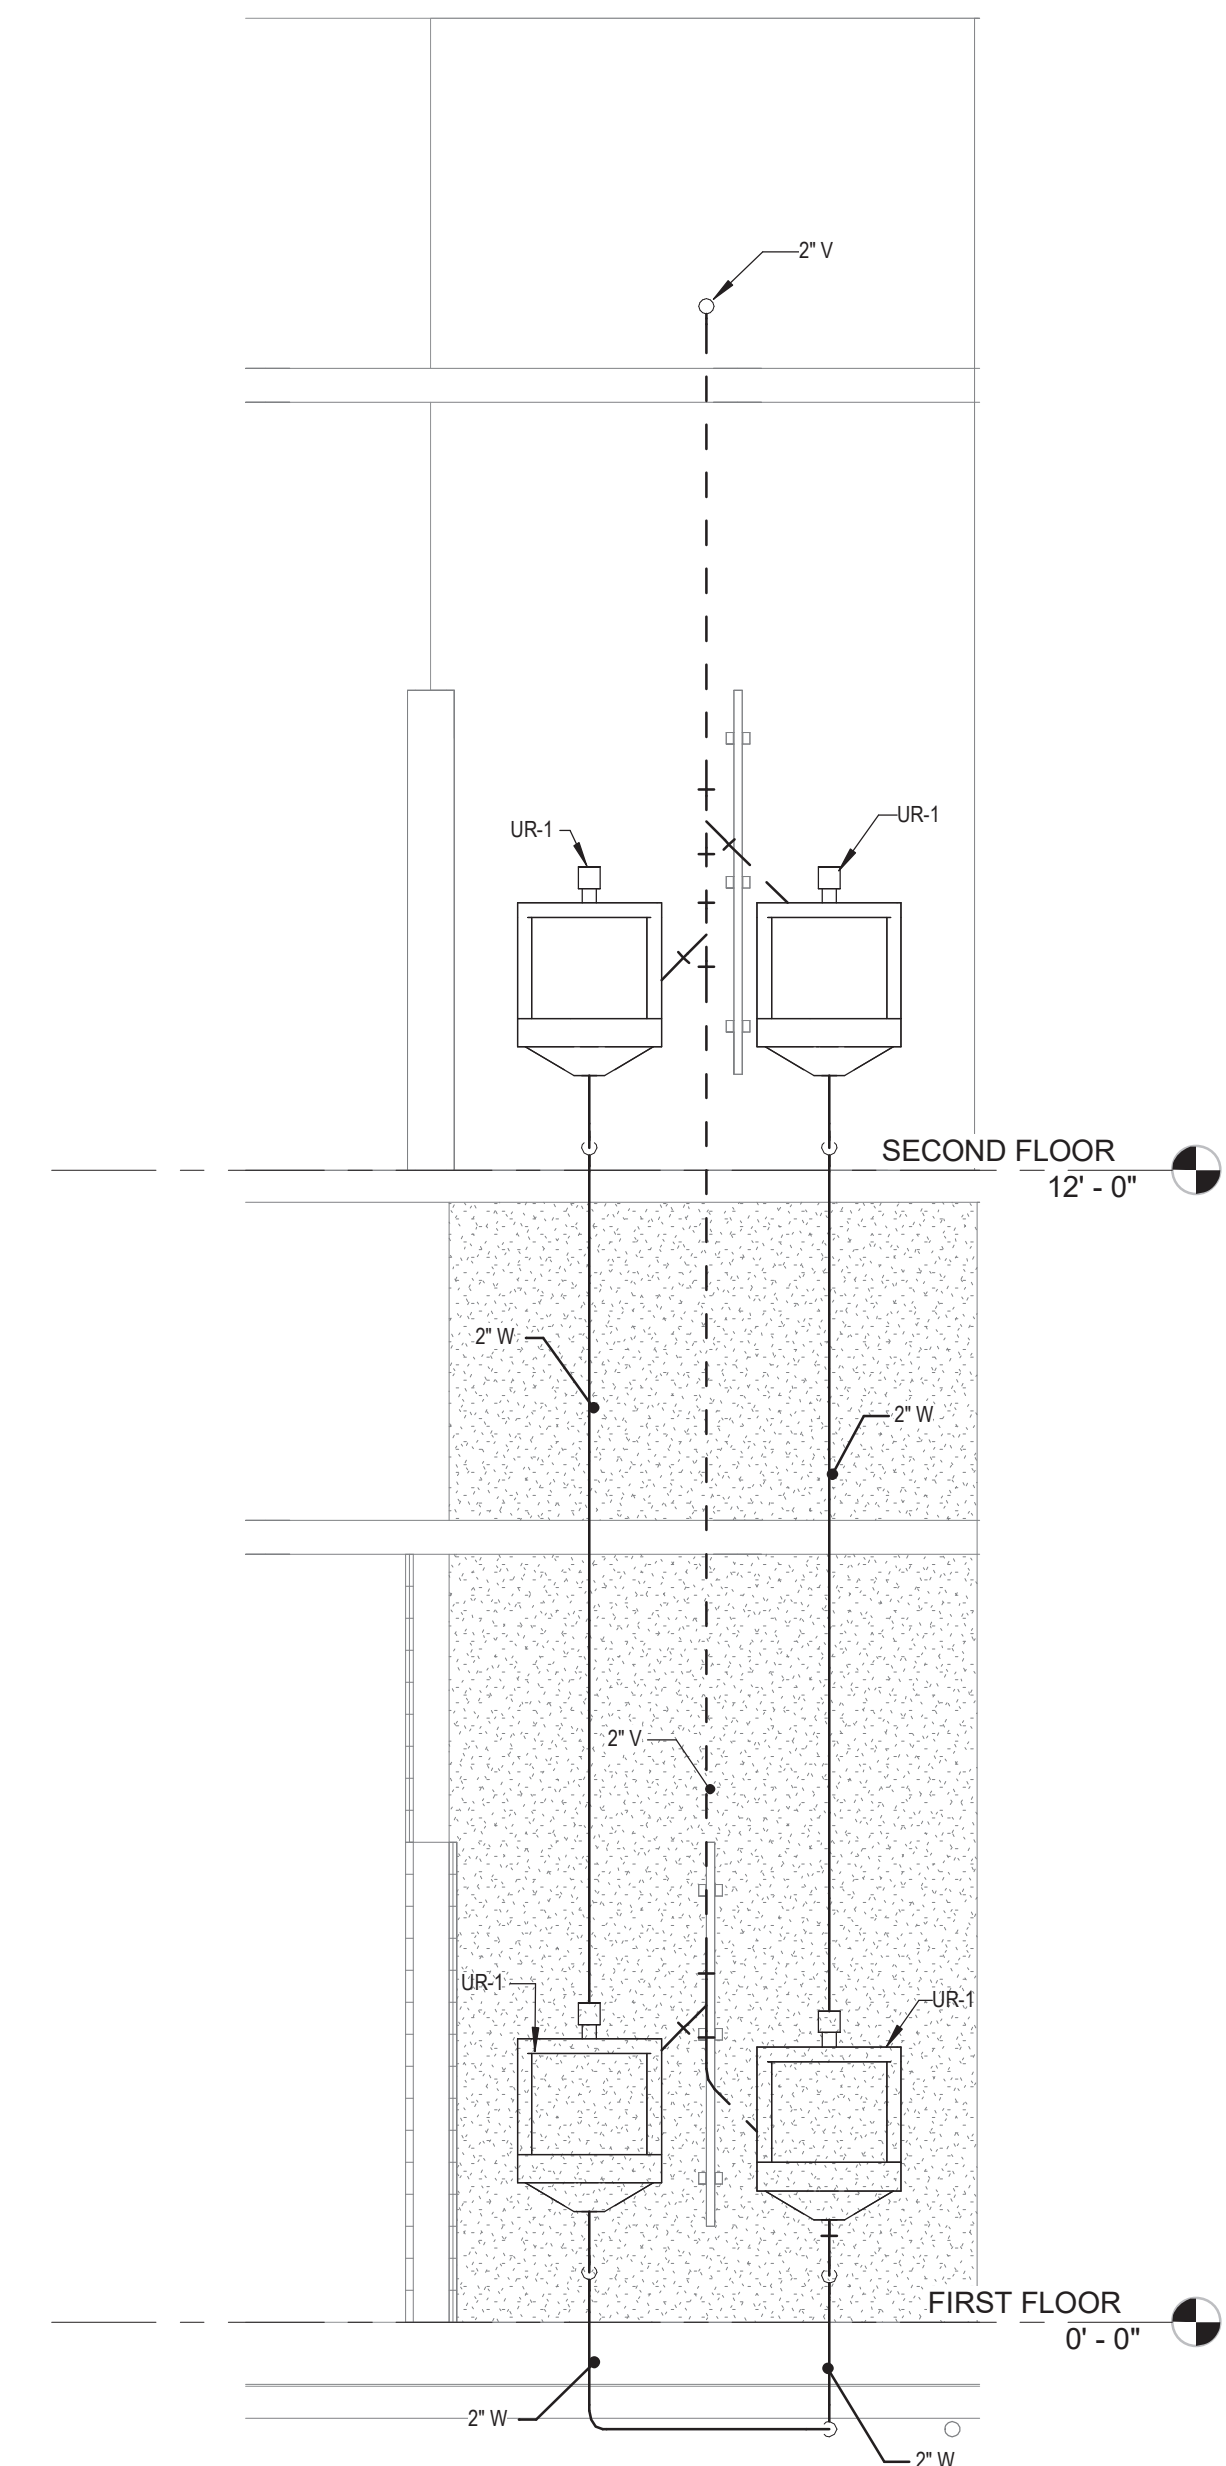

3 SANITARY AND VENT SECTION AT BOYS BATHROOM URINALS
1/2" = 1'-0"



NUFSD BOND
PROJECT
PHASE 5 -
HIGHVIEW

- SED#50-01-08-03-0-002-020 (HIGHVIEW ES)
SED#50-01-08-03-7-007-002 (Maintenance)
SED#50-01-08-03-7-012-004 (OEC)
SED#50-01-08-03-0-001-026 (MILLER ES)
SED#50-01-08-03-0-004-022 (BARR MS)

Highview Elementary School

24 Highview Ave
Nanuet, NY 10954

OEC Building

135 Convent Rd
Nanuet, NY 10954

Maintenance Building


103 Church St.
Nanuet, NY 10954

Miller Elementary School

50 Blauvelt Rd Unit1
Nanuet, NY 10954

MacArthur Park Middle School

143 Church St
Newark, NJ 07102

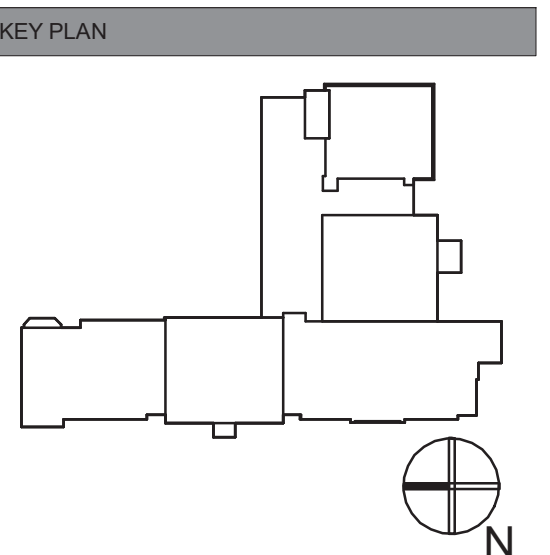

REVISIONS		
No.	Description	Date

ISSUED: BID SET

DATE: 06/21/2024

SCALE: 1/2" = 1'-0"

SHEET NAME:

FIRST FLOOR SANITARY AND VENT INSTALLATION PLAN

SHEET NUMBER:

HE-P102



NUFSD BOND
PROJECT
PHASE 5 -
HIGHVIEW

SED#50-01-08-03-0-002-020 (HIGHVIEW ES)
SED#50-01-08-03-7-007-002 (Maintenance)
SED#50-01-08-03-7-012-004 (OEC)
SED#50-01-08-03-0-001-026 (MILLER ES)
SED#50-01-08-03-0-004-022 (BARR MS)


Highview Elementary School
24 Highview Ave
Nanuet, NY 10954

OEC Building
135 Convent Rd
Danuett, NY 10954

Maintenance Building
103 Church St.
Nanuet, NY 10954

Miller Elementary School
50 Blauvelt Rd Unit1
Nanuet, NY 10954

MacArthur Barr Middle School
143 Church St
Nanuet, NY 10954

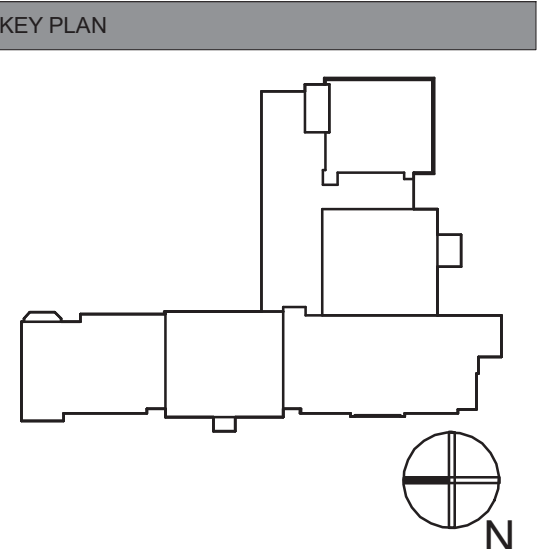

REVISIONS		
No.	Description	Date

ISSUED: BID SET

DATE: 06/21/2024


SCALE: 1/2" = 1'-0"

SHEET NAME:


SECOND FLOOR SANITARY AND VENT

INSTALLATION PLAN

HE-P103

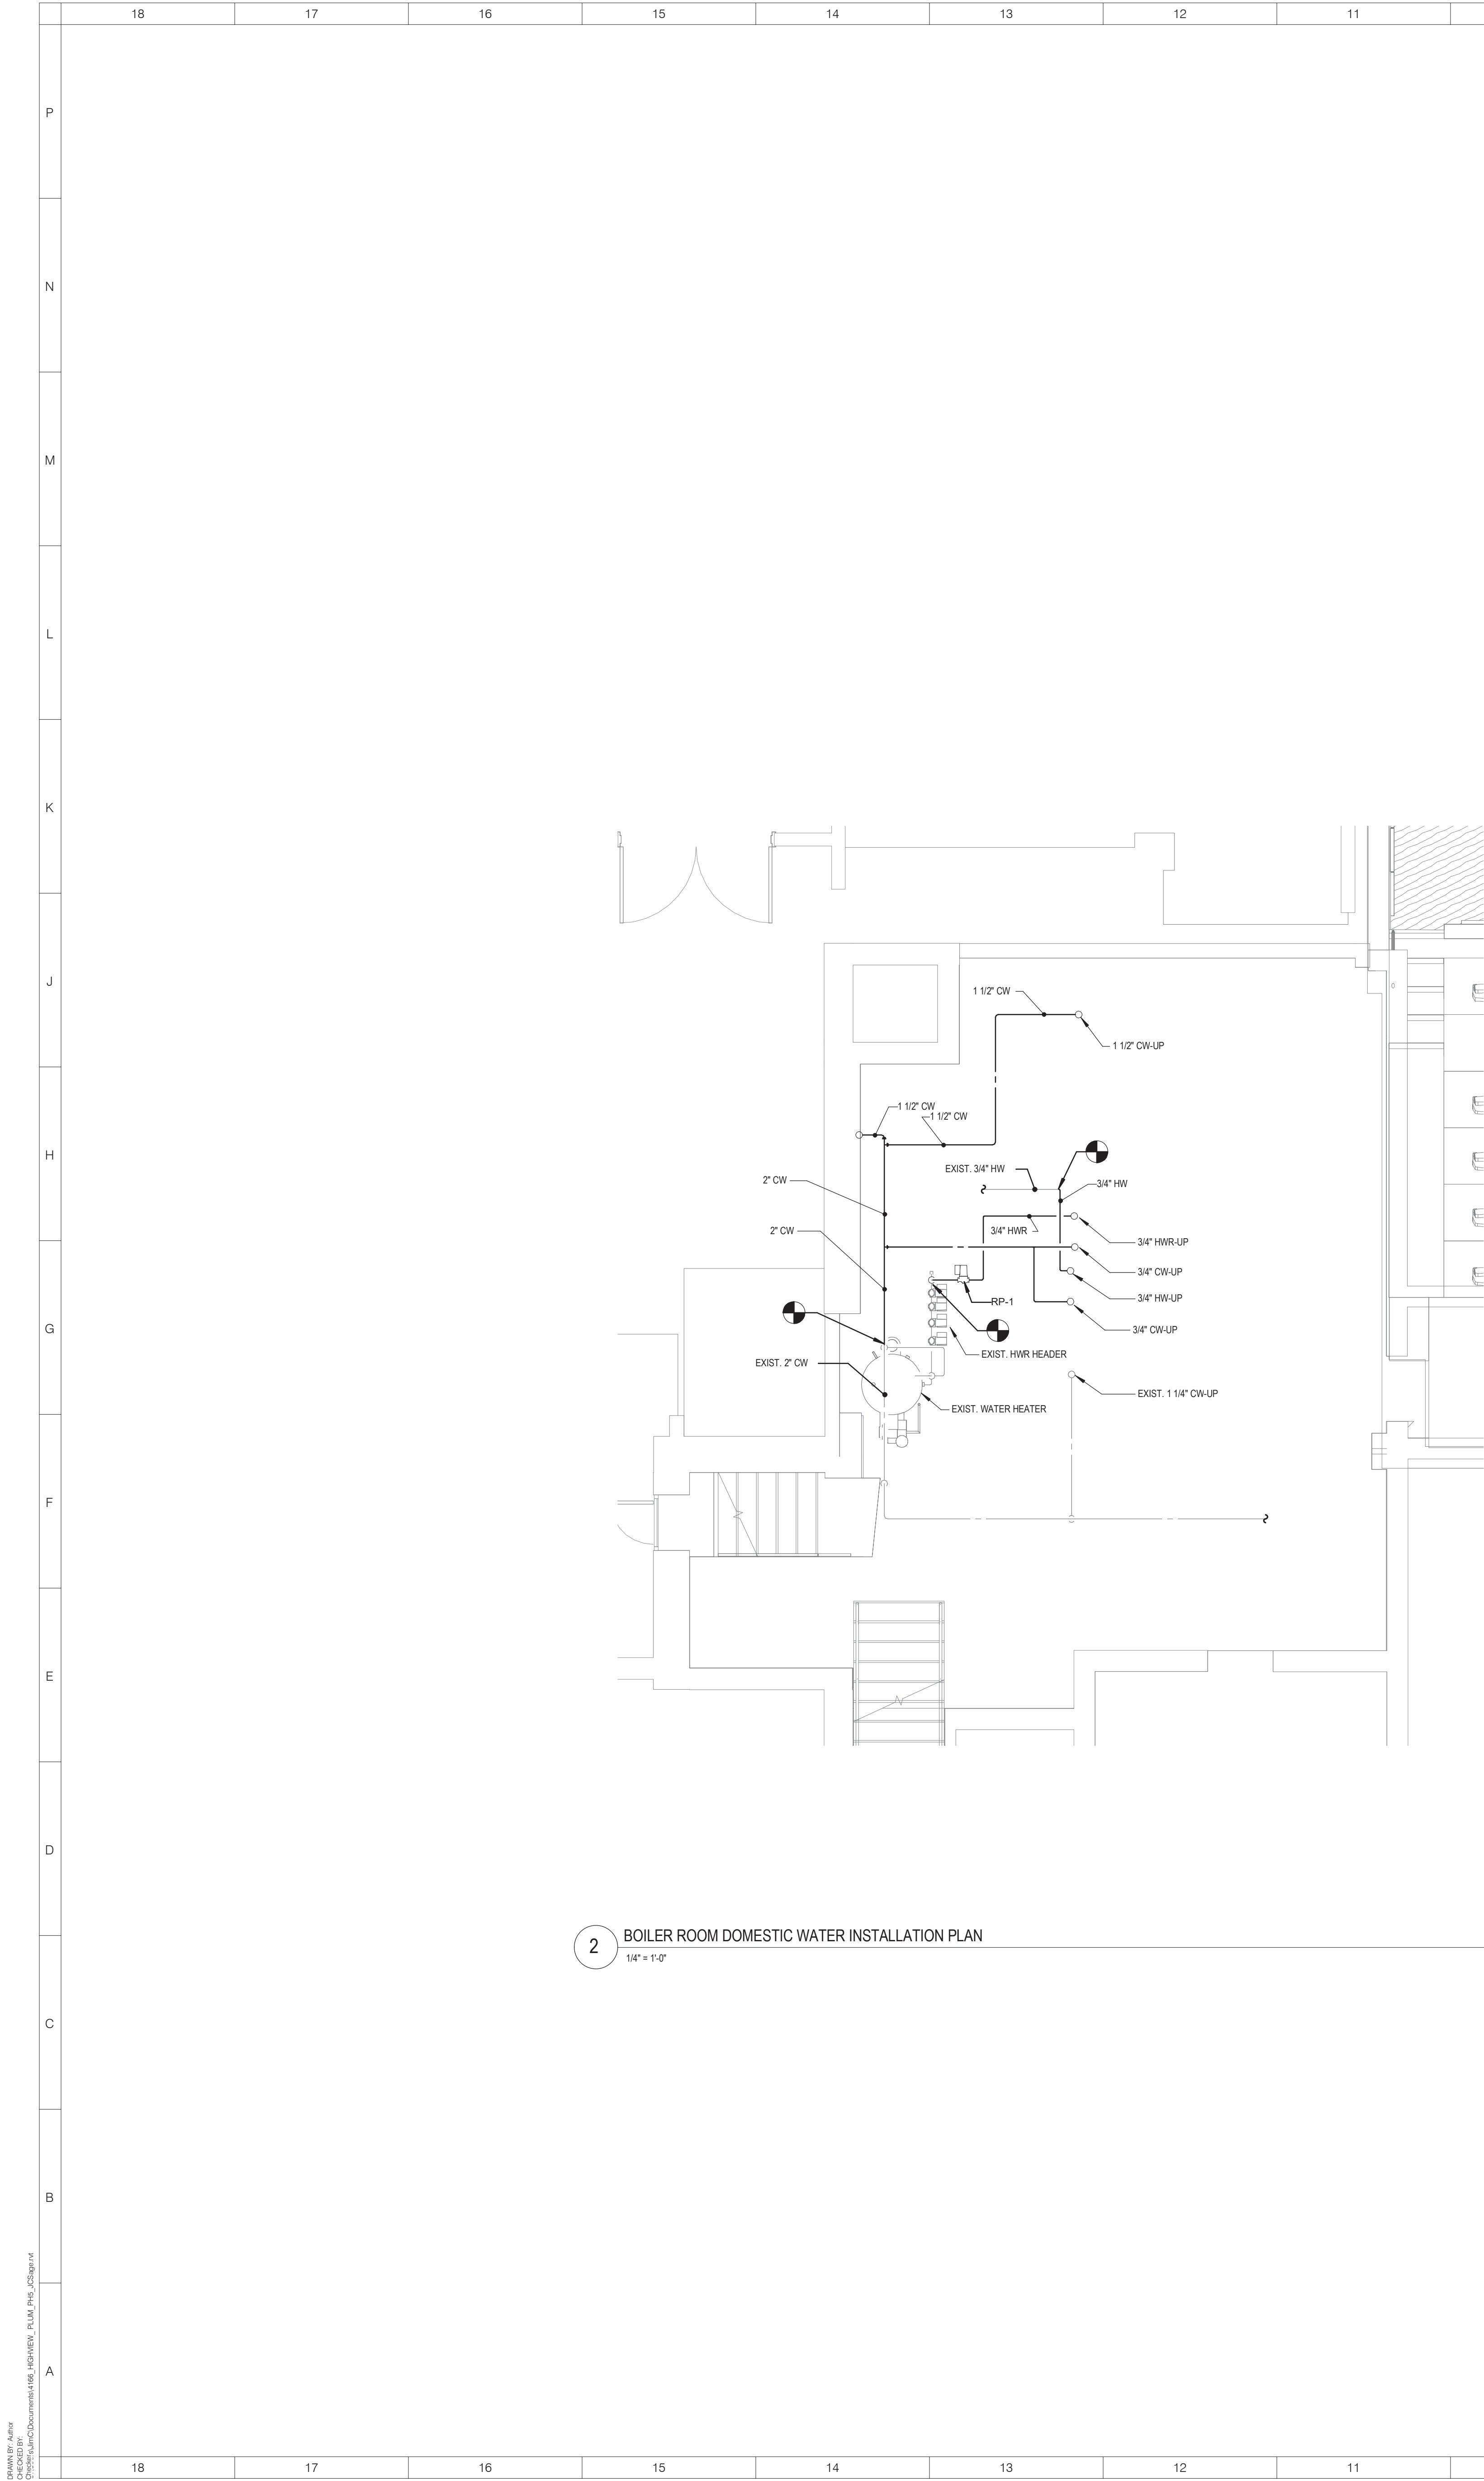

2 BOILER ROOM DOMESTIC WATER INSTALLATION PLAN
1/4" = 1'-0"

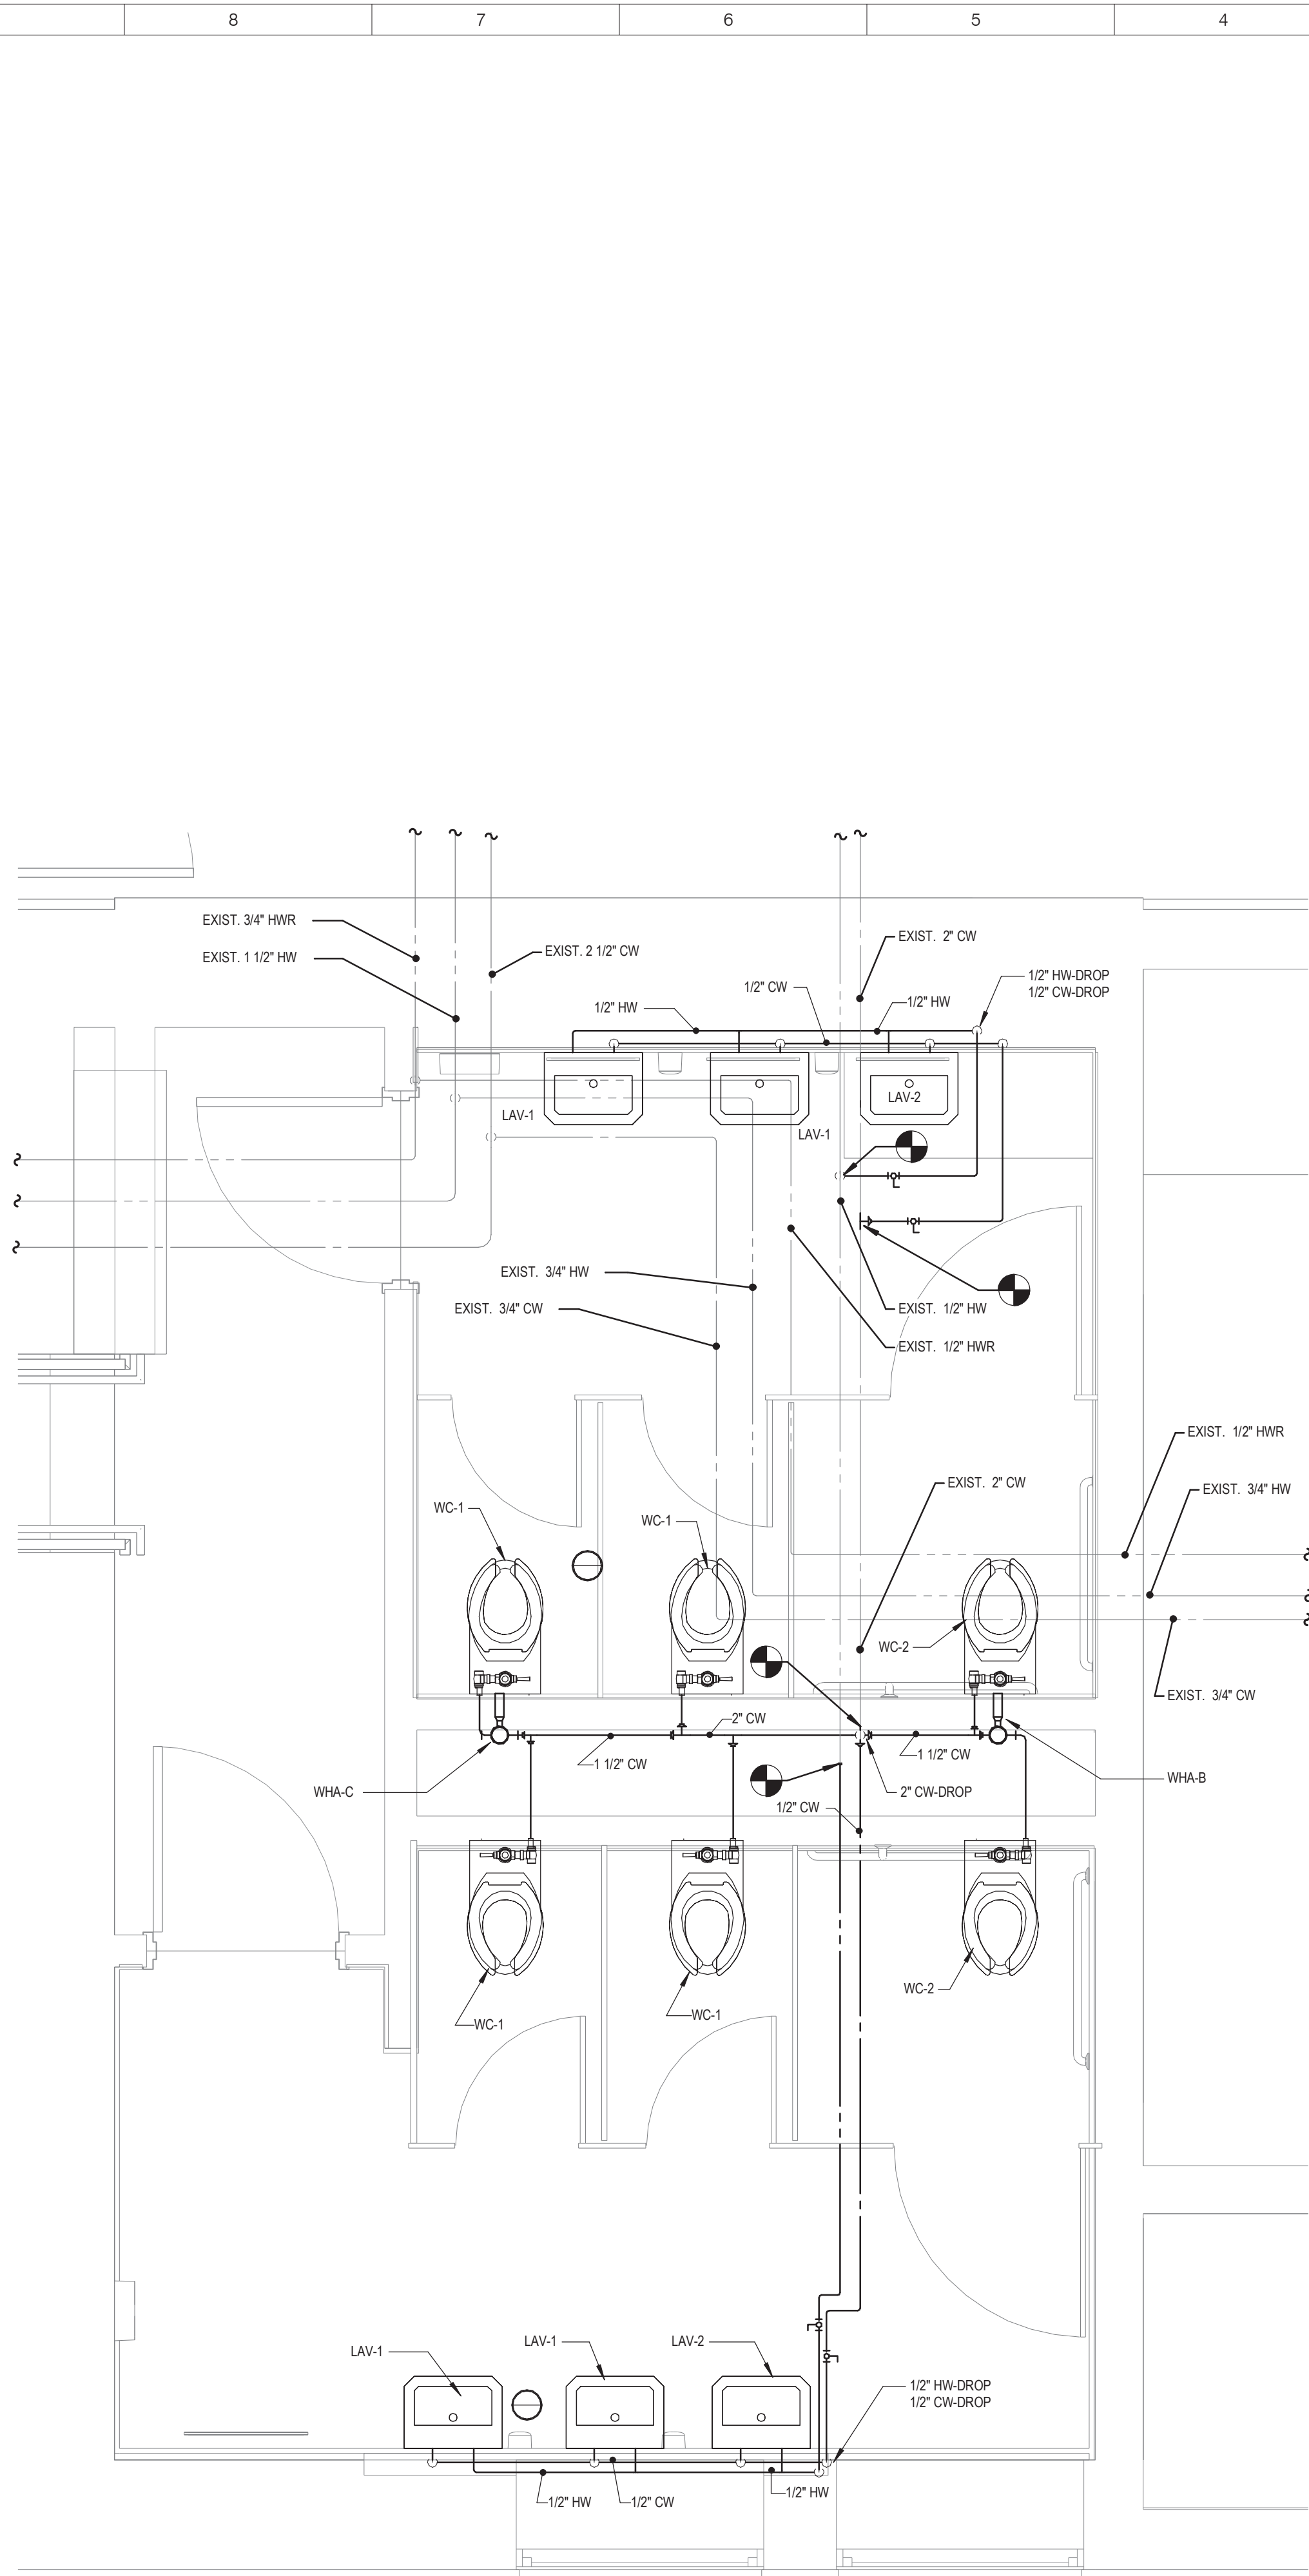

1 GROUND FLOOR DOMESTIC WATER INSTALLATION PLAN
1/2" = 1'-0"

ARCHITECT

ksqdesign

NEW YORK OKLAHOMA

KSQ Design
215 W 40th Street 15th Floor
New York, NY 10018
646.425.0660 office
www.ksqdesign.com

Owner

Nanuet Union Free School District
101 Church Street
Nanuet, NY 10954
845.627.3680
www.nanuet.edu

Structural Engineer

Clapper Structural Engineering
160 Partition Street
Saugerties, NY 12477
845.943.9601
www.clapperstructural.com

MEP Engineer

Sage Engineering Associates, LLP
9 Columbus Circle
Albany NY 12203
518.453.6051
www.sageells.com

Environmental Engineer

Quest Environmental Solutions
1376 Route 9
Wappingers Falls, NY 12590
845.298.6251
www.qualityenv.com

Construction Manager

Jacobs
One Penn Plaza
24th Floor, Suite 2400
New York, NY 10119
646.908.6550
www.jacobs.com

STATE OF NEW YORK
JOHN VENTURA
LICENSED PROFESSIONAL ENGINEER
08994
REGISTRATION EXPIRES: 11/30/25

NANUET

NUFSD BOND PROJECT PHASE 5 - HIGHVIEW

SED#50-01-08-03-0-002-000 (HIGHVIEW ES)
SED#50-01-08-03-7-002-000 (Maintenance)
SED#50-01-08-03-7-012-004 (OEC)
SED#50-01-08-03-0-001-005 (MILLER ES)
SED#50-01-08-03-0-004-022 (BARR MS)

Highview Elementary School
24 Highview Ave
Nanuet, NY 10954

OEC Building
135 Convent Rd
Nanuet, NY 10954

Maintenance Building
103 Church St.
Nanuet, NY 10954

Miller Elementary School
50 Blauvelt Rd Unit1
Nanuet, NY 10954

A MacArthur Barr Middle School
143 Church St
Nanuet, NY 10954

KEY PLAN

REVISIONS

No.	Description	Date

ISSUED: BID SET

DATE: 06/21/2024

SCALE: As indicated

SHEET NAME:
BASEMENT DOMESTIC WATER INSTALLATION PLAN

SHEET NUMBER:
HE-P201

ISSUE FOR BID SET



