


11/7/2023 3:44:41 PM

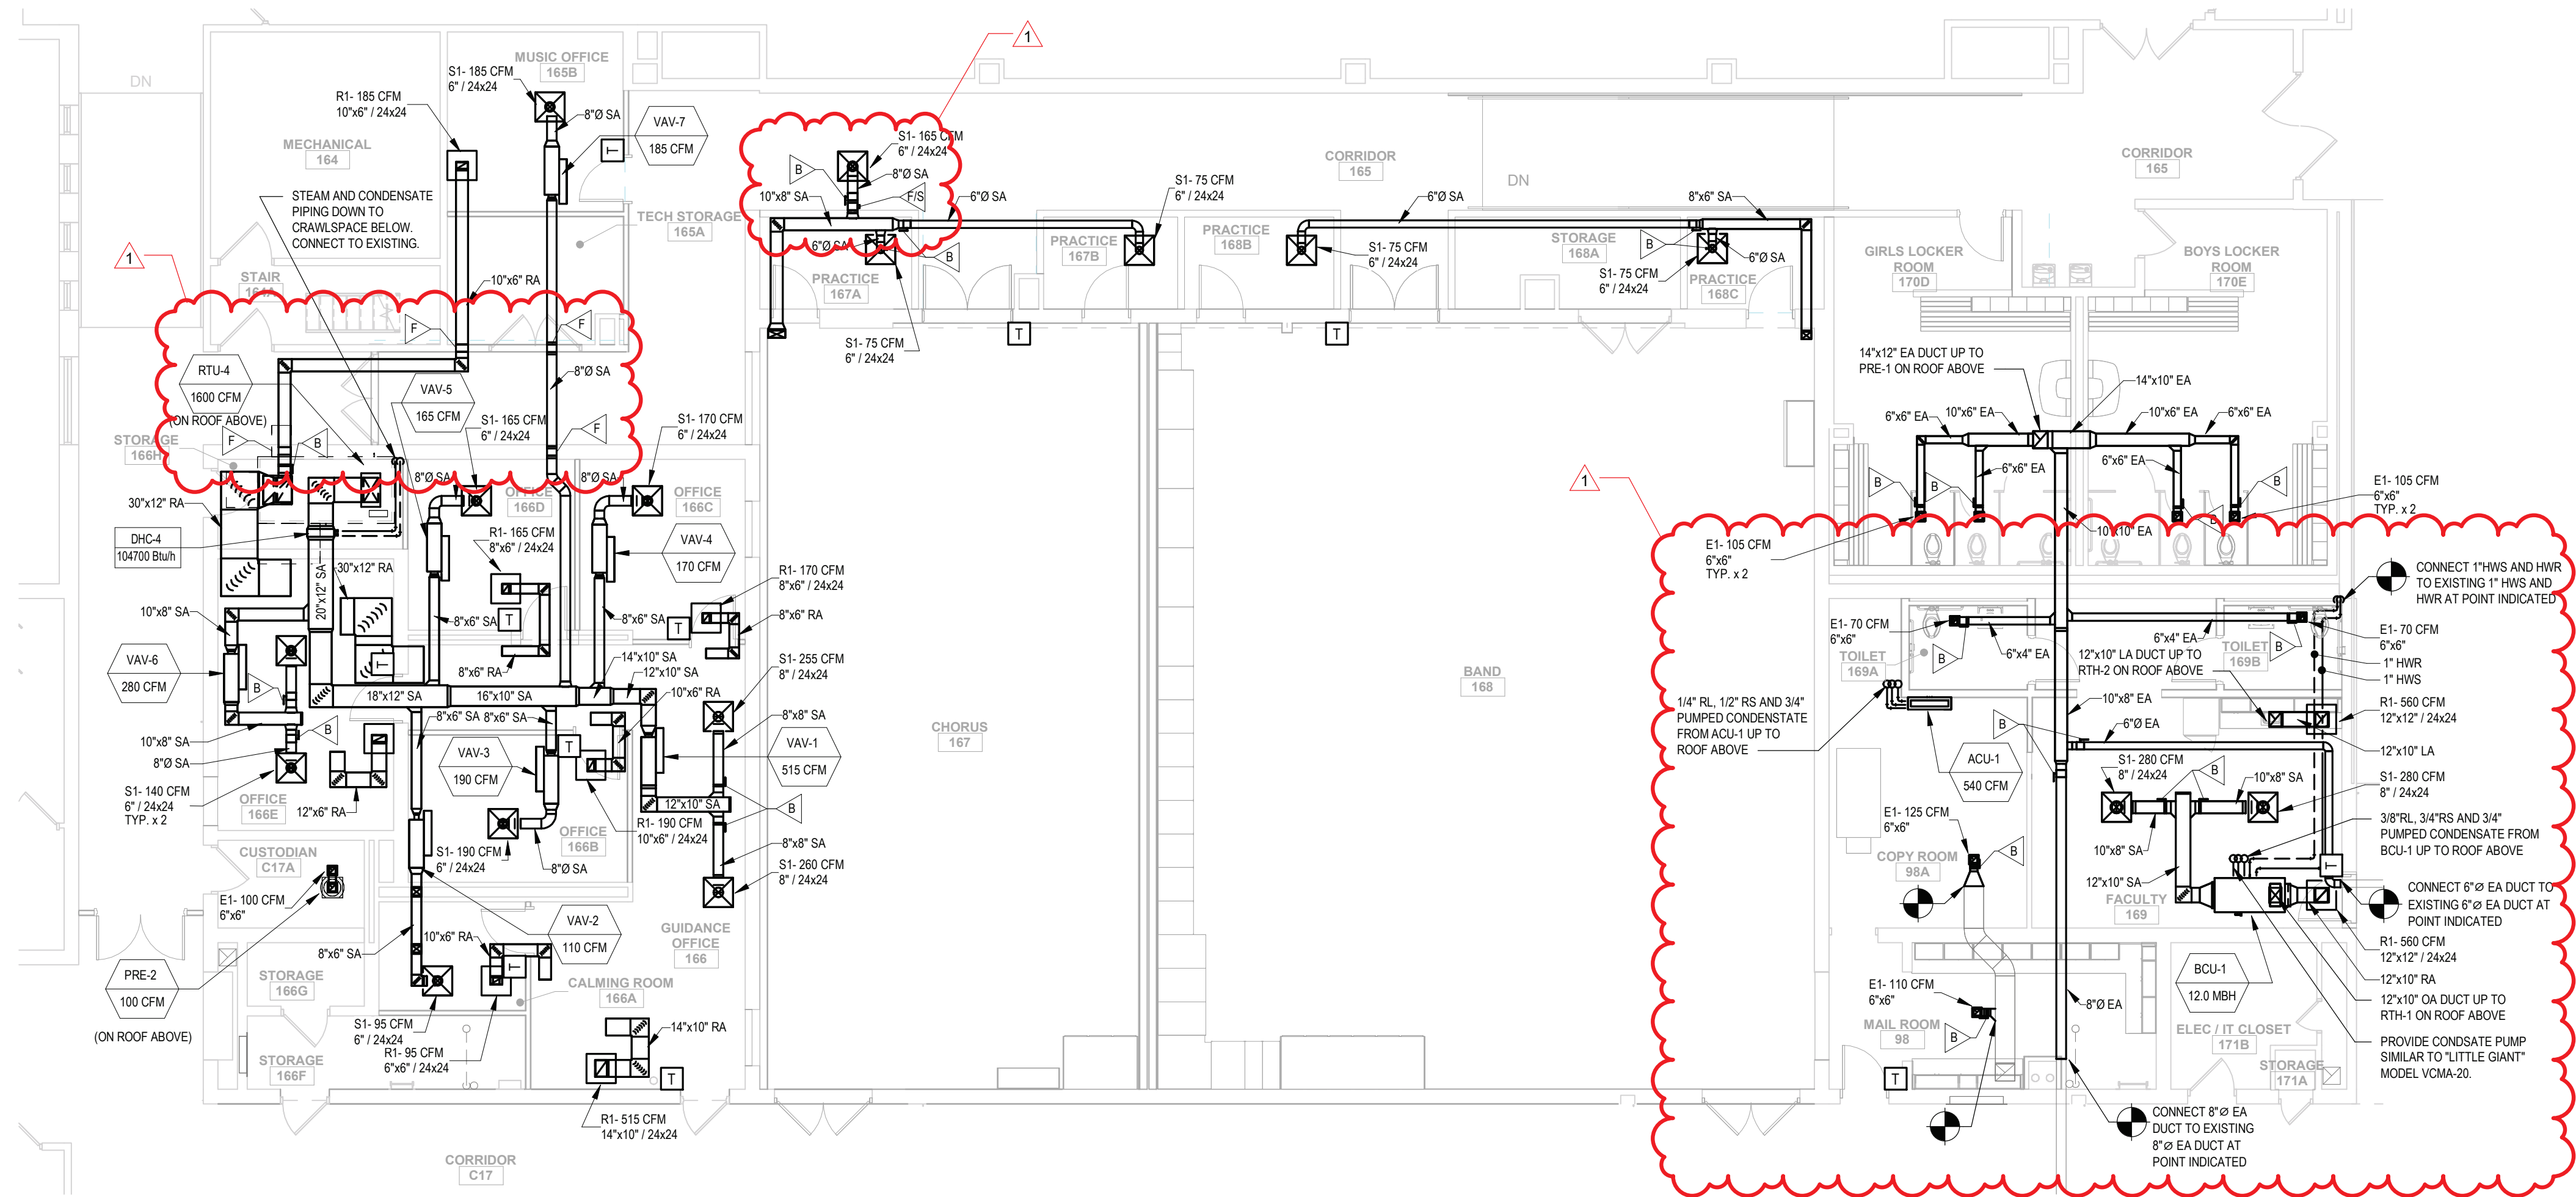


1 FIRST FLOOR PLAN - AREA B
SCALE: 1/8" = 1'-0"

GENERAL NOTES:
1. SEE DRAWING M5000 FOR GENERAL NOTES, ABBREVIATIONS, SYMBOLS AND LEGENDS

KEYNOTE LEGEND

KEY PLAN:

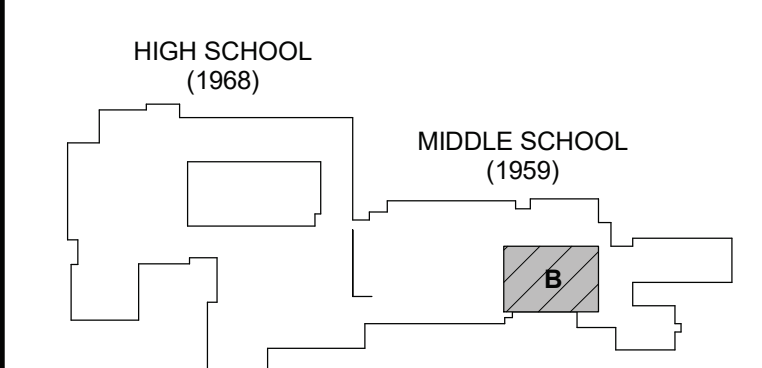

SED CONTROL NO. 44-18-00-05-0-012-040
COPYRIGHT © 2023 - BCA ARCHITECTS & ENGINEERS, WARNING - IT IS A VIOLATION OF THE NEW YORK STATE EDUCATION LAW FOR ANY UNAUTHORIZED ALTERATIONS TO THIS DOCUMENT AS PER ARTICLE 145 AND 147.

BCA Architects & Engineers
Ithaca | Saratoga Springs | Watertown | Rochester
WWW.THEBCGROUP.COM

BCA
ARCHITECTS
ENGINEERS



PORT JERVIS CITY SCHOOL DISTRICT
RENOVATIONS TO:
KUHL ELEMENTARY
Port Jervis - Orange County - New York

REV	DATE	DESCRIPTION
1	11/06/2023	BID ADD. NO. 1
DRAWN BY AJZ		PROJECT NUMBER 2019-011 PH2
CHECKED BY JLM		DATE 10/06/2023

FIRST FLOOR PLAN - AREA B

BUILDING	SHEET NUMBER
AS	M101