

GENERAL NOTES:

- The work on this project shall be awarded as four (4) separate prime contracts. Contracts to be awarded under this BID are as follows:



2108.01B GC - General Construction
2108.01B M - Mechanical Work
2108.01B P - Plumbing Work
2108.01B E - Electrical Work
- All contractors and their sub contractors shall be required to coordinate and schedule their work with other contractors as required to facilitate sequencing, coordination, etc. It shall be the responsibility of each contractor to notify other contractors of conditions that will affect their work or the work of respective sub contractors that will require coordination and/or verification. No change orders will be considered for costs incurred due to lack of proper coordination. All notifications between prime contractors shall be in writing or in meeting minutes to be considered valid.
- Each contractor shall review the entire set of drawings (including architectural drawings) to coordinate their own work and with work of other trades, and to verify information that will affect their work. In general, locations indicated on architectural plans takes precedence over other documents. Architect shall provide interpretation of locations etc. when requested.
- All items specified indicate the minimum standard for components to be incorporated into the project. Any "or equal" must be approved by the Architect and owner. All items called for or specified shall be installed in compliance with the manufacturers written specifications and installation instructions which are incorporated into these drawings in their entirety by this reference. Installations shall include any and all hardware, supports, fittings, components, clearances, etc. which are required for a complete and proper installation and maintenance without exception.
- All work shall comply with the requirements of the Building Code of New York State. Contractors shall coordinate any and all required inspections as required for issuance certificate of occupancy.
- Each prime contractor shall be responsible for his own excavations, shoring, dewatering, etc. as required for the installation of his own work. Provide 95% compaction clean back fill in max. 12" lifts typical. All Areas.
- Each contractor shall maintain one set of marked up drawings to indicate any and all deviations for as built conditions and shall turn over same to the Architect upon completion of project.

PROPOSED SUBSTATION ALTERATION FOR TAPPAN FIRE DISTRICT 300 WESTERN HIGHWAY SOUTH TAPPAN, NY 10983

DATE: ISSUE
07-20-2022 ISSUED
FOR BIDDING & PERMIT

SEAL:

SENDLEWSKI ARCHITECTS PC
ARCHITECTS - PLANNERS
215 ROANOKE AVENUE
RIVERHEAD, NY 11901
(631) 727-5352
9 SELENA COURT
WALDEN, NY 12586
(845) 275-8859

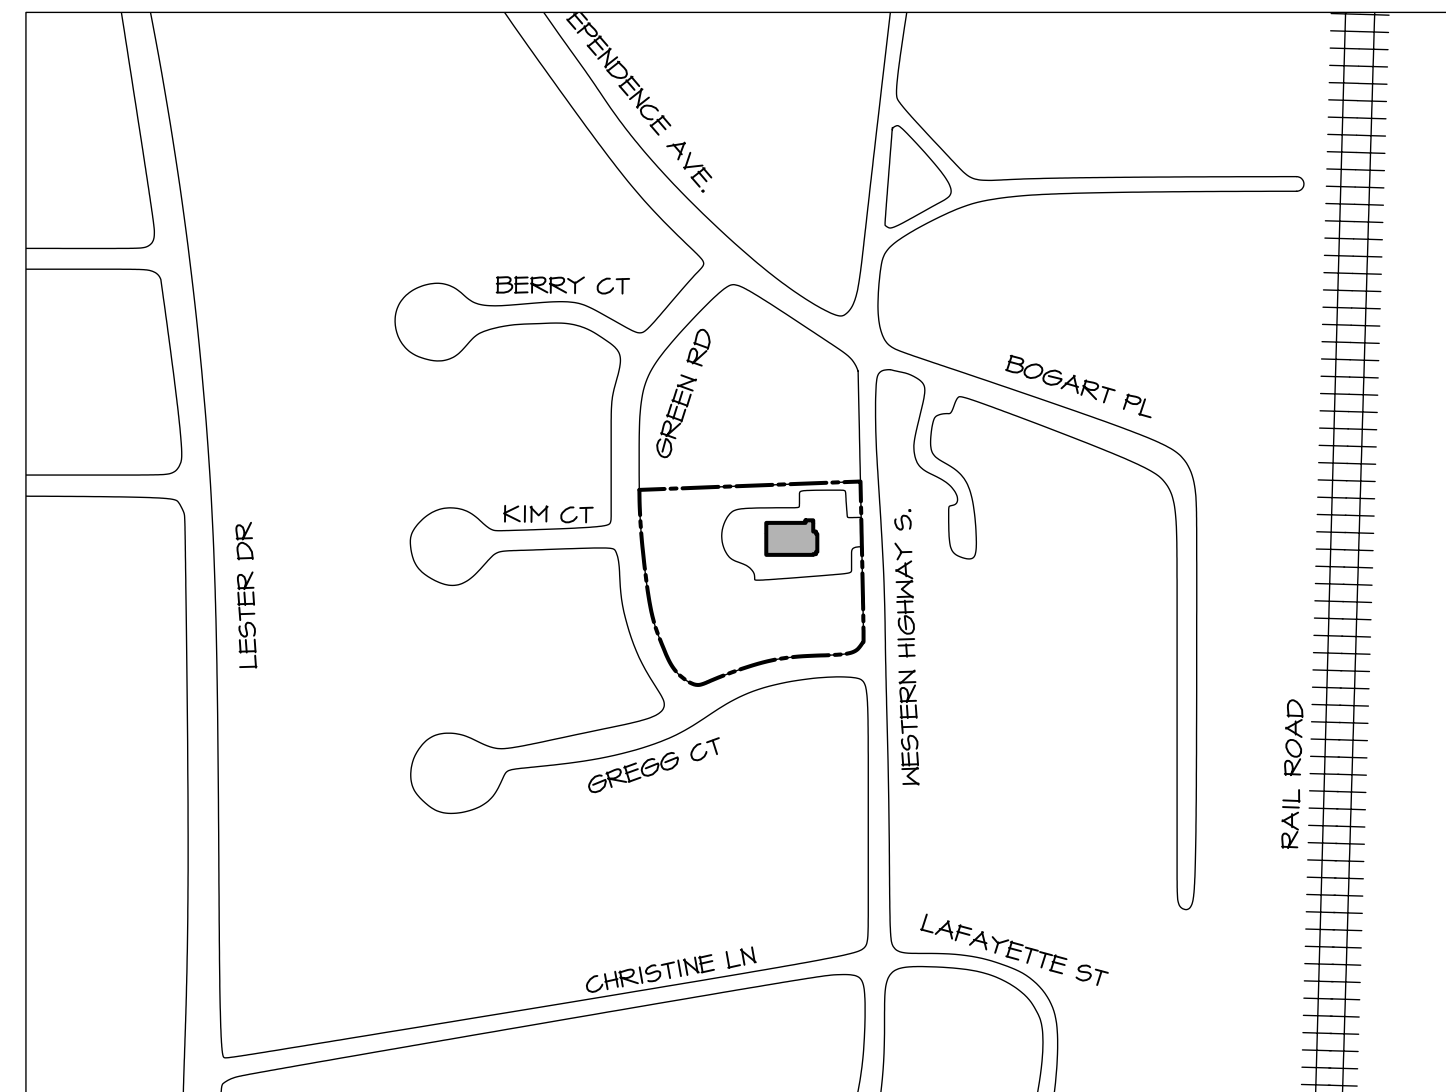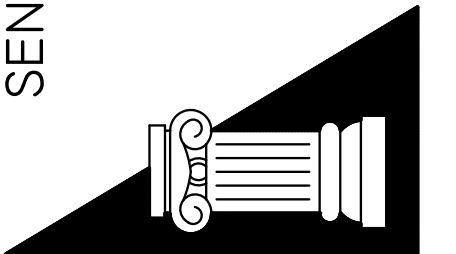

LIST OF DRAWINGS

GENERAL CONSTRUCTION DRAWINGS

O-0	COVER SHEET
D-1	SELECTIVE DEMOLITION PLAN, ELEVATIONS & NOTES
A-1.1	FIRST FLOOR PLAN & DETAILS
A-1.2	MEZZANINE PLAN & DETAILS
A-2.1	ROOF PLAN & DETAILS
A-3.1	ELEVATIONS & NOTES
A-4.1	SECTIONS & DETAILS
A-4.2	SECTIONS & DETAILS
A-5.1	STAIR PLANS AND SECTION
A-6.1	WALL SECTIONS & DETAILS
A-7.1	DOOR & FINISH SCHEDULES & DETAILS
A-7.2	BATHROOM PLANS & ELEVATIONS & PARTIAL FIRST FLOOR PLAN
A-8.1	FIRST FLOOR & MEZZANINE REFLECTIVE CEILING PLAN

MECHANICAL DRAWINGS

O-0	COVER SHEET
D-1	SELECTIVE DEMO PLAN
M-1	SCOPE OF WORK HEAR GAIN / LOSS CALCULATIONS
M-2	FIRST FLOOR PLAN
M-3	SECOND FLOOR MECHANICAL PLAN
M-4	ROOF MECHANICAL PLAN
M-5	MECHANICAL EQUIPMENT SCHEDULES & RISER DIAGRAM
M-6	MECHANICAL DETAILS
M-7	MECHANICAL NOTES

PLUMBING DRAWINGS

O-0	COVER SHEET
D-1	SELECTIVE DEMOLITION PLAN
P-1	PLUMBING SITE PLAN
P-2	PLUMBING FIXTURE & SPECIALTY SCHEDULES
P-3	FIRST FLOOR DOMESTIC WATER, AIR, GAS PLAN
P-4	MEZZANINE DOMESTIC WATER, AIR GAS PLAN
P-5	FIRST FLOOR SANITARY PLAN
P-6	MEZZANINE SANITARY LINE
P-7	PLUMBING ROOF PLAN
P-8	PLUMBING RISER DIAGRAMS
P-9	PLUMBING DETAILS
P-10	PLUMBING NOTES

ELECTRICAL DRAWINGS

O-0	COVER SHEET
D-1	SELECTIVE DEMO PLAN
E-1	ELECTRICAL SITE PLAN
E-2	ELECTRICAL PANEL SCHEDULES
E-3	FIRST FLOOR POWER PLAN
E-4	MEZZANINE POWER PLAN
E-5	ROOF POWER PLAN
E-6	FIRST FLOOR LIGHTING PLAN
E-7	MEZZANINE LIGHTING PLAN
E-8	FIRST FLOOR MISCELLANEOUS PLAN
E-9	MEZZANINE MISCELLANEOUS PLAN
E-10	MISCELLANEOUS RISERS
E-11	MISCELLANEOUS RISERS CONTINUED

PRE-BID CONFERENCE & RFI NOTE:

A PRE-BID CONFERENCE STARTING AT 11:00 AM PREVAILING TIME ON WEDNESDAY THE 10TH DAY OF AUGUST 2022 AT THE TAPPAN FIRE DEPARTMENT WASHINGTON STREET FIREHOUSE LOCATED AT 135 WASHINGTON STREET, TAPPAN, NY 10983. FOLLOWED BY VISITS TO BOTH PROJECT SITES FOR THE ABOVE NOTED BIDS.

TAPPAN FIRE DISTRICT
300 WESTERN HIGHWAY SOUTH
TAPPAN, NY 10983

 
COVER SHEET

PROJECT #: 2108.01B

DRAWN BY: AR/JC

CAD FILE: 2108.01B/P-/BID

DRAWING#:



SUB STATION

CONSTRUCTION

- C1. EXISTING INTERIOR WALL ARE TO BE REMOVE
- C2.1 EXISTING INTERIOR WALL FINISHES ARE TO BE REMOVED & REPLACE WHERE APPLICABLE. SEE FINISH SCHEDULE DWG A-1.1.
- C2.2 EXISTING WOOD SHELVES TO BE REMOVE
- C3. EXISTING VENT TO BE REMOVE, AREA TO BE INFILL & PATCH AS NEEDED.
- C4. EXISTING CEILING TO BE REMOVED. REPLACE WHERE APPLICABLE SEE DWG A-1.1
- C5.1 EXISTING WINDOW INCLUDING FRAME TO BE REMOVE
- C5.2 EXISTING WINDOW TO REMAIN
- C6. EXISTING SOFFIT TO BE REMOVE & REPLACE
- C7. EXISTING WHITE VINYL SIDING TO BE REMOVE & REPLACE WITH NEW HARDIE WOOD PLANK.
- C8. EXISTING PAINTED CMU TO REMAIN, EXISTING PAINT TO BE REMOVE, AREA TO BE PATCH AS NEEDED FOR NEW CULTURE STONE TO BE INSTALL.
- C9. EXISTING FRAME WITH GLASS ABOVE DOORS TO BE REMOVE & REPLACE.
- C10. EXISTING DOORS INCLUDING DOOR FRAMES TO BE REMOVE & REPLACE UNLESS NOTED OTHER WISE
- C11.1 REMOVE EXISTING O.H.D. OPERATORS TO BE REPLACED AS PART OF BASE BID
- C11.2 REMOVE EXISTING O.H.D. AS PART OF ADD. ALTERNATE TO BE REPLACED IF ACCEPTED.
- C12. NEW EIFS SYSTEM TO BE INSTALL ON TOP OF EXISTING BRICK
- C13. METAL & ASSOCIATED STONE COPING TO BE REMOVE.
- C14. EXISTING ANTENNA TO BE REMOVE & REINSTALL
- C15. EXISTING FLAG POLE TO BE REMOVE & REINSTALL
- C16. EXISTING TAPPAN FIRE DISTRICT SIGN TO BE REMOVE & REINSTALL (SEE DWG. A-3.1 FOR LOCATION)
- C17. PULL DOWN STAIR TO BE REMOVE, AREA TO BE ALTER FOR NEW STAIRWAY TO BE INSTALLED
- C18. ROOF SHEATHING TO BE REMOVE & REPLACE
- C19. EXISTING MONUMENT TO BE REMOVE.

- C20. ARE TO BE SAW CUT & PATCH AS NEEDED. NEW 2" CONC. SLAB TO BE POUR.
- C21. PORTION OF EXISTING MEZZANINE FLOOR AT NEW STAIR LOCATION TO BE REMOVE & ALTER AS NEEDED.
- C22. PORTION OF EXISTING ASPHALT TO BE SAW CUT, FOR NEW COLUMN FOOTING. AREA TO BE PATCH AS NEEDED. SEE DWG A-2.1 DETAIL A.
- C23. PROVIDE POCKETS IN EXISTING CMU WITH NEW 8"x12" PLATE W/ (2) 3"x8" ANCHORS INTO EXISTING CMU. W/ SOLID GROUT TO RECEIVE NEW FRAMING.

MECHANICAL


- M1. BOILER TO BE REMOVE
- M2. AIR COMPRESSOR TO BE REMOVE
- M3. EXHAUST VENT TO REMAIN
- M4. ANY AND ALL MECHANICAL HEATING SYSTEM TO BE REMOVED INCLUDING BASEBOARDS, UNITS HEATERS, ETC. INCLUDING ALL ASSOCIATED PIPING, PUMPS, ETC.

ELECTRICAL


- E1.1 EXISTING LIGHT FIXTURE TO BE REMOVE
- E1.2 EXISTING LIGHT FIXTURE TO BE REMOVE & RELOCATED
- E2. EXISTING LIGHT FIXTURE TO REMAIN
- E3. ALL ELECTRICAL OUTLET ASSOCIATED WITH DEMOLISHED WALLS ARE TO BE REMOVED. CIRCUIT WIRING TO BE BACK INTO CEILING FOR FUTURE USE WHERE APPLICABLE.
- E4. ELECTRICAL PANEL TO REMAIN

PLUMBING


- P1. EXISTING PLUMBING FIXTURES TO BE REMOVE & ASSOCIATED PIPING
- P2. EXISTING HOT WATER HEATER TO BE REMOVE.
- P3. SAW CUT & REMOVE PORTION OF EXISTING SLAB AS REQUIRED FOR NEW SANITARY PIPING

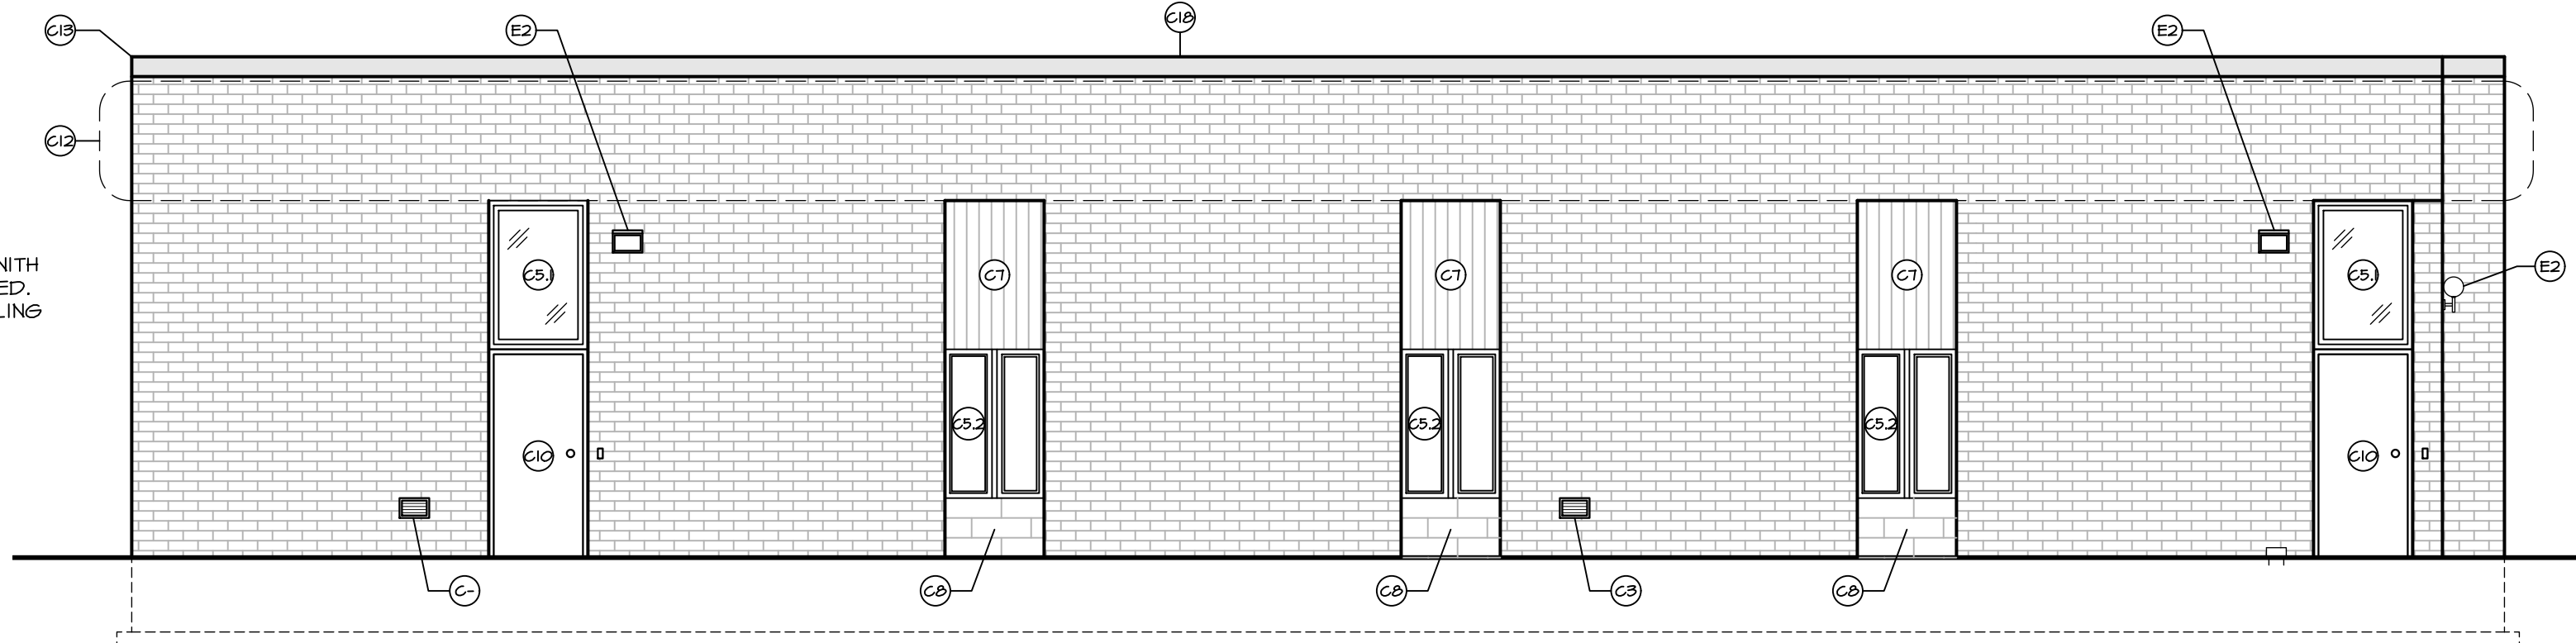


NORTH ELEVATION
SCALE: 3/16" = 1'-0"

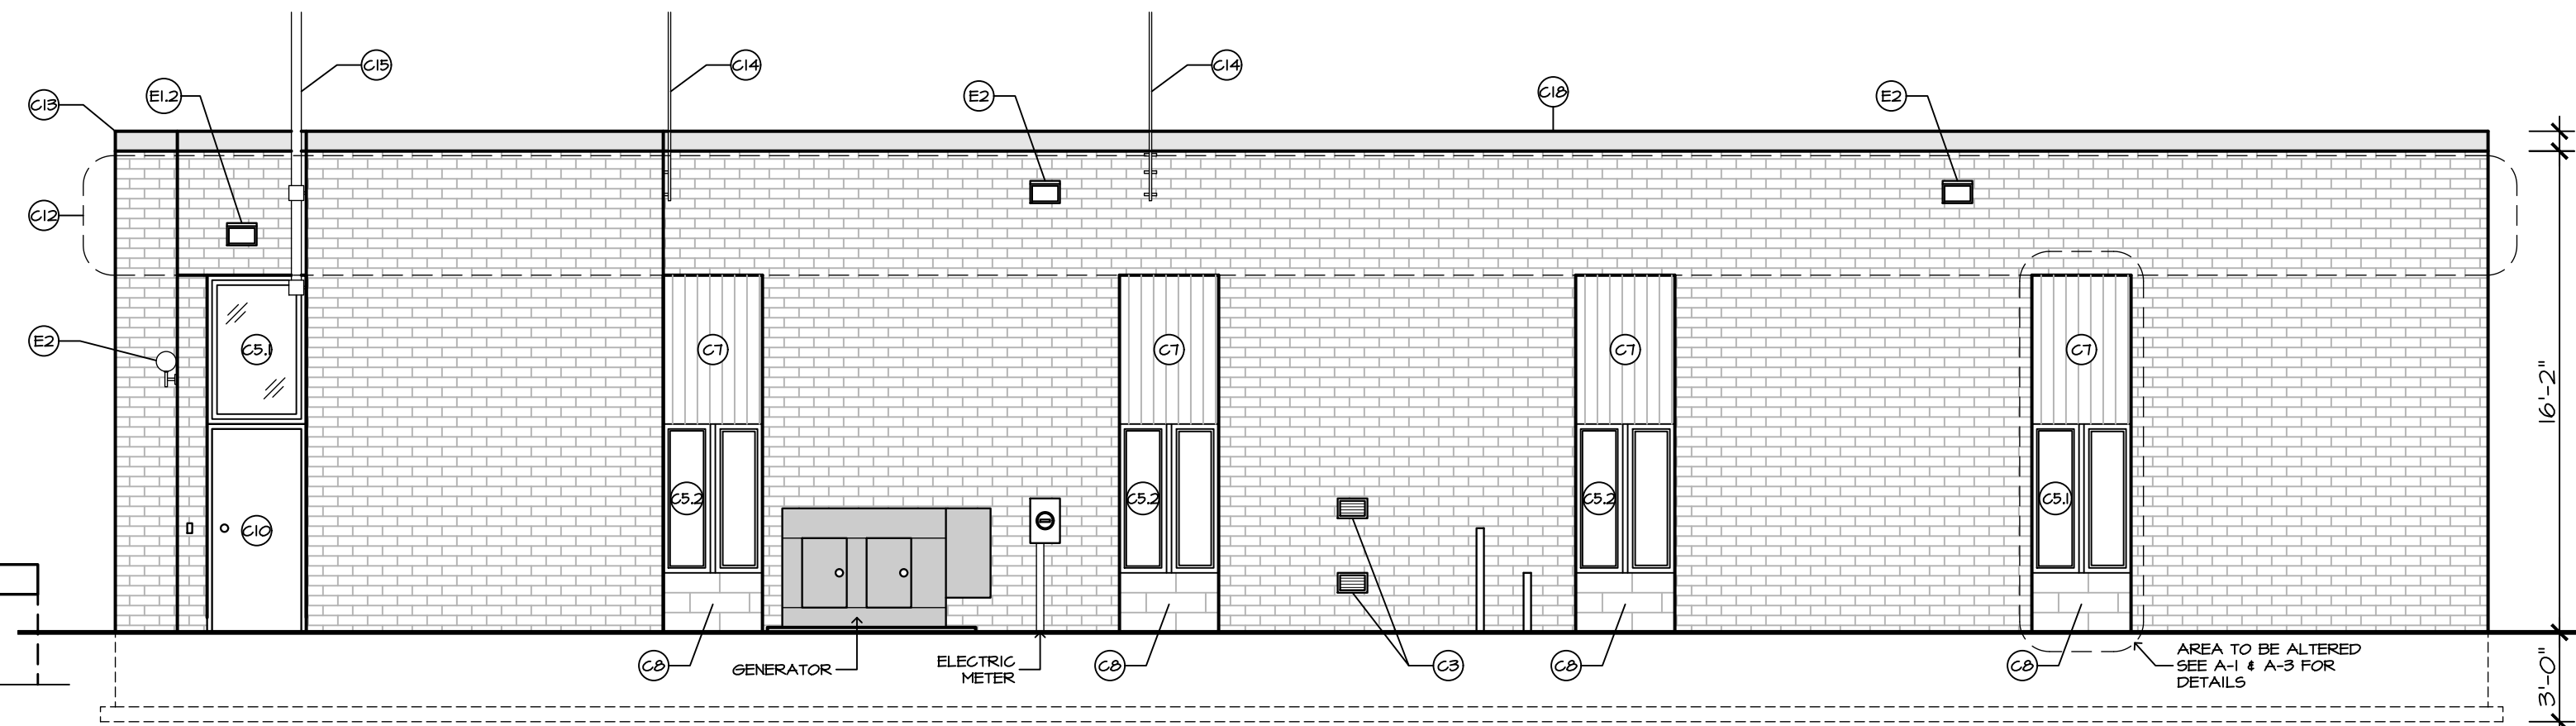


SOUTH ELEVATION
SCALE: 3/16" = 1'-0"

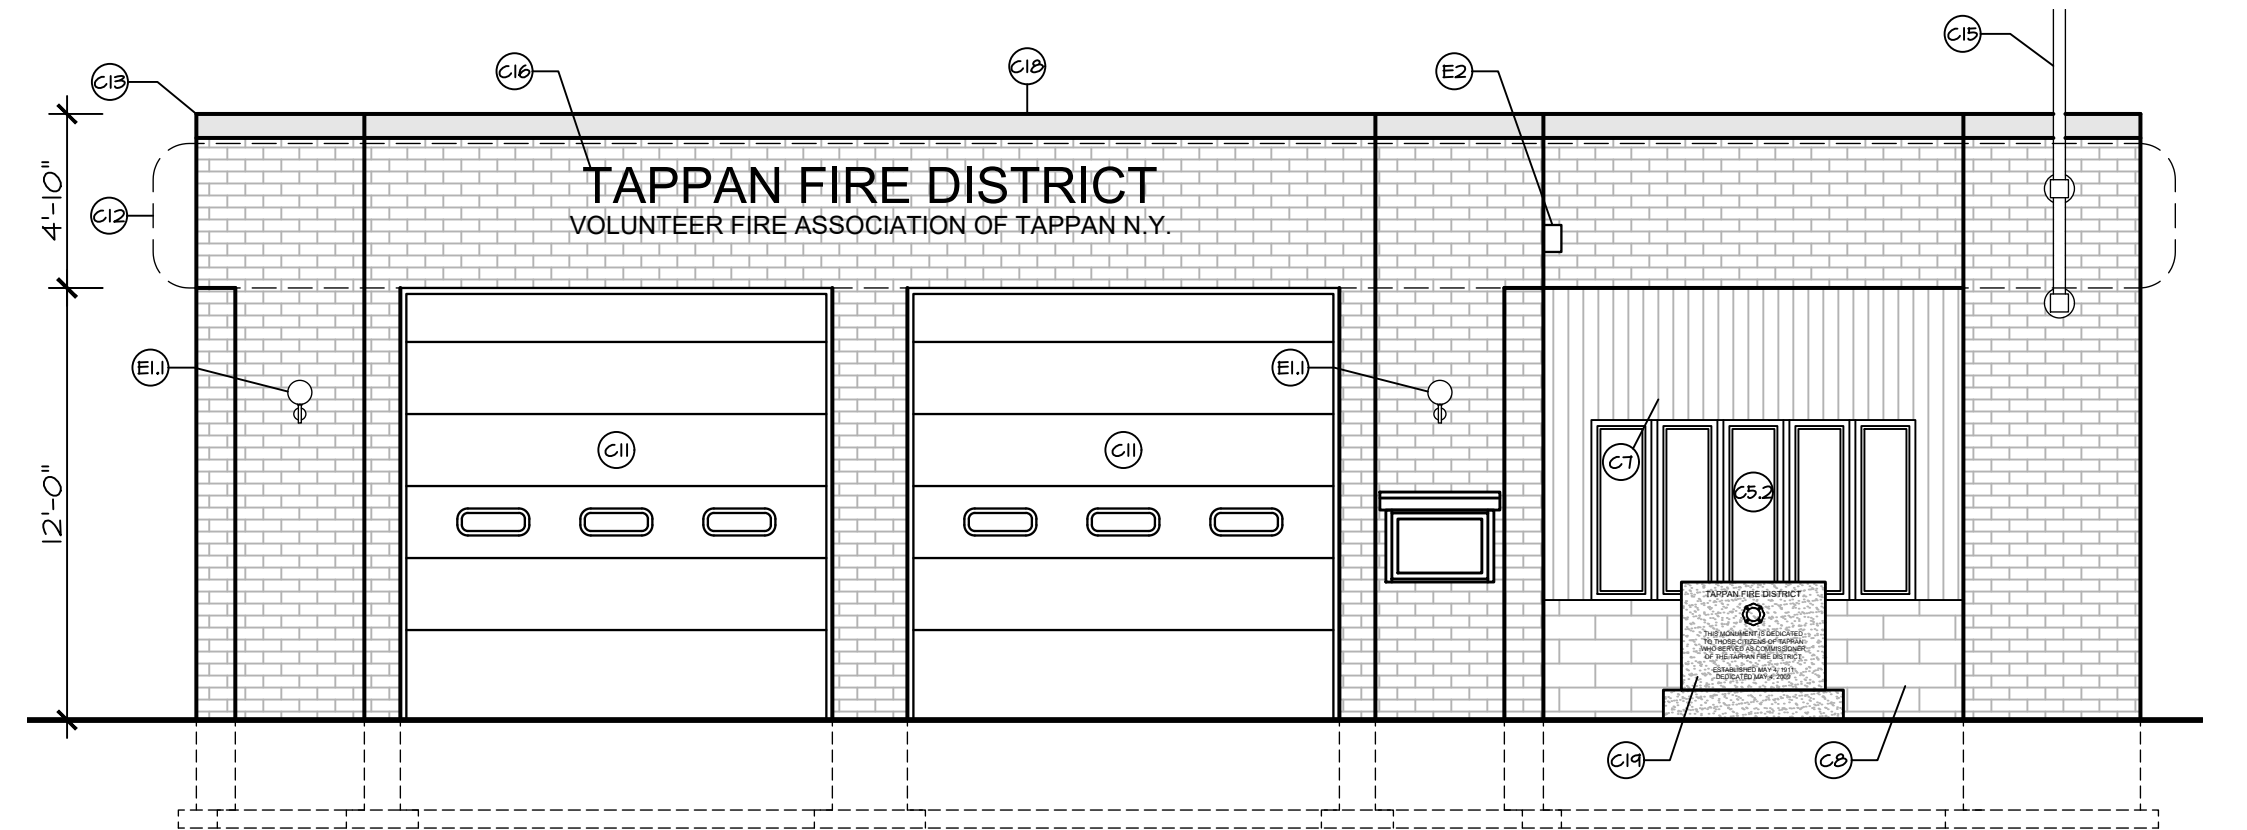


EAST ELEVATION
SCALE: 3/16" = 1'-0"

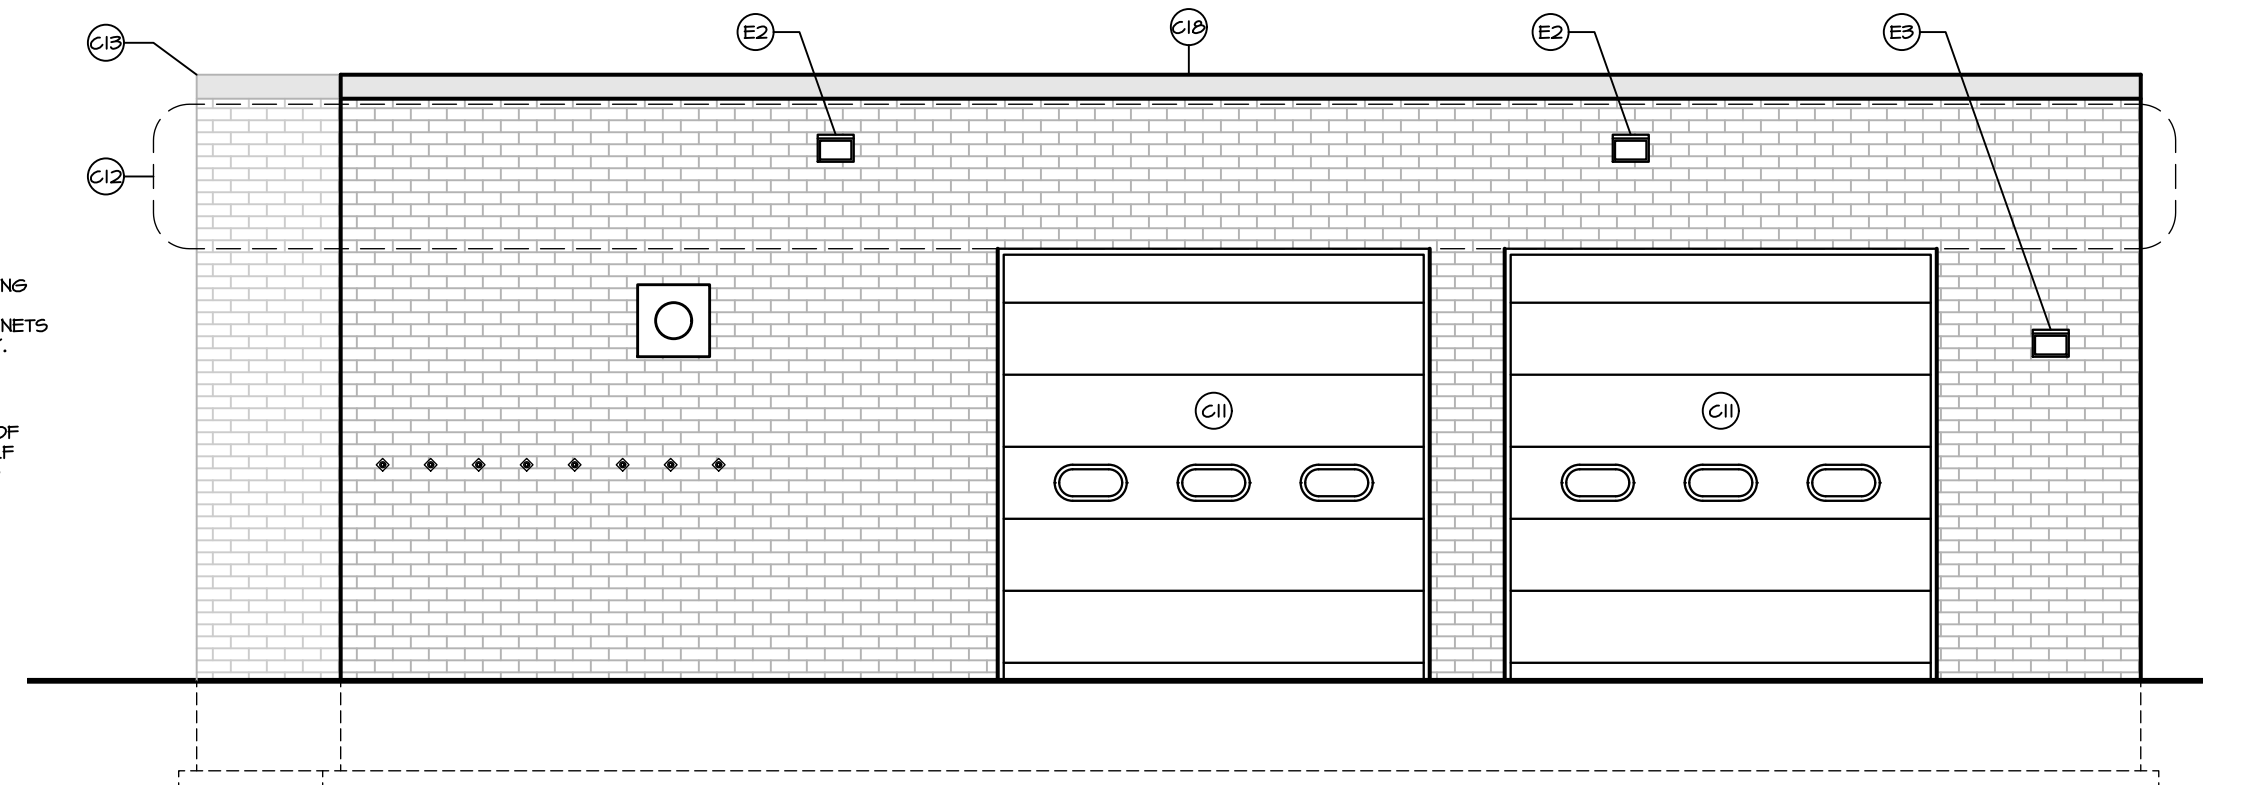

WEST ELEVATION
SCALE: 3/16" = 1'-0"

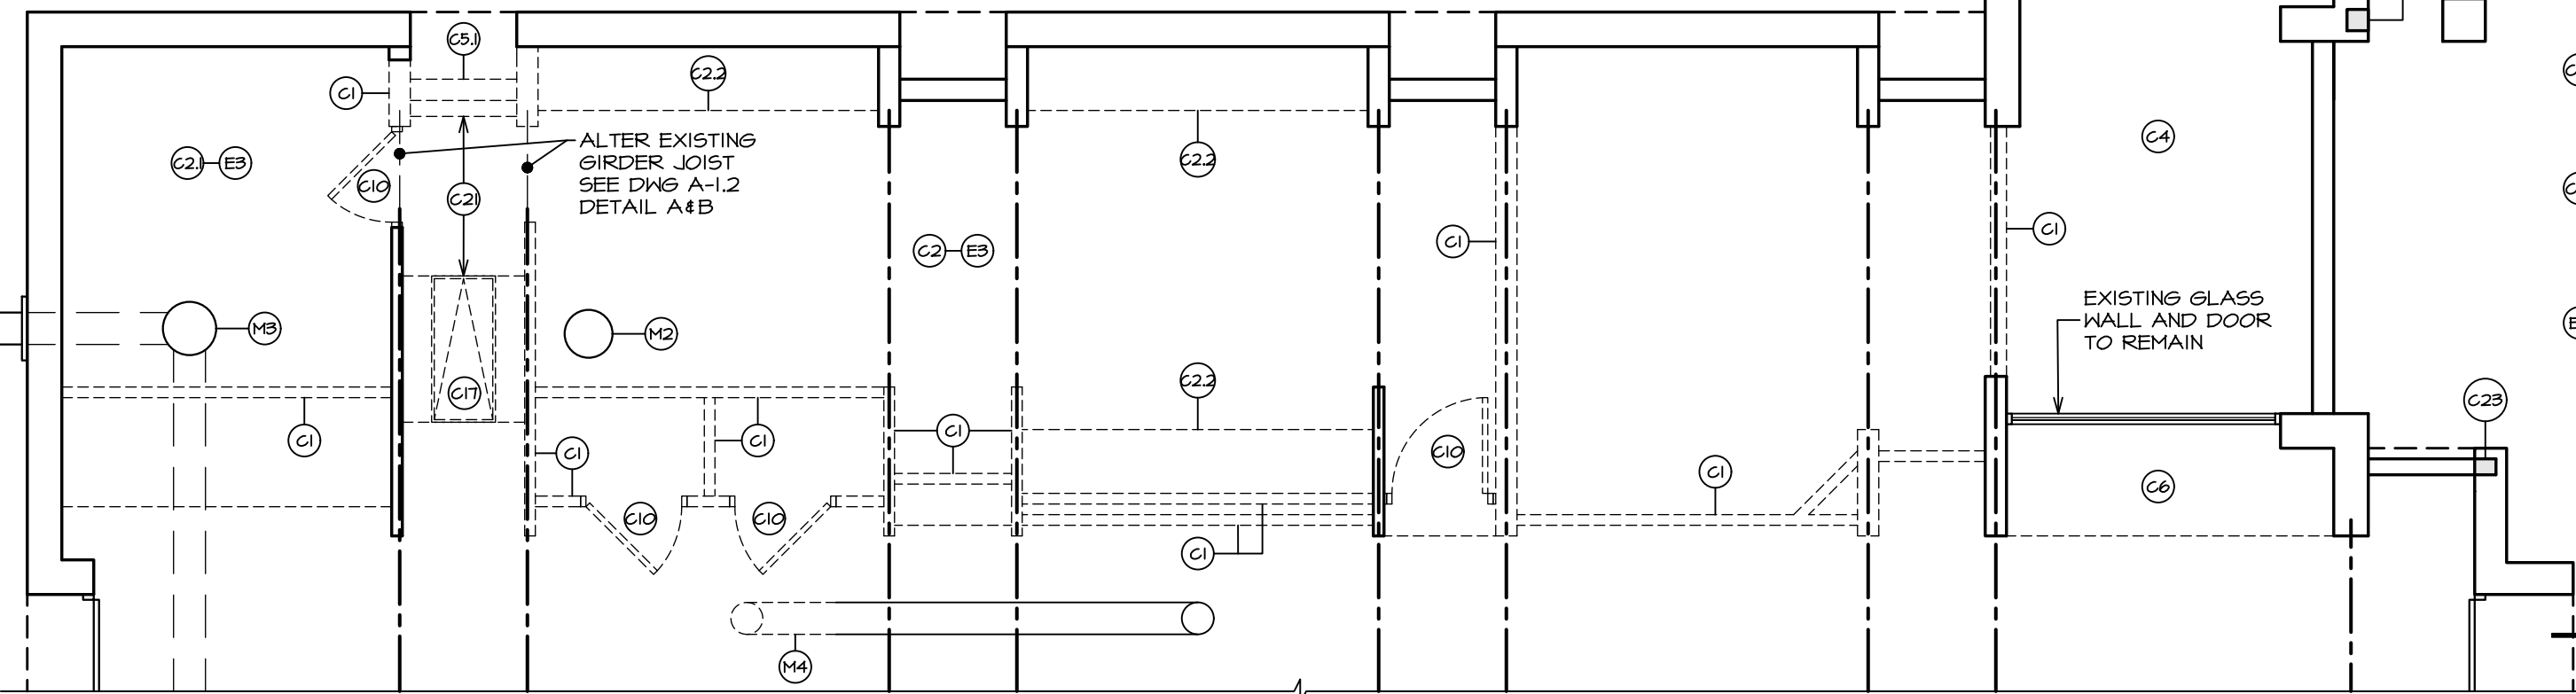


MEZZANINE DEMO PLAN (M-4 TYP.)
SCALE: 3/16" = 1'-0"

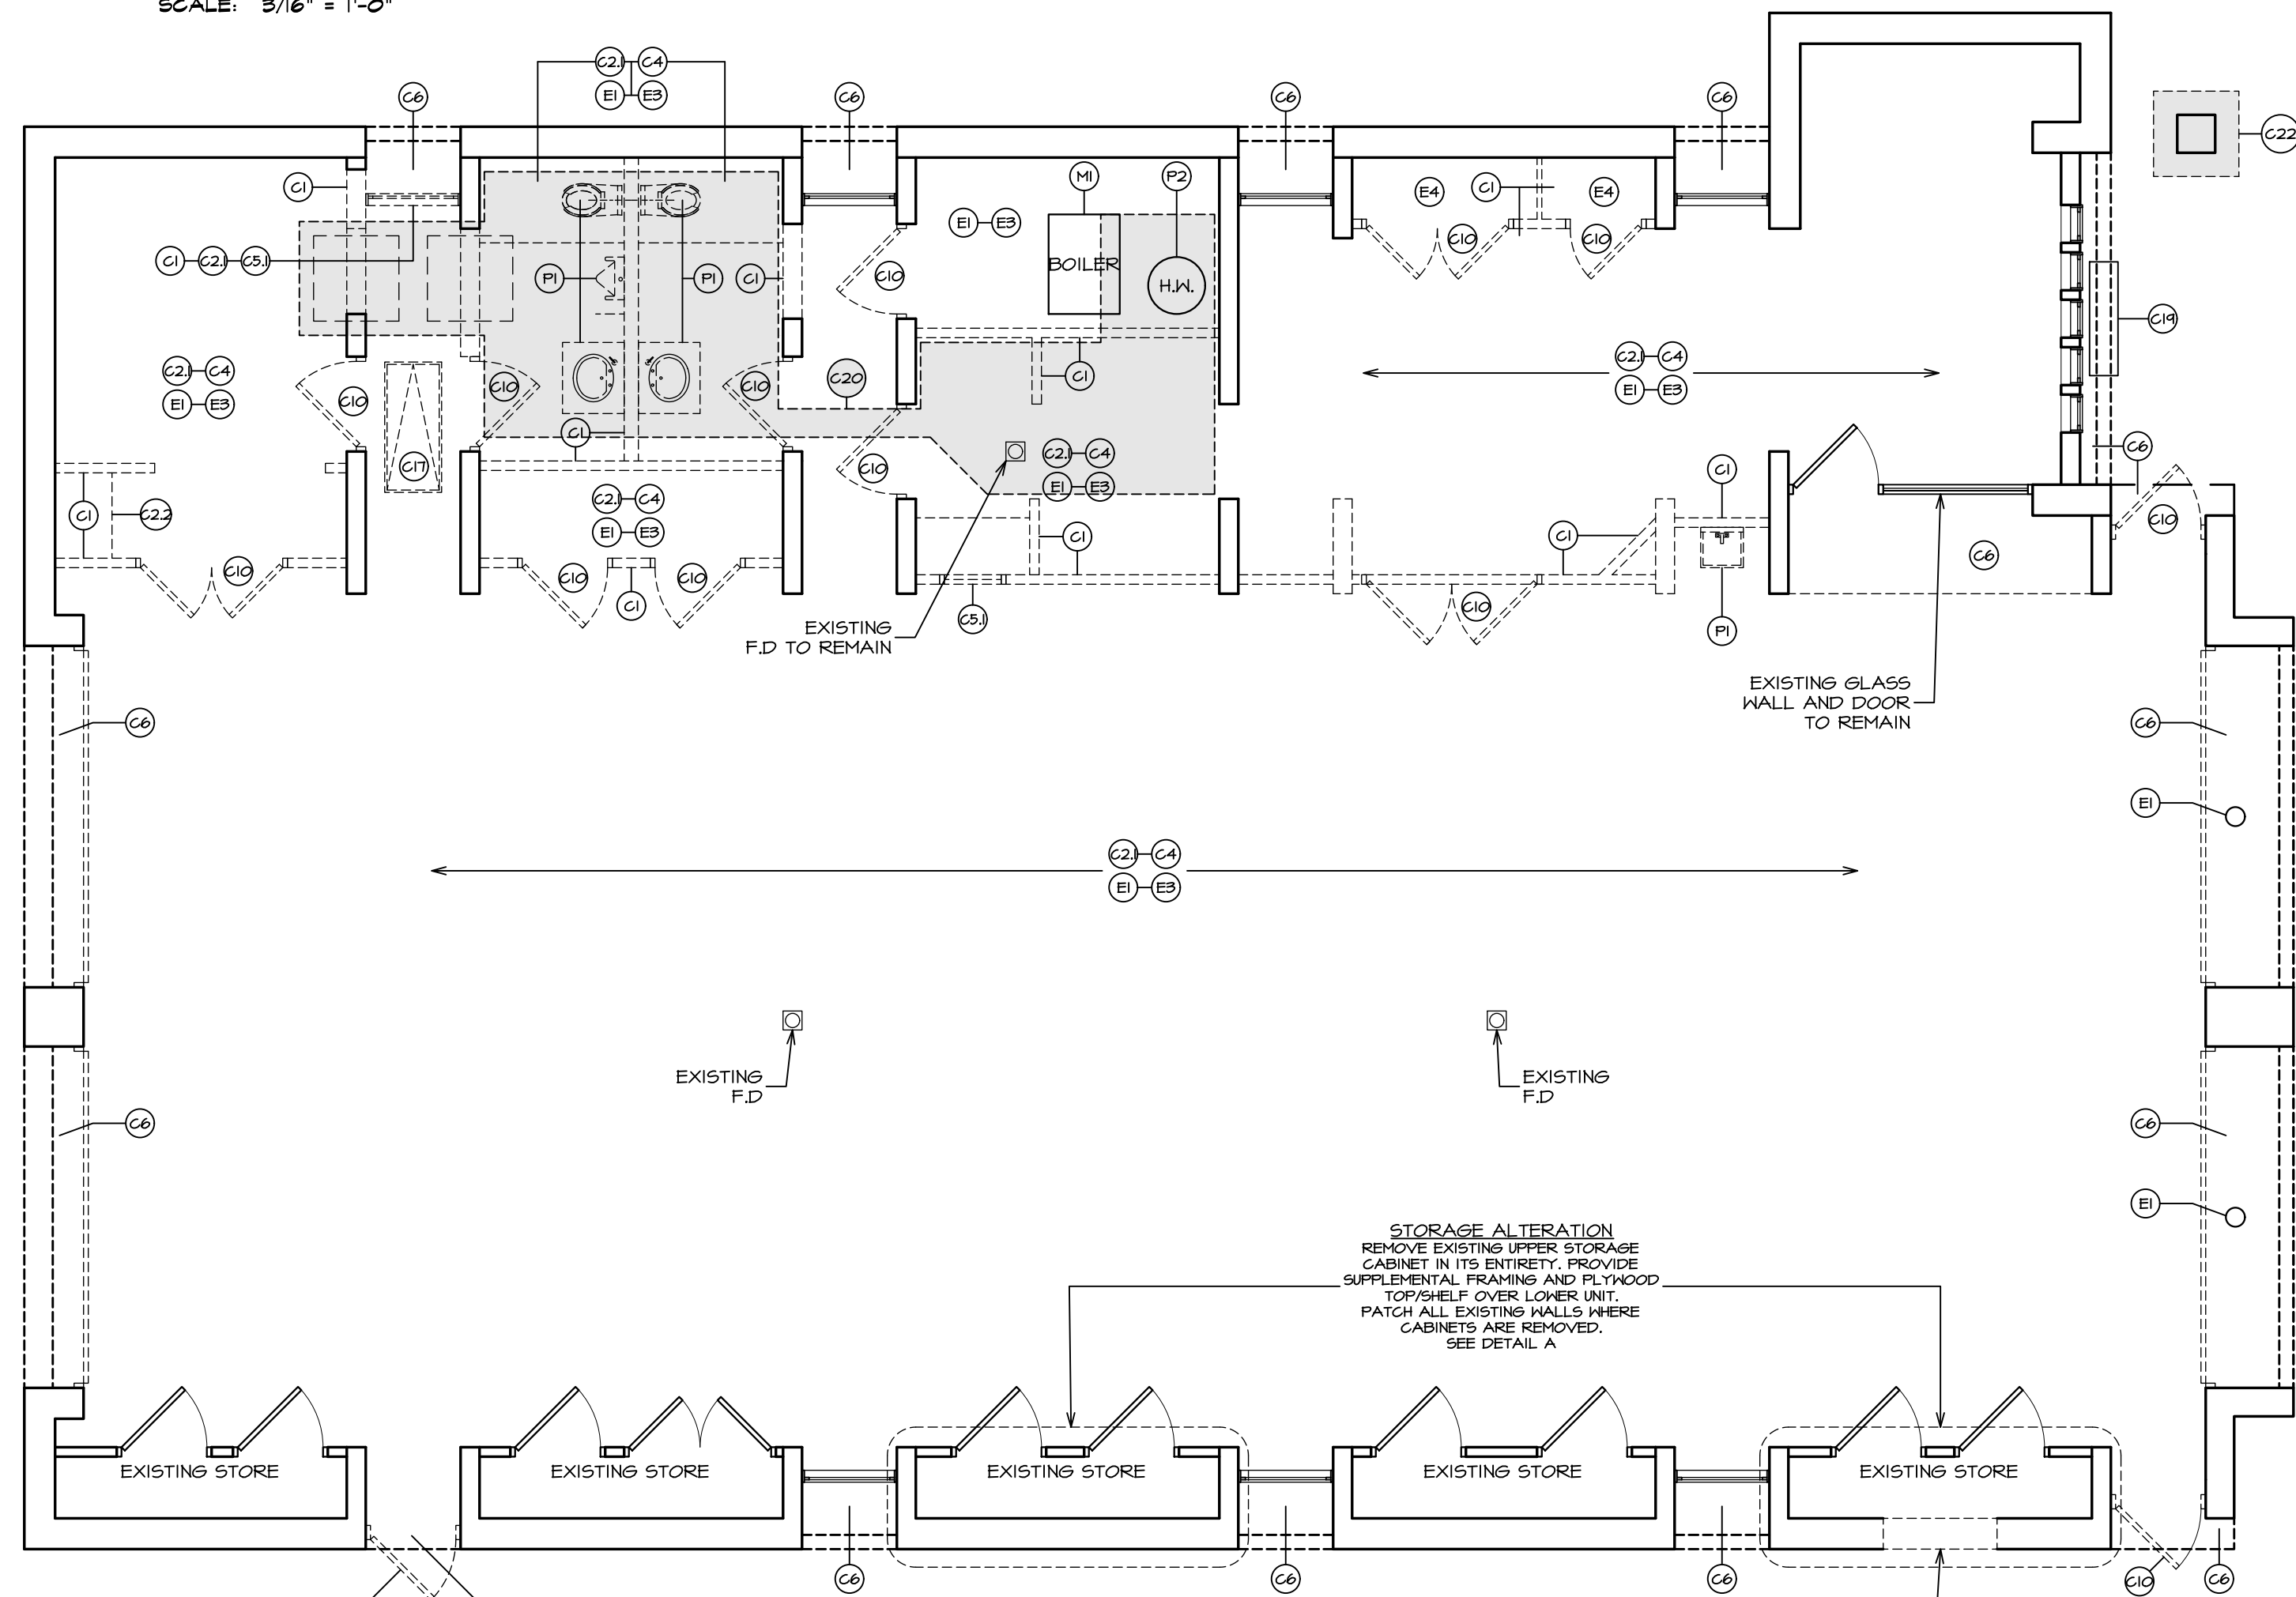

FIRST FLOOR DEMO PLAN (M-4 TYP.)
SCALE: 3/16" = 1'-0"

A STORAGE ALTERATION
SCALE: 3/16" = 1'-0"

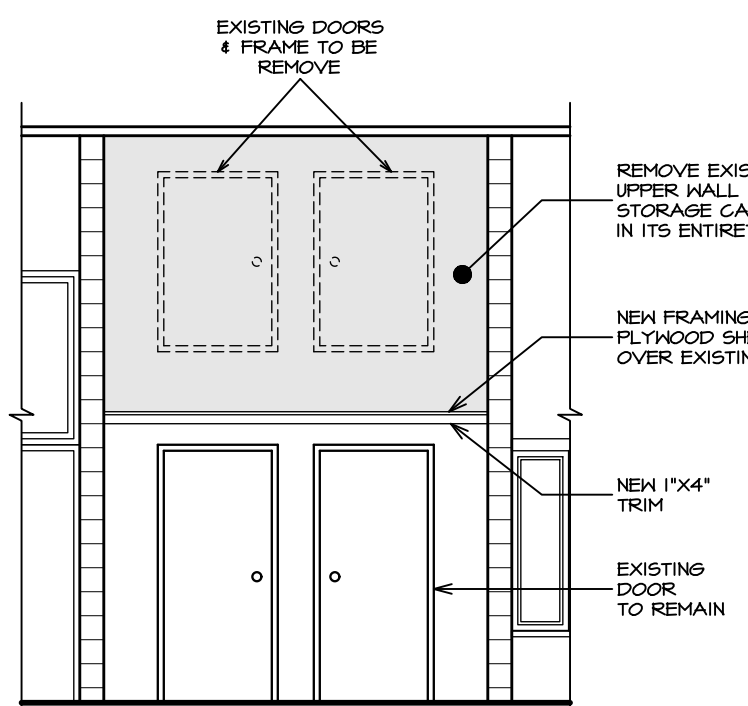

DATE: ISSUE
07-20-2022 ISSUED
FOR BIDDING & PERMIT

SEAL:

SENDEWSKI ARCHITECTS PC
ARCHITECTS - PLANNERS
215 ROANOKE AVENUE
RIVERHEAD, NY 11901
(631) 727-5352
9 SELENA COURT
WALDEN, NY 12586
(845) 275-8859

TAPPAN FIRE DISTRICT
300 WESTERN HIGHWAY SOUTH
TAPPAN, NY 10983
EXISTING DEMOLITION PLAN &
ELEVATIONS & NOTES

PROJECT #: 2108.01B


DRAWN BY: AR/JC

CAD FILE: 2108.01B/P./BID

DRAWING#:

D=1

SUB STATION

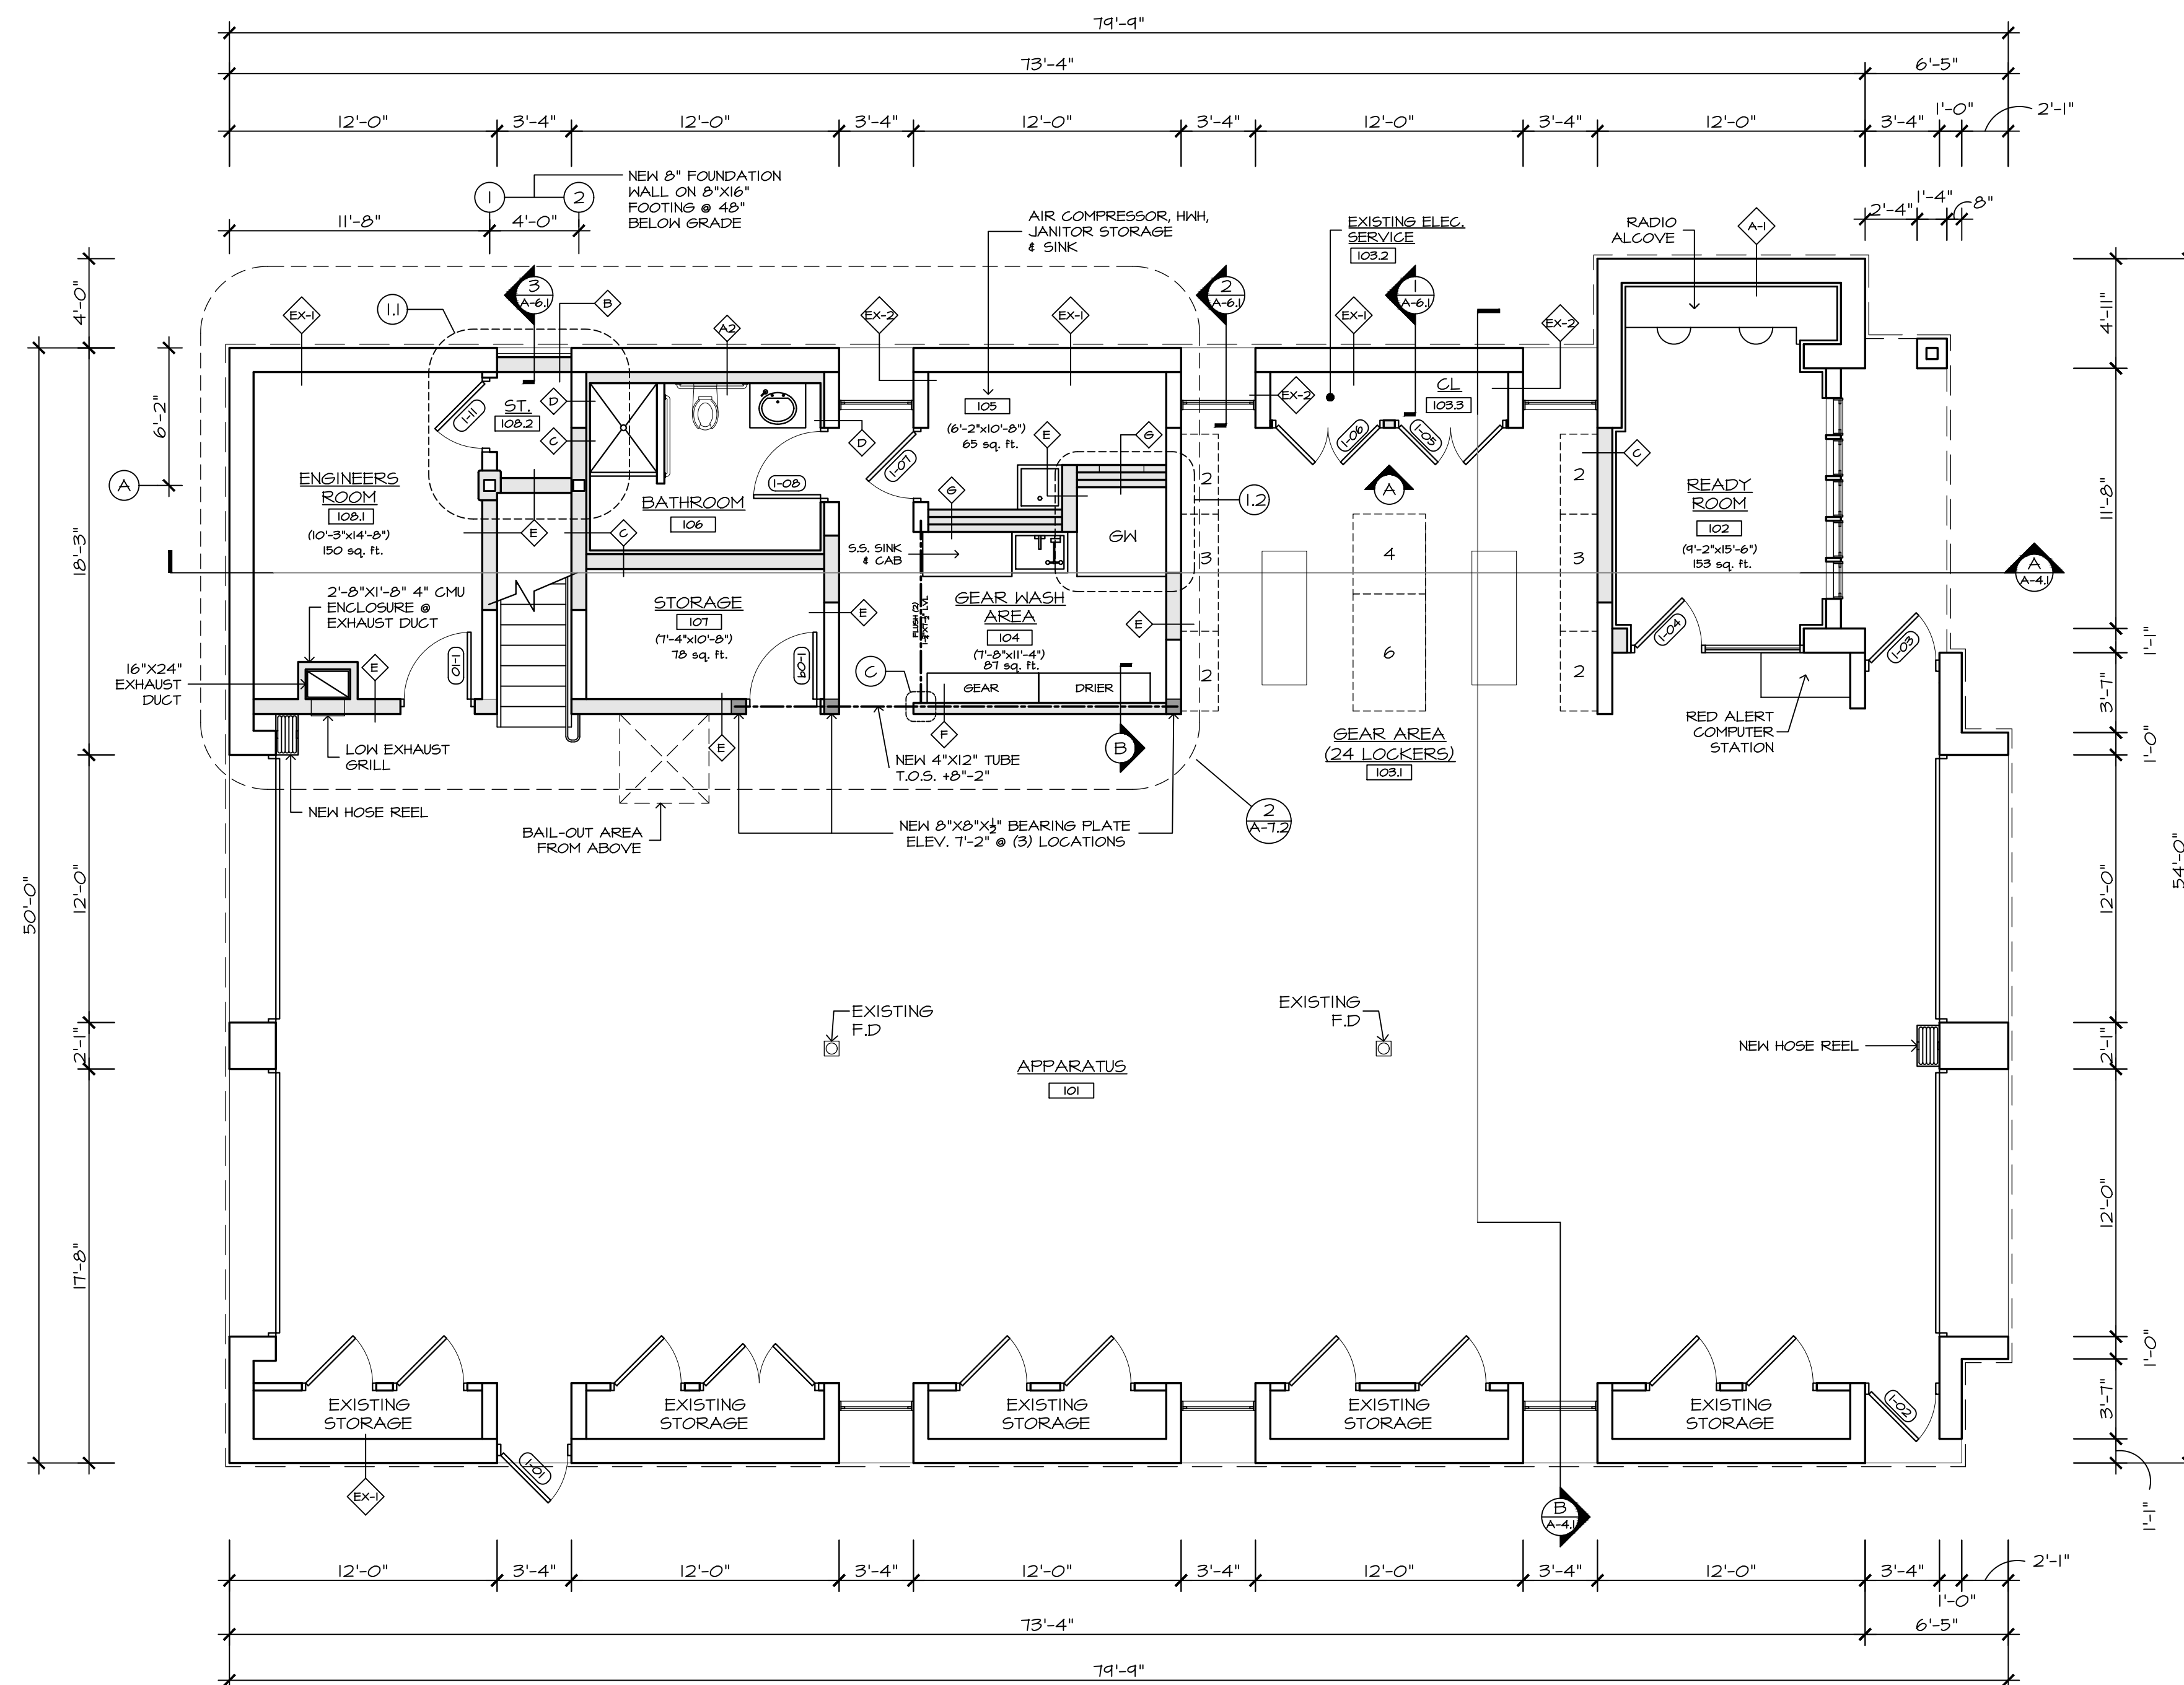


FIRST FLOOR PLAN
SCALE: 3/16" = 1'-0"
3,913 S.F.

WALL TYPES

EX-1	EXISTING 8" CMU W/ 1" CAVITY & 4" MASONRY	B	NEW 8" CMU W/ 2" EIFS SYSTEM	F	NEW 6" CMU W/ PAINTED FINISH 48" HIGH
EX-2	EXISTING 4" CMU W/ 4" MASONRY	C	NEW 8" CMU W/ 2" FURRING & 3/8" GYP. BD.	G	(2) 4" CMU WALL W/ 4" AIR CAVITY W/ PAINT FINISH
A1	EXISTING 8" CMU W/ 1" CAVITY & 4" MASONRY ADD 2" FURRING W/ 3/8" GYP. BD.	D	EXISTING 4" CMU W/ 4" MASONRY & NEW 2" FURRING & 3/8" GYP. BD.	H	4" STUD WALL @ 16 O.C. & BATT. INSULATION W/ 3/8" GYP. BD.
A2	EXISTING 8" CMU W/ 1" CAVITY & 4" MASONRY ADD 6" FRAMING INSIDE 2" RIGID INSULATION @ EXISTING CMU. W/ 3/8" GYP. BD.	E	NEW 8" CMU W/ PAINTED FINISH	J	8" STUD WALL @ 16 O.C. & BATT. INSULATION W/ 3/8" GYP. BD.



LV L CONNECTION DETAIL
SCALE: 3/8" = 1'-0"

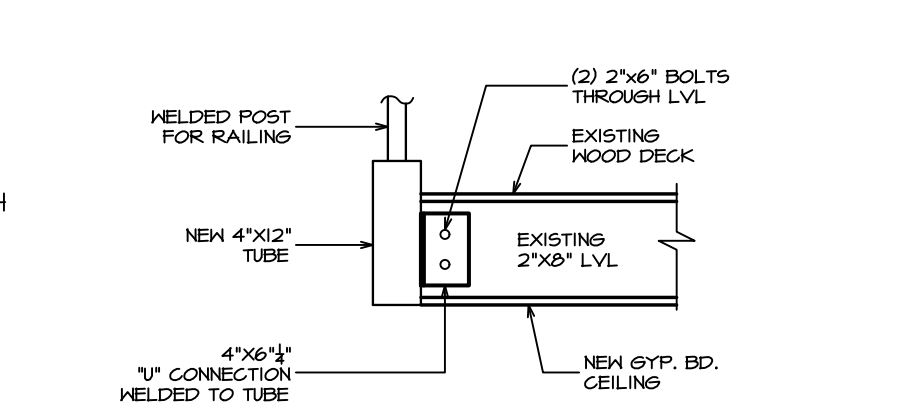


RAILING TUBE DETAIL
SCALE: 3/8" = 1'-0"

QUANTITY	SERIES	SIZE
1	FREE STANDING CASTER	6 PACK LOCKERS
1	FREE STANDING CASTER	4 PACK LOCKERS
2	STANDARD WALL MOUNT	3 PACK LOCKERS
4	STANDARD WALL MOUNT	2 PACK LOCKERS

* GC TO PROVIDE & INSTALL GEAR GRID LOCKERS
NOTE:
1. ALL LOCKERS TO HAVE STANDARD POWER BAR
2. COLOR TO BE SELECTED BY OWNER.

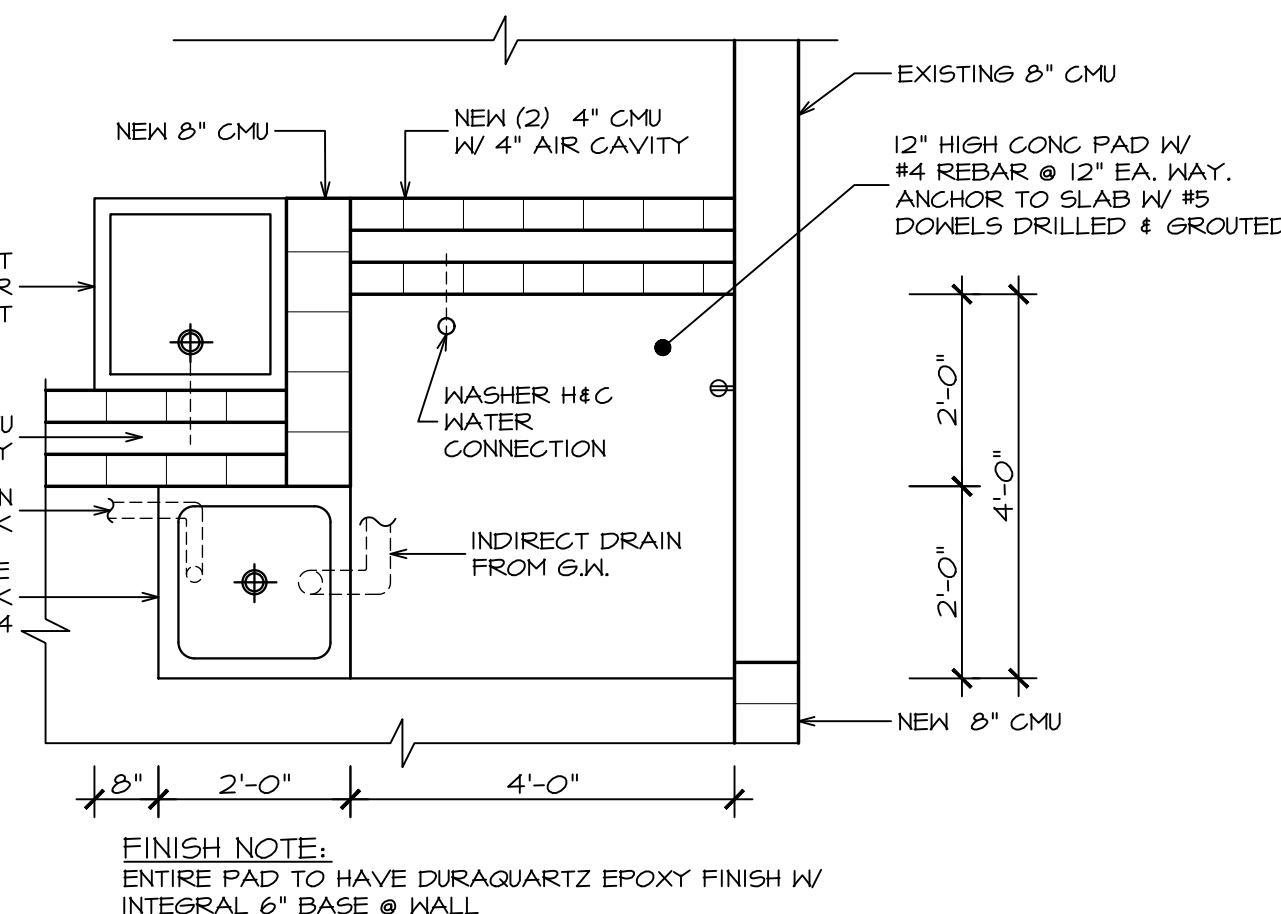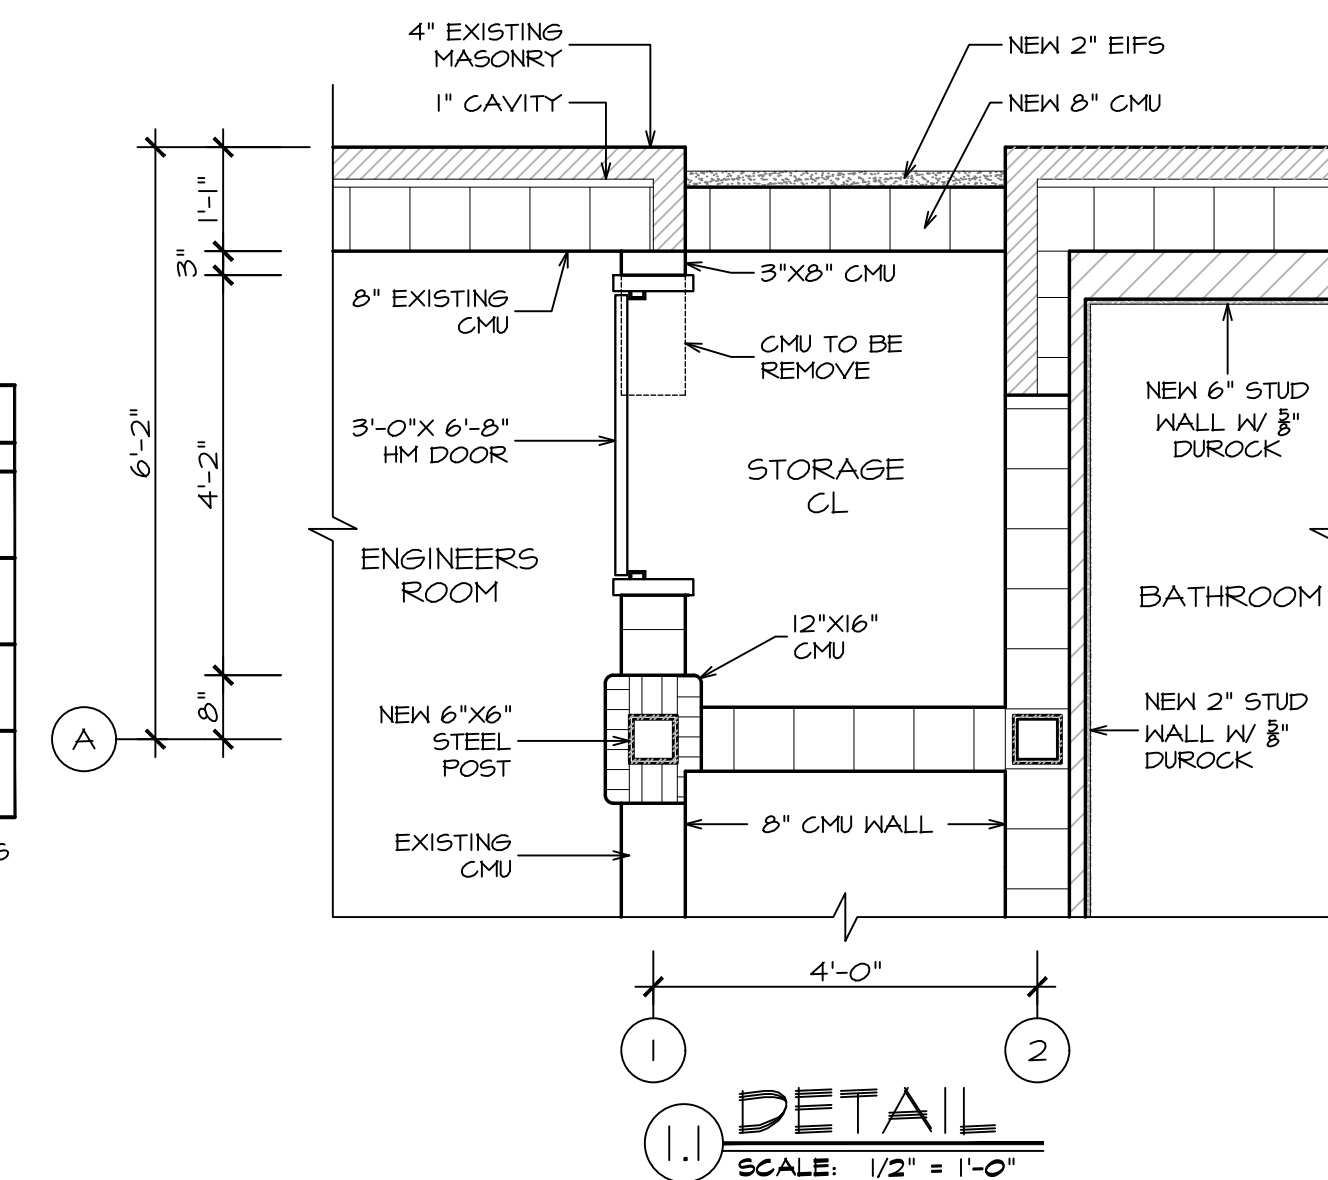

GEAR WASH PLAN
SCALE: 1/2" = 1'-0"

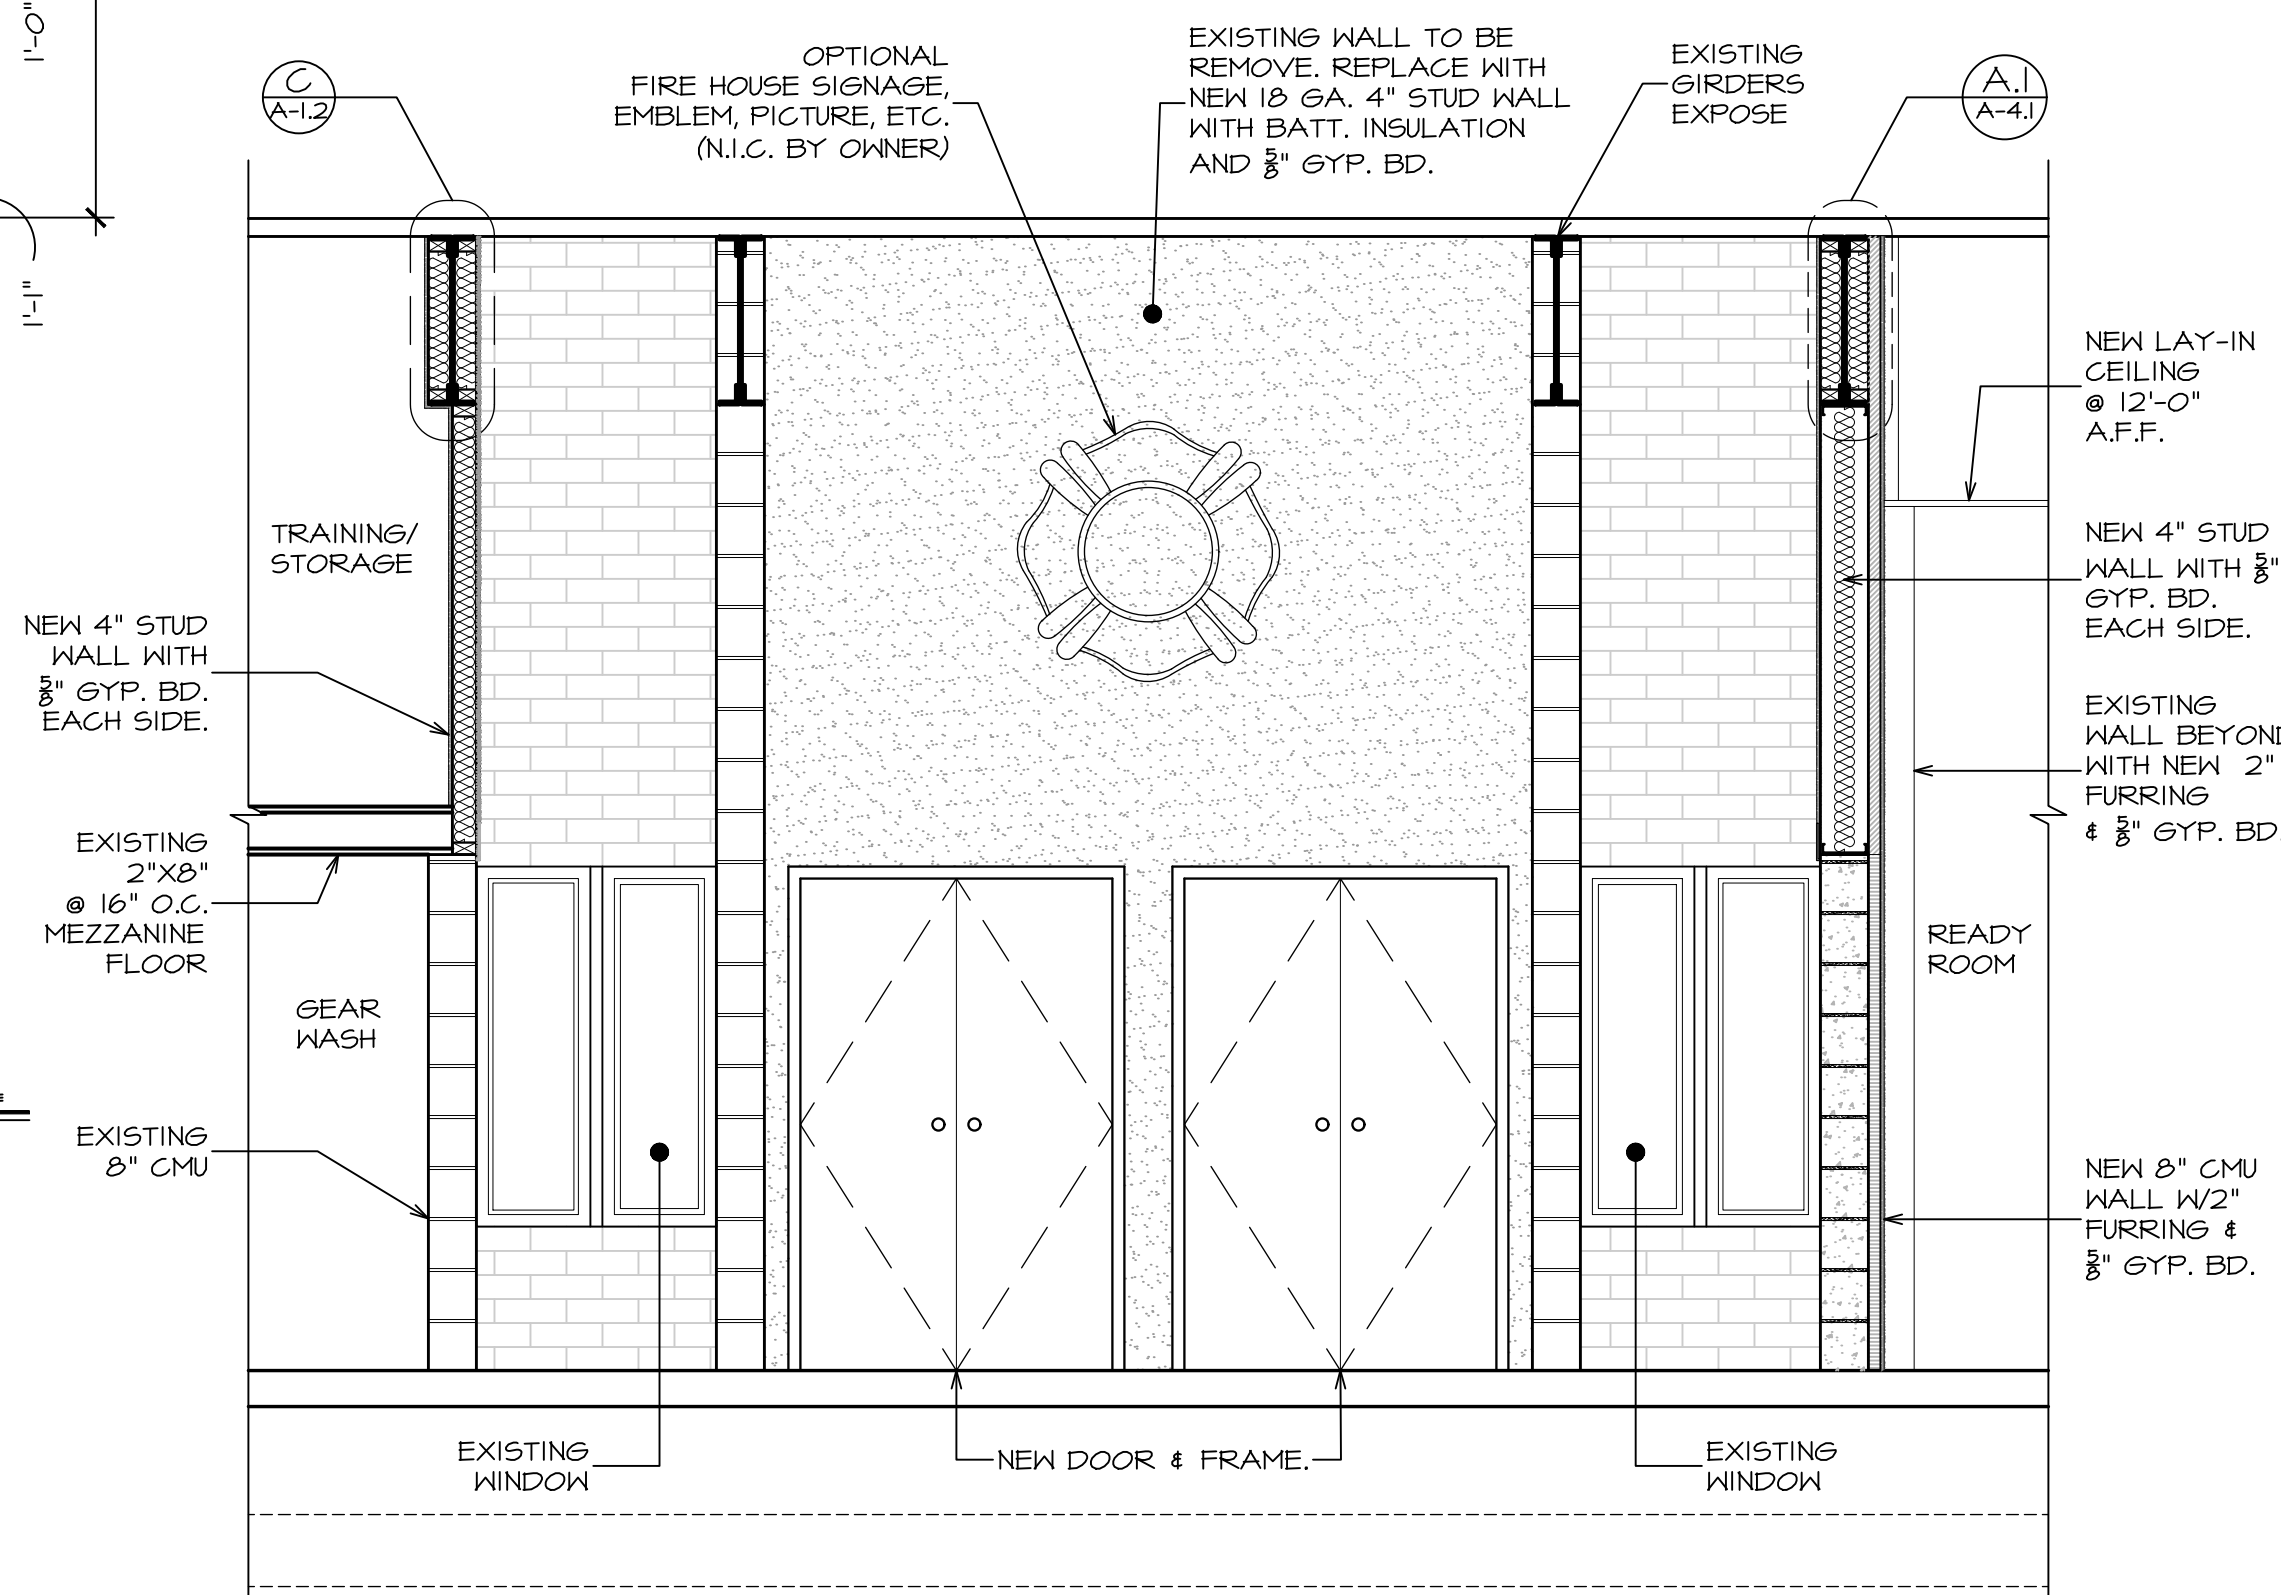

ELEVATION AT GEAR LOCKER
SCALE: 3/8" = 1'-0"

DATE: ISSUE
07-20-2022 ISSUED
FOR BIDDING & PERMIT

SEAL:

SENDEWSKI ARCHITECTS PC
ARCHITECTS - PLANNERS
215 ROANOKE AVENUE
RIVERHEAD, NY 11901
(631) 727-5352
9 SELENA COURT
WALDEN, NY 12586
(845) 275-8859

TAPPAN FIRE DISTRICT
300 WESTERN HIGHWAY SOUTH
TAPPAN, NY 10983

FIRST FLOOR PLAN
& DETAILS

PROJECT #: 2108.01B




DRAWN BY: AR/JC

CAD FILE: 2108.01B/P./BID


DRAWING#:

A=1.1


SUB STATION

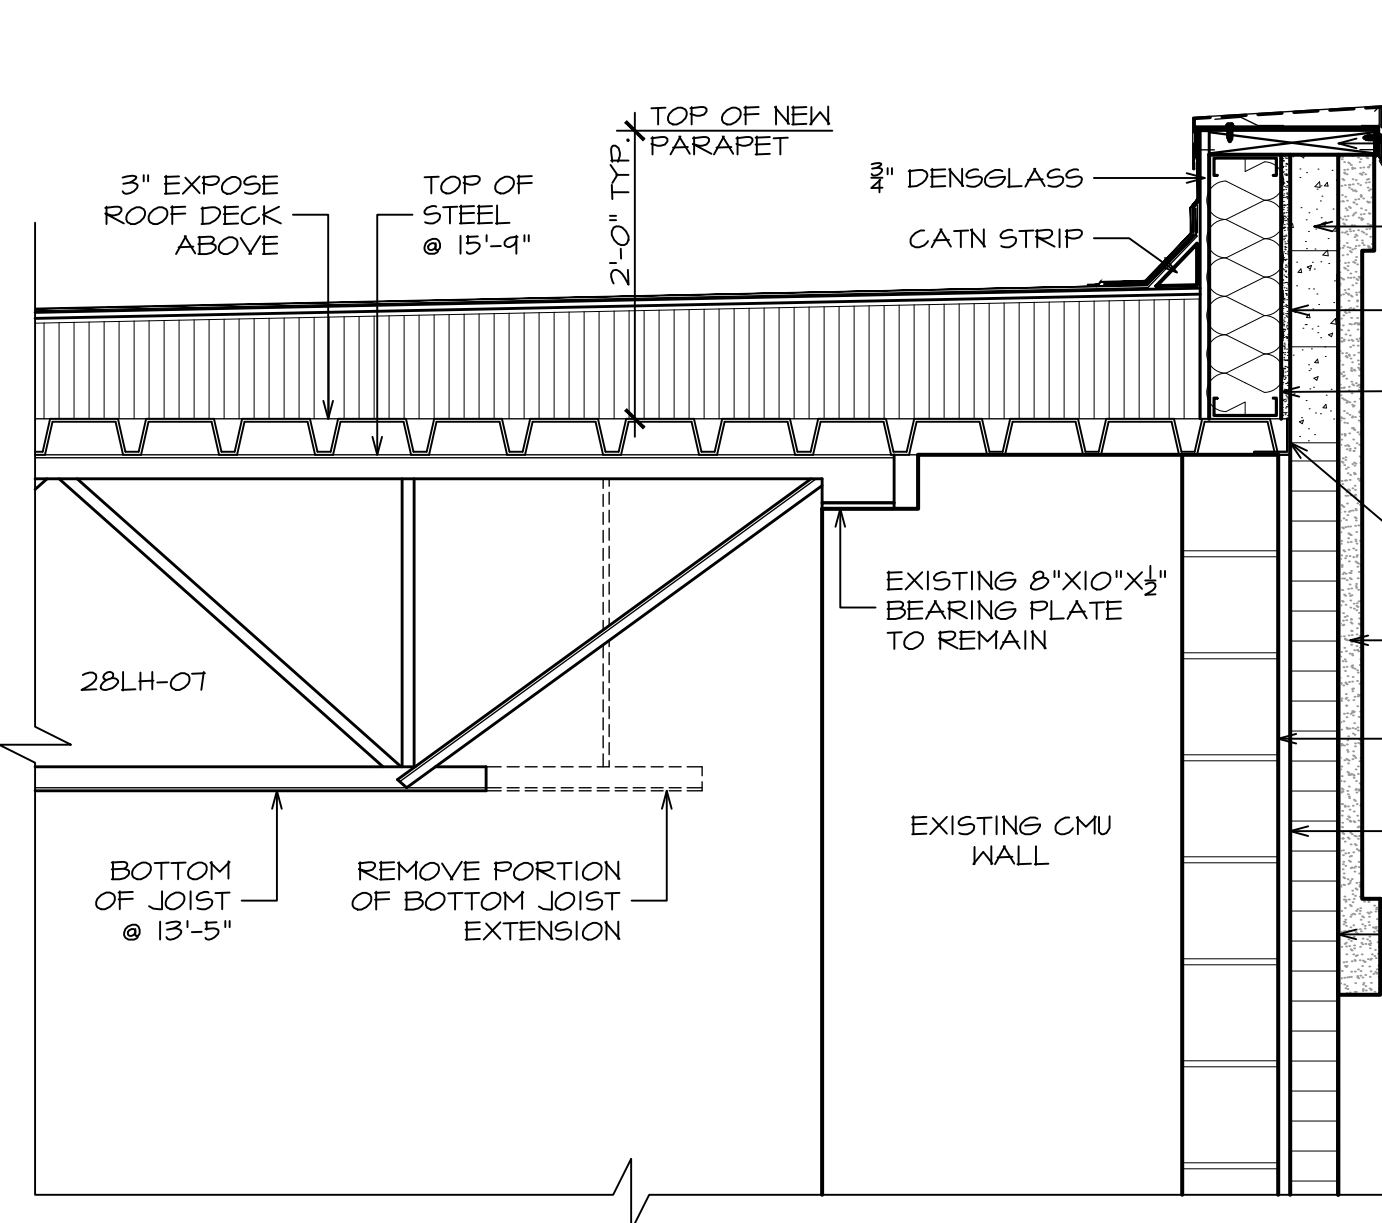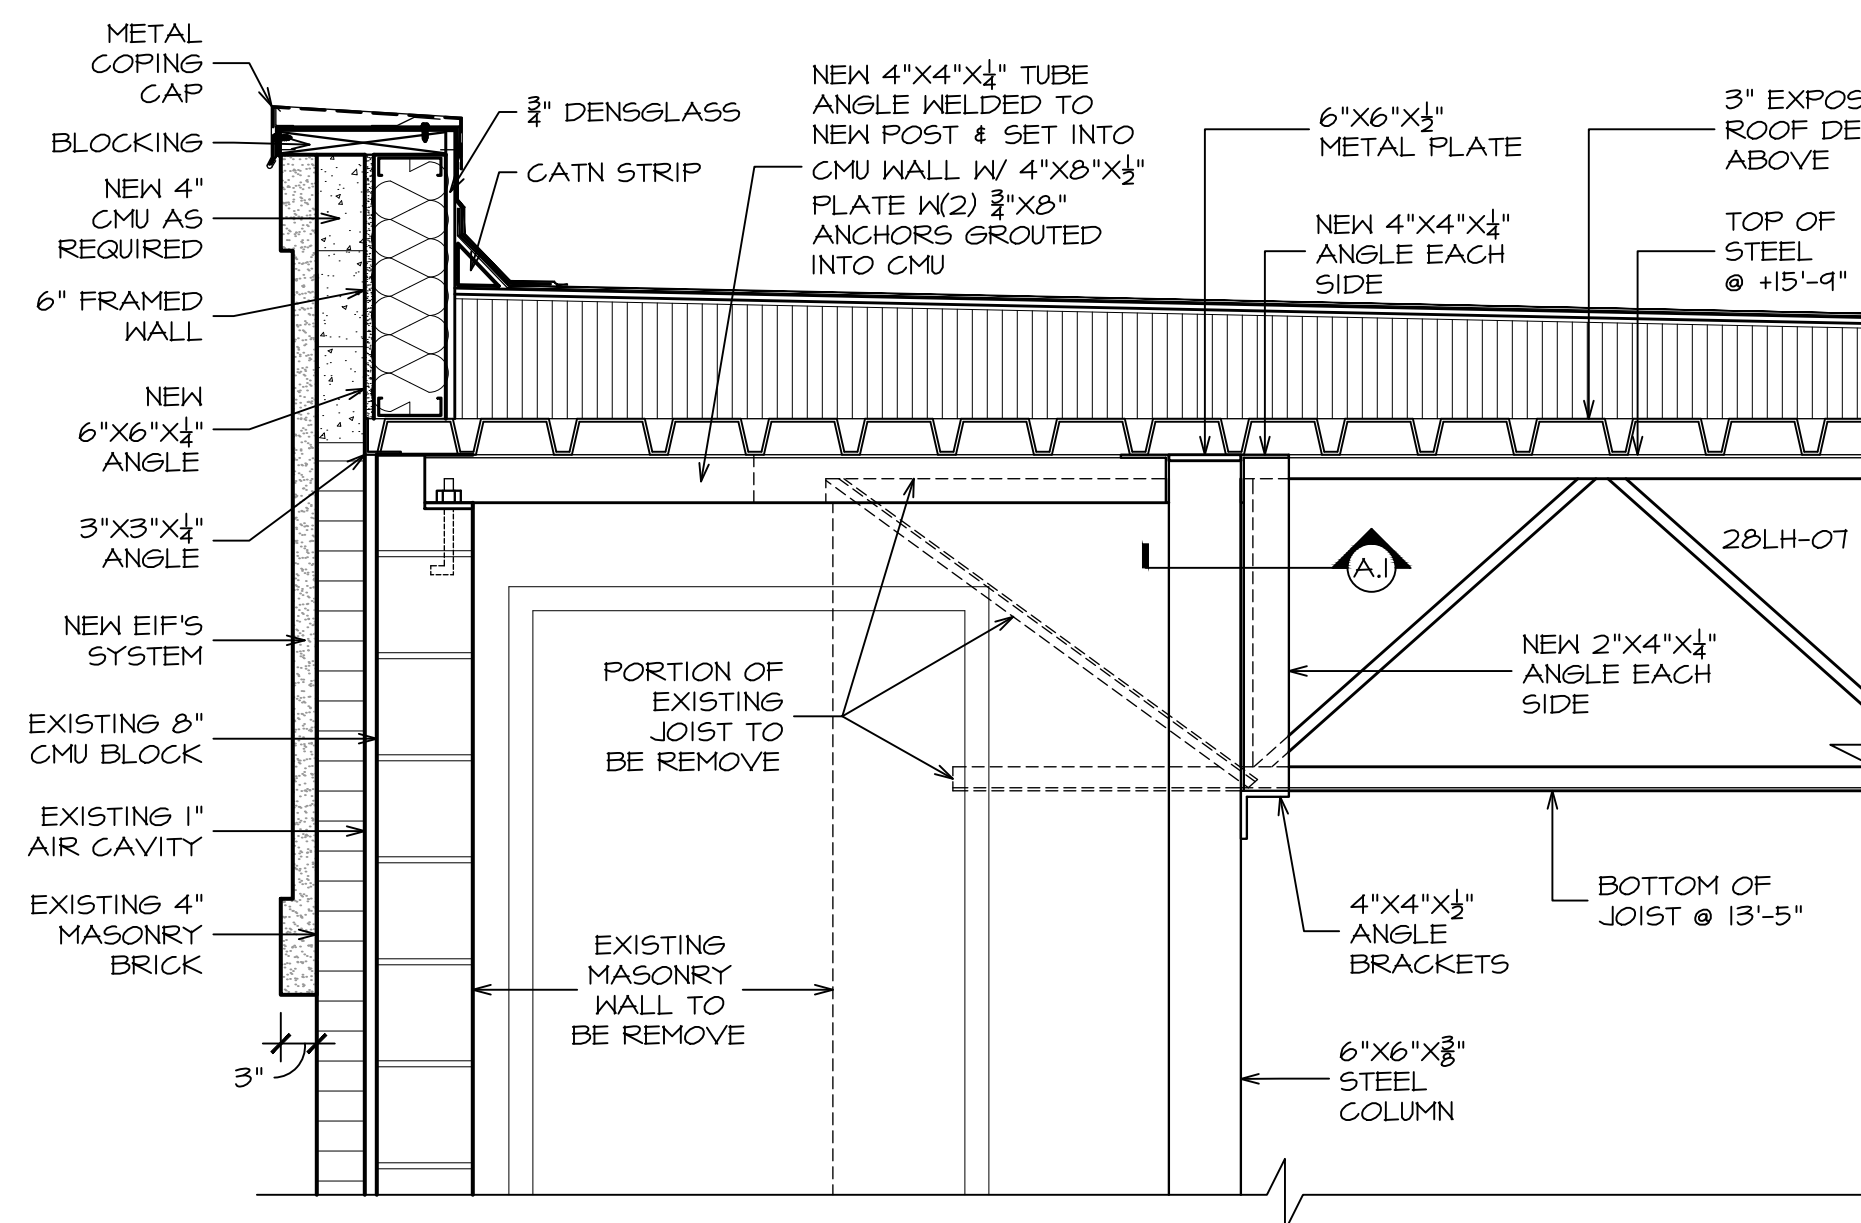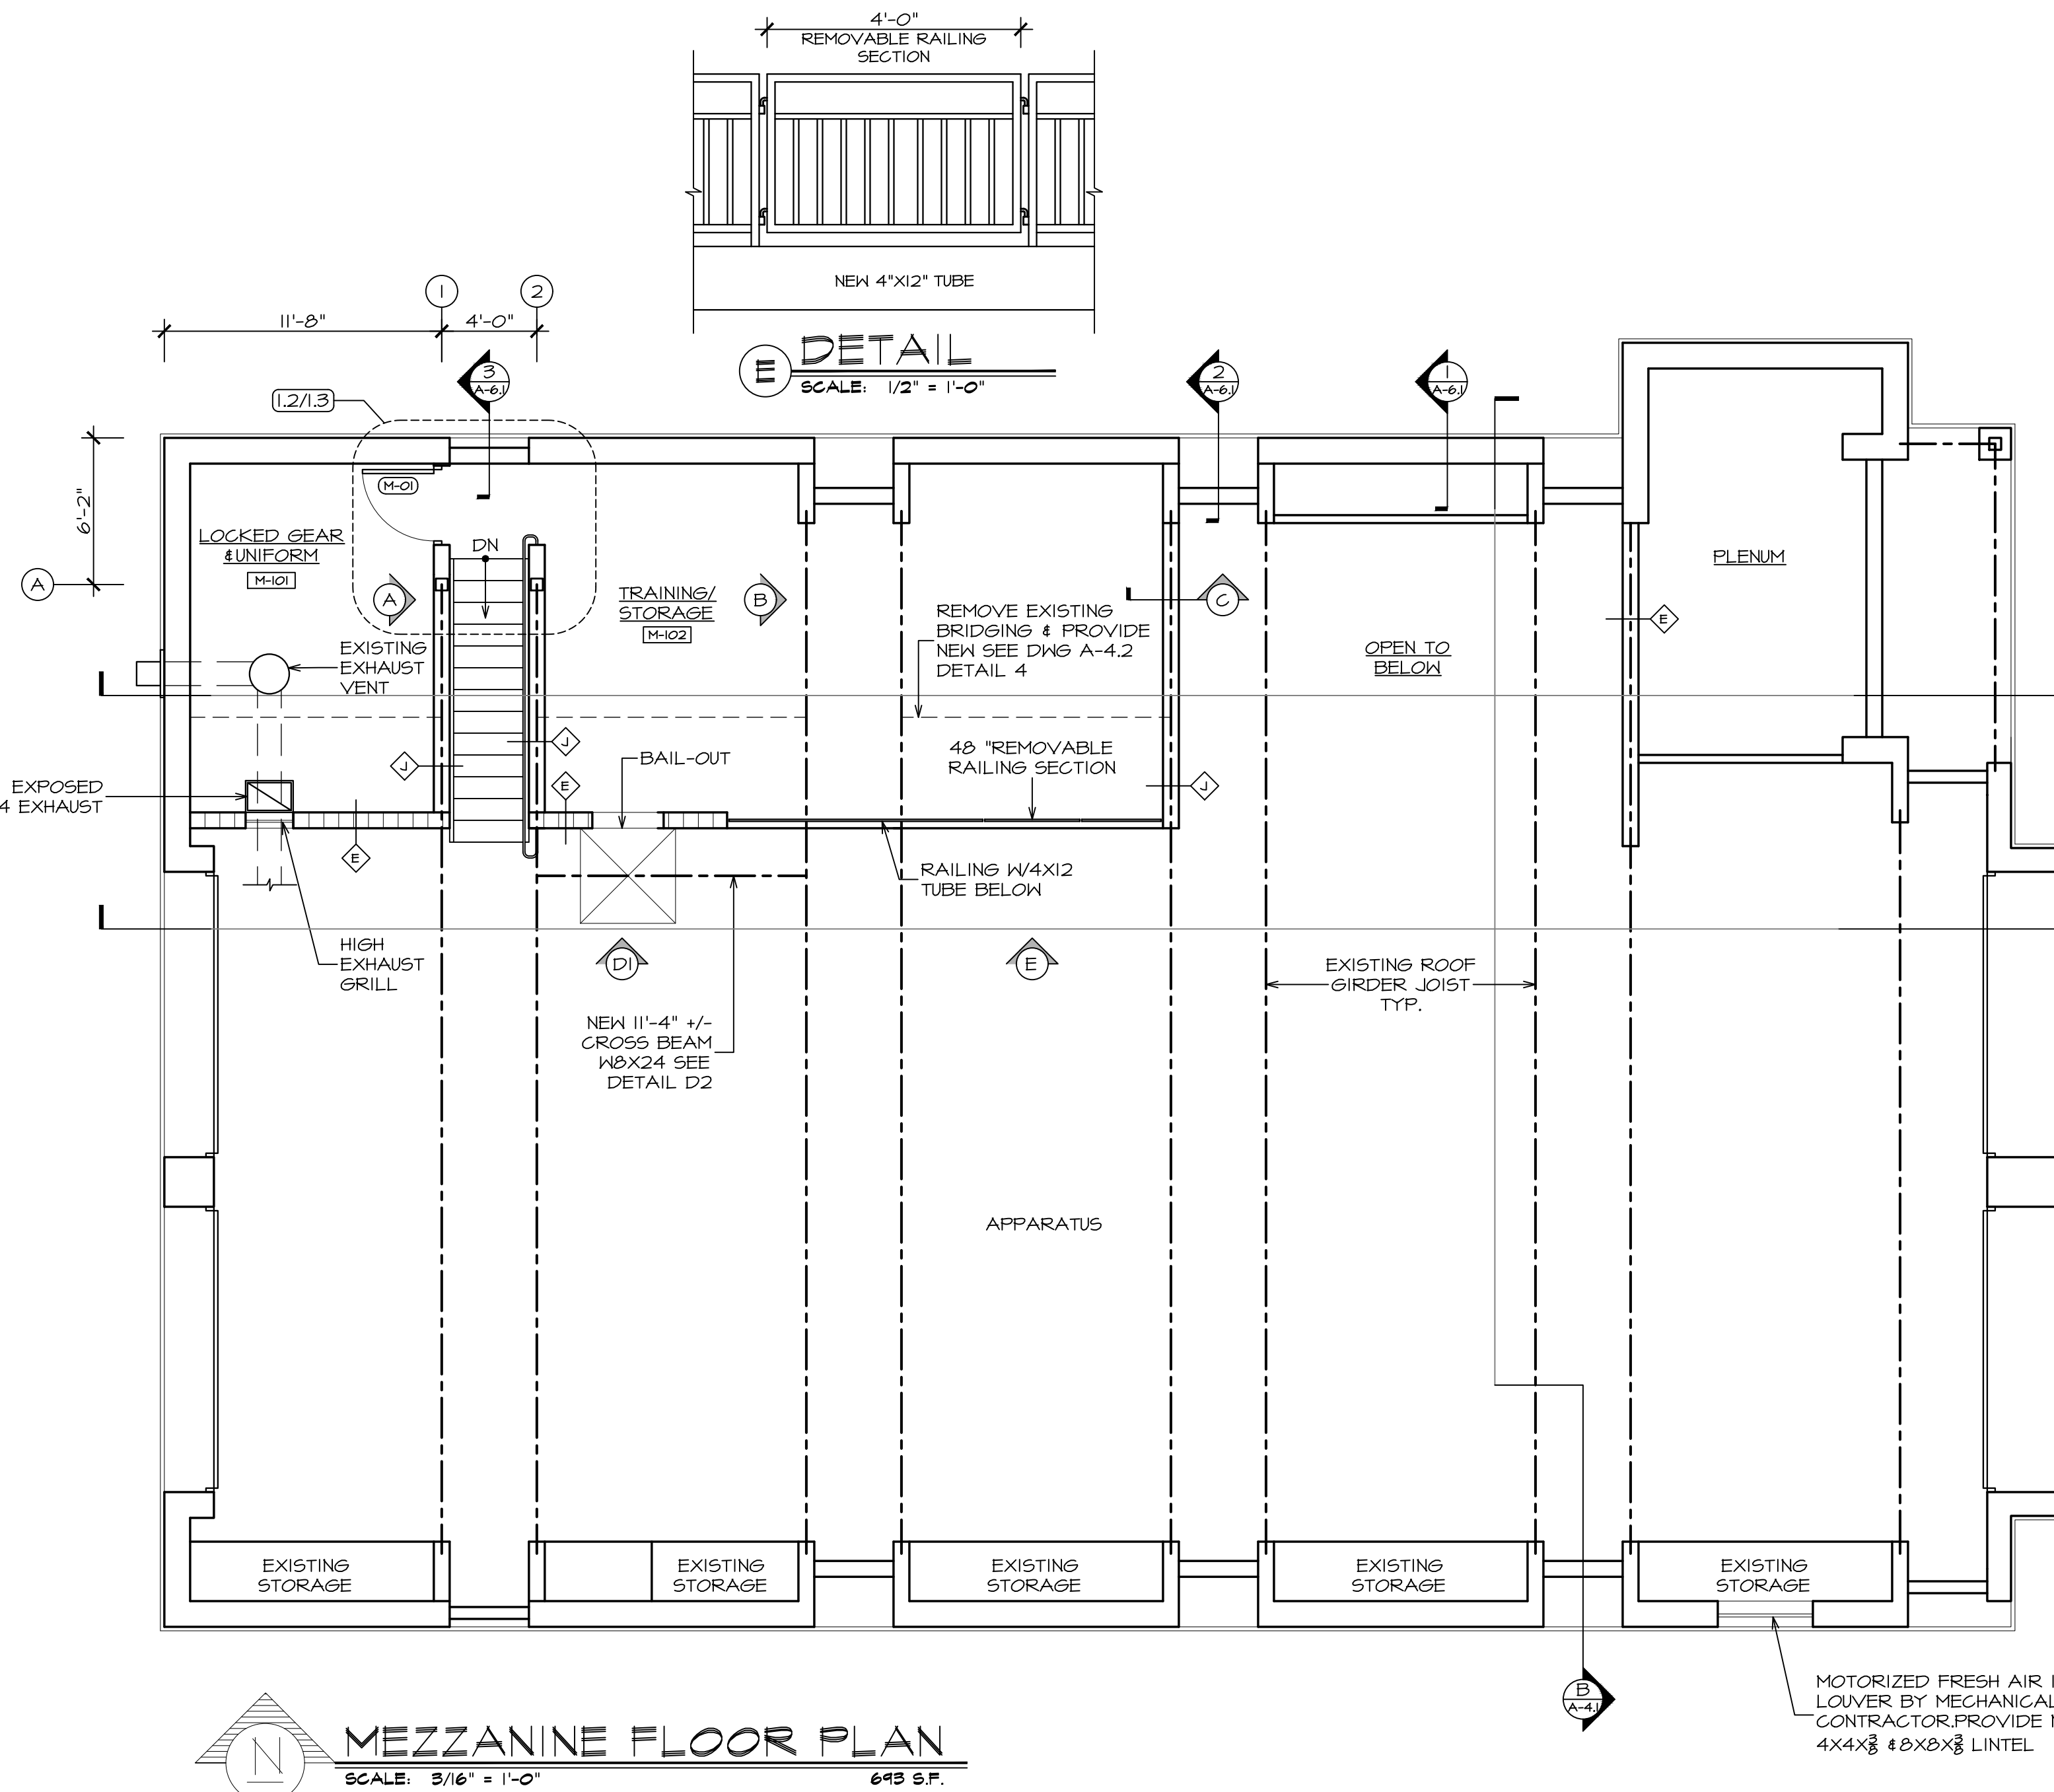


A. JOIST DETAIL
SCALE: 1-1/2" = 1'-0"

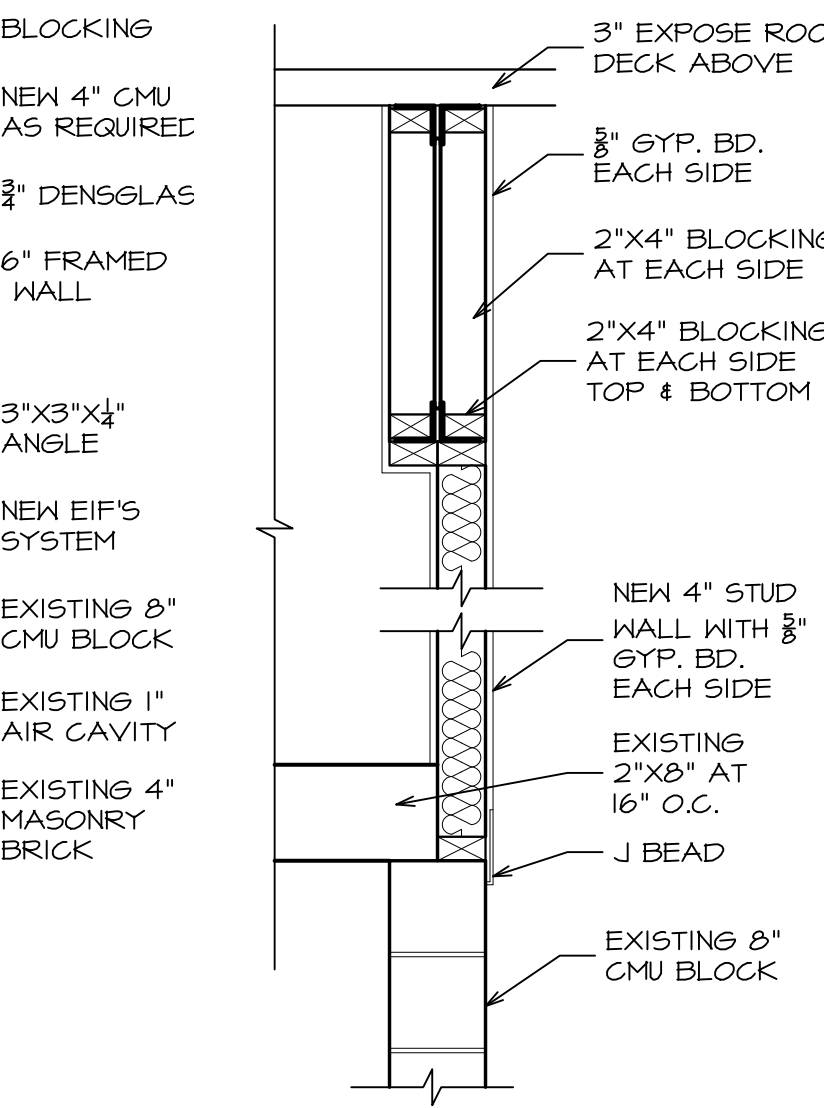


C. JOIST DETAIL
SCALE: 3/4" = 1'-0"

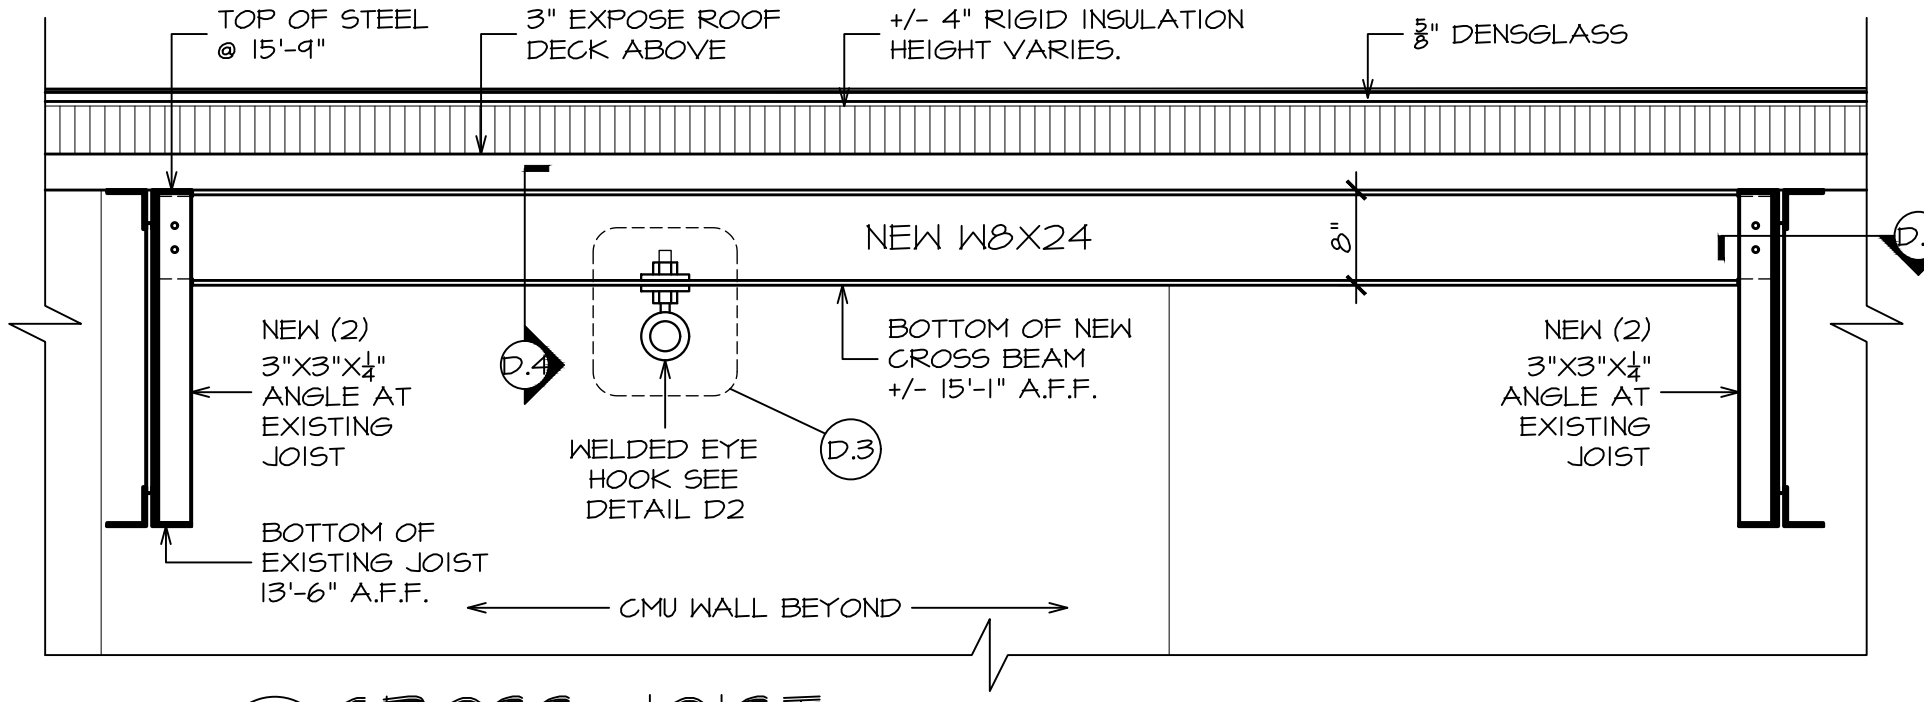


D.2 CROSS JOIST
SCALE: 3/4" = 1'-0"

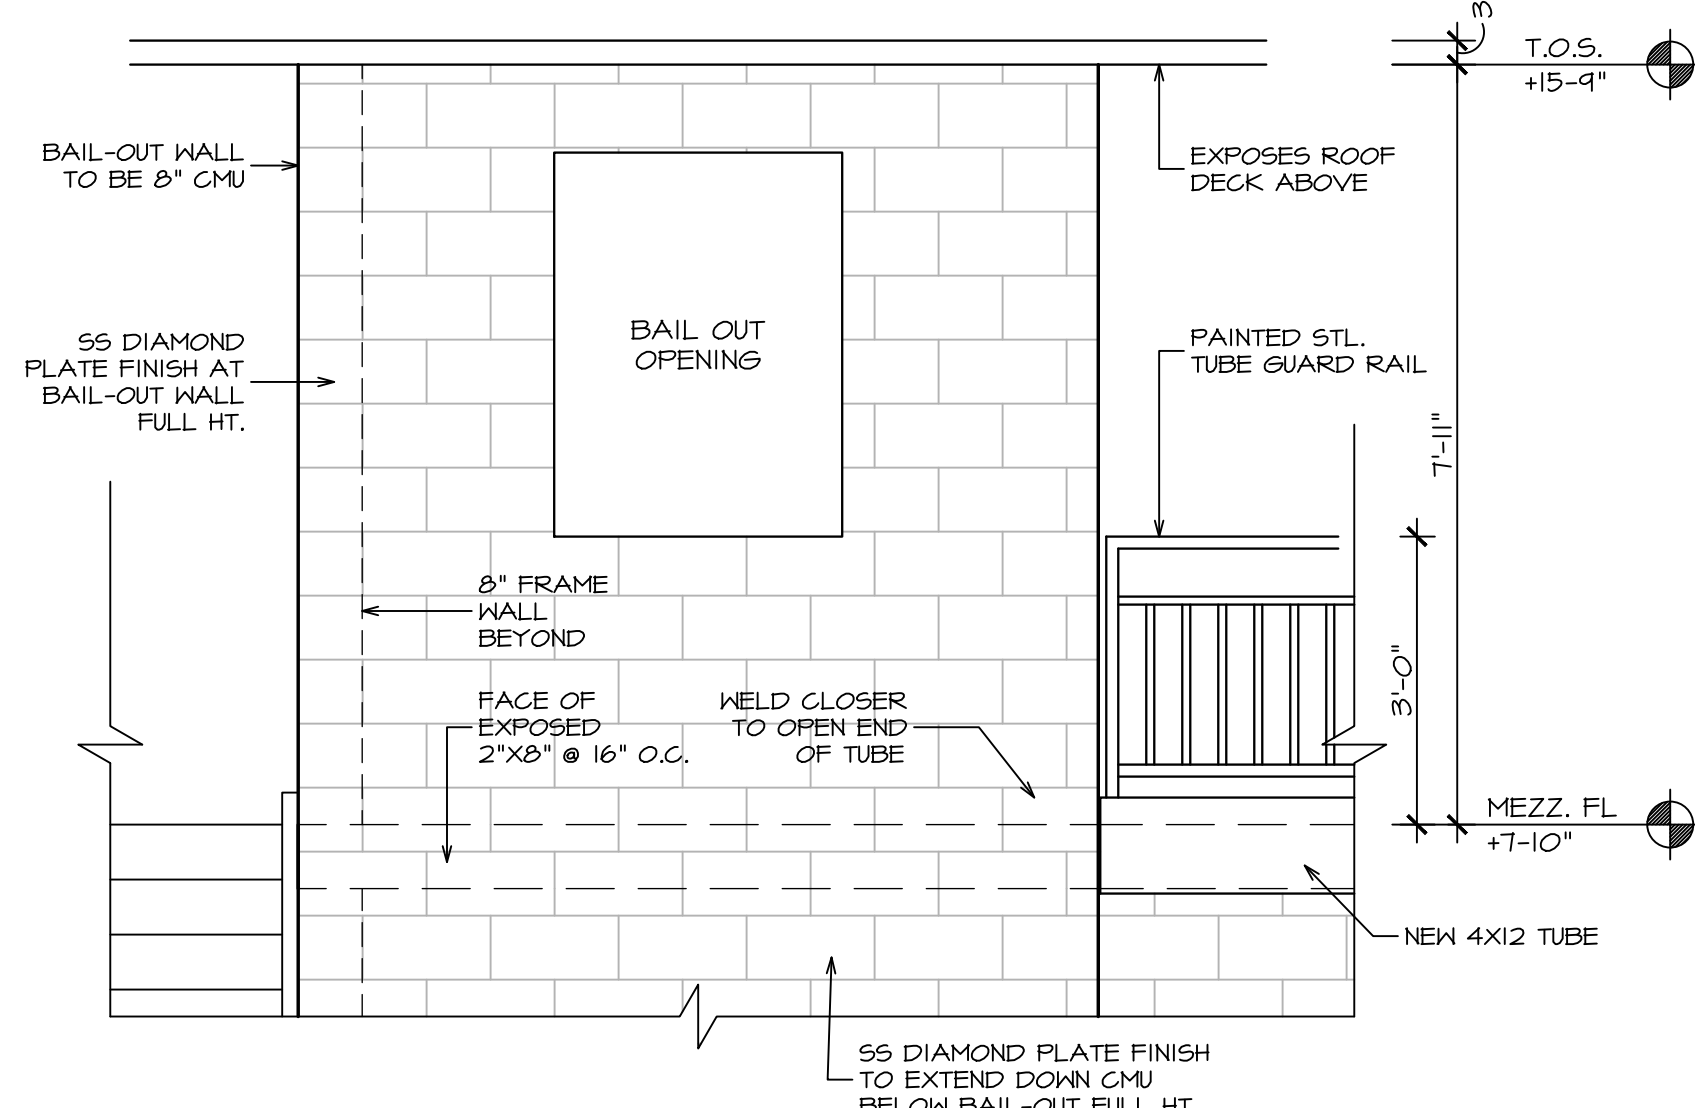


D. BAIL-OUT
SCALE: 1/2" = 1'-0"

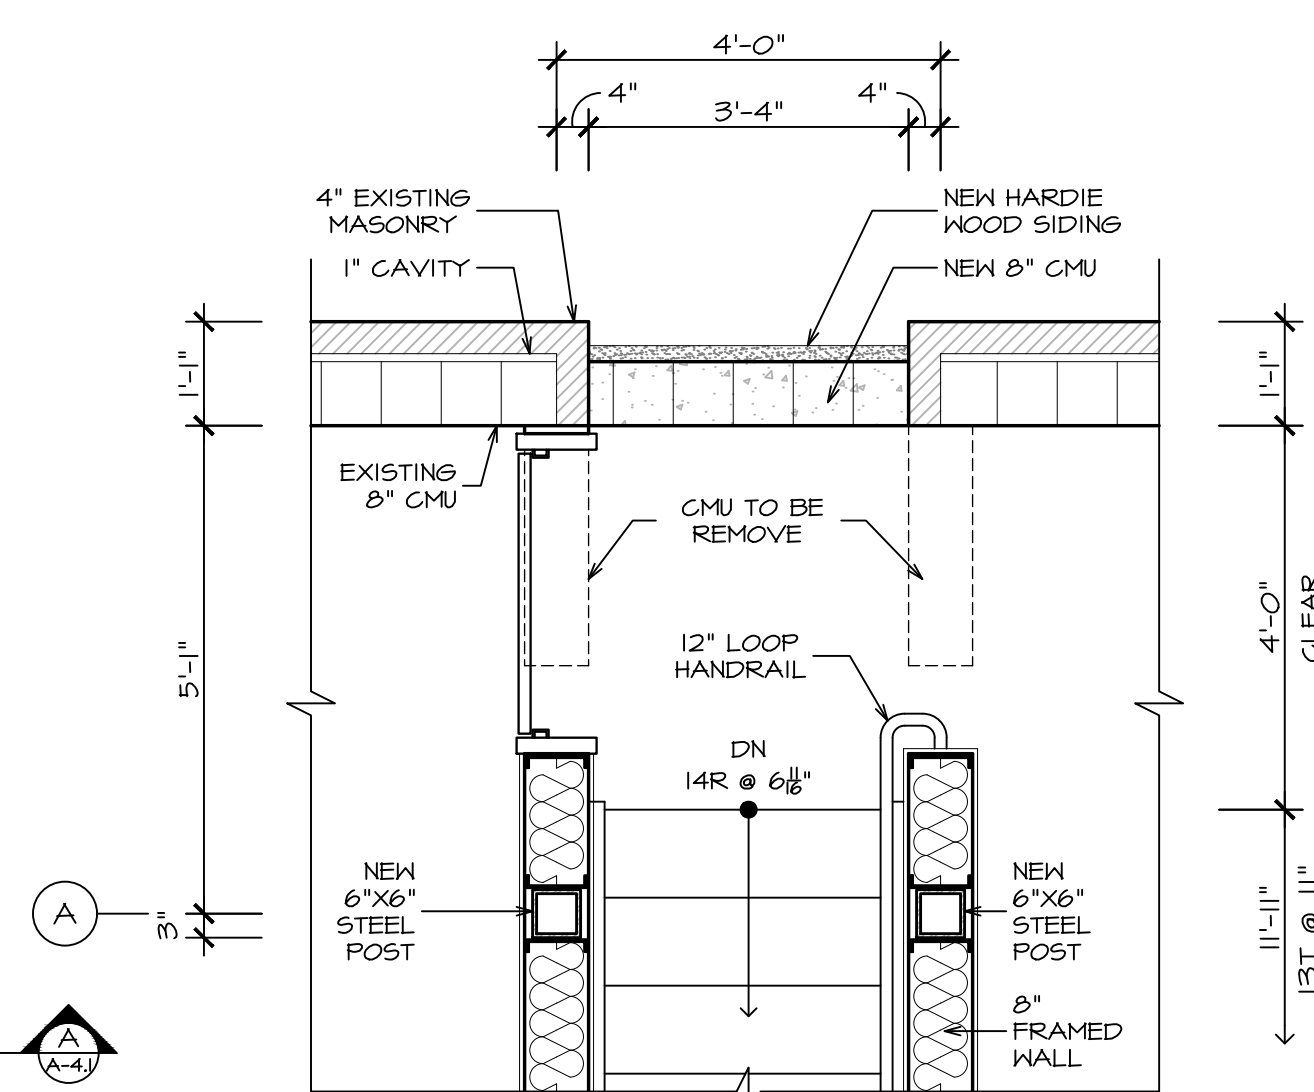


DETAIL 2
SCALE: 1/2" = 1'-0"

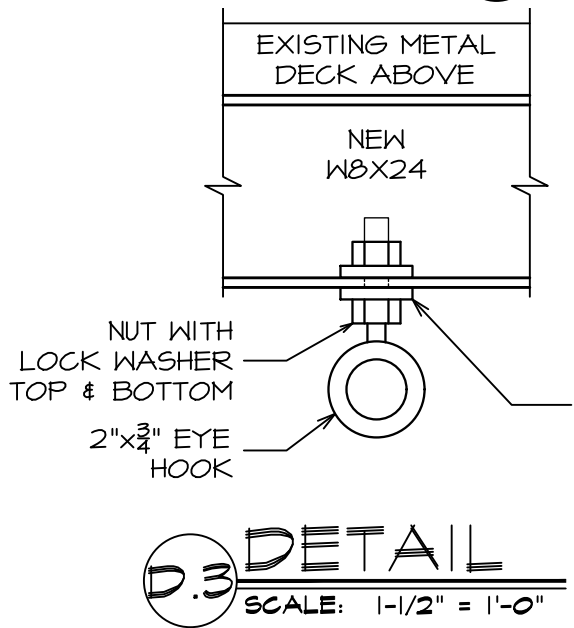


DETAIL 3
SCALE: 1-1/2" = 1'-0"

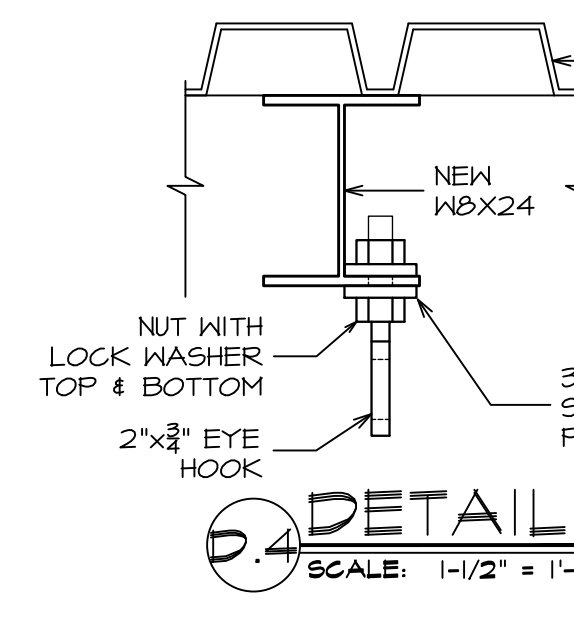

DETAIL 4
SCALE: 1-1/2" = 1'-0"

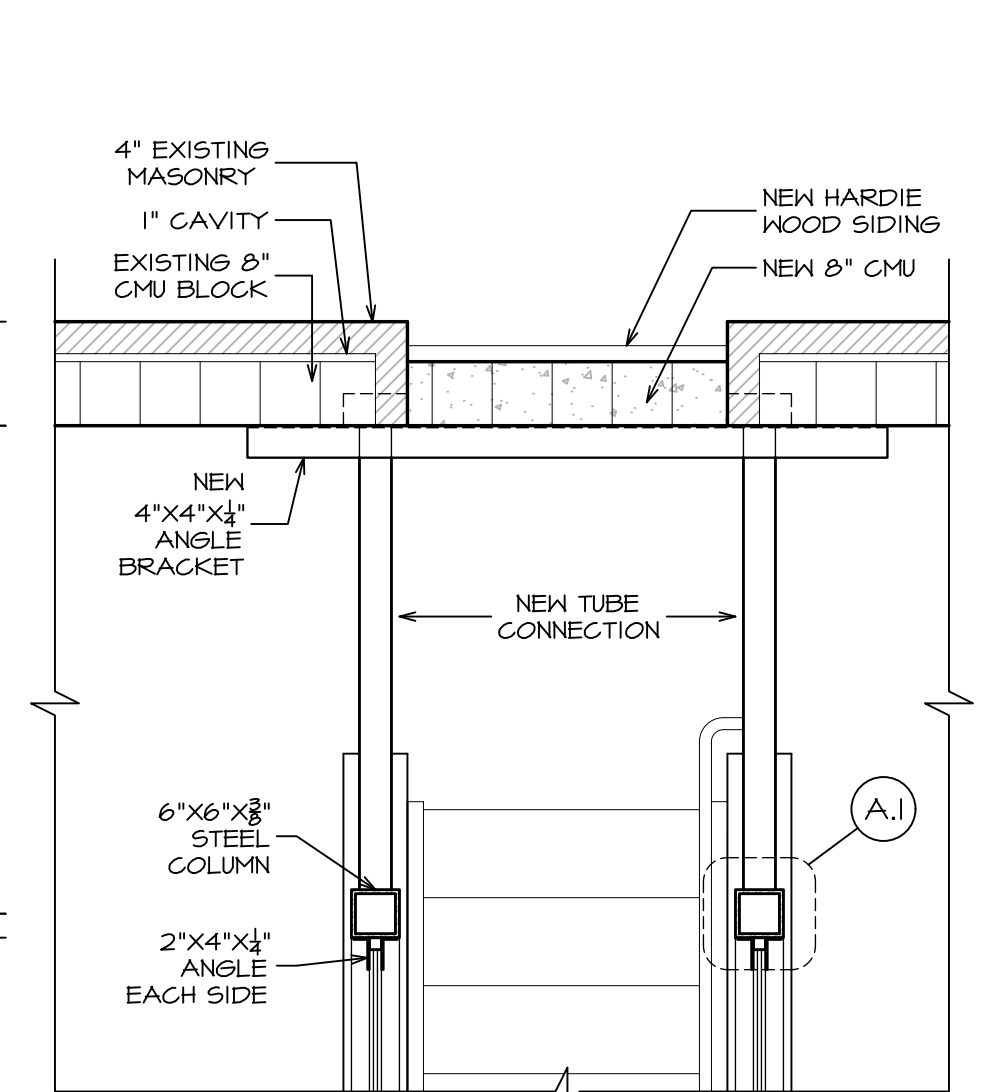

DETAIL 3
SCALE: 1/2" = 1'-0"

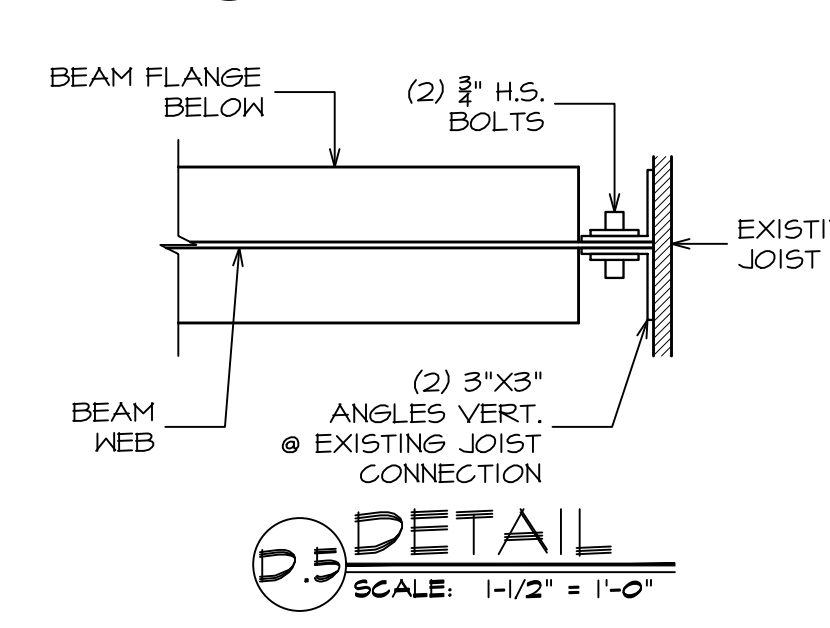

DETAIL 5
SCALE: 1-1/2" = 1'-0"

DATE: ISSUE
07-20-2022 ISSUED
FOR BIDDING & PERMIT

SEAL:

SENDEWSKI ARCHITECTS PC
ARCHITECTS - PLANNERS
215 ROANOKE AVENUE
RIVERHEAD, NY 11901
(631) 727-5352
9 SELENA COURT
WALDEN, NY 12586
(845) 275-8859

TAPPAN FIRE DISTRICT
300 WESTERN HIGHWAY SOUTH
TAPPAN, NY 10983

MEZZANINE FLOOR
PLAN & DETAILS

PROJECT #: 2108.01B

DRAWN BY: AR/JC

CAD FILE: 2108.01B/P-/BID

DRAWING#:

A-1.2

SUB STATION

SEAL:

SENDEWSKI ARCHITECTS PC
ARCHITECTS - PLANNERS
215 ROANOKE AVENUE
RIVERHEAD, NY 11901
(631) 727-5352
9 SELENA COURT
WALDEN, NY 12586
(845) 275-8859

TAPPAN FIRE DISTRICT
300 WESTERN HIGHWAY SOUTH
TAPPAN, NY 10983

ROOF PLAN

PROJECT #: 2108.01B












DRAWN BY: AR/JC

CAD FILE: 2108.01B/P-/BID

DRAWING#:

A=2.1

SUB STATION

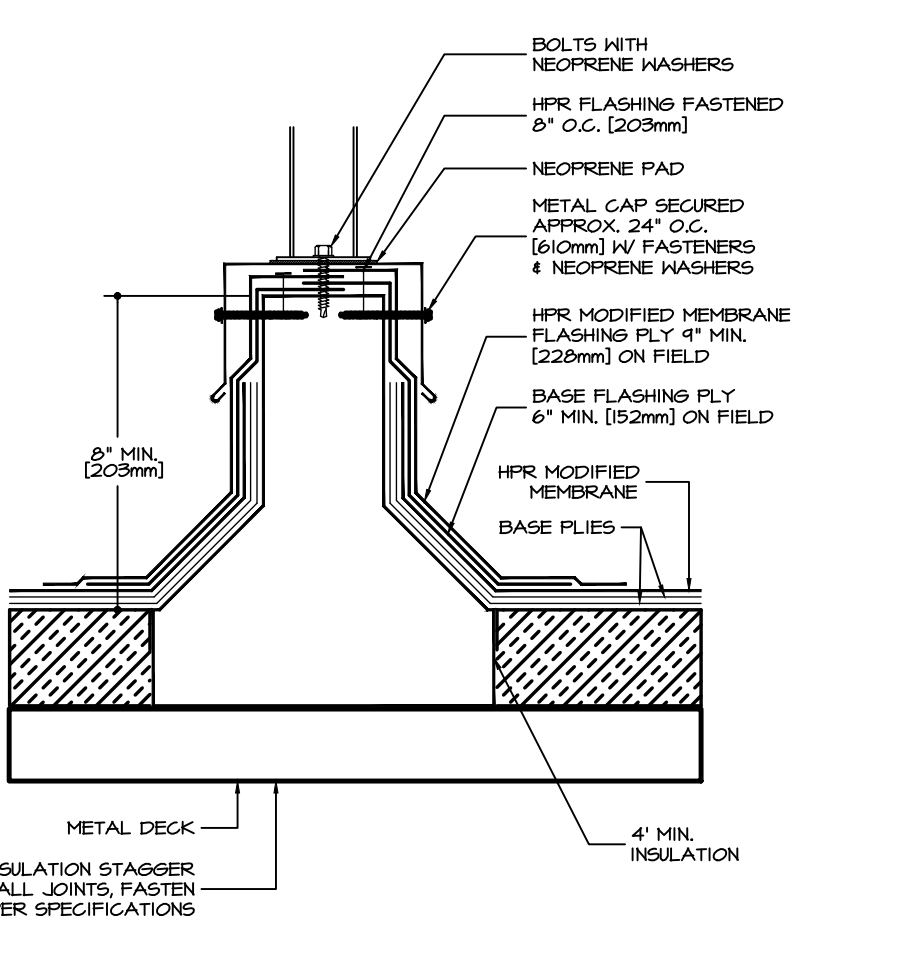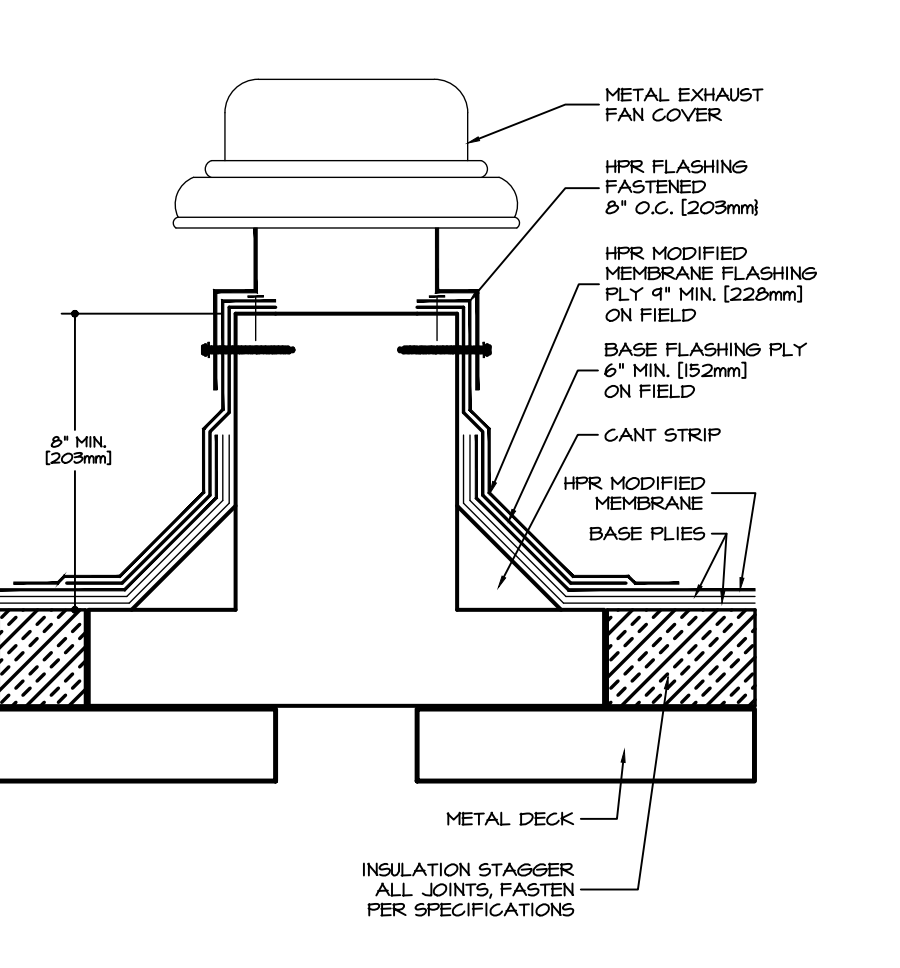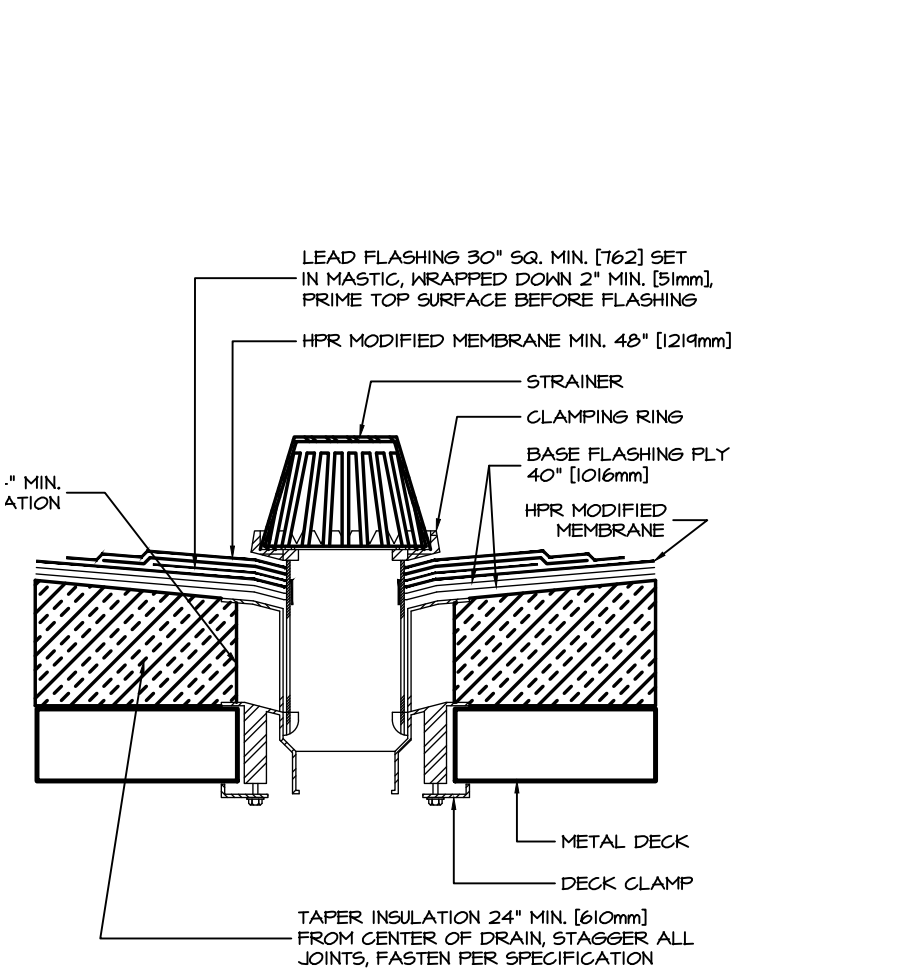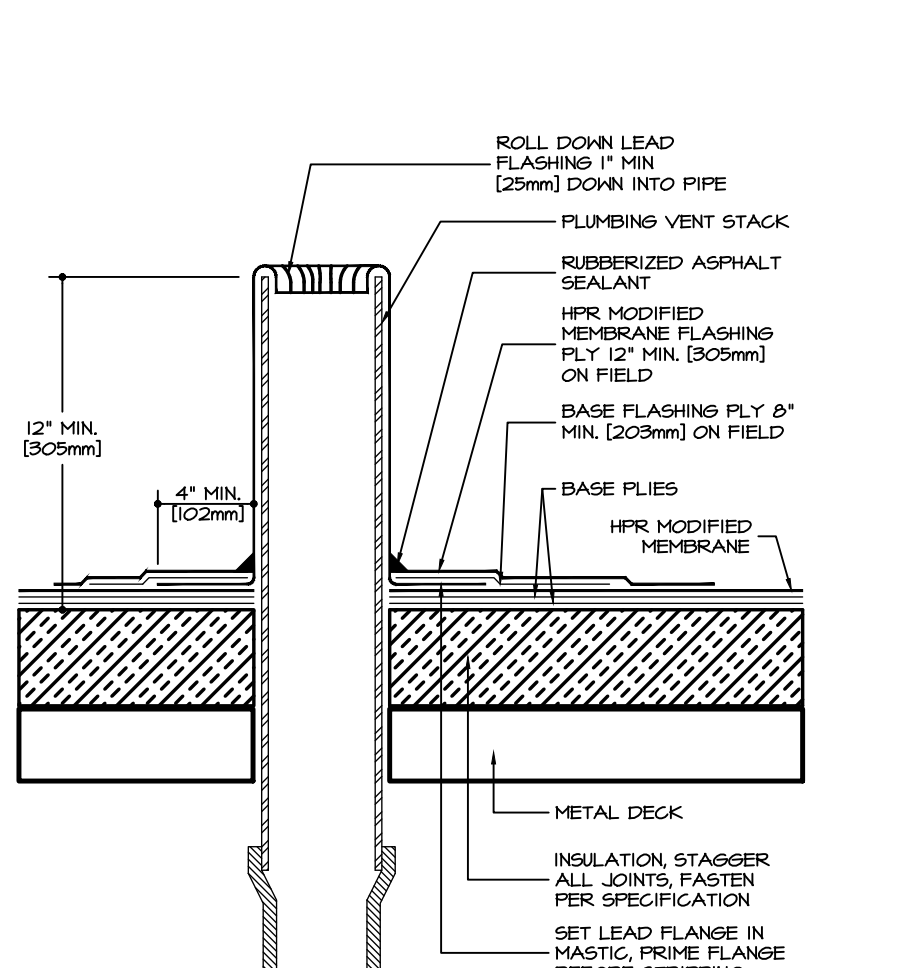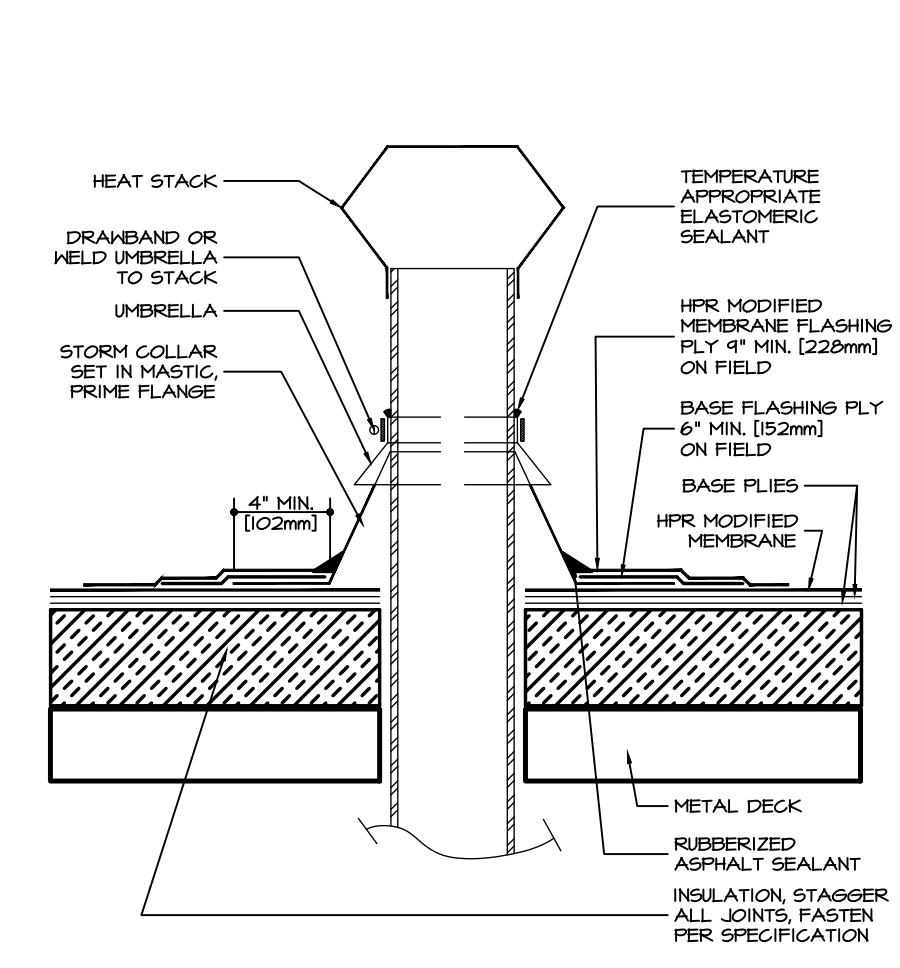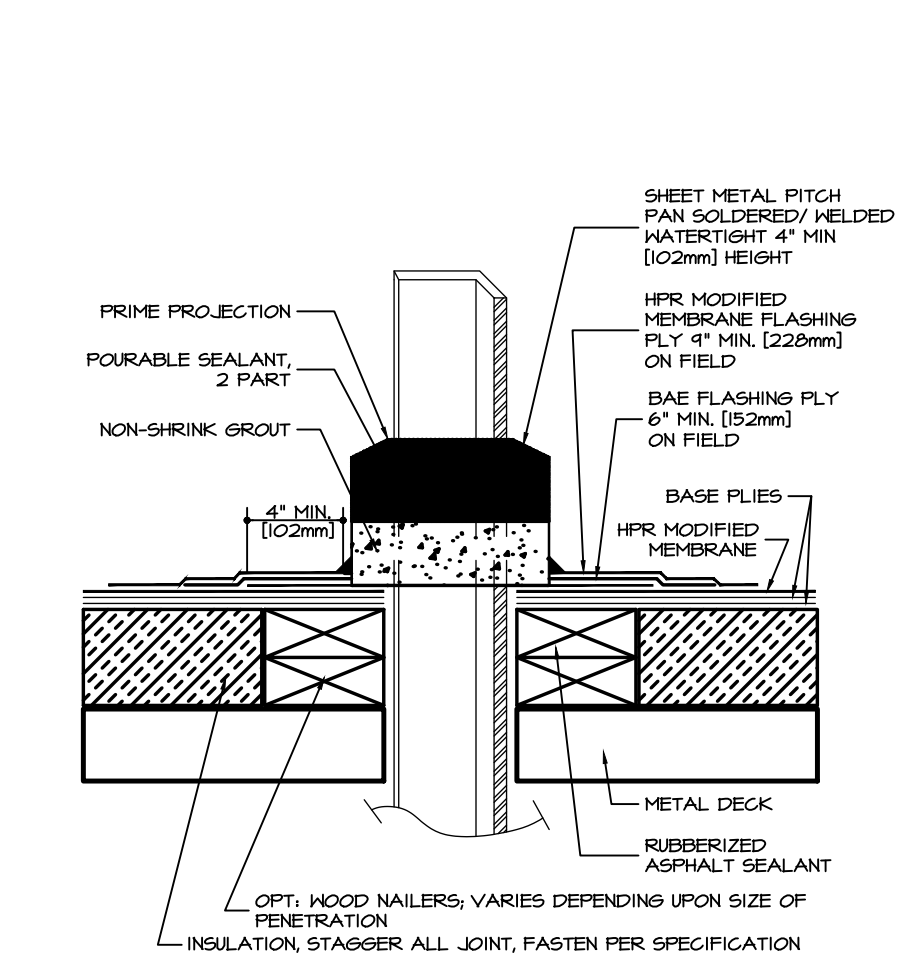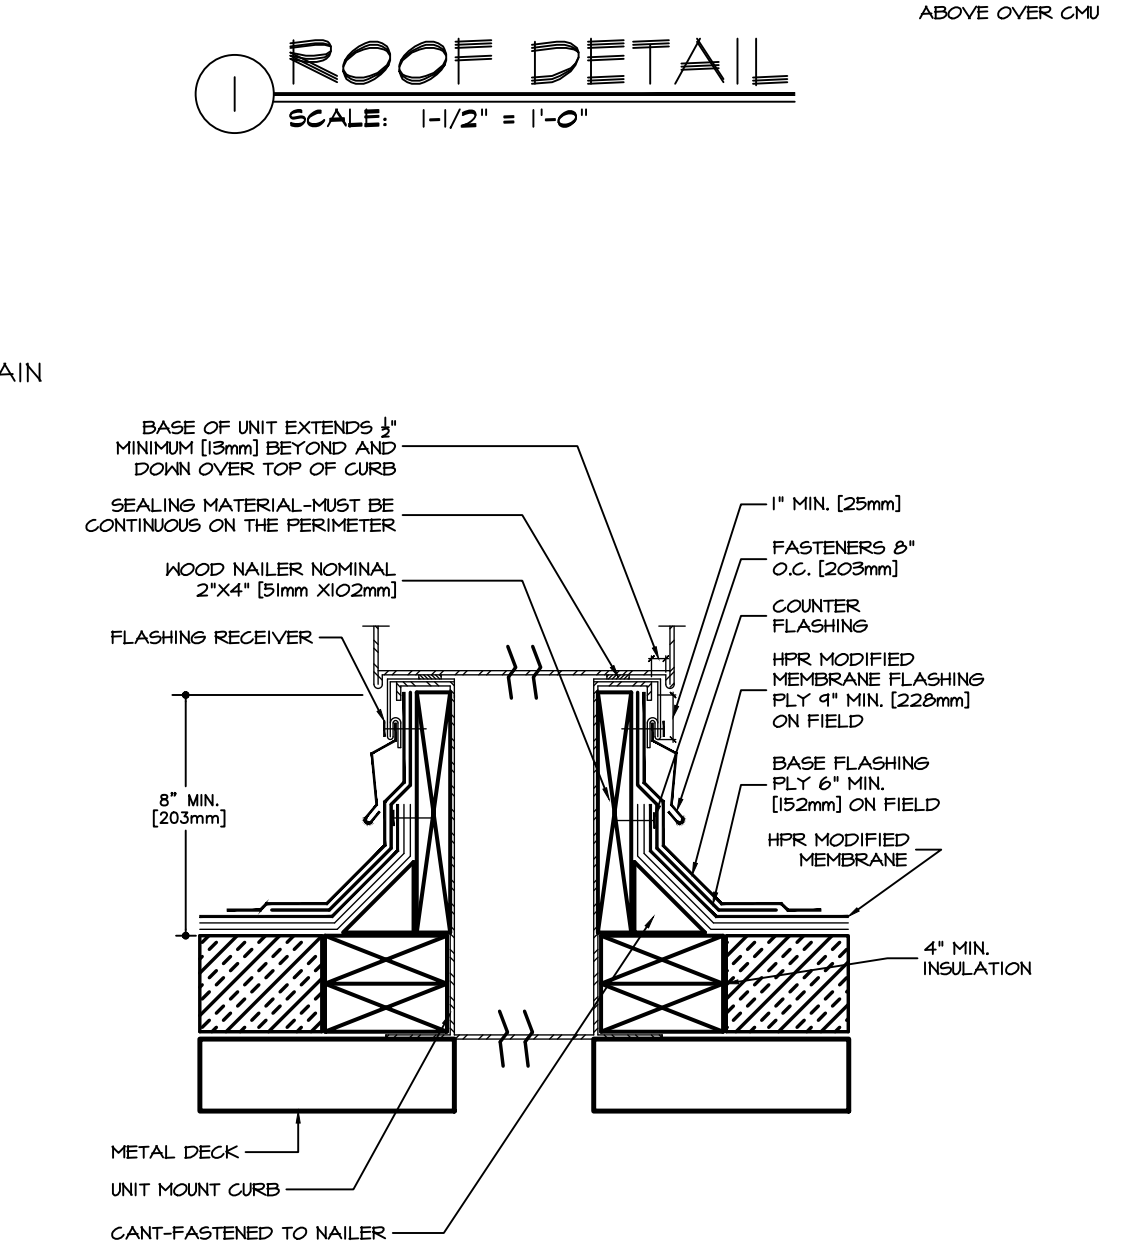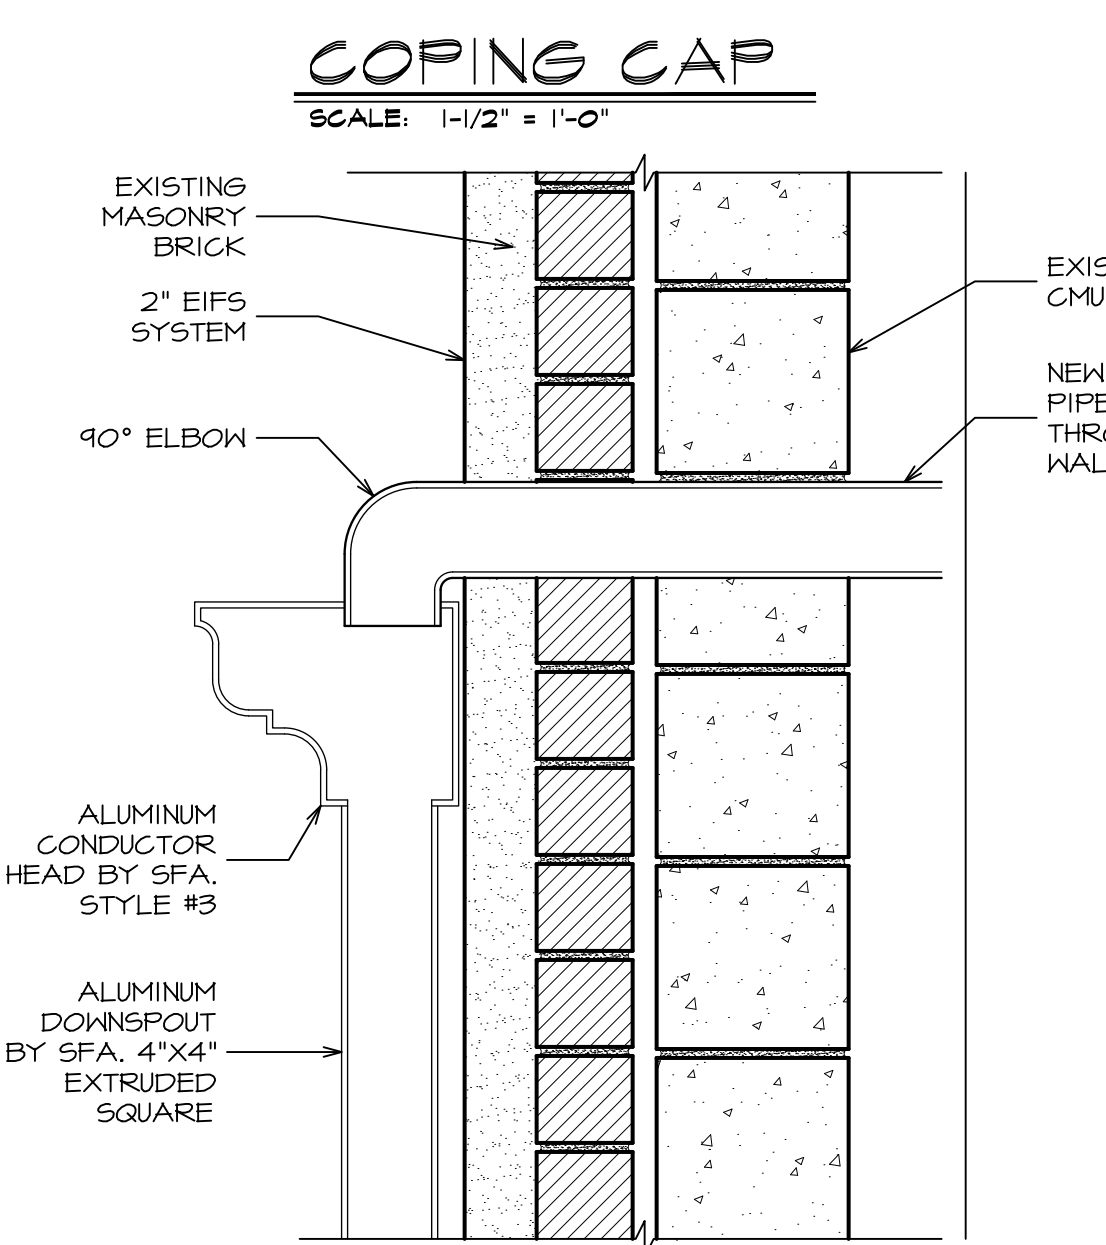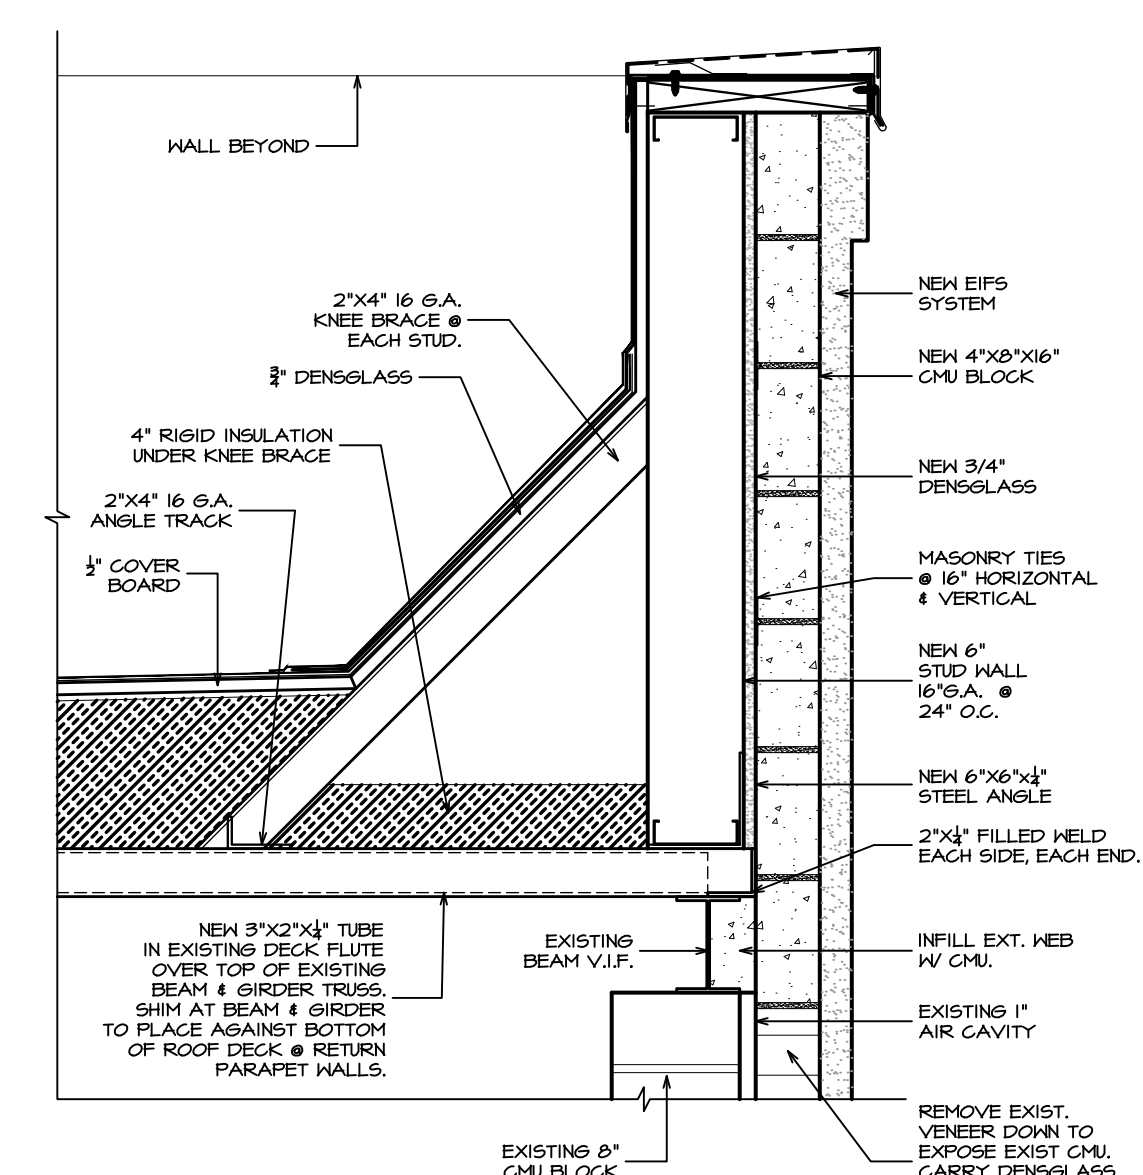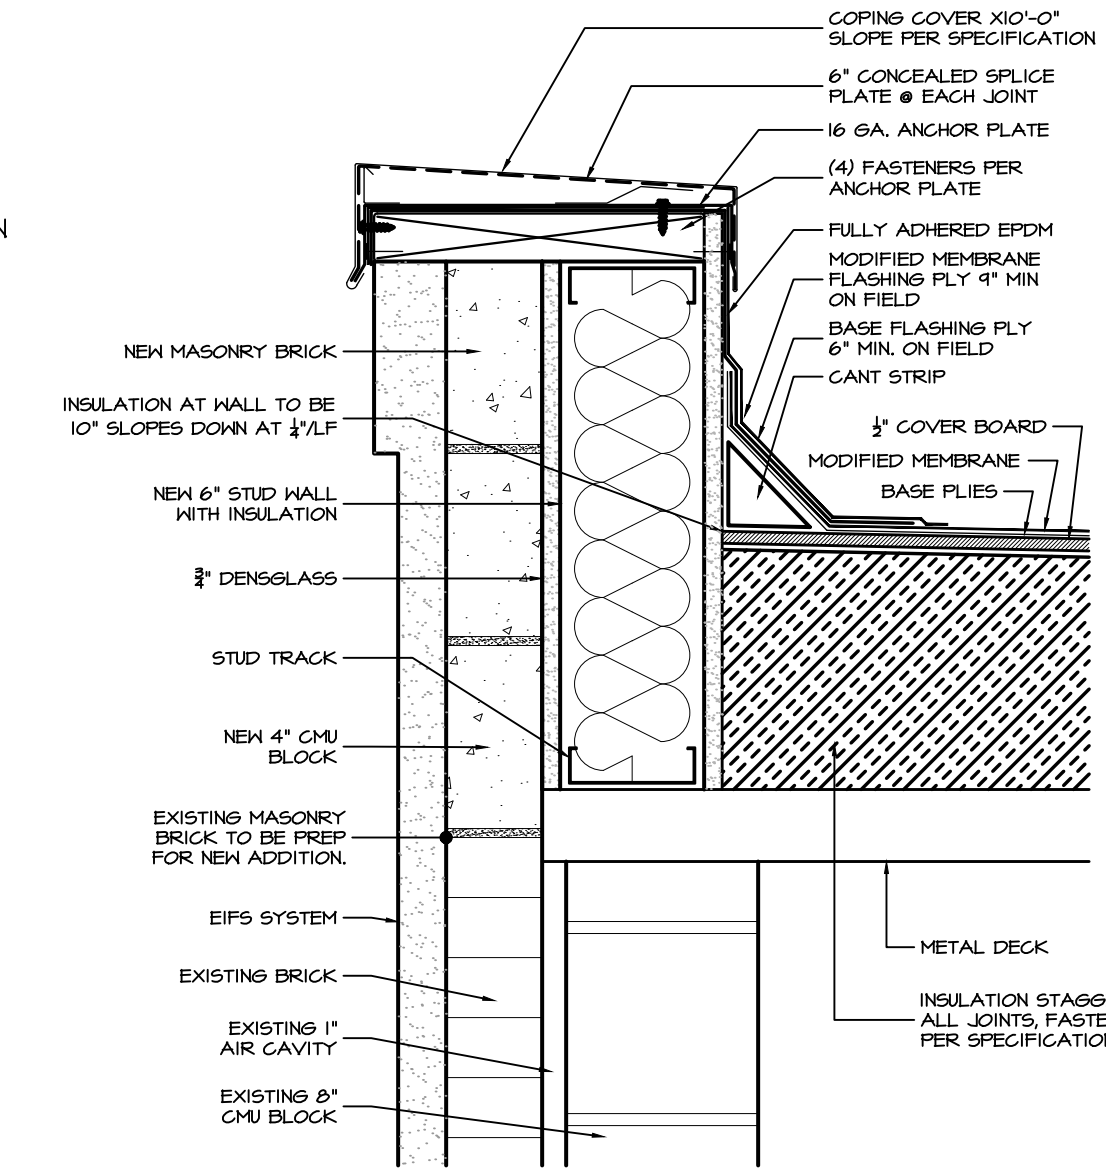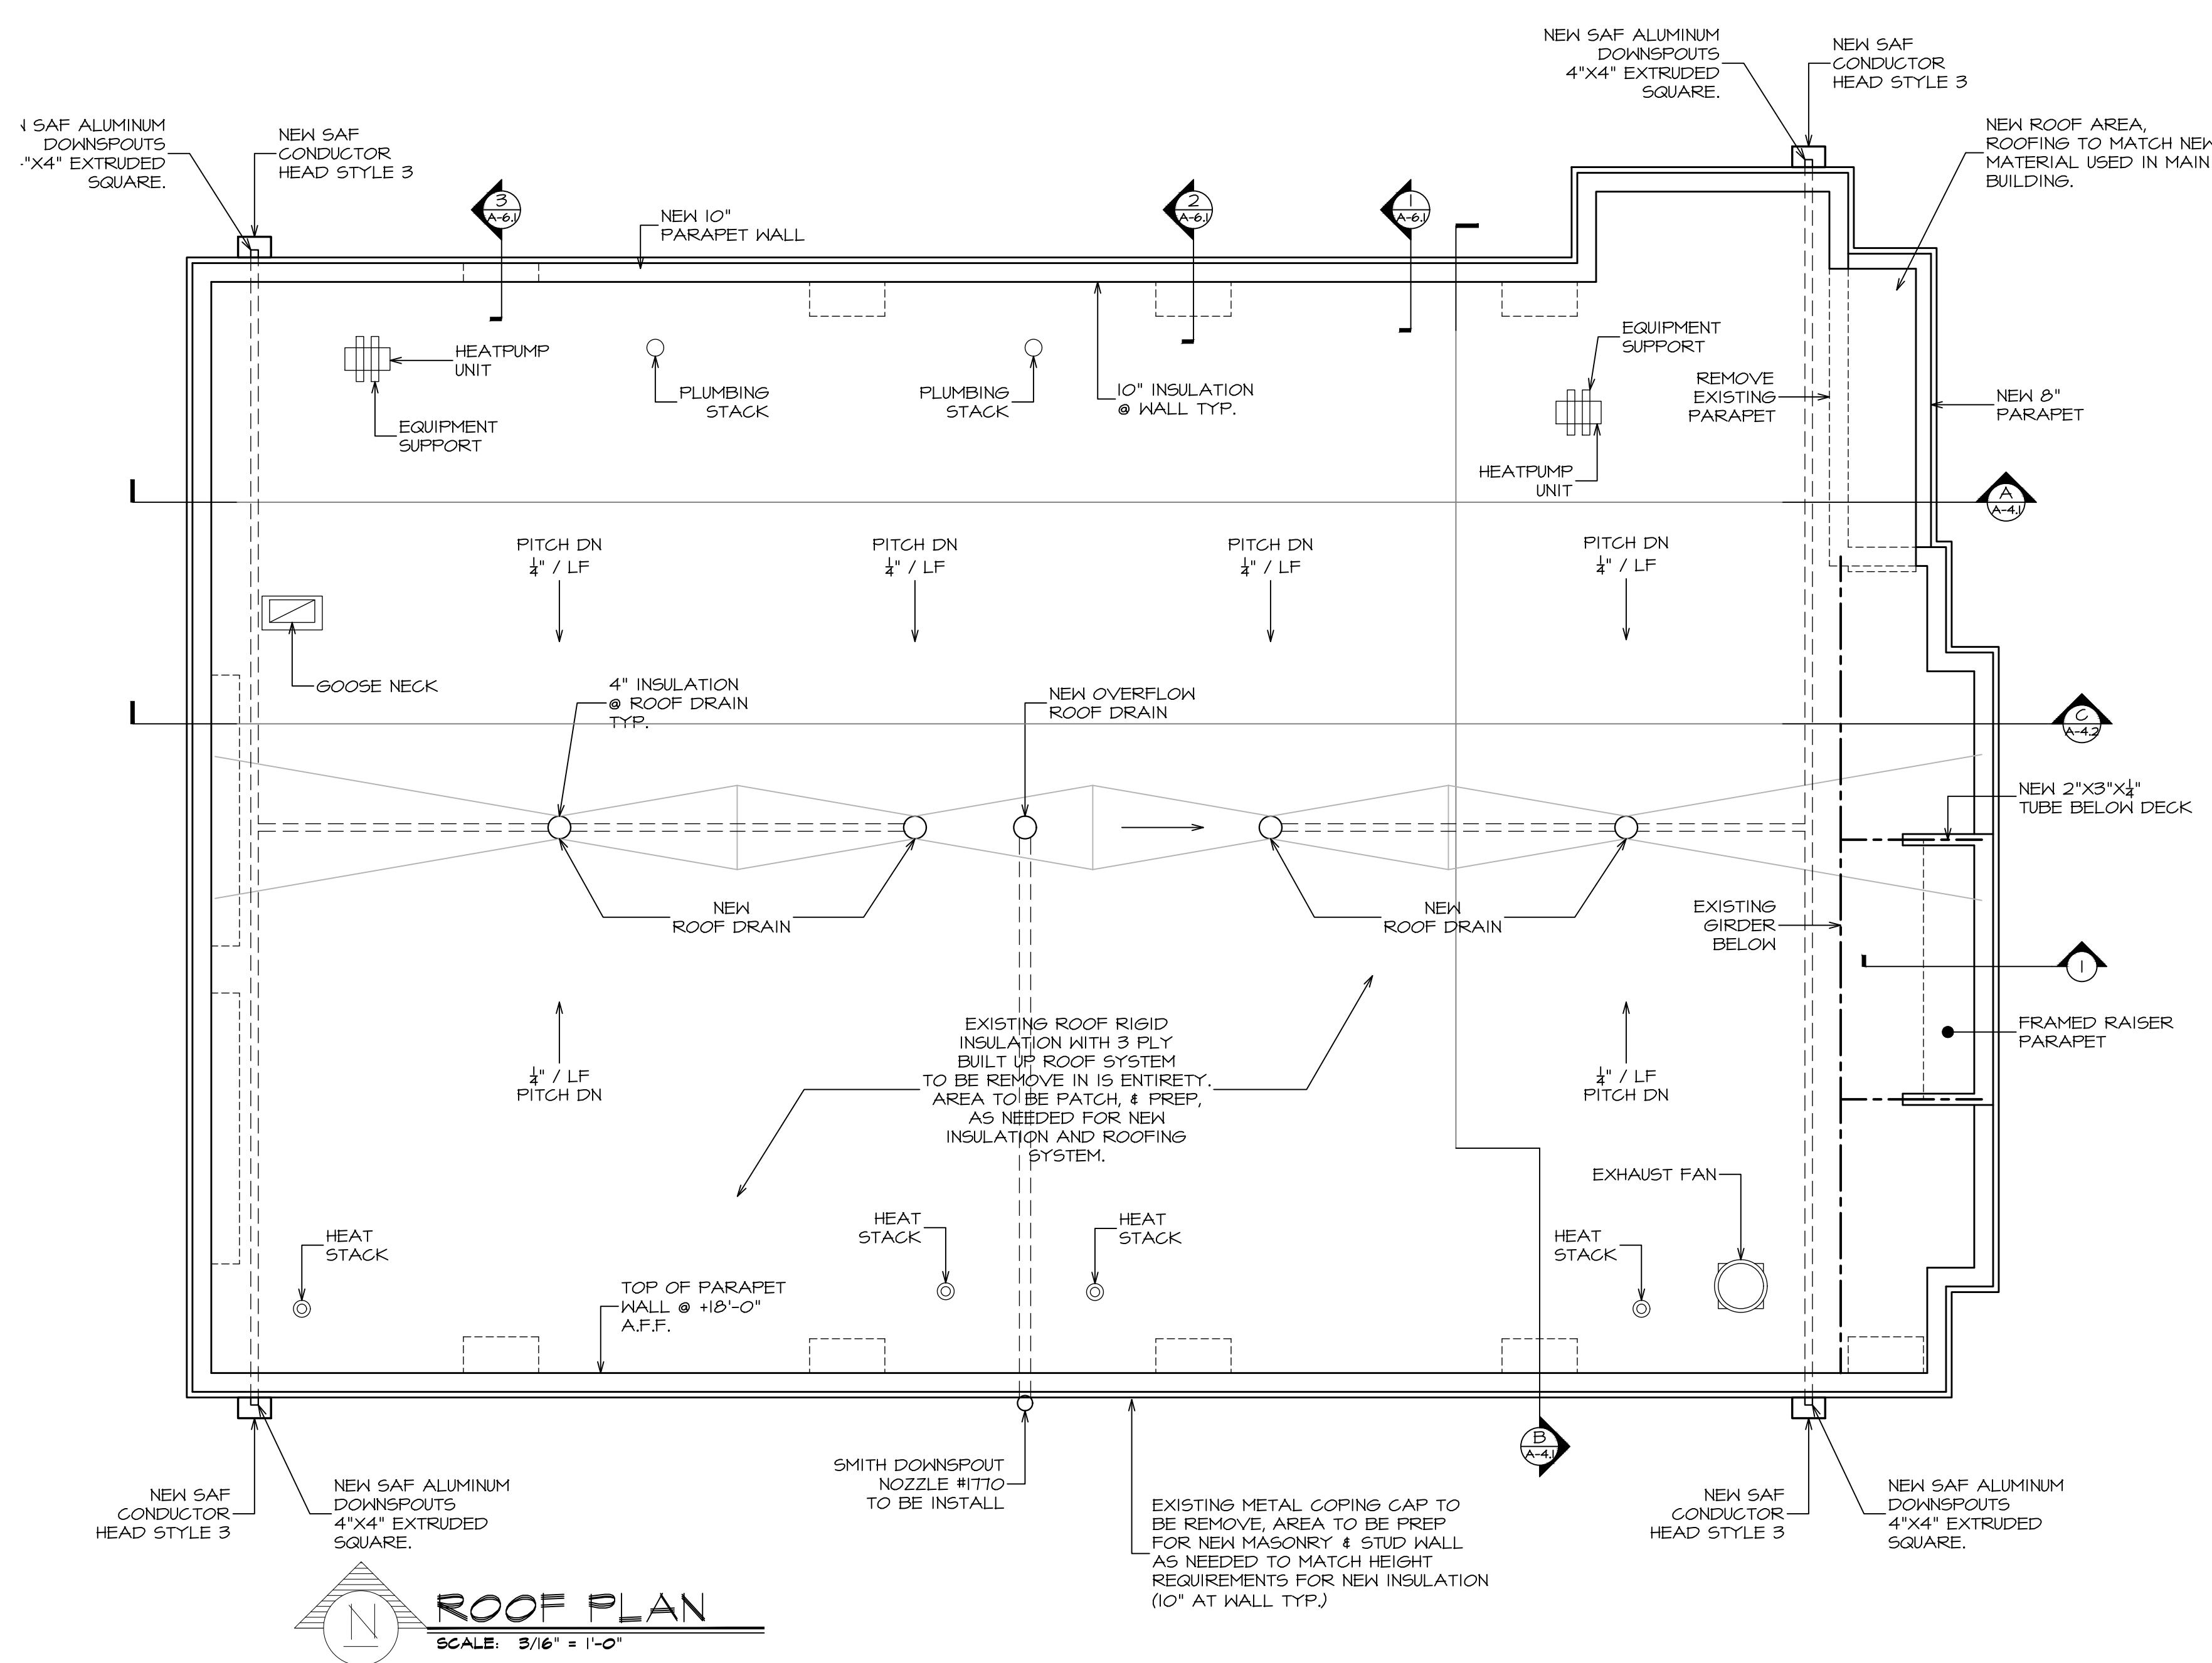

PITCH POCKET DETAIL
SCALE: 1-1/2" = 1'-0"


HEAT STACK DETAIL
SCALE: 1-1/2" = 1'-0"

PLUMBING STACK DETAIL
SCALE: 1-1/2" = 1'-0"

ROOF DRAIN DETAIL
SCALE: 1-1/2" = 1'-0"


EXHAUST FAN DETAIL
SCALE: 1-1/2" = 1'-0"

PRE. MANU. CURB FOR EQUIPMENT SUPPORT
SCALE: 1-1/2" = 1'-0"

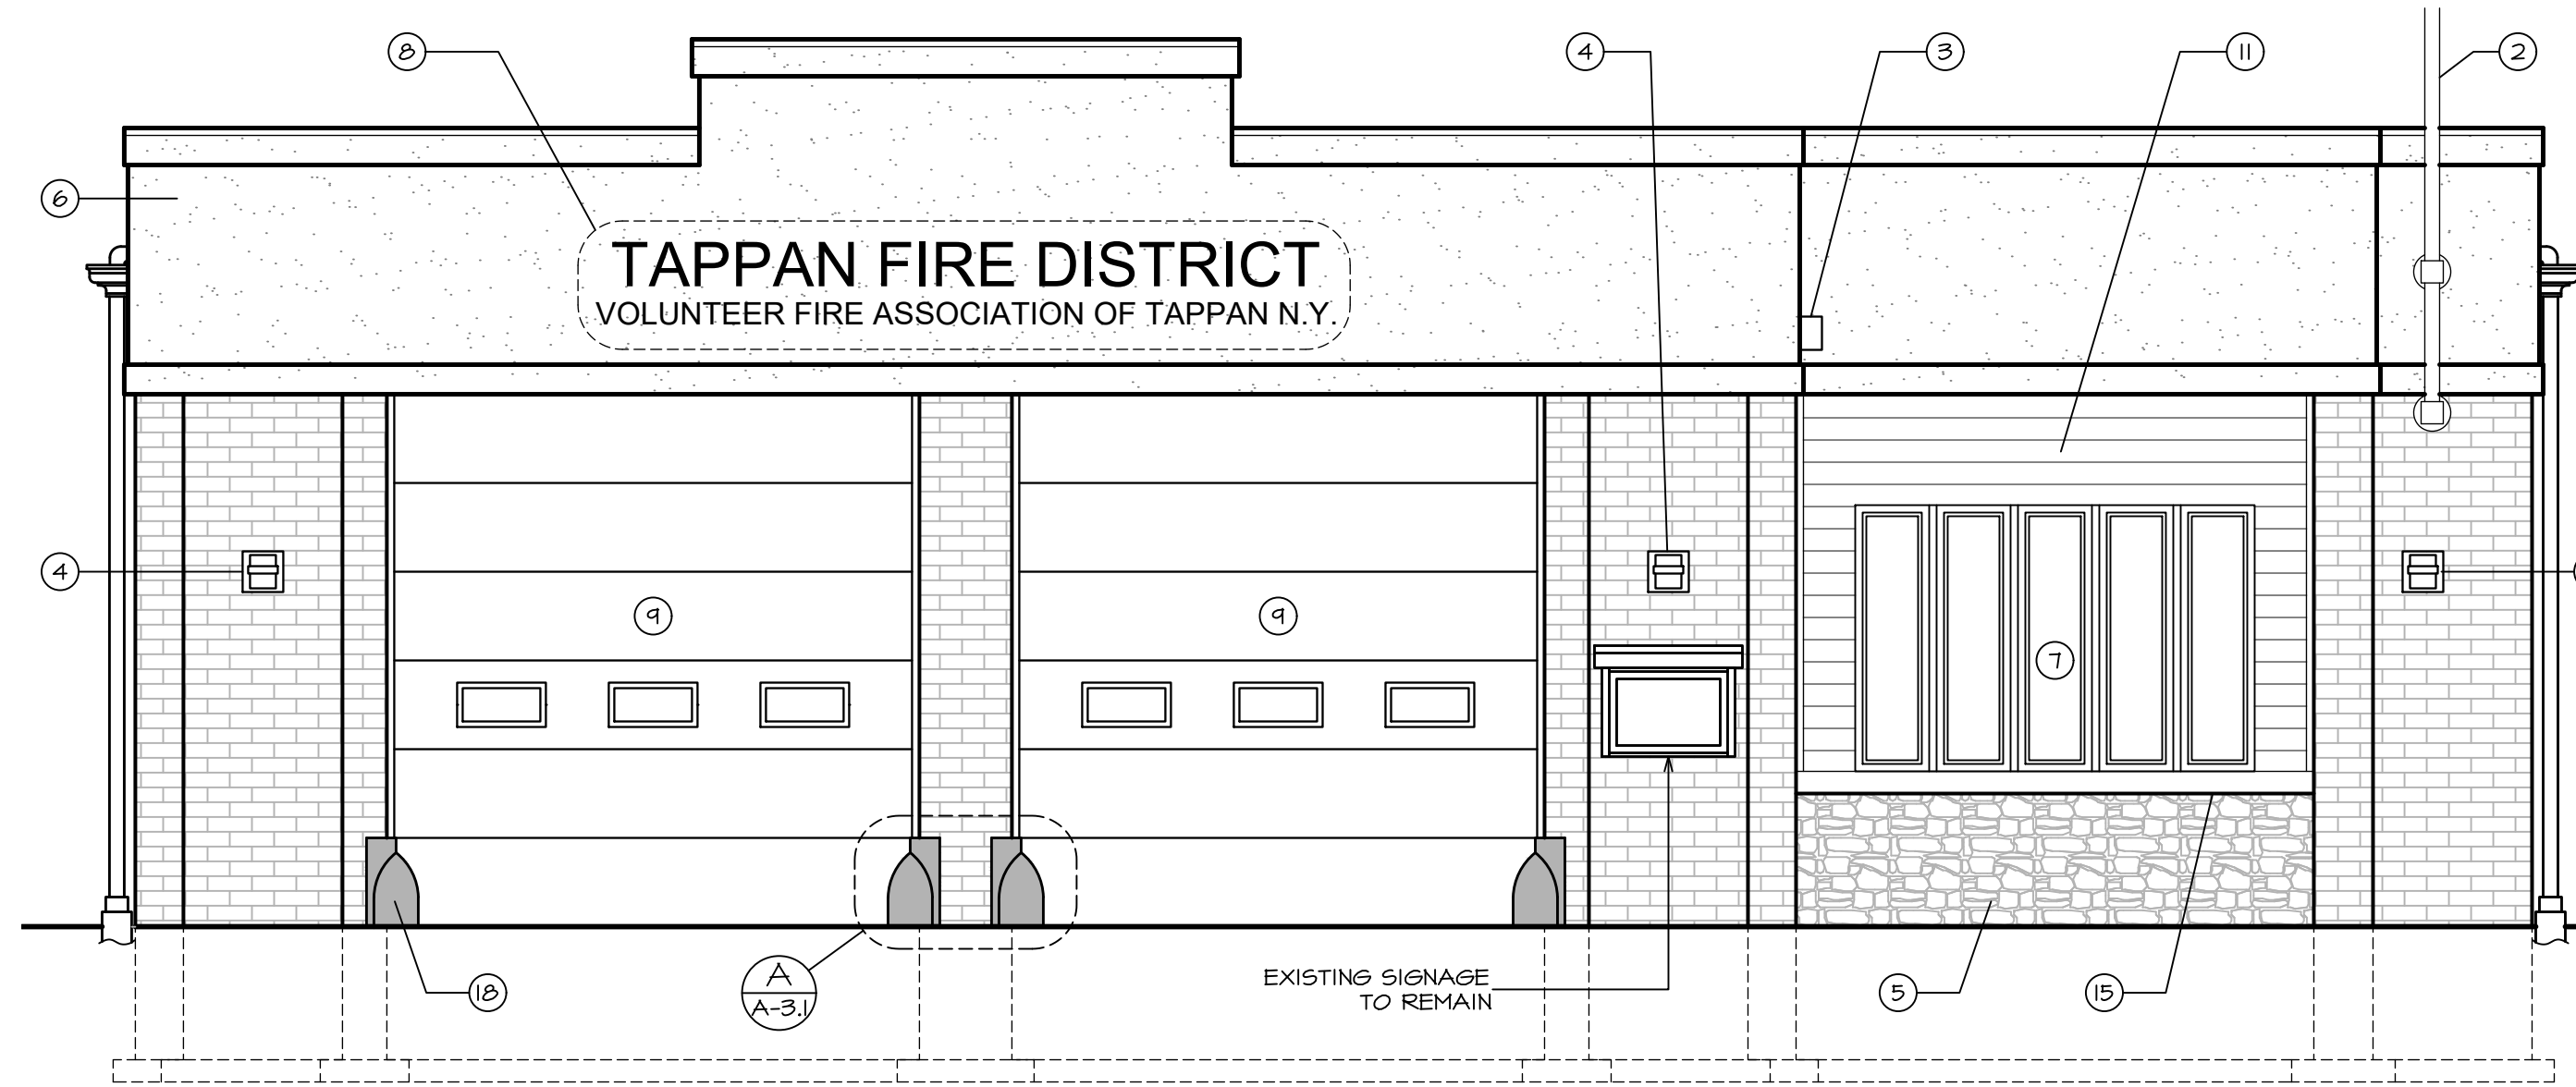


EAST ELEVATION

SCALE: 1/4" = 1'-0"

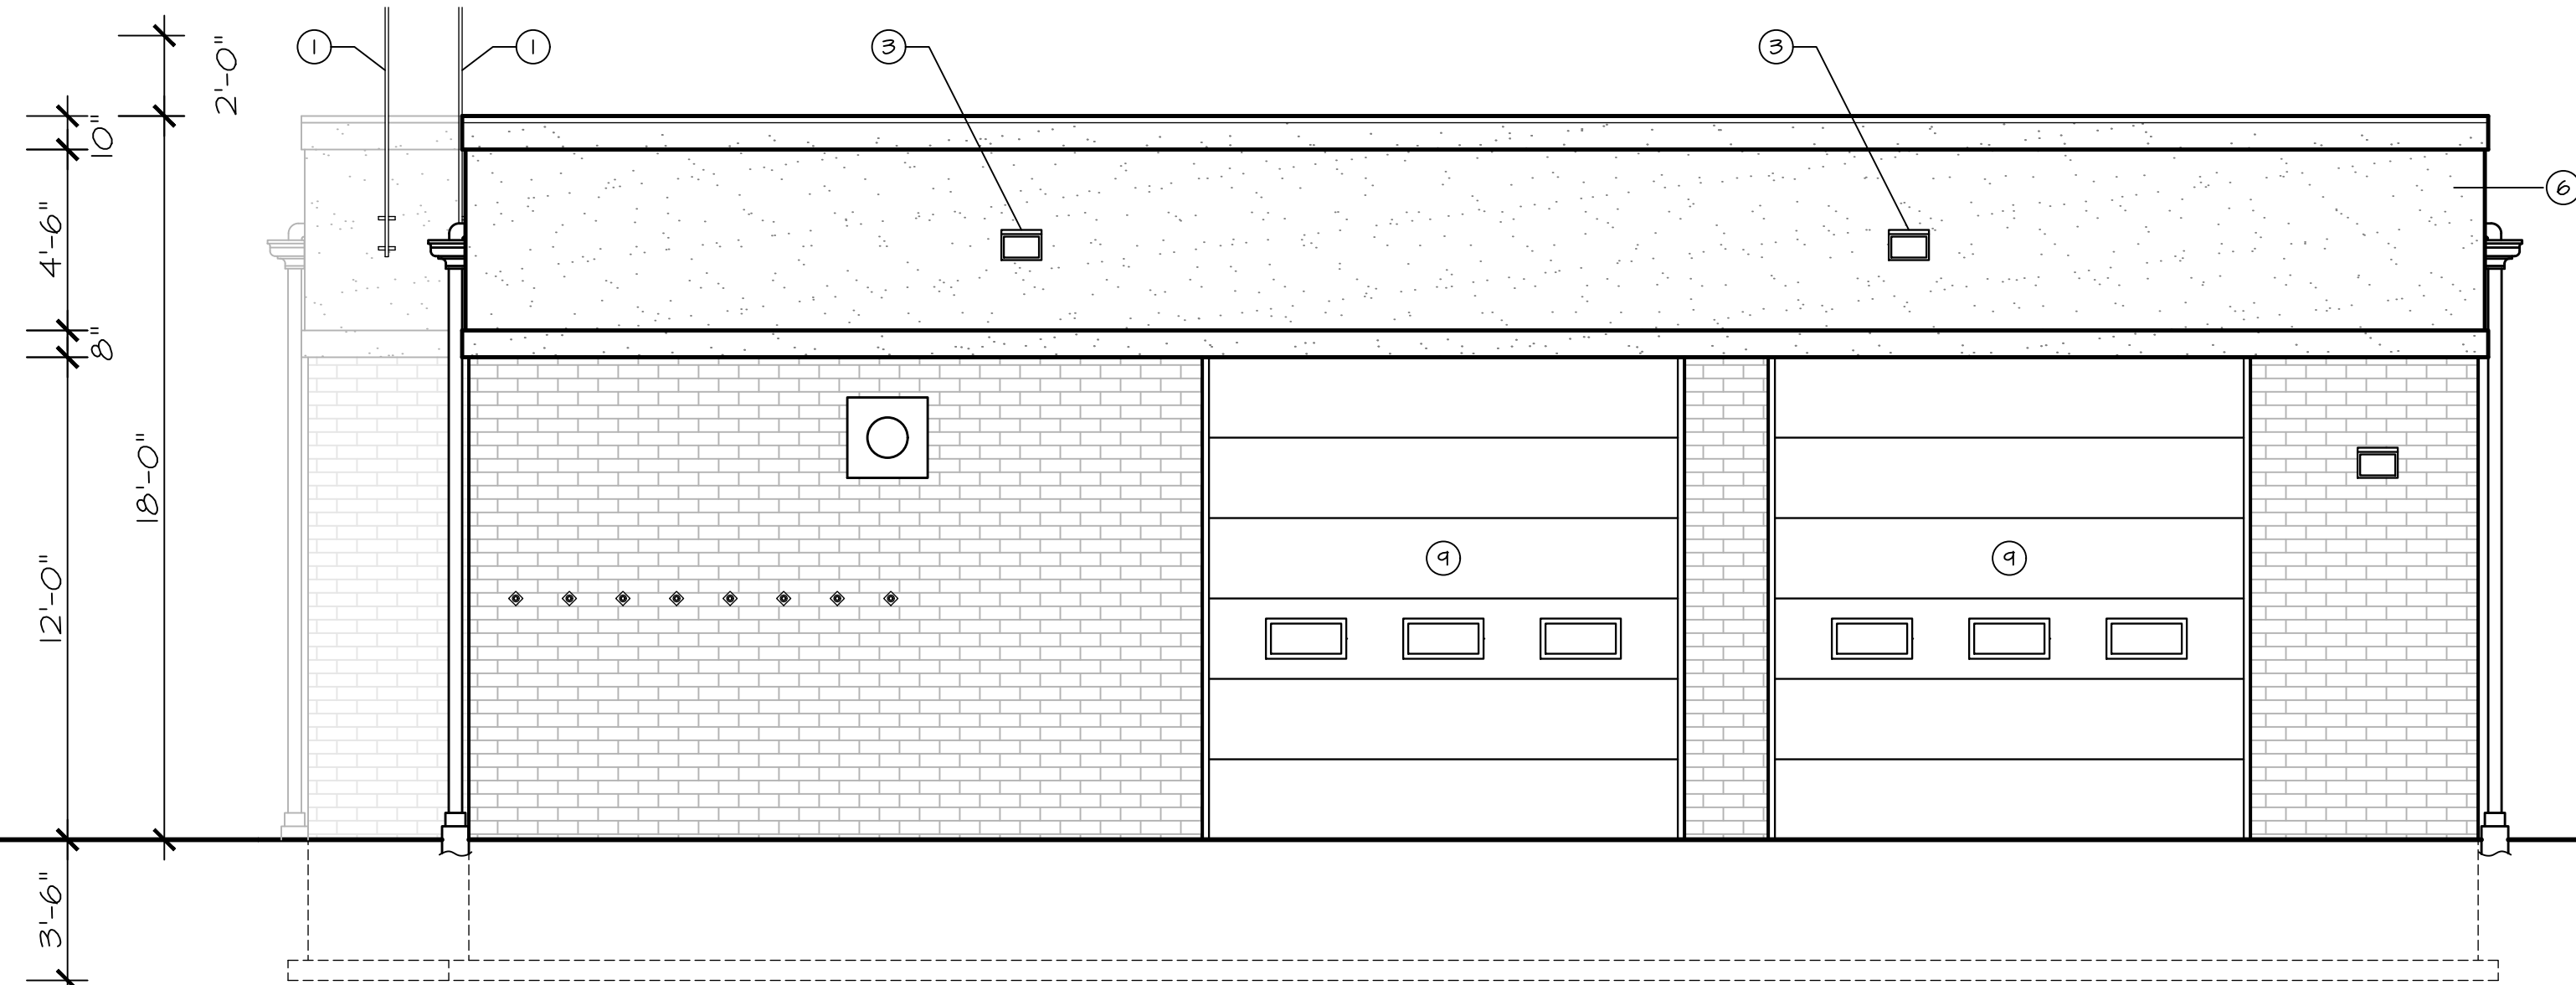


WEST ELEVATION

SCALE: 1/4" = 1'-0"

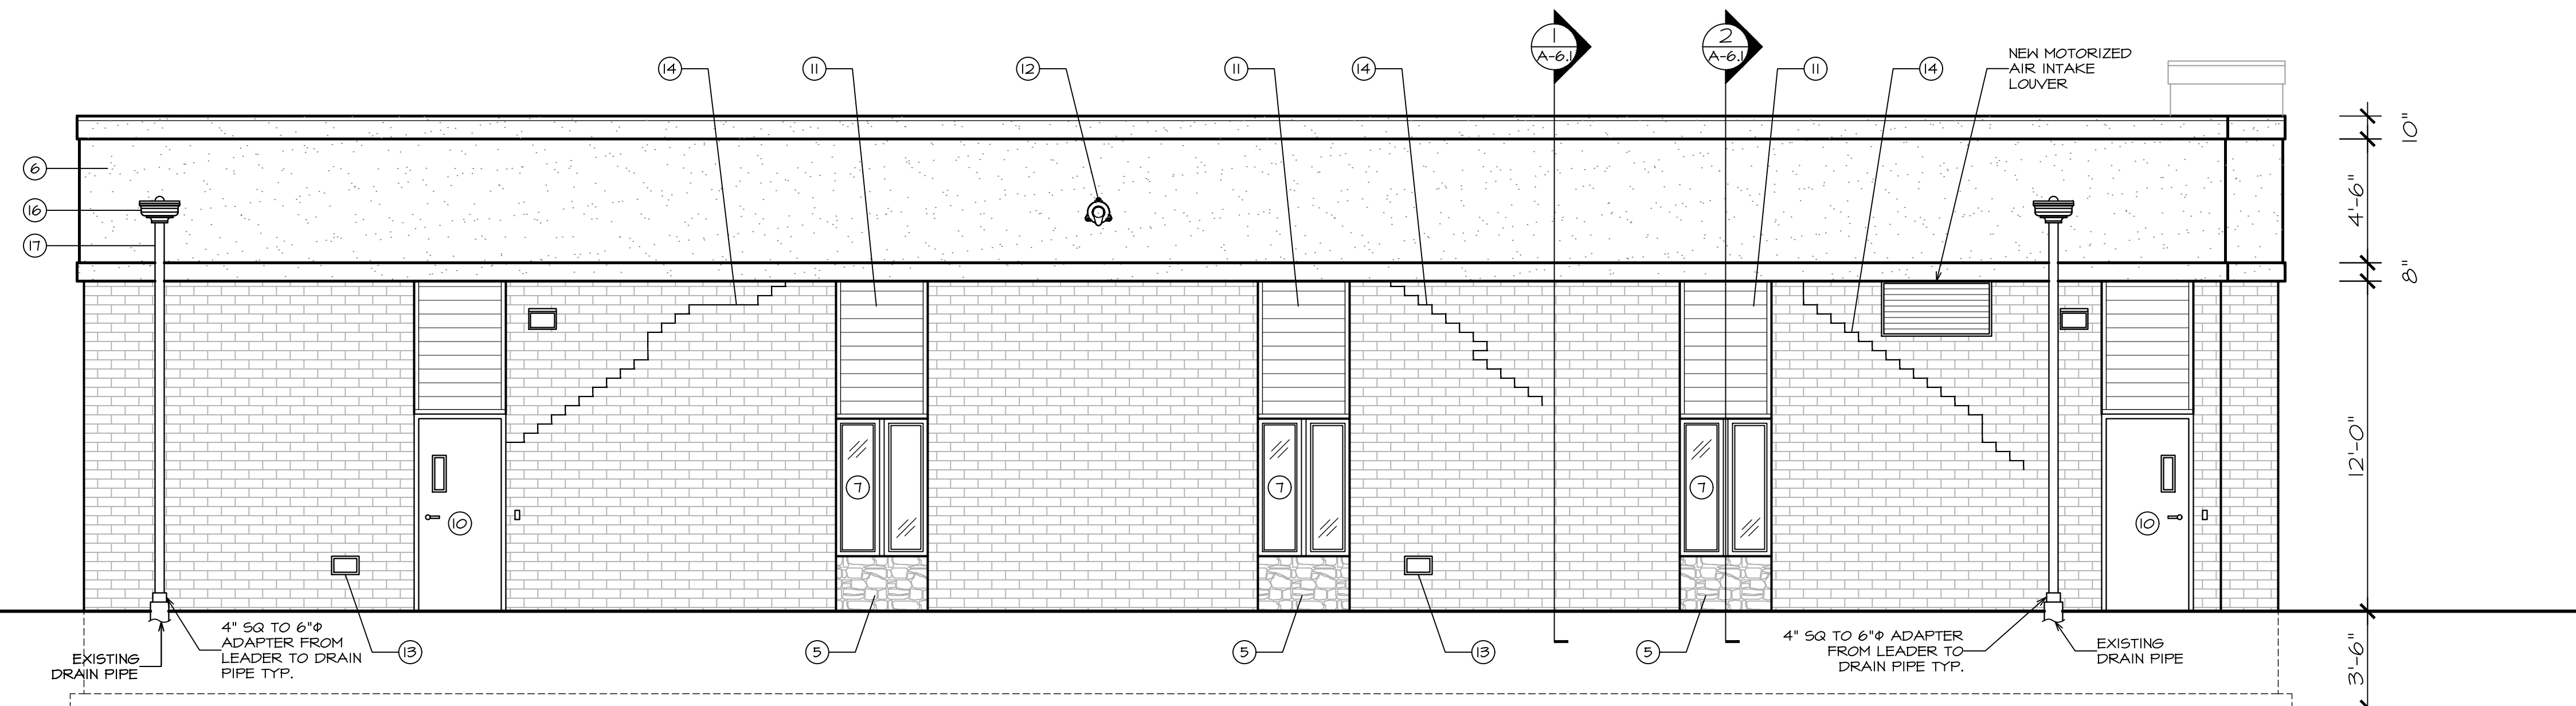

NORTH ELEVATION

SCALE: 1/4" = 1'-0"

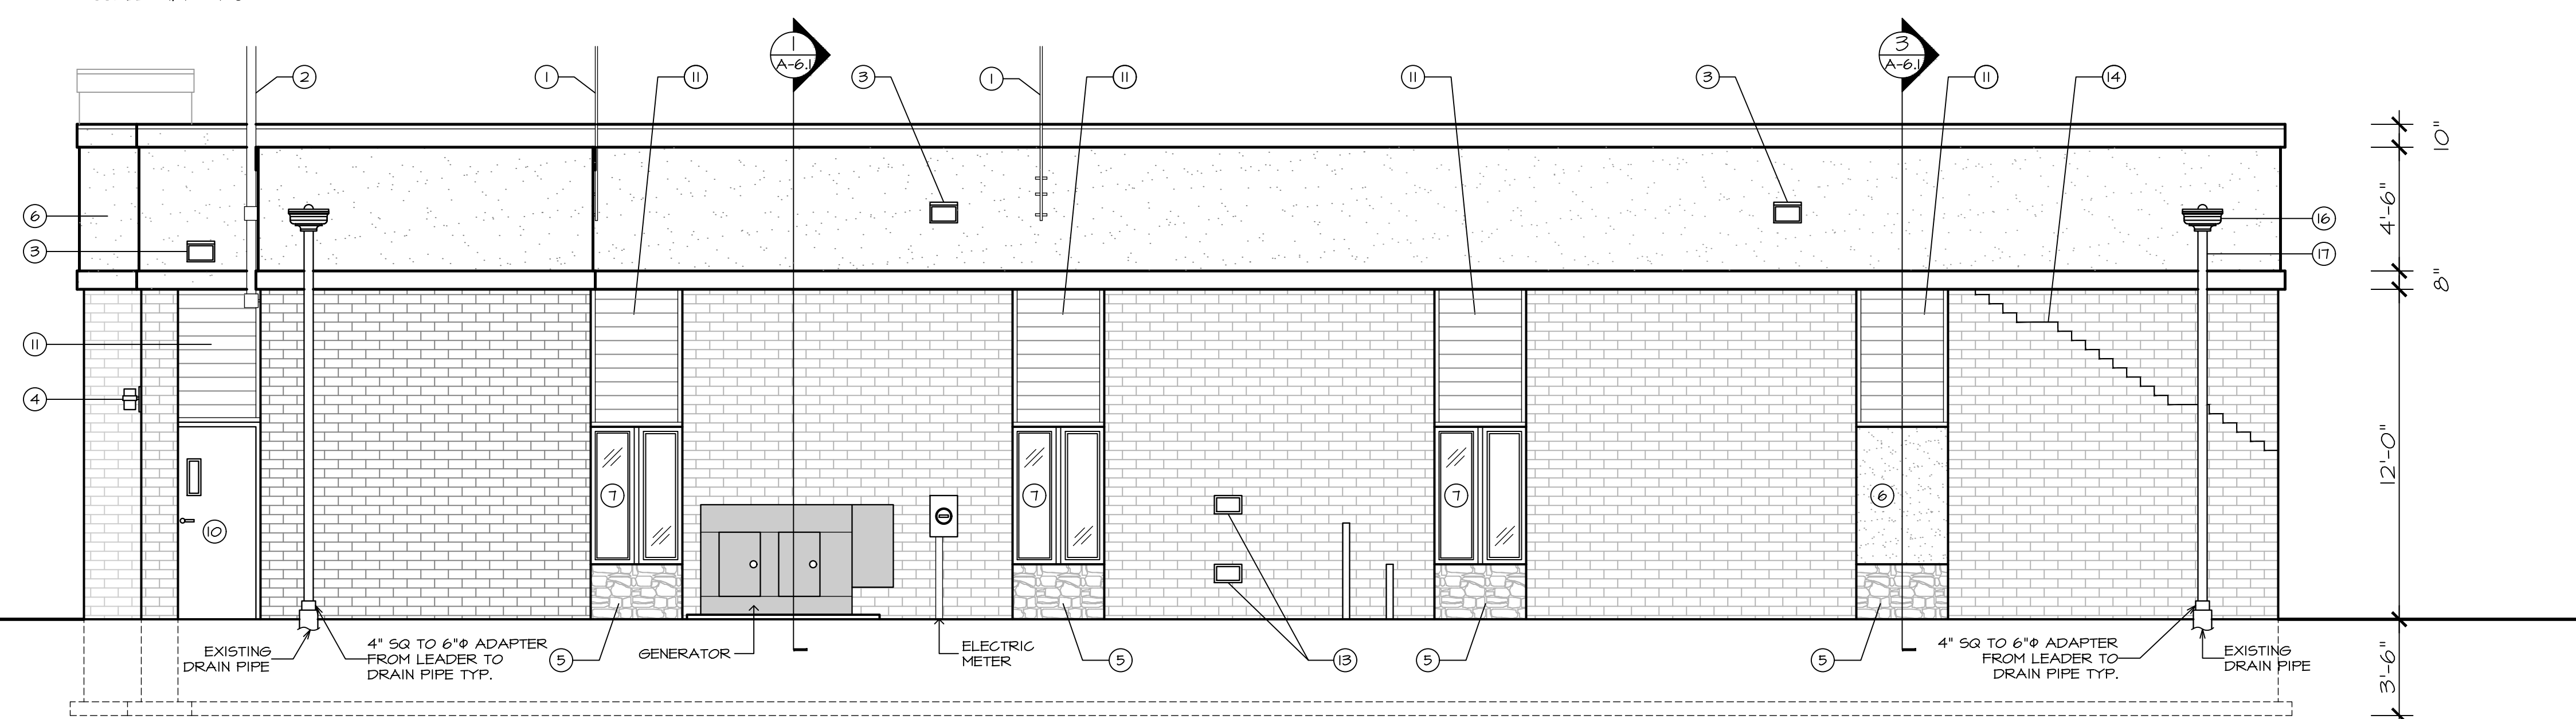


SOUTH ELEVATION

SCALE: 1/4" = 1'-0"

NOTES

- EXISTING ANTENNAS TO BE REMOVE & REINSTALL.
- EXISTING FLAG POLE TO REMAIN. COORDINATE NEW EIFS SYSTEM FINISH AND CAULKING AROUND EXISTING CONNECTION.
- EXISTING LIGHT FIXTURE TO BE REMOVE & REINSTALL.
- NEW LED WALL SCONCE POSSINI EURO FRAMED BRUSHED NICKEL LAMPS
- NEW CULTURE STONE TO BE INSTALLED SEE DETAILS DWG A-6.1
- NEW EIFS SYSTEM TO BE INSTALLED SEE DETAILS IN DWG A-4.2
- EXISTING WINDOWS TO REMAIN.
- TAPPAN FIRE DISTRICT SIGN TO BE REMOVE PAINTED & REINSTALLED WITH NEW STAND OFF HARDWARE & ANCHORS.
- EXISTING O.H.D. TO REMAIN IN BASE BID. (NEW O.H.D. TO BE INSTALL AS ADD ALTERNATE)
- NEW DOOR & FRAME TO BE INSTALLED.
- NEW HARDI PLANK TO BE INSTALLED.
- DOWNPOUT NOZZLE BY MFG FIGURE NUMBER ITTIO
- EXISTING VENTS TO BE REMOVE. AREA TO BE FILL IN AND PATCH THE SURROUNDING AREA AS NEEDED TO MATCH EXISTING BRICK & MORTAR.
- RAKE OUT EXISTING JOINTS AS REQUIRED FOR RE-POINTING. FIELD REVIEW ALL AREAS WITH ARCHITECT PRIOR TO PROCEEDING. ALL JOINTS TO BE RE-POINTED WITH NEW MORTAR TO MATCH EXISTING.
- NEW 1"x6" HARDI PLANK TRIM UNDER WINDOW FULL WIDTH
- NEW SAF ALUMINUM CONDUCTOR HEAD STYLE 3
- NEW SAF ALUMINUM DOWNSPOUTS 4"x4" EXTRUDED SQUARE & RECTANGULAR
- 24"x12" HEAVY DUTY CAST IRON WHEEL GUARD BY TRENCH DRAIN SUPPLY (MODEL: R-4486-DG) WITH PAINT FINISH, COLOR SELECTED BY OWNER.

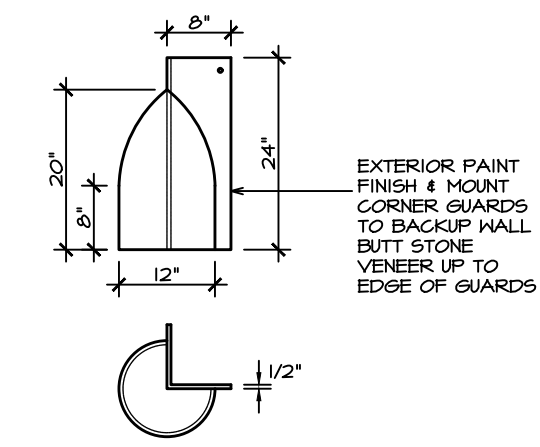

WHEEL GUARD DETAIL

SCALE: 1/2" = 1'-0"

DATE: ISSUE
07-20-2022 ISSUED
FOR BIDDING & PERMIT

SEAL:

SENDEWSKI ARCHITECTS PC
ARCHITECTS - PLANNERS
215 ROANOKE AVENUE
RIVERHEAD, NY 11901
(631) 727-5352
9 SELENA COURT
WALDEN, NY 12586
(845) 275-8859

TAPPAN FIRE DISTRICT
300 WESTERN HIGHWAY SOUTH
TAPPAN, NY 10983

ELEVATIONS & NOTES

PROJECT #: 2108.01B


DRAWN BY: AR/JC

CAD FILE: 2108.01B/P-/BID


DRAWING#:

A-3.1


SUB STATION

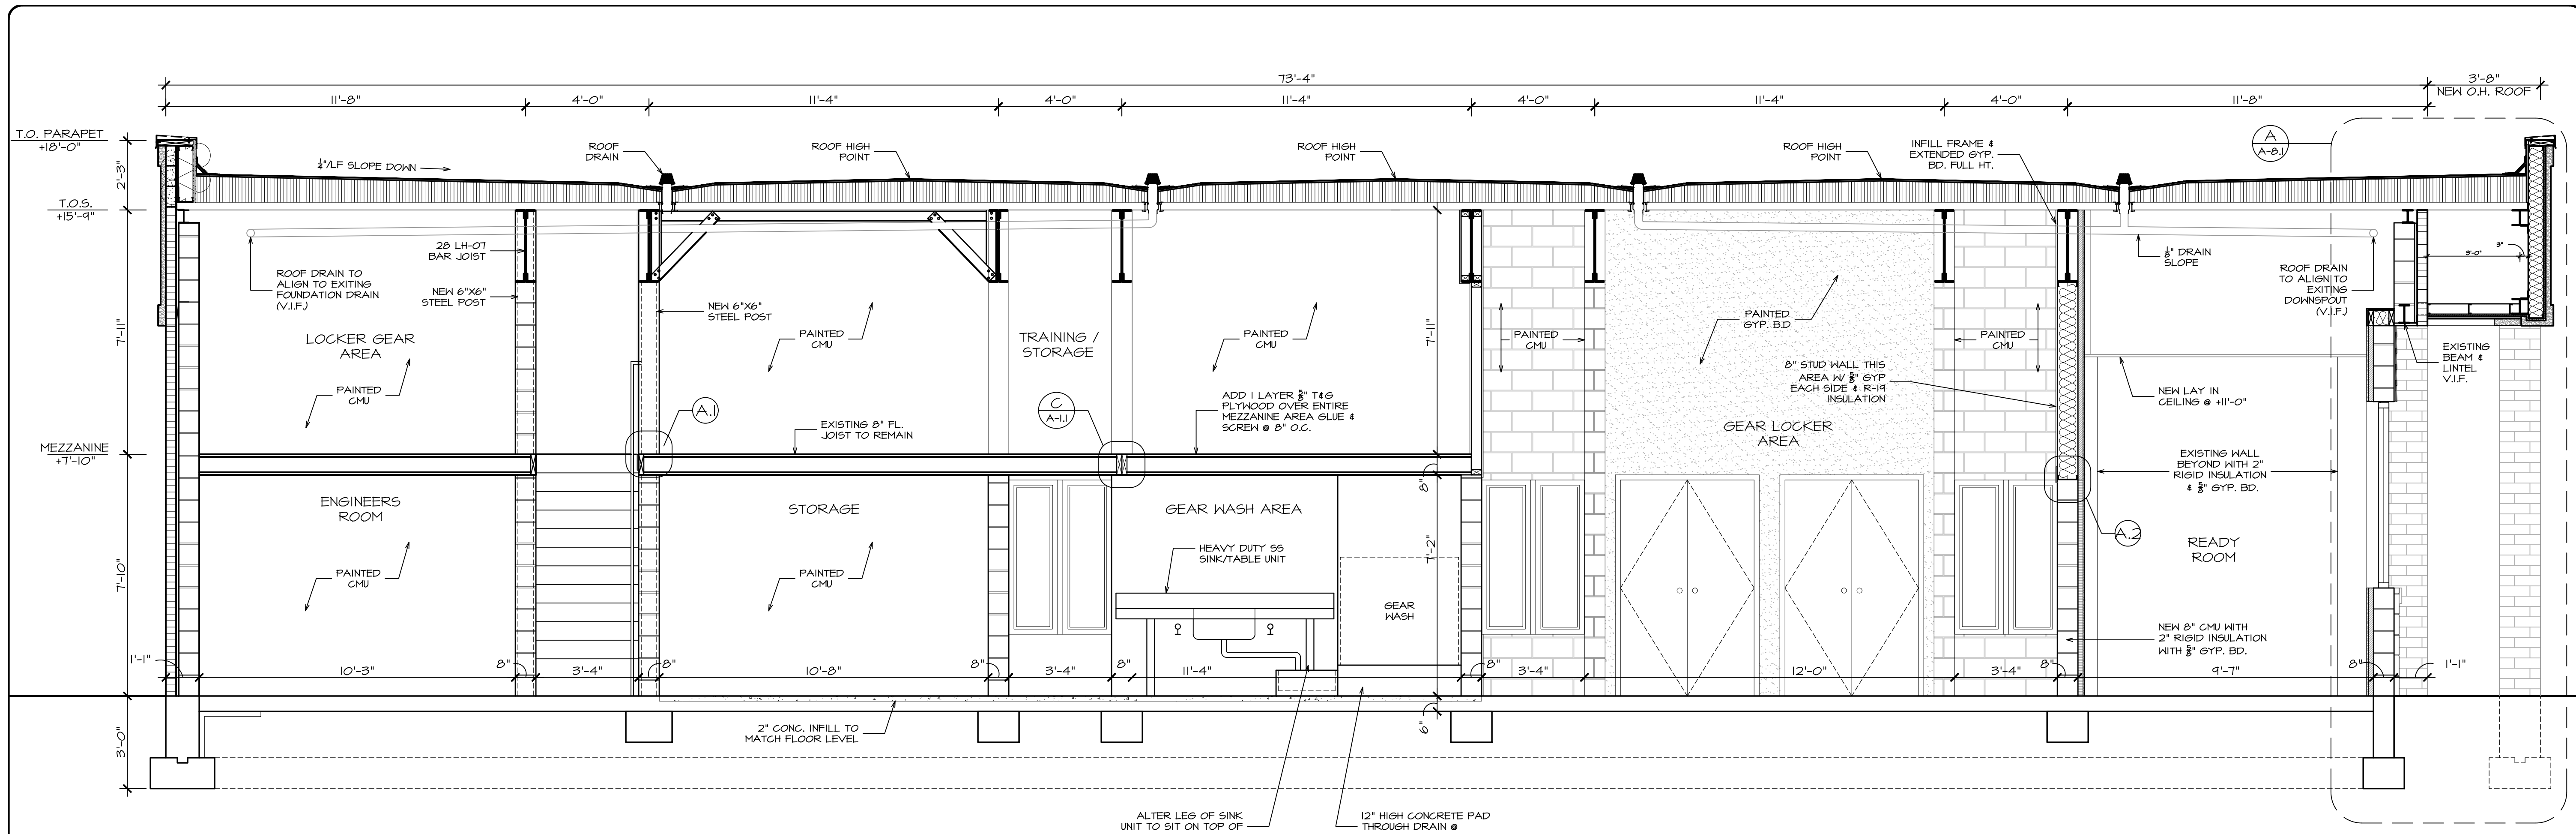


A SECTION
SCALE: 3/8" = 1'-0"

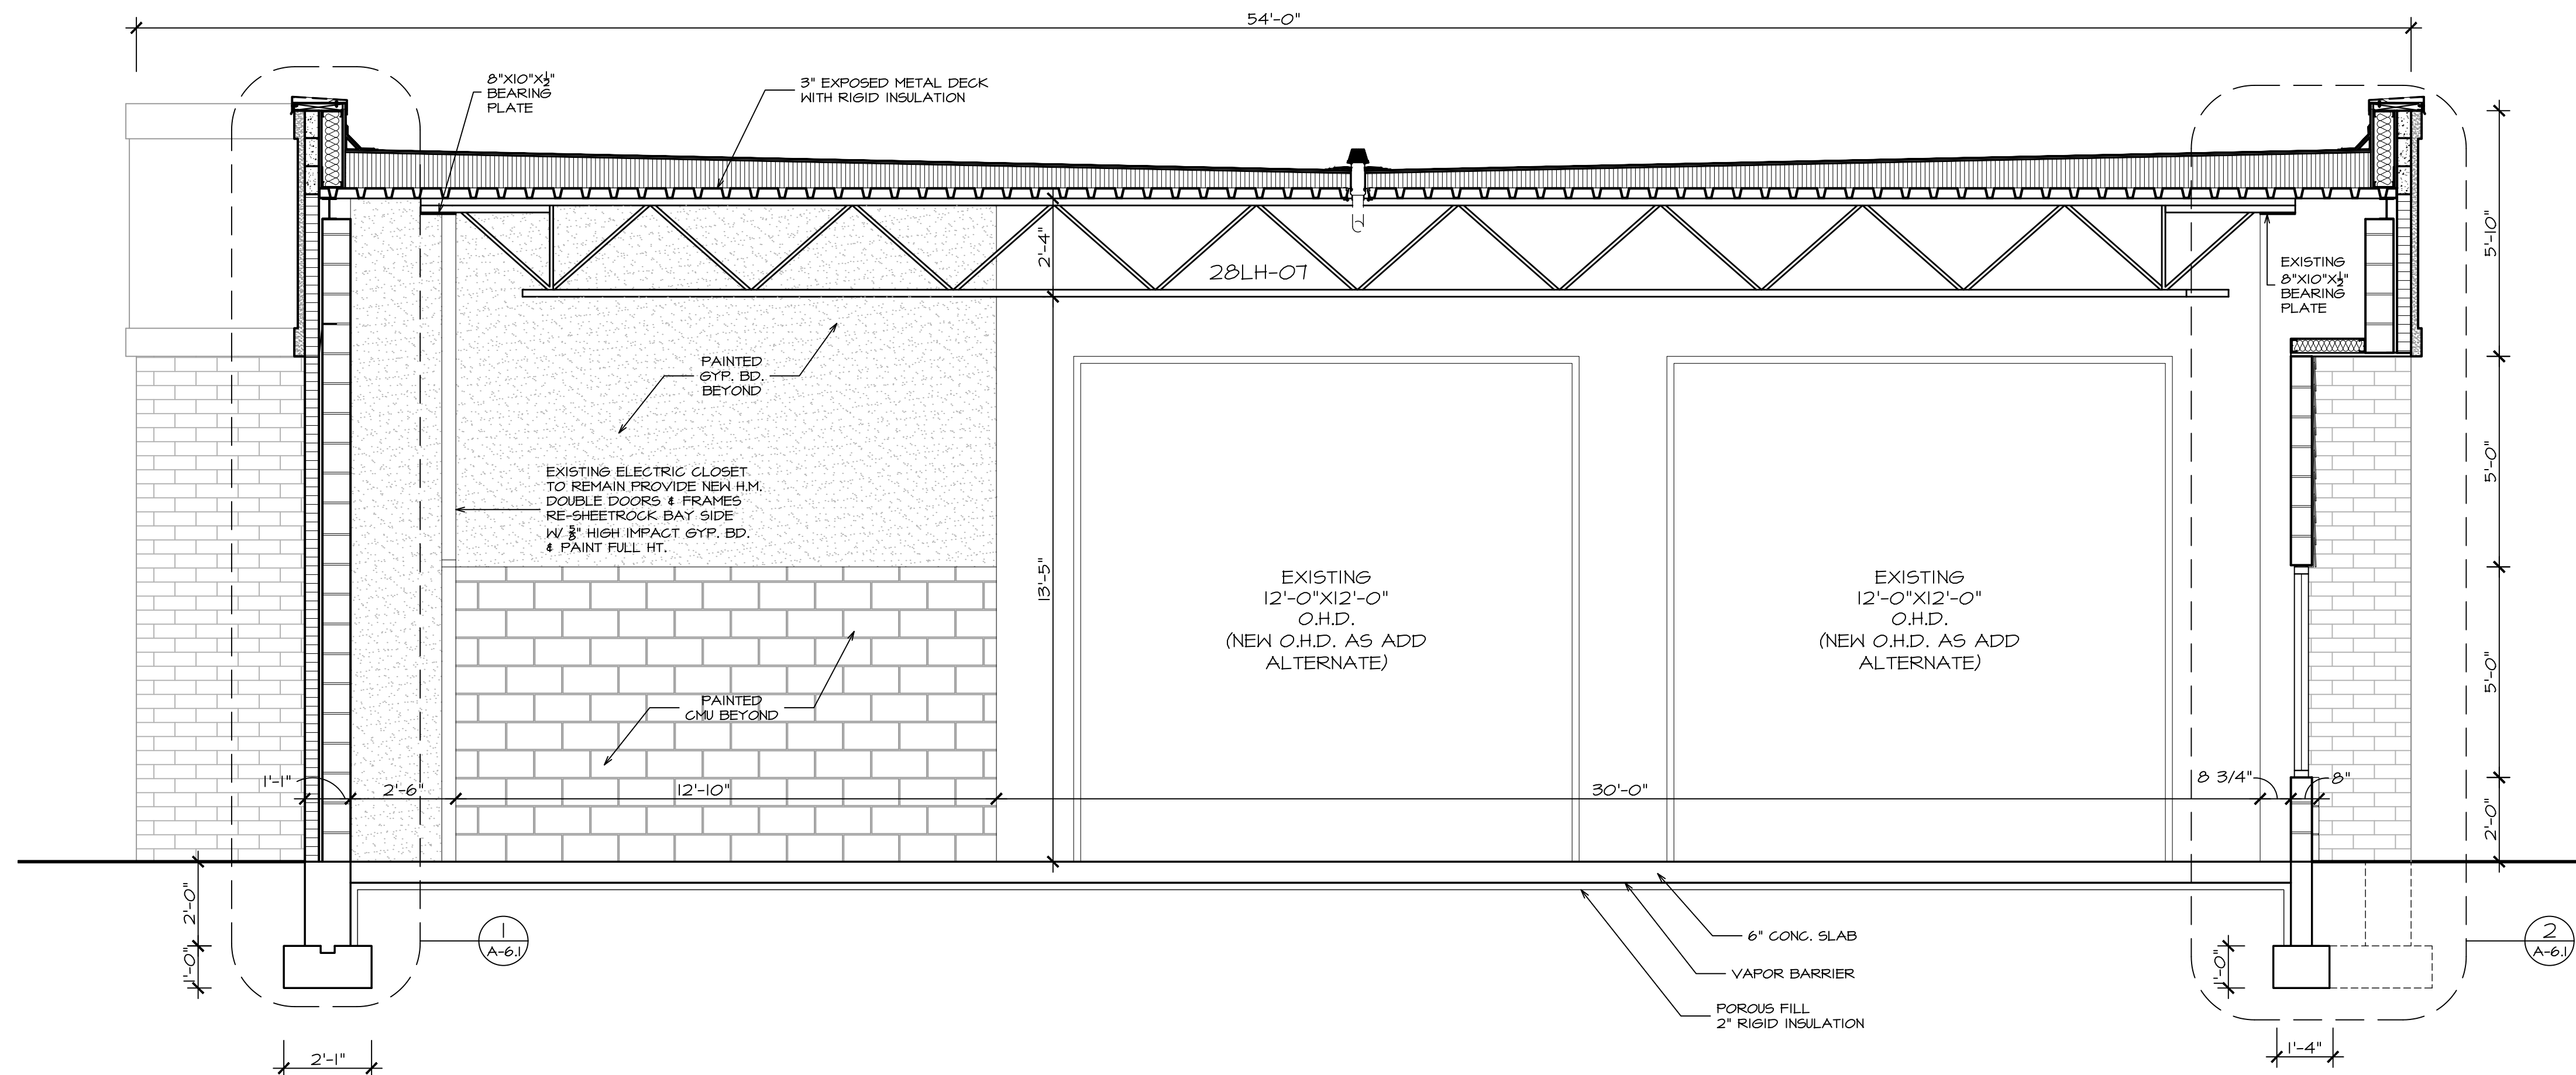

B SECTION
SCALE: 3/8" = 1'-0"

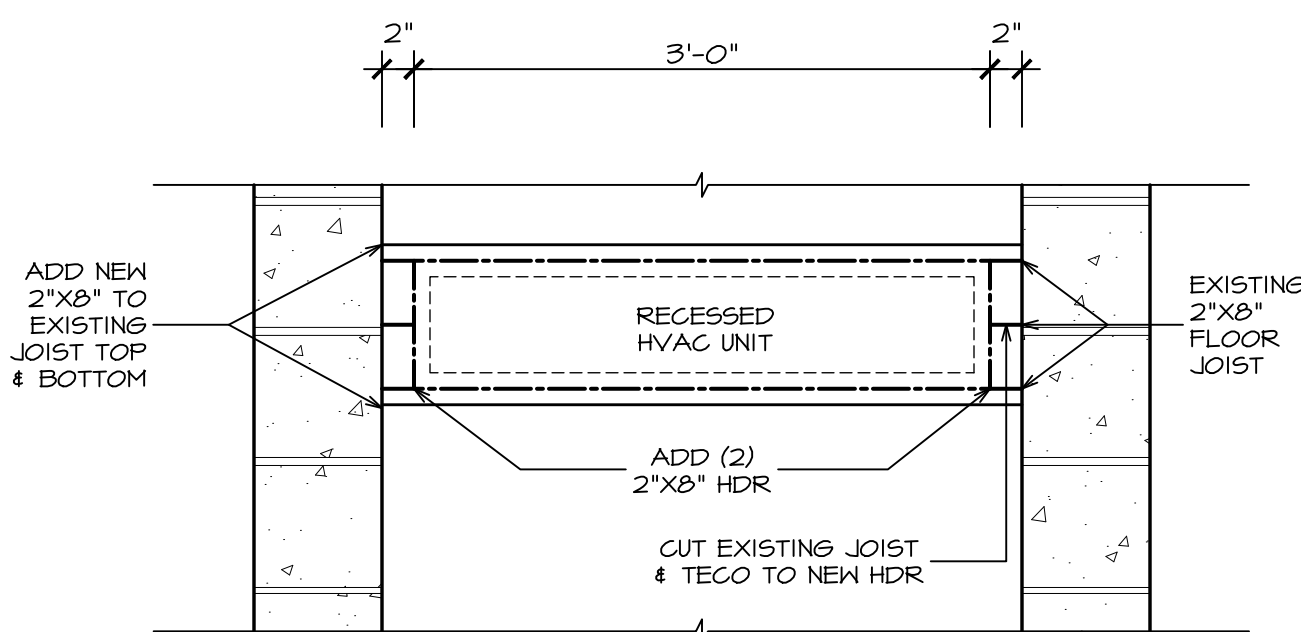

A-1 SECTION
SCALE: 1" = 1'-0"

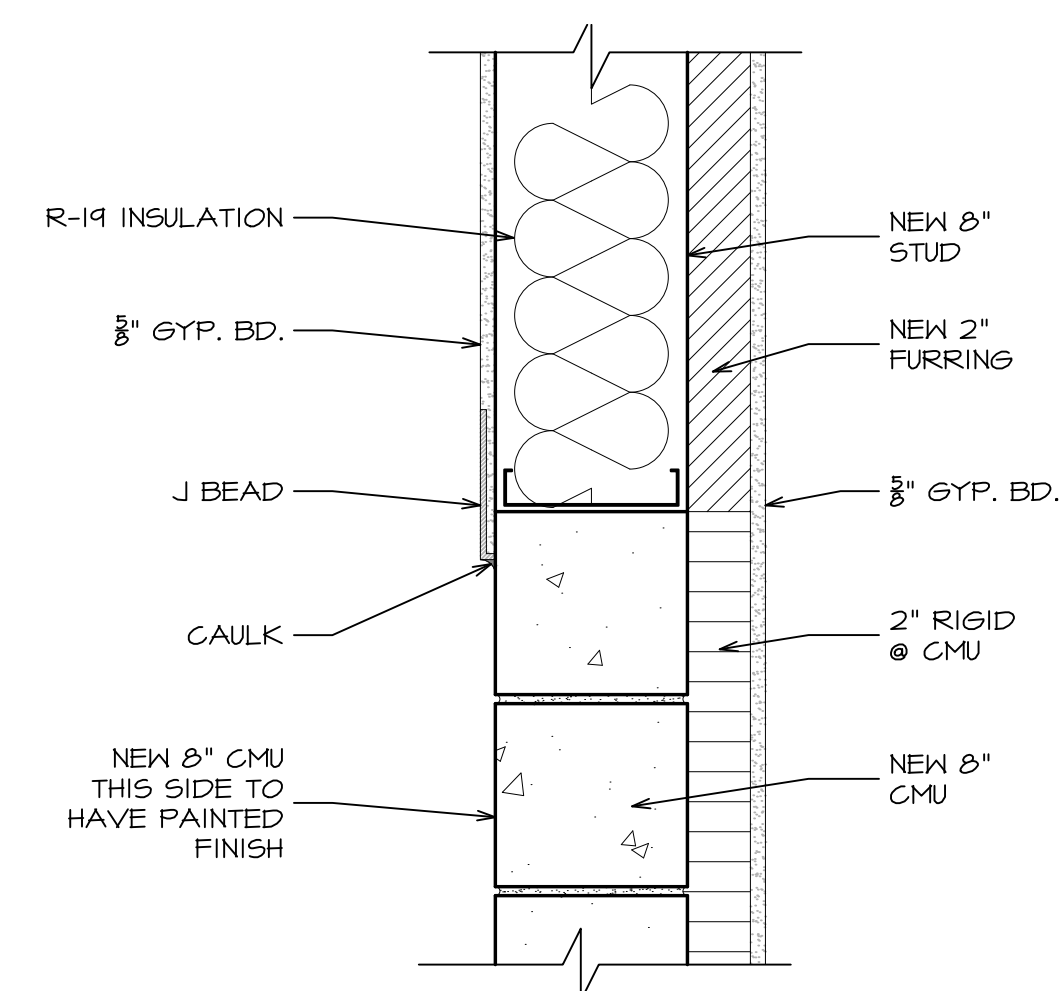

A-2 SECTION
SCALE: 1-1/2" = 1'-0"

DATE: ISSUE
07-20-2022 ISSUED
FOR BIDDING & PERMIT

SEAL:

SENDEWSKI ARCHITECTS PC
ARCHITECTS - PLANNERS
215 ROANOKE AVENUE
RIVERHEAD, NY 11901
(631) 727-5352
9 SELENA COURT
WALDEN, NY 12586
(845) 275-8859

TAPPAN FIRE DISTRICT
300 WESTERN HIGHWAY SOUTH
TAPPAN, NY 10983

SECTION & DETAILS

PROJECT #: 2108.01B


DRAWN BY: AR/JC

CAD FILE: 2108.01B/P-/BID


DRAWING#:

A=4.1



SUB STATION

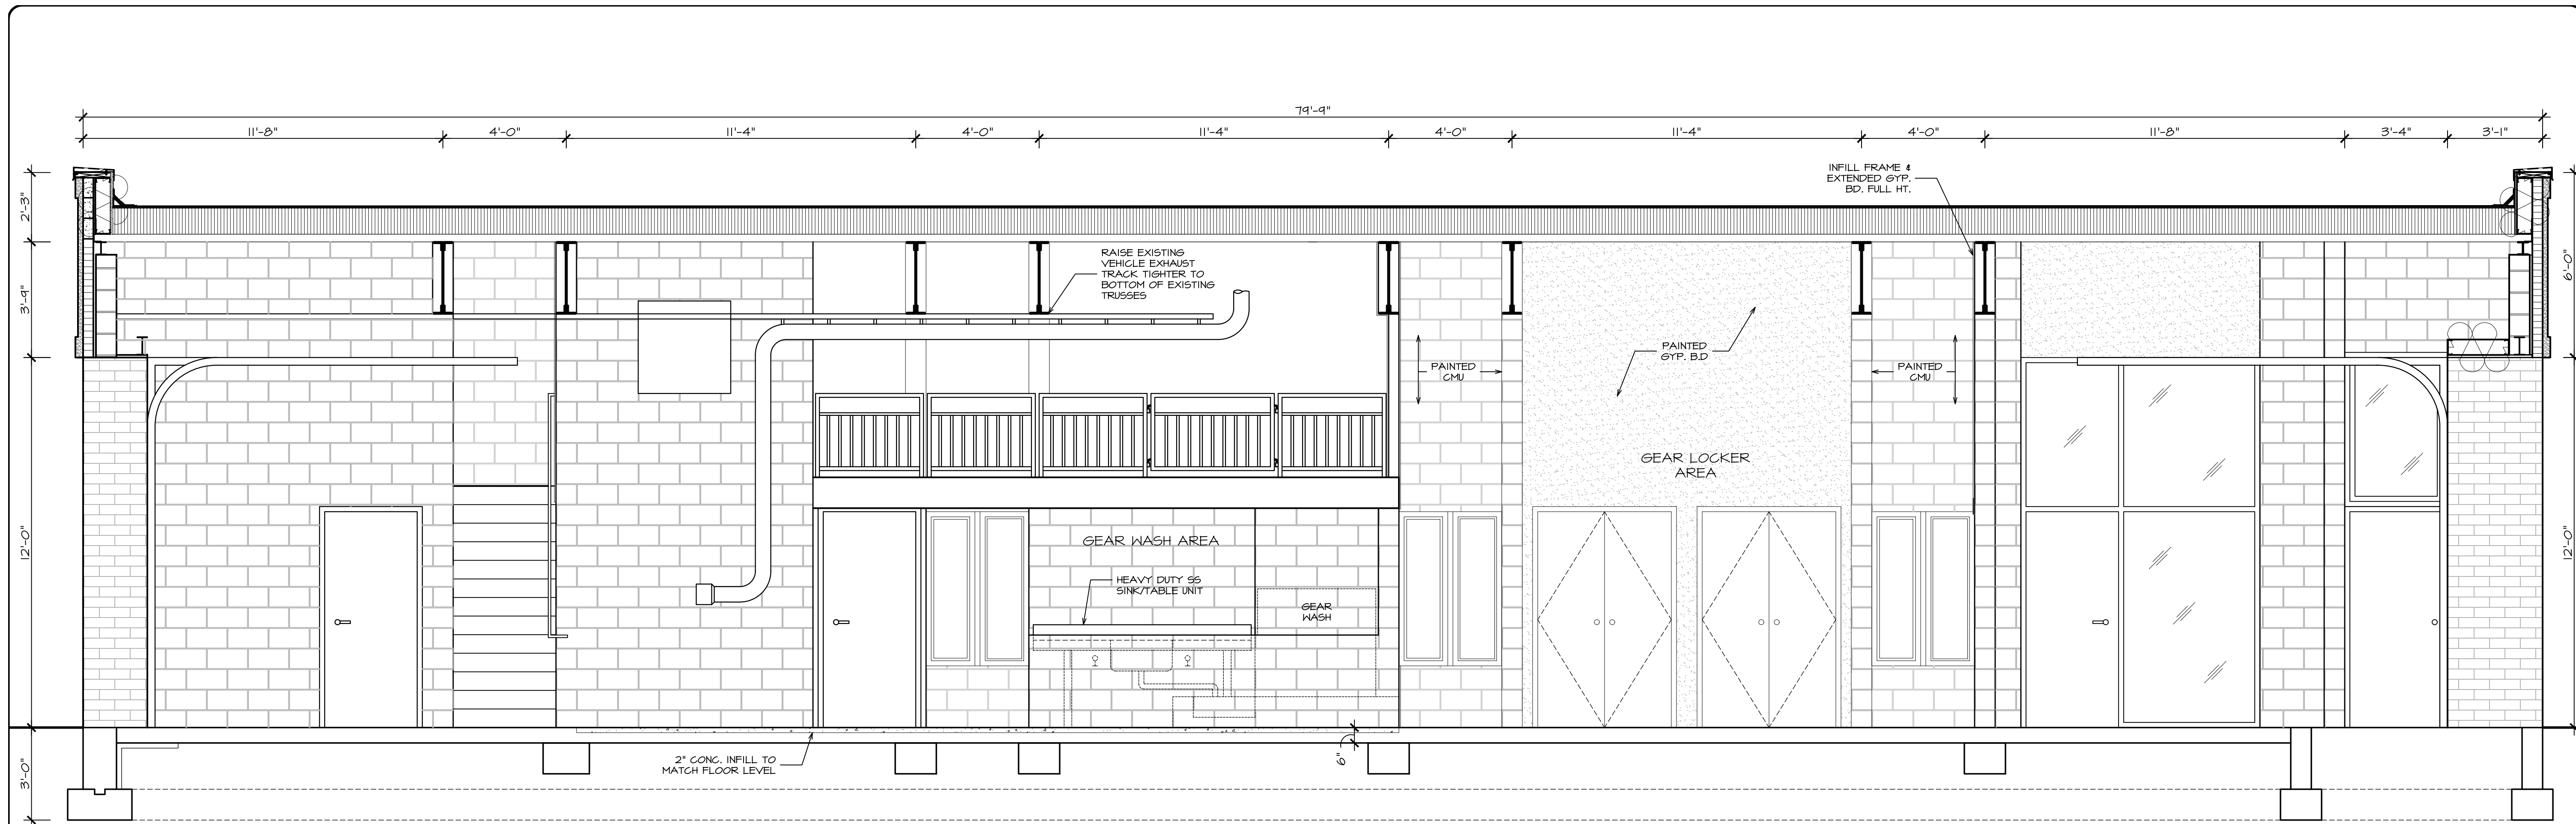


SECTION
SCALE: 3/8" = 1'-0"

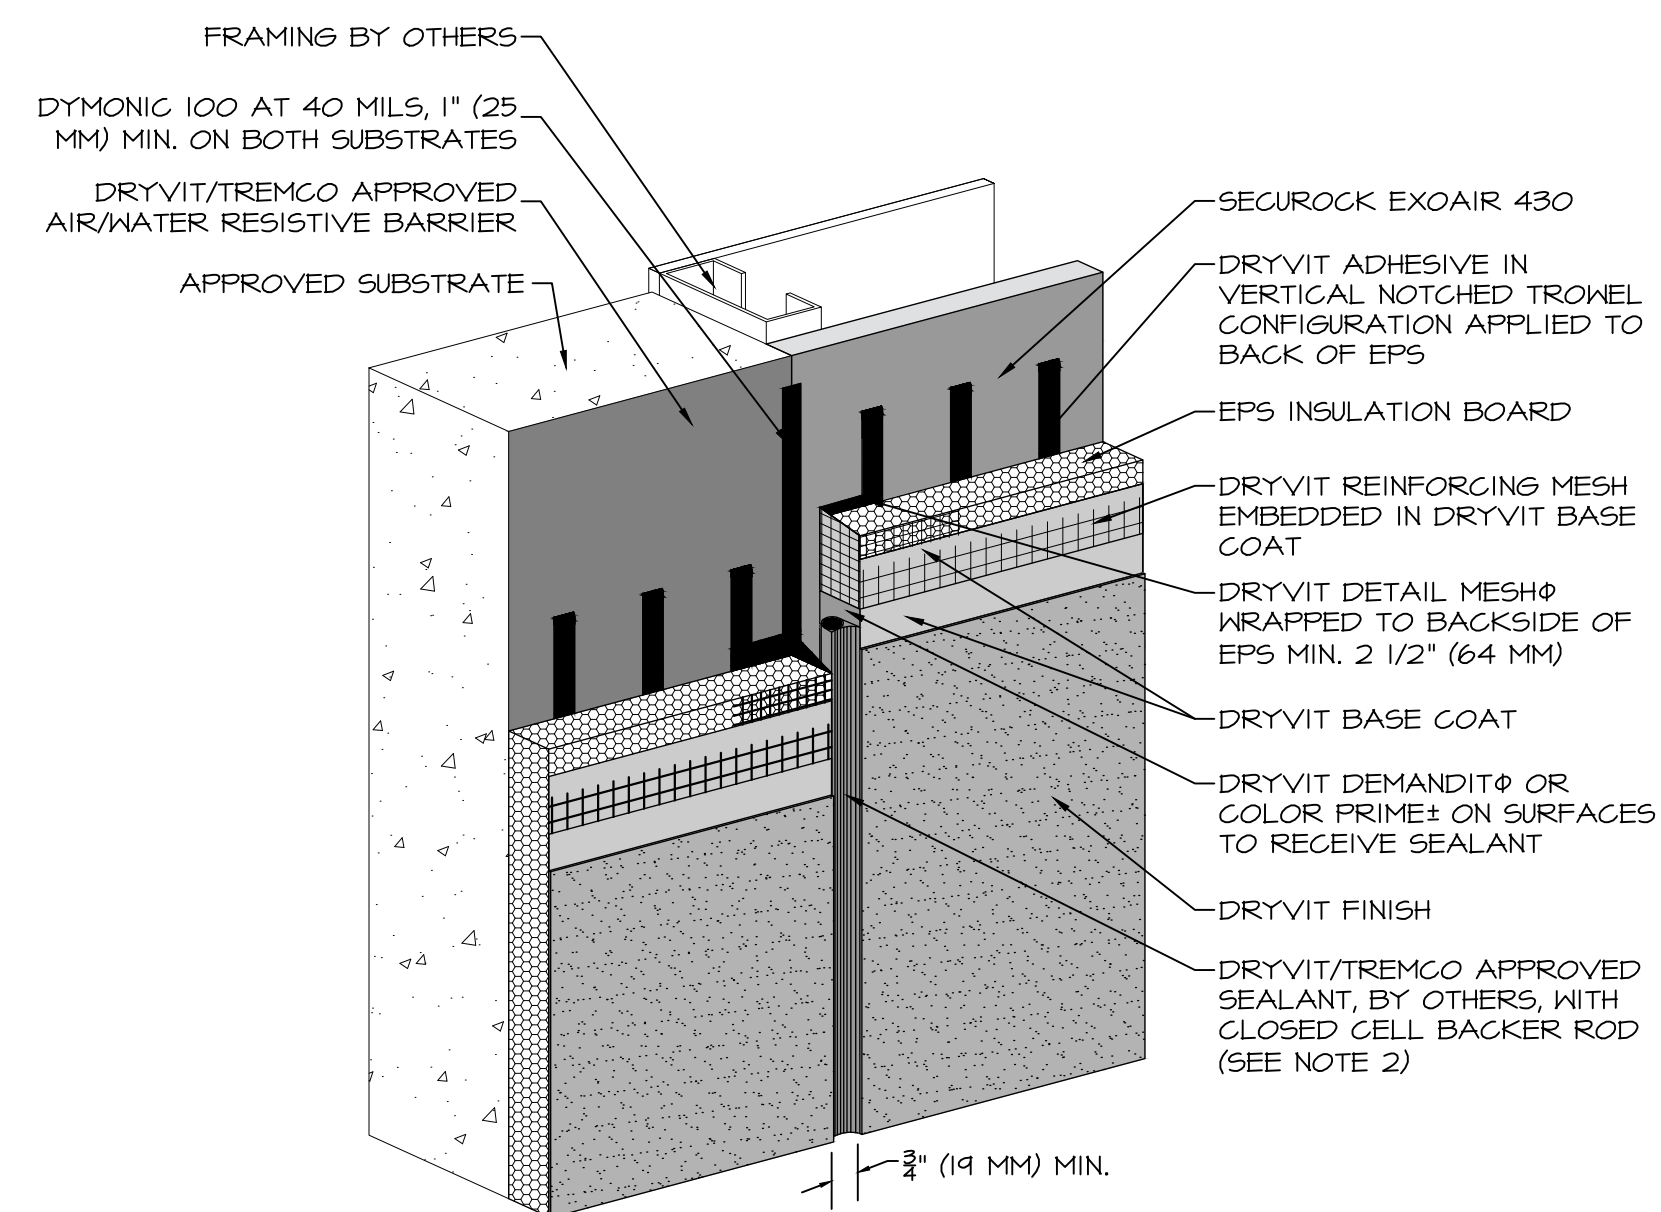


1 EIFS SYSTEM DETAILS
SCALE: 1-1/2" = 1'-0"

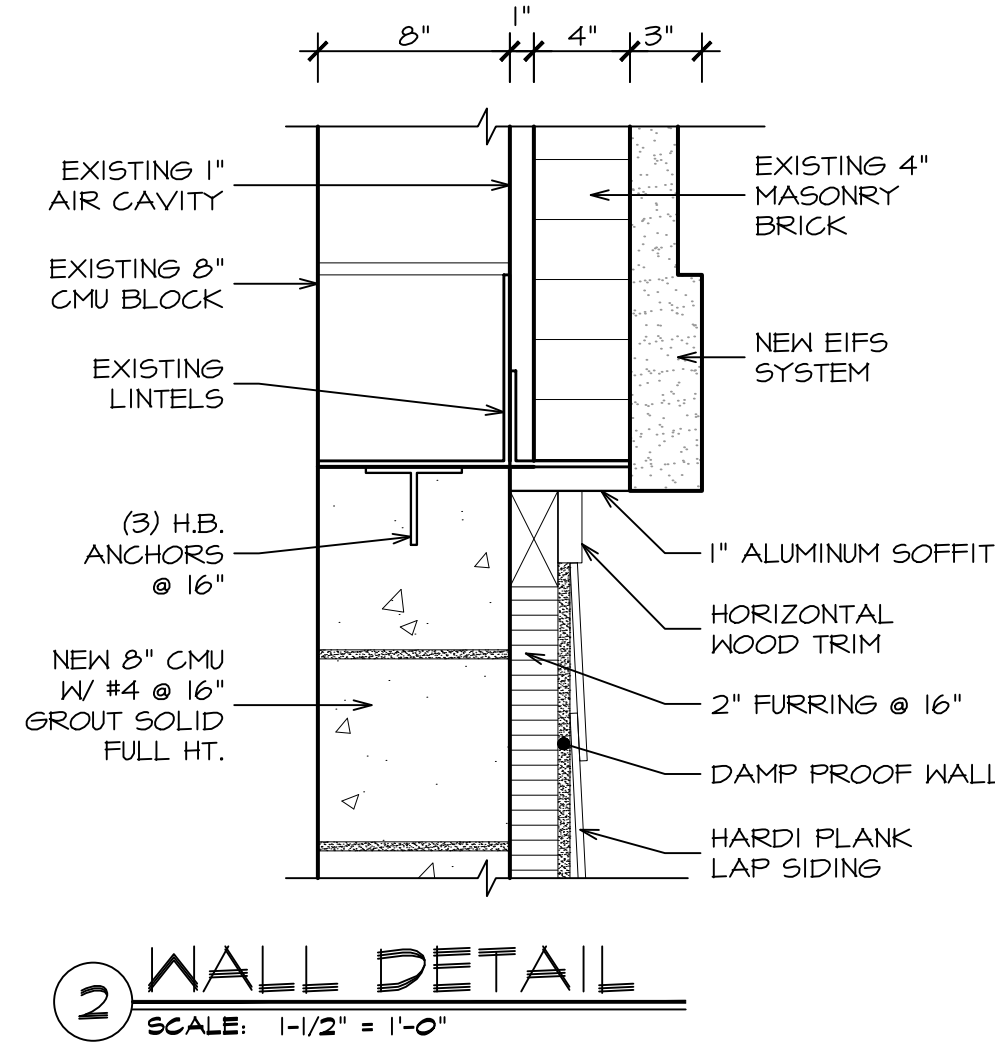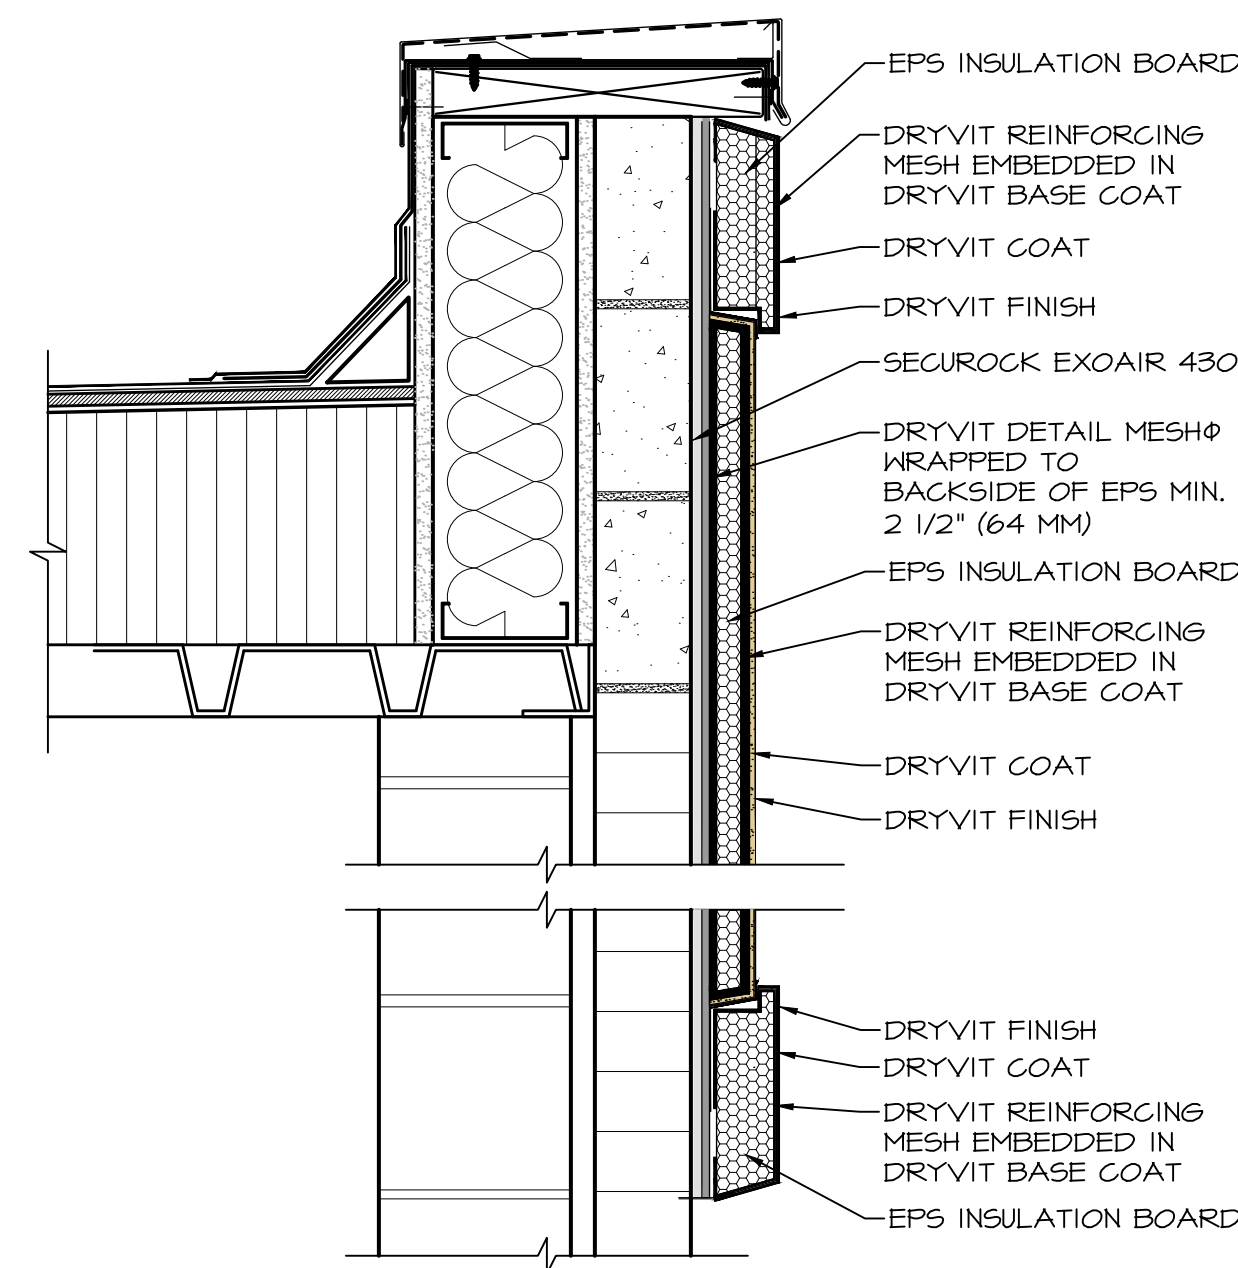

2 WALL DETAIL
SCALE: 1-1/2" = 1'-0"

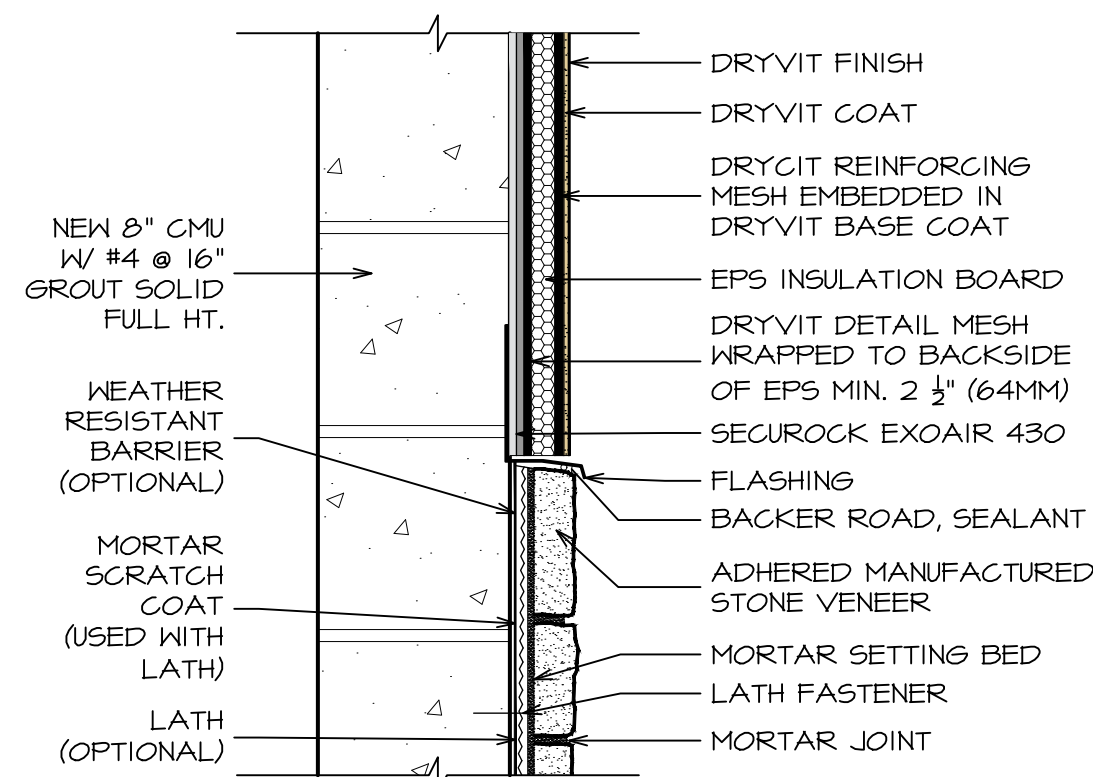

3 WALL DETAIL
SCALE: 1-1/2" = 1'-0"

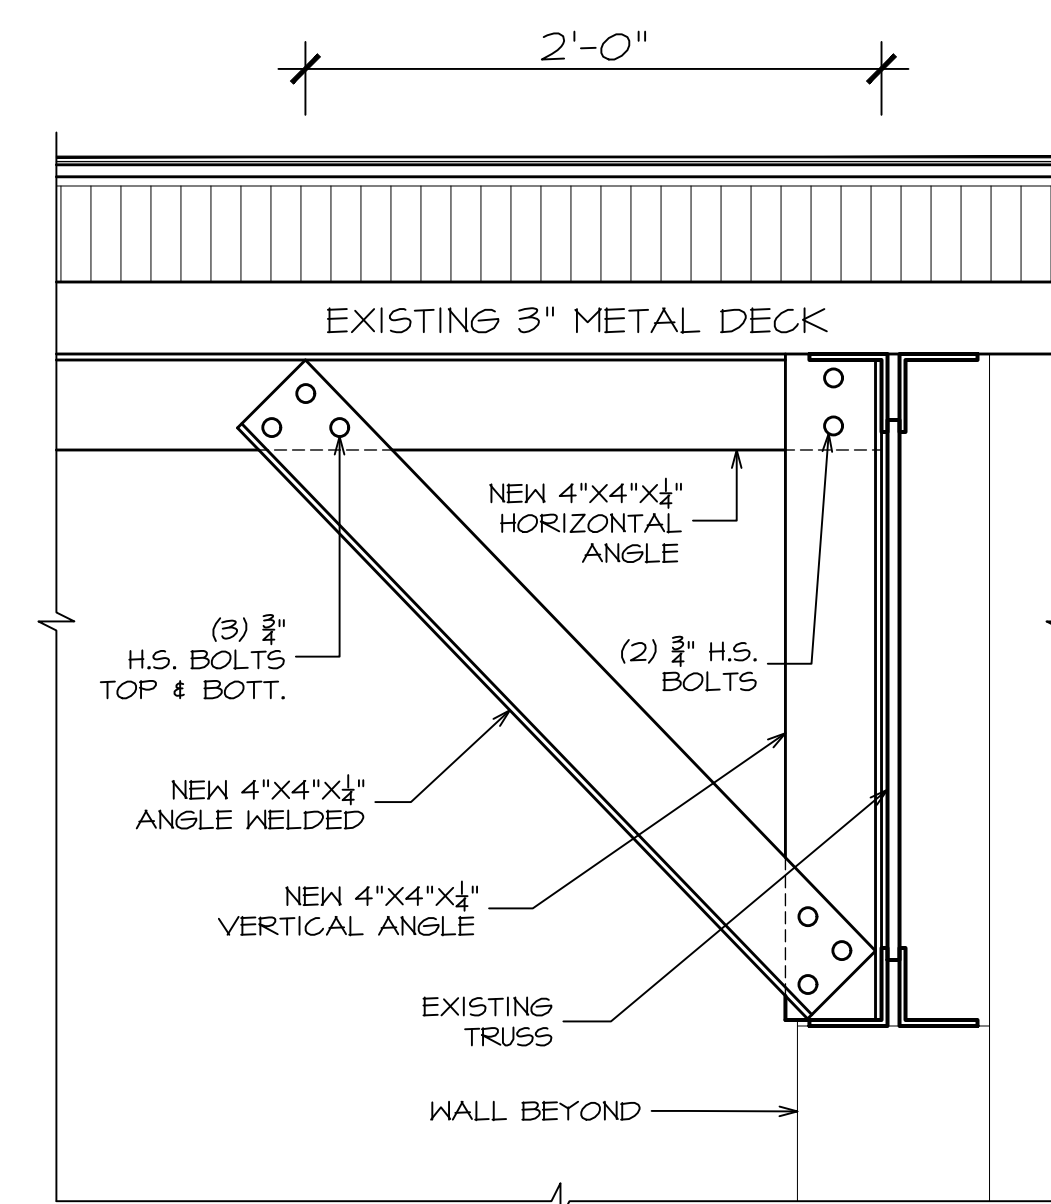

4 BRIDGING DETAIL
SCALE: 1-1/2" = 1'-0"

DATE: ISSUE
07-20-2022 ISSUED
FOR BIDDING & PERMIT

SEAL:

SENDEWSKI ARCHITECTS PC
ARCHITECTS - PLANNERS
215 ROANOKE AVENUE
RIVERHEAD, NY 11901
(631) 727-5352
9 SELENA COURT
WALDEN, NY 12586
(845) 275-8859

TAPPAN FIRE DISTRICT
300 WESTERN HIGHWAY SOUTH
TAPPAN, NY 10983

SECTION & DETAILS

PROJECT #: 2108.01B

DRAWN BY: AR/JC


CAD FILE: 2108.01B/P./BID

DRAWING#:


A=4.2

SUB STATION


SUB STATION

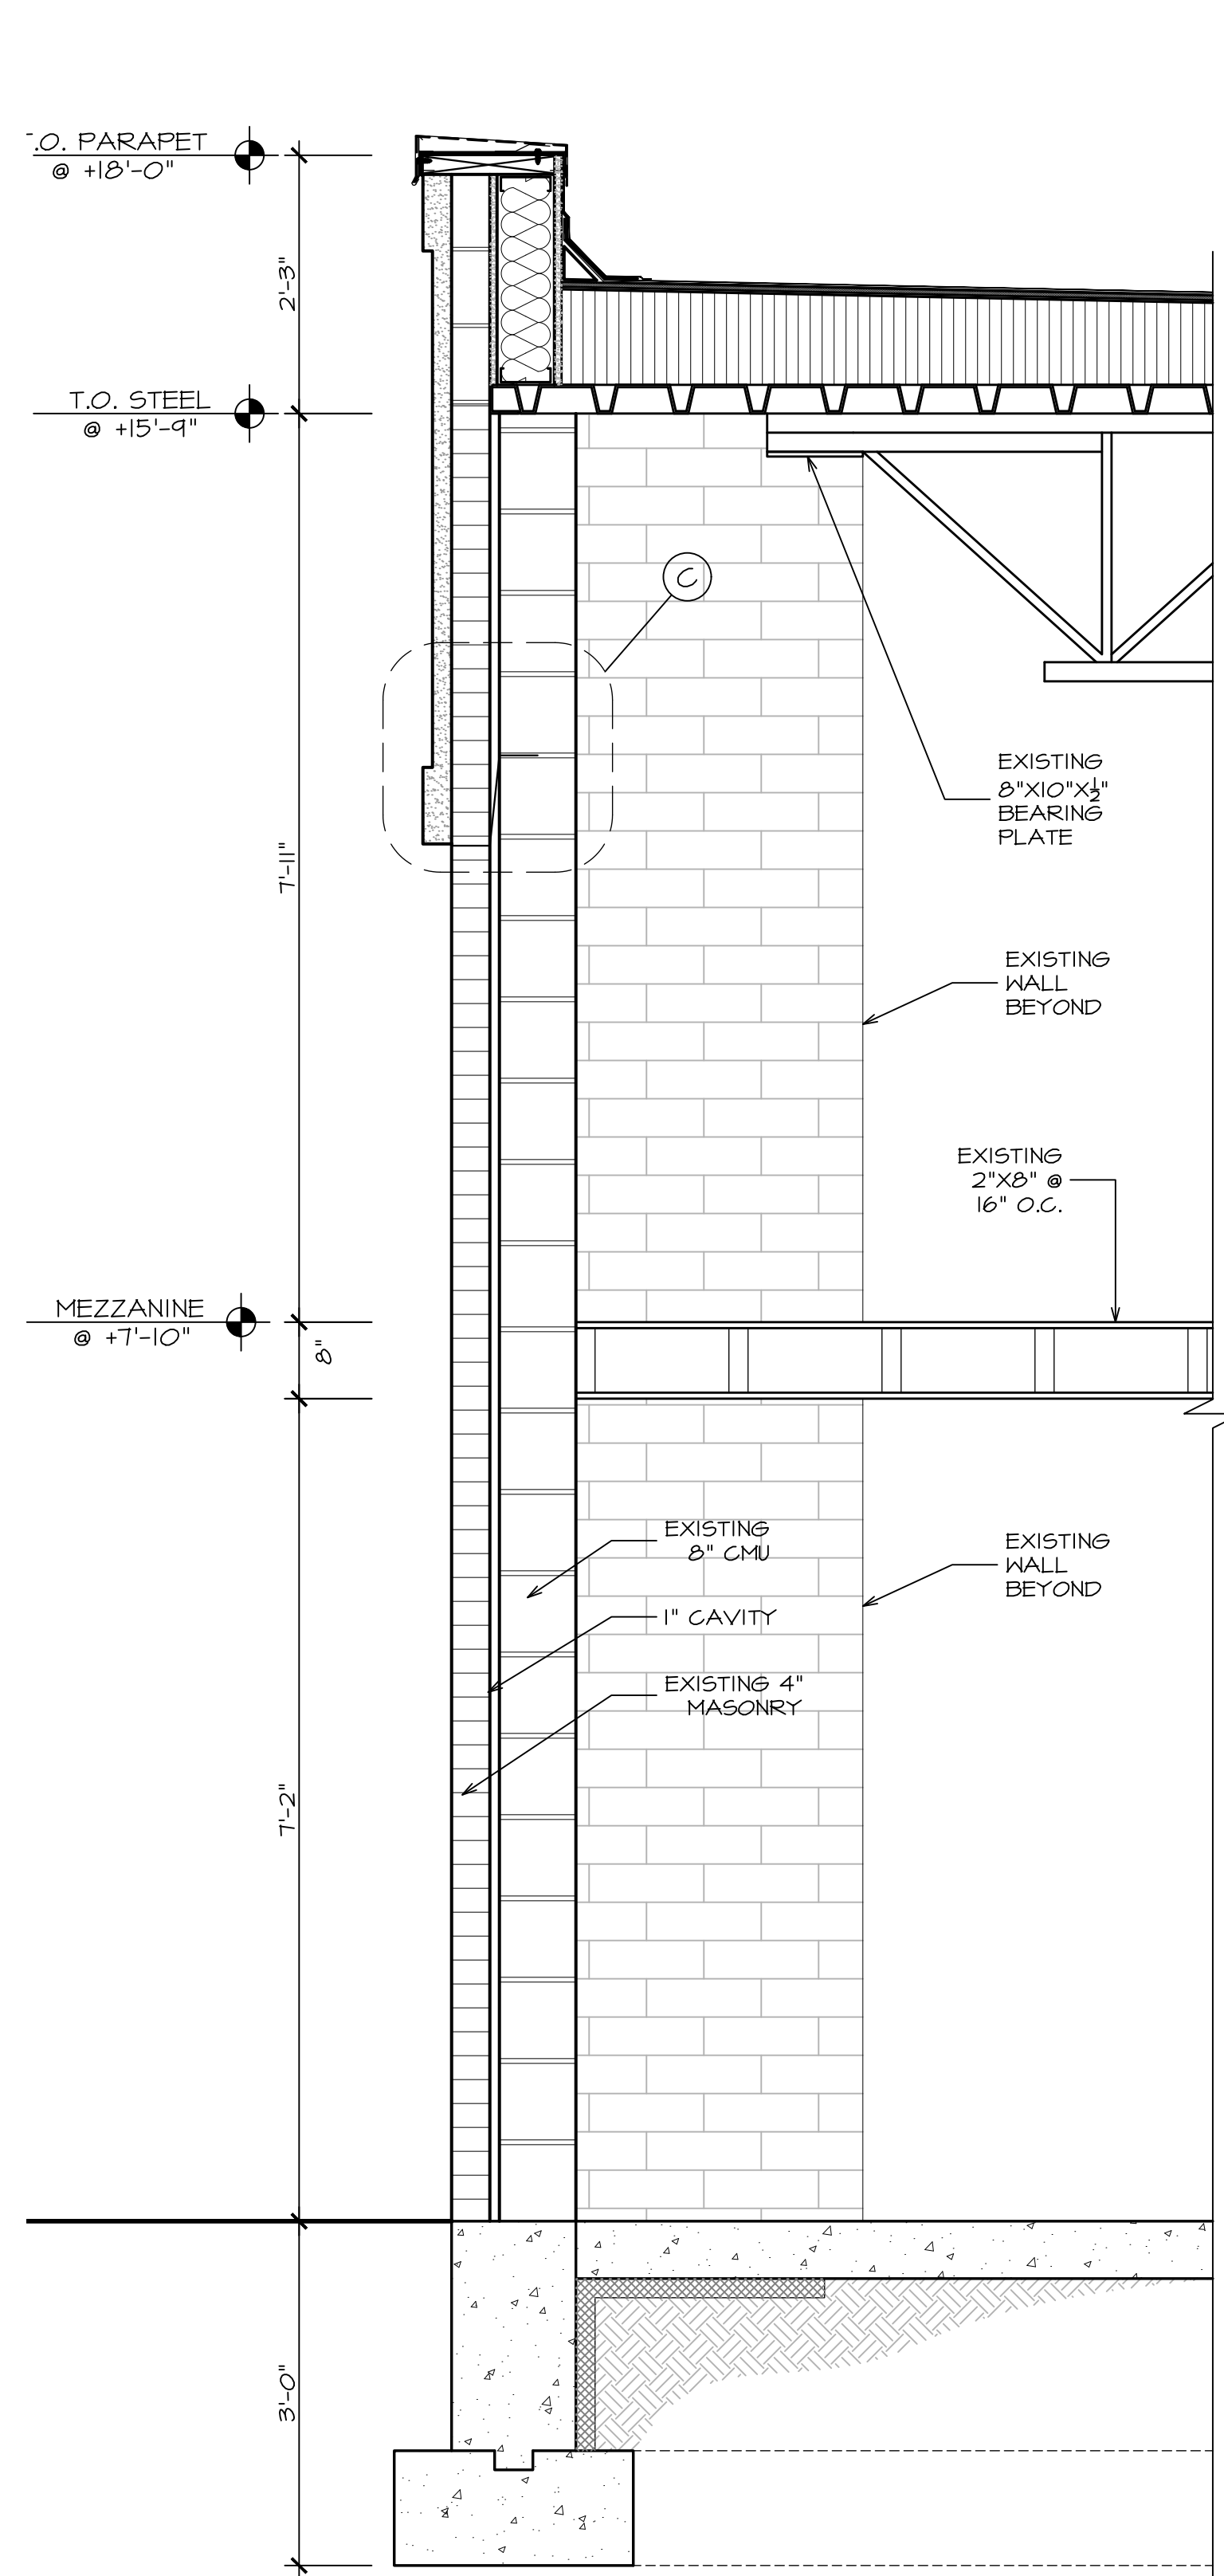


1 WALL SECTION
SCALE: 3/4" = 1'-0"

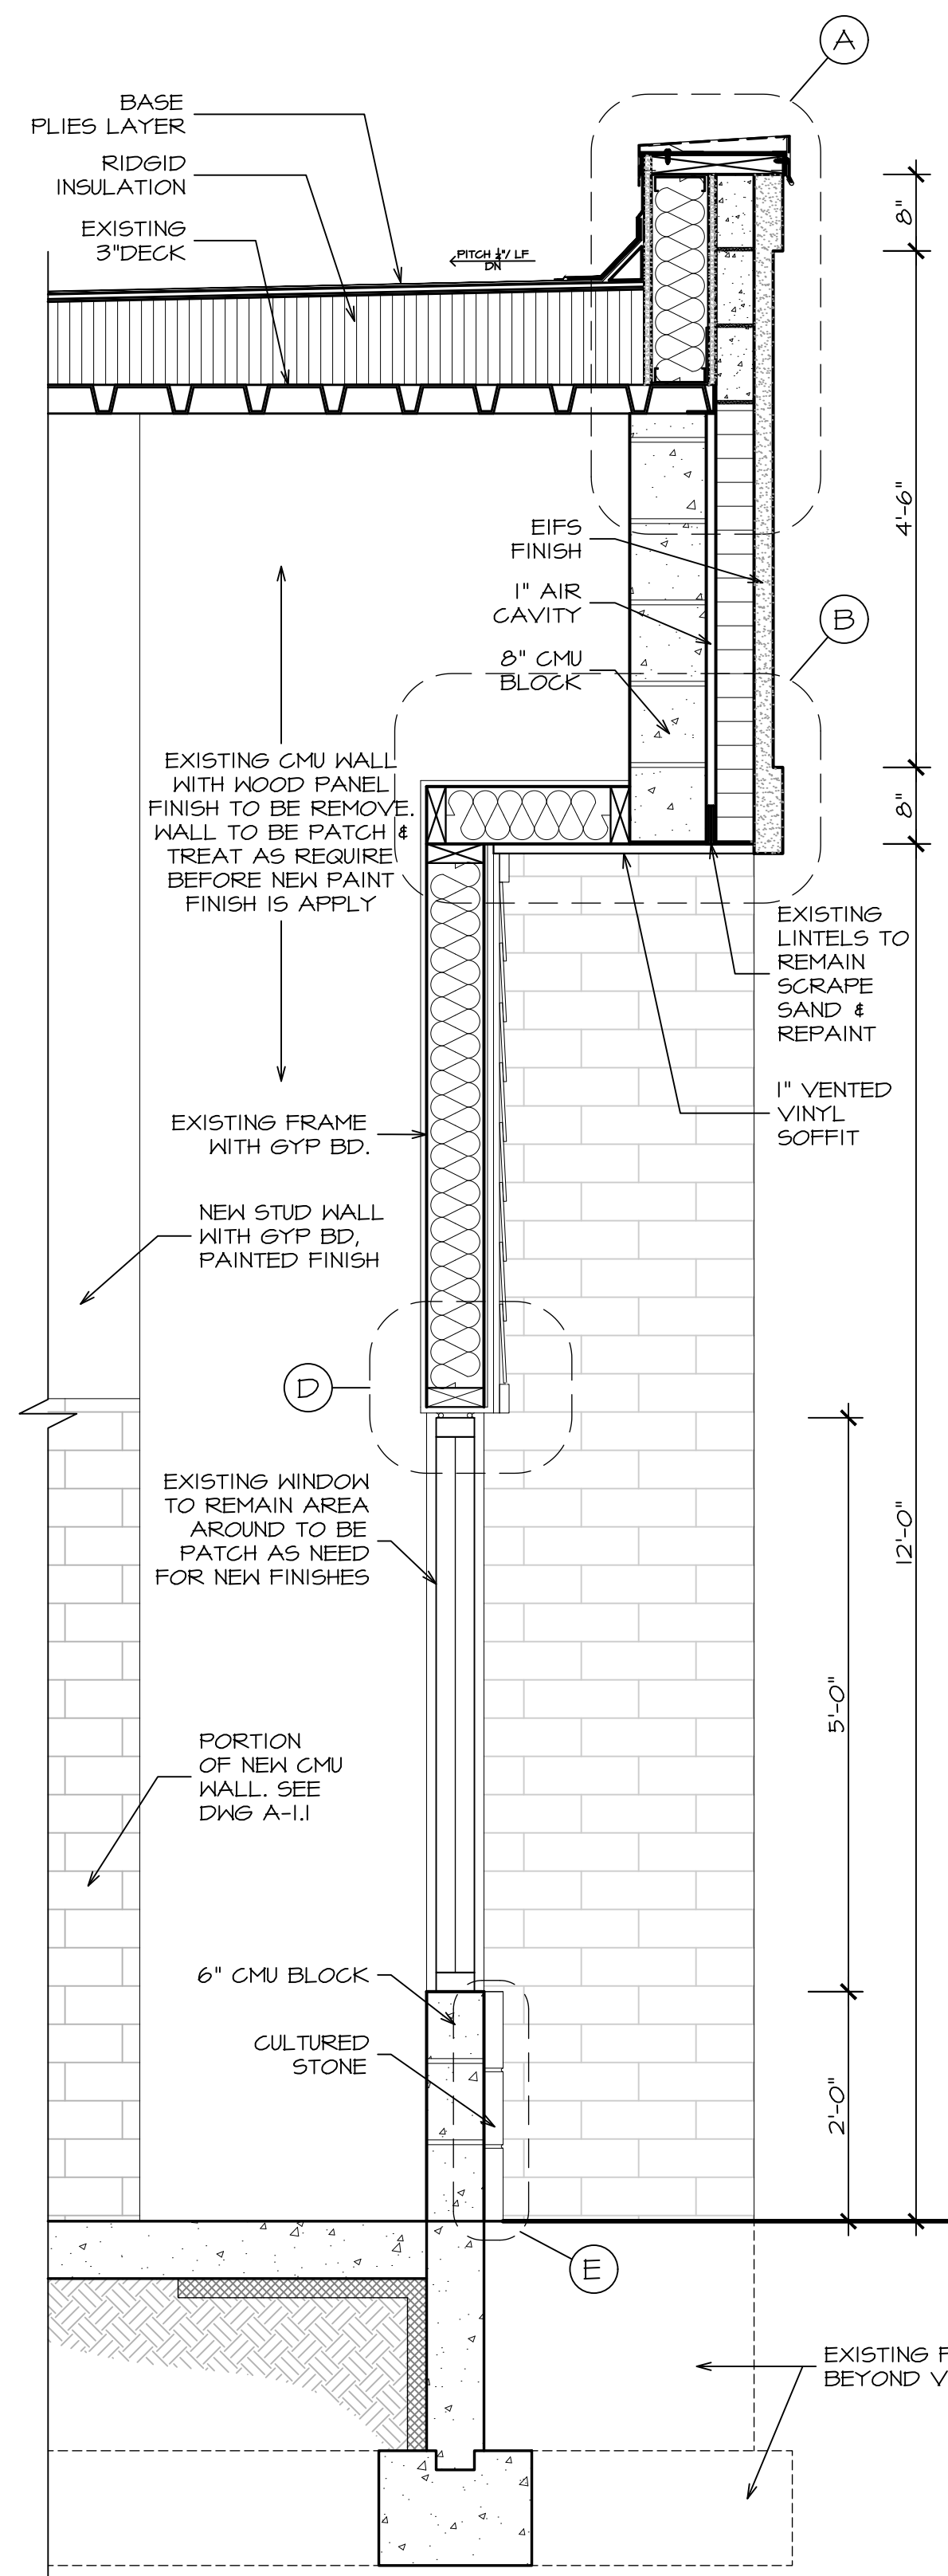


2 WALL SECTION
SCALE: 3/4" = 1'-0"

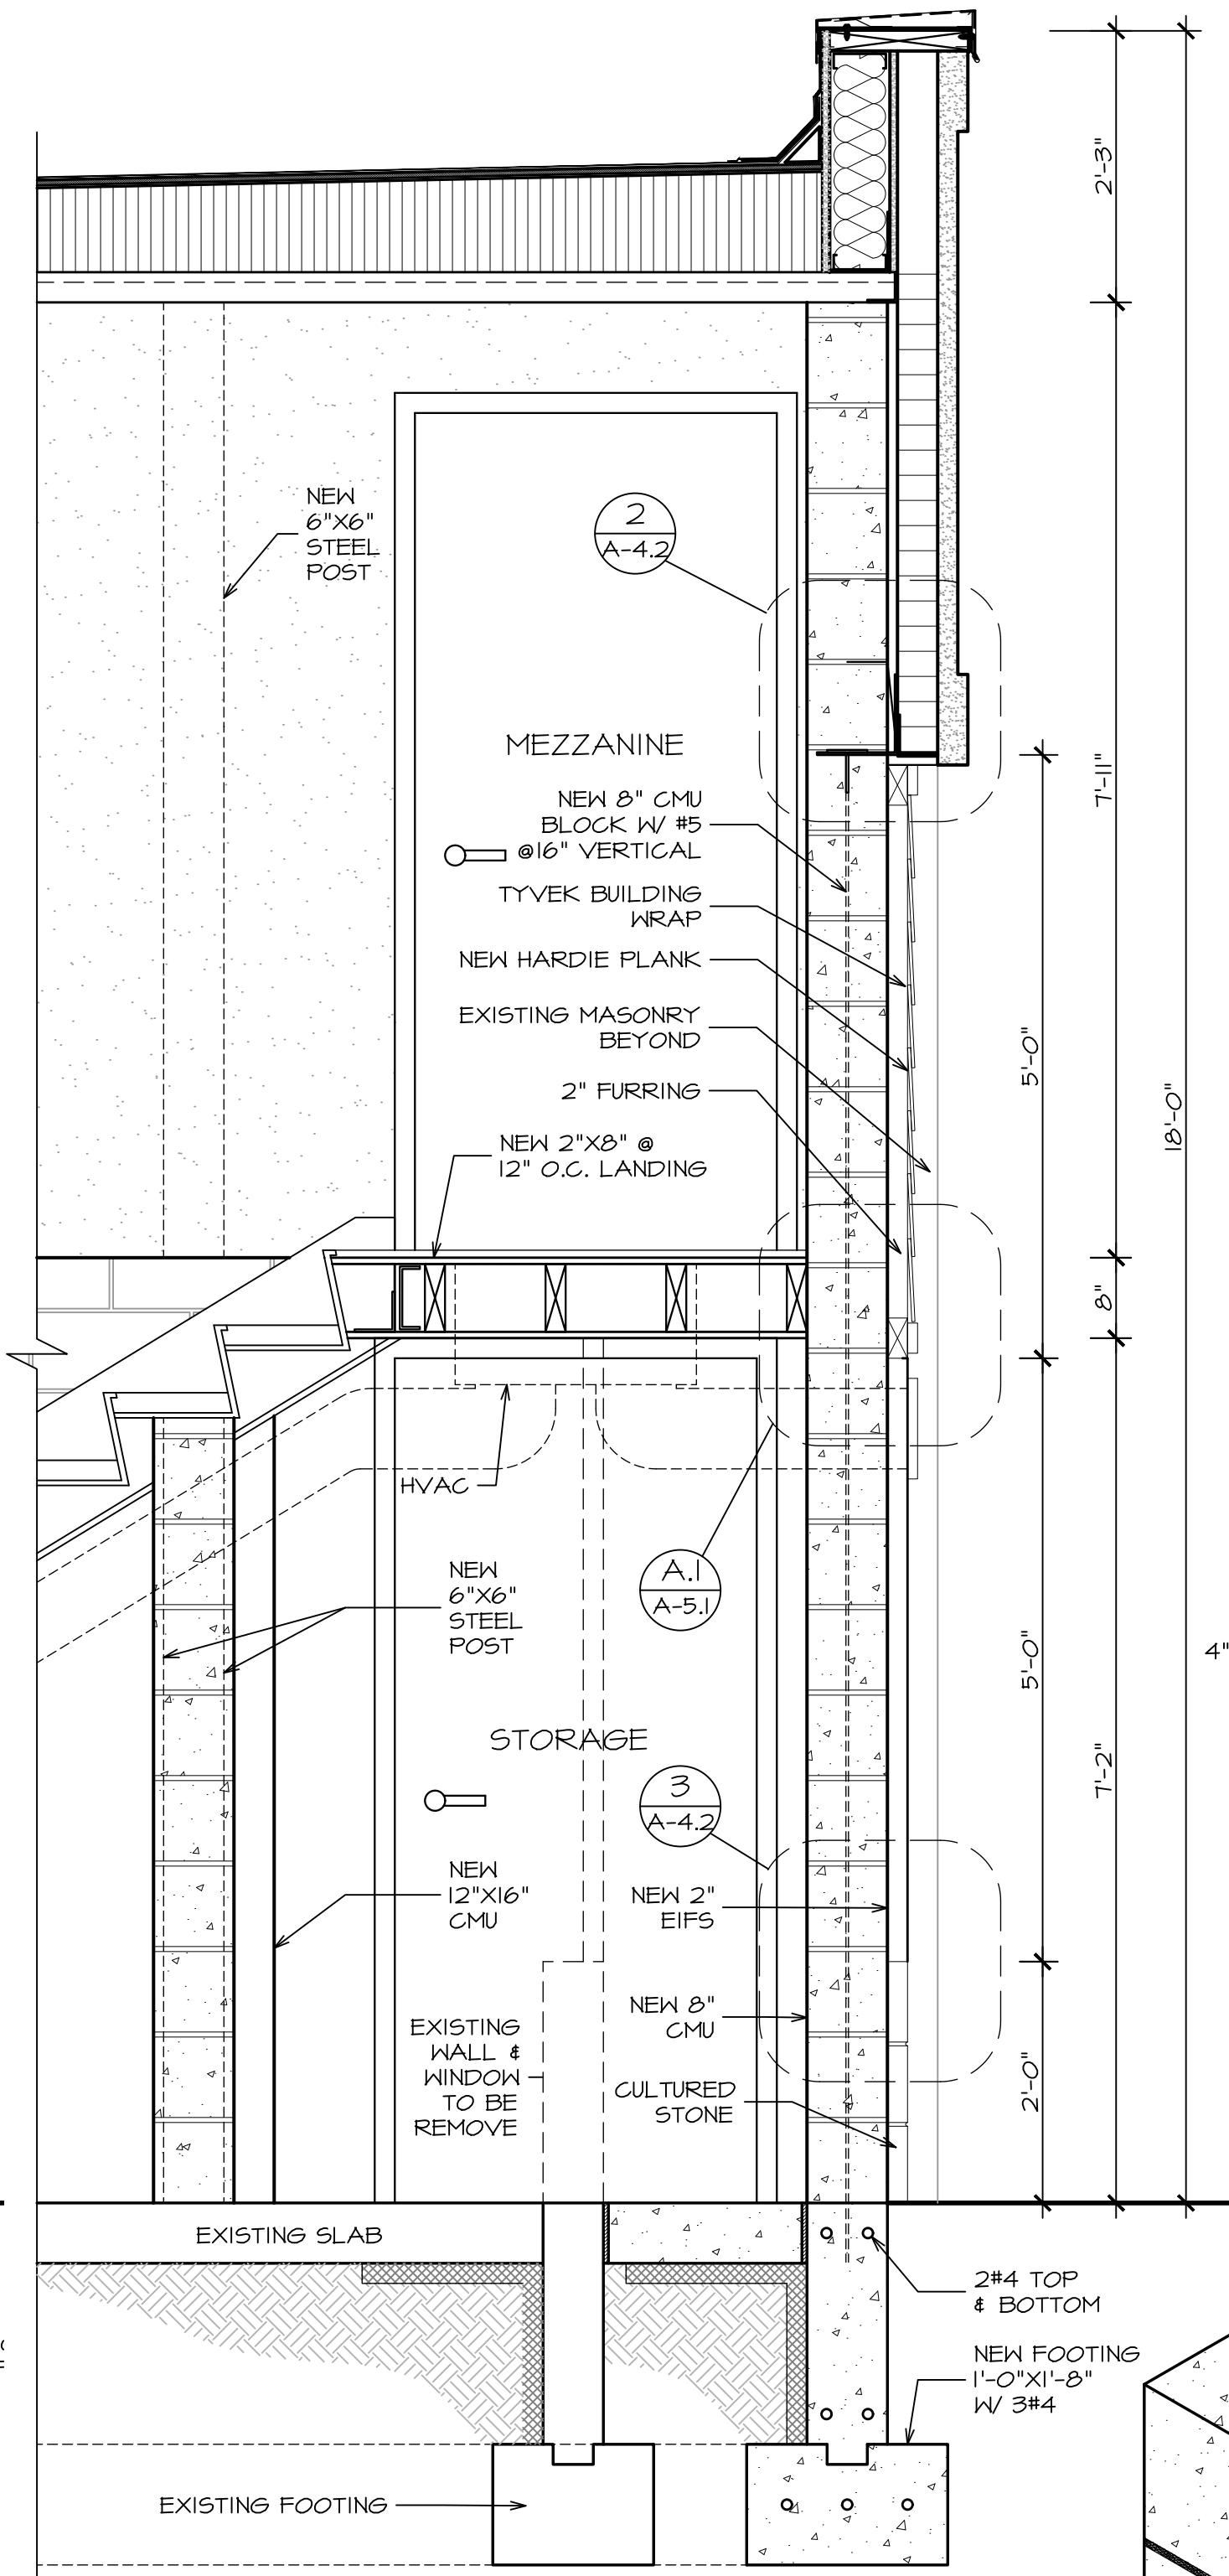


3 WALL SECTION
SCALE: 3/4" = 1'-0"
*NOTE: FOR HVAC REFER TO DETAIL A-1 ON DRAWING 4.1

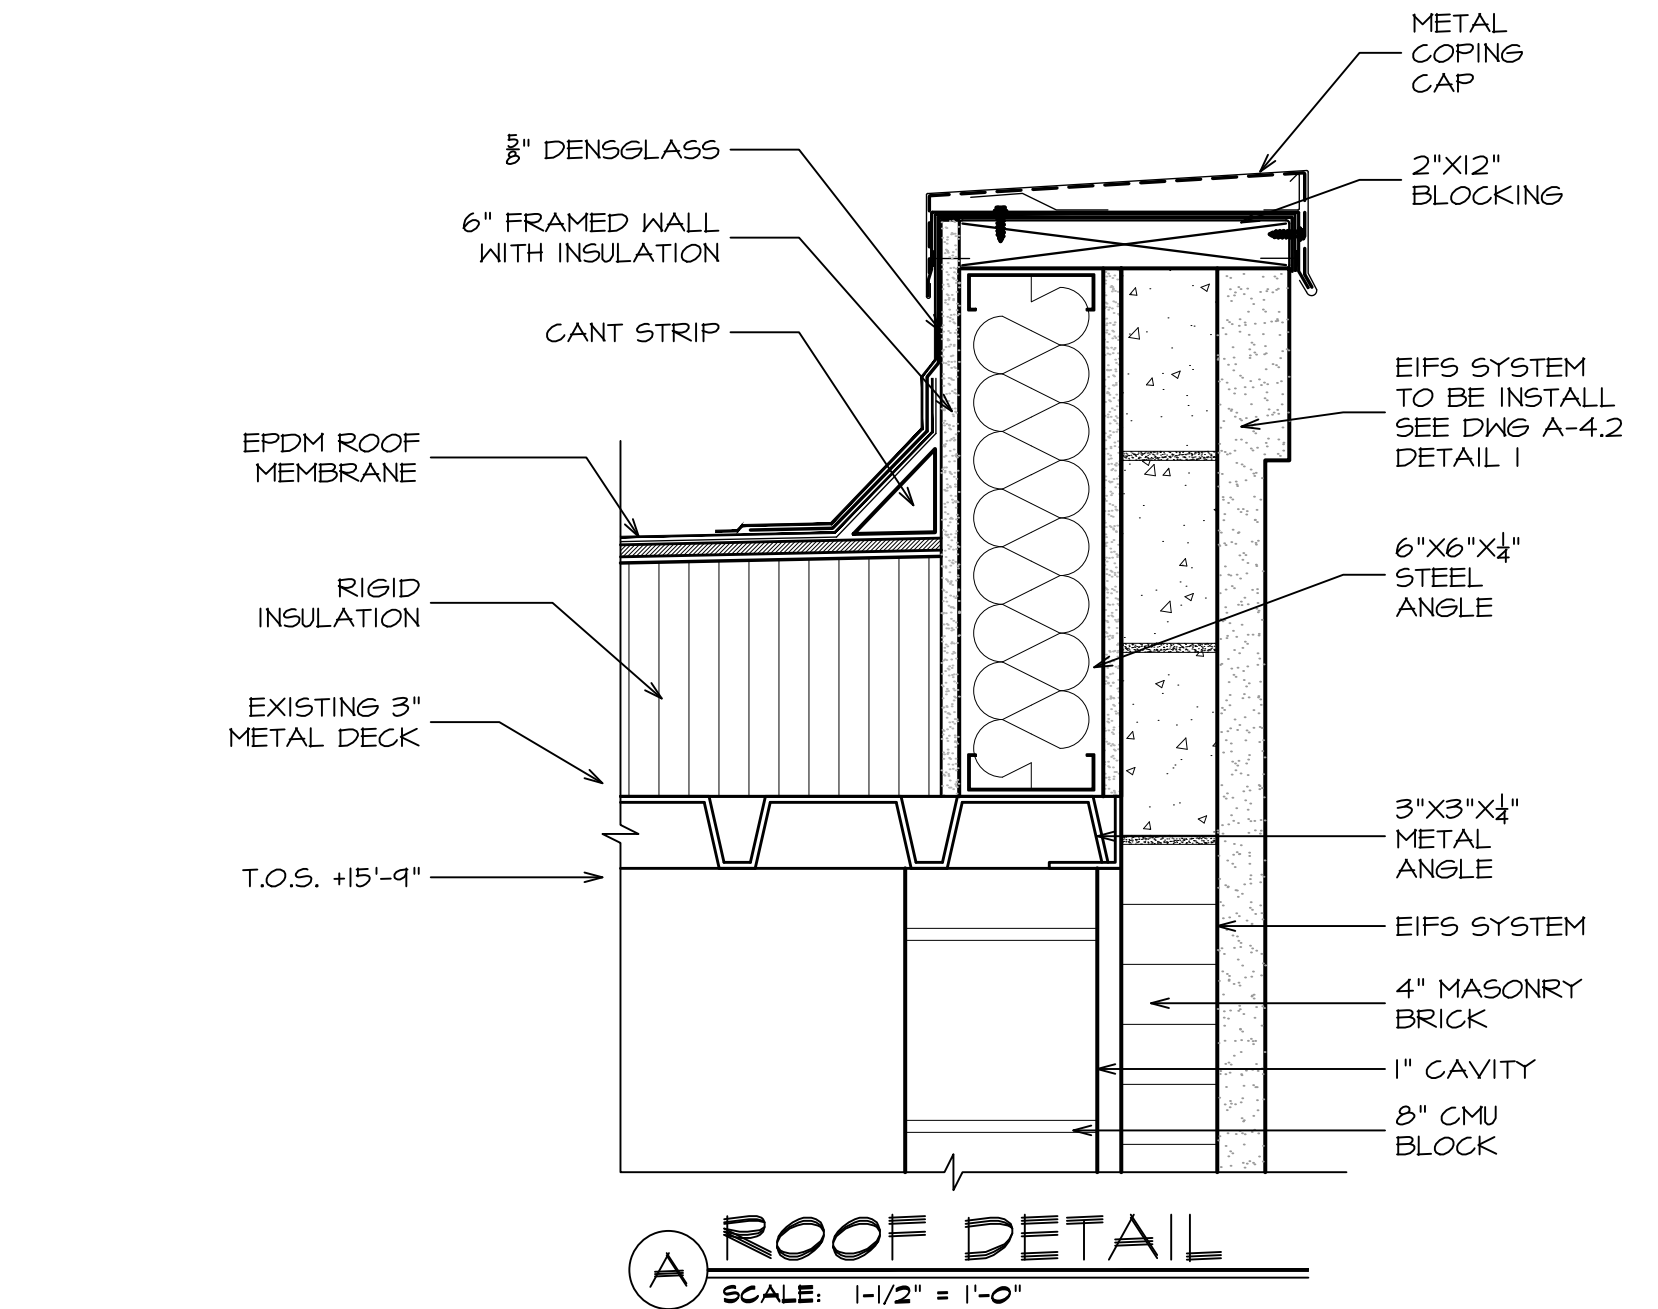


A ROOF DETAIL
SCALE: 1-1/2" = 1'-0"

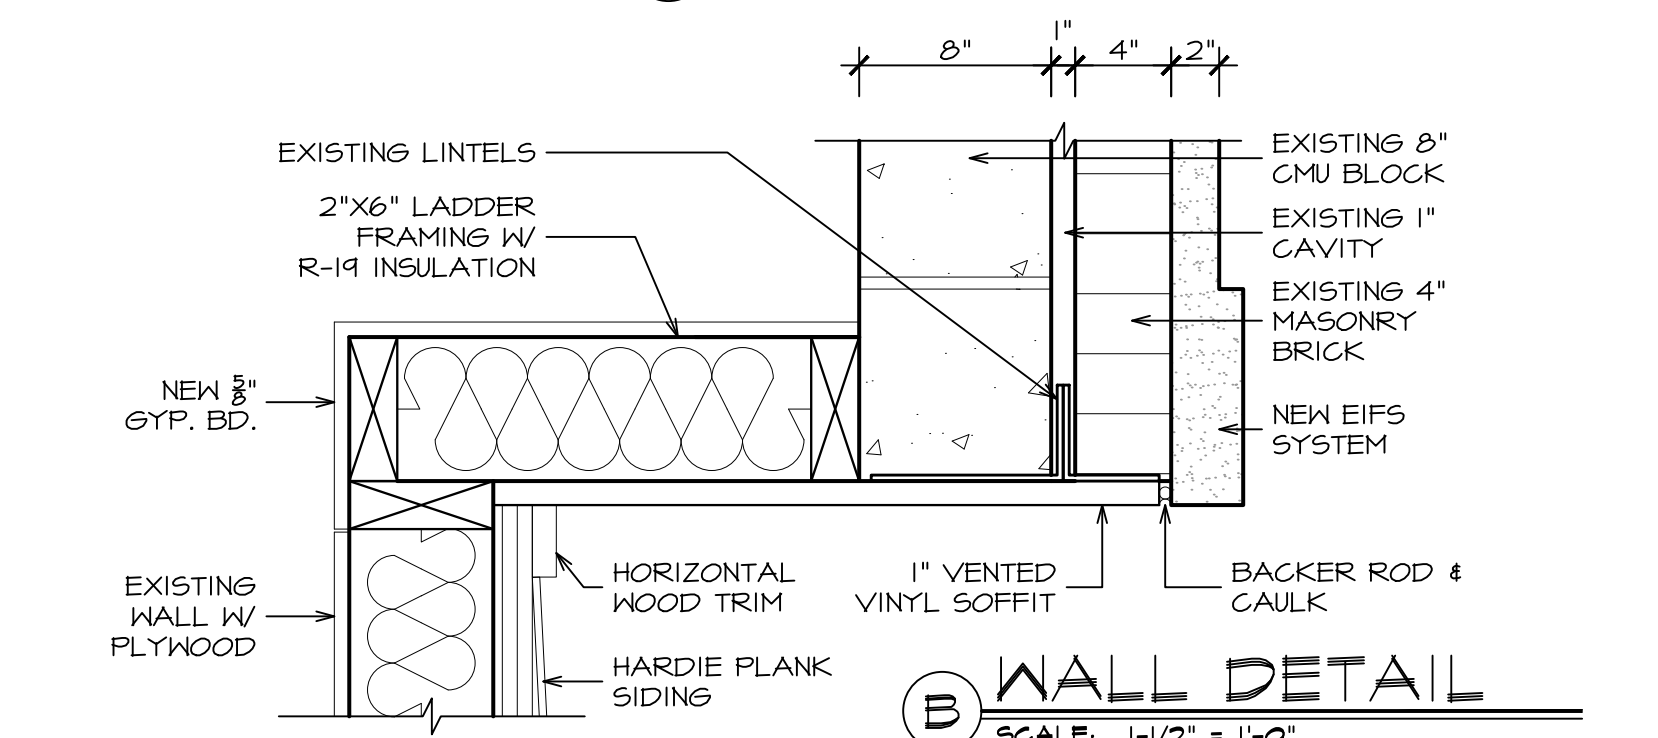


B WALL DETAIL
SCALE: 1-1/2" = 1'-0"

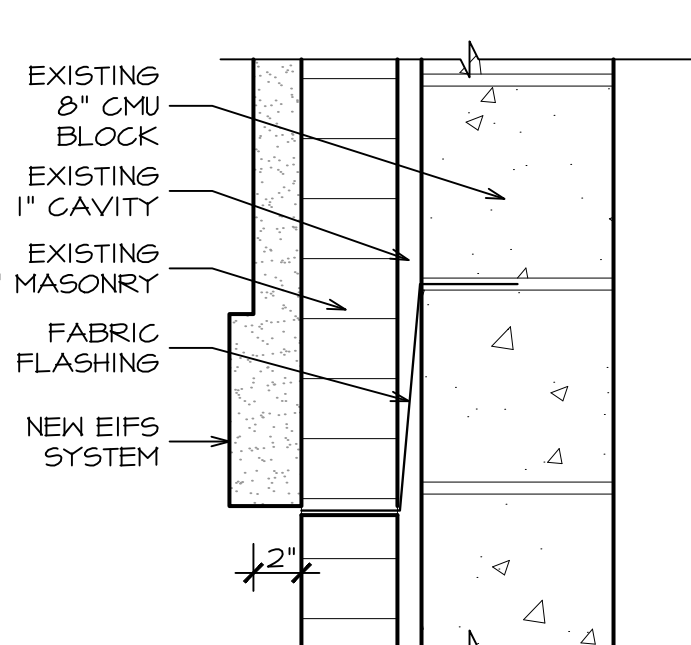

C WALL DETAIL
SCALE: 1-1/2" = 1'-0"

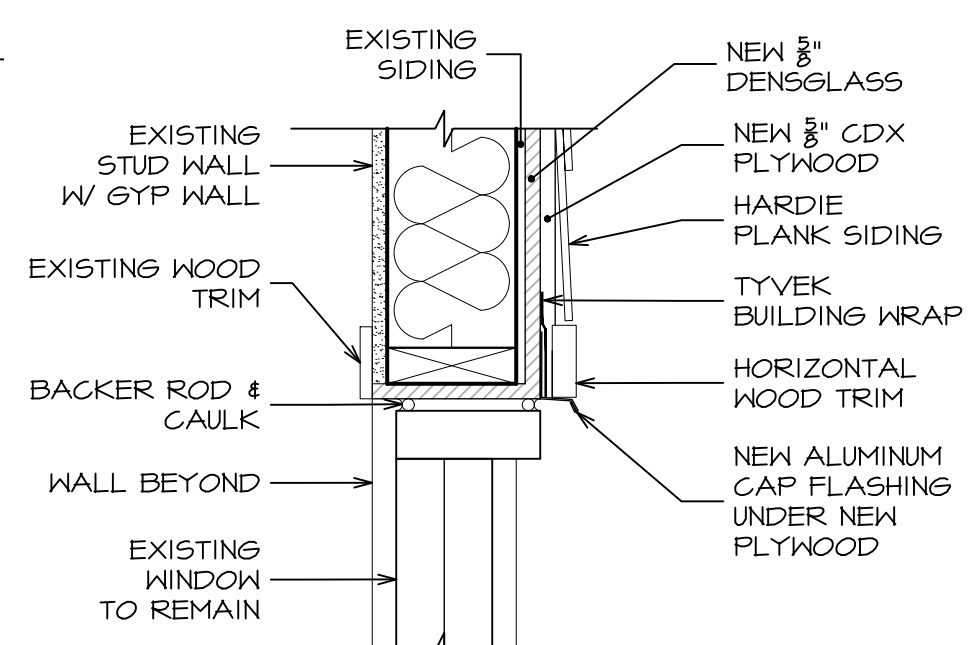

D WALL DETAIL
SCALE: 1-1/2" = 1'-0"

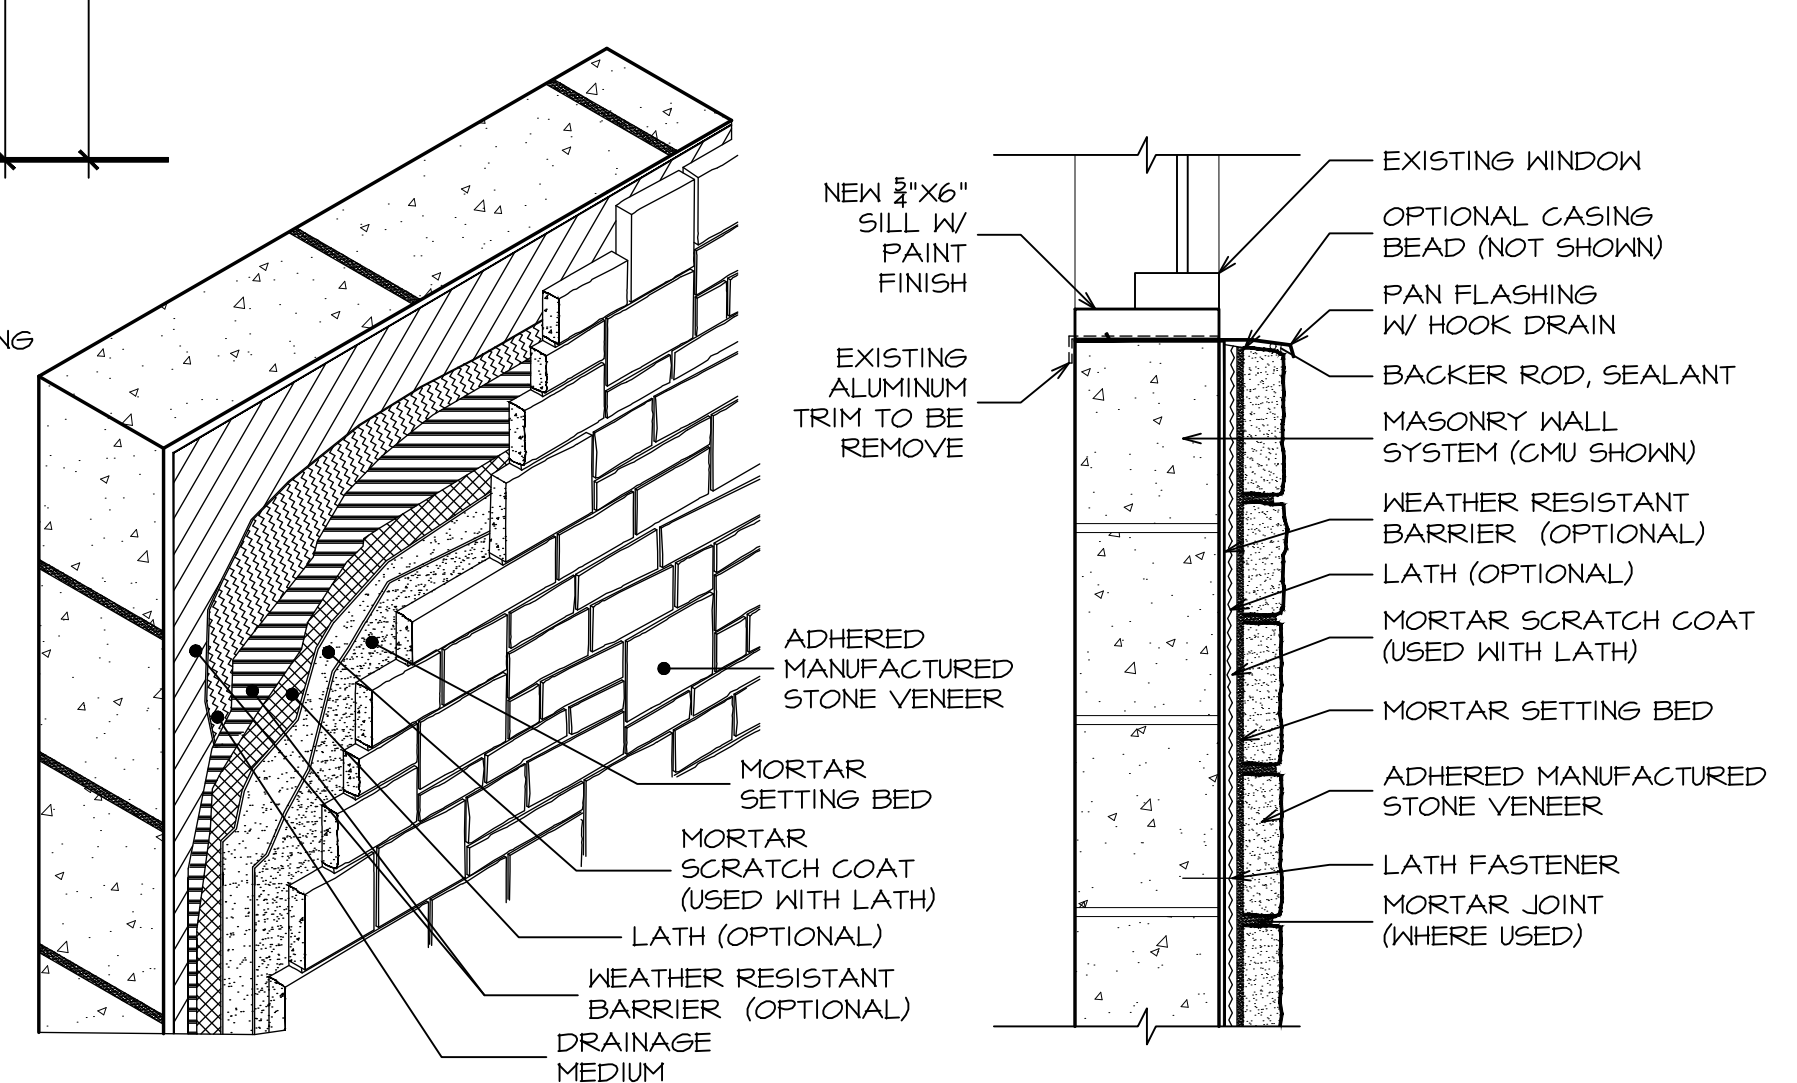

E CULTURE STONE DETAIL
SCALE: 1-1/2" = 1'-0"

DATE: ISSUE
07-20-2022 ISSUED
FOR BIDDING & PERMIT

SEAL:

SENDEWSKI ARCHITECTS PC
ARCHITECTS - PLANNERS
215 ROANOKE AVENUE
RIVERHEAD, NY 11901
(631) 727-5352
9 SELDEN COURT
WALDEN, NY 12586
(845) 275-8859

TAPPAN FIRE DISTRICT
300 WESTERN HIGHWAY SOUTH
TAPPAN, NY 10983

WALL SECTION & DETAILS

PROJECT #: 2108.01B

DRAWN BY: AR/JC


CAD FILE: 2108.01B/P./BID


DRAWING#:

A=6.1

SUB STATION

DOOR SCHEDULE															
DOOR INFORMATION			SIZE			MATERIAL		FINISH		DETAILS		FRAME TYPE	HARDWARE GROUP	RATING	REMARKS
NO.	QTY.	TYPE	WITH	HEIGHT	THK	DOOR	FRAME	DOOR	FRAME	HEAD	JAMB			LABEL DR. FRAME	
I-01	1	B	3'-4"	7'-0"	1-3/4"	HM	HM	PT	PT	6	1	3	1		
I-02	1	B	3'-4"	7'-0"	1-3/4"	HM	HM	PT	PT	6	1	3	1		
I-03	1	B	3'-4"	7'-0"	1-3/4"	HM	HM	PT	PT	6	1	3	1		
I-04	EXISTING		3'-4"	7'-0"	1-3/4"	EXISTING							ALTER DOOR FOR HES HARDWARE TO BE INSTALL		
I-05	2	C	2'-4"	7'-0"	1-3/4"	HM	HM	PT	PT	5	2	2	3		
I-06	2	C	2'-4"	7'-0"	1-3/4"	HM	HM	PT	PT	5	2	2	3		
I-07	1	A	3'-0"	7'-0"	1-3/4"	HM	HM	PT	PT	4	2	1	3		
I-08	1	A	3'-0"	7'-0"	1-3/4"	HM	HM	PT	PT	3	2	1	3		
I-09	1	A	3'-0"	7'-0"	1-3/4"	HM	HM	PT	PT	3	2	1	2		
I-10	1	B	3'-0"	7'-0"	1-3/4"	HM	HM	PT	PT	4	2	1	2		
I-11	1	A	3'-0"	7'-0"	1-3/4"	HM	HM	PT	PT	3	2	1	3		
M-01	1	B	3'-0"	7'-0"	1-3/4"	HM	HM	PT	PT	5	2	1	3		

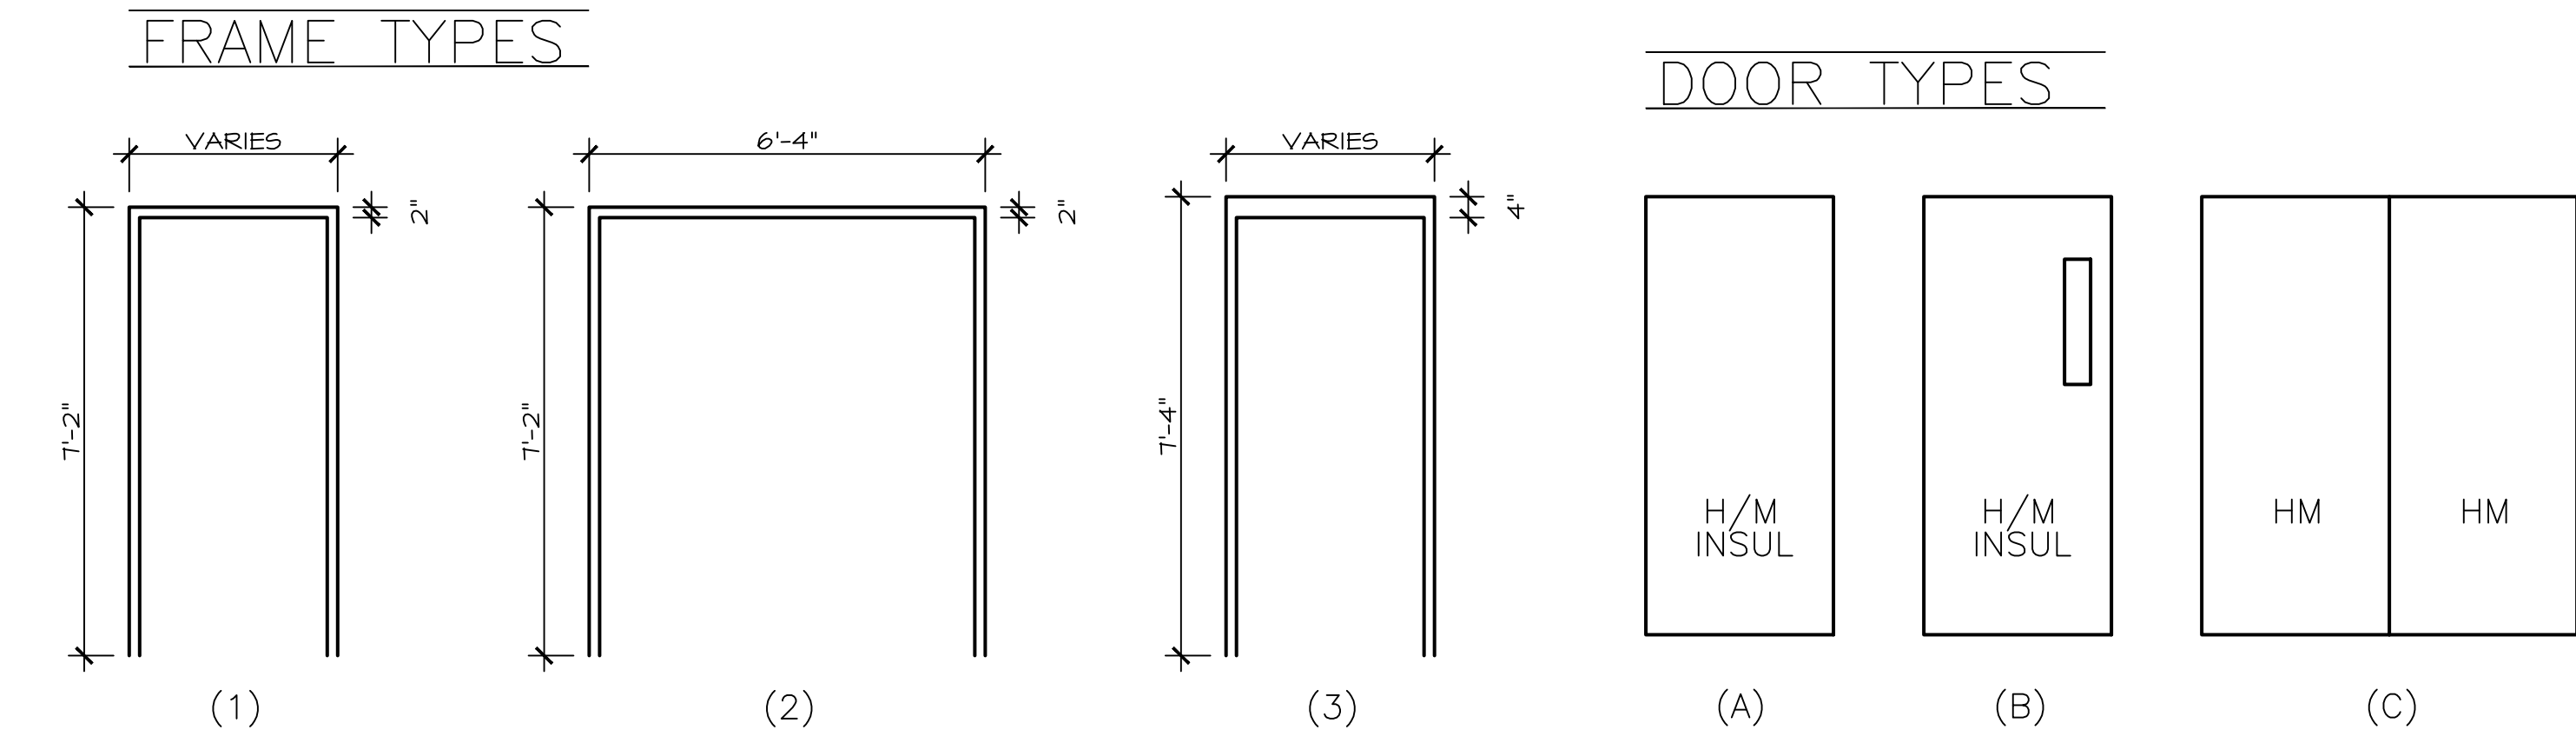


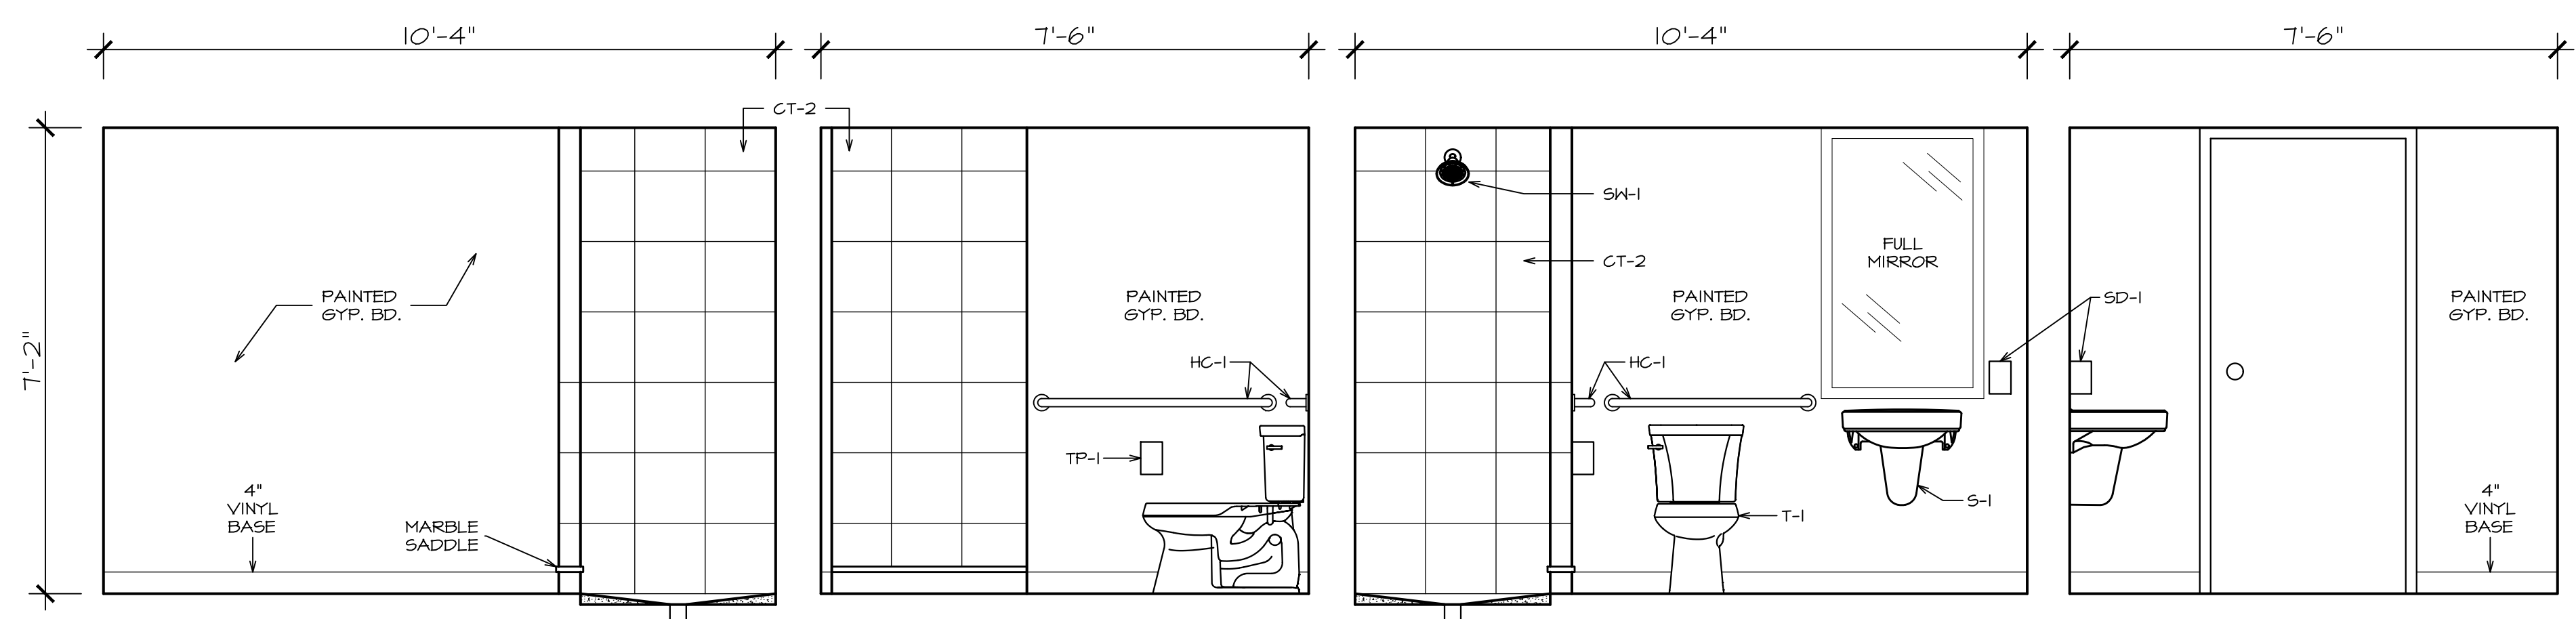[illegible][illegible]

TYP. GRAB ANCHOR
SCALE: 3/4" = 1'-0"


BATHROOM TILE LENGEND				
TILE REF.	SERIES	COLOR	SIZE	NOTE
CT-1	AYERS ROCK	MAJESTIC MOUND	3"x3"	--
CT-2	AYERS ROCK	BRONZED BEACON	13"x13"	--

NOTE: ALL HARDWARE SHALL MEET ADA REQ'MTS FOR MOUNTING HEIGHT.

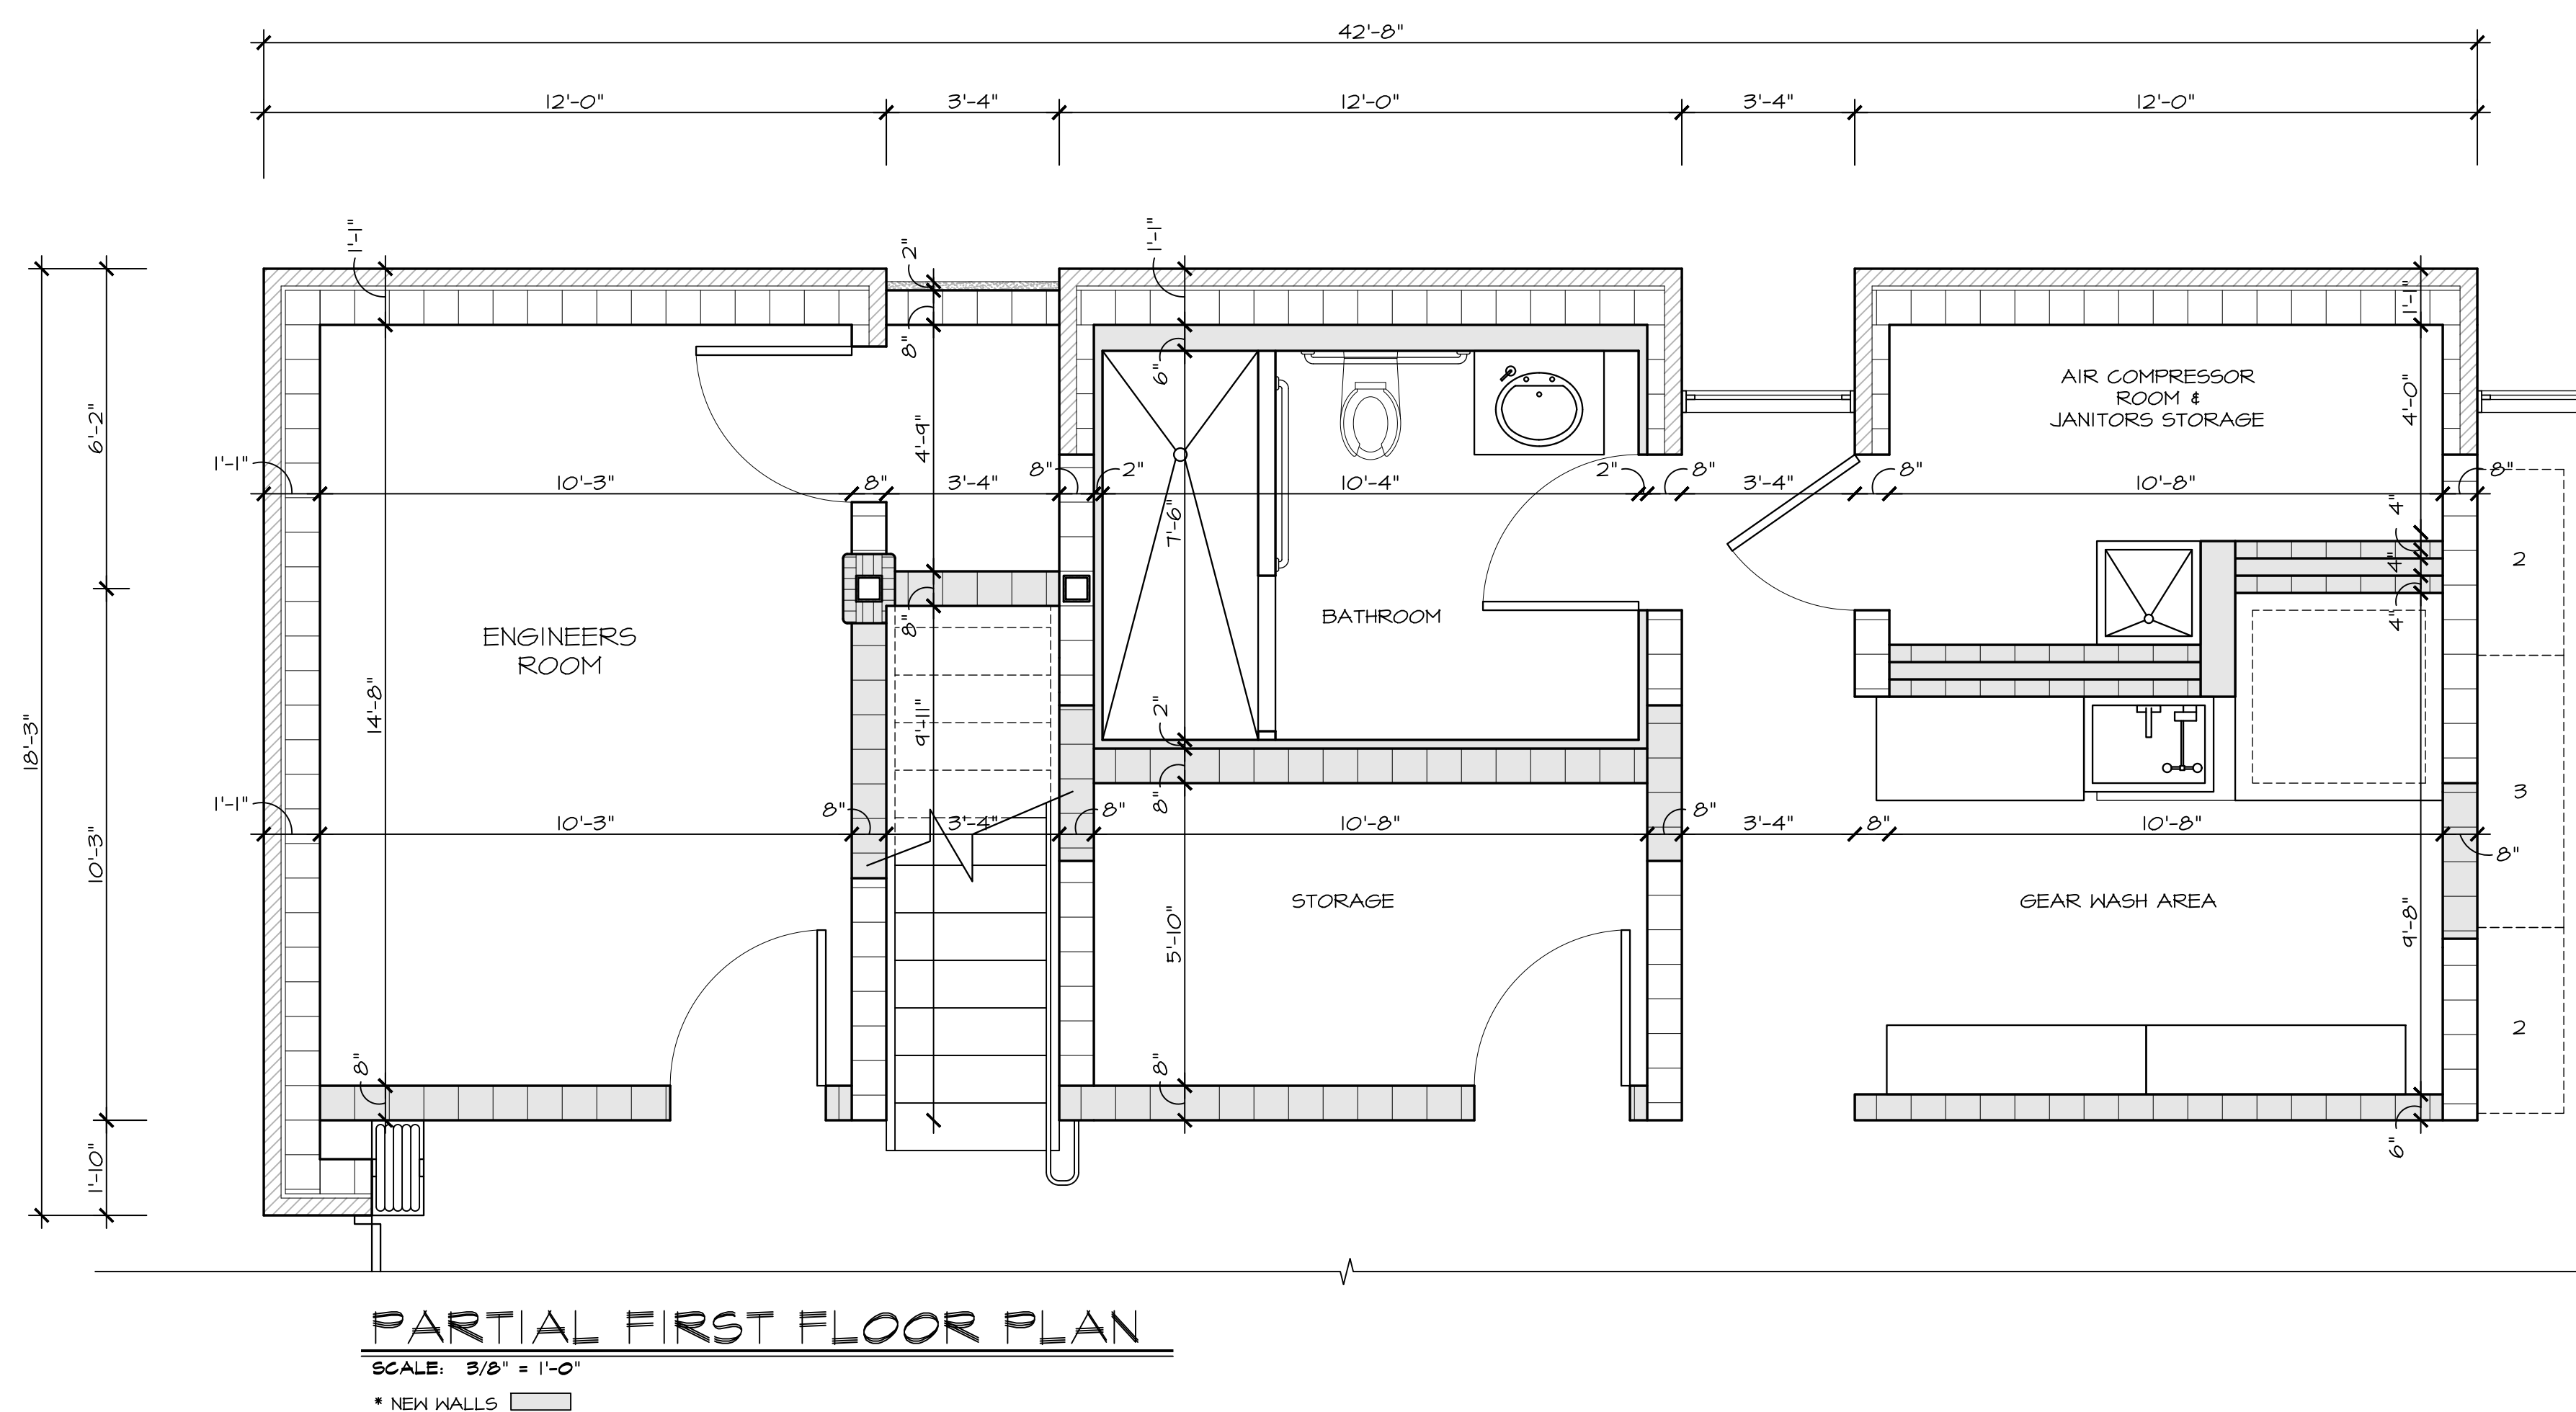


PARTIAL FIRST FLOOR PLAN
SCALE: 3/8" = 1'-0"
 * NEW WALLS 

SUB STATION

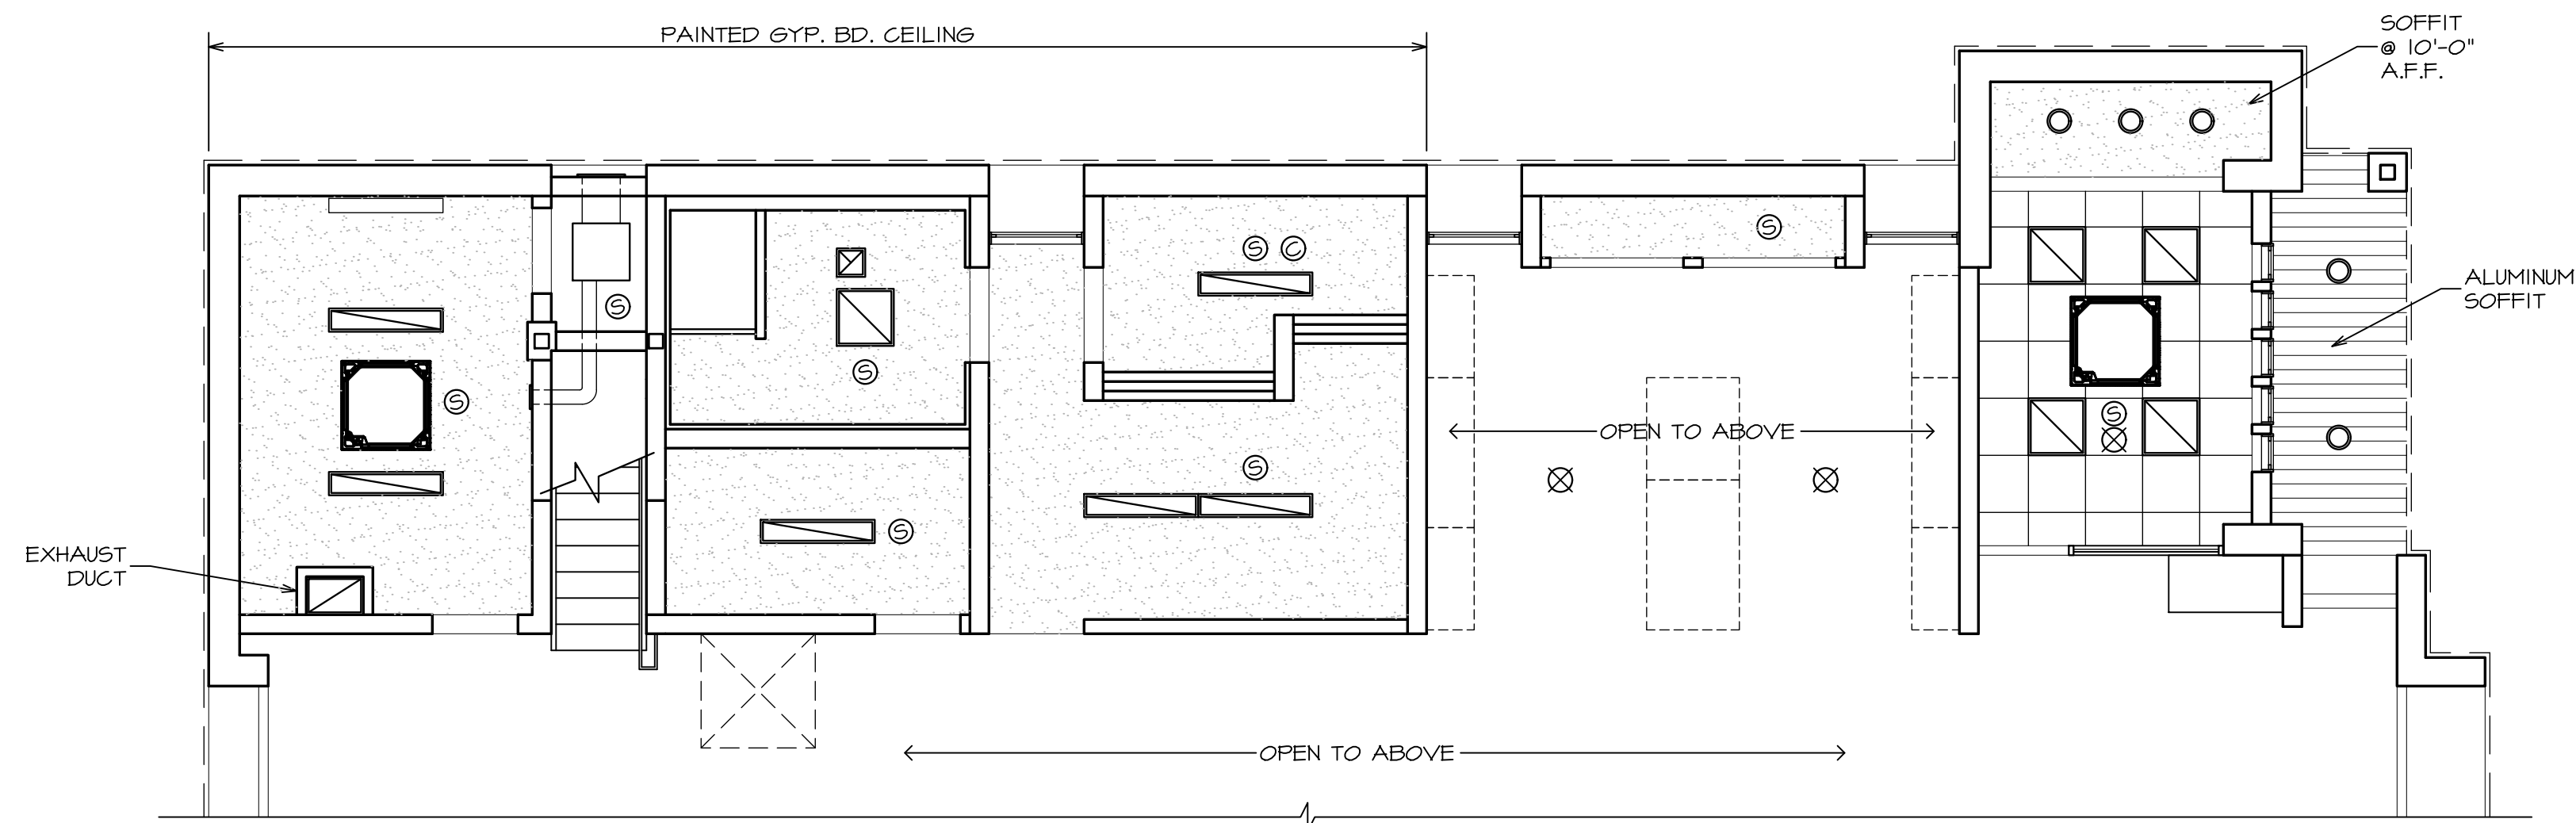

FIRST FLOOR CEILING PLAN



SCALE: 3/16" = 1'-0"

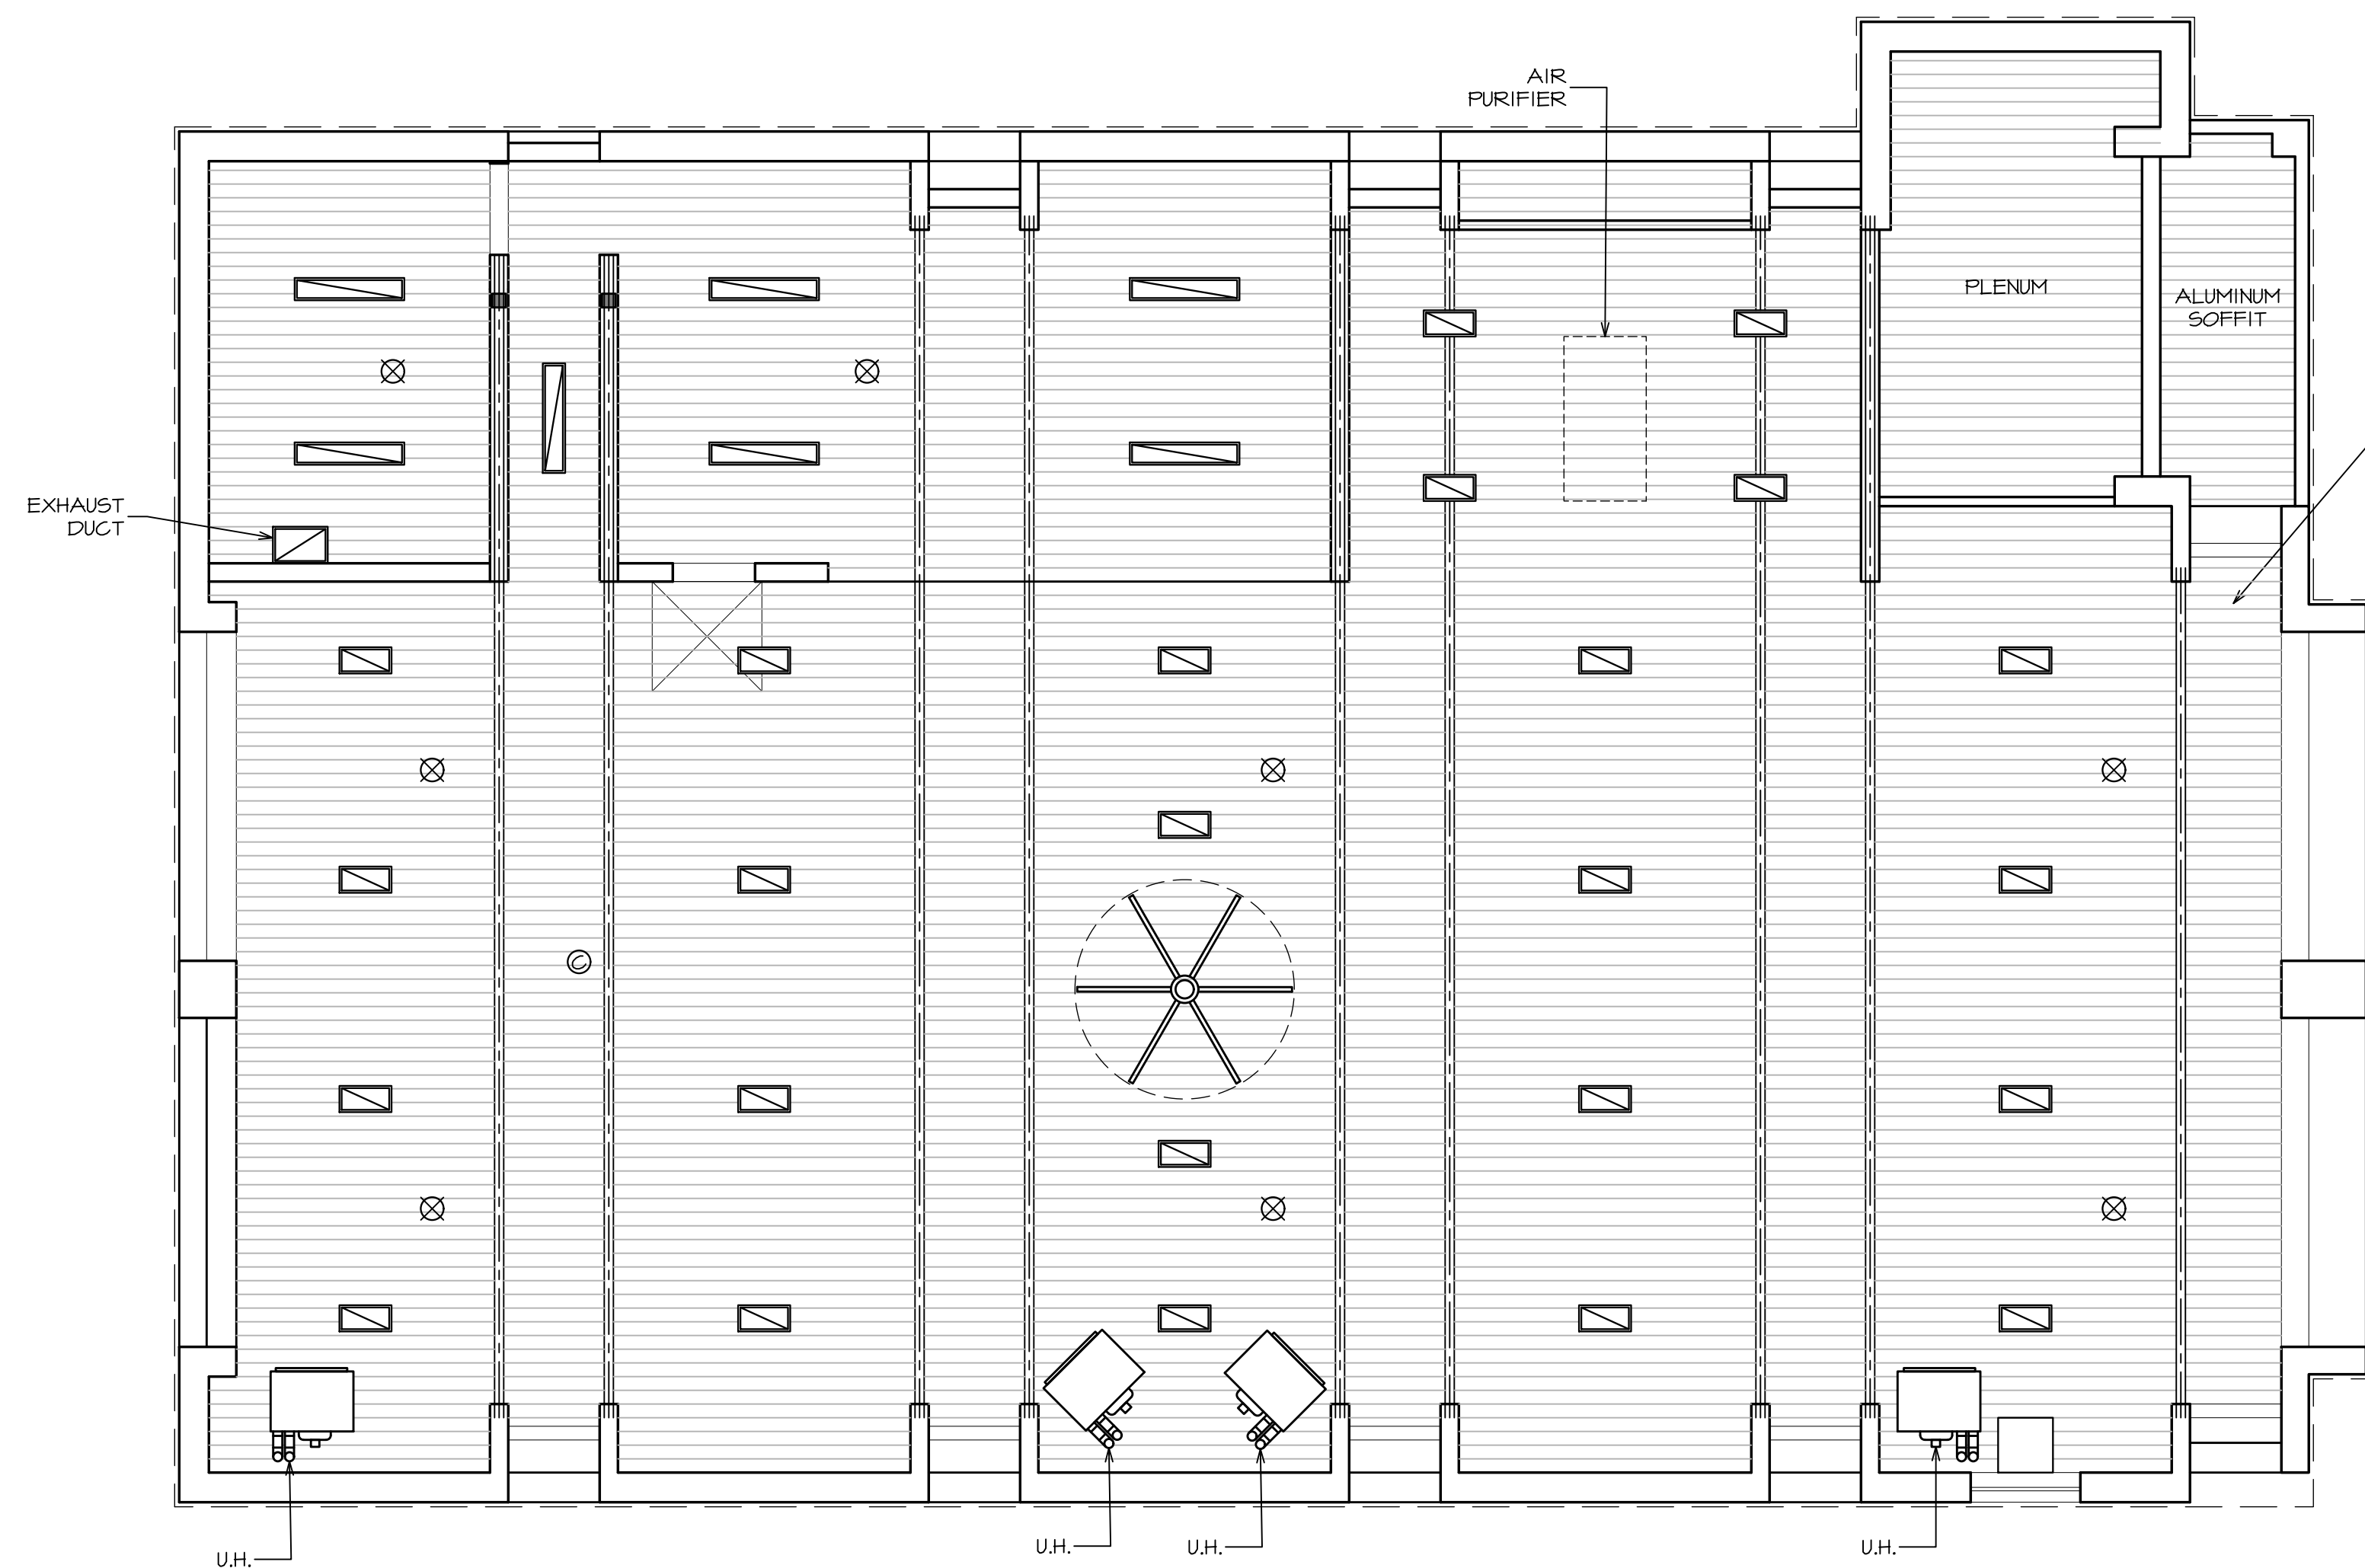

MEZZANINE CEILING PLAN

SCALE: 3/16" = 1'-0"

CEILING LEGENDS	
	10' X 4'-0" LOW BAY LED
	1'-0" X 1'-11" HIGH BAY LED
	2'-0" X 2'-0" LED FIXTURE
	LED RECESSED HI-HAT
	HVAC RETURN AIR GRILLE
	SMOKE DETECTOR
	CARBON MONOXIDE DETECTOR
	RADIO SYSTEM SPEAKER
	CEILING FAN
	CEILING FAN COIL UNIT
	MODINE UNIT HEATER
	GYP. BD. CEILING W/ PAINT FINISH (TYP.)

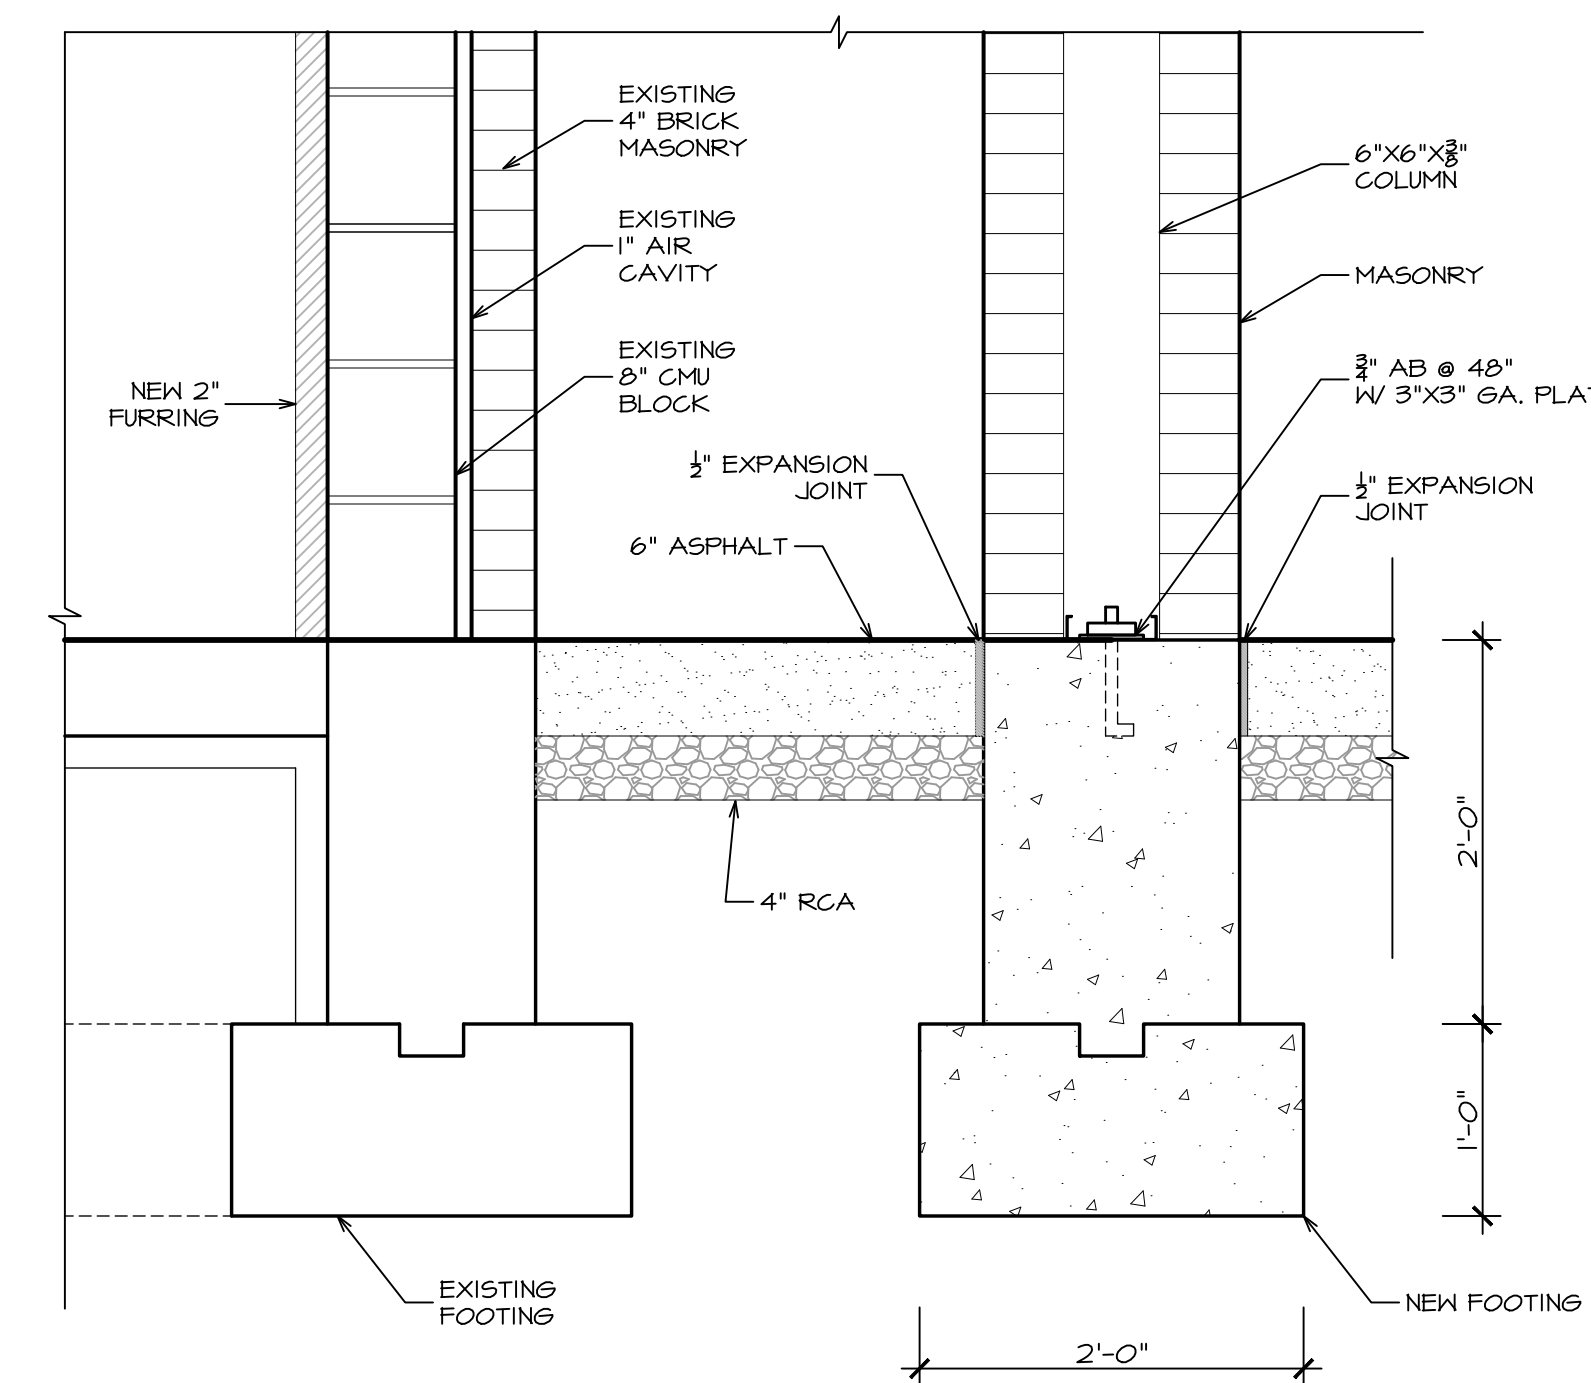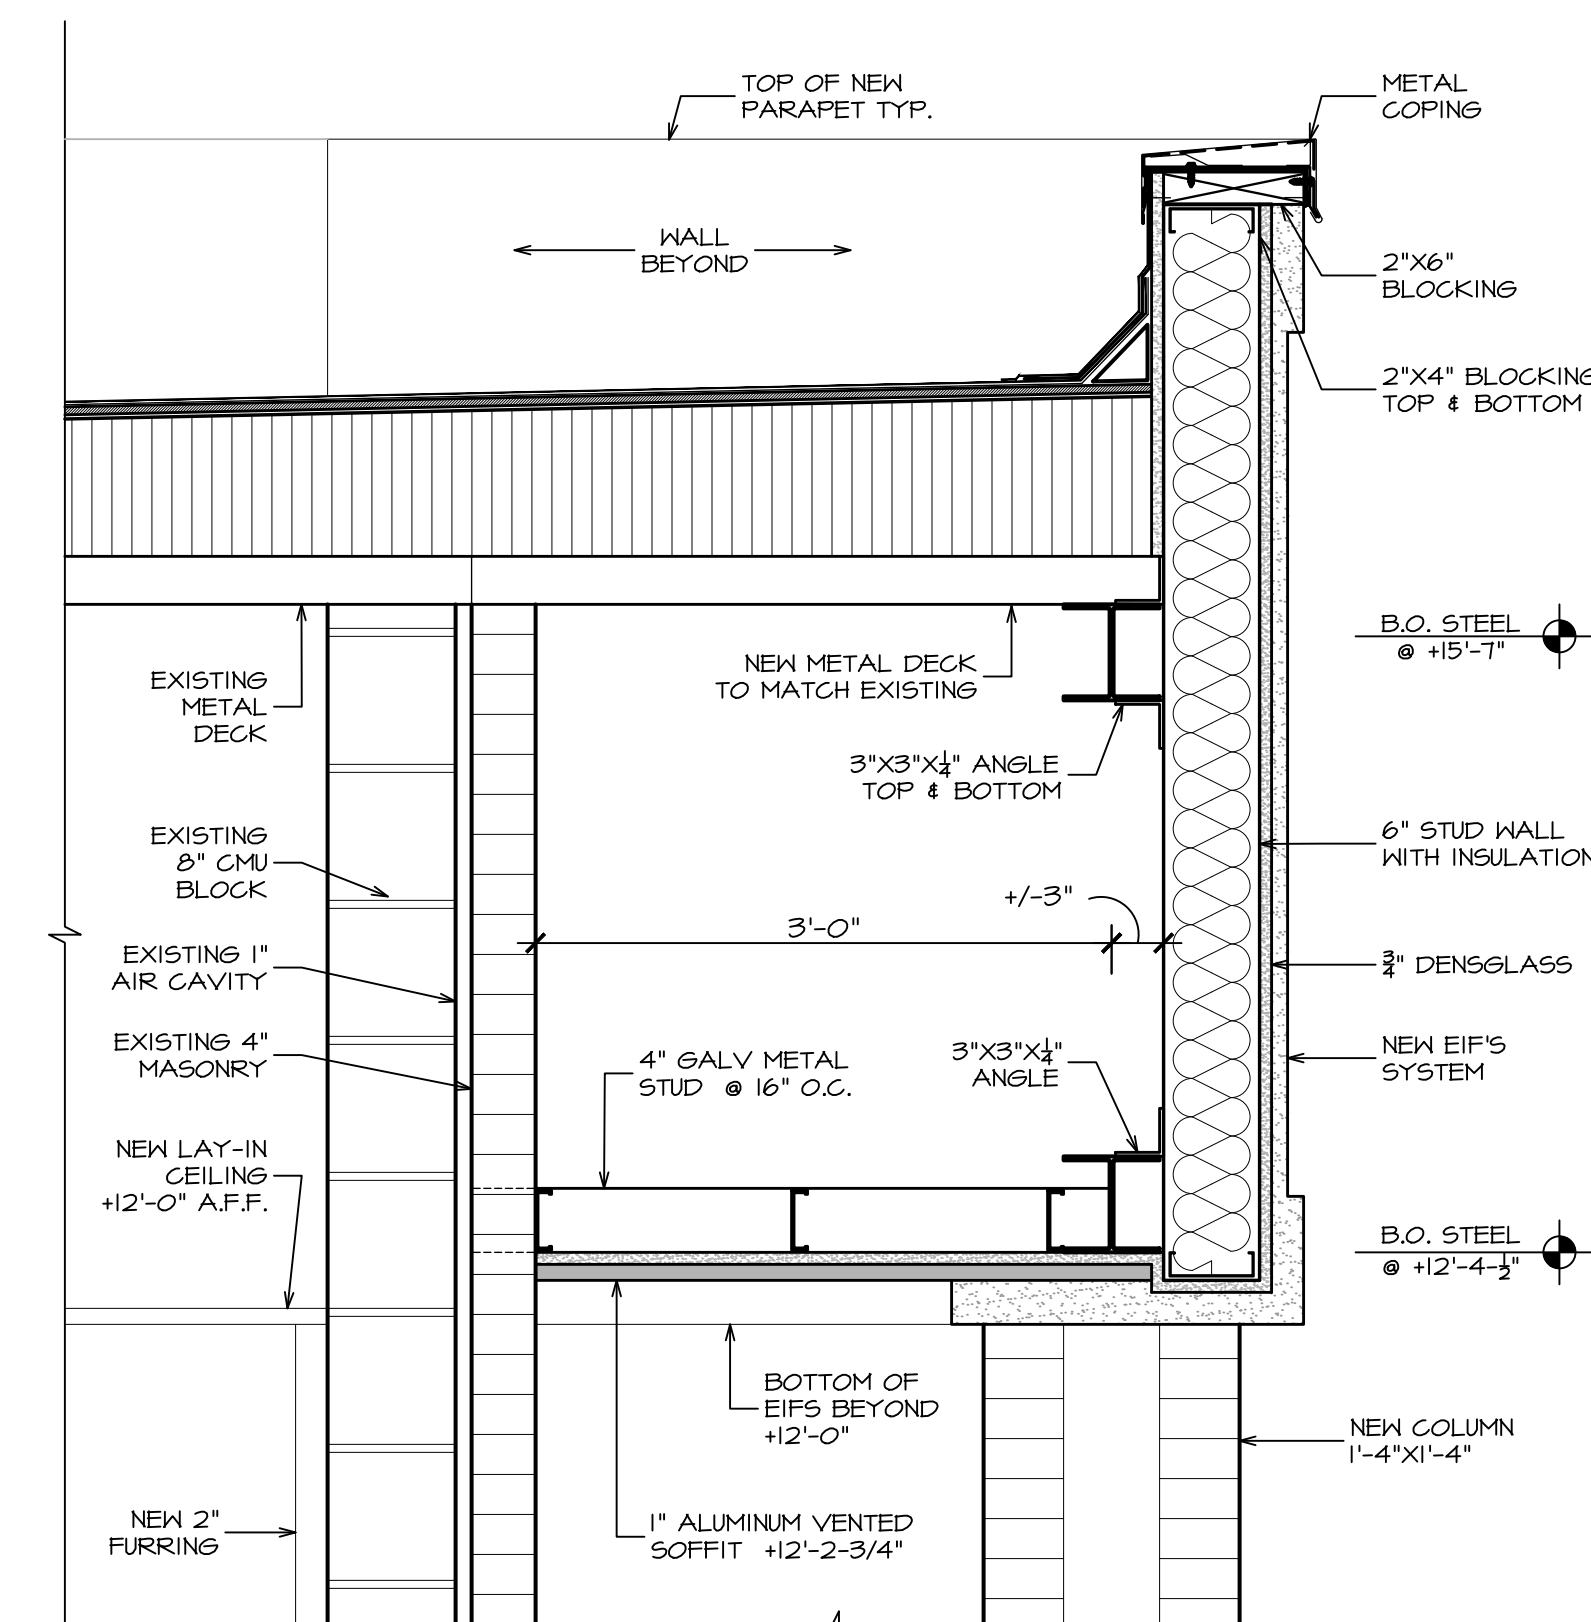

POST/FLAT ROOF
SCALE: 1" = 1'-0"

DATE: ISSUE
07-20-2022 ISSUED
FOR BIDDING & PERMIT

SEAL:

SENDEWSKI ARCHITECTS PC
ARCHITECTS - PLANNERS
215 ROANOKE AVENUE
RIVERHEAD, NY 11901
(631) 727-5352
9 SELENA COURT
WALDEN, NY 12586
(845) 275-8859

TAPPAN FIRE DISTRICT
300 WESTERN HIGHWAY SOUTH
TAPPAN, NY 10983
FIRST FLOOR & MEZZANINE
REFLECTIVE CEILING PLAN

PROJECT #: 2108.01B

DRAWN BY: AR/JC

CAD FILE: 2108.01B/P-/BID

DRAWING#:

A=8.1

SUB STATION