

GENERAL NOTES:

1. The work on this project shall be awarded as four (4) separate prime contracts. Contracts to be awarded under this BID are as follows:

2108.02 GC - General Construction
2108.02 M - Mechanical Work
2108.02 P - Plumbing Work
2108.02 E - Electrical Work

2. ALL prime contractors and their sub contractors shall be required to coordinate and schedule their work with other contractors as required to facilitate sequencing, coordination, etc. It shall be the responsibility of EACH prime contractor to notify other prime contractors of conditions that will affect their work or the work of respective sub contractors that will require coordination and/or verification. NO change orders will be considered for costs incurred due to lack of proper coordination. All notifications between prime contractors shall be in writing or in official project meeting minutes to be considered valid.
3. The work under all sections of the specifications and all work indicated on the drawings are subject to all applicable provisions of the Notice to Bidders, Instruction to Bidders (AIA A701), General Conditions (AIA A201), Supplementary Conditions, prevailing wage rate schedules, bonds, and Division I General Conditions, as included in the project manual.
4. Each contractor shall review the ENTIRE set of drawings (including architectural drawings) to coordinate their own work and with work of other trades, and to verify information that will affect their work. In general, locations indicated on architectural plans takes precedence over other documents. Architect shall provide interpretation of locations etc. when requested.


5. All items specified indicate the minimum standard for components to be incorporated into the project. Any "or equal" MUST be approved by the Architect and owner. All items called for or specified shall be installed in compliance with the manufacturers written specifications and installation instructions which are incorporated into these drawings in their entirety by this reference. Installations of any portion of work shall include any and all hardware, supports, fittings, components, clearances, etc. which are required for a complete and proper installation and maintenance, without exception.
6. All work shall comply with the requirements of the Building Code of New York State.
7. EACH prime contractor shall be responsible for his own excavations, trenching, shoring, dewatering, etc. as required for the installation of his own work. Provide 95% compaction clean back fill in max. 12" lifts typical at all affected areas.
8. Each contractor shall coordinate and furnish any and all concrete/masonry sleeves and inserts to general contractor in coordination with the GC schedule for concrete/masonry work.
9. Each contractor shall maintain one full set of marked up drawings to indicate any and all deviations for as-built conditions and shall turn over same to the Architect upon completion of project.
10. Each prime contractor shall be required to have a designated project superintendent who will be at the project site whenever contract work is in progress. Said representative shall be in attendance at ALL job meetings, regardless of ongoing work associated with that contractor.
11. Each prime contractor shall provide for and follow any requirements associated with current health and safe construction practices, for all aspects of their bid, and as currently mandated by NYS at the time of the bid.

PROPOSED ACCESSORY PAVILLION FOR
TAPPAN
FIRE DISTRICT
300 WESTERN HIGHWAY SOUTH
TAPPAN, NY 10983

DATE: ISSUE
--- --20--- ISSUED
FOR BIDDING
& PERMIT

SEAL:

SENDLEWSKI ARCHITECTS PC
ARCHITECTS - PLANNERS
215 ROANOKE AVENUE
RIVERHEAD, NY 11901
(631) 727-5352
9 SELENA COURT
WALDEN, NY 12586
(845) 275-8859

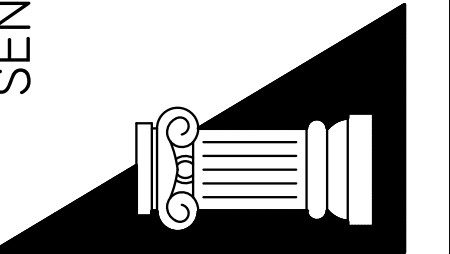

PROPOSED PAVILLION
TAPPAN FIRE DISTRICT
300 WESTERN HIGHWAY SOUTH
TAPPAN, NY 10983

 
COVER SHEET

PROJECT #: 2108.02


DRAWN BY: AR/JC

CAD FILE: 2108.02/P-/BID

DRAWING#:




PAVILLION

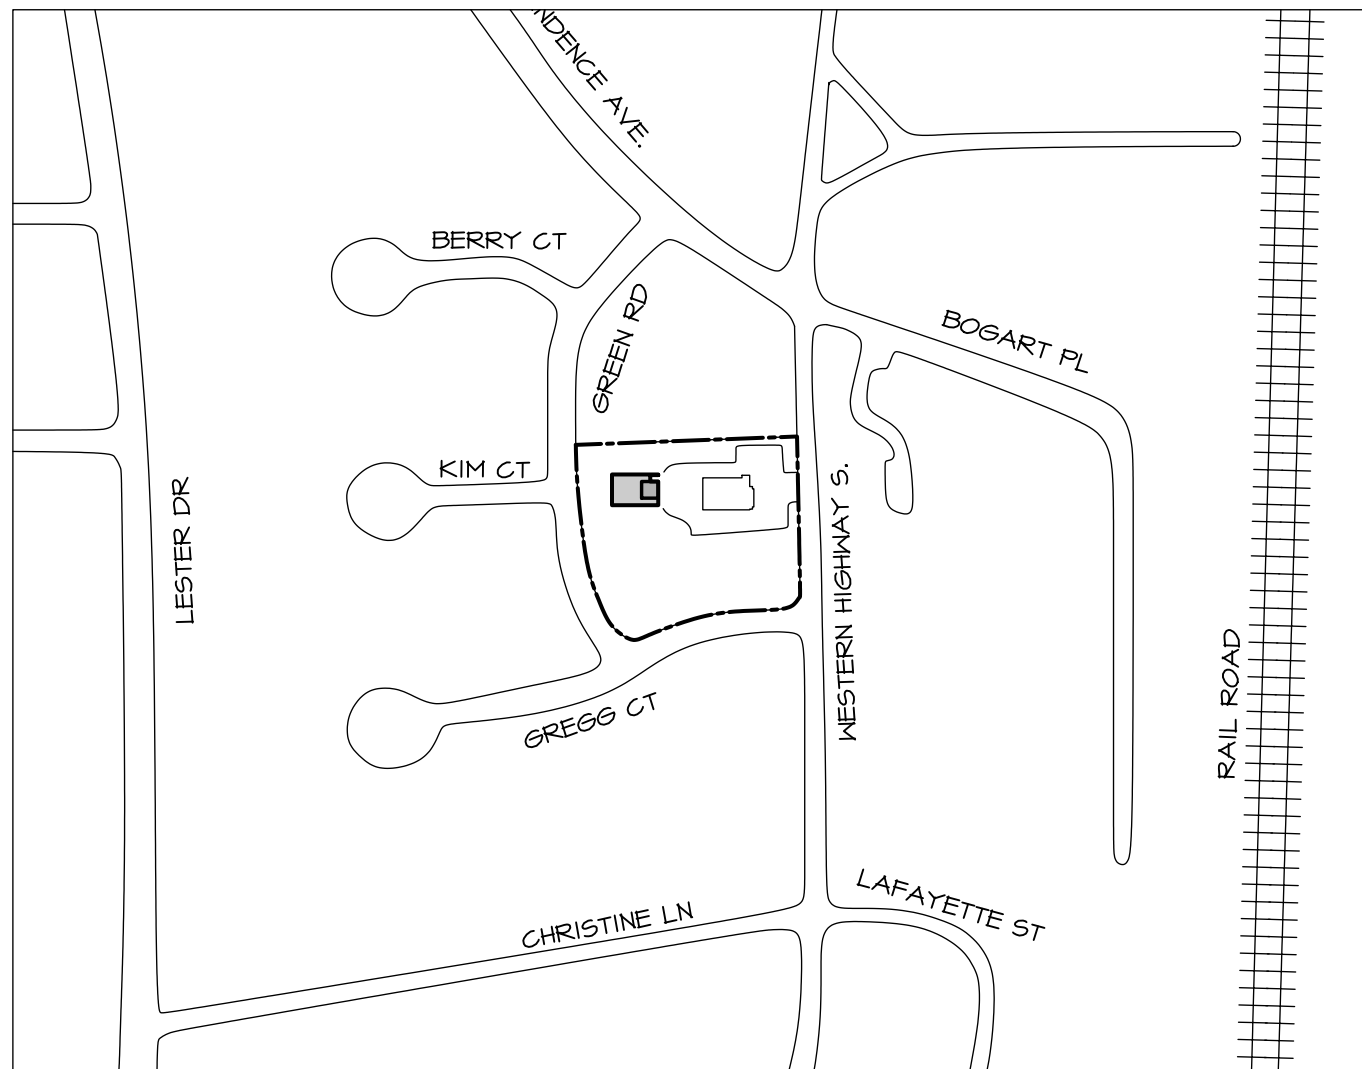

PLAQUE DETAIL

NOT TO SCALE

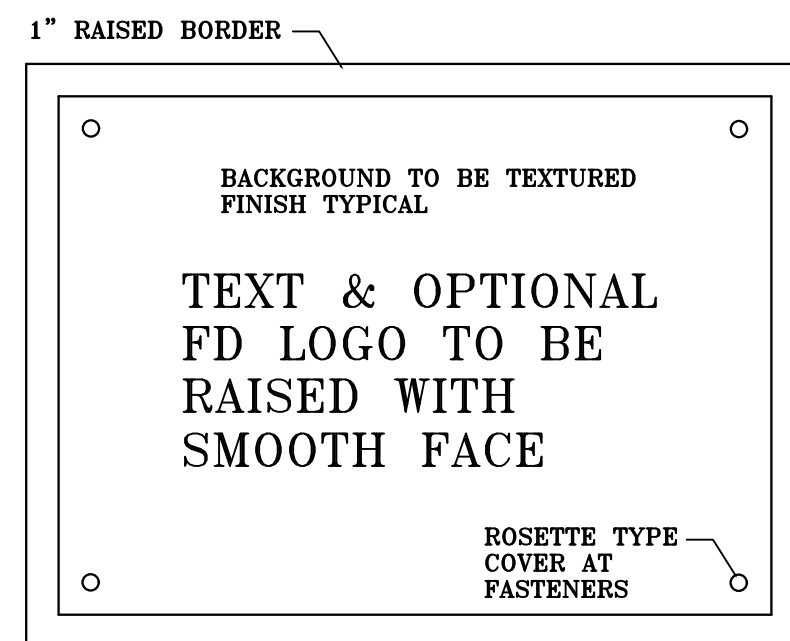

GENERAL CONTRACTOR SHALL PROVIDE AND INSTALL WHERE DIRECTED.
24" X 36" BRONZE PLAQUE. TEXT
CONTENT, FD LOGO & LAYOUT OF INFORMATION
SHALL BE PROVIDED BY OWNER.

LIST OF DRAWINGS

GENERAL CONSTRUCTION DRAWINGS

- 0-0 COVER SHEET
E-1/D-1 EXISTING CONDITIONS PLAN
1 SITE DEVELOPMENT PLAN
2 EXISTING CONDITIONS PLAN
3 GRADING PLAN
4 SITE DETAILS
5 EROSION CONTROL PLAN
21R336.2 SUBSURFACE INVESTIGATION
6 LANDSCAPING PLAN
7 LIGHTING PLAN
A-1 LOWER LEVEL / FOUNDATION PLAN
A-2 MAIN LEVEL PLAN
A-3 ATTIC / ROOF PLAN
A-4.1 EAST & NORTH ELEVATIONS
A-4.2 WEST & SOUTH ELEVATIONS & TRUSS SECTION
A-5.1 BUILDING SECTIONS & DETAILS
A-5.2 BUILDING SECTIONS & DETAILS
A-6.1 DOOR / FINISH SCHEDULES & DETAILS
A-6.2 RESTROOM / KITCHEN PLANS & ELEVATIONS
A-7 CEILING PLANS
A-8 STRUCTURAL FRAMING PLANS

PLUMBING DRAWINGS

- 0-0 COVER SHEET
P-1 PLUMBING SITE PLAN
P-2 PLUMBING FIXTURE & SPECIALTY SCHEDULES
P-3 LOWER LEVEL DOMESTIC WATER & GAS PLAN
P-4 FIRST FLOOR DOMESTIC WATER & GAS PLAN
P-5 UPPER LEVEL DOMESTIC WATER & GAS PLAN
P-6 LOWER LEVEL SANITARY PLAN
P-7 FIRST FLOOR SANITARY PLAN
P-8 UPPER LEVEL SANITARY PLAN
P-9 PLUMBING DETAILS
P-10 PLUMBING NOTES

MECHANICAL DRAWINGS


- 0-0 COVER SHEET
M-1 MECHANICAL EQUIPMENT SCHEDULES
M-2 LOWER LEVEL MECHANICAL PLAN
M-3 FIRST FLOOR MECHANICAL PLAN
M-4 UPPER LEVEL MECHANICAL PLAN
M-5 MECHANICAL KITCHEN HOOD SCHEDULES
M-6 MECHANICAL KITCHEN EQUIPMENT SCHEDULES
M-7 MECHANICAL HOOD DETAILS
M-8 MECHANICAL KITCHEN MAKEUP AIR & EXHAUST DETAILS
M-9 MECHANICAL DETAILS

ELECTRICAL DRAWINGS


- 0-0 COVER SHEET
E-1 ELECTRIC SITE PLAN
E-2 ELECTRICAL PANEL SCHEDULES
E-3 LOWER LEVEL POWER & MISCELLANEOUS PLAN
E-4 FIRST FLOOR POWER & MISCELLANEOUS PLAN
E-5 UPPER LEVEL POWER & MISCELLANEOUS PLAN
E-6 FIRST FLOOR LIGHTING PLAN
E-7 MEZZANINE LIGHTING PLAN
E-8 KITCHEN EQUIPMENT POWER DETAILS
E-9 KITCHEN EQUIPMENT POWER DETAILS CONTINUED
E-10 KITCHEN HOOD POWER DETAILS
E-11 KITCHEN HOOD SUPPRESSION DETAILS

PRE-BID CONFERENCE & RFI NOTE:


A HIGHLY RECOMMENDED PRE-BID CONFERENCE WILL BE HELD AT THE INTENDED PROJECT SITE, LOCATED AT 135 WASHINGTON STREET, TAPPAN N.Y. 10983 ON WEDNESDAY AUGUST 10th, 2022 AT 11:00AM.

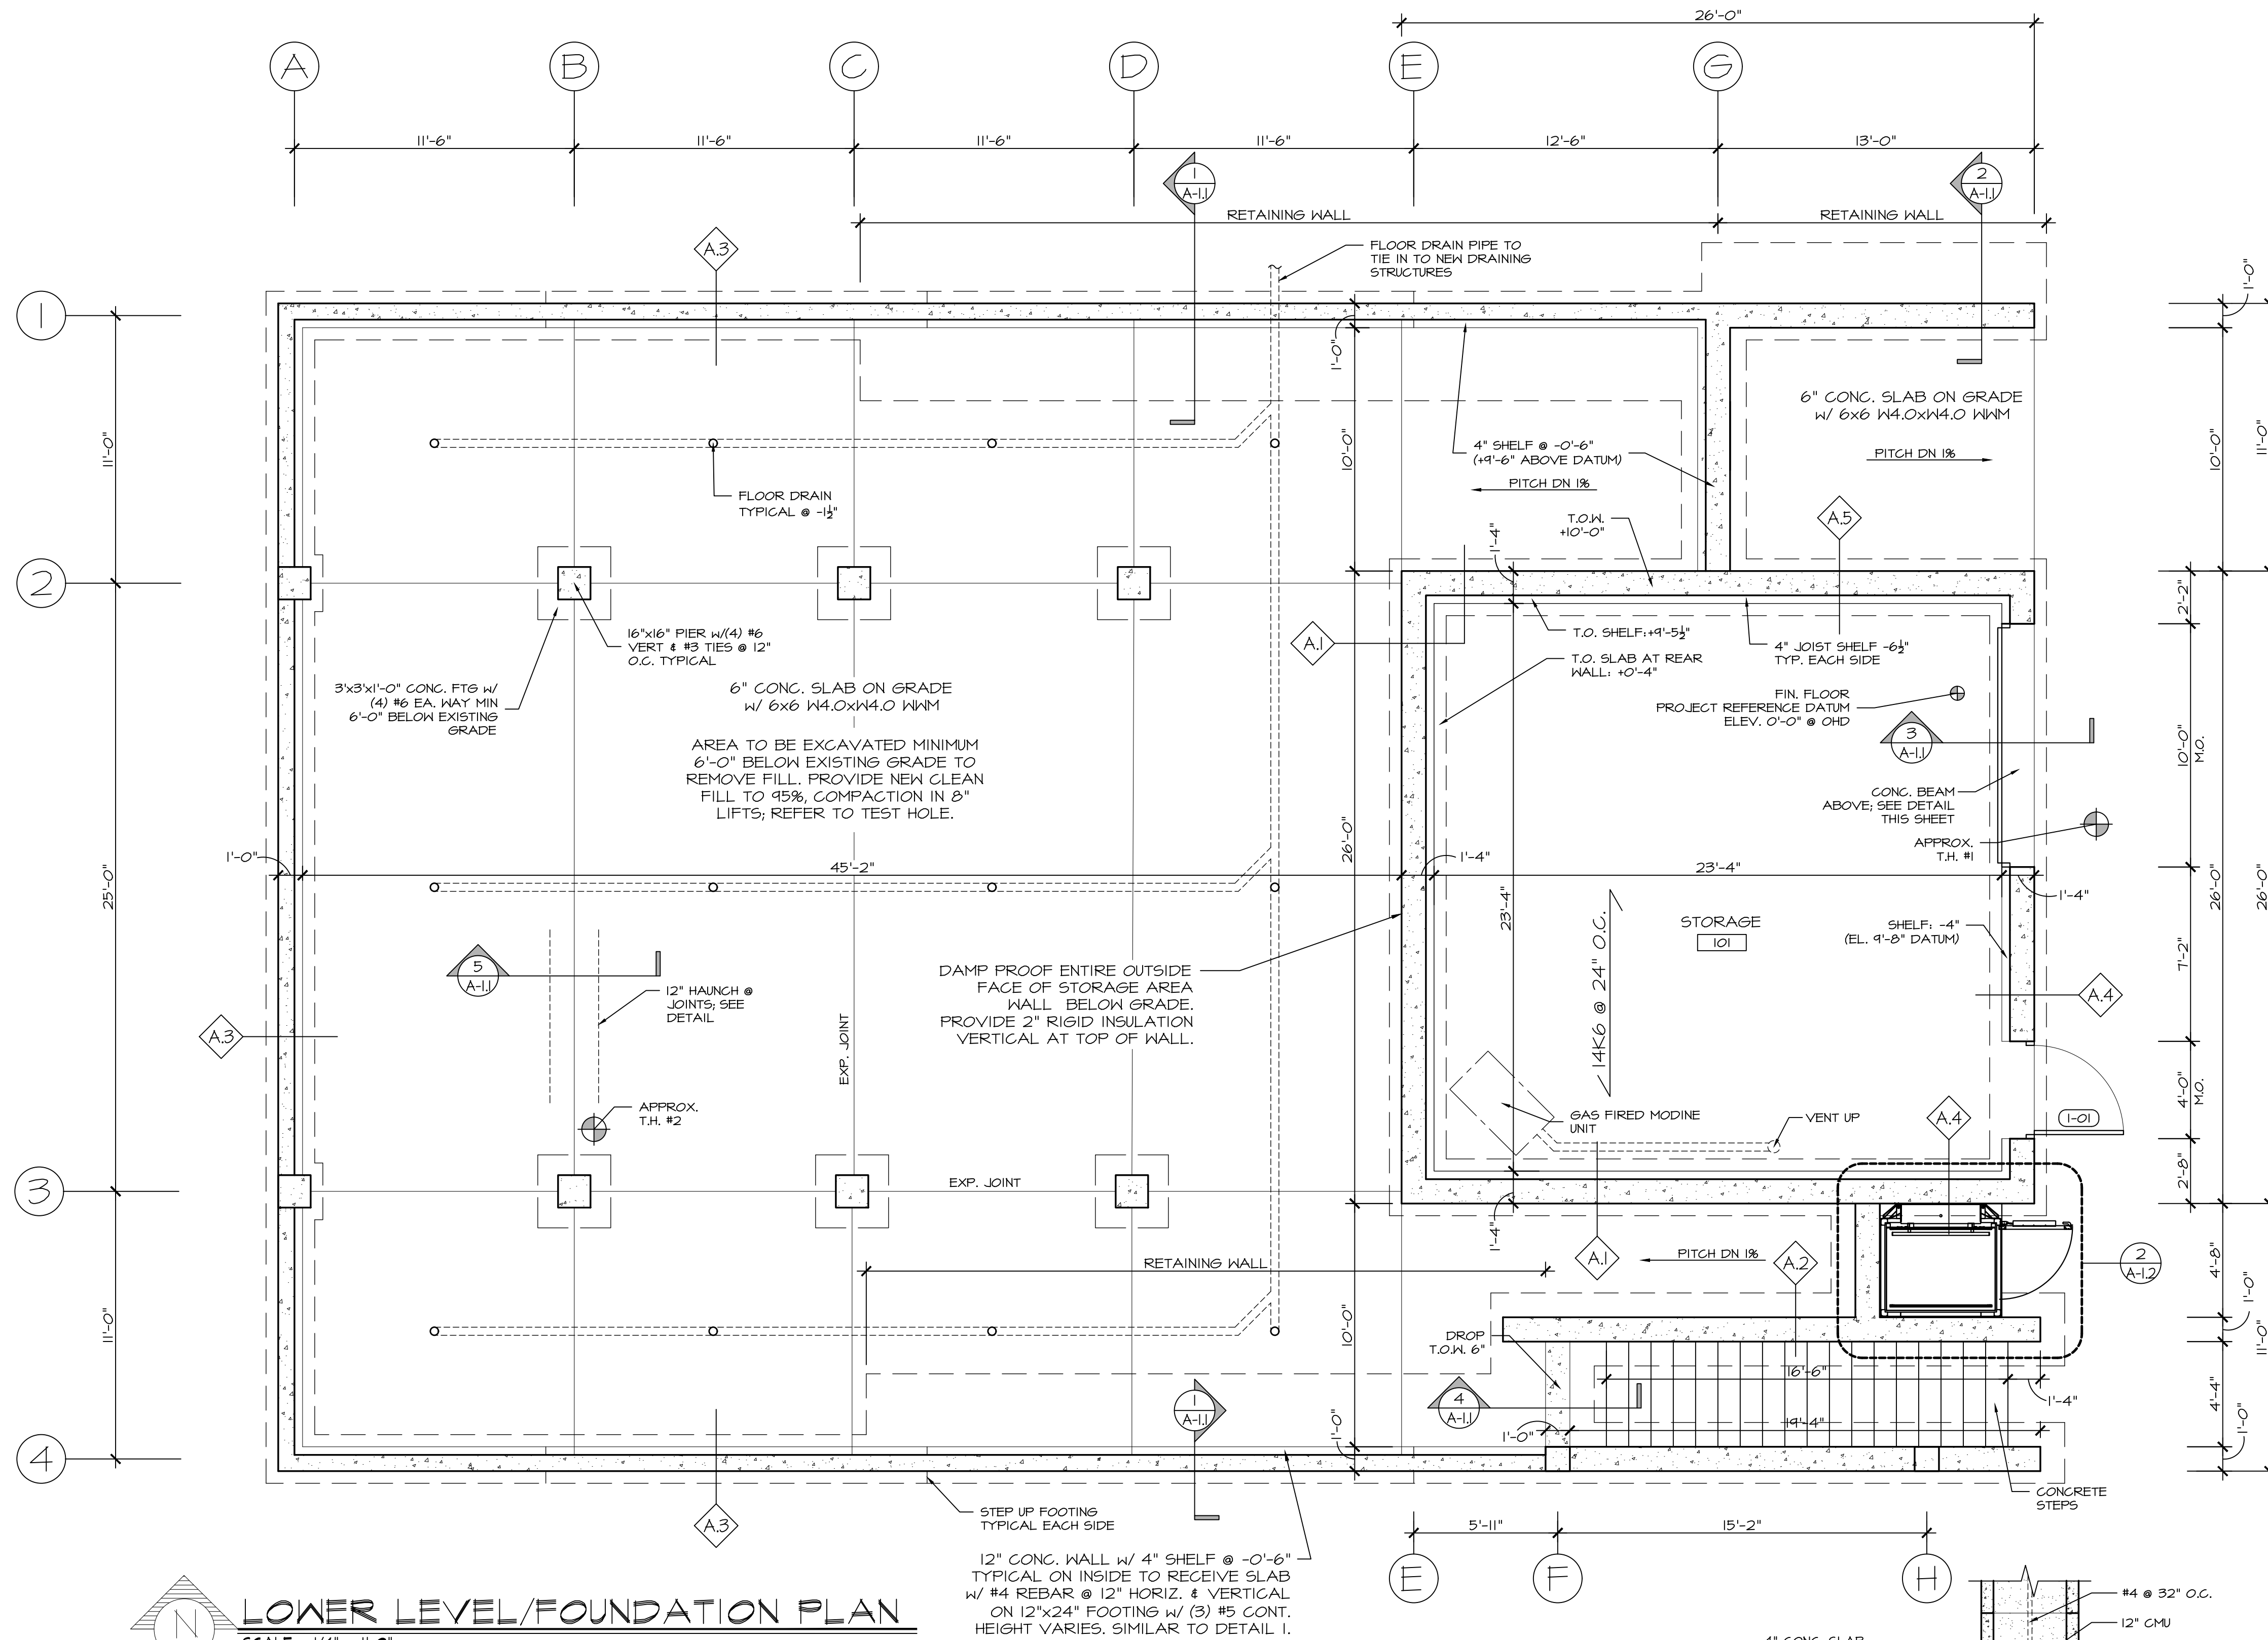


LOWER LEVEL/FOUNDATION PLAN
SCALE: 1/4" = 1'-0"

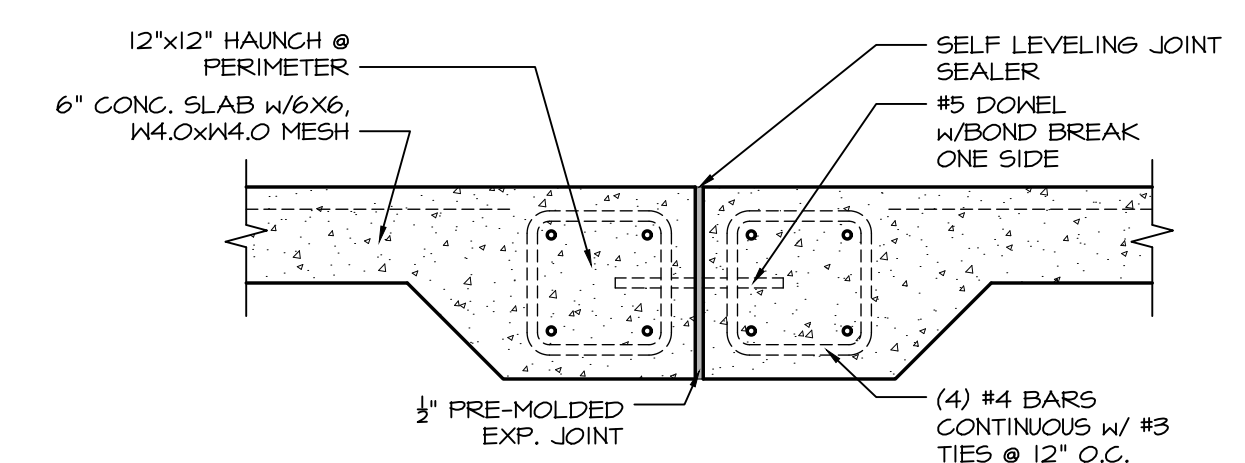


5 EXPANSION JOINT DETAIL
SCALE: 3/4" = 1'-0"

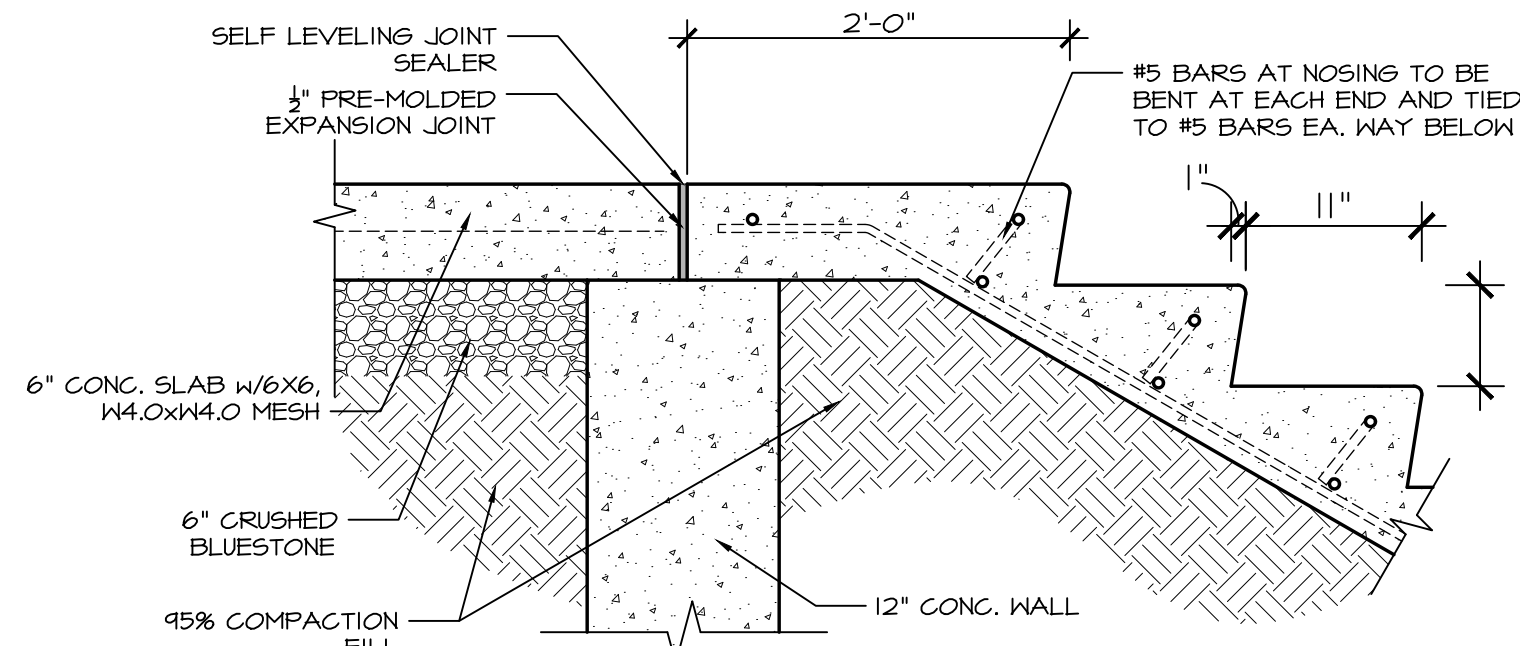


4 CONC. STAIR DETAIL
SCALE: 3/4" = 1'-0"

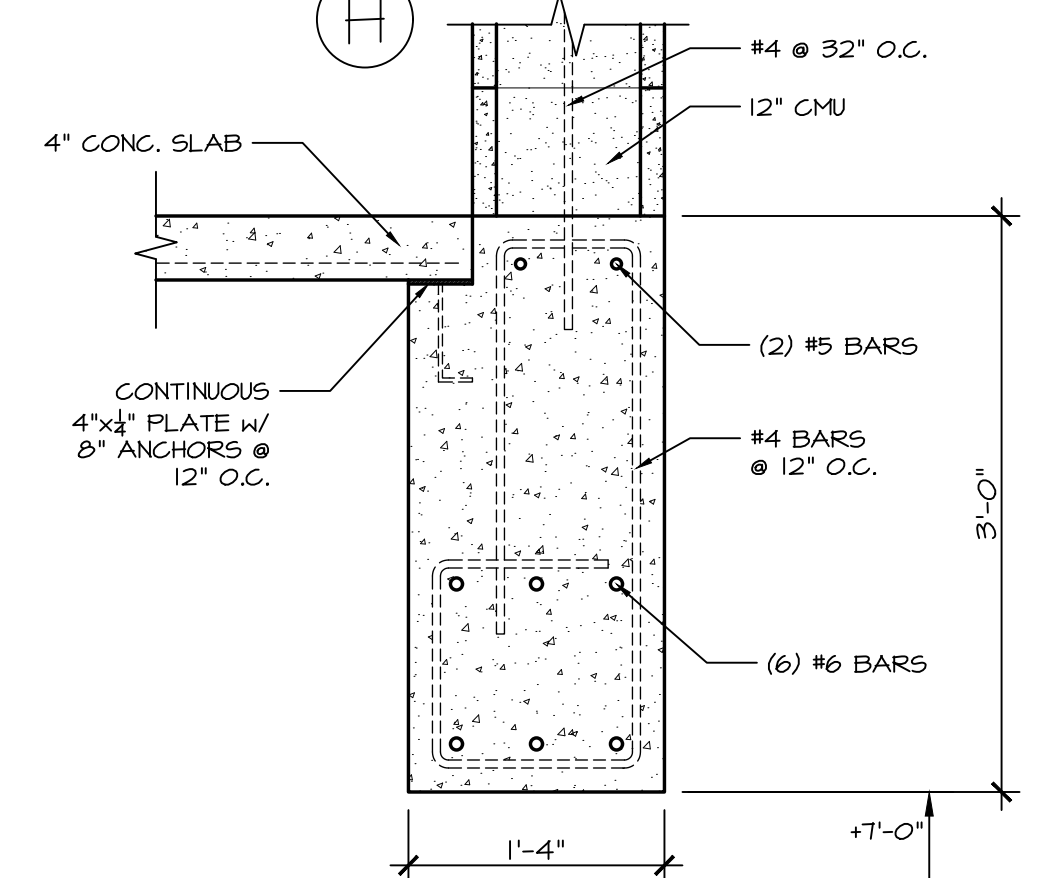

3 CONCRETE BEAM AT O.H.D.
SCALE: 3/4" = 1'-0"

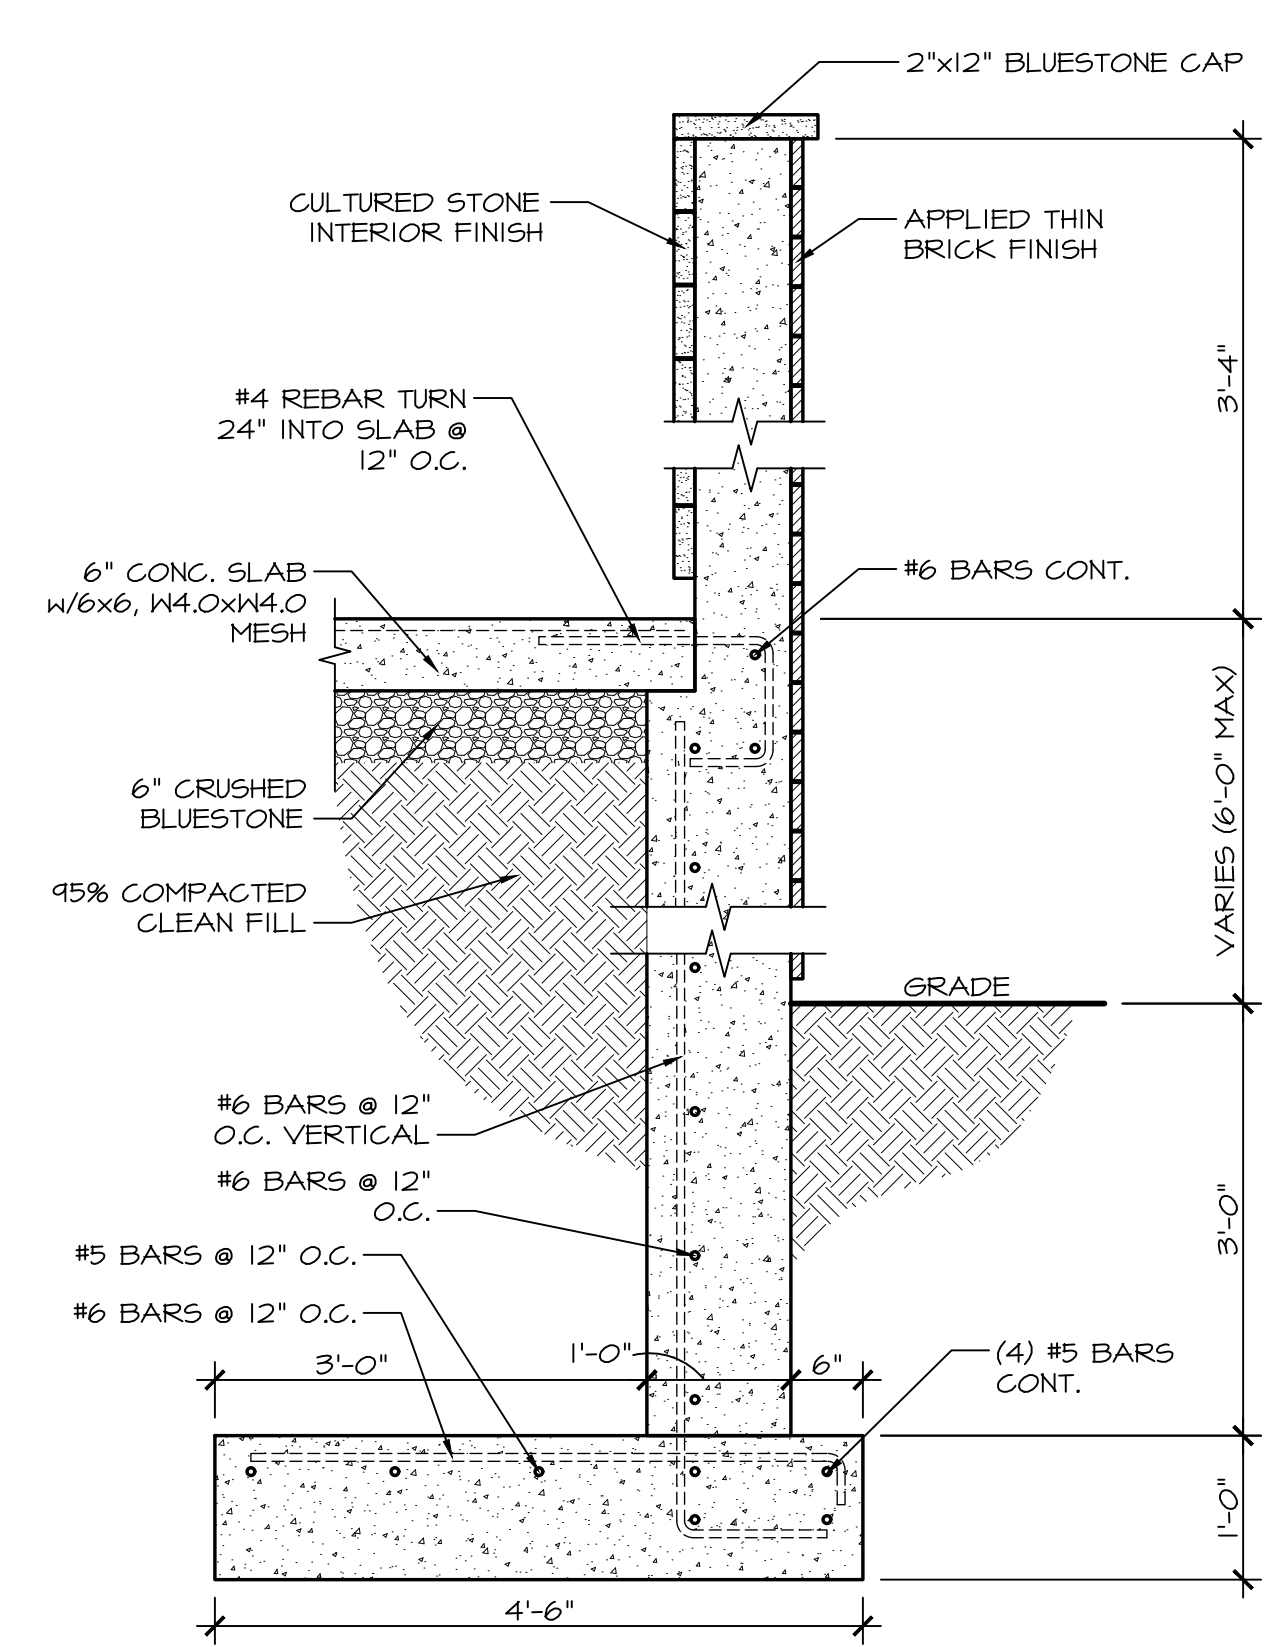

1 RETAINING WALL DETAIL
SCALE: 3/4" = 1'-0"

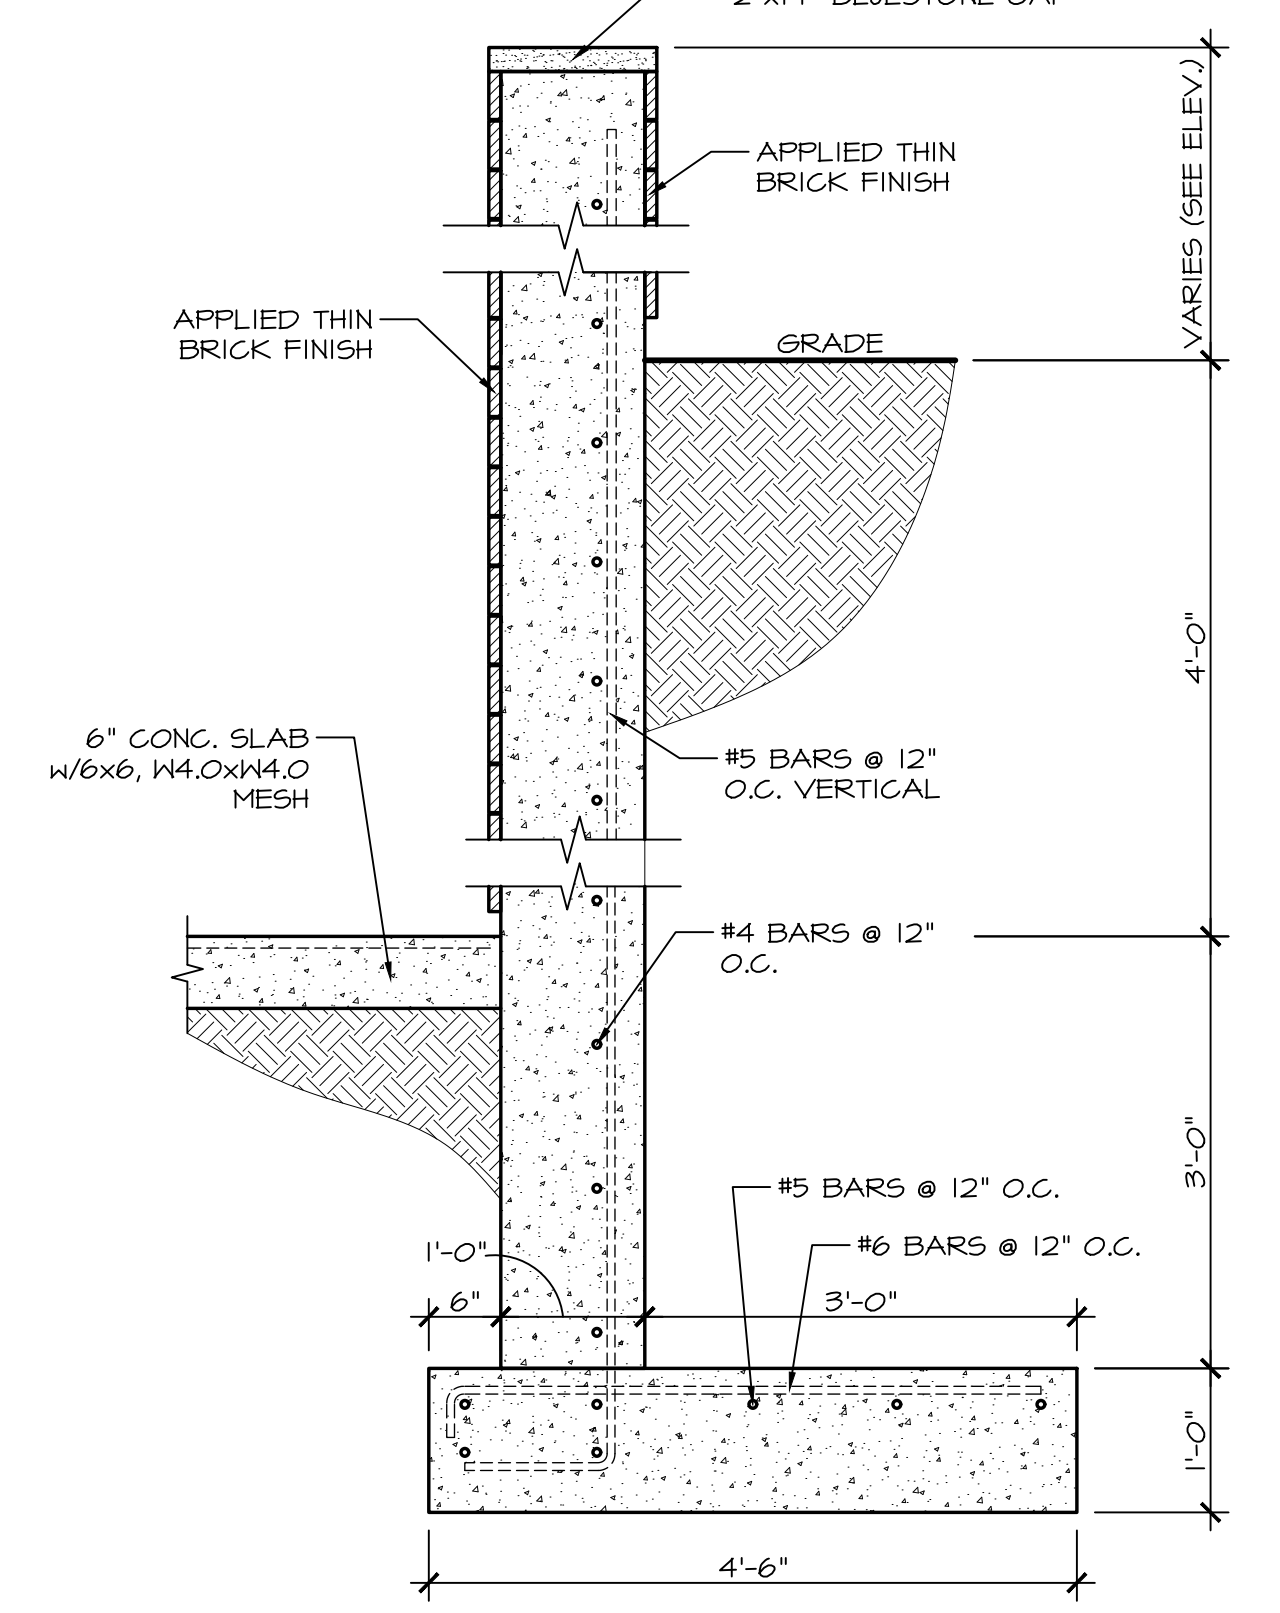

2 RETAINING WALL DETAIL
SCALE: 3/4" = 1'-0"

DATE: ISSUE
---20--- ISSUED FOR BIDDING & PERMIT

SEAL:

SENDEWSKI ARCHITECTS PC
ARCHITECTS - PLANNERS
215 ROANOKE AVENUE
RIVERHEAD, NY 11901
(631) 727-5352

9 SELENA COURT
WALDEN, NY 12586
(845) 275-8859

PROPOSED PAVILLION
TAPPAN FIRE DISTRICT
300 WESTERN HIGHWAY SOUTH
TAPPAN, NY 10983

LOWER LEVEL/FOUNDATION PLAN

PROJECT #: 2108.02


DRAWN BY: AR/JC

CAD FILE: 2108.02/P/BID

DRAWING#:

PAVILLION

07-12-22 UPDATE

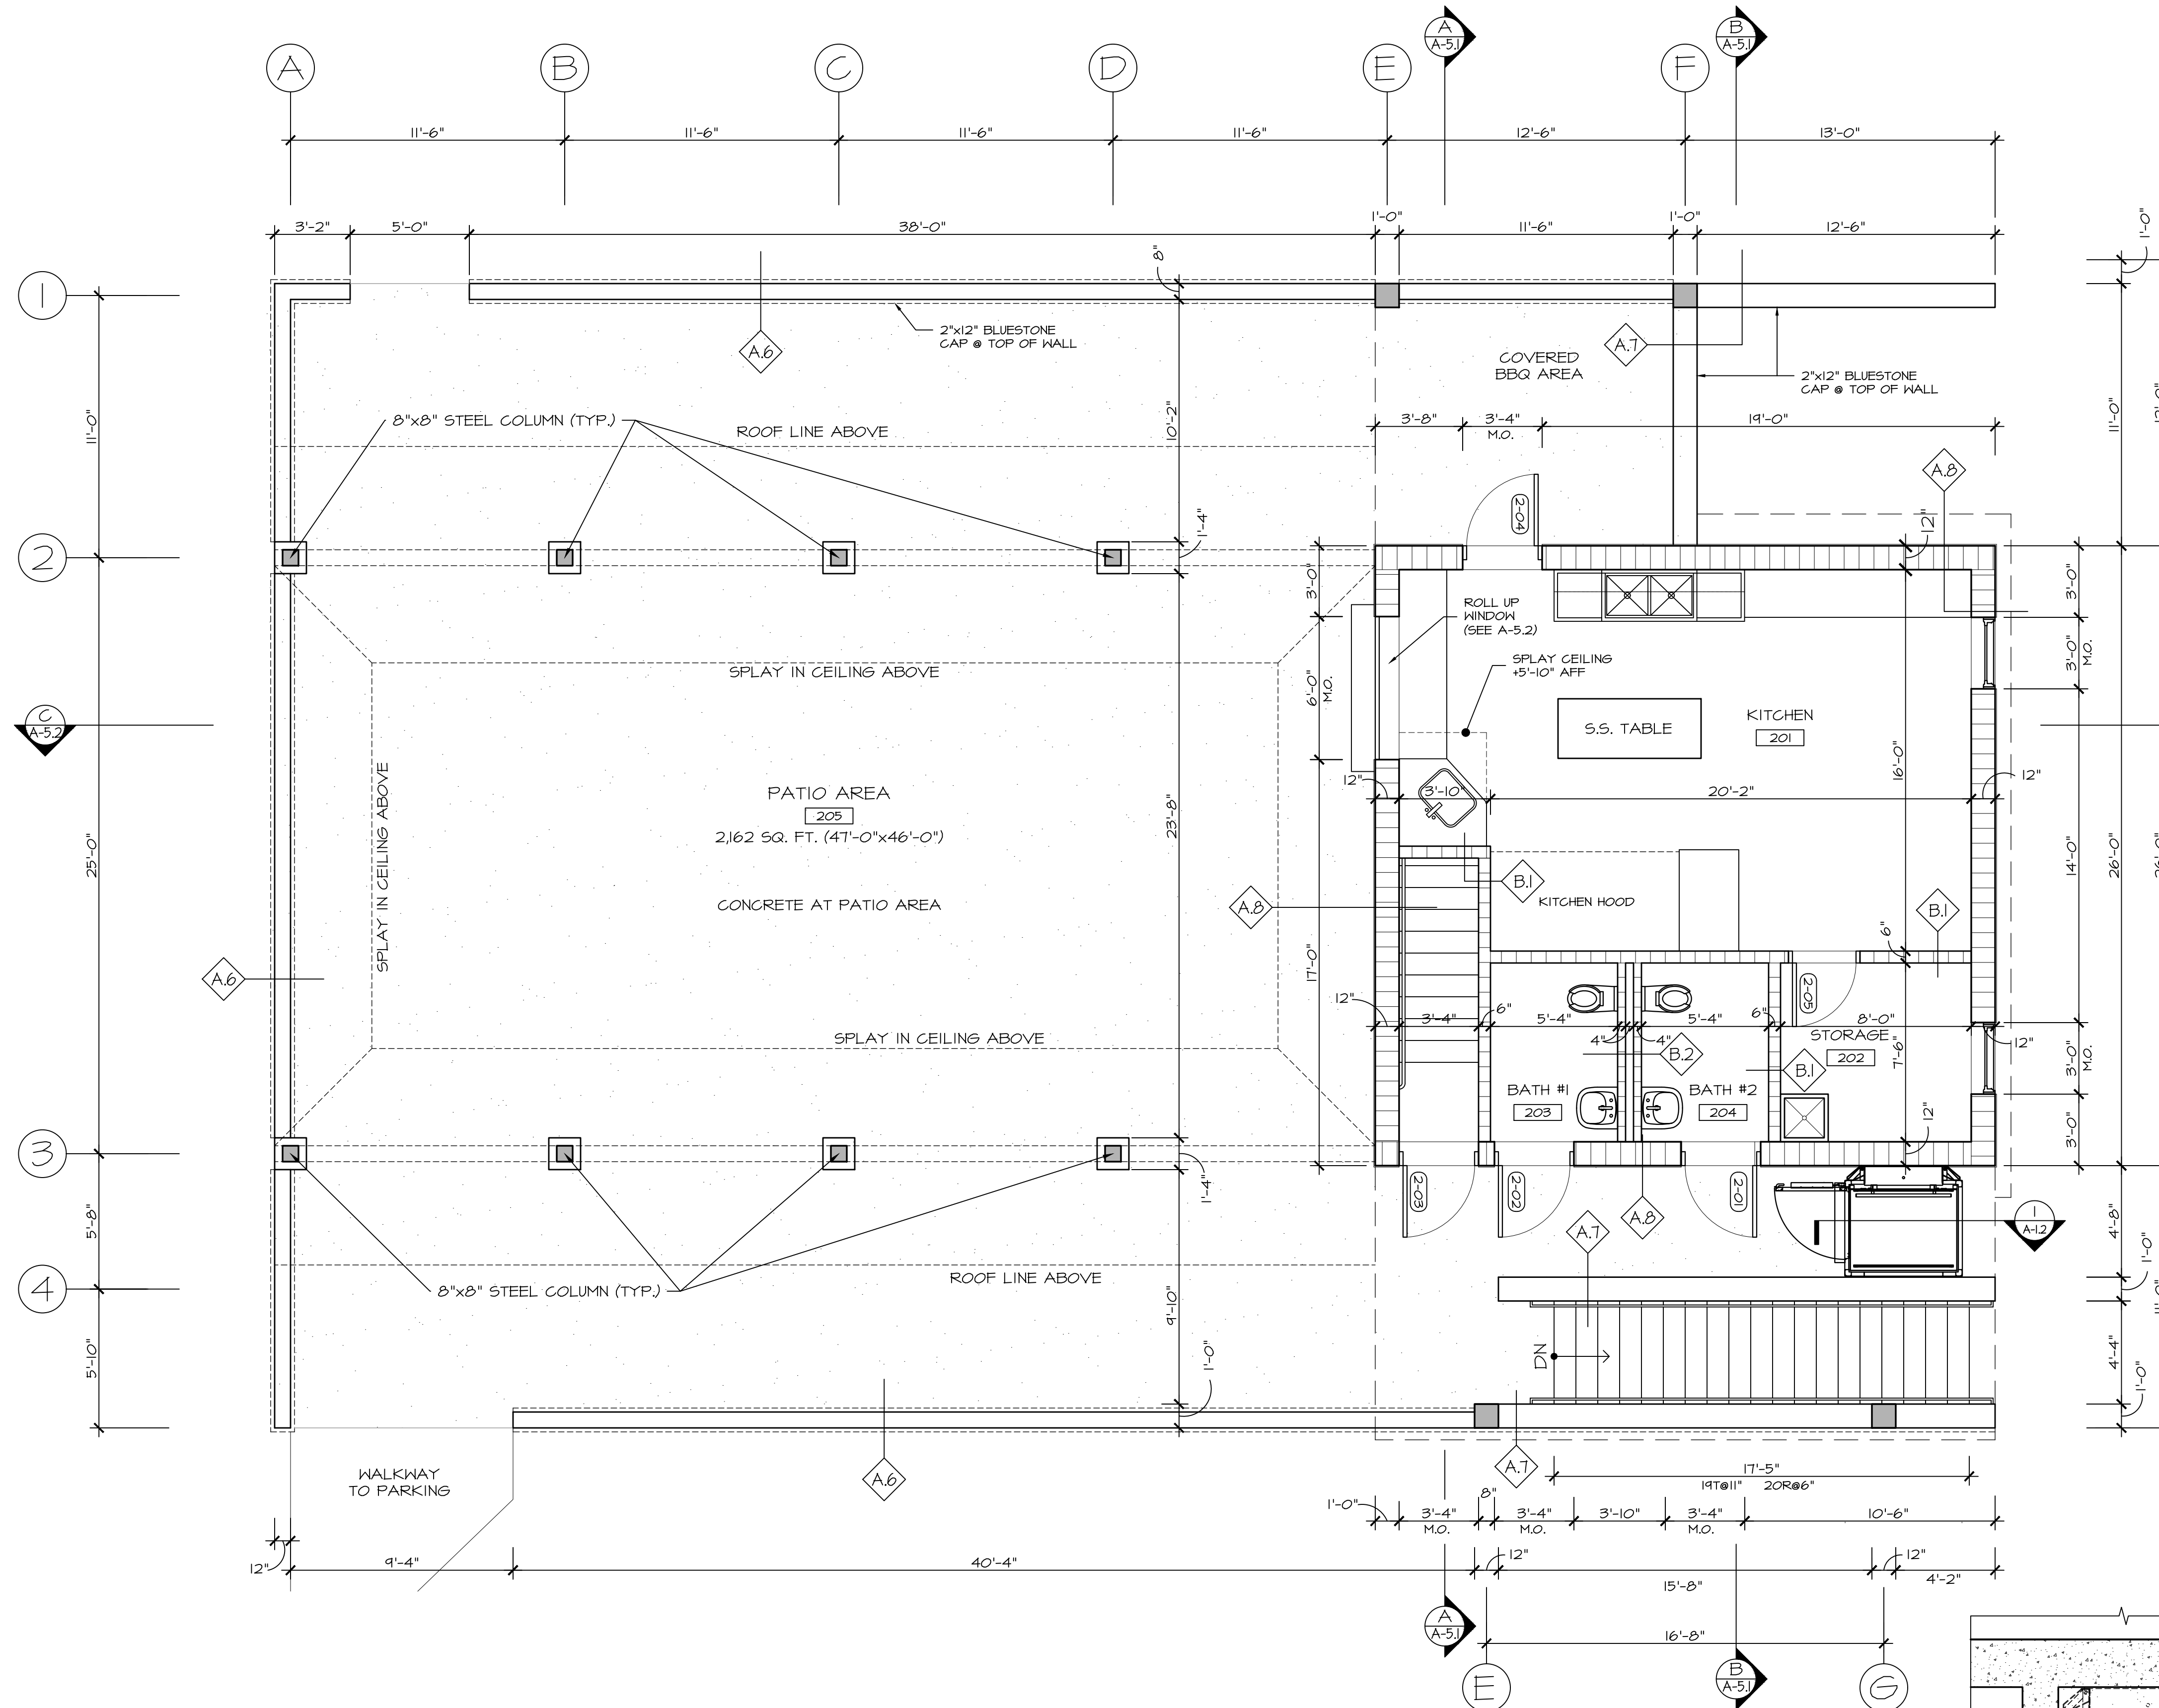


MAIN LEVEL PLAN
SCALE: 1/4" = 1'-0"

OCCUPANCY

KITCHEN: 800 sf / 200 = 4.1
ASSEMBLY AREAS: 2,162 sf / 15 = 144.13
TOTAL OCCUPANT LOAD: = 148.23


WALL TYPES LEGEND

A.1	EXTERIOR WALL	16" 4,000 PSI CONC. WALL
A.2	EXTERIOR WALL	12" 4,000 PSI CONC. WALL
A.3	EXTERIOR WALL	12" 4,000 PSI CONC. WALL w/ EXTERIOR APPLIED THIN BRICK FINISH BOTH SIDES
A.4	EXTERIOR WALL	16" CONC. WALL w/ 36" HIGH CULTURED STONE WATER TABLE AND APPLIED THIN BRICK FINISH ABOVE.
A.5	EXTERIOR WALL	16" CONC. WALL w/ APPLIED THIN BRICK FINISH ABOVE.
A.6	EXTERIOR WALL	8" CONC. WALL w/ CULTURED STONE INTERIOR FINISH, APPLIED THIN BRICK EXTERIOR FINISH, 2"x12" BLUESTONE CAP @ TOP OF WALL.
A.7	EXTERIOR WALL	12" CONC. WALL w/ APPLIED THIN BRICK FINISH BOTH SIDE, 2"x12" BLUESTONE CAP @ TOP OF WALL.
A.8	EXTERIOR WALL	12" CMU BLOCK WALL w/ FULLY INSULATED CAVITY, 36" HIGH THIN BRICK @ BASE AND HARDIE PLANK LAP SIDING ABOVE.
A.9	EXTERIOR WALL	12" CMU BLOCK WALL TO 20" SILL HEIGHT, CONTINUE WITH 8" BLOCK TO UNDERSIDE OF ROOF w/ FULLY INSULATED CAVITY, HARDIE PLANK LAP SIDING.
A.10	EXTERIOR WALL	8" CMU BLOCK WALL w/ FULLY INSULATED CAVITY AND HARDIE PLANK LAP SIDING.
B.1	INTERIOR WALL	6" CMU BLOCK WALL w/ FULLY INSULATED CAVITY
B.2	INTERIOR WET WALL	(3) 4" CMU BLOCK WALLS WITH 4" AIR GAPS IN-BETWEEN FOR PLUMBING
B.3	INTERIOR WALL	4" 19GA. HTL STUDS @ 24" O.C. FULL HEIGHT TO DECK, 5/8" GYP. BOARD EA. SIDE, TAPE SPACKLE AND PAINT

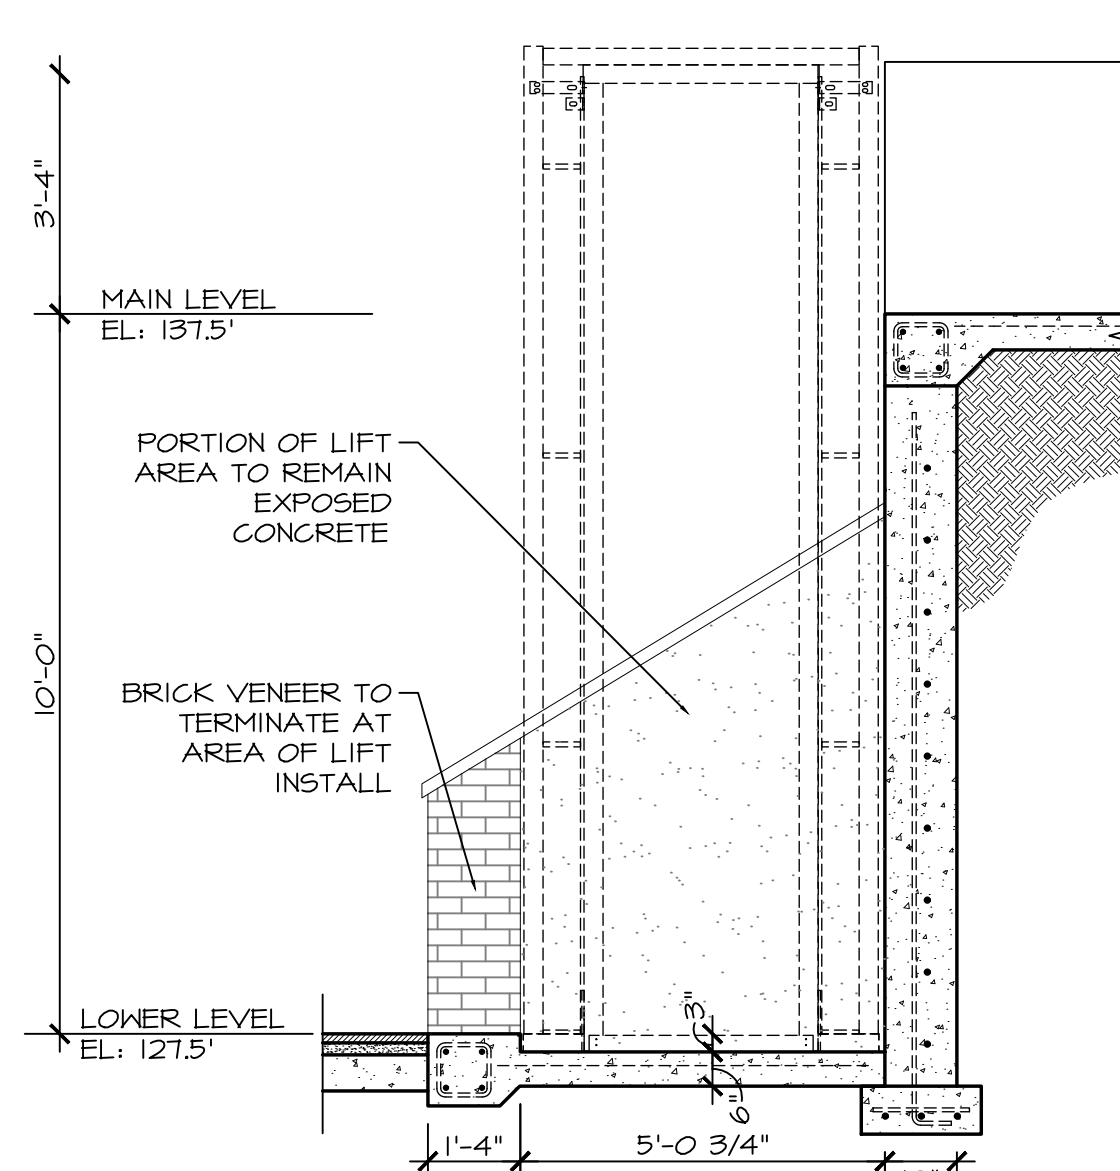

LIFT PIT SECTION

SCALE: 3/8" = 1'-0"

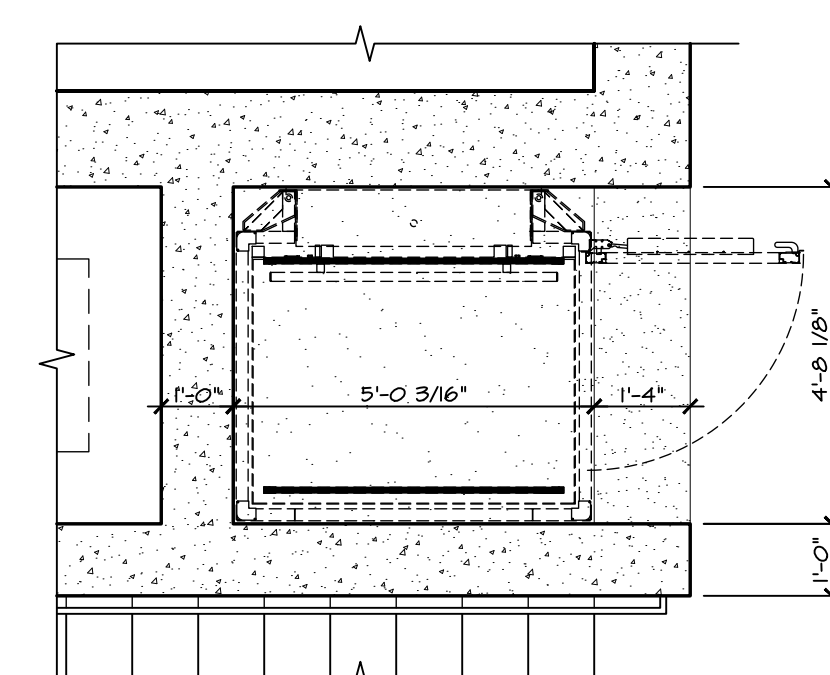

LIFT PLAN

SCALE: 3/8" = 1'-0"

GENERAL:	ASME A187.1 SAFETY STANDARD FOR PLATFORMS LIFTS AND STAIRWAY CHAIRLIFTS
GENERAL:	COLOR: STANDARD SILVER MOON POWDERED ALUMINUM EXTRUSIONS WITH 8 GA. GALVANIZED STEEL PANELS POWDER COATED SILVER MOON
GENERAL:	OUTDOOR KIT - PIT HOIST (GRAB REQUIRED) AND 20" FLEXIBLE STEERING
GENERAL:	NUMBER OF STOPS - TWO STOP KIT
DRIVE HAUST:	MODEL: 6V1-EH144
DRIVE HAUST:	CHAIN HYDRAULIC DRIVE SYSTEM CAN CONTINUOUS HAND POWER WITH AUXILIARY BATTERY POWER SYSTEM PLATFORM
DRIVE HAUST:	LOWERING SPEED: 100 LB & 175 LB
DRIVE HAUST:	TRAVEL SPEED: 200 LB & 175 LB
DRIVE HAUST:	POWER SUPPLY: 120 VAC, SINGLE PHASE, 60 HZ, ON A DEDICATED 15 AMP CIRCUIT
DRIVE HAUST:	EQUIPPED WITH ELECTRICAL DISCONNECT (SHIPPED LOOSE) (A) OIL RECOVERY SYSTEM, SPLIT HAUST KIT.
CONTROLS:	PLATFORM CONTROLS: PUSH-BUTTON (TACTILE) TYPE CAN ILLUMINATED DIRECTIONAL BUTTONS, CORRIDOR LIGHTING, ILLUMINATED BOARD (PUSHBUTTON) EMERGENCY STOP SWITCH & AUDIBLE ALARM.
CONTROLS:	LOWER LANDING CALL STATION: PUSH-BUTTON (TACTILE) WALL MOUNT
CONTROLS:	UPPER LANDING CALL STATION: PUSH-BUTTON (TACTILE) WALL MOUNT
CONTROLS:	EQUIPPED WITH TIME DELAY DOOR LOCK
PLATFORM:	SIZE: STANDARD CAN GRAB RAIL, ANTI-SKID DECK AND 48 1/4" HIGH CONSTRUCTION STEEL THROUGH (DO NOT EXCEED)
PLATFORM:	CAPACITY: MAXIMUM 200 LB OPERATING LOAD
PLATFORM:	EQUIPPED WITH AUTO-CALLER PHONE
DOOR/GATES:	LOWER: 36" WIDE 1/4" LAMINATED GLASS DOOR CAN POWERLOCK 2000 INTERLOCK & CHAIN DOOR STOP & GARAVENTA POWER DOOR OPERATOR
DOOR/GATES:	UPPER: 36" WIDE 1/4" LAMINATED GLASS GATE CAN POWERLOCK 2000 INTERLOCK & CHAIN DOOR STOP & GARAVENTA POWER DOOR OPERATOR
ENCLOSURE:	PANELS: STEEL
ENCLOSURE:	TOTAL INT HEIGHT: APPROXIMATELY 575 LB
ENCLOSURE:	LIFTING HT. (A) 120" LOWER TO UPPER FLOOR PLUS 9" DEEP PIT

DATE: ISSUE

---20--- ISSUED FOR BIDDING & PERMIT

SEAL:

SENDELSKI ARCHITECTS PC
ARCHITECTS - PLANNERS
215 ROANOKE AVENUE
RIVERHEAD, NY 11901
(631) 727-5352
9 SELENA COURT
WALDEN, NY 12586
(845) 275-8859

PROPOSED PAVILLION
TAPPAN FIRE DISTRICT
300 WESTERN HIGHWAY SOUTH
TAPPAN, NY 10983

MAIN LEVEL PLAN

PROJECT #: 2108.02

DRAWN BY: AR/JC


CAD FILE: 2108.02/P/BID

DRAWING#:

A-2

PAVILLION

07-12-22 UPDATE

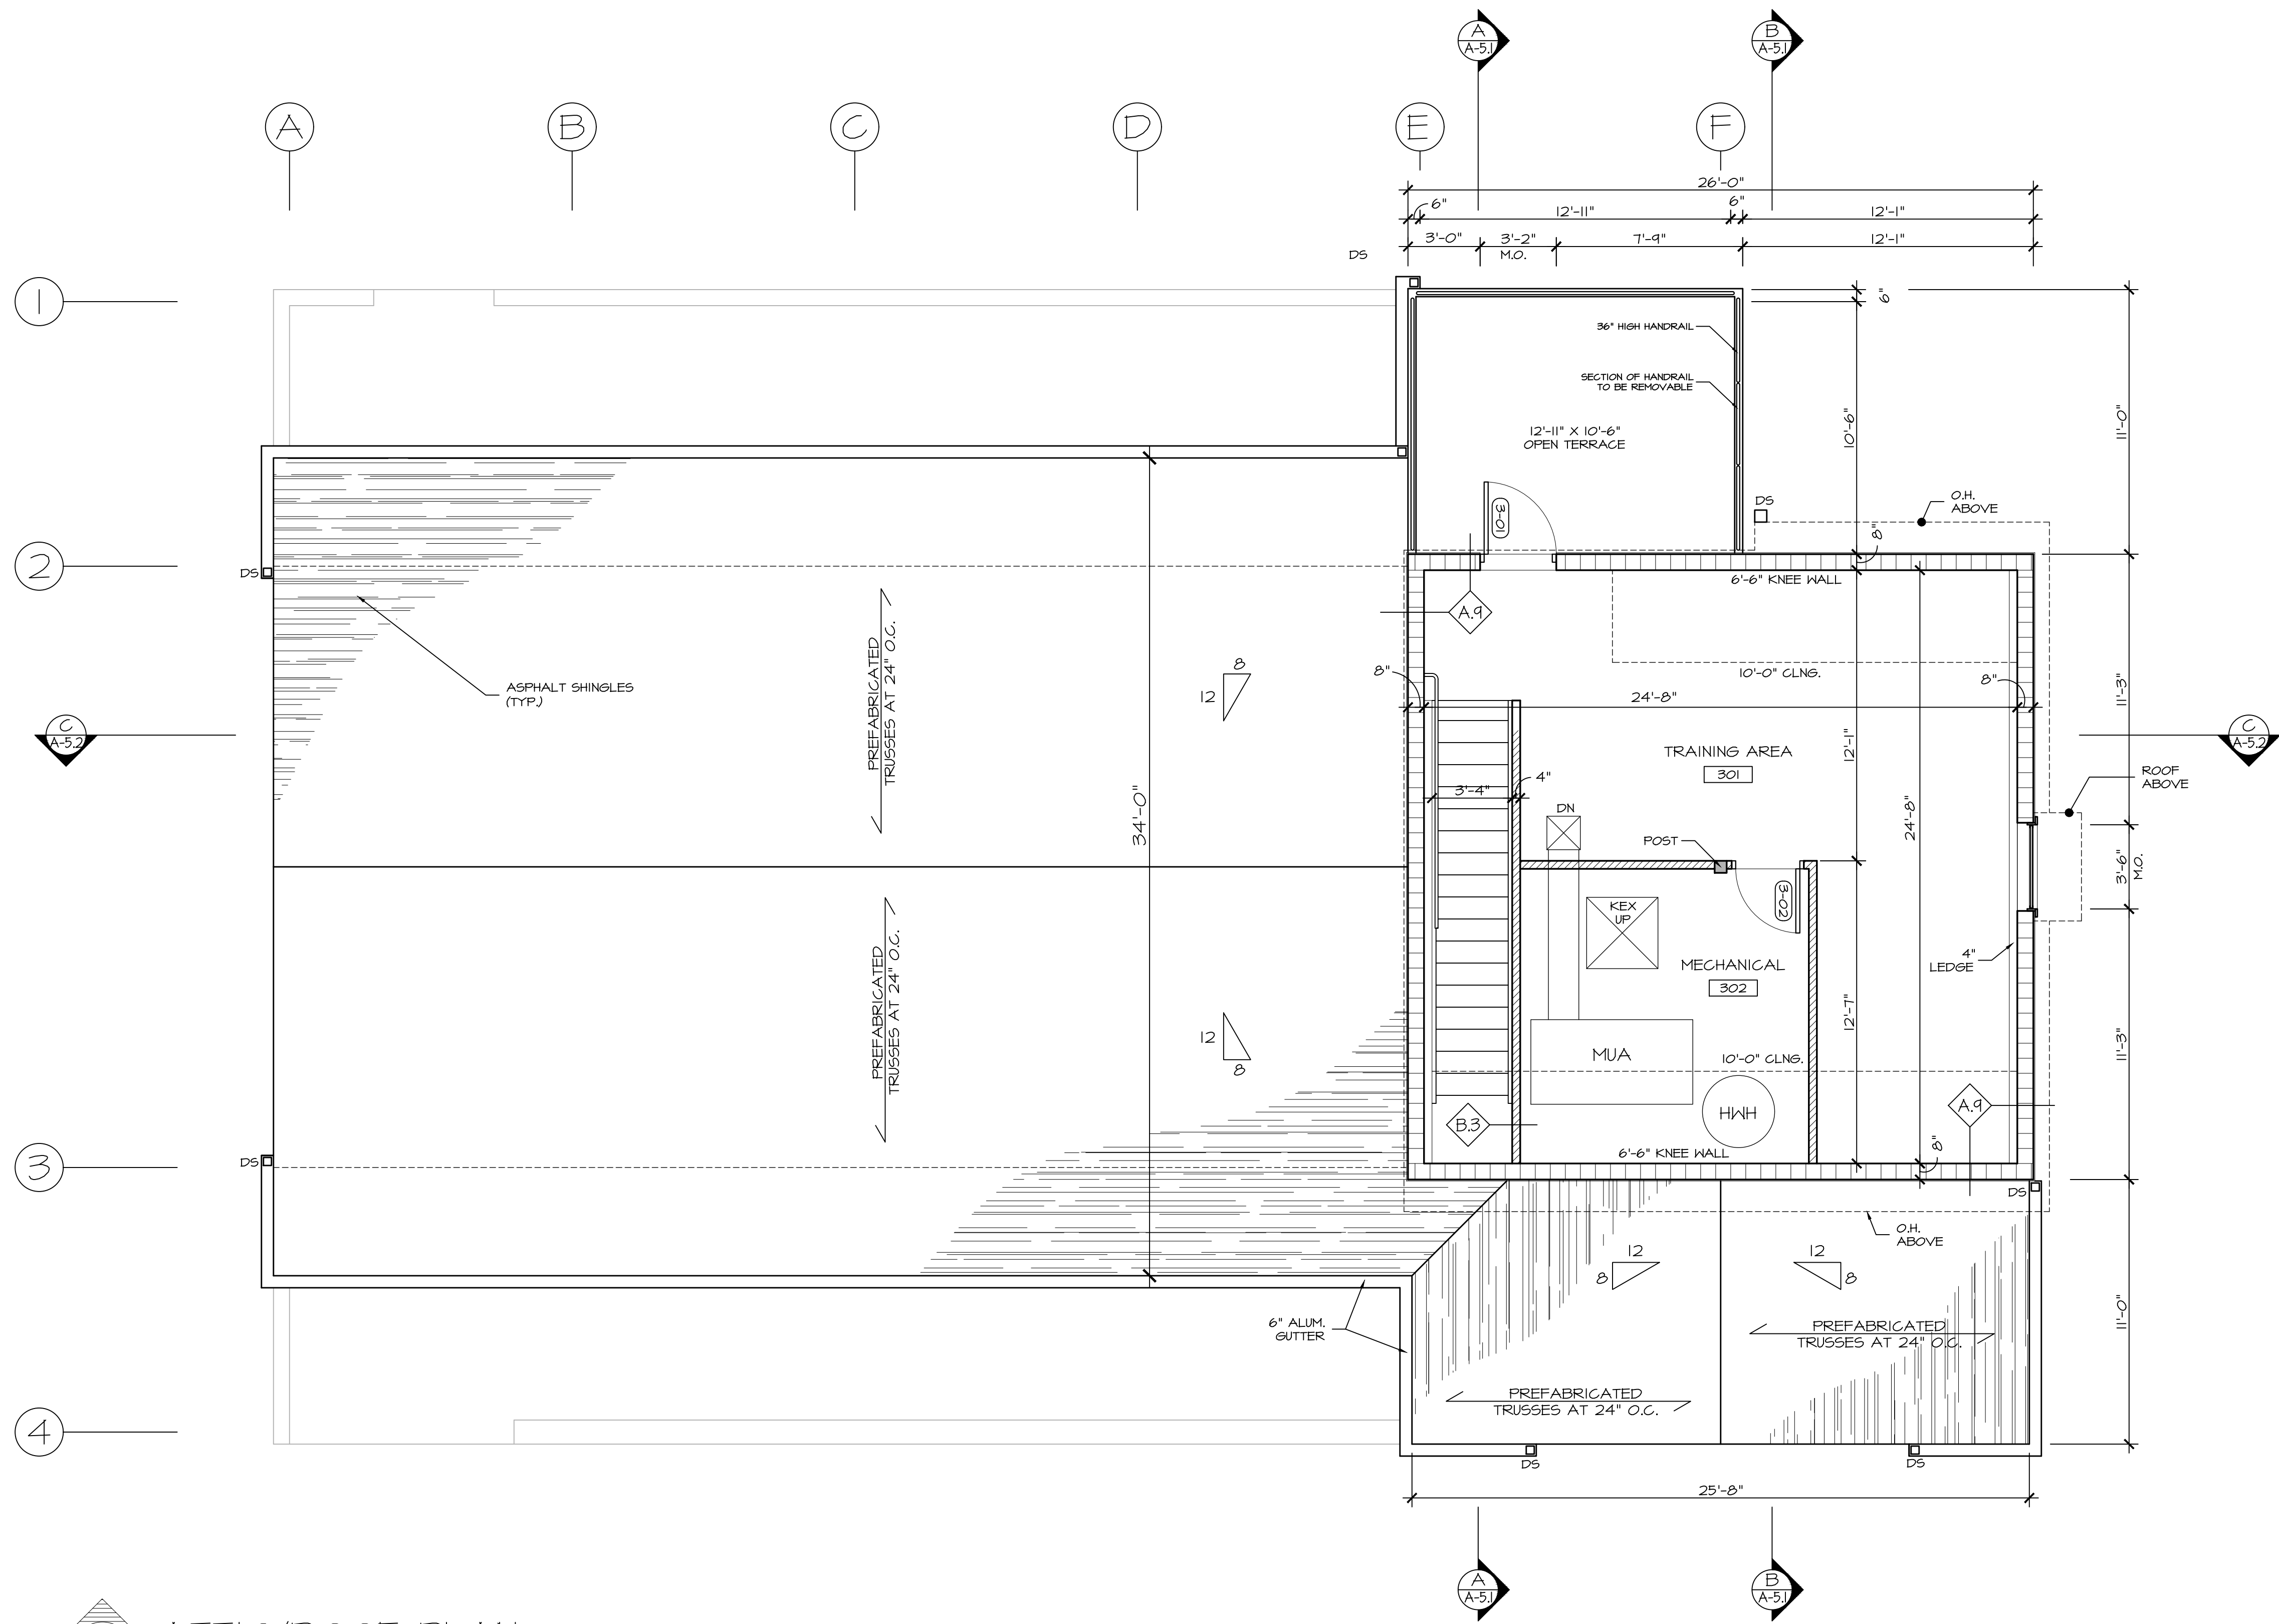

ATTIC/ROOF PLAN
SCALE: 1/4" = 1'-0"

DATE: ISSUE
---20--- ISSUED
FOR BIDDING
& PERMIT

SEAL:

SENDLEWSKI ARCHITECTS PC
ARCHITECTS - PLANNERS
215 ROANOKE AVENUE
RIVERHEAD, NY 11901
(631) 727-5352
9 SELENA COURT
WALDEN, NY 12586
(845) 275-8859

PROPOSED PAVILLION
TAPPAN FIRE DISTRICT
300 WESTERN HIGHWAY SOUTH
TAPPAN, NY 10983

ATTIC/ROOF PLAN

PROJECT #: 2108.02

DRAWN BY: AR/JC

CAD FILE: 2108.02/P./BID

DRAWING#:

A-3

PAVILLION

07-11-22 UPDATE

SEAL:

SENDEWSKI ARCHITECTS PC
ARCHITECTS - PLANNERS
215 ROANOKE AVENUE
RIVERHEAD, NY 11901
(631) 727-5352
9 SELENA COURT
WALDEN, NY 12586
(845) 275-8859

PROPOSED PAVILLION
TAPPAN FIRE DISTRICT
300 WESTERN HIGHWAY SOUTH
TAPPAN, NY 10983

ELEVATIONS

PROJECT #: 2102/C

DRAWN BY:

CAD FILE: 2102/P/BID

DRAWING#:



A=4.1


PAVILLION

07-11-22 UPDATE

LEGEND


- ALL SLOPED ROOF AREAS SHALL BE MARINO JOISTS SIZED W/ 1 1/2" HOMASOTE NFOR ROOF DECKING W/ TYVEK PROTEC UNDERLAYMENT FELT, CERTAIN-TEED "HIGHLAND" ROOFING SHINGLES (OR EQUAL) TYPICAL. COLOR SELECTED BY OWNER. (PROVIDE ADD ALTERNATE FOR STANDING SEAM METAL ROOF)
- EXTERIOR THIN BRICK VENEER SHALL BE -- OR EQUAL QUALITY. COLOR AS SELECTED BY OWNER.
- EXTERIOR STONE VENEER UNIT SHALL BE ---. COLOR TO TO SELECTED BY OWNER
- 4" PRECAST HORIZONTAL ACCENT BAND, ROCK CAST, SELECT STONE SMOOTH FINISH, OR EQUAL. COLOR TO BE SELECTED BY OWNER.
- HARDI-PLANK LAP SIDING 8" EXPOSURE, FINISH SHALL BE CEDARMILL. COLOR TO BE SELECTED BY OWNER.
- 8" FASCIA BOARD PRE-PRIMED (COLOR WHITE)
- 4" FRIEZE BOARD PRE-PRIMED (COLOR WHITE)
- 4" CORNER BOARD PRE-PRIMED (COLOR WHITE)
- NEW 10'-0" X 8'-0" (M.O.) OVERHEAD DOOR.
- H.M. INSULATED DOOR & FRAME WITH 4" HEAD
- ANDERSEN 400 SERIES TILT WASH WINDOW MODEL:TW21036
- GUTTERS SHALL BE S.A.F. 6" COLONIAL GUTTER SYSTEM W/ 4"x4" DOWNSPOUTS.
- NUMBERS SHALL BE METAL ARTS OR EQUAL (800) 237-8064. CAST METAL LETTERS 8" HIGH X 3/4" DEEP TIMES BD 210 STYLE WITH # 20 ACRYLIC BAKED ENAMEL FINISH. MOUNT WITH PMS-3 ALUMINUM TUBE SPACERS. VERIFY FINISH COLOR W/ OWNER.
- CAST STONE 6'-0" DIA. MALTESE CROSS.
- WALL PACK LIGHT, REFER TO DRAWING --- FOR SPECS. COORDINATE ALL EXTERIOR OUTLETS IN MASONRY WITH ELECTRICAL CONTRACTOR
- H.C. LIFT SHALL BE FROM GARAVENTA LIFT #711T2-16-A SEE DRAWING A-1.2 FOR DETAILS.
- 3'-8"x5'-8" ROLL DOWN SHUTTER SYSTEM
- 6'-0"x5'-8" ROLL UP WINDOW
- 1-1/2" HANDRAIL W/ REMOVABLE SECTION, HEIGHT TO MEET CODE
- 2" TRAINING BAR
- 12" STEEL TUBE FASCIA SECTIONS
- BBQ HOOD
- ROOF VENT

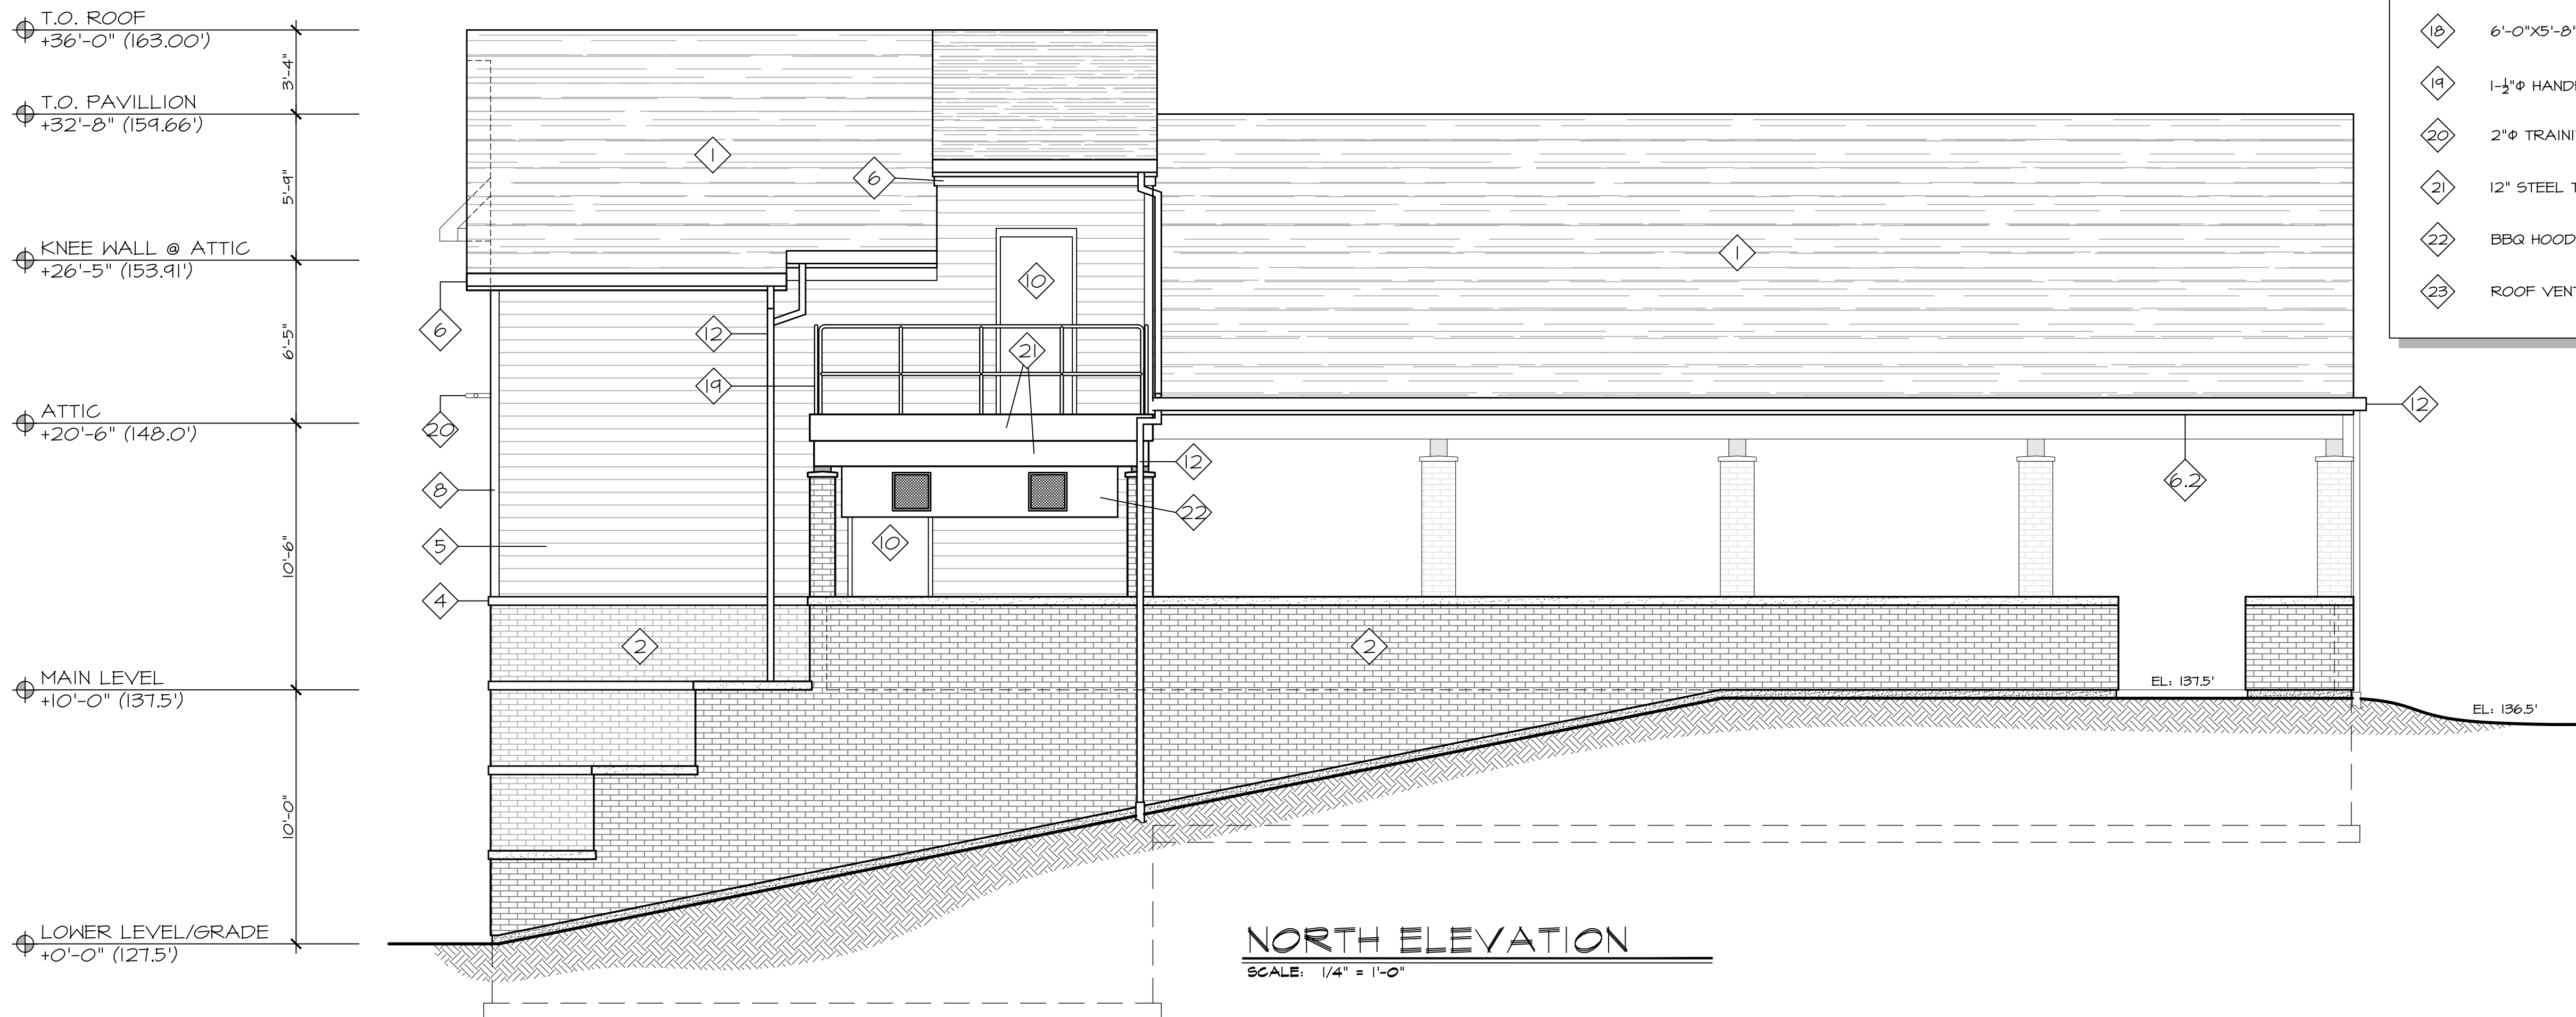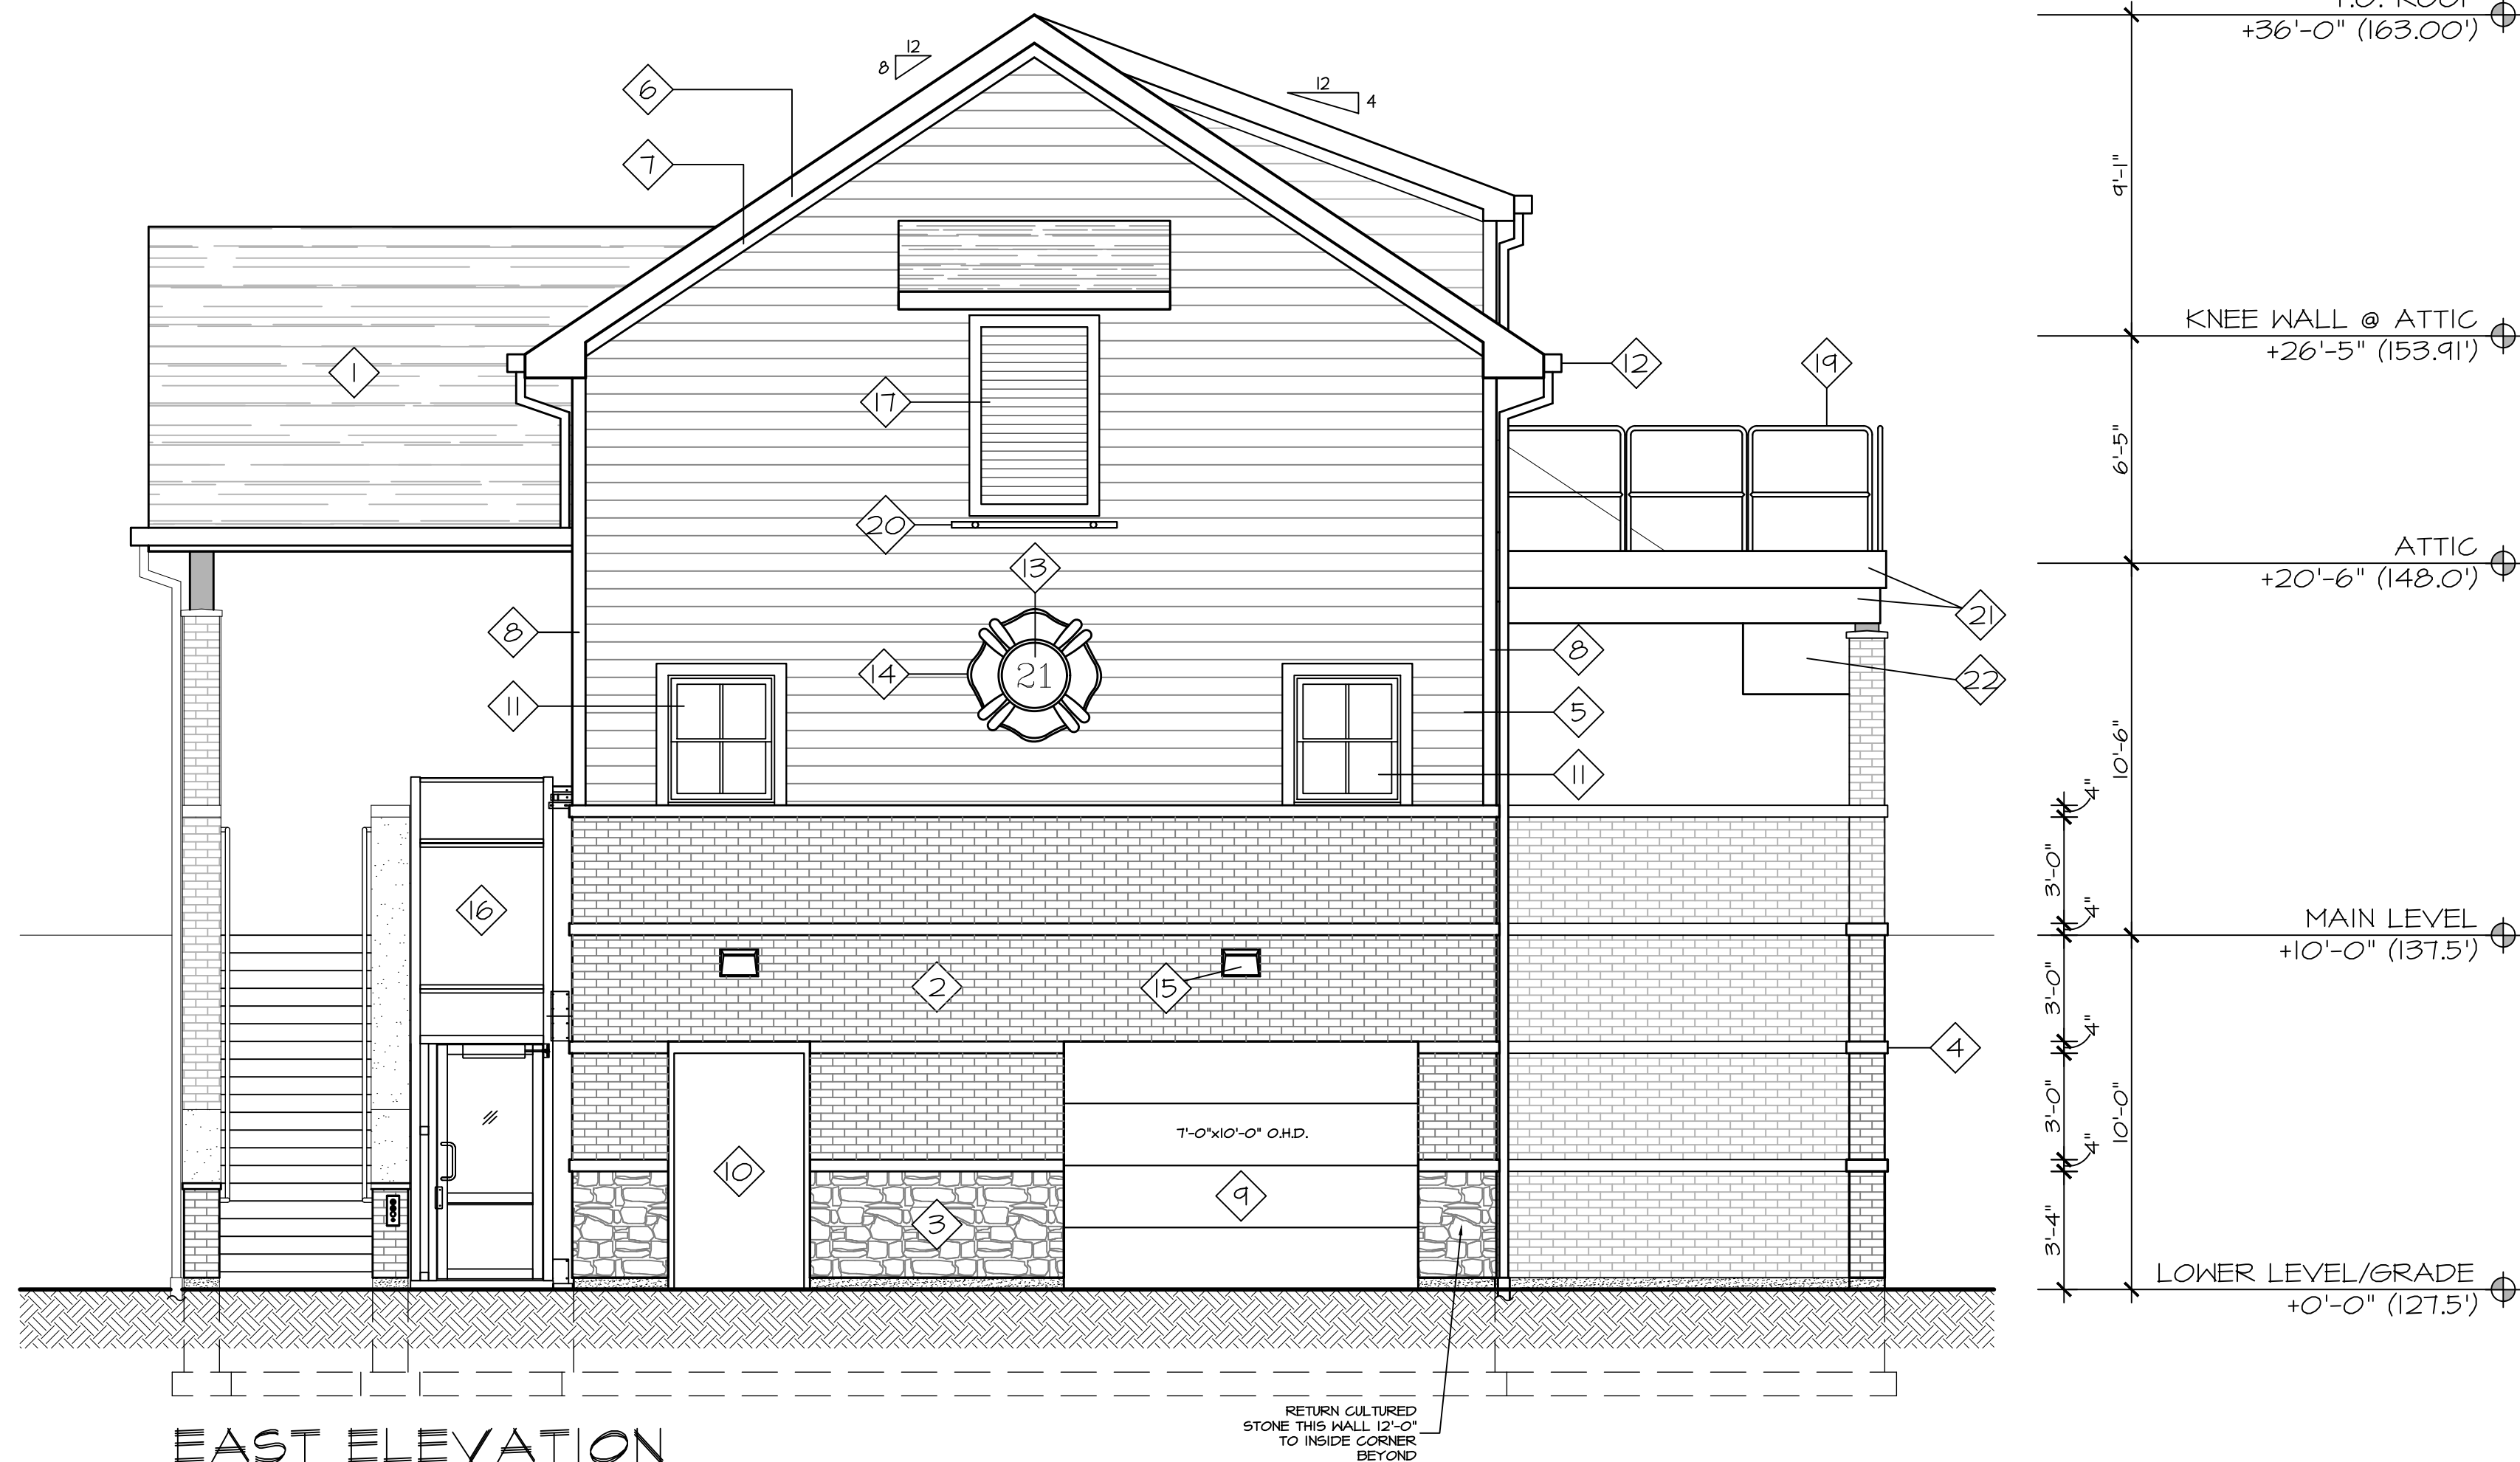

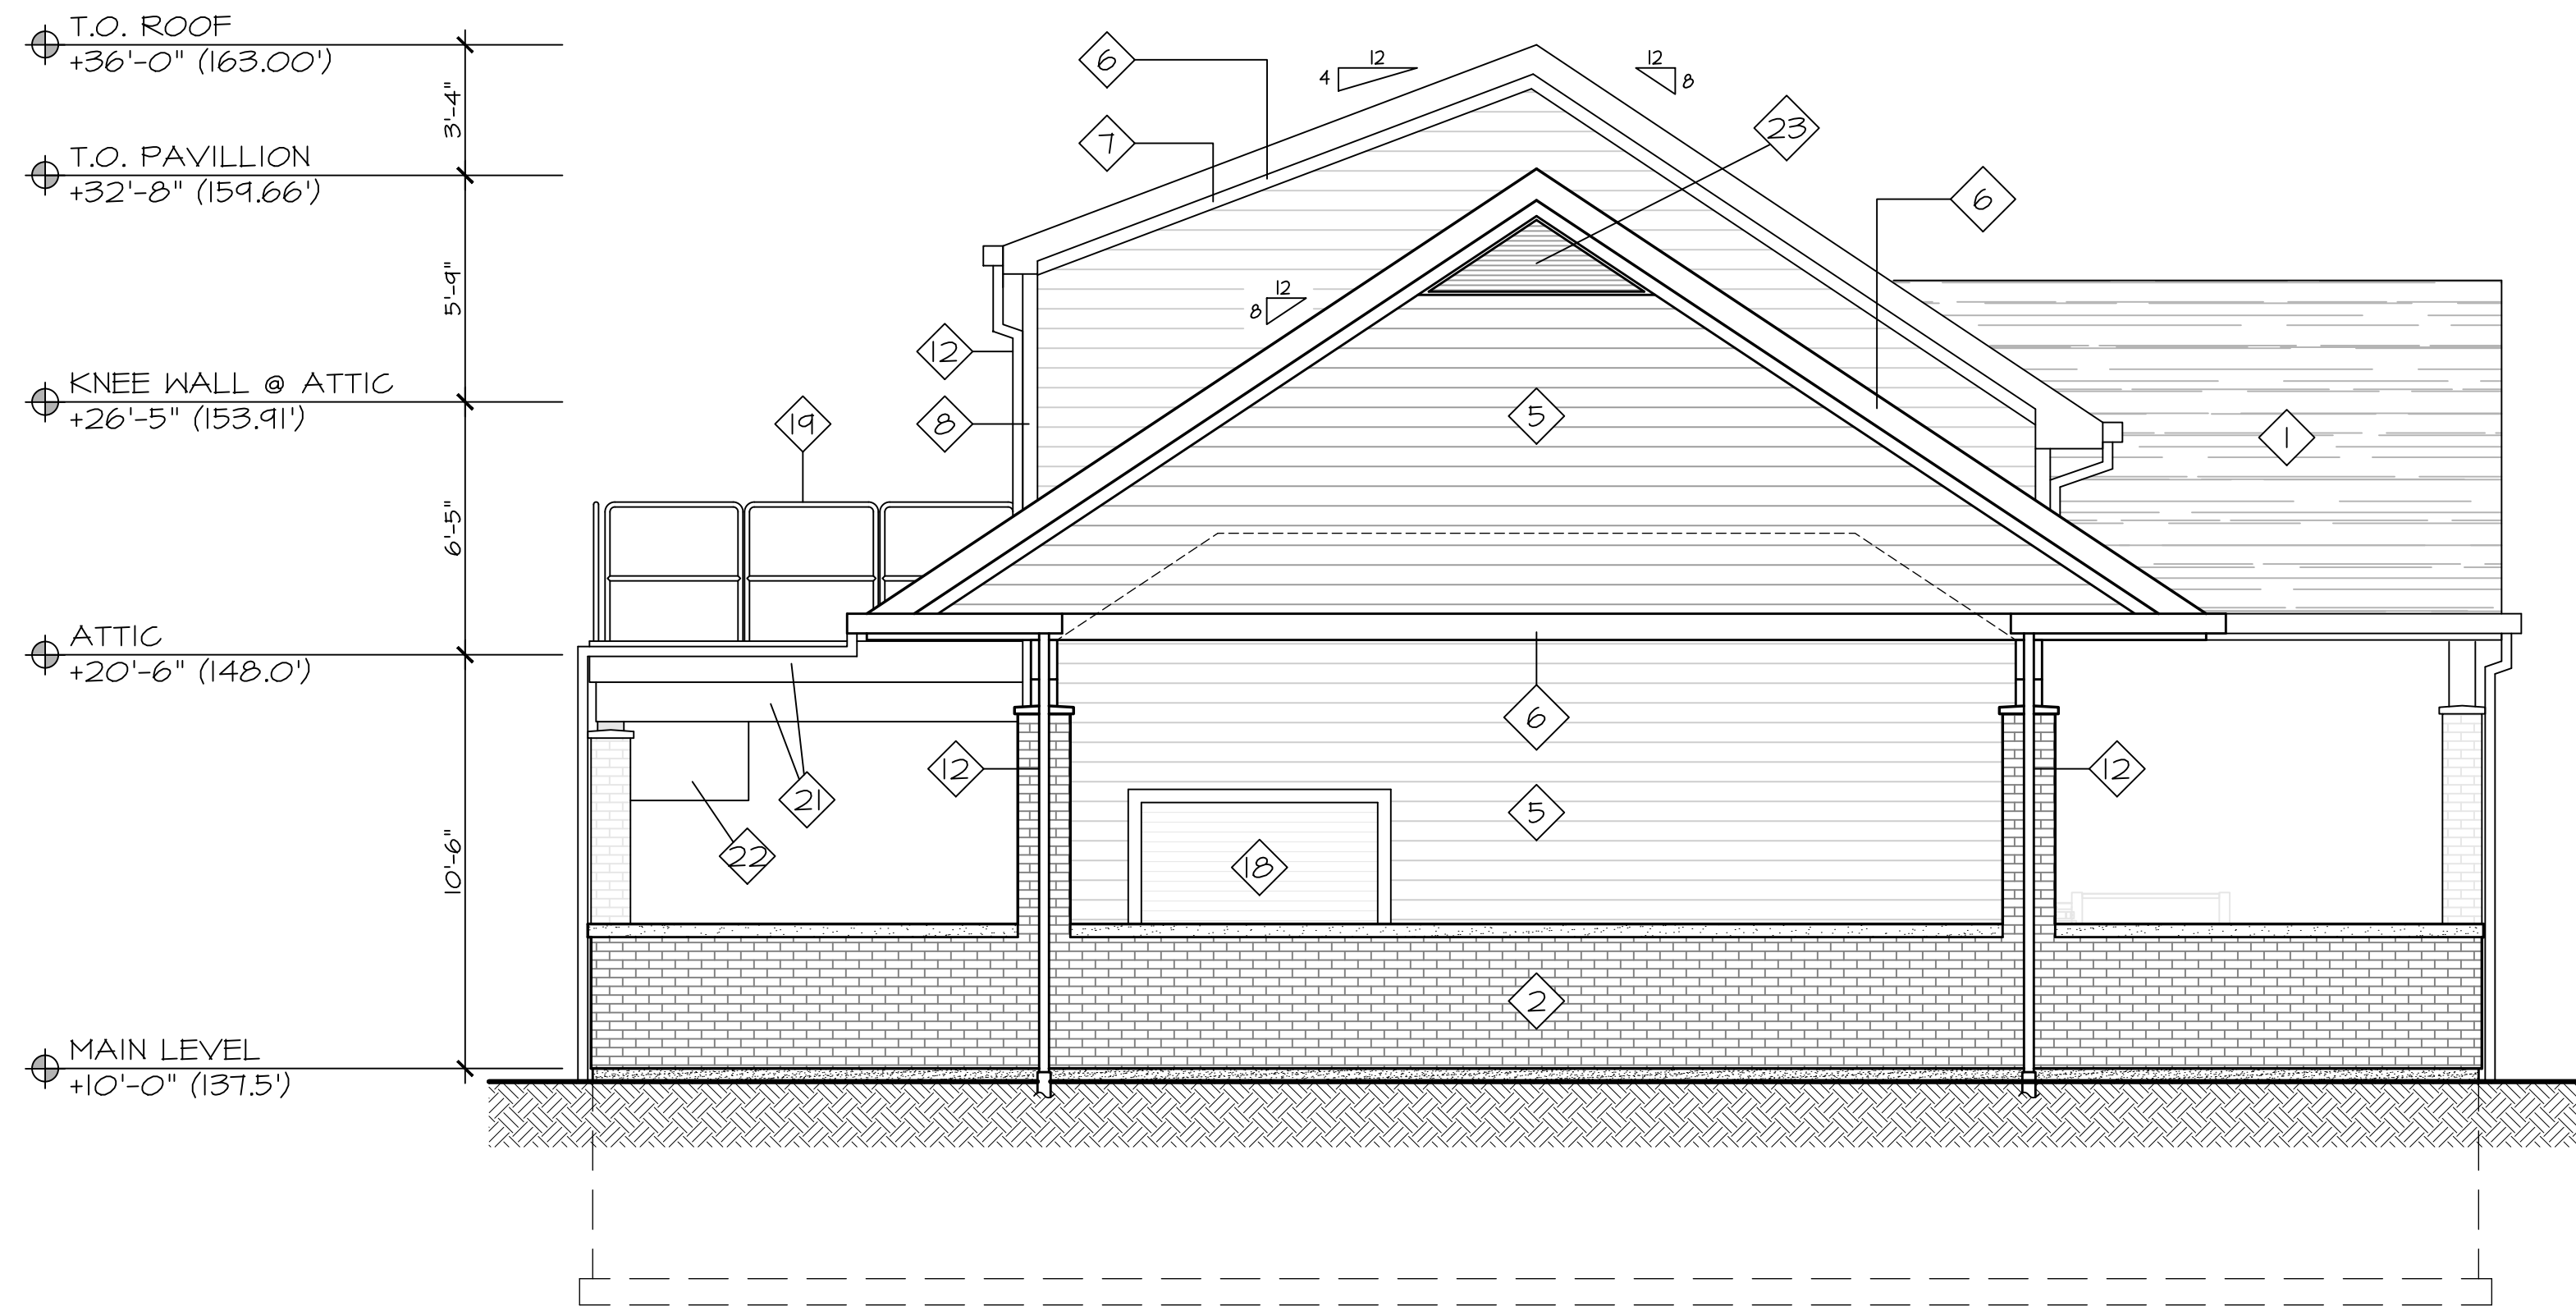


WEST ELEVATION

SCALE: 1/4" = 1'-0"

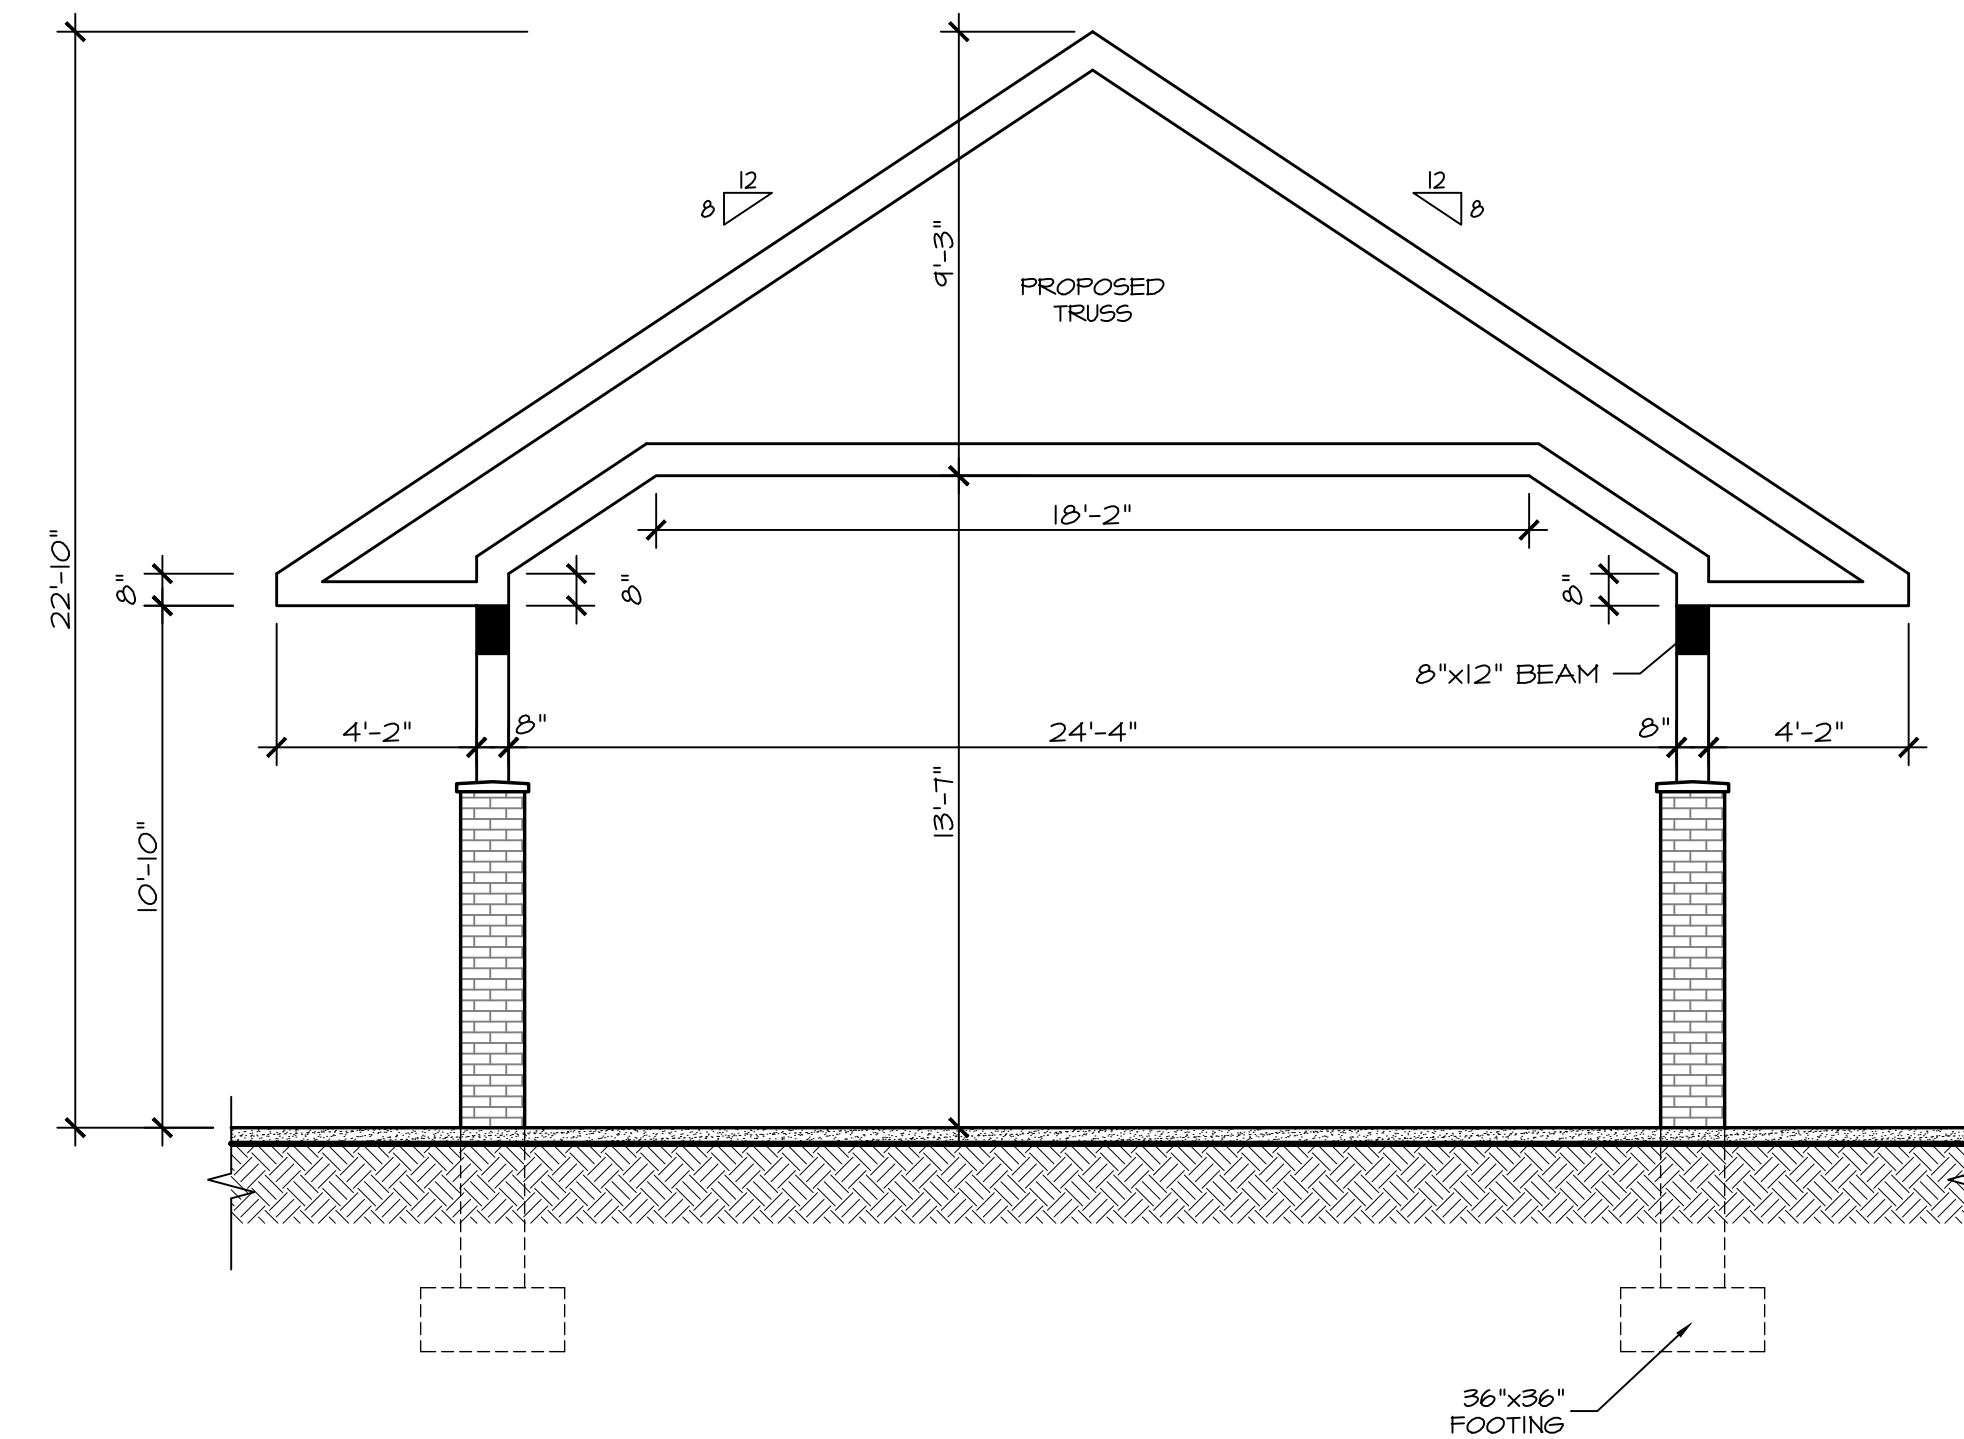

TRUSS SECTION

SCALE: 1/4" = 1'-0"

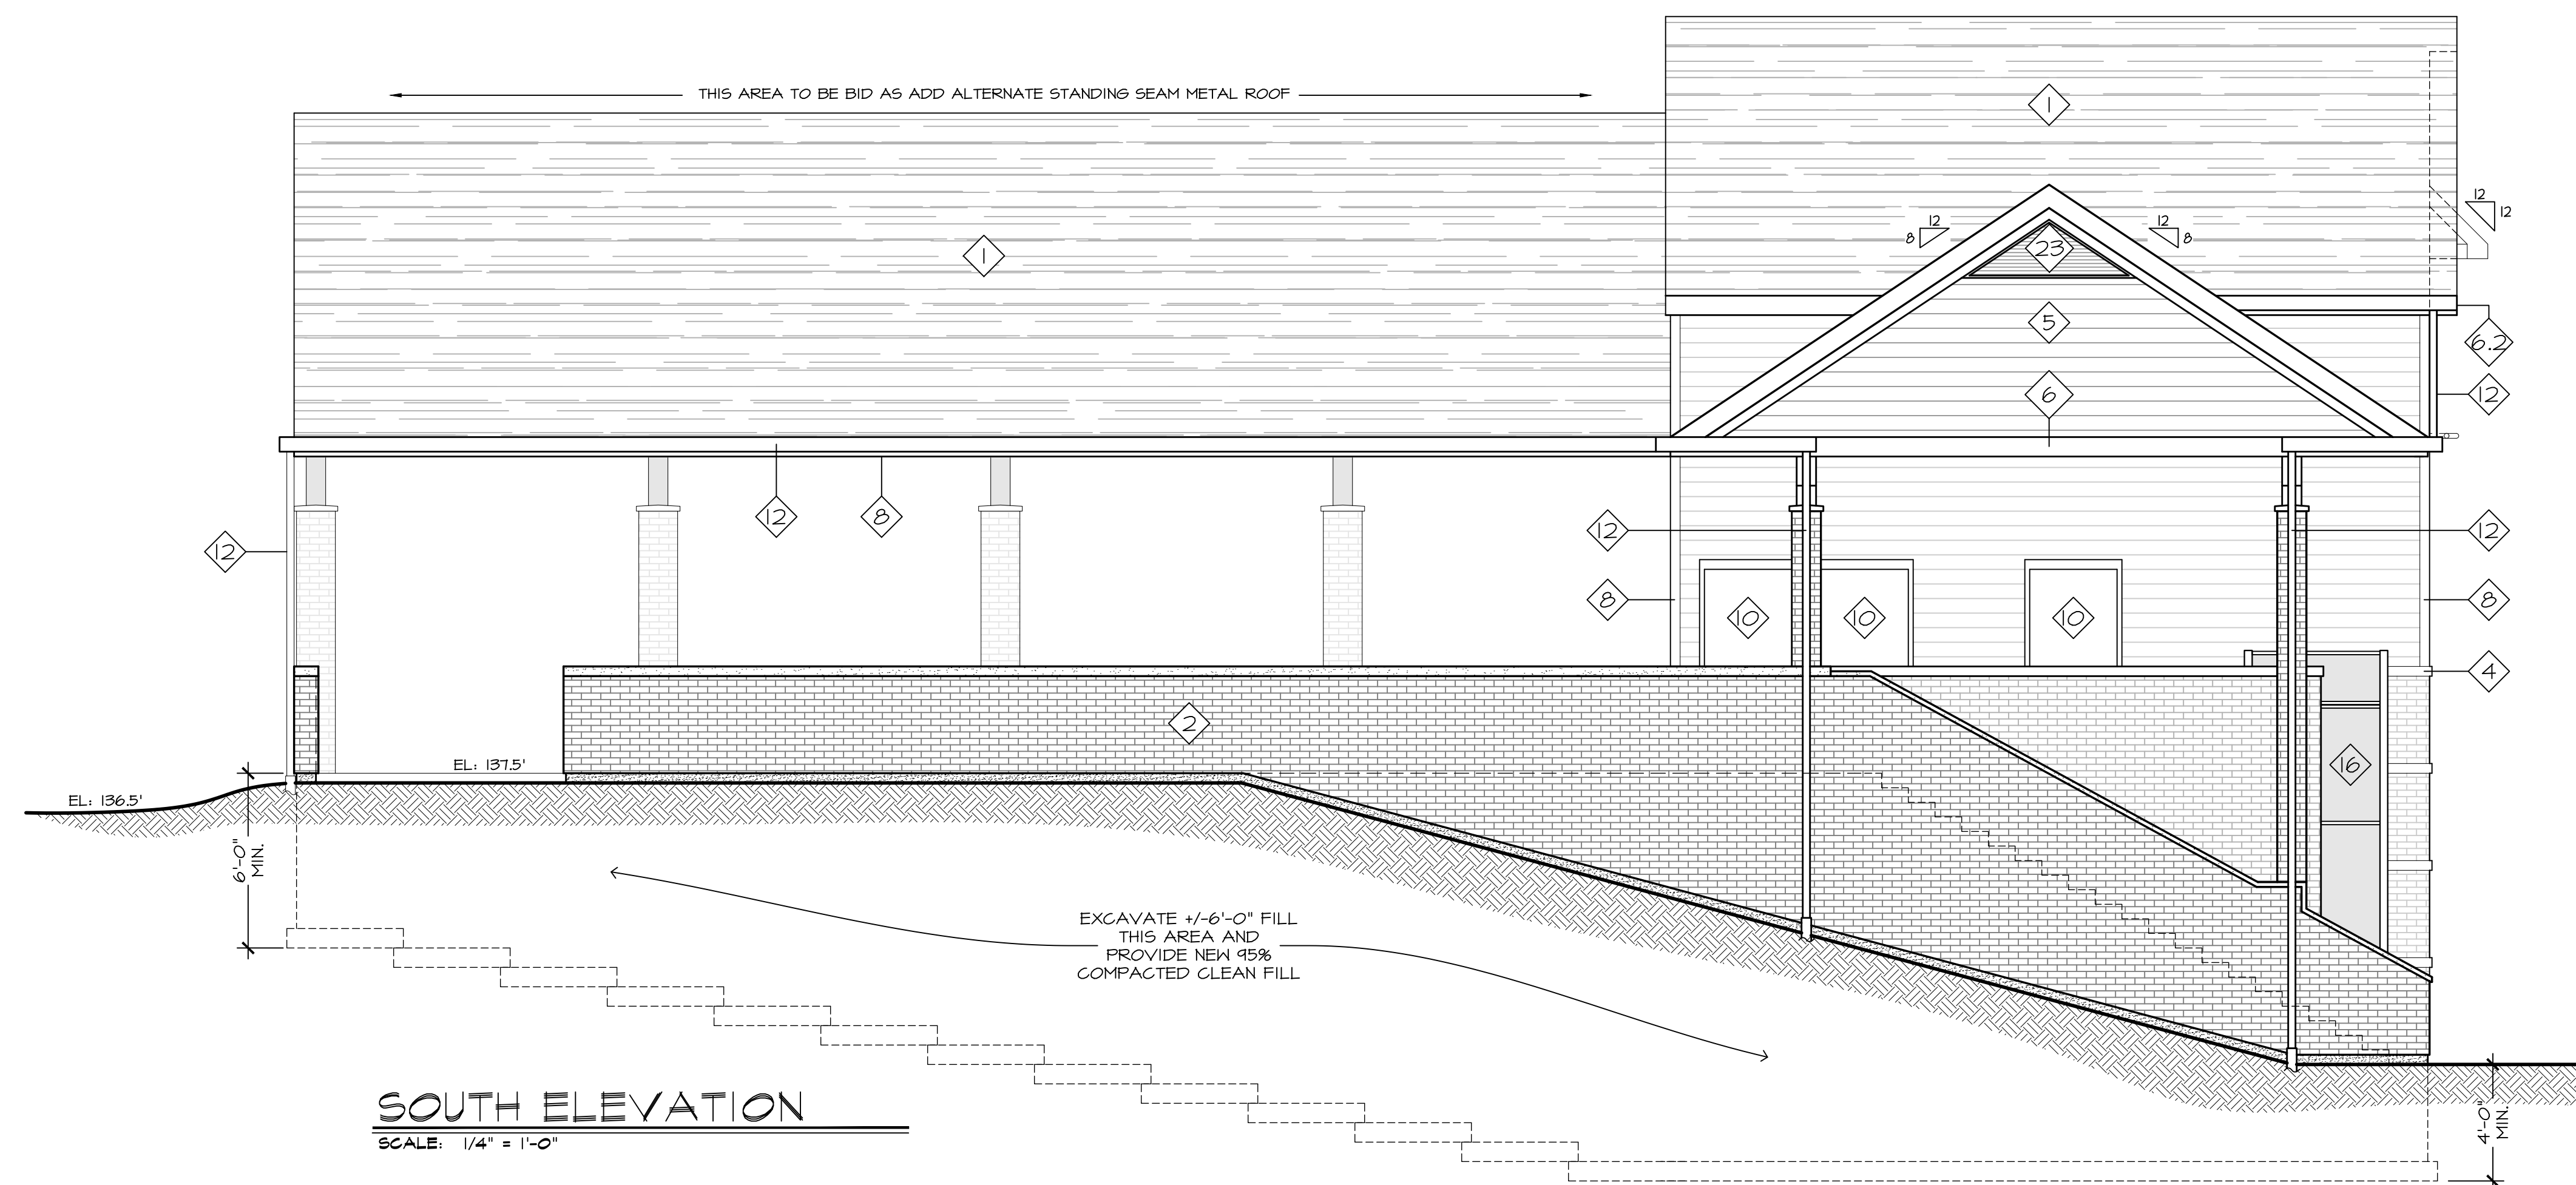

SOUTH ELEVATION

SCALE: 1/4" = 1'-0"

DATE: ISSUE
---20--- ISSUED
FOR BIDDING
& PERMIT

SEAL:

SENDEWSKI ARCHITECTS PC
ARCHITECTS - PLANNERS
215 ROANOKE AVENUE
RIVERHEAD, NY 11901
(631) 727-5352
9 SELENA COURT
WALDEN, NY 12586
(845) 275-8859

PROPOSED PAVILLION
TAPPAN FIRE DISTRICT
300 WESTERN HIGHWAY SOUTH
TAPPAN, NY 10983

ELEVATIONS

PROJECT #: 2108/C

DRAWN BY:


CAD FILE: 2108/P./BID

DRAWING#:


A-4.2

PAVILLION


07-11-22 UPDATE

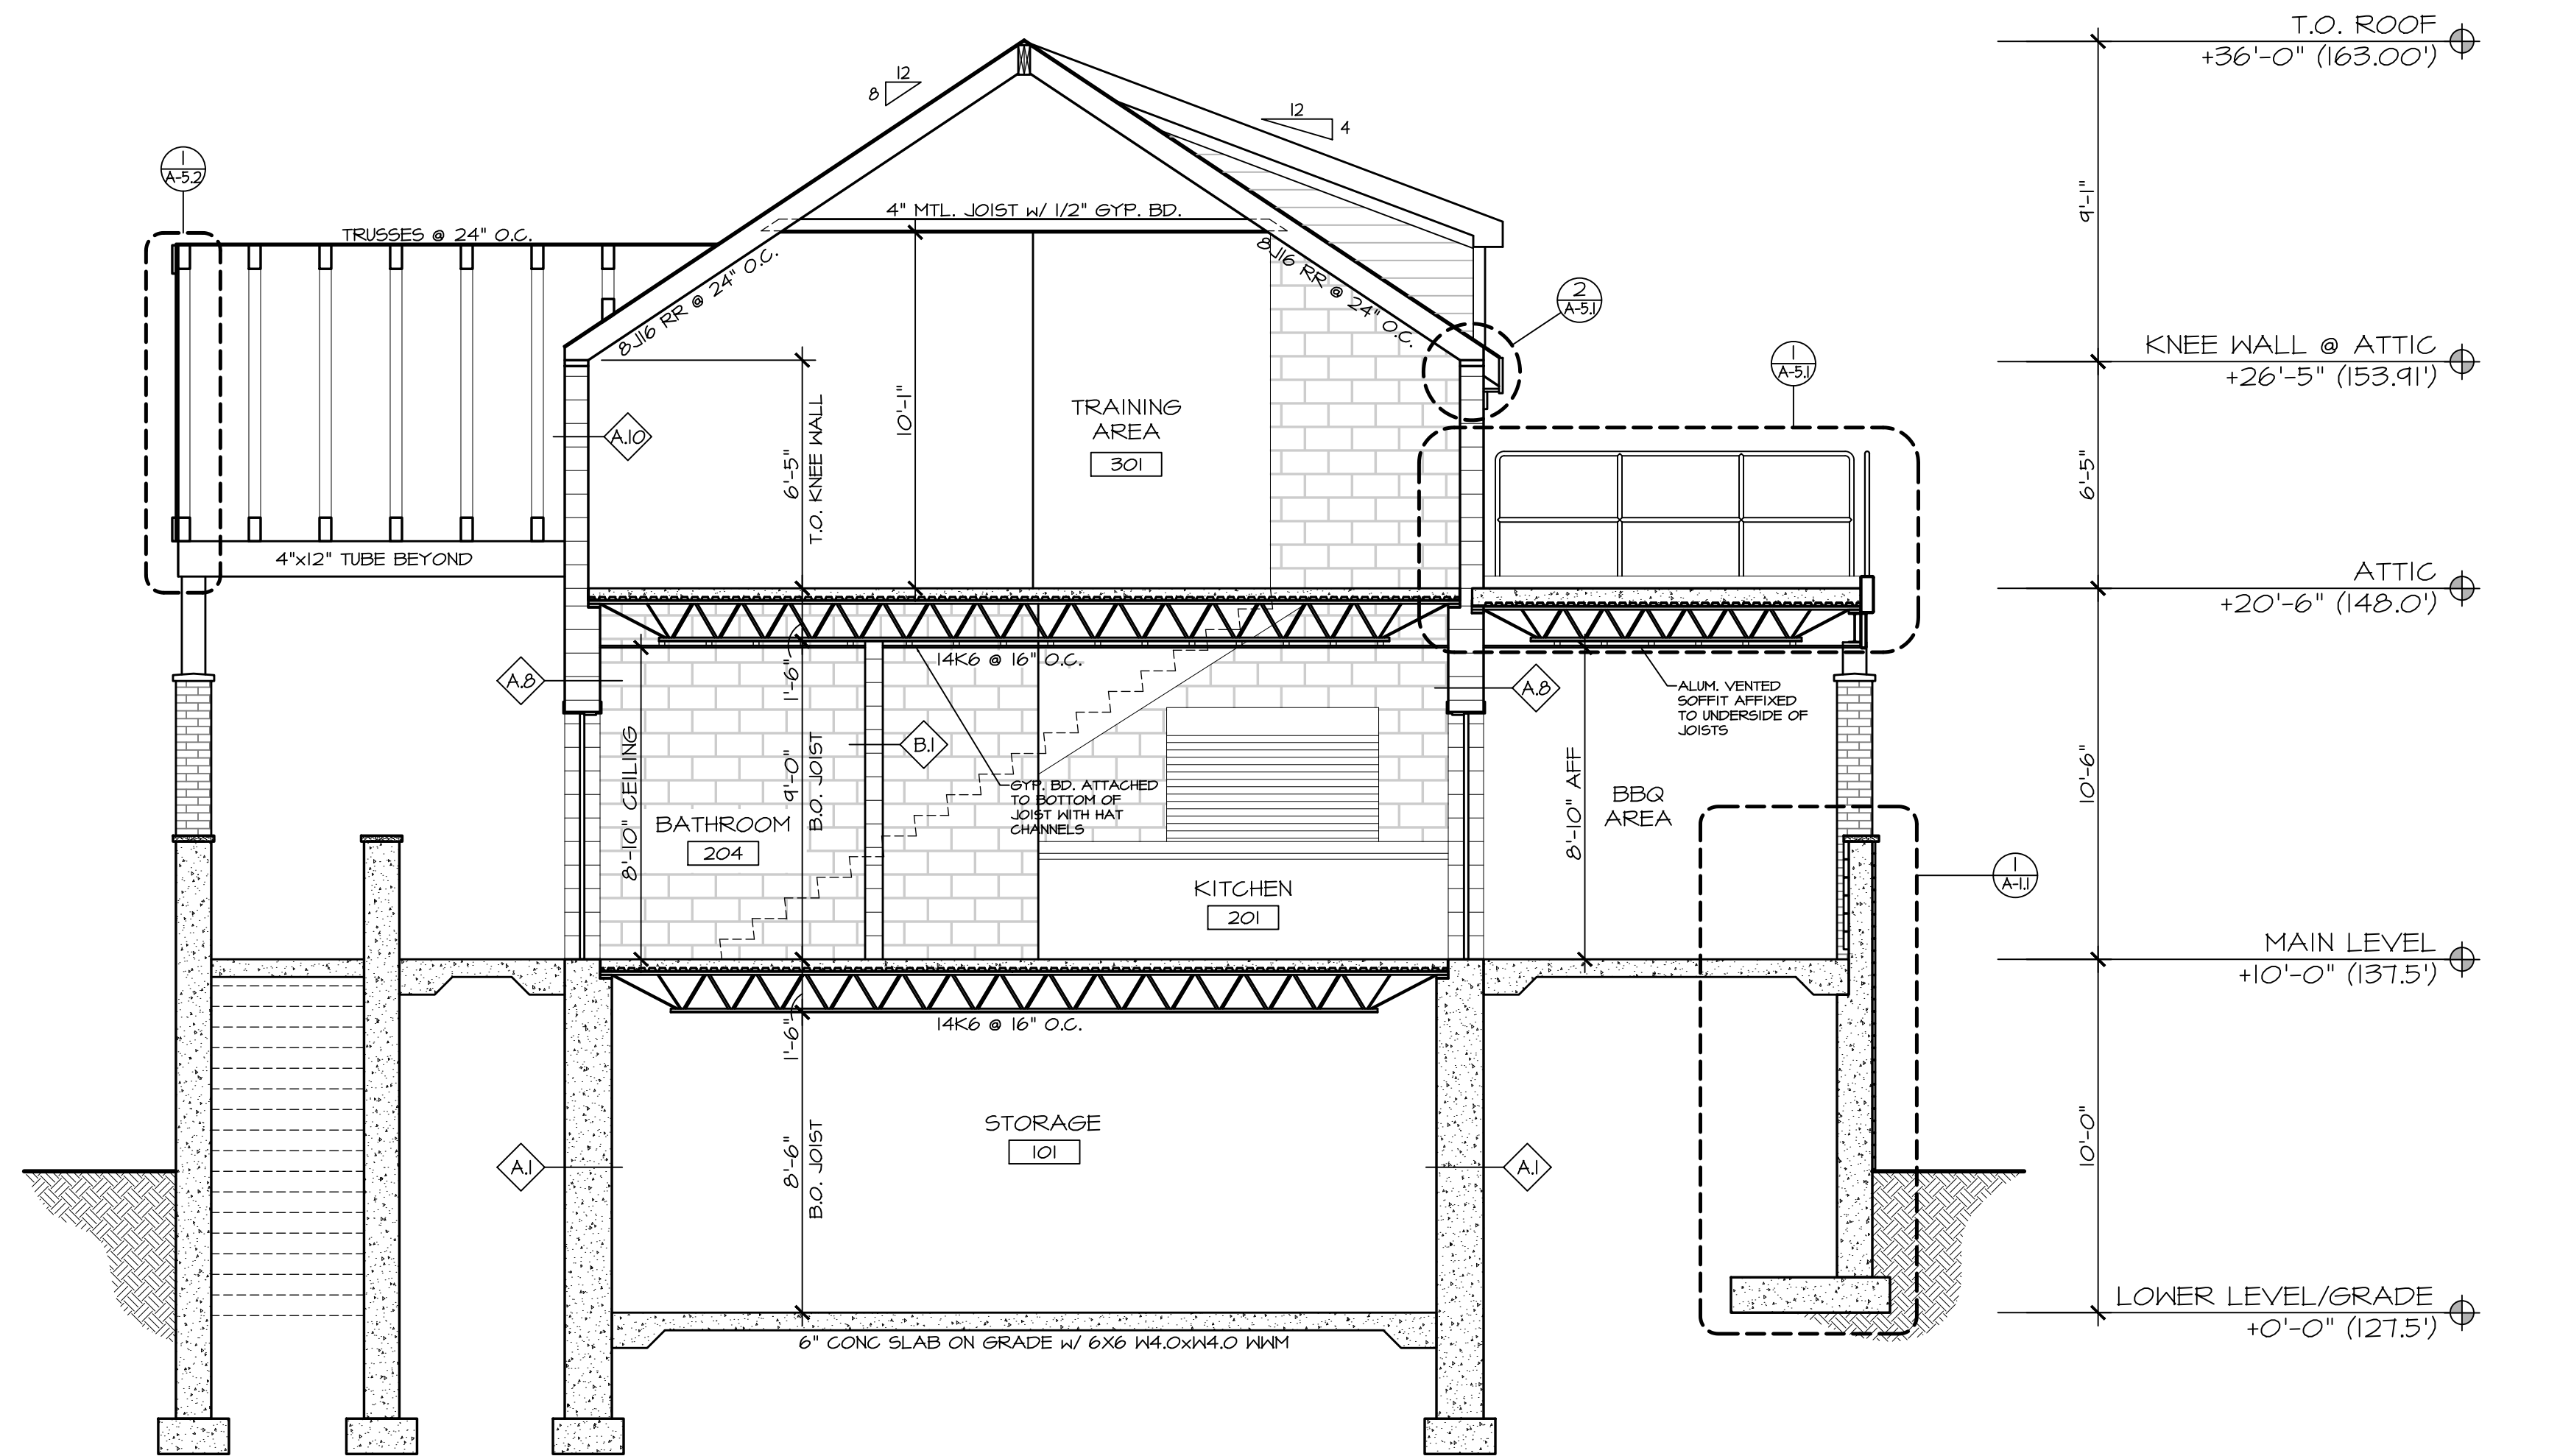


B SECTION
SCALE: 1/4" = 1'-0"

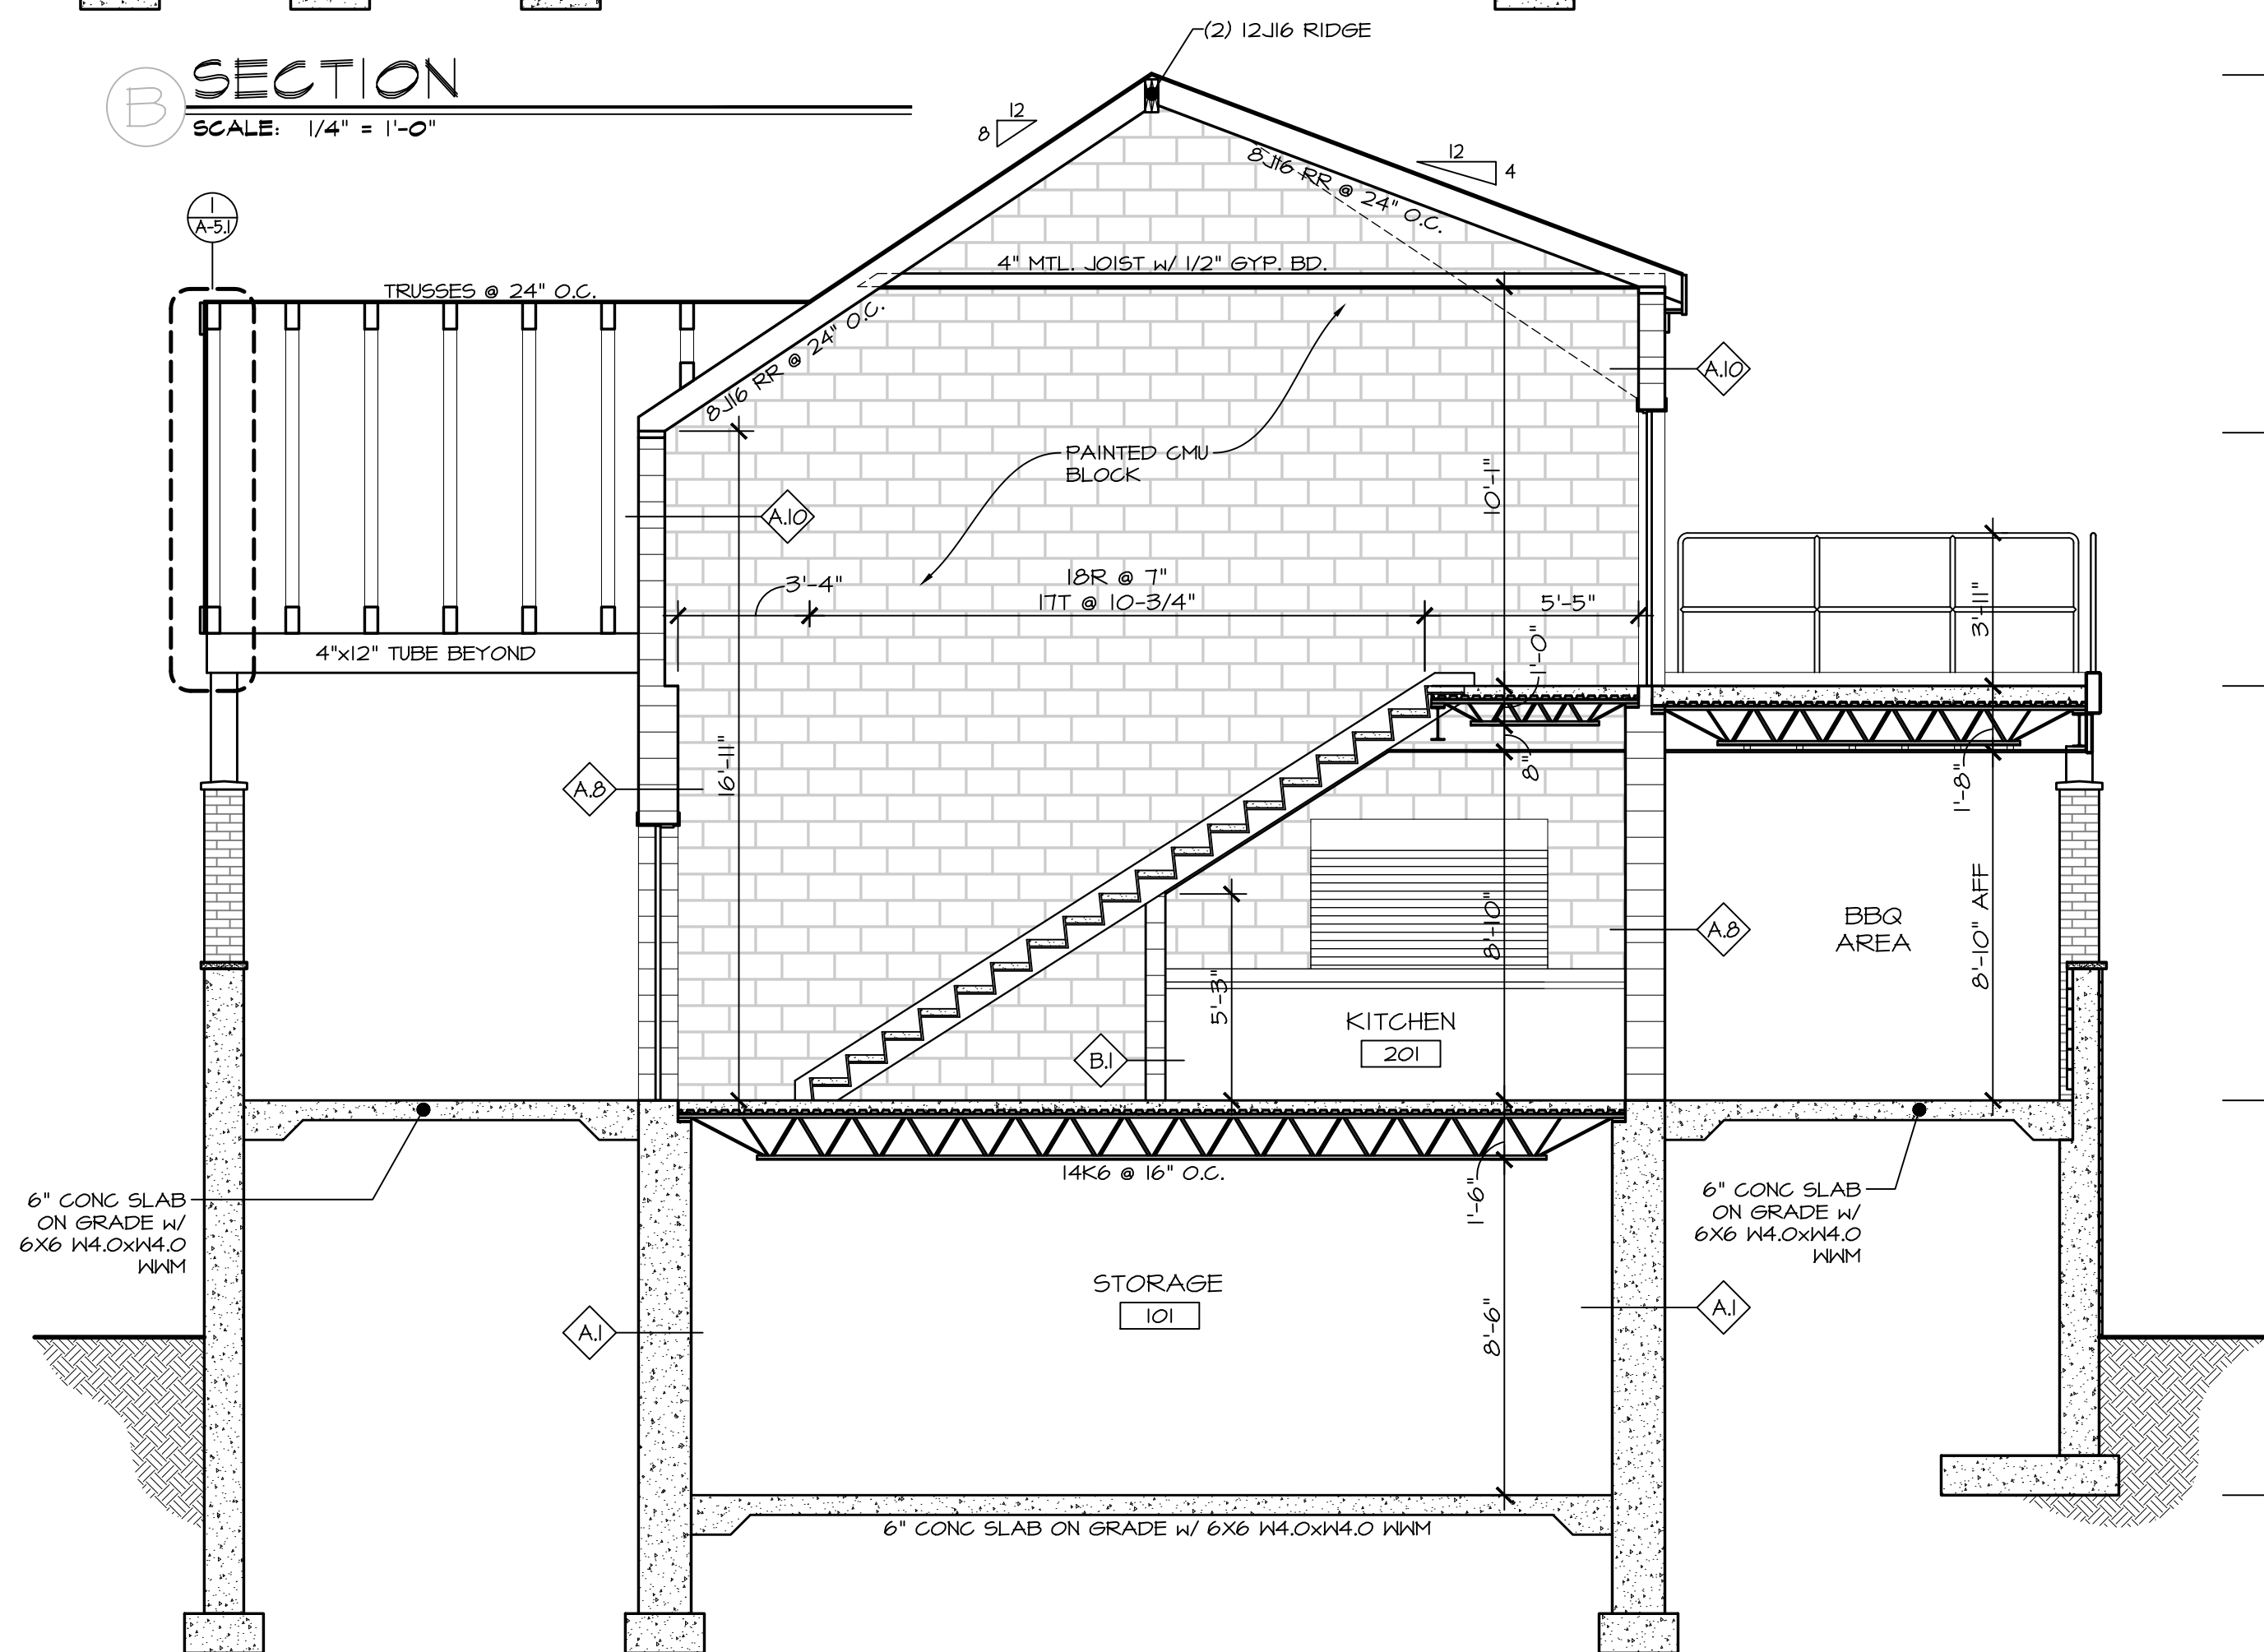


A SECTION
SCALE: 1/4" = 1'-0"

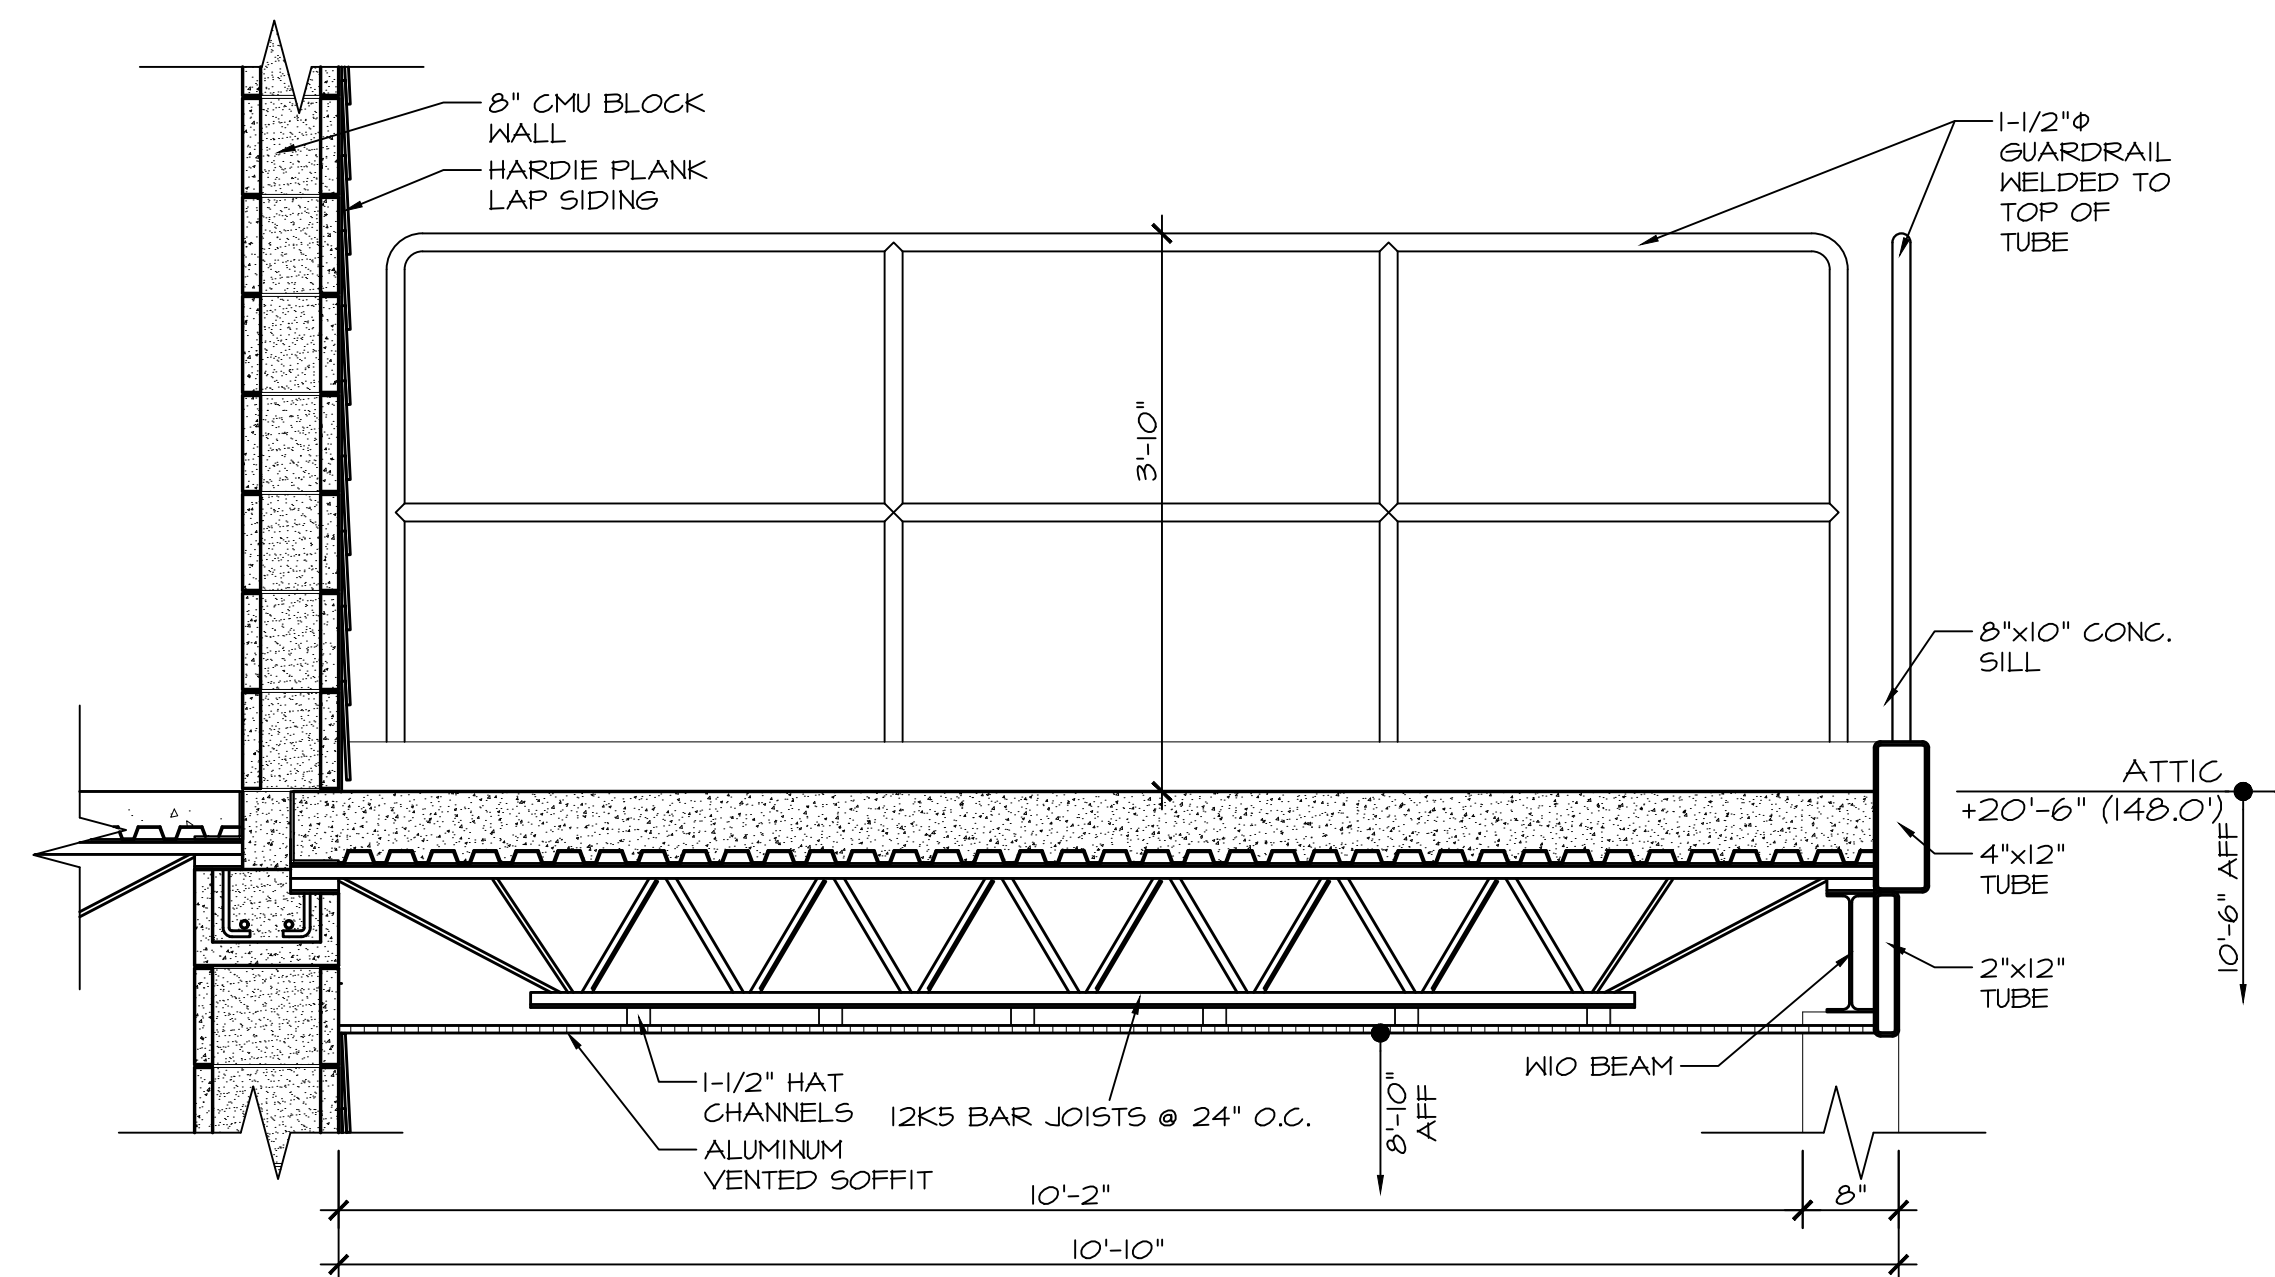


1 SECTION
SCALE: 3/4" = 1'-0"

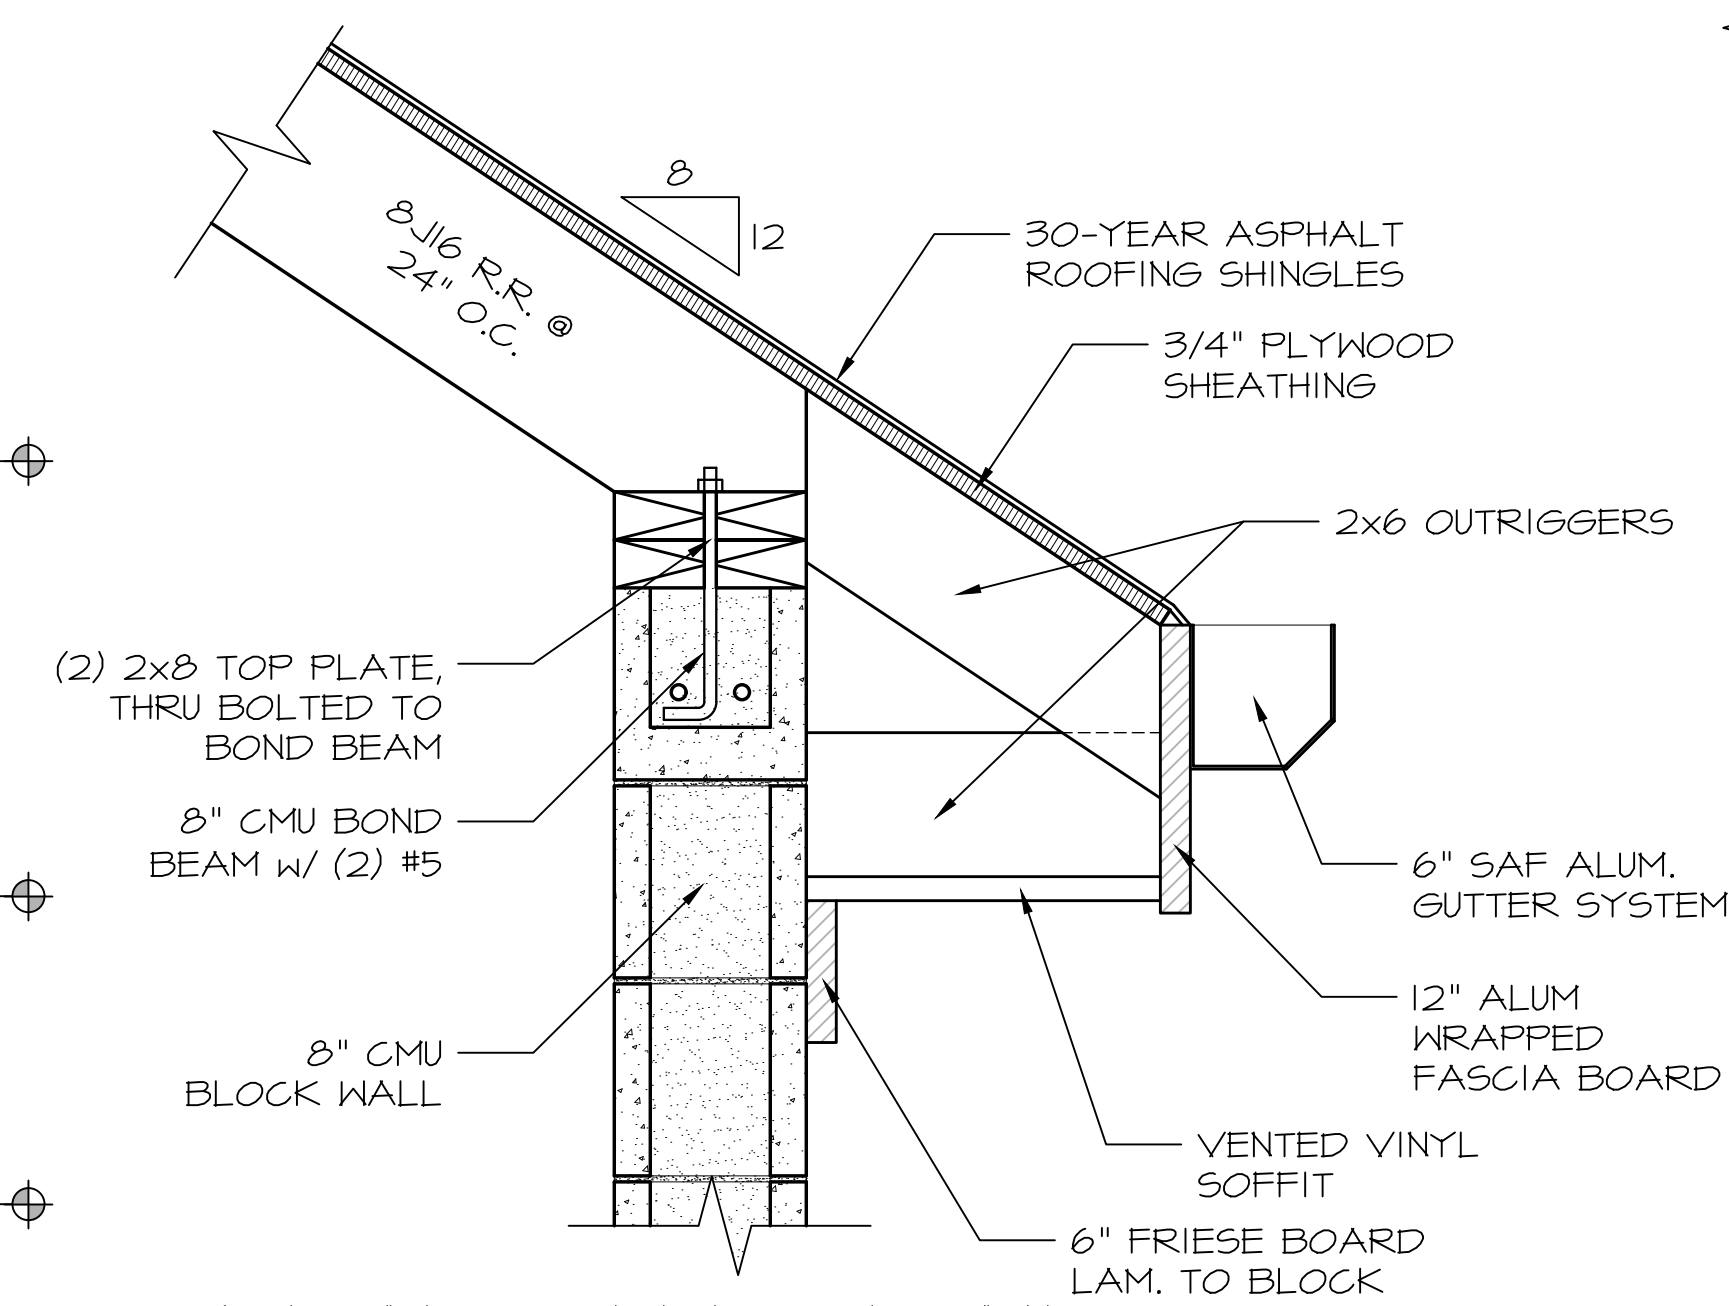


2 TYPICAL SOFFIT DETAIL
SCALE: 1-1/2" = 1'-0"

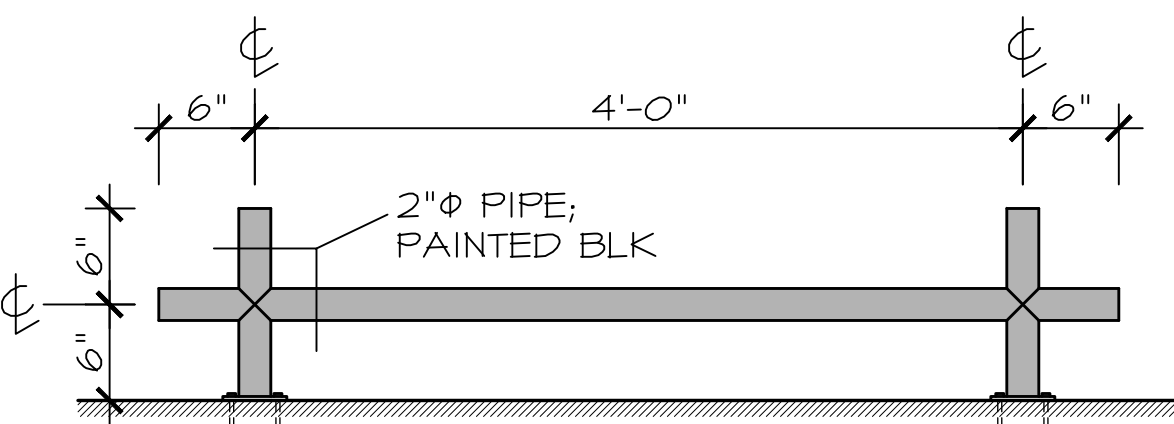

STAND-OFF PIPE DETAIL
SCALE: 1-1/2" = 1'-0"

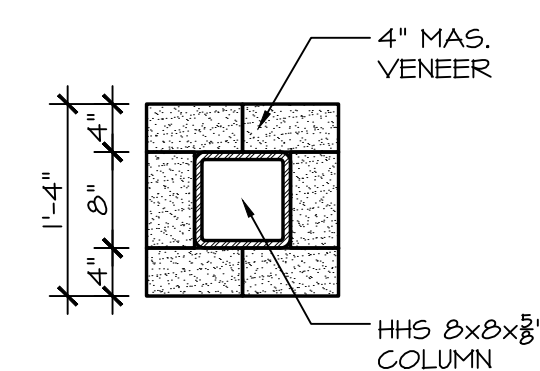

4 PIER SECTION
SCALE: 3/4" = 1'-0"

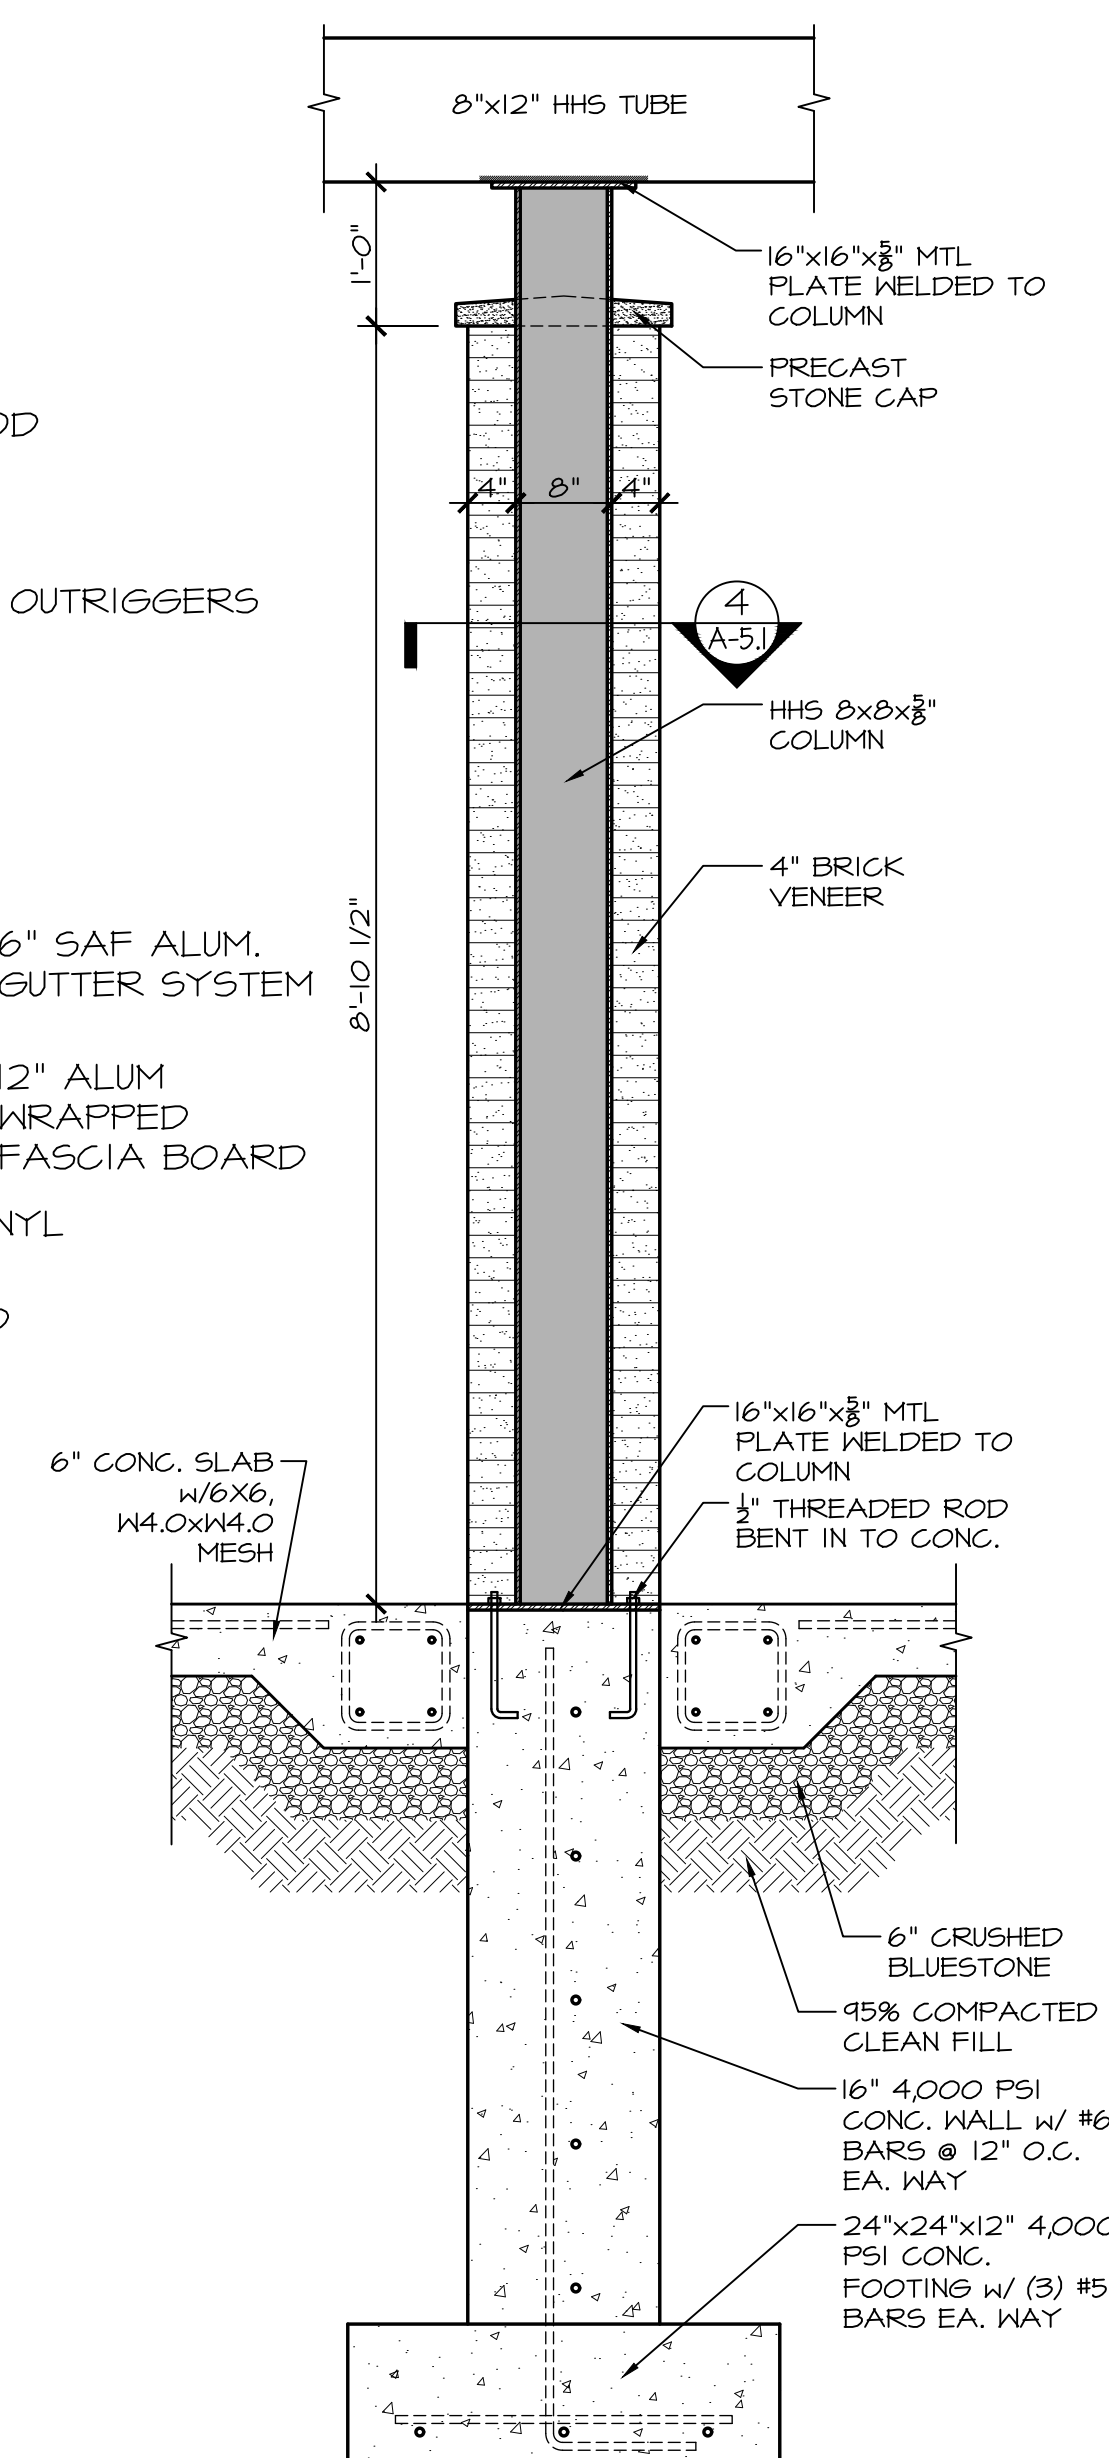

3 TYPICAL PIER DETAIL
SCALE: 3/4" = 1'-0"

DATE: ISSUE
---20--- ISSUED
FOR BIDDING
& PERMIT

SEAL:

SENDEWSKI ARCHITECTS PC
ARCHITECTS - PLANNERS
215 ROANOKE AVENUE
RIVERHEAD, NY 11901
(631) 727-5352
9 SELENA COURT
WALDEN, NY 12586
(845) 275-8859

PROPOSED PAVILION
TAPPAN FIRE DISTRICT
300 WESTERN HIGHWAY SOUTH
TAPPAN NY 10983

SECTIONS & DETAILS

PROJECT #: 2108/C

DRAWN BY:


CAD FILE: 2108/P/BID

DRAWING#:


A-5.1

PAVILION


07-11-22 UPDATE

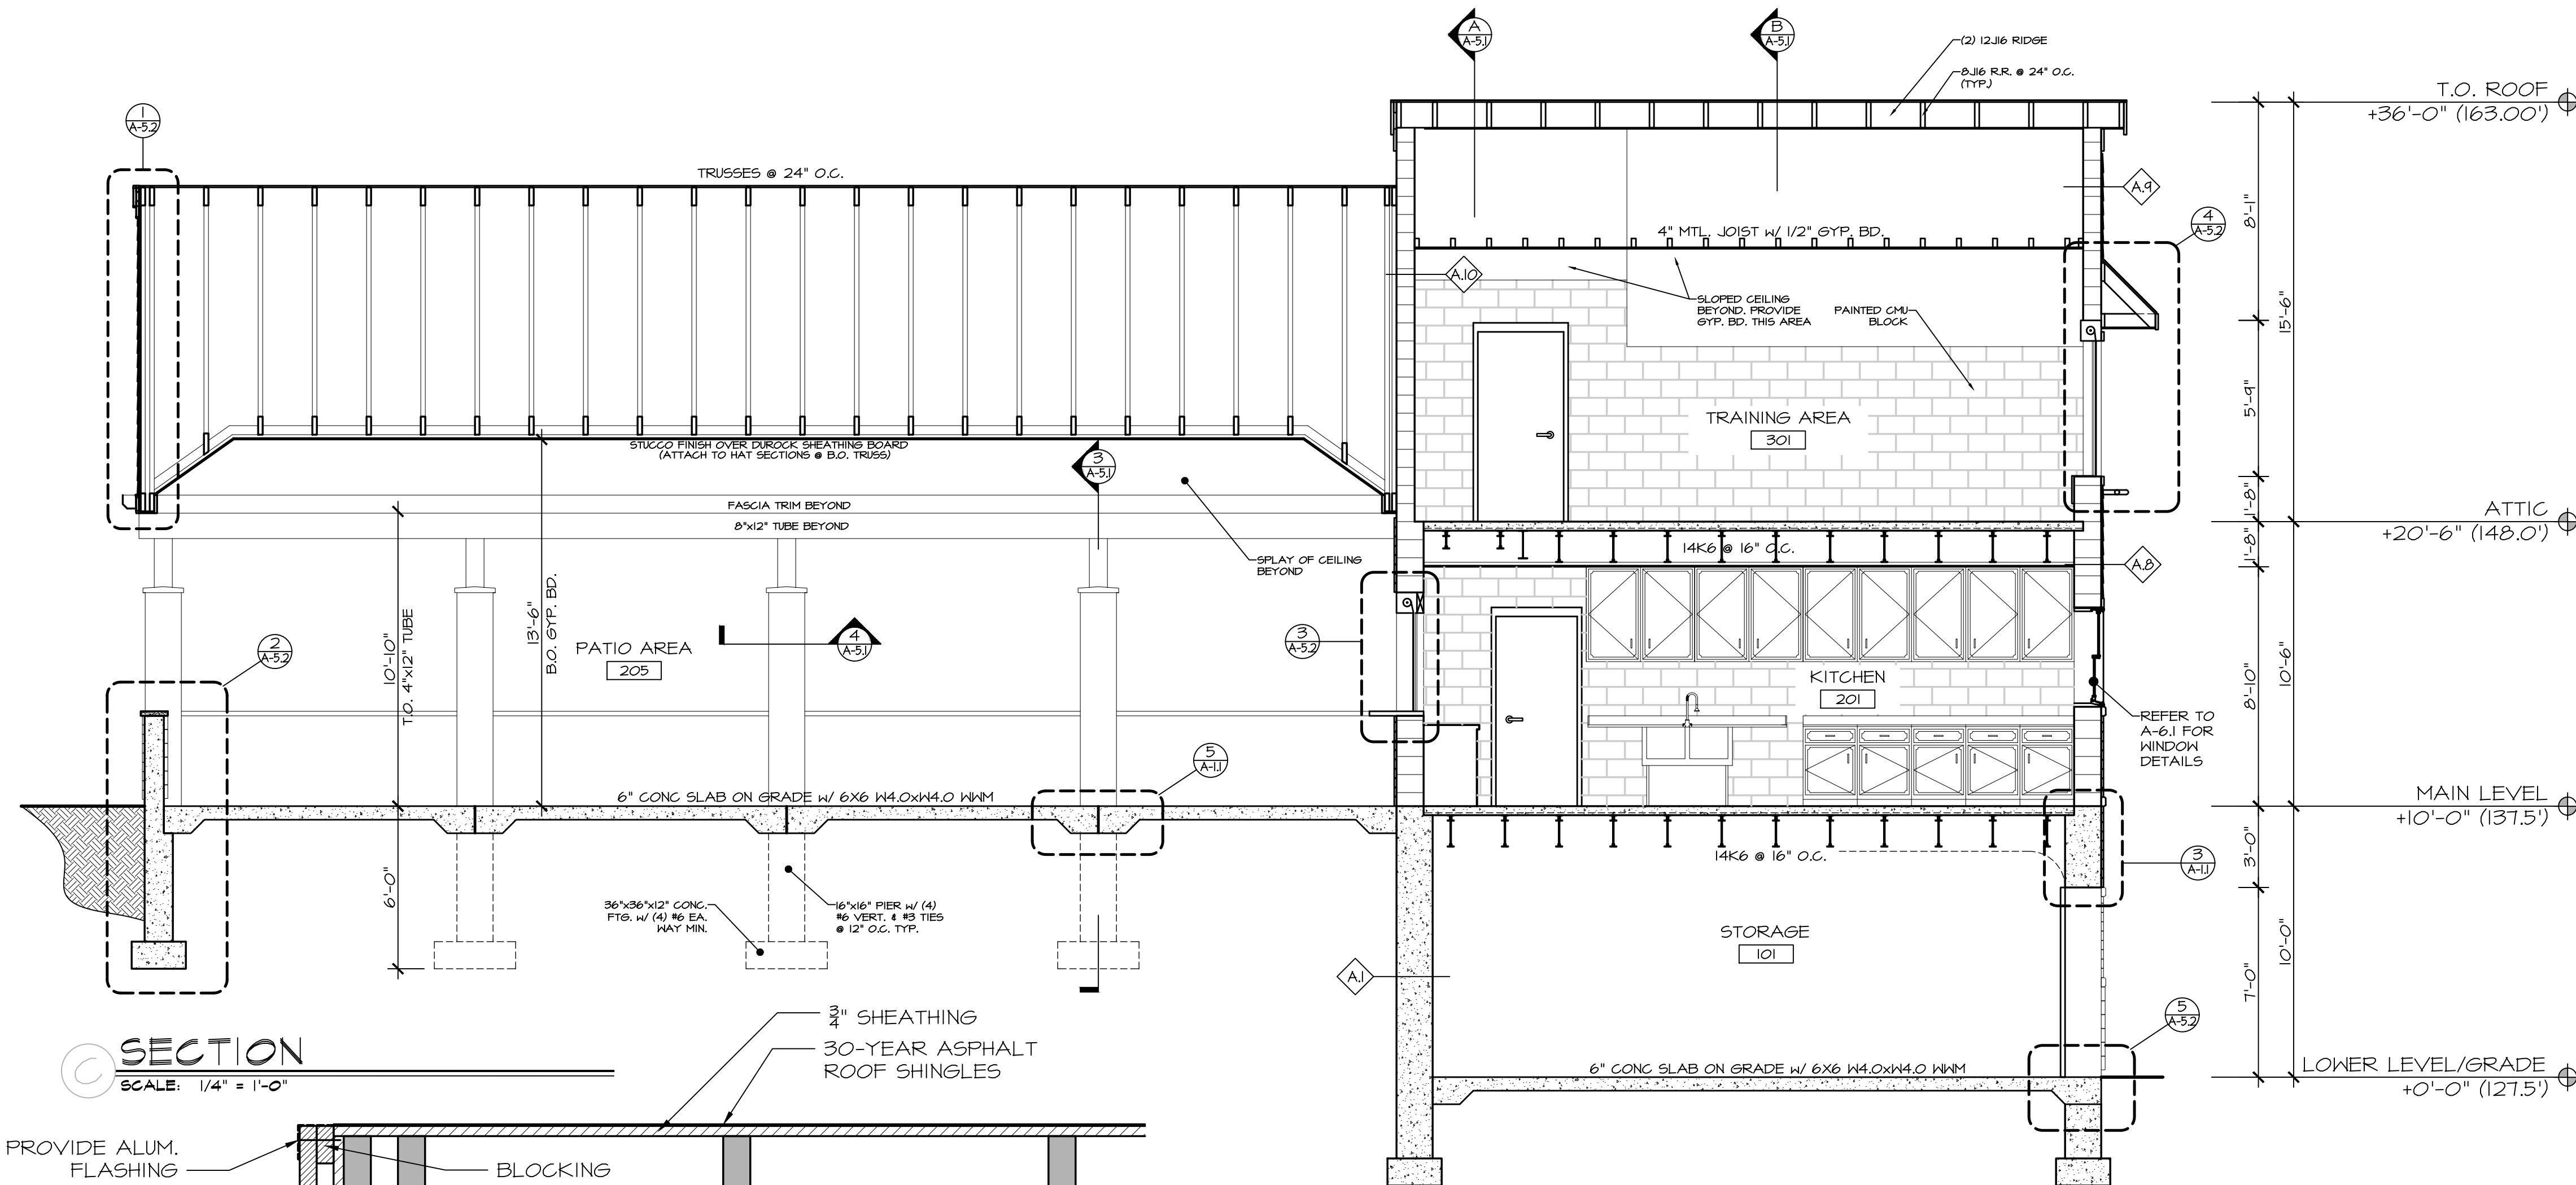


SECTION
SCALE: 1/4" = 1'-0"

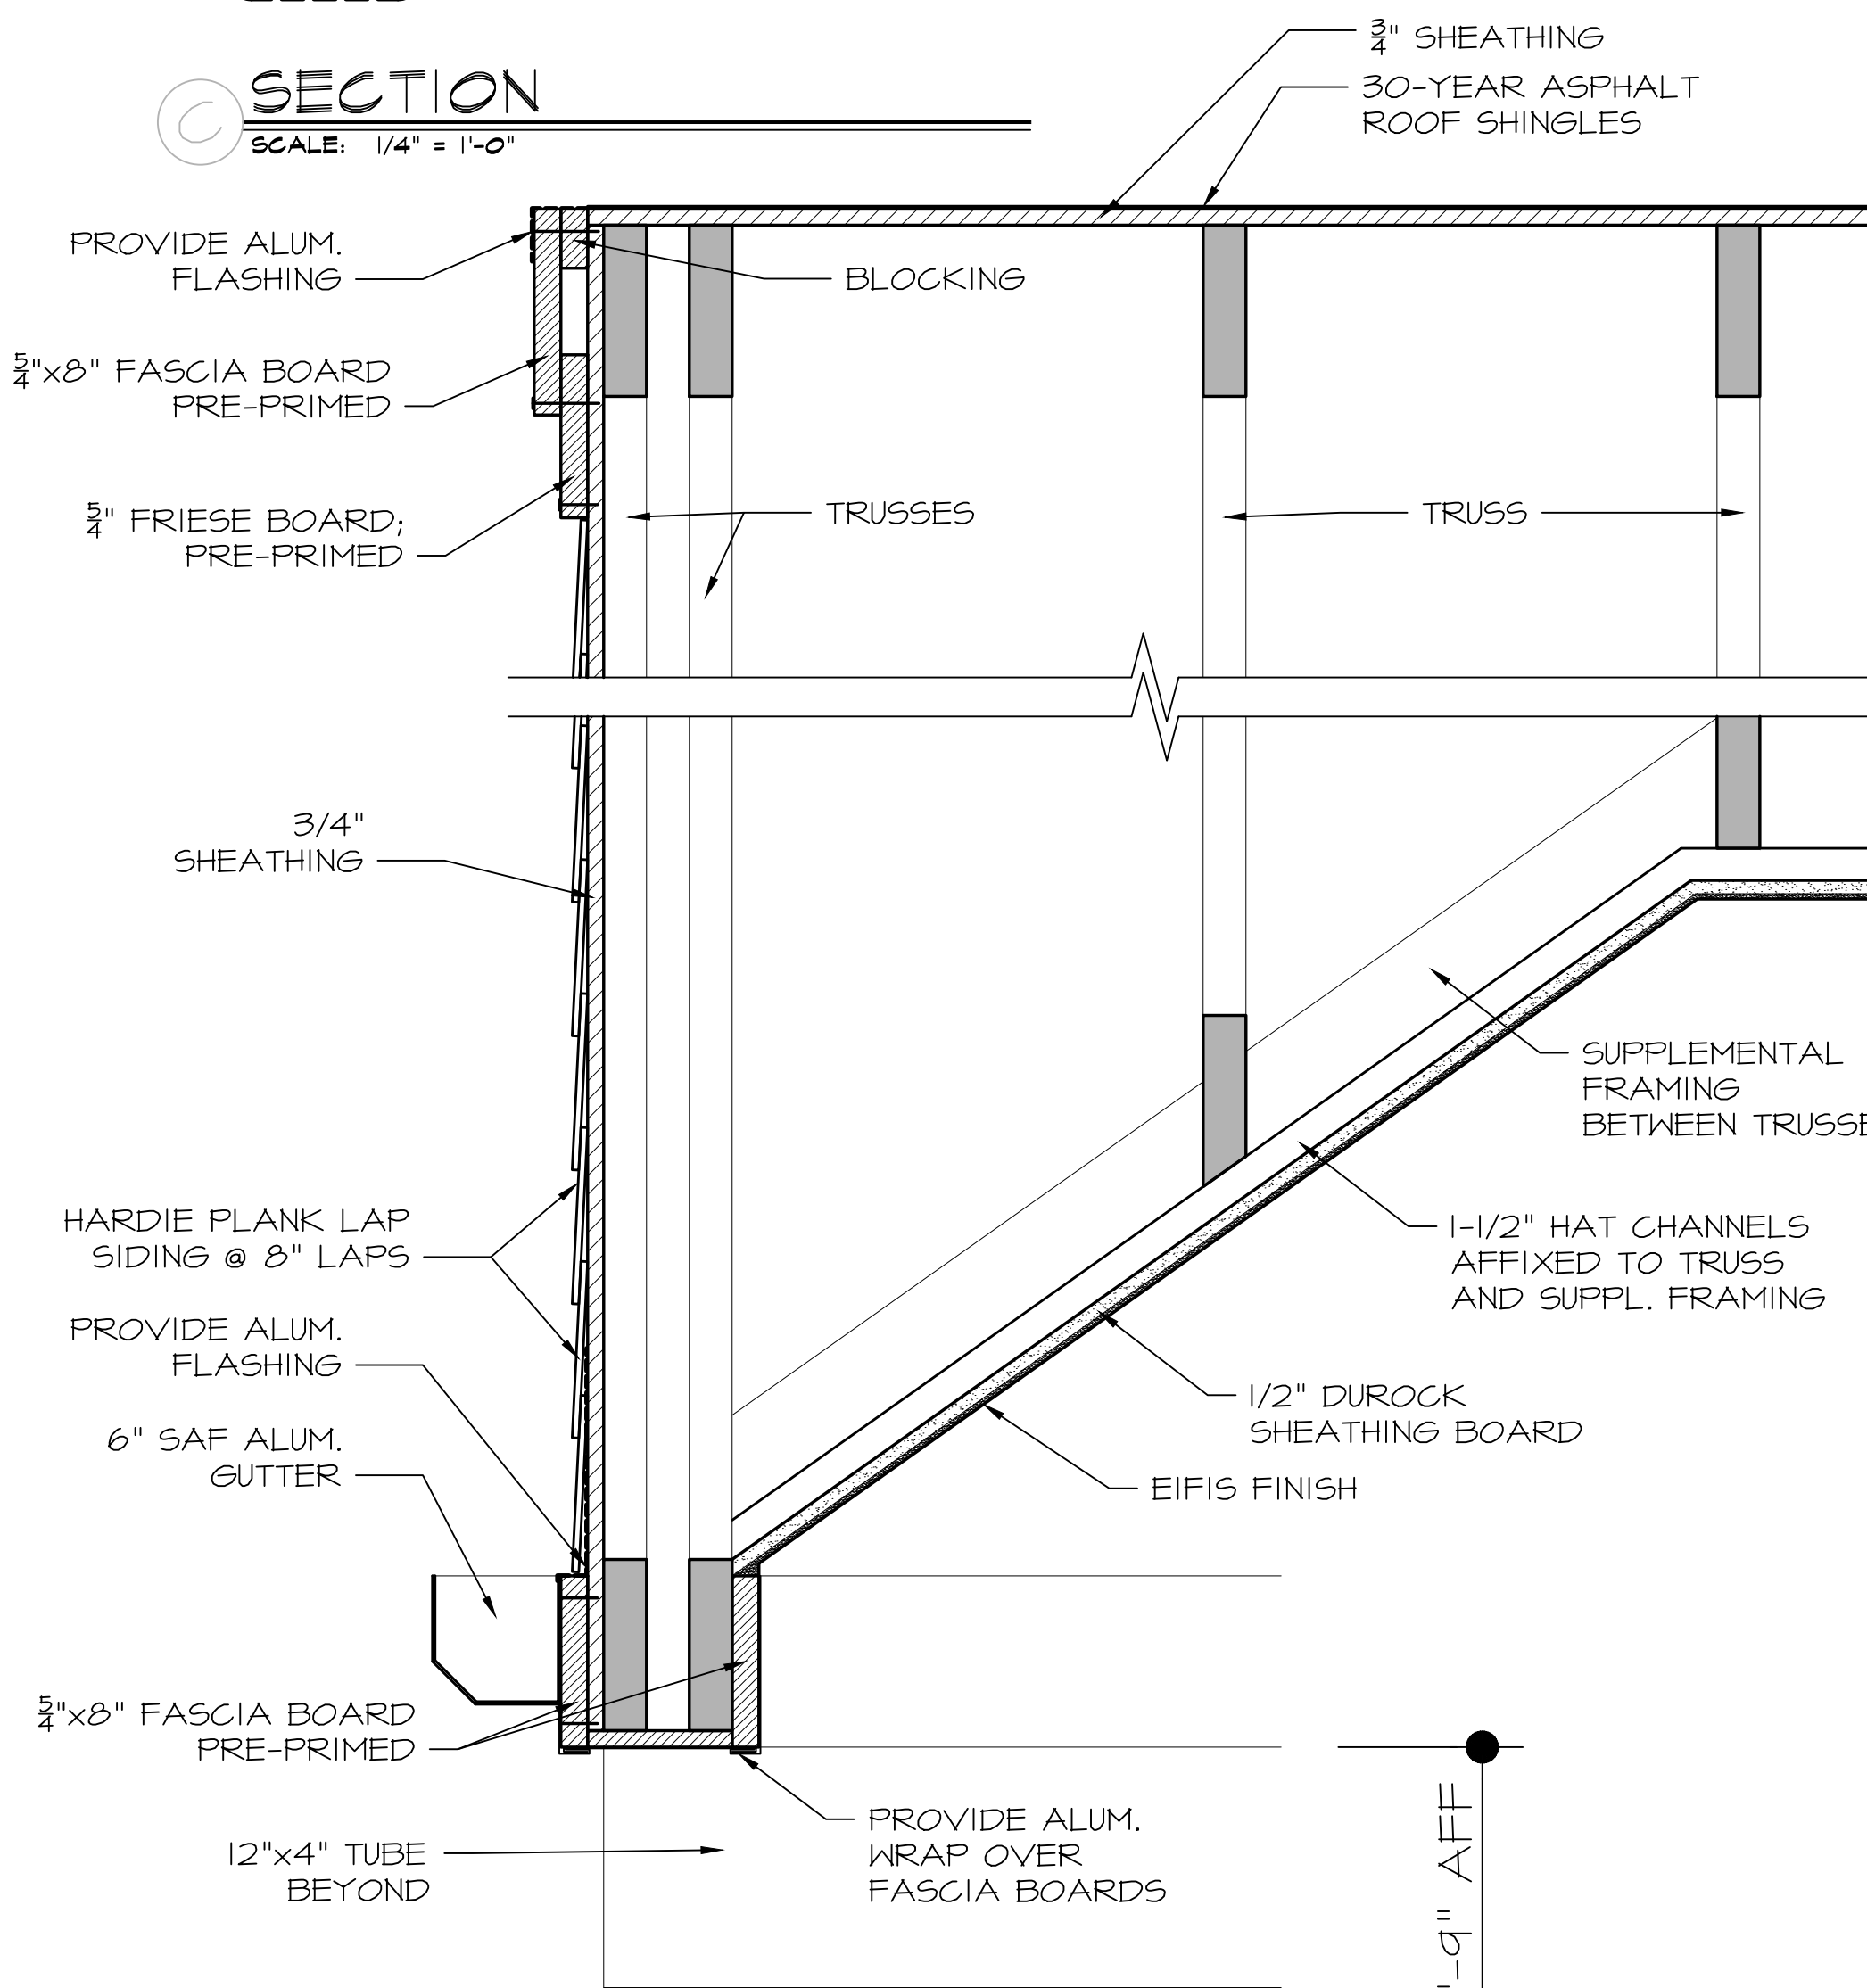


1 TRUSS END DETAIL
SCALE: 1-1/2" = 1'-0"

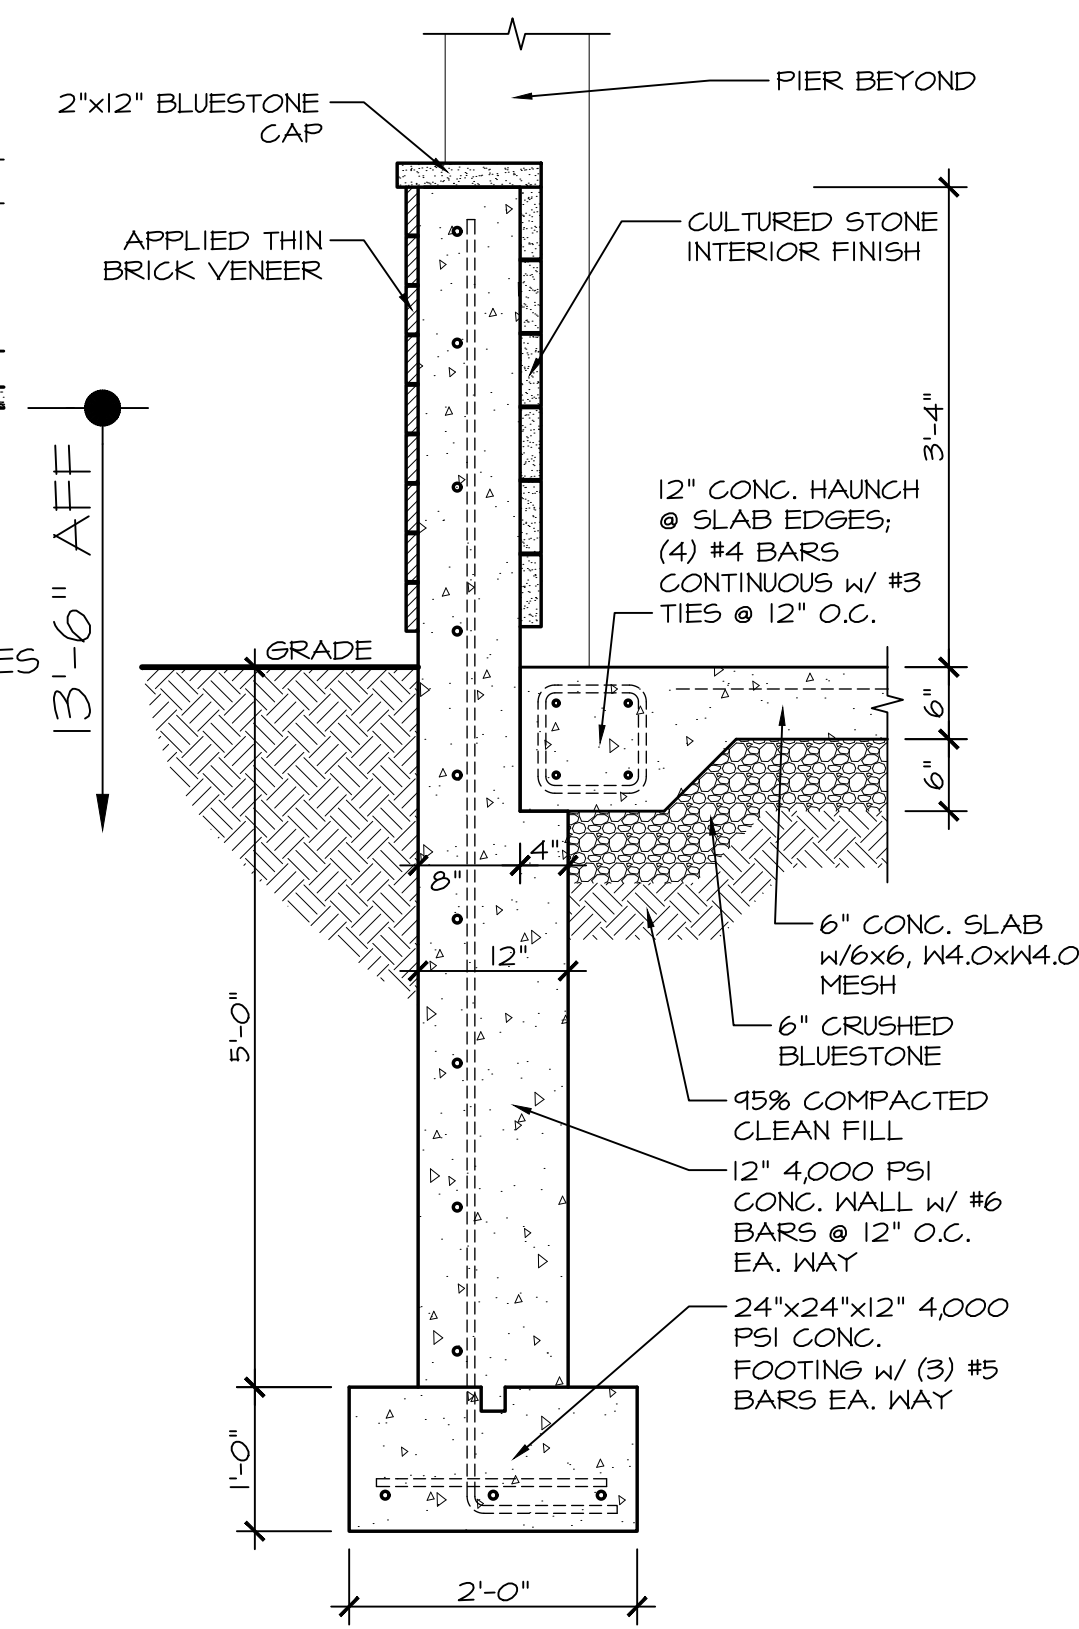

2 WALL DETAIL
SCALE: 3/4" = 1'-0"

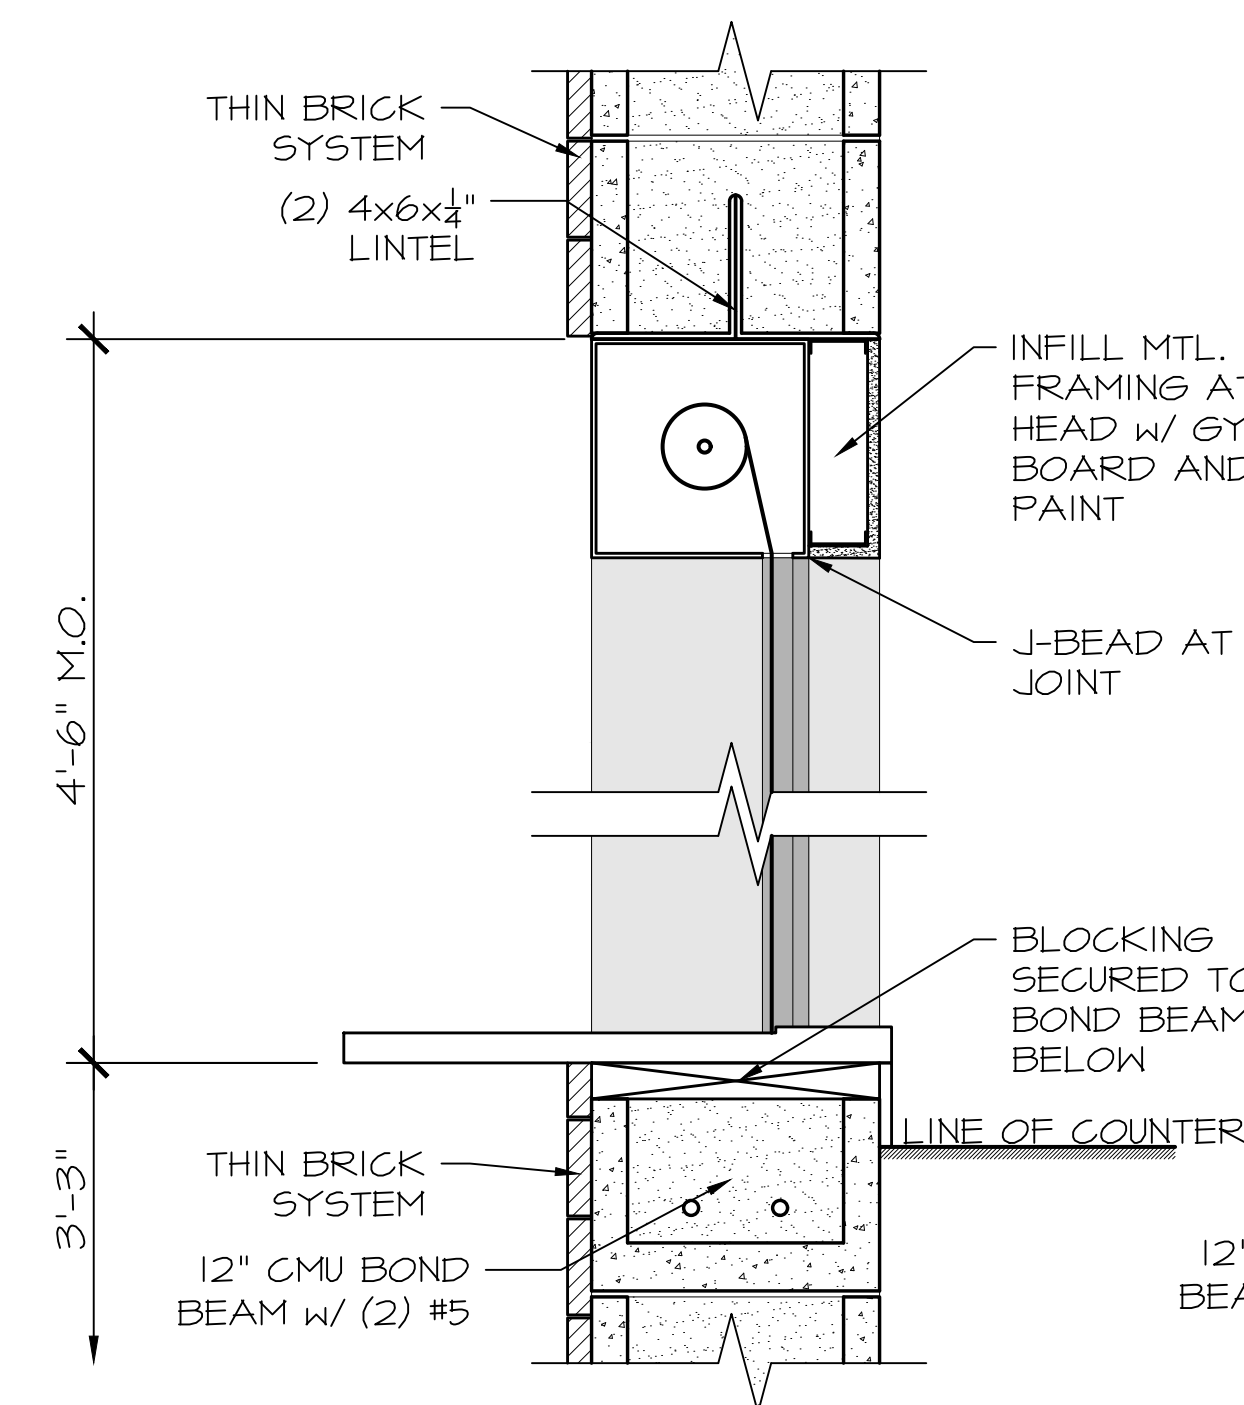

3 KITCHEN ROLL UP WINDOW
SCALE: 1-1/2" = 1'-0"

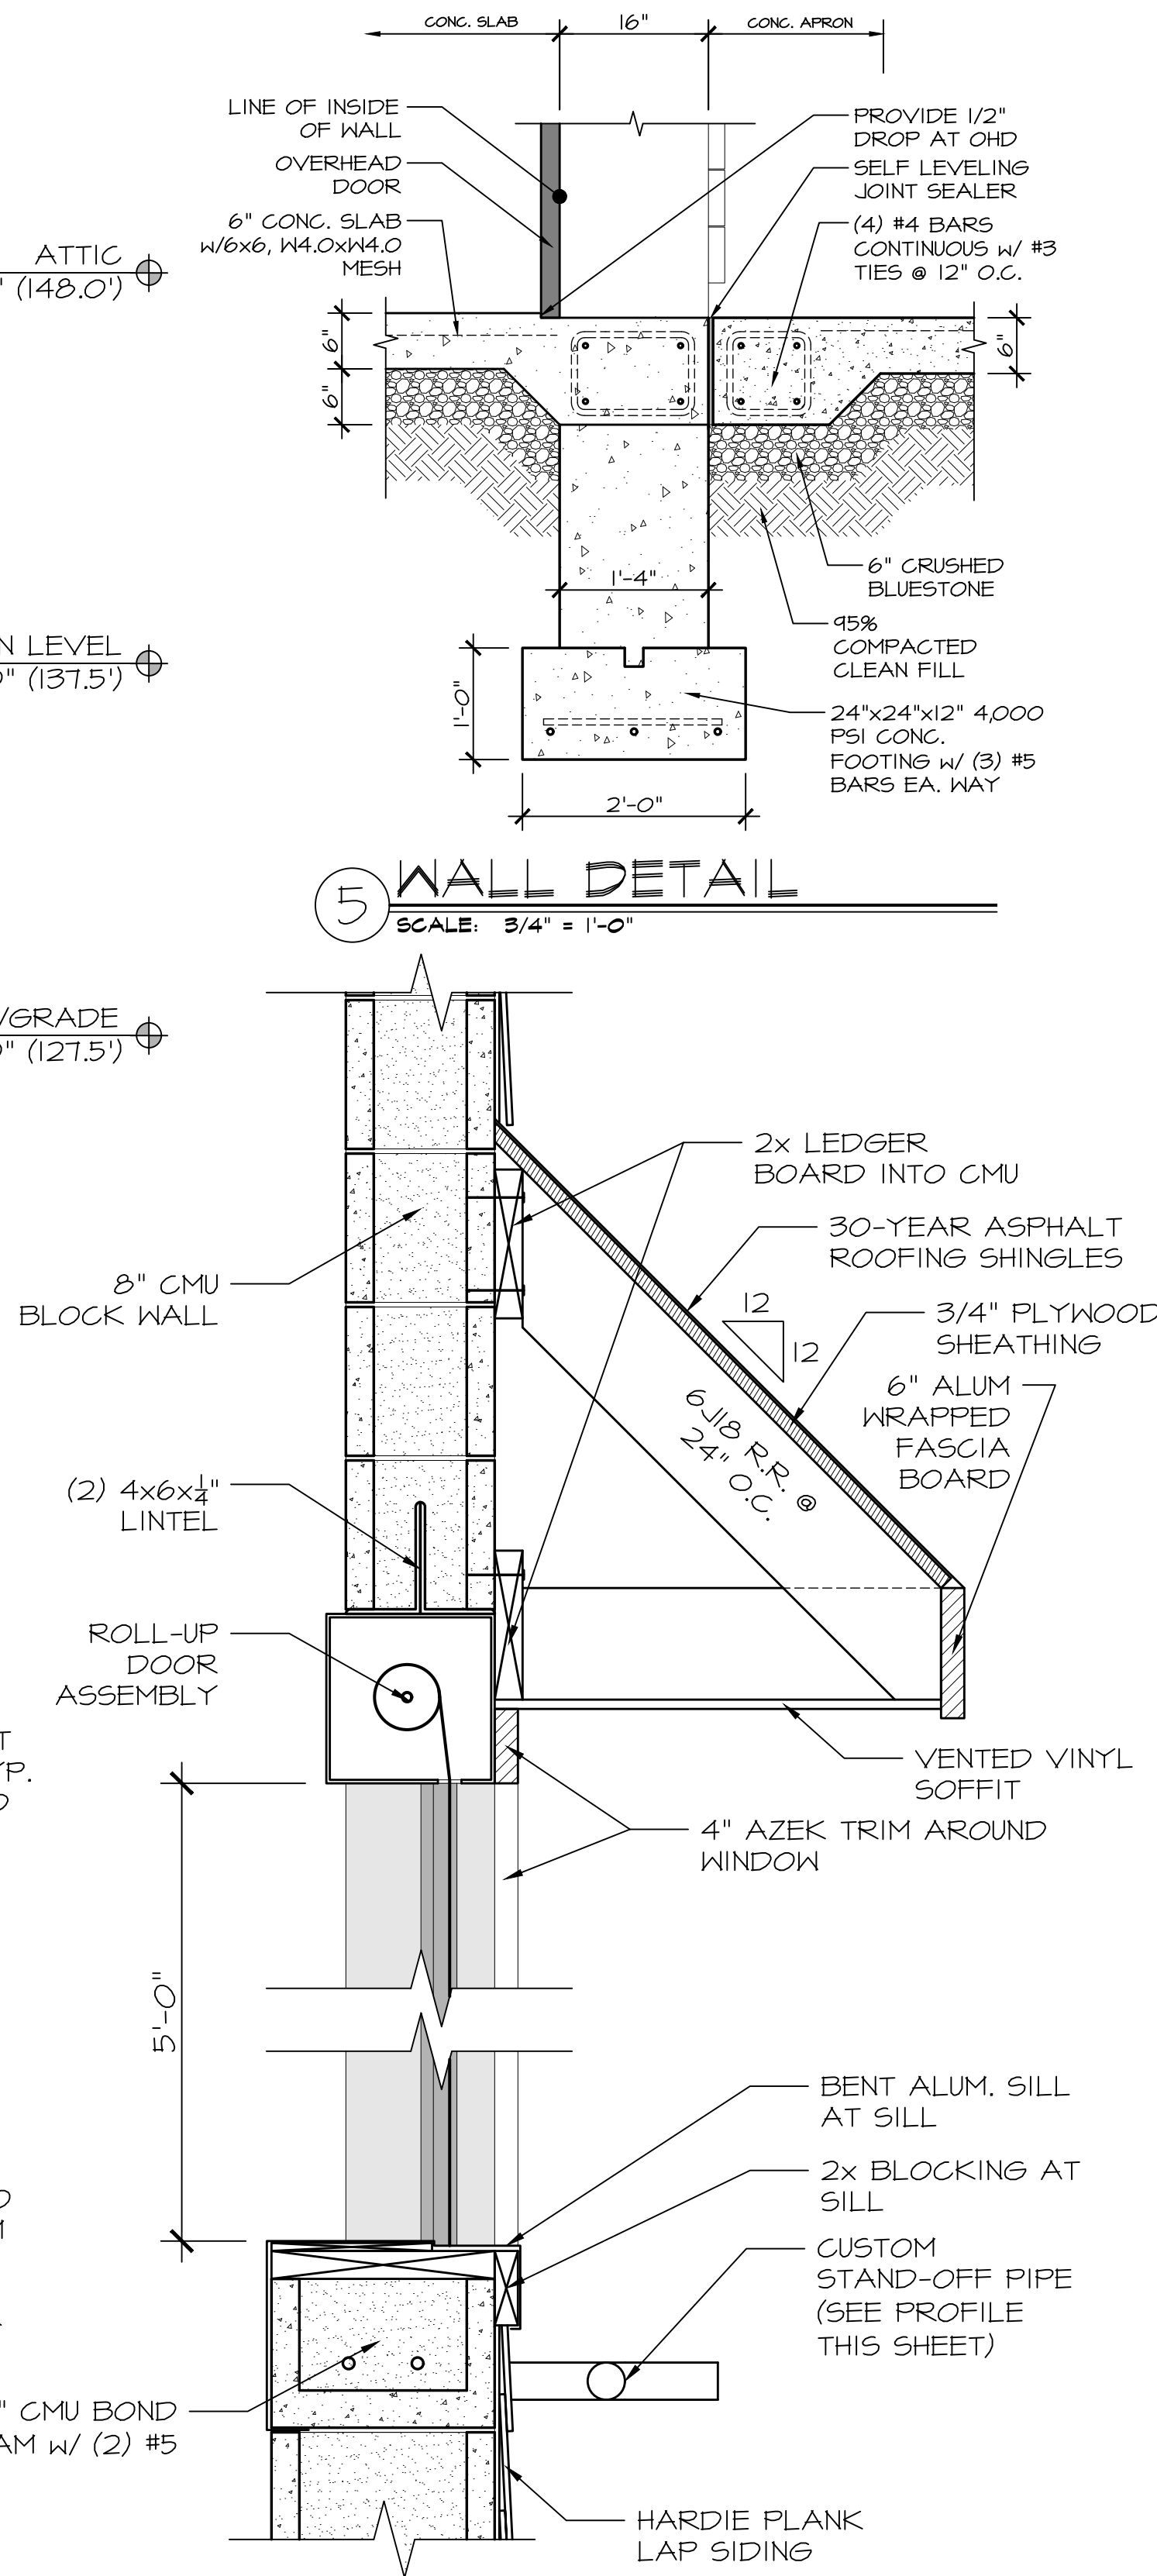

4 TRAINING ROLL UP WINDOW
SCALE: 1-1/2" = 1'-0"

5 WALL DETAIL
SCALE: 3/4" = 1'-0"

DATE: ISSUE
---20--- ISSUED FOR BIDDING & PERMIT

SEAL:

SENDEWSKI ARCHITECTS PC
ARCHITECTS - PLANNERS
215 ROANOKE AVENUE
RIVERHEAD, NY 11901
(631) 727-5352


9 SELENA COURT
WALDEN, NY 12586
(845) 275-8859

PROPOSED PAVILION
TAPPAN FIRE DISTRICT
300 WESTERN HIGHWAY SOUTH
TAPPAN, NY 10988

SECTIONS & DETAILS

PROJECT #: 2108/C
DRAWN BY:
CAD FILE: 2108/P./BID
DRAWING#:
A-5.2
PAVILION
07-11-22 UPDATE

DOOR SCHEDULE															
DOOR INFORMATION			SIZE			MATERIAL		FINISH		DETAILS		FRAME TYPE	HARDWARE GROUP	RATING	REMARKS
NO.	QTY.	TYPE	WIDTH	HEIGHT	THK	DOOR	FRAME	DOOR	FRAME	HEAD	JAMB			LABEL DR. FRAME	
1-01	1	B	3'-8"	7'-0"	1-3/4"	HM	HM	PT	PT	1	2	2	1		
2-01	1	A	3'-0"	7'-0"	1-3/4"	HM	HM	PT	PT	1	2	2	3		
2-02	1	A	3'-0"	7'-0"	1-3/4"	HM	HM	PT	PT	1	2	2	3		
2-03	1	B	3'-0"	7'-0"	1-3/4"	HM	HM	PT	PT	1	2	2	1		
2-04	1	B	3'-0"	7'-0"	1-3/4"	HM	HM	PT	PT	1	2	2	1		
2-05	1	A	2'-8"	7'-0"	1-3/4"	HM	HM	PT	PT	3	3	1	2		
3-01	1	B	3'-0"	7'-0"	1-3/4"	HM	HM	PT	PT	3	3	2	1		
3-02	1	A	2'-8"	7'-0"	1-3/4"	HM	HM	PT	PT	3	3	2	2		

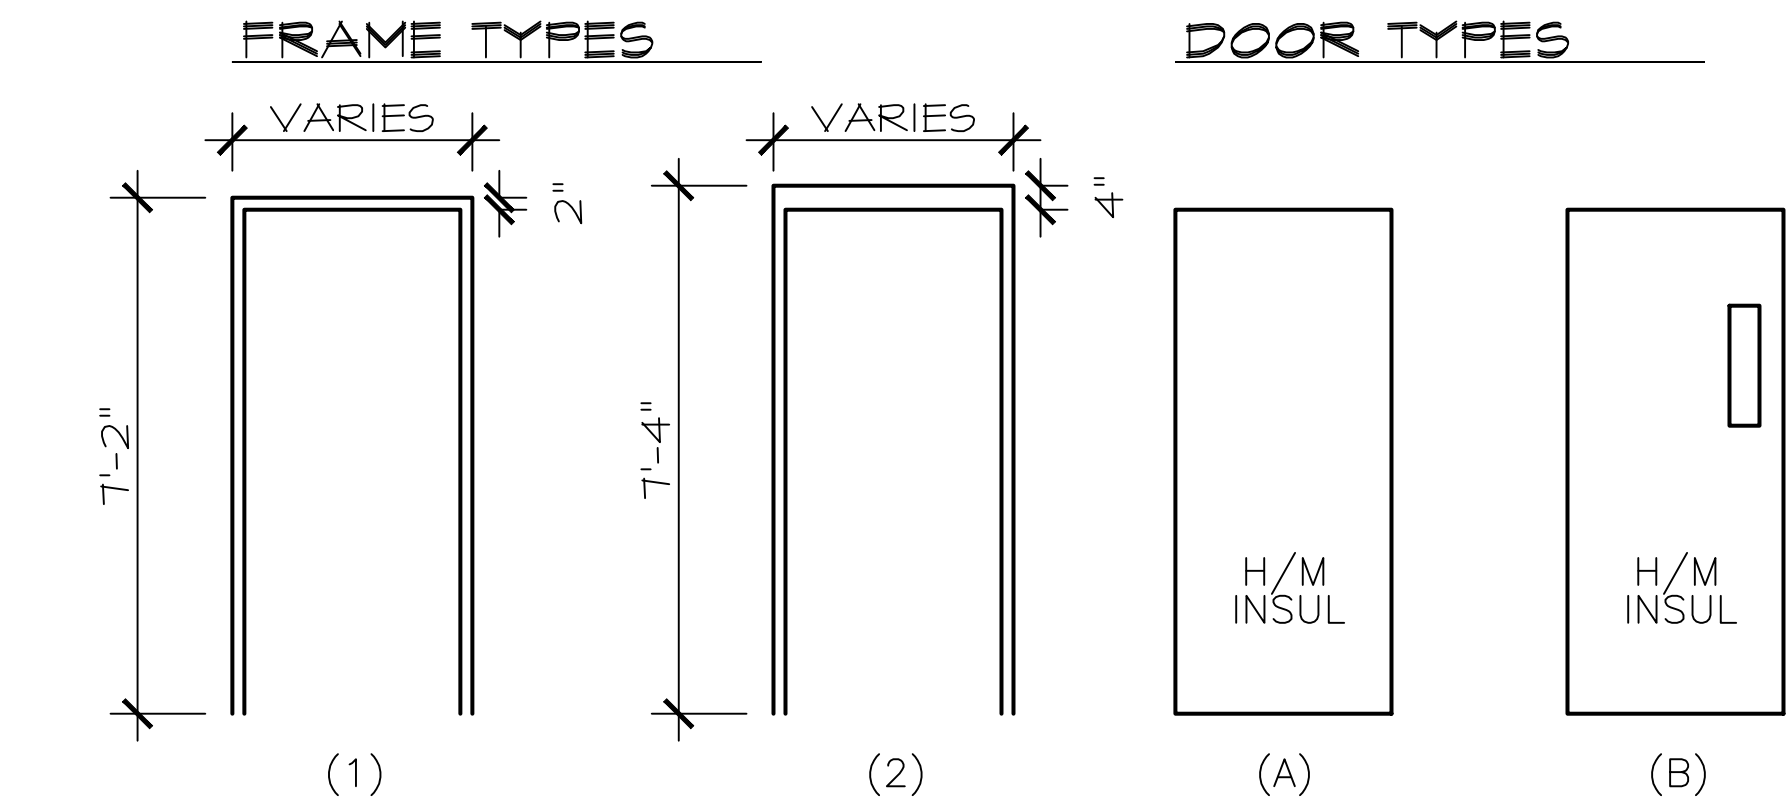

FINISH SCHEDULE												
ROOM	NAME	FLOOR		BASE		WALLS		CEILING			MISC.	NOTES
		MATERIAL	FINISH	MATERIAL	HEIGHT	MATERIAL	FINISH	TYPE	FINISH	HEIGHT		
101	STORAGE	CONC.	--	--	--	CONC.	PT	STL/CONC	PT	8'-7½"		
201	KITCHEN	CONC.	QT	QT	4"	GB/CMU	PT	GB	PT	9'-0"		
202	STORAGE	CONC.	VCT	VB	4"	GB/CMU	PT	GB	PT	9'-0"		
203	BATHROOM #1	CONC.	CT	--	--	CT/GB/CMU	PT	GB	PT	9'-0"		
204	BATHROOM #2	CONC.	CT	--	--	CT/GB/CMU	PT	GB	PT	9'-0"		
301	TRAINING AREA	CONC.	VCT	VB	4"	GB	PT	GB	PT	VARIES		
302	MECH. AREA	CONC.	VCT	VB	4"	GB	PT	GB	PT	VARIES		

LEGEND:

ABBREVIATIONS

AFF	ABOVE FINISHED FLOOR	PT	PAINT
BRCK	BRICK	QT	8"x8" QUARRY TILE
CMU	CONCRETE BLOCK	RT	ROPPE RUBBER TREAD DIAMOND DESIGN
CONC	CONCRETE	SFF	SPRAY FIREPROOFING, MASK WALLS TO AVOID OVER SPRAY
CT	CERAMIC TILE		
EPOX	EPOXY PAINT		
GB	GYPSUM BOARD	VB	4" HIGH ROPPE VINYL BASE, USE FORMED CORNERS
N/A or	NOT APPLICABLE		
PLYND	3/4" CDX BACKING	WD	WOOD

NOTES




- PROVIDE RUBBER STAIR TREADS, PAINT STRINGERS AND RISERS TYPICAL
- GYP. BD. BOTTOM OF STAIR AND LANDINGS ABOVE TYPICAL W/ SUPPLEMENTAL FRAMING AS REQUIRED
- ALL GYP. BD. TO BE WATER RESISTANT TYPE, TYP. ALL AREAS.
- PROVIDE DUROCK WALLBOARD AT ALL WALL TILE AREAS TYP.
- PARTIAL SOFFIT CEILINGS SHALL BE ON METAL SUSPENSION SYSTEMS W/ PAINT FINISH, TYPICAL ALL SOFFIT LOCATIONS.

PAINTING NOTES

- GC SHALL PROVIDE A FULL MOCK-UP PANEL CONSISTING OF ALL OWNER SELECTED PAINT FINISHES, FOR APPROVAL PRIOR TO COMMENCEMENT OF ANY PAINTING
- GC SHALL ENSURE THAT ALL CMU TO RECEIVED PAINT FINISH IS PROPERLY BRUSHED & PREPARED PRIOR TO PAINTING.
- ALL PAINTED CMU SHALL RECEIVED BLOCK-FILLER BASE PAINT AS PREPARATION TO PAINTING.
- ALL AREAS TO RECEIVE FINISH PAINT SHALL NOT GET ITS FINAL COAT UNTIL THE END OF THE PROJECTS PUNCH-LIST PHASE AND ONLY WHEN ALL OTHER TRADE/VENDORS HAVE BEEN CONFIRMED TO BE COMPLETED WITH THEIR WORK IN ALL AREAS.


GENERAL FINISH NOTES:

- ALL DOOR FRAMES, TRIMS, SOFFITS, RAILINGS, EXPOSED STL. LINTELS, ETC. TO HAVE PAINT FINISH TYPICAL.
- ALL INTERIOR WOOD TRIM, MOLDING, BASEBOARD TO HAVE STAIN/VARNISH FINISH.

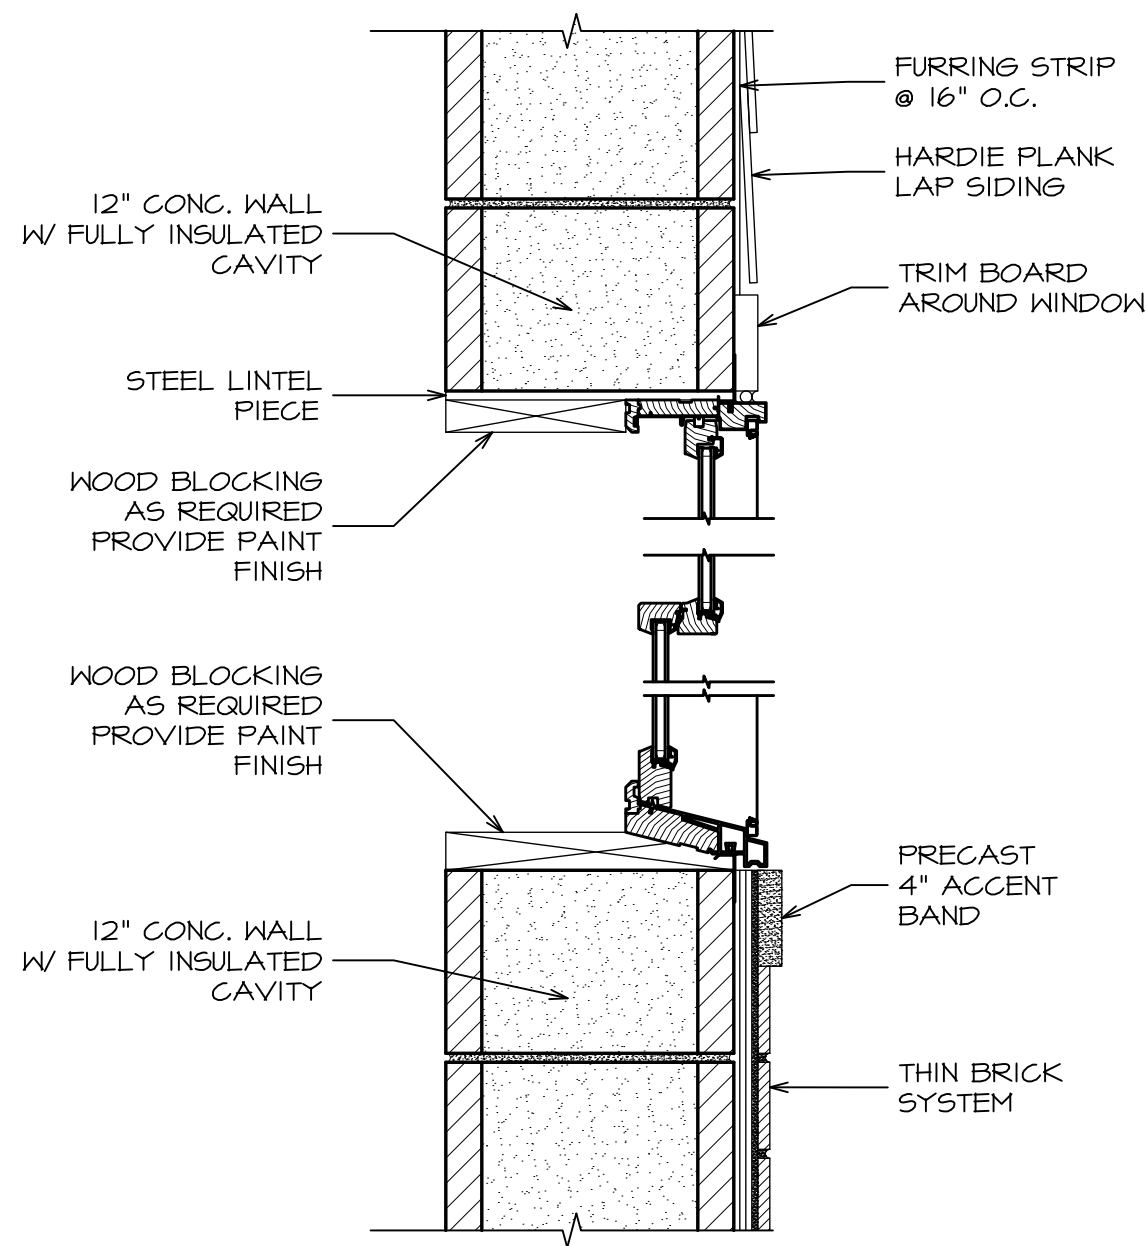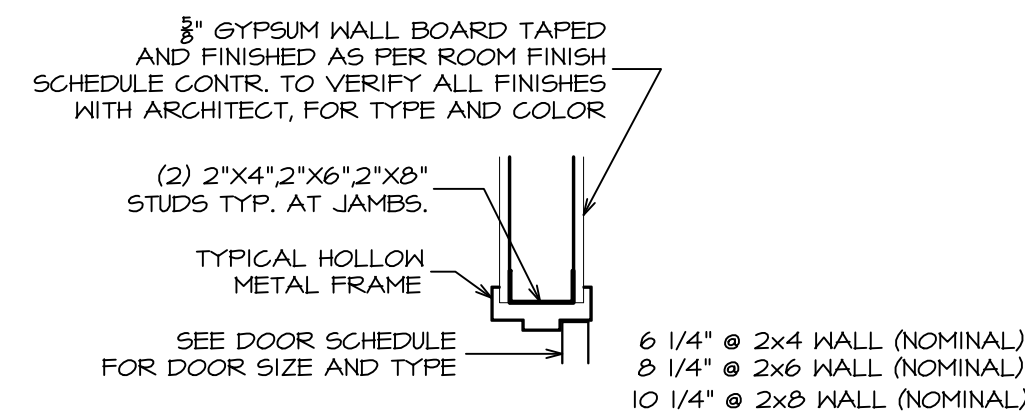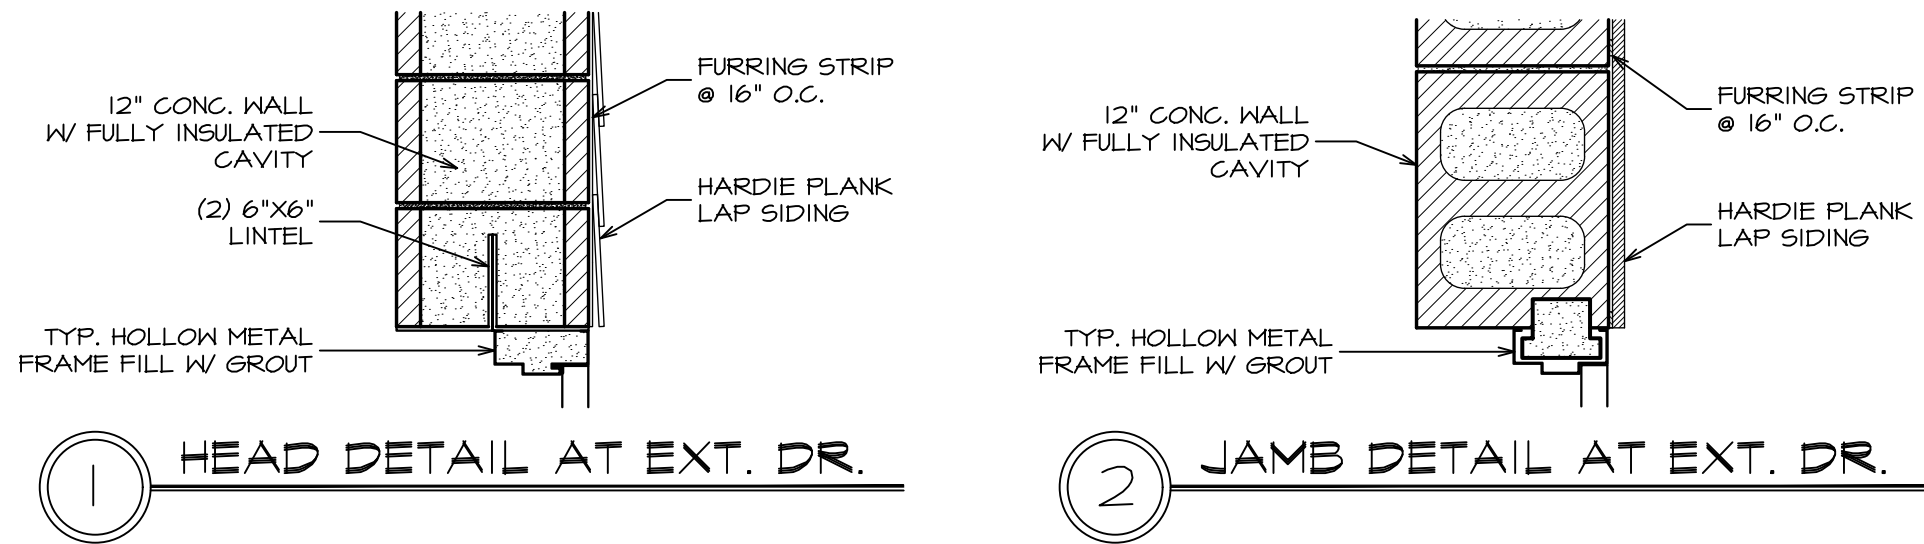

WINDOW SECTION

SCALE: 1-1/2" = 1'-0"

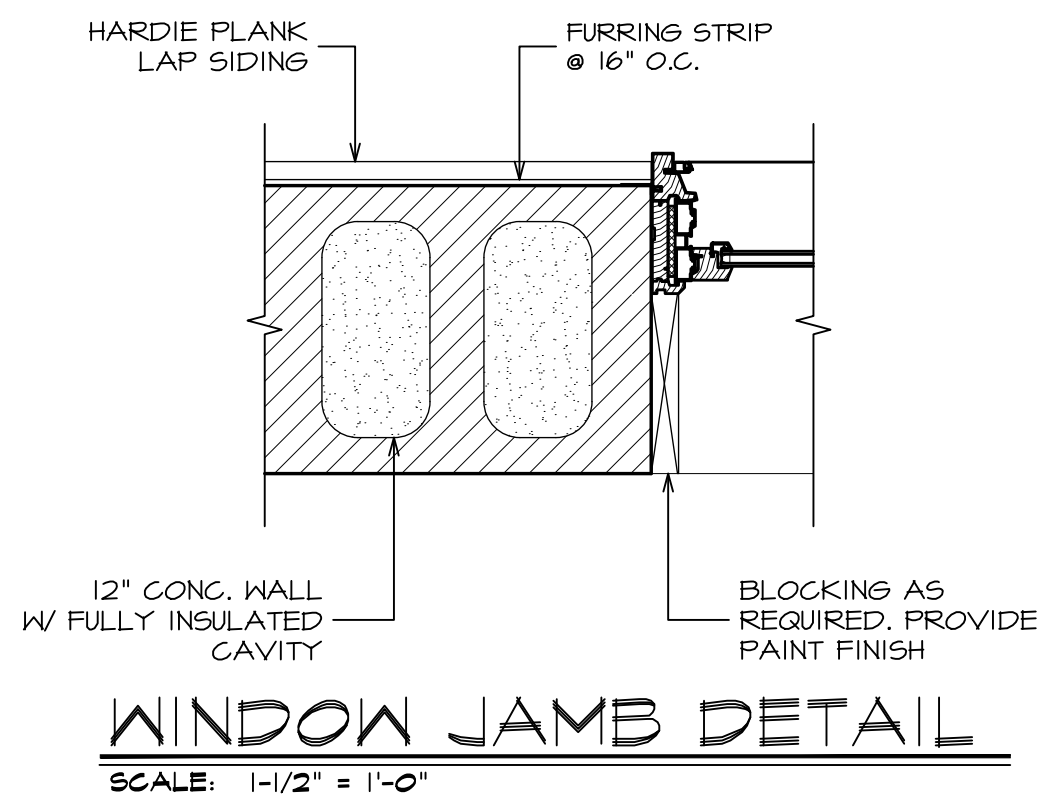

DATE: ISSUE

---20--- ISSUED FOR BIDDING & PERMIT

SEAL:

SENDEWSKI ARCHITECTS PC
ARCHITECTS - PLANNERS
215 ROANOKE AVENUE
RIVERHEAD, NY 11901
(631) 727-5352
9 SELENA COURT
WALDEN, NY 12586
(845) 275-8859

PROPOSED PAVILION
TAPPAN FIRE DISTRICT
300 WESTERN HIGHWAY SOUTH
TAPPAN, NY 10983

DOOR & FINISH SCHEDULES
AND DETAILS

PROJECT #: 2108/C

DRAWN BY:


CAD FILE: 2108/P./BID

DRAWING#:


A-6.1

PAVILLION


07-11-22 UPDATE

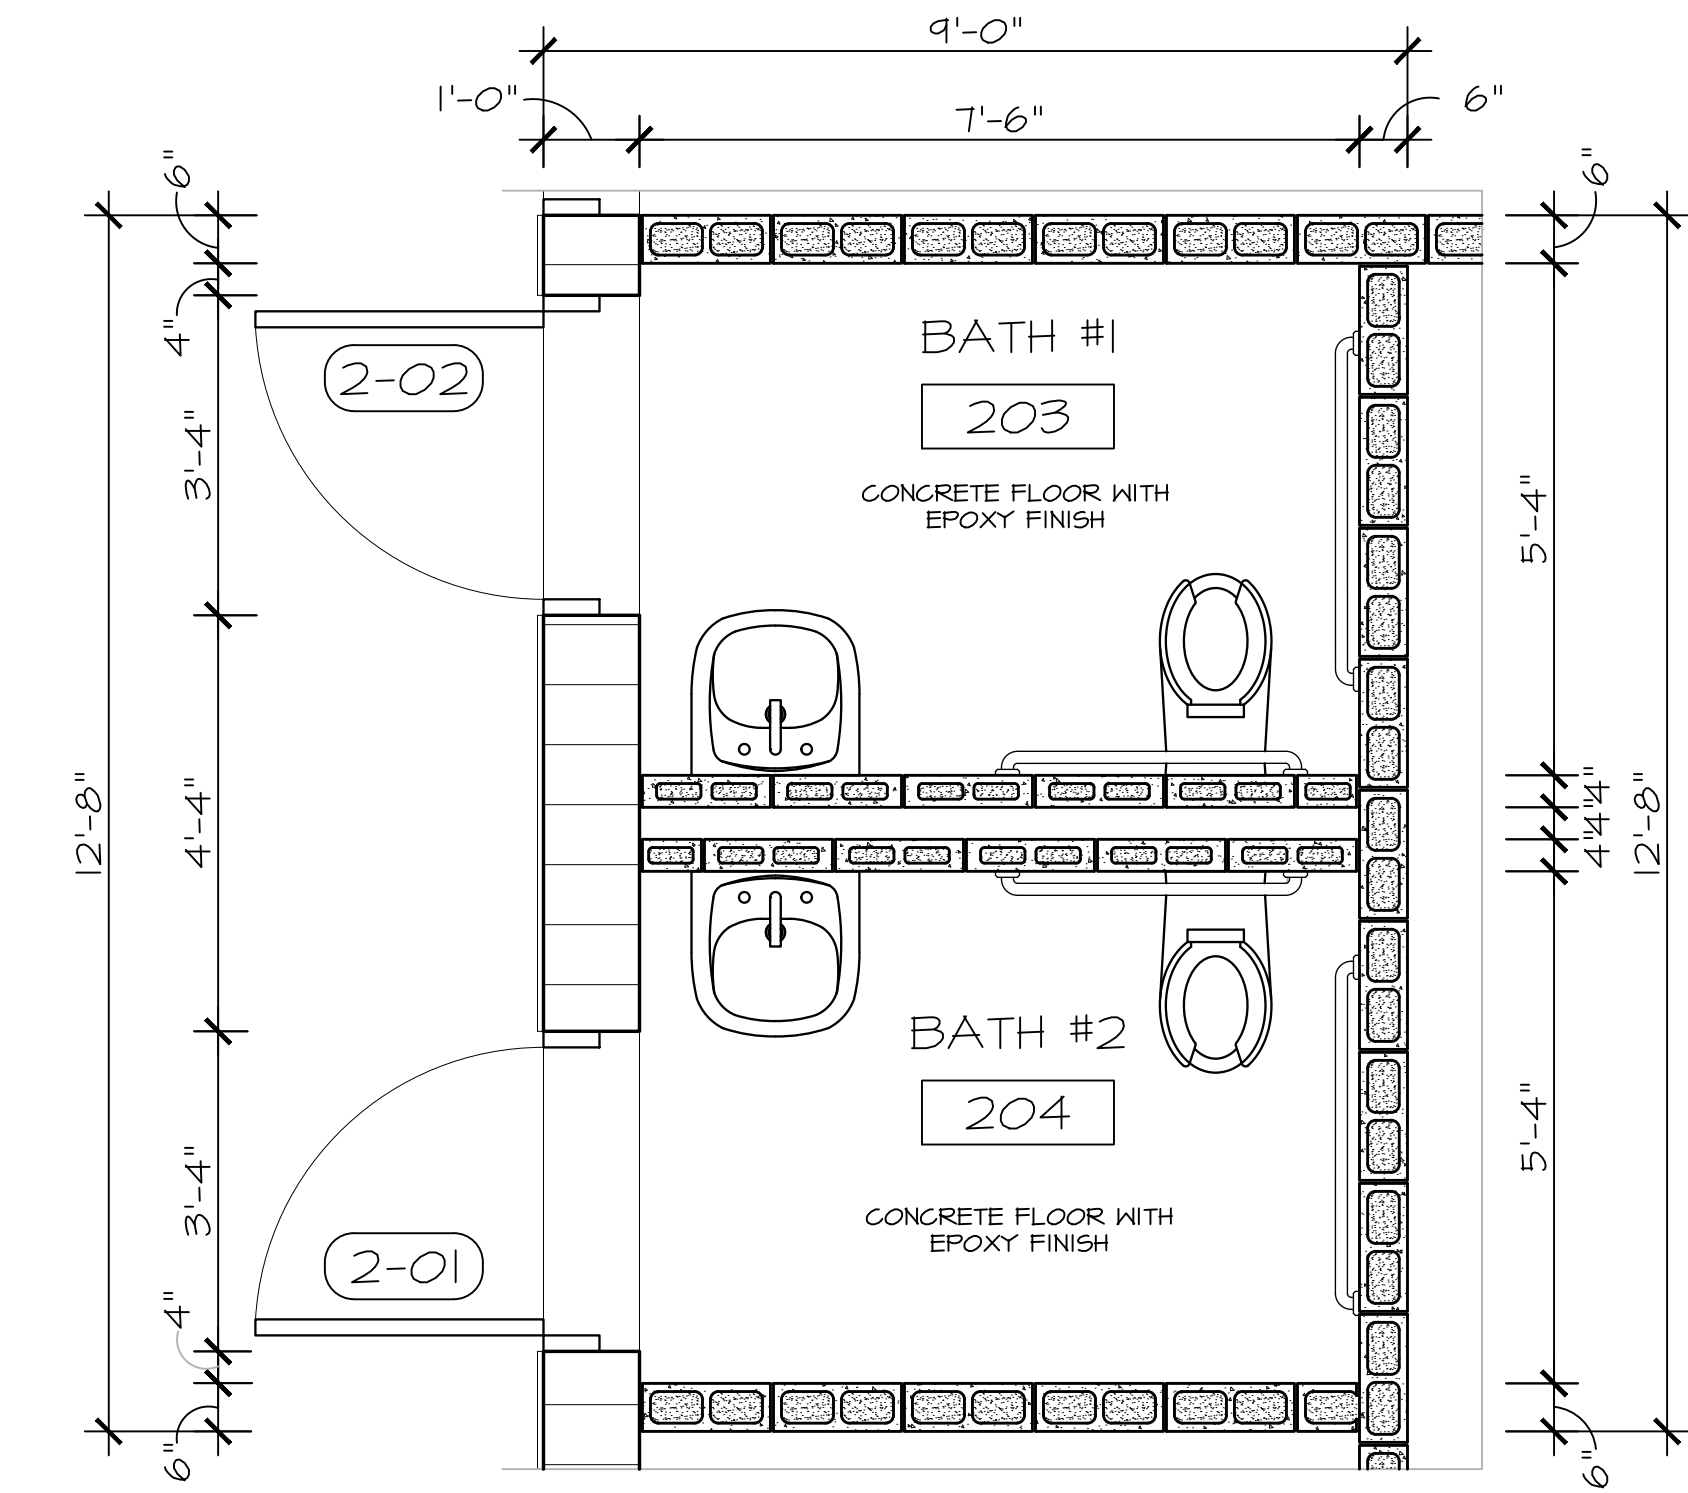


MAIN LEVEL RESTROOMS
SCALE: 1/2" = 1'-0"

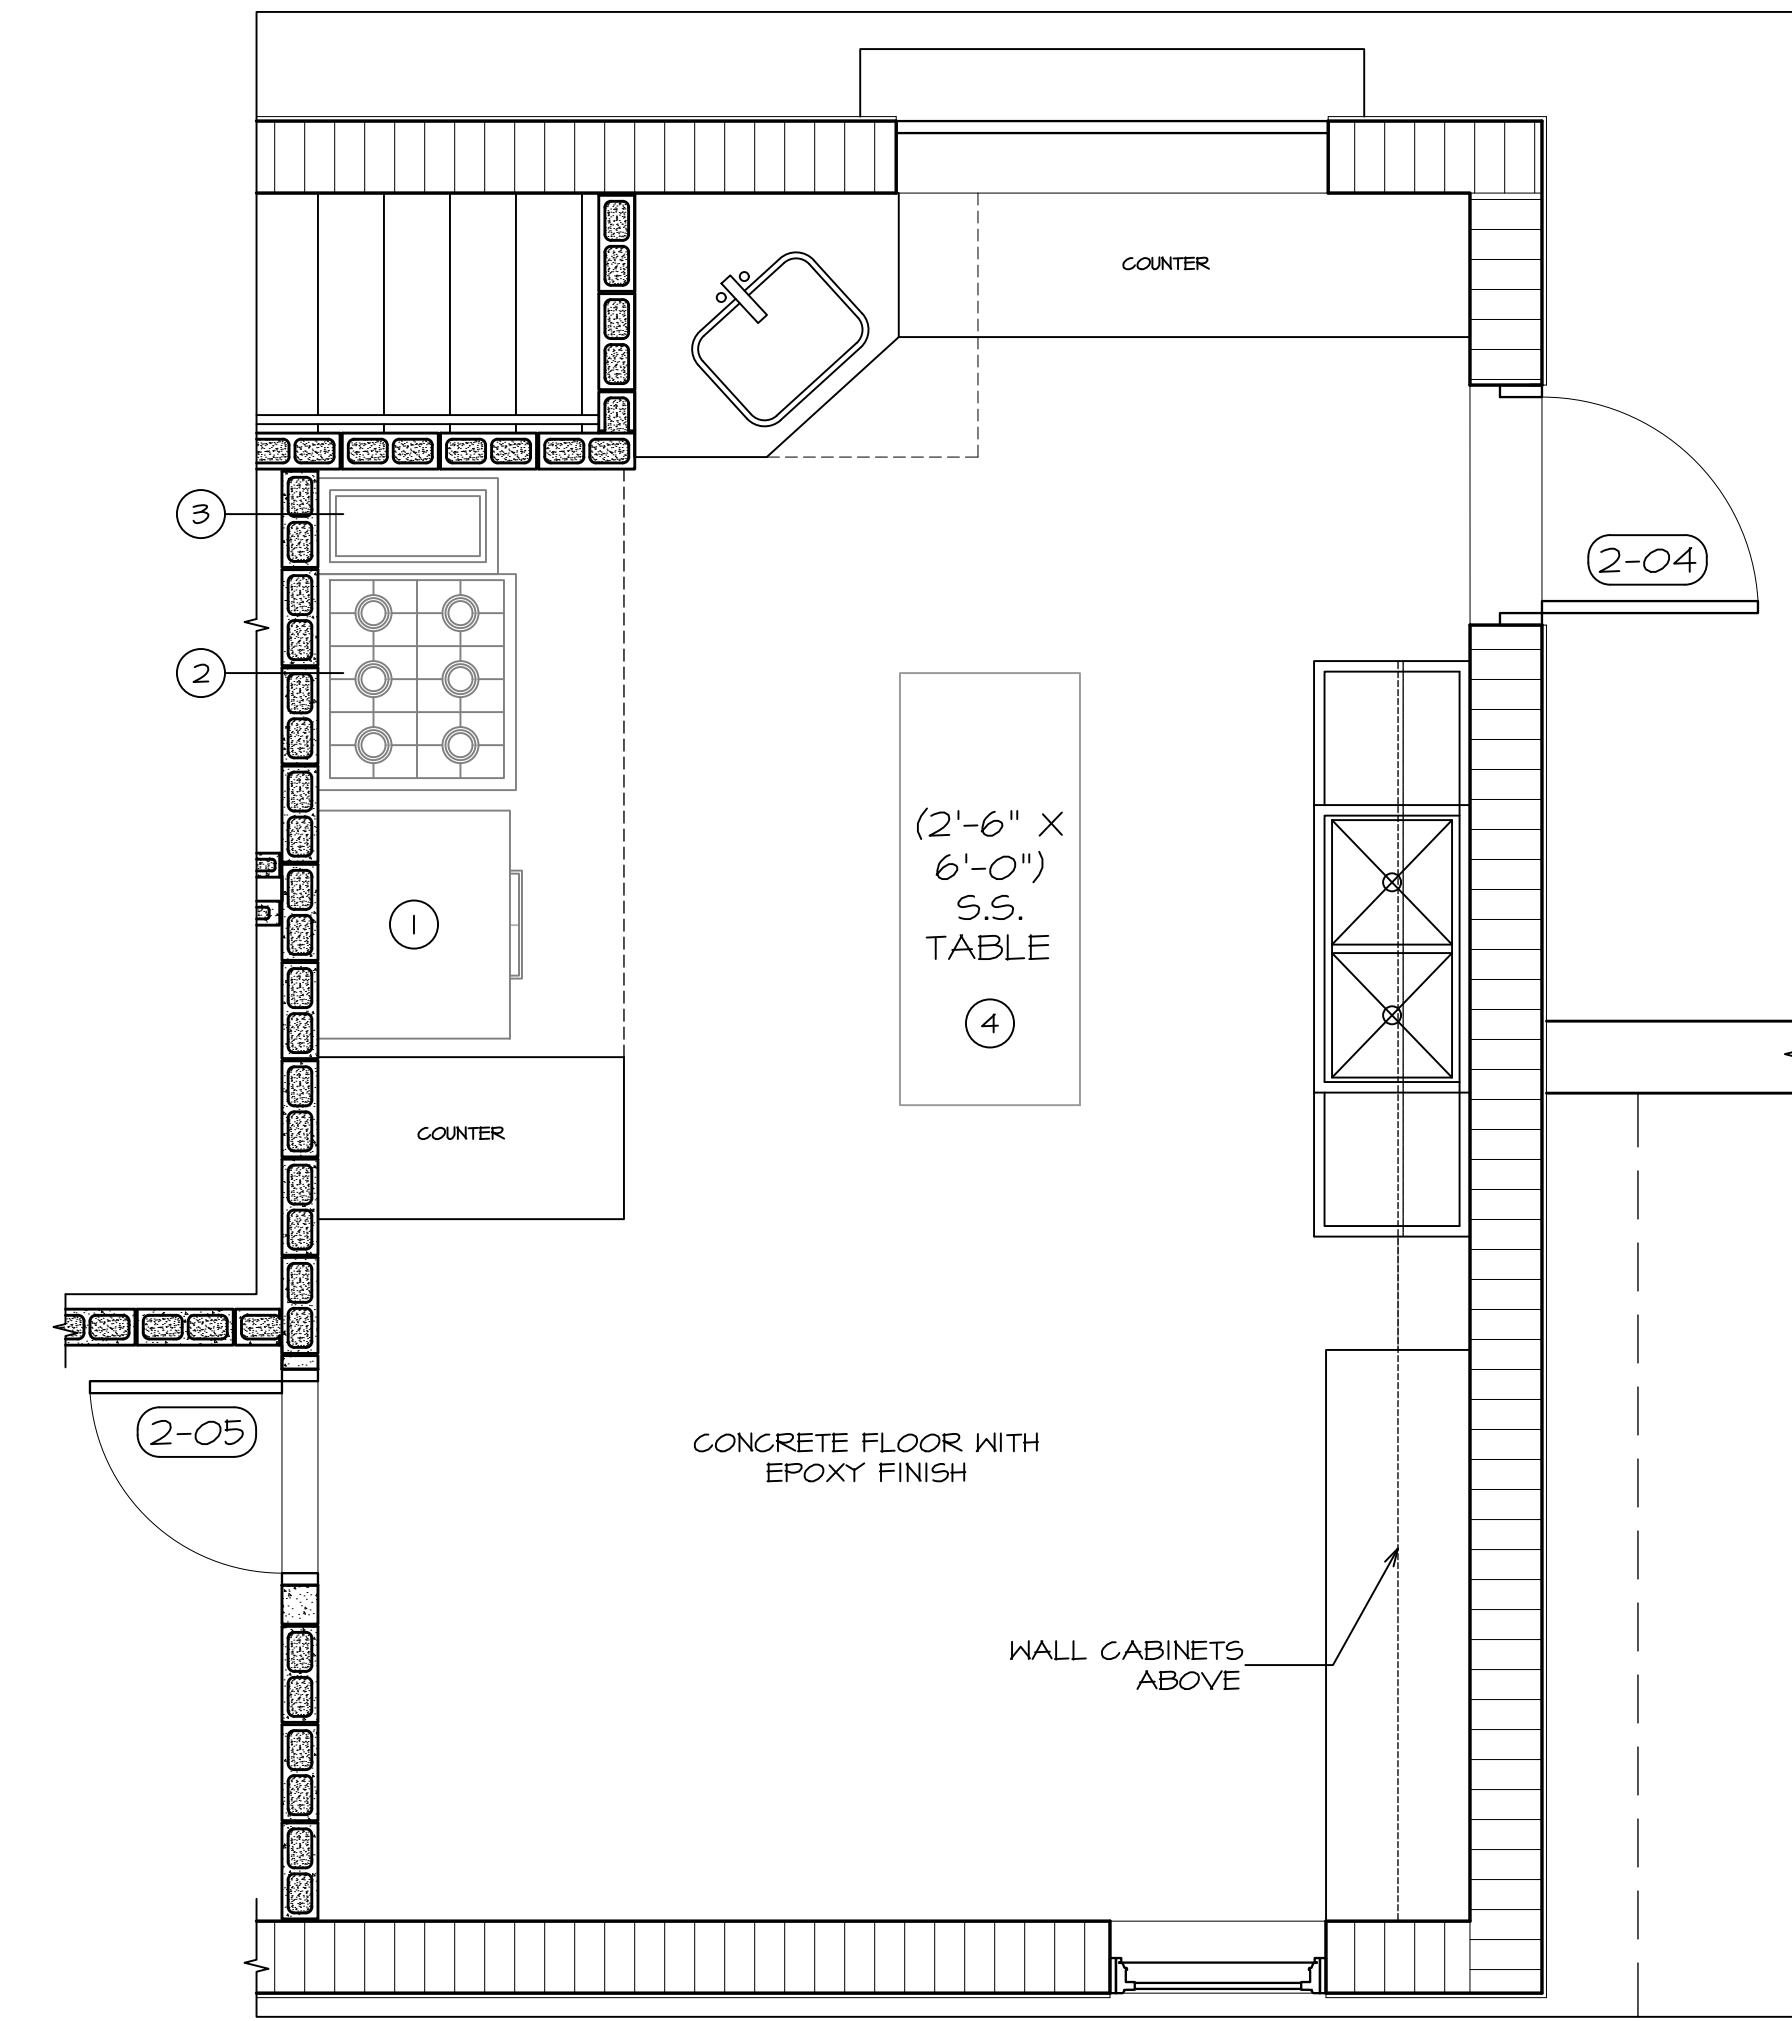



KITCHEN PLAN
SCALE: 3/8" = 1'-0"

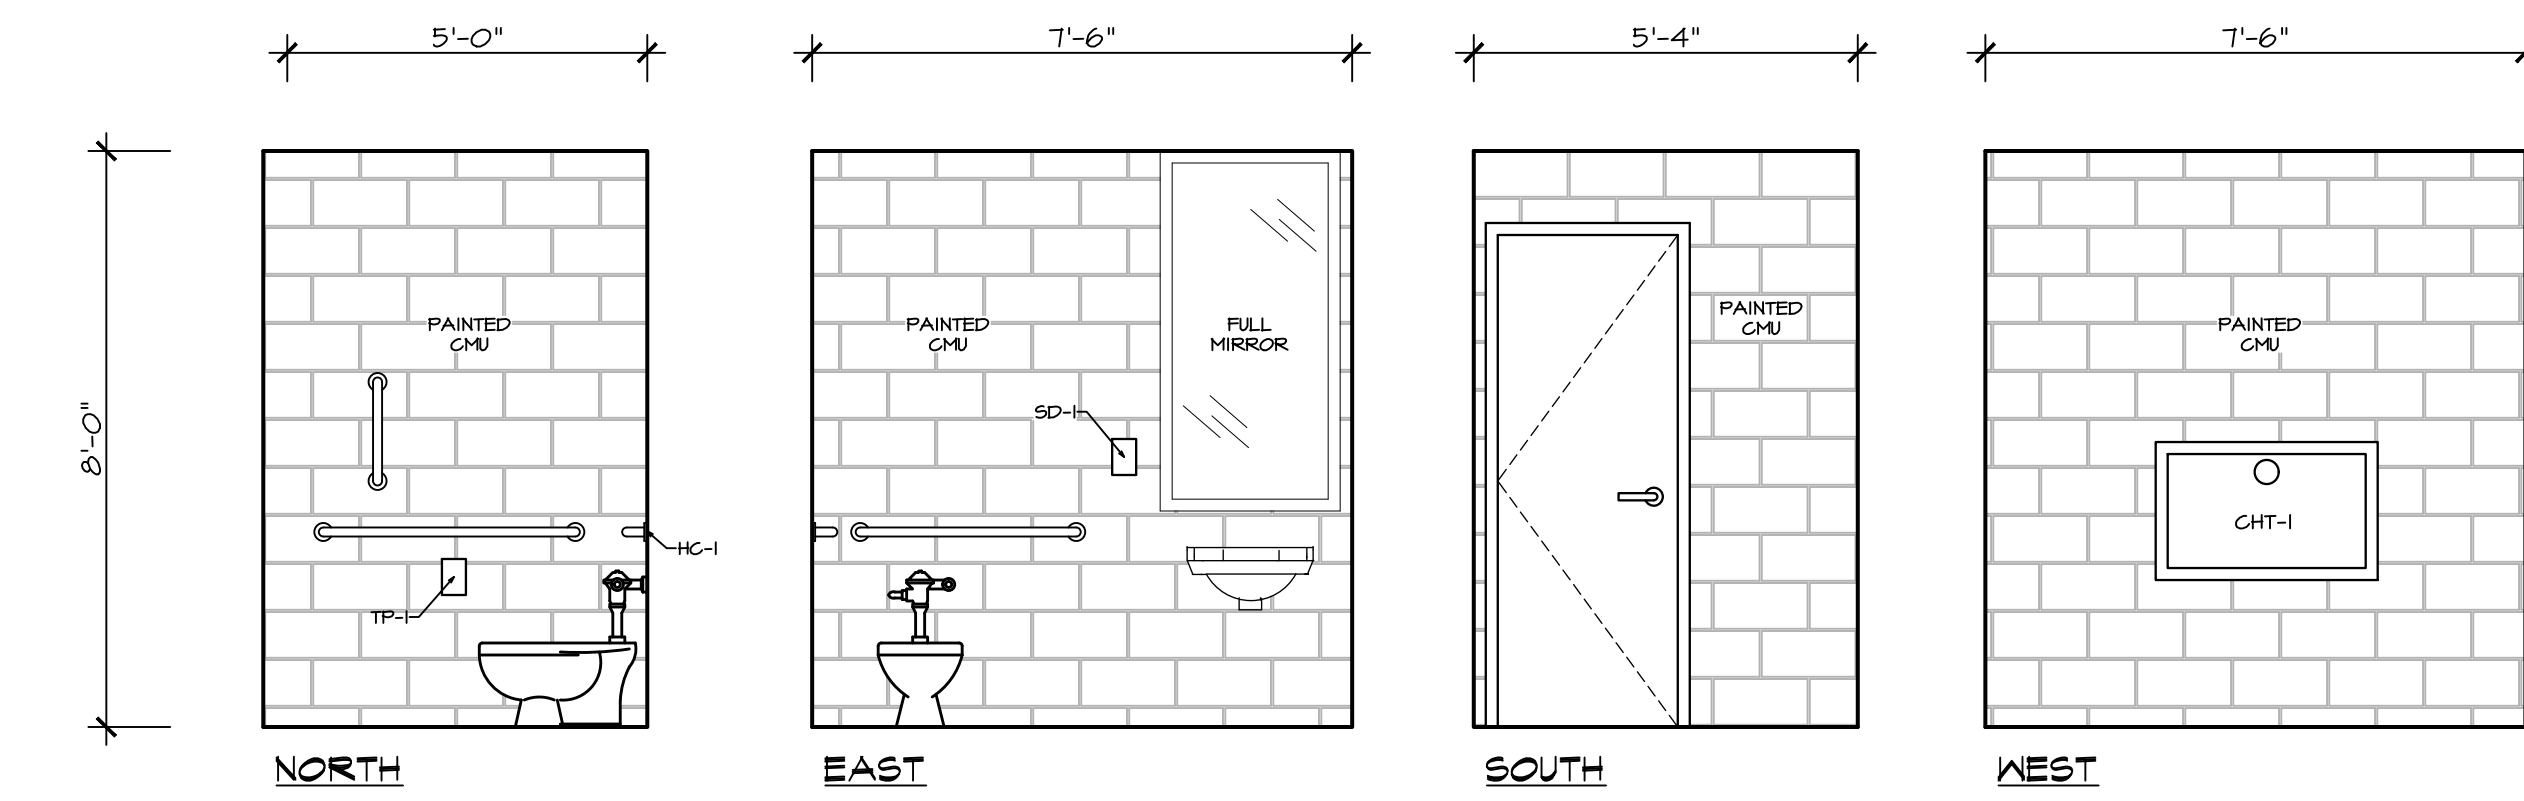

203 BATHROOM #1
SCALE: 3/8" = 1'-0"

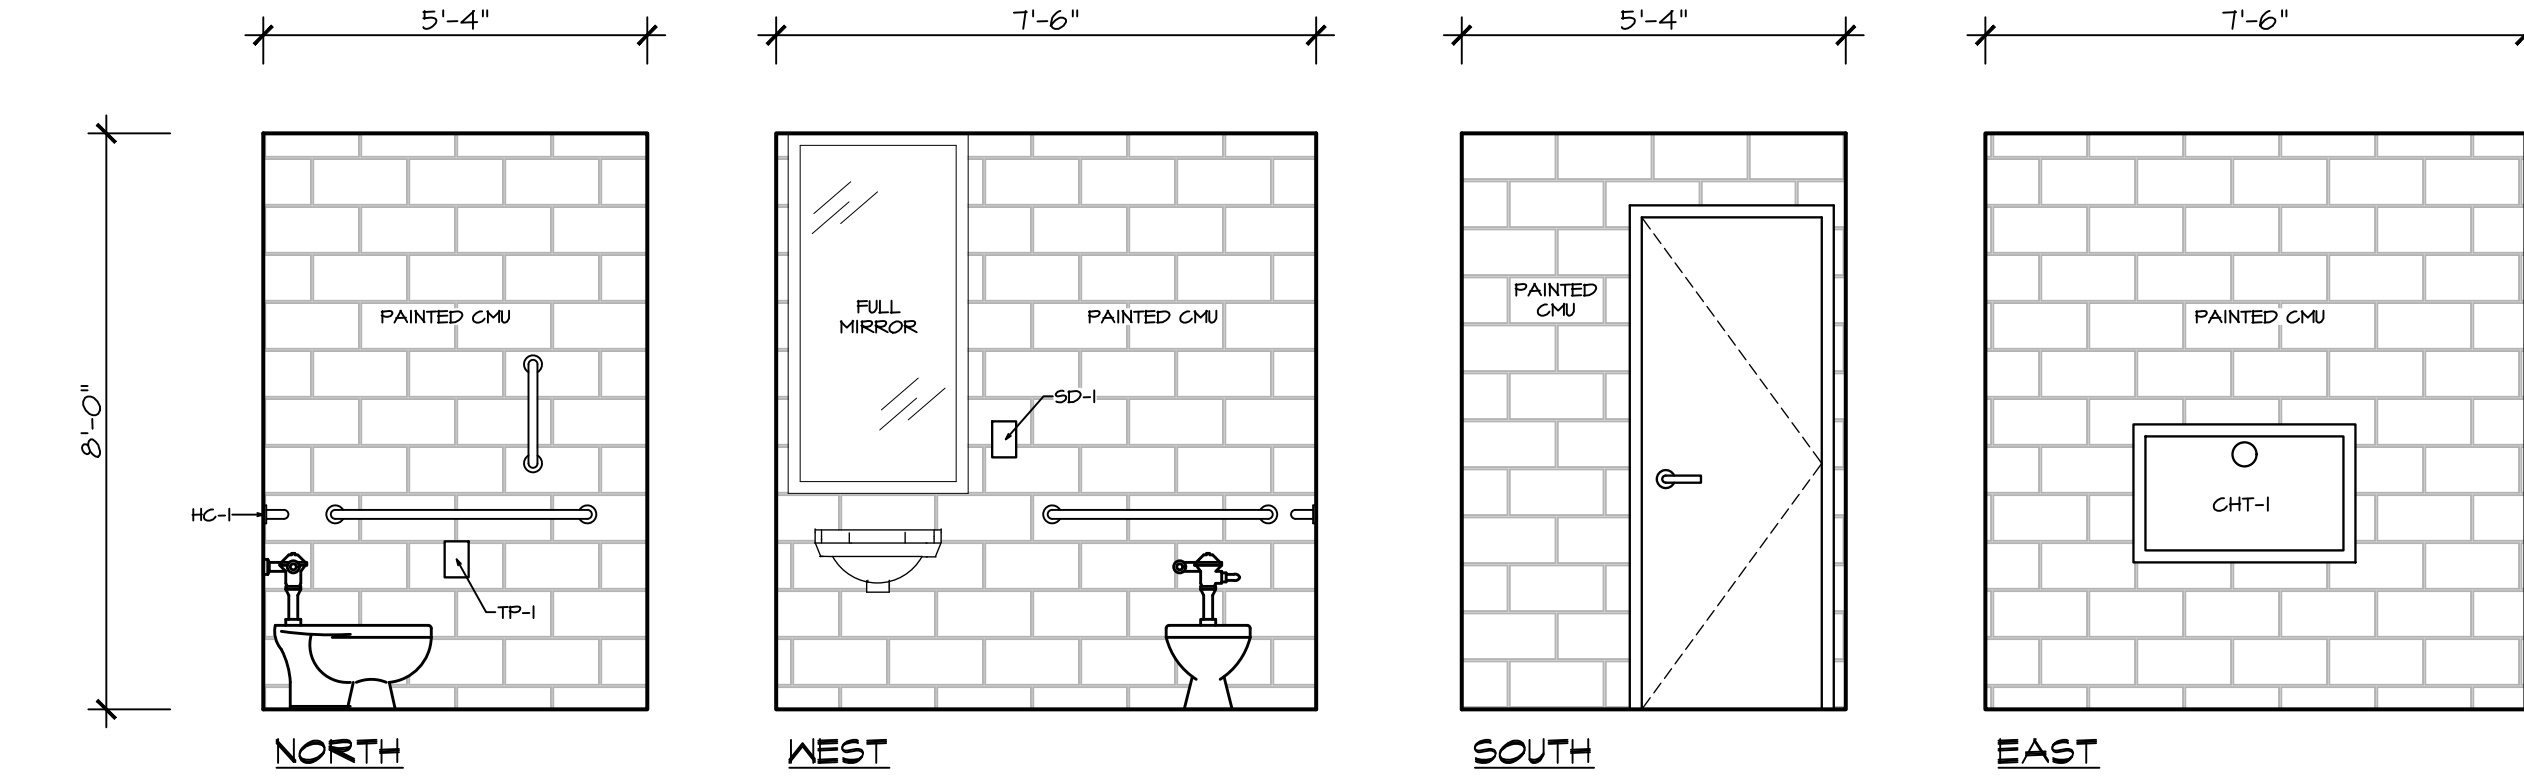

204 BATHROOM #2
SCALE: 3/8" = 1'-0"

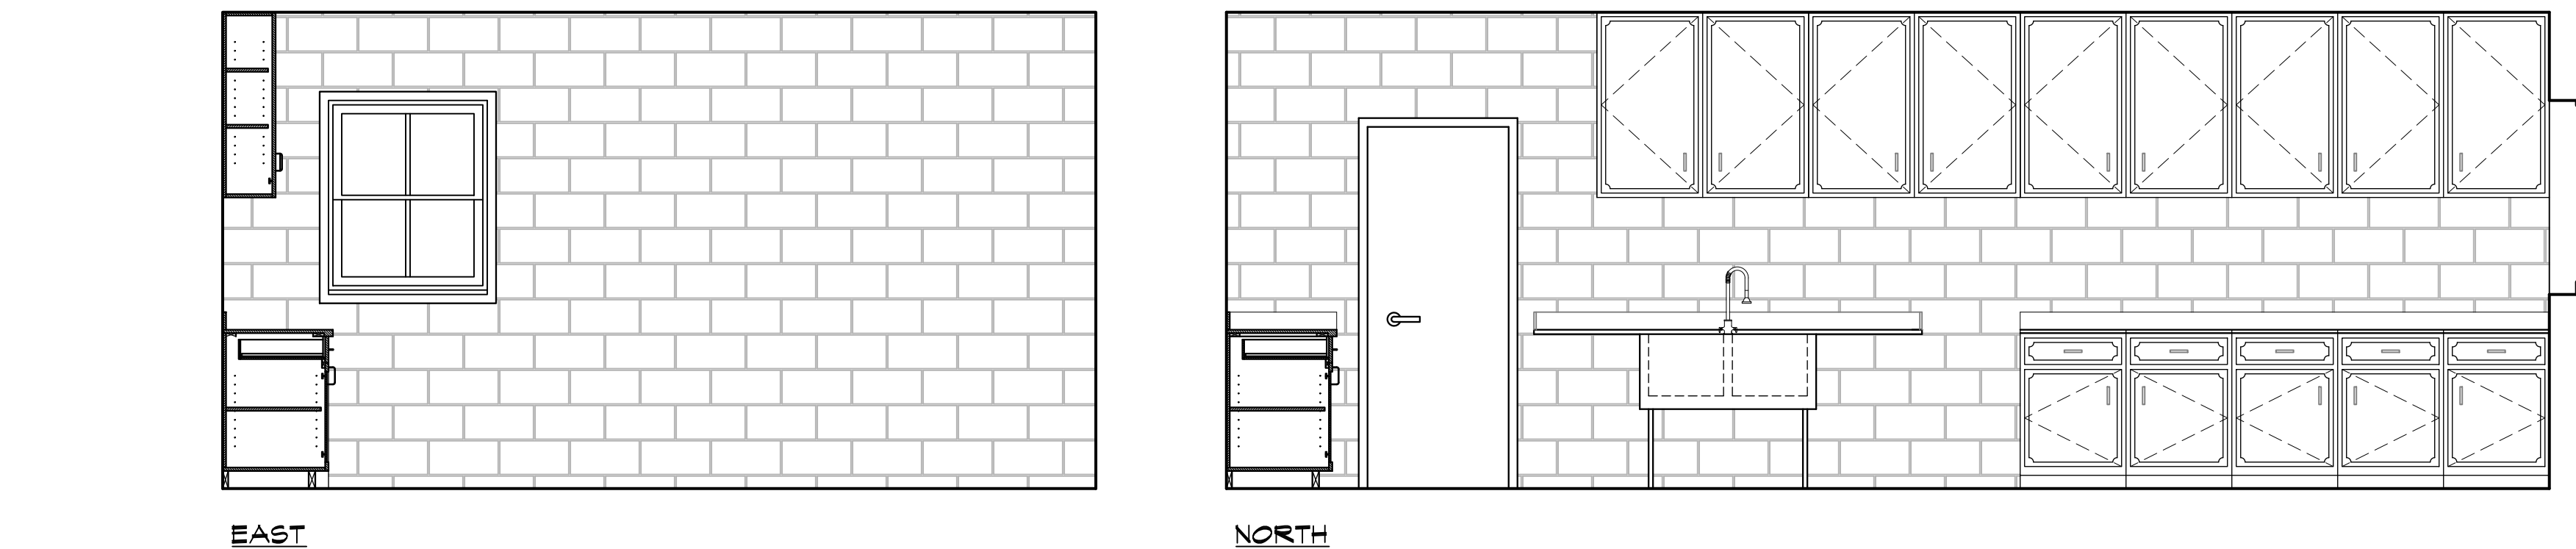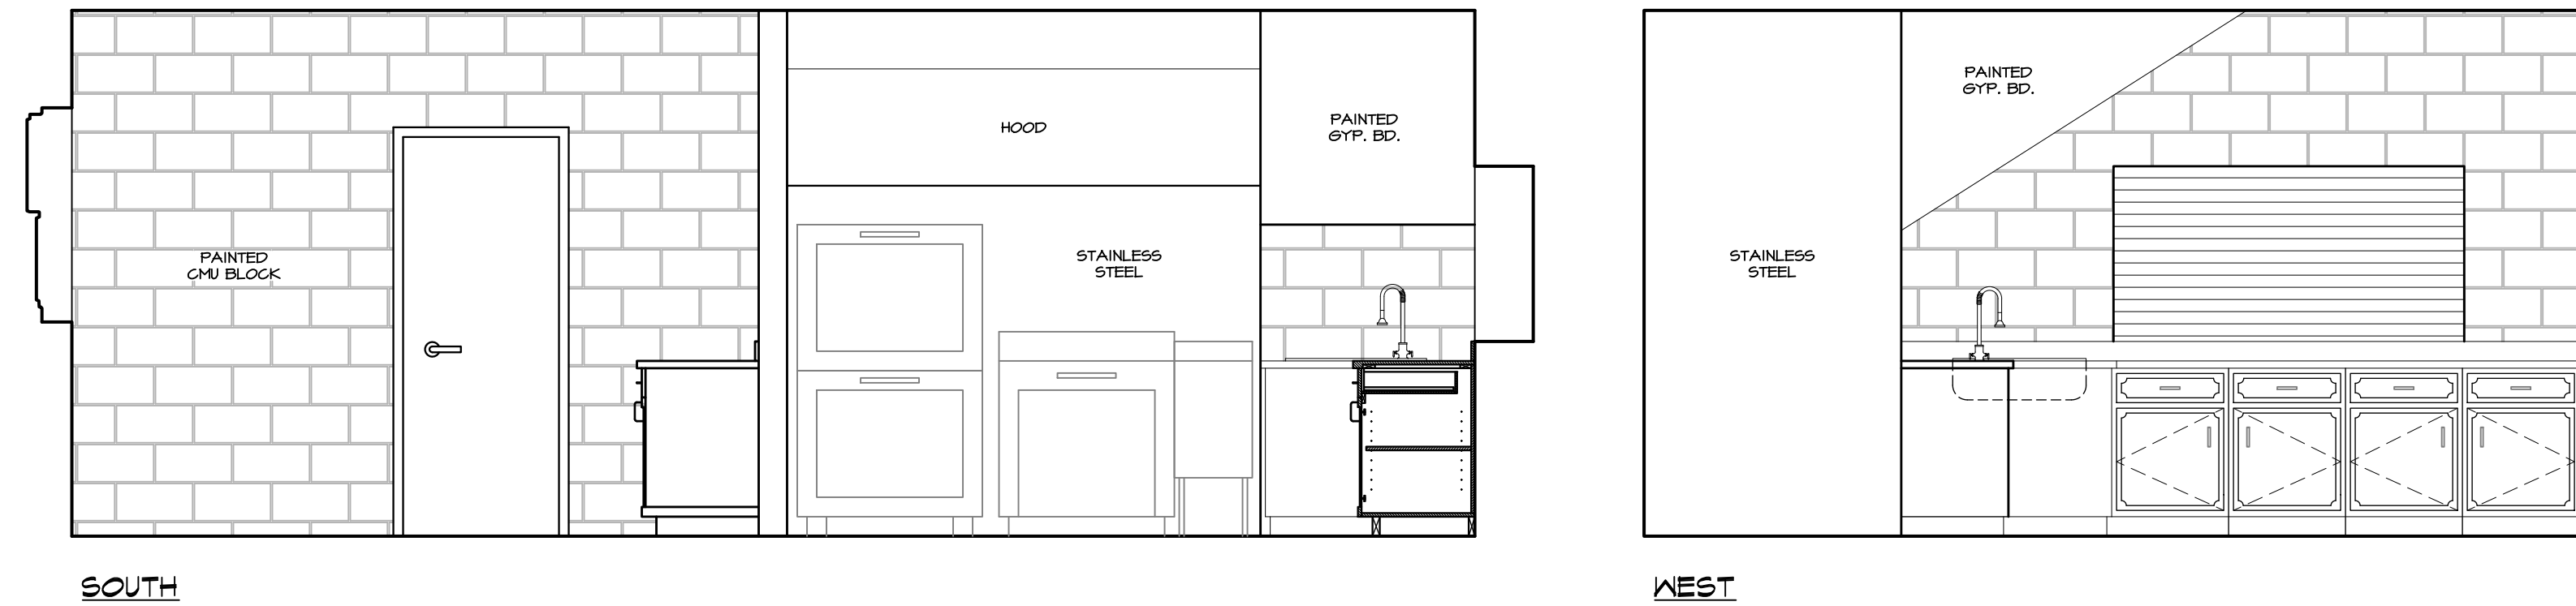

201 KITCHEN
SCALE: 3/8" = 1'-0"

EQUIPMENT SCHEDULE			
EQ. NO.	QUANTITY	DESCRIPTION	NOTES
①	1	---	SUPPLY & INSTALL
②	1	---	SUPPLY & INSTALL
③	1	---	SUPPLY & INSTALL
④	1	---	SUPPLY & INSTALL

GENERAL CONTRACTOR SHALL REMOVE EXISTING EQUIPMENT TO ALLOW FOR NEW WORK AND RE-INSTALL UPON COMPLETION. DIS-CONNECT AND RE-CONNECT TO BE BY OTHERS

BATHROOM ACCESSORY/EQUIPMENT LENDEND				
TILE REF.	MAKE	MODEL	COLOR/FINISH	NOTES
SD-1 (SOAP DISP.)	ASI	0362	SS	FIELD COORDINATE LOCATIONS & MTG. HEIGHTS
TP-1 (TP DISP.)	ASI	20030	SS	FIELD COORDINATE LOCATIONS & MTG. HEIGHTS
GB-1 (GRAB BAR)	ASI	3700	SS	FIELD COORDINATE LOCATIONS & MTG. HEIGHTS
CHT-1 (CHANGING TBL)	KOALA CARE	KB100-01ST	GREY	FIELD COORDINATE LOCATIONS & MTG. HEIGHTS

NOTE: ALL HARDWARE SHALL MEET ADA REQ'MTS FOR MOUNTING HEIGHT.

DATE: ISSUE
---20--- ISSUED FOR BIDDING & PERMIT

SEAL:

SENDEWSKI ARCHITECTS PC
ARCHITECTS - PLANNERS
215 ROANOKE AVENUE
RIVERHEAD, NY 11901
(631) 727-5352
9 SELENA COURT
WALDEN, NY 12586
(845) 275-8859

PROPOSED PAVILION
TAPPAN FIRE DISTRICT
300 WESTERN HIGHWAY SOUTH
TAPPAN, NY 10983
RESTROOM & KITCHEN PLANS
& ELEVATIONS

PROJECT #: 2108/C

DRAWN BY:


CAD FILE: 2108/P./BID

DRAWING#:

A-6.2

PAVILLION

07-12-22 UPDATE

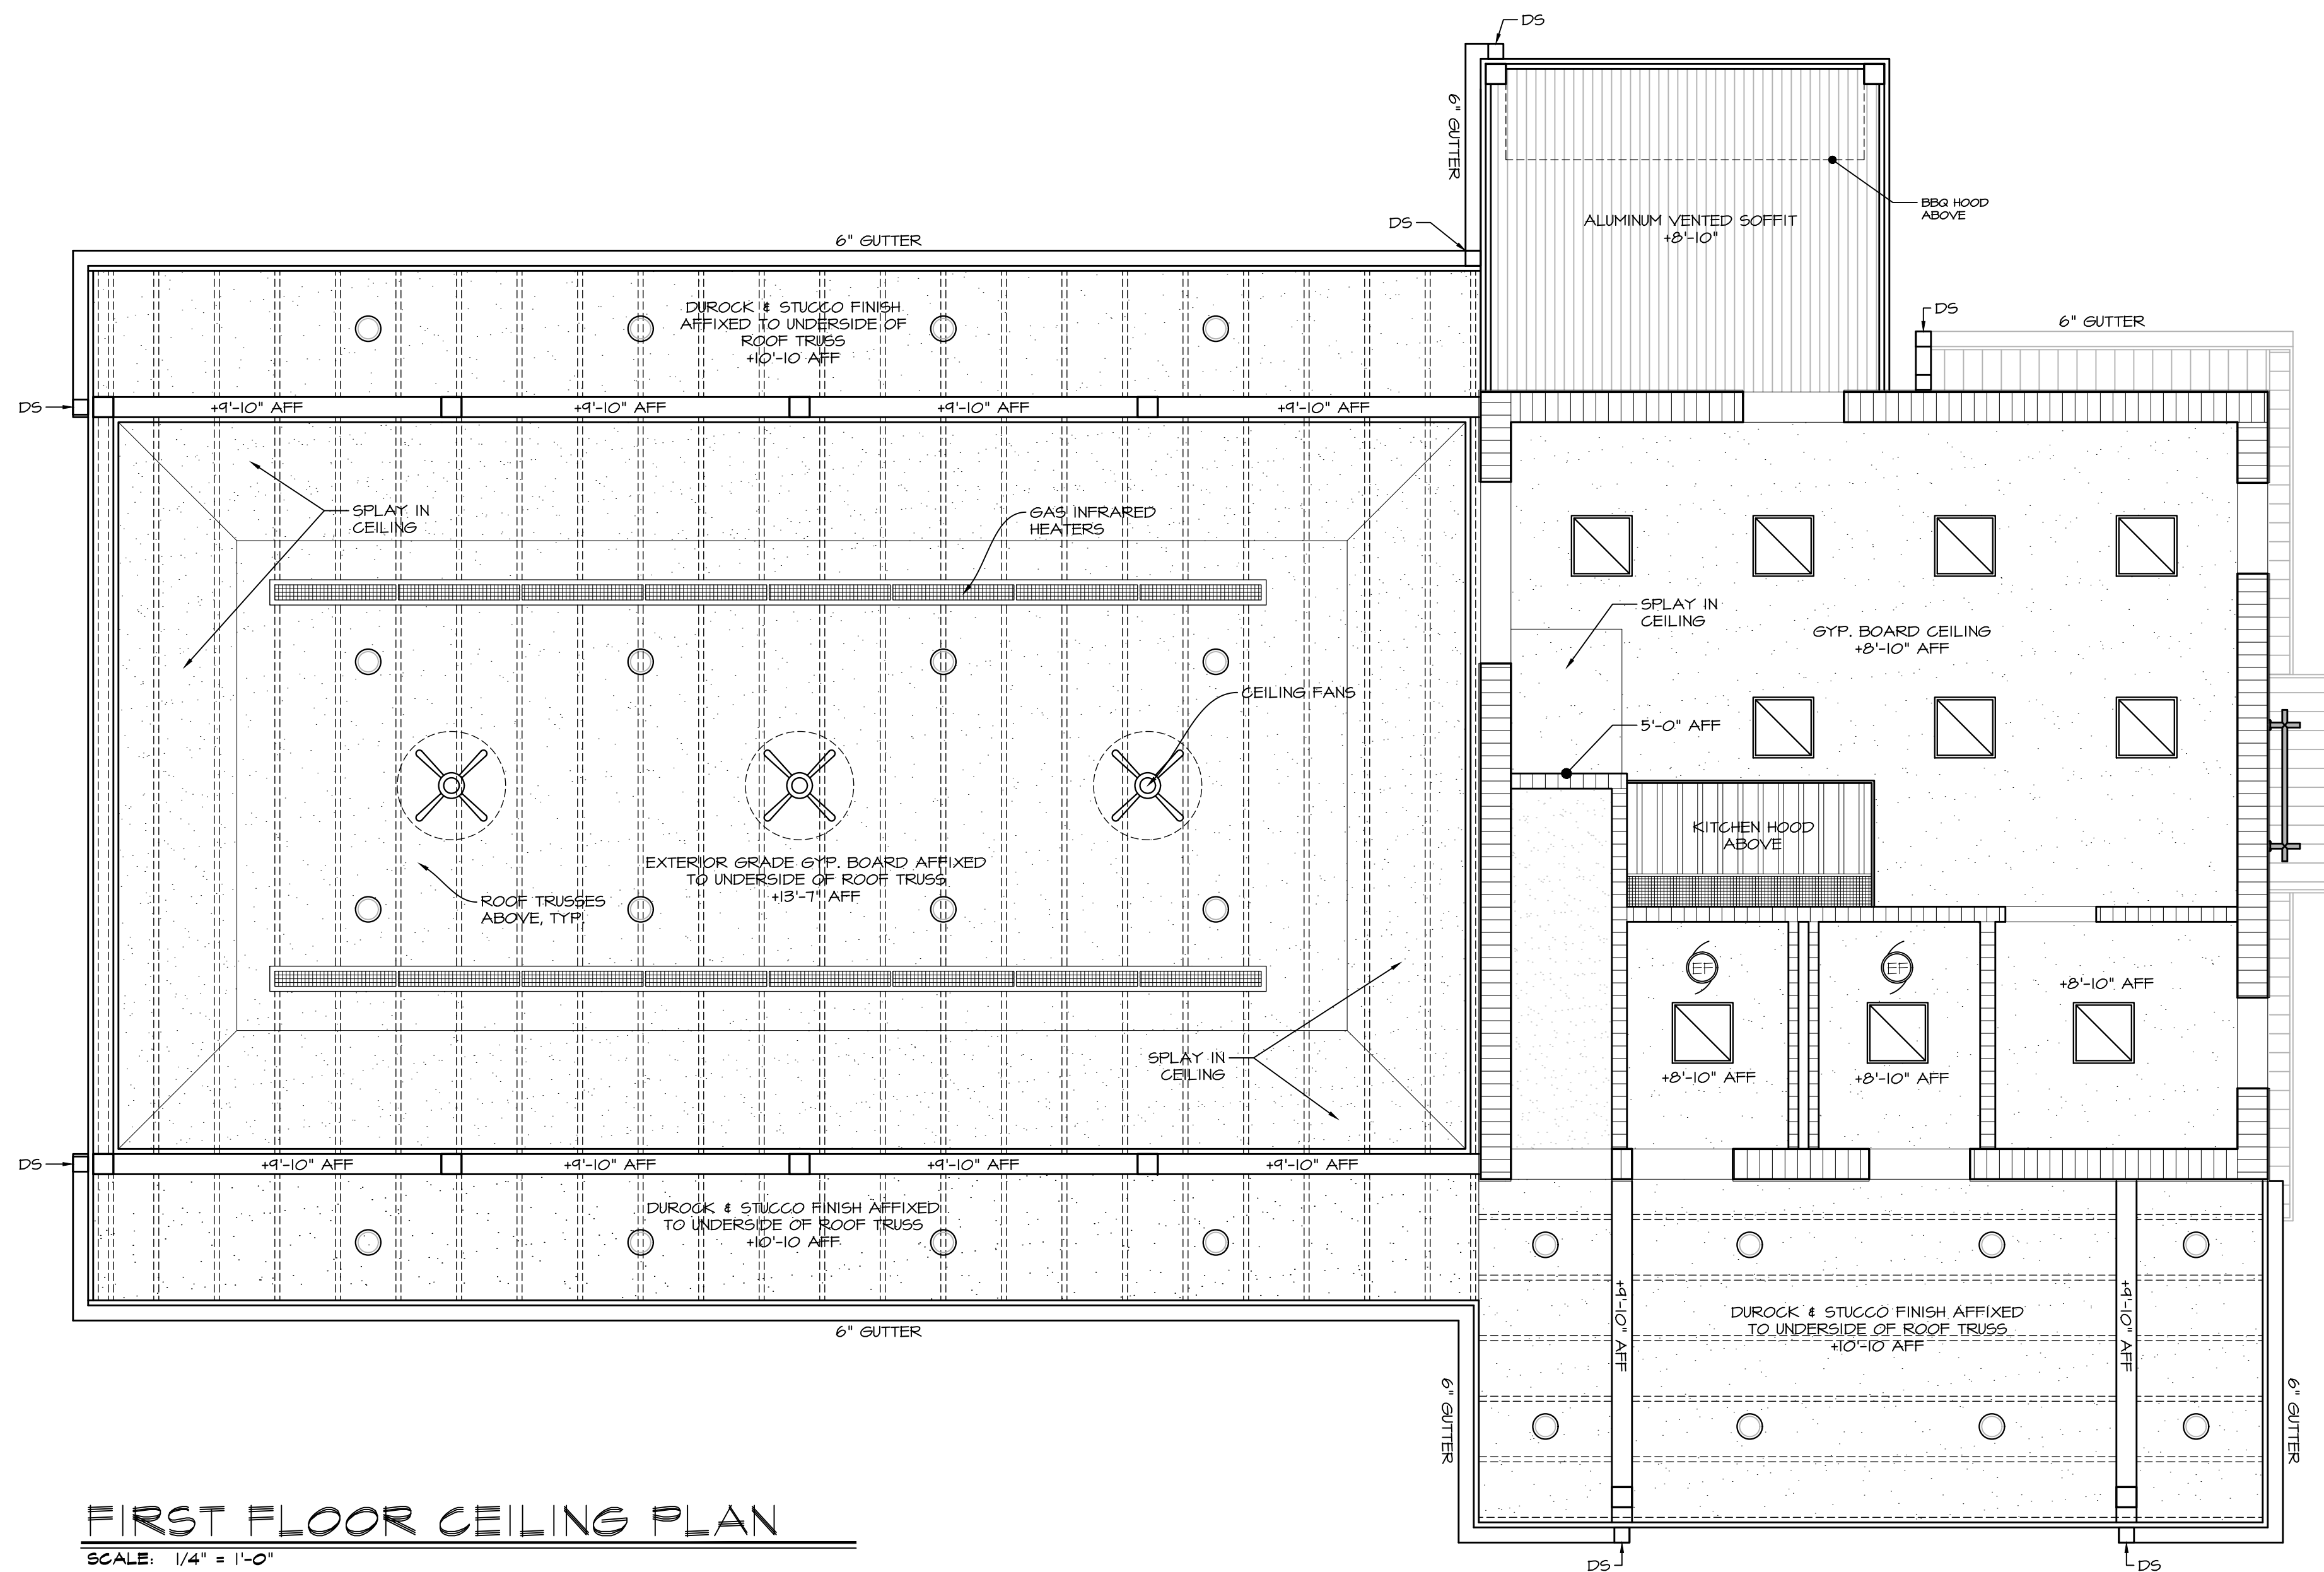


FIRST FLOOR CEILING PLAN

SCALE: 1/4" = 1'-0"


CEILING LEGEND:

- 1'-0" x 4'-0" LED SURFACE LIGHT
- 2'-0" x 4'-0" LED FIXTURE
- 2'-0" x 2'-0" LED FIXTURE
- LED RECESSED HI-HAT
- HVAC SUPPLY
- HVAC RETURN
- EXHAUST FAN
- HATCH DEPICTS PAINTED GYP. BD. CLNG. FINISH (TYP.)
- CEILING FAN
- GAS INFRARED HEATER

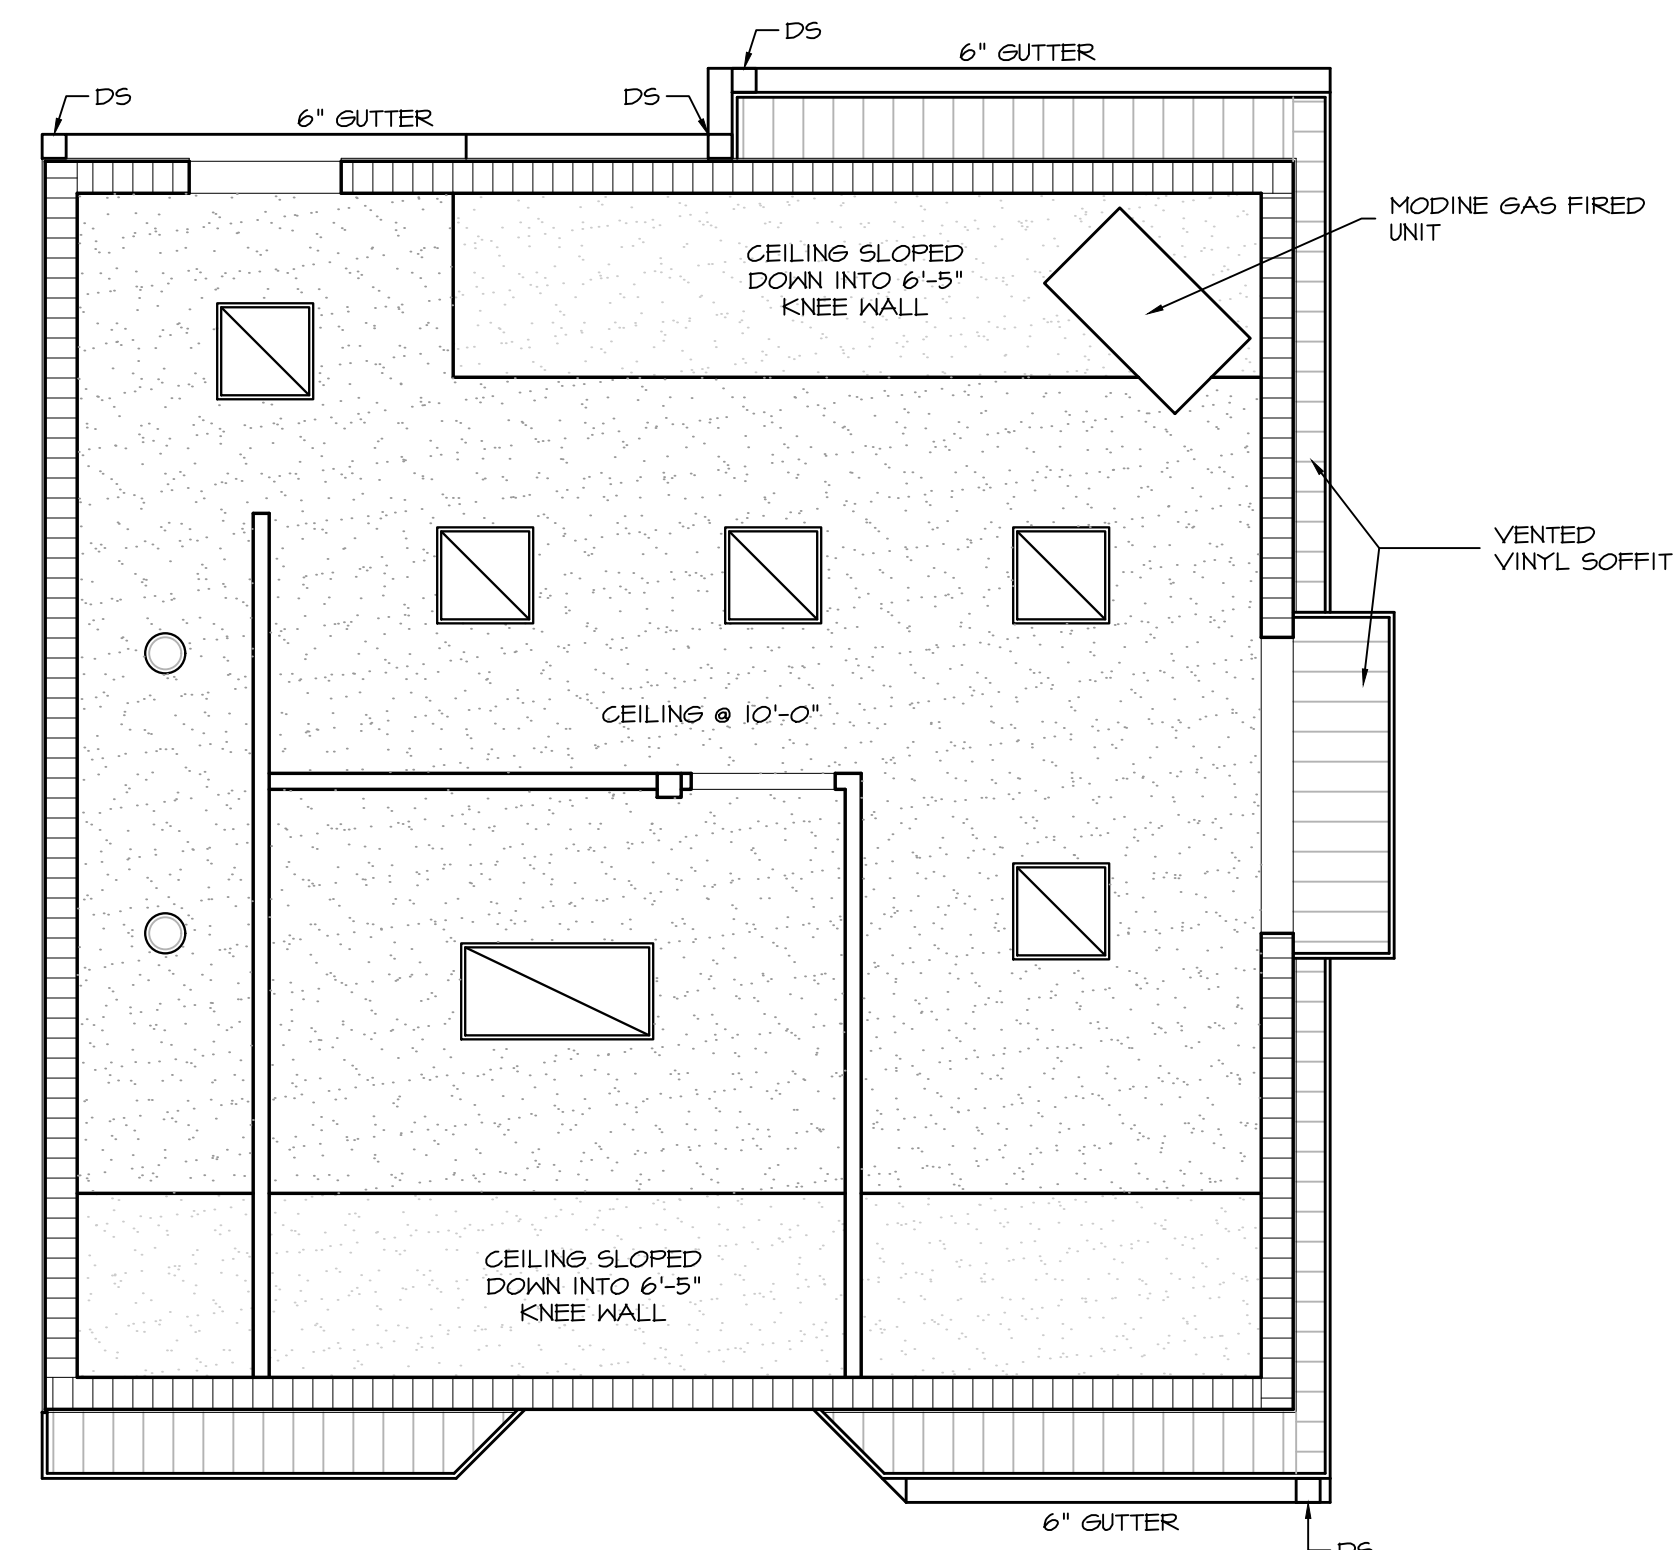

SECOND FLOOR CEILING PLAN

SCALE: 1/4" = 1'-0"

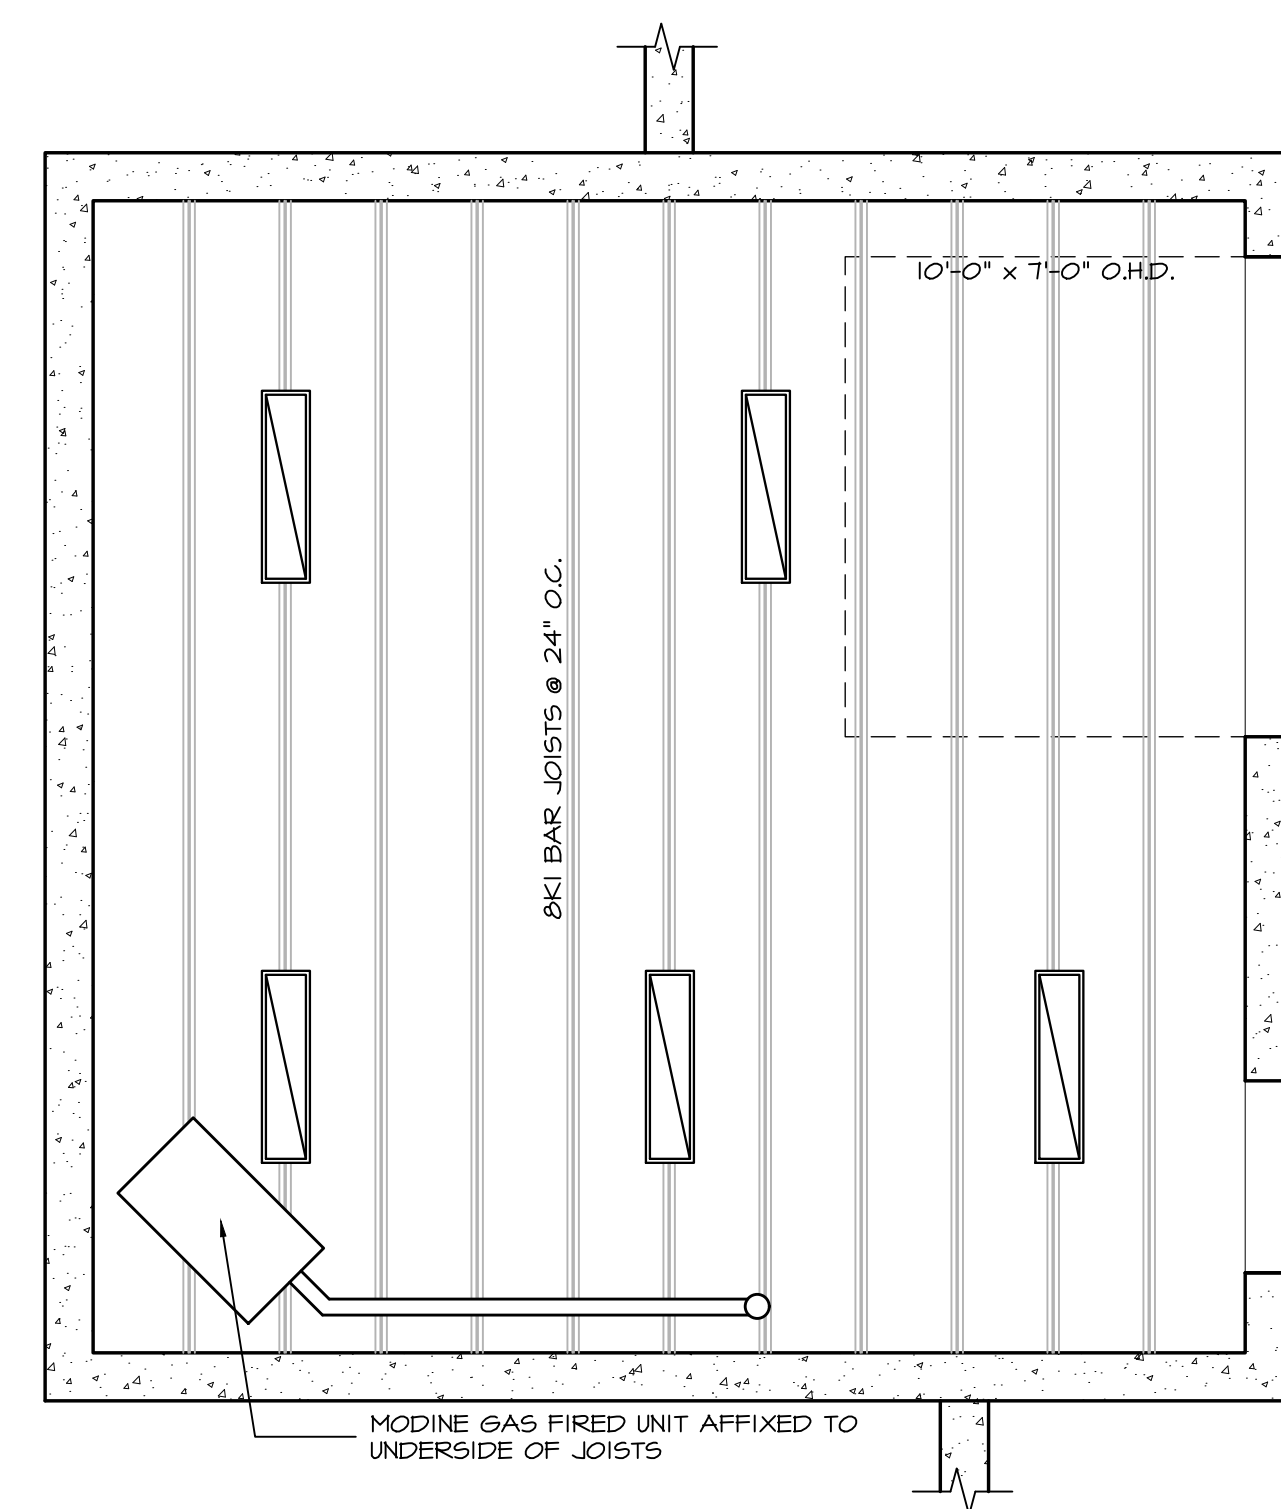

LOWER FIRST FLOOR CEILING PLAN

SCALE: 1/4" = 1'-0"

DATE: ISSUE
---20--- ISSUED FOR BIDDING & PERMIT

SEAL:

SENDEWSKI ARCHITECTS PC
ARCHITECTS - PLANNERS
215 ROANOKE AVENUE
RIVERHEAD, NY 11901
(631) 727-5352
9 SELENA COURT
WALDEN, NY 12586
(845) 275-8859

PROPOSED PAVILLION
TAPPAN FIRE DISTRICT
300 WESTERN HIGHWAY SOUTH
TAPPAN, NY 10983

CEILING PLANS

PROJECT #: 2108/C

DRAWN BY:

CAD FILE: 2108/P./BID

DRAWING#:

A=7.1

PAVILLION

07-11-22 UPDATE