


A40 VOID.	A45 NEW RTU ABOVE TO INFILL EXISTING SKYLIGHT OPENING. SEE PLANS SPES-A-103, SPES-S-101, AND SPES-M-106.
A41 VOID	
A42 INSTALL NEW 2X2 SUSPENDED ACT-1 CEILING. NEW CEILING HEIGHT TO MATCH EXISTING.	
A43 INSTALL NEW 2X2 RECESSED LIGHTING IN NEW CEILING GRID.	
A44 BASE BID: MODIFY AND REINSTALL EXISTING ACT CEILING/CEILING, CEILING LIGHTS FOR NEW HVAC EQUIPMENT AND REFRIGERANT PIPING AS REQUIRED. ALTERNATE-100: REPLACE EXISTING CEILING/CEILING TILE, GRID AND LIGHTING WITH NEW ACT-1 AND LIGHTING	
KEY NOTES	

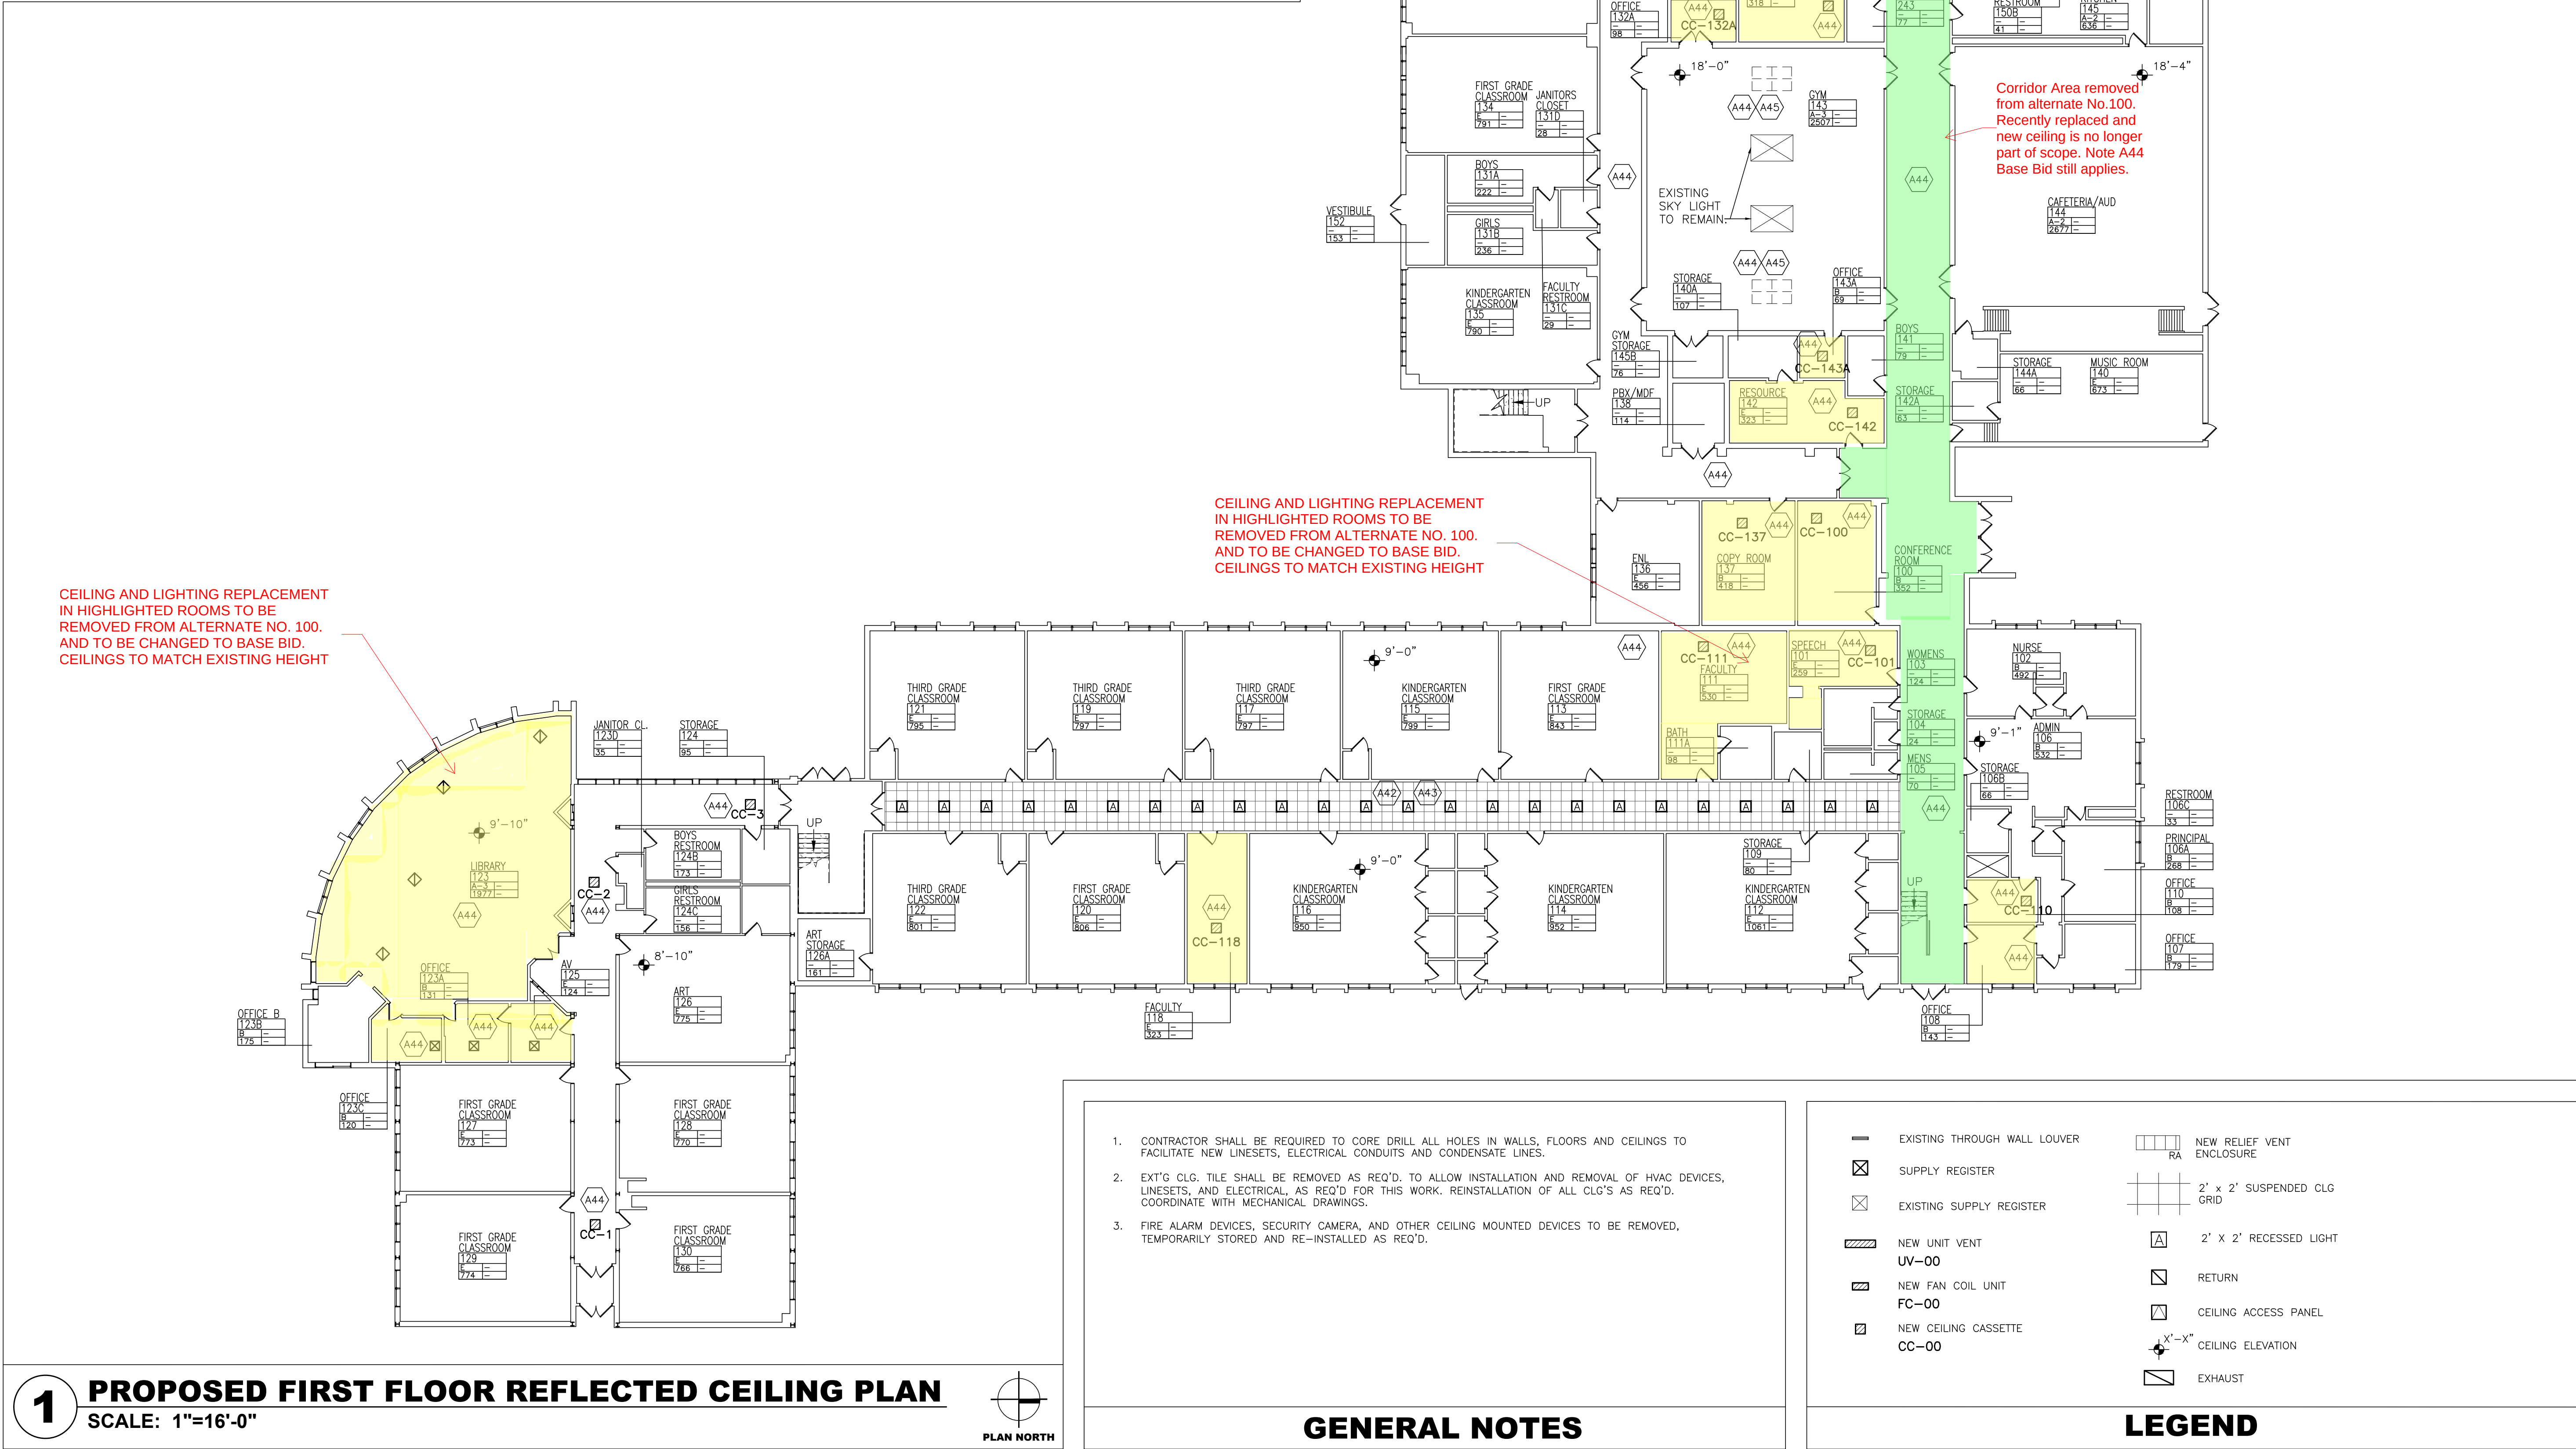

1 PROPOSED FIRST FLOOR REFLECTED CEILING PLAN
SCALE: 1"=16'-0"

PLAN NORTH

- GENERAL NOTES**
- CONTRACTOR SHALL BE REQUIRED TO CORE DRILL ALL HOLES IN WALLS, FLOORS AND CEILINGS TO FACILITATE NEW LINESETS, ELECTRICAL CONDUITS AND CONDENSATE LINES.
 - EXT'D CLG. TILE SHALL BE REMOVED AS REQ'D. TO ALLOW INSTALLATION AND REMOVAL OF HVAC DEVICES, LINESETS, AND ELECTRICAL. AS REQ'D FOR THIS WORK. REINSTALLATION OF ALL CLG'S AS REQ'D. COORDINATE WITH MECHANICAL DRAWINGS.
 - FIRE ALARM DEVICES, SECURITY CAMERA, AND OTHER CEILING MOUNTED DEVICES TO BE REMOVED, TEMPORARILY STORED AND RE-INSTALLED AS REQ'D.

— EXISTING THROUGH WALL LOUVER	□ NEW RELIEF VENT ENCLOSURE
☒ SUPPLY REGISTER	□ 2' x 2' SUSPENDED CLG GRID
☒ EXISTING SUPPLY REGISTER	□ 2' x 2' RECESSED LIGHT
▨ NEW UNIT VENT UV-00	□ RETURN
▨ NEW FAN COIL UNIT FC-00	□ CEILING ACCESS PANEL
▨ NEW CEILING CASSETTE CC-00	⊕ X'-X" CEILING ELEVATION
	□ EXHAUST

LEGEND



No.	Date	Revisions
0	03-04-25	BIDDING DOCUMENTS

REG. EXP DATE: 12-31-25

Drawn by	JR/SP/OG
Checked by	MS/JC
Project No.	43041
Scale	AS NOTED
Date	03-18-24

Mechanical & Electrical Engineer:	GREENMAN PEDERSEN, INC 400 BELLA BOULEVARD MONTEBELLO, NY 10901
Structural Engineer:	GREENMAN PEDERSEN, INC 400 BELLA BOULEVARD MONTEBELLO, NY 10901

UNIVENT REPLACEMENT AT
STONY POINT, THIELLS
AND WEST HAVERSTRAW
ELEMENTARY SCHOOL
SPES SED# 50-02-01-06-0-014-012
TES SED# 50-02-01-06-0-025-018
WHES SED# 50-02-01-06-0-024-015
7 GURNEE DRIVE
STONY POINT, NY 10980
COUNTY OF ROCKLAND

HSA
MICHAEL SHILALE ARCHITECTS, L.L.P.
140 Park Avenue New City, NY 10856 Tel 845-708-9200
www.mshlak.com

Drawing Title
**PROPOSED
FIRST FLOOR
RCP**

Drawing No.
SPES-A-401

IT IS A VIOLATION OF THE LAW FOR ANY PERSON, UNLESS ACTING UNDER THE DIRECTION OF A LICENSED ARCHITECT, TO ALTER AN ITEM IN ANY WAY.

A40

VOID.

A41

VOID

A42

INSTALL NEW 2X2 SUSPENDED ACT-1 CEILING. NEW CEILING HEIGHT TO MATCH EXISTING.

A43

INSTALL NEW 2X2 RECESSED LIGHTING IN NEW CEILING GRID.


A44

BASE BID: MODIFY AND REINSTALL EXISTING ACT CEILING/CEILING, CEILING LIGHTS FOR NEW HVAC EQUIPMENT AND REFRIGERANT PIPING AS REQUIRED.
ALTERNATE-100: REPLACE EXISTING CEILING/CEILING TILE, GRID AND LIGHTING WITH NEW ACT-1 AND LIGHTING

A45

NEW RTU ABOVE TO INFILL EXISTING SKYLIGHT OPENING. SEE PLANS SPES-A-103, SPES-S-101, AND SPES-M-106.

KEY NOTES

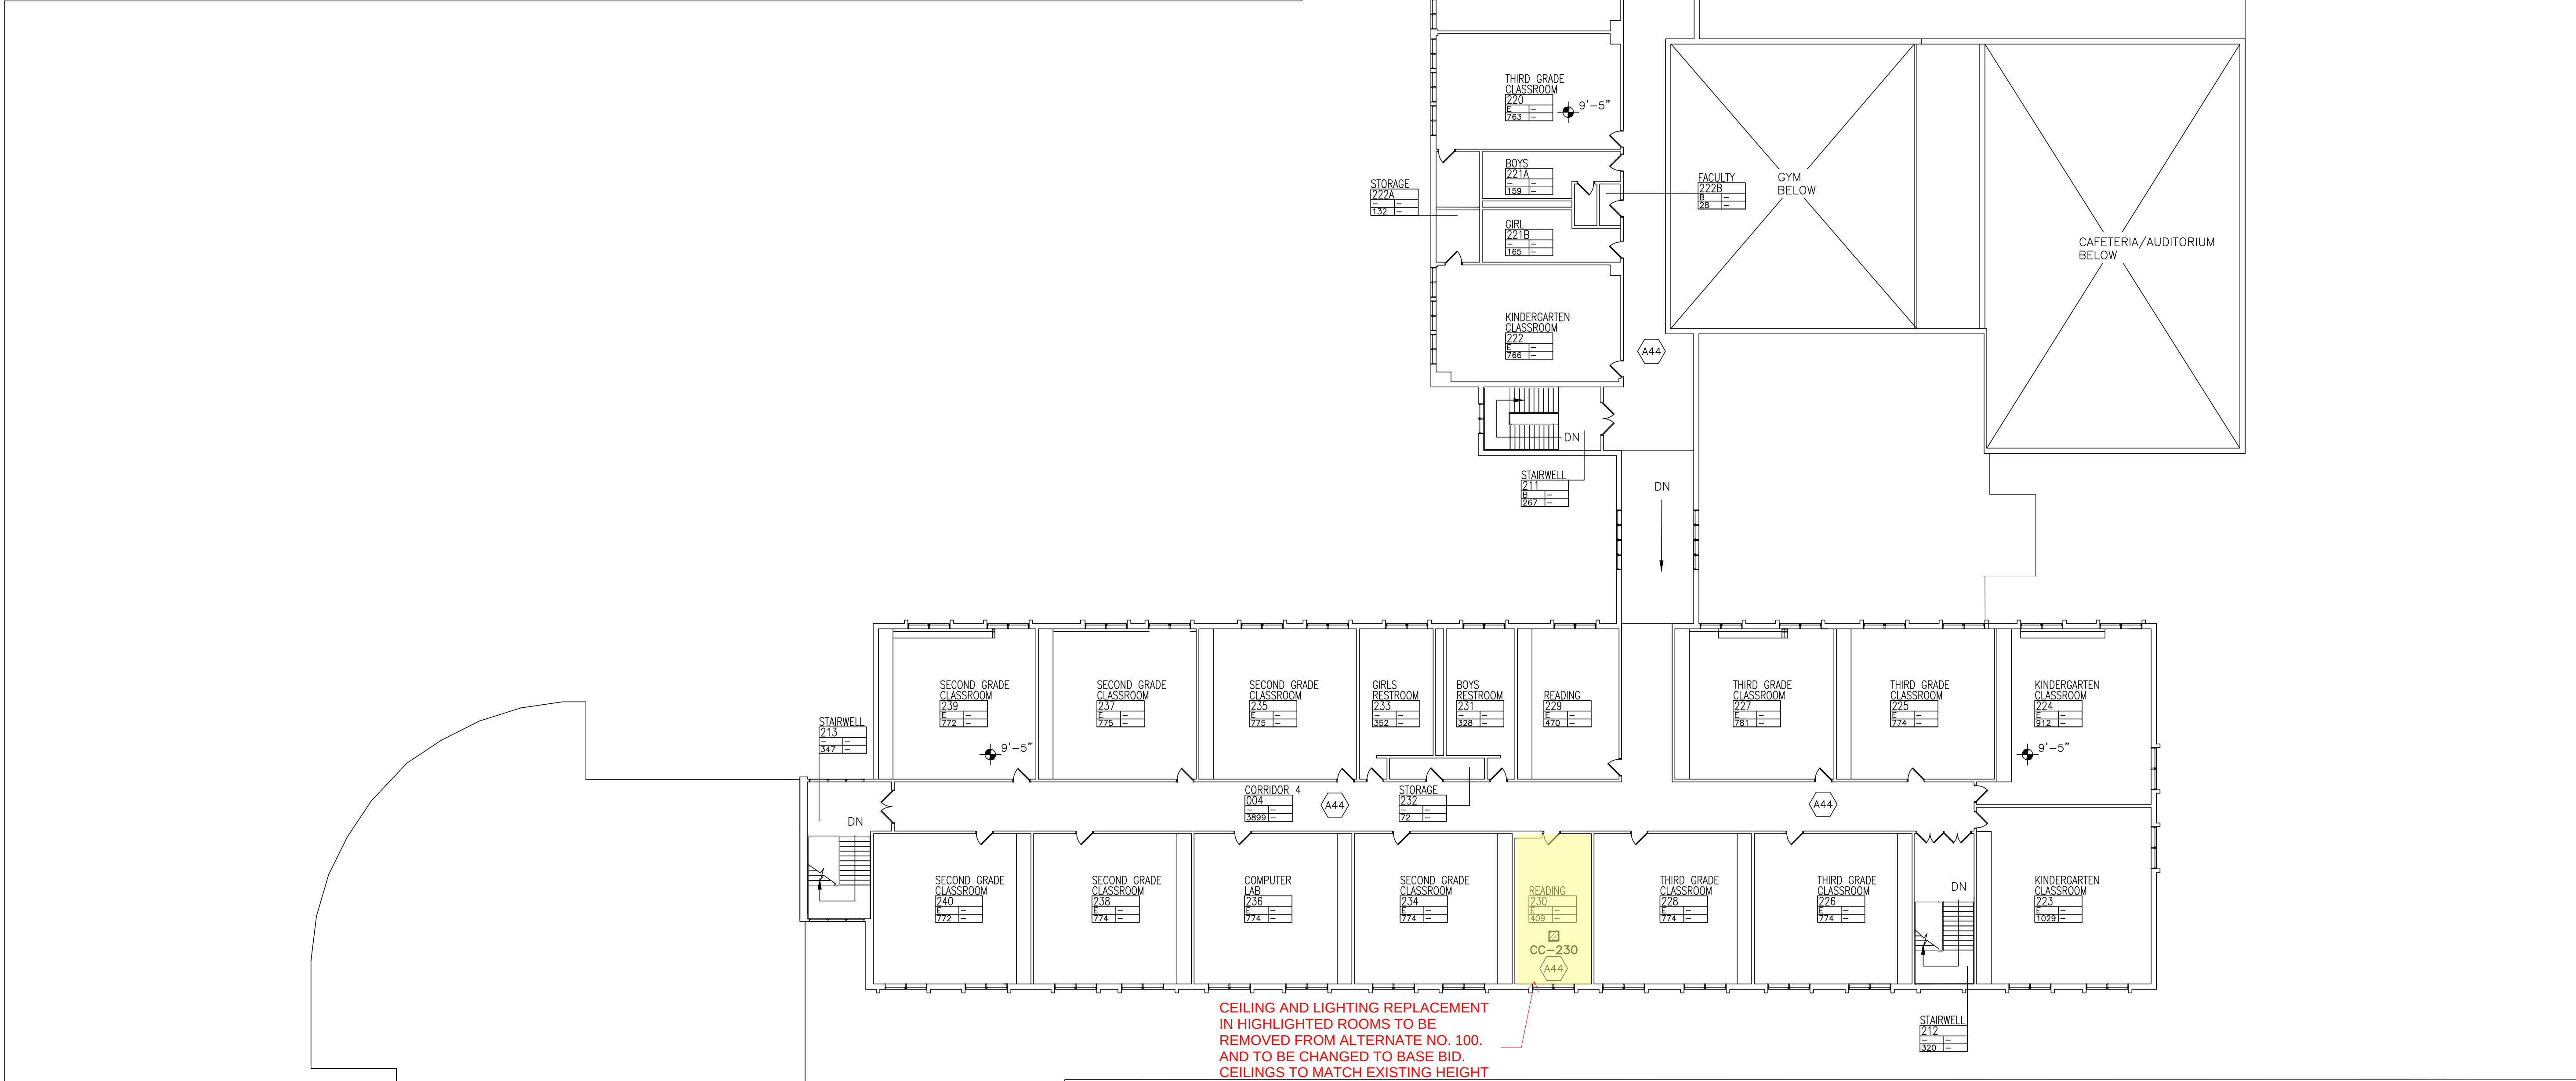

1

PROPOSED SECOND FLOOR REFLECTED CEILING PLAN

SCALE: 1/16"=1'-0"

PLAN NORTH

1. CONTRACTOR SHALL BE REQUIRED TO CORE DRILL ALL HOLES IN WALLS, FLOORS AND CEILINGS TO FACILITATE NEW LINESETS, ELECTRICAL CONDUITS AND CONDENSATE LINES.

2. EXT'G CLG. TILE SHALL BE REMOVED AS REQ'D. TO ALLOW INSTALLATION AND REMOVAL OF HVAC DEVICES, LINESETS, AND ELECTRICAL, AS REQ'D FOR THIS WORK. REINSTALLATION OF ALL CLG'S AS REQ'D. COORDINATE WITH MECHANICAL DRAWINGS.

3. FIRE ALARM DEVICES, SECURITY CAMERA, AND OTHER CEILING MOUNTED DEVICES TO BE REMOVED, TEMPORARILY STORED AND RE-INSTALLED AS REQ'D.

—

EXISTING THROUGH WALL LOUVER

☒

SUPPLY REGISTER

☒

EXISTING SUPPLY REGISTER

NEW UNIT VENT
UV-00

NEW FAN COIL UNIT
FC-00

☒

NEW CEILING CASSETTE
CC-00

RA

NEW RELIEF VENT ENCLOSURE

2' x 2' SUSPENDED CLG GRID

A

2' x 2' RECESSED LIGHT

☒

RETURN

☒

CEILING ACCESS PANEL

X'-X"

CEILING ELEVATION

EXHAUST

LEGEND

GENERAL NOTES

Drawn by	JR/SP/CG
Checked by	MS/JC
Project No.	43041
Scale	AS NOTED
Date	03-18-24

Mechanical & Electrical Engineer:	GREENMAN PEDERSEN, INC 400 BELLA BOULEVARD MONTEBELLO, NY 10901
Structural Engineer:	GREENMAN PEDERSEN, INC 400 BELLA BOULEVARD MONTEBELLO, NY 10901

UNIVENT REPLACEMENT AT
STONY POINT, THIELLS
AND WEST HAVERSTRAW
ELEMENTARY SCHOOL

SPES SED# 50-02-01-08-0-014-012
YES SED# 50-02-01-06-0-025-018
WHES SED# 50-02-01-06-0-024-015

7 GUNNE DRIVE
STONY POINT, NY 10980

COUNTY OF ROCKLAND

 
MSA

MICHAEL SHILALE ARCHITECTS, L.L.P.
140 Park Avenue New York, NY 10022 Tel 945-706-6200
info@shilale.com

Proposed
SECOND FLOOR
RCP PLAN

SPES-A-402

© COPYRIGHT, MICHAEL SHILALE ARCHITECTS LLP. ALL RIGHTS RESERVED. IT IS A VIOLATION OF THE LAW FOR ANY PERSON, UNLESS ACTING UNDER THE DIRECTION OF A LICENSED ARCHITECT, TO ALTER AN ITEM IN ANY WAY.


	EXISTING THROUGH WALL LOUVER		NEW RELIEF VENT ENCLOSURE
	SUPPLY REGISTER		2' x 2' SUSPENDED CLG GRID
	EXISTING SUPPLY REGISTER		2' x 2' RECESSED LIGHT
	NEW UNIT VENT UV-00		RETURN
	NEW FAN COIL UNIT FC-00		CEILING ACCESS PANEL
	NEW CEILING CASSETTE CC-00		CEILING ELEVATION
			EXHAUST

LEGEND

A40	VOID.
A41	VOID
A42	INSTALL NEW 2X2 SUSPENDED ACT-1 CEILING. NEW CEILING HEIGHT TO MATCH EXISTING.
A43	INSTALL NEW 2X2 RECESSED LIGHTING IN NEW CEILING GRID.
A44	<u>BASE BID:</u> MODIFY AND REINSTALL EXISTING ACT CEILING/CEILING, CEILING LIGHTS FOR NEW HVAC EQUIPMENT AND REFRIGERANT PIPING AS REQUIRED. <u>ALTERNATE-200:</u> REPLACE EXISTING CEILING/CEILING TILE, GRID AND LIGHTING WITH NEW ACT-1 AND LIGHTING

1. CONTRACTOR SHALL BE REQUIRED TO CORE DRILL ALL HOLES IN WALLS, FLOORS AND CEILINGS TO FACILITATE NEW LINESETS, ELECTRICAL CONDUITS AND CONDENSATE LINES.
2. EXT'G CLG. TILE SHALL BE REMOVED AS REQ'D. TO ALLOW INSTALLATION AND REMOVAL OF HVAC DEVICES, LINESETS, AND ELECTRICAL, AS REQ'D FOR THIS WORK. REINSTALLATION OF ALL CLG'S AS REQ'D. COORDINATE WITH MECHANICAL DRAWINGS.
3. FIRE ALARM DEVICES, SECURITY CAMERA, AND OTHER CEILING MOUNTED DEVICES TO BE REMOVED, TEMPORARILY STORED AND RE-INSTALLED AS REQ'D.

GENERAL NOTES

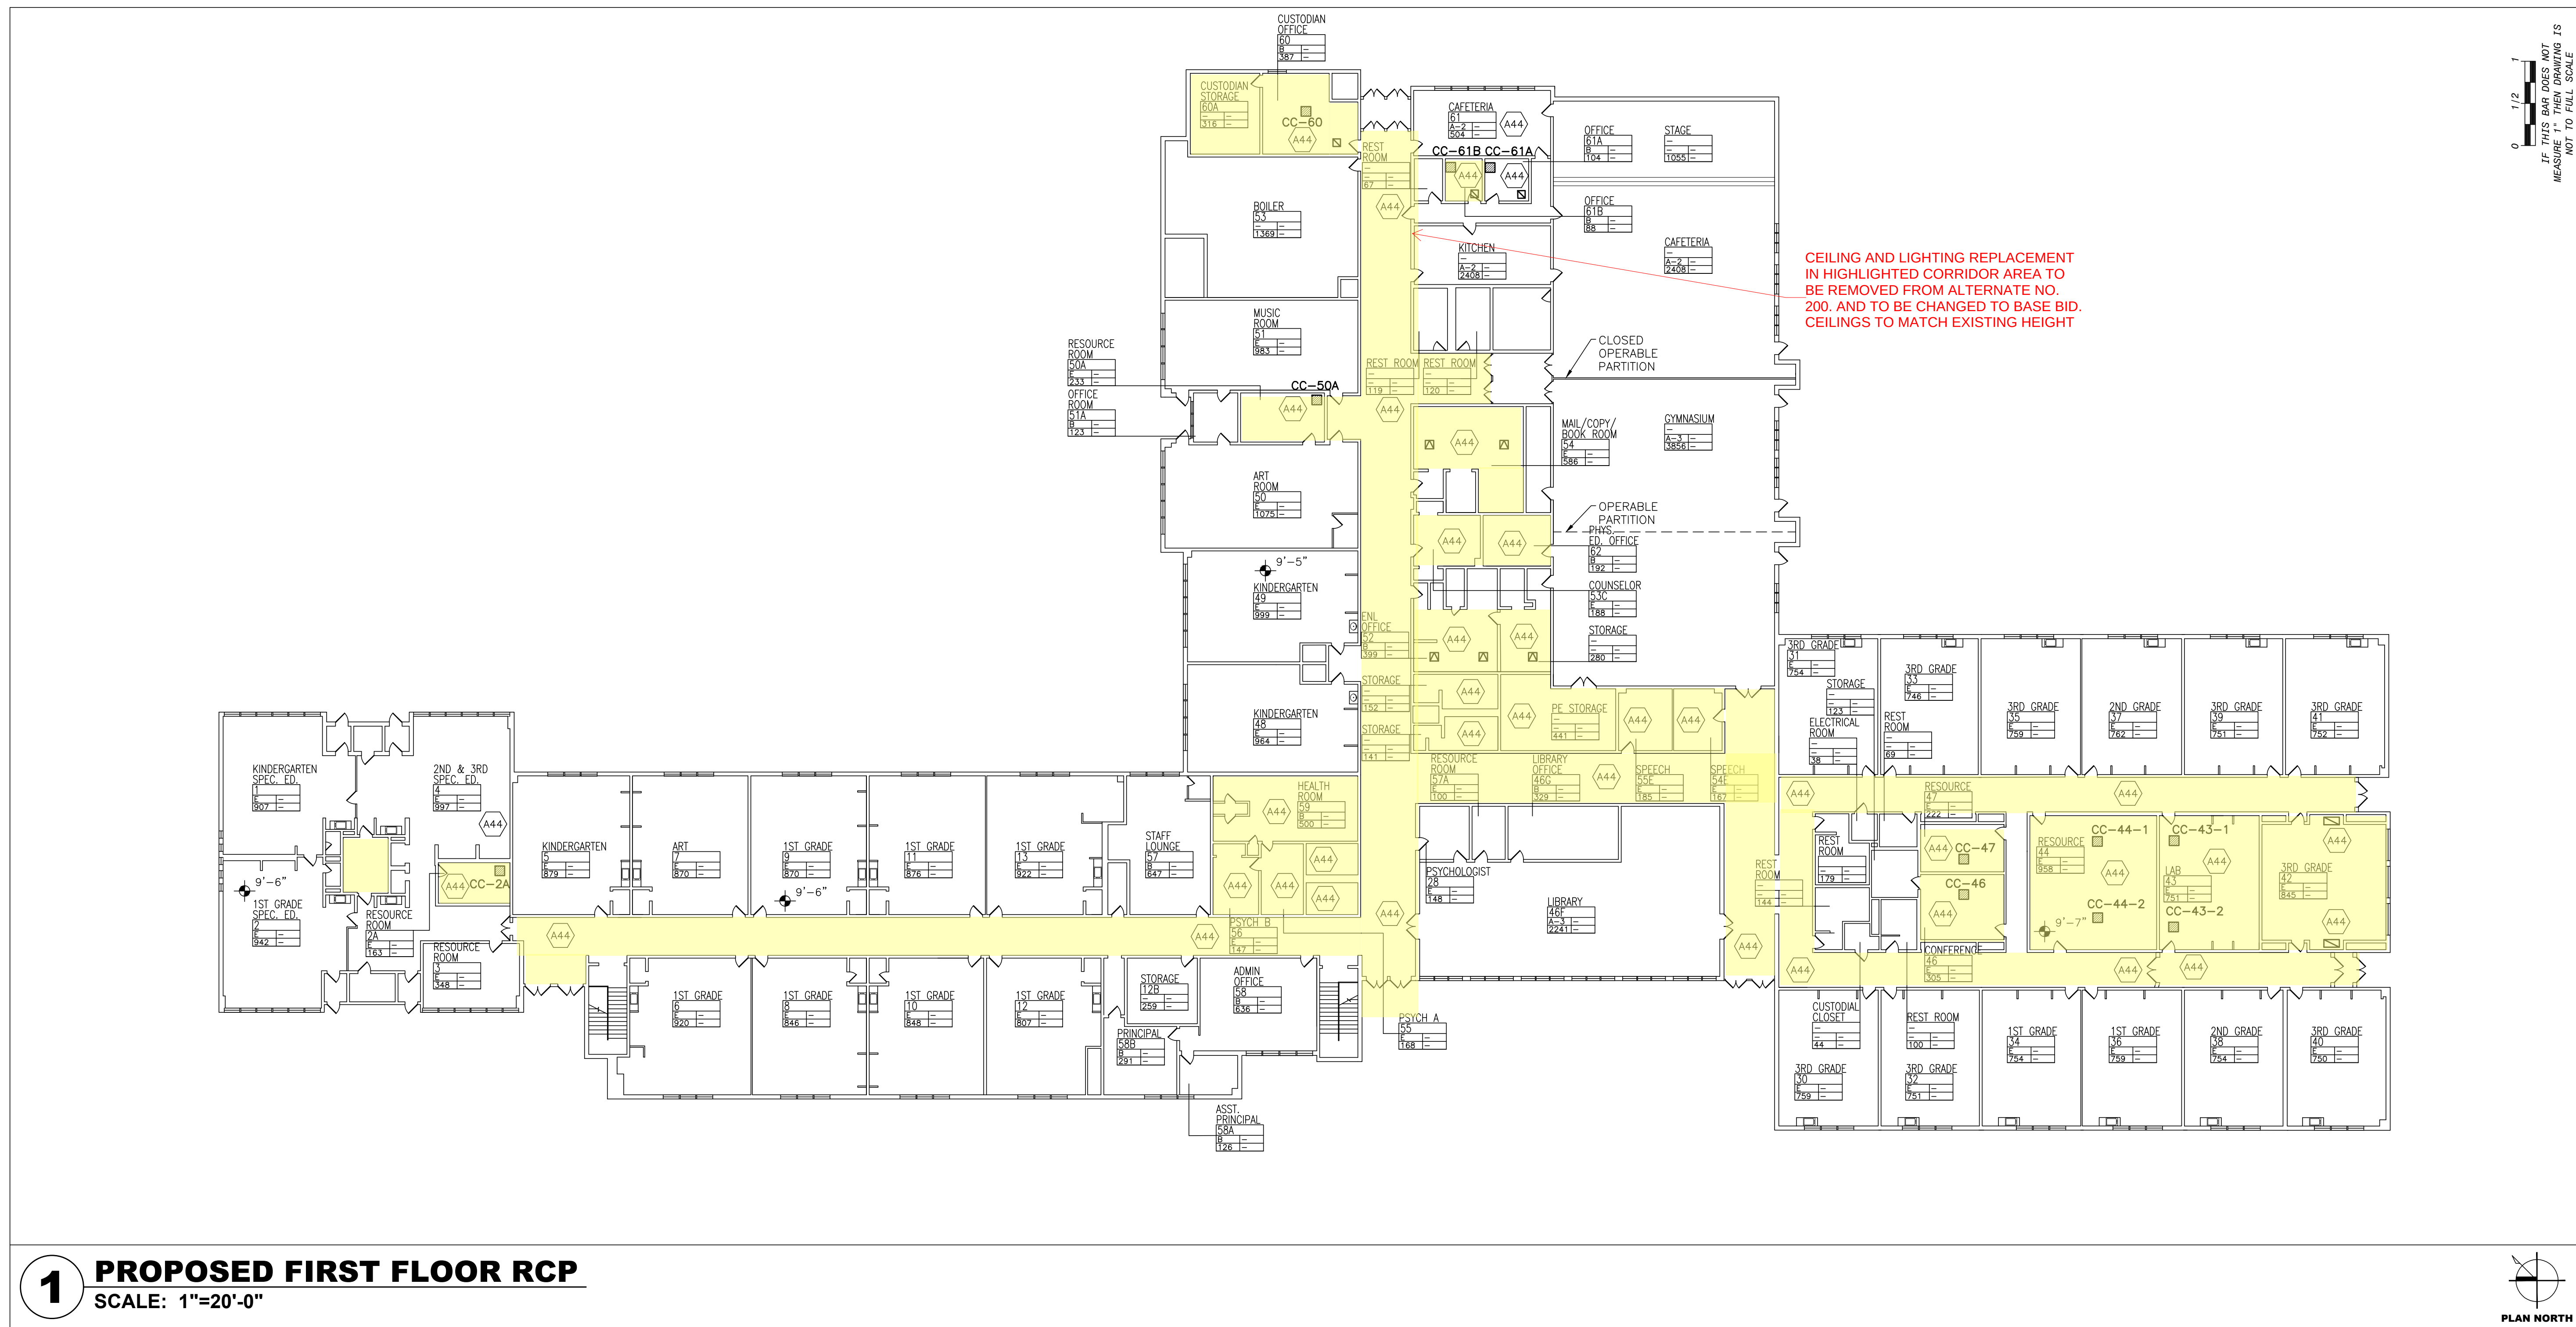

—

EXISTING THROUGH WALL LOUVER

☒

SUPPLY REGISTER

☒

EXISTING SUPPLY REGISTER

NEW UNIT VENT
UV-00

NEW FAN COIL UNIT
FC-00

NEW CEILING CASSETTE
CC-00

RA

NEW RELIEF VENT ENCLOSURE

2' x 2' SUSPENDED CLG GRID

A

2' X 2' RECESSED LIGHT

RETURN

CEILING ACCESS PANEL

X'-X"

CEILING ELEVATION

EXHAUST

LEGEND

(A40)

VOID.

(A41)

VOID

(A42)

INSTALL NEW 2X2 SUSPENDED ACT-1 CEILING. NEW CEILING HEIGHT TO MATCH EXISTING.

(A43)

INSTALL NEW 2X2 RECESSED LIGHTING IN NEW CEILING GRID.

(A44)

BASE BID: MODIFY AND REINSTALL EXISTING ACT CEILING/CEILING, CEILING LIGHTS FOR NEW HVAC EQUIPMENT AND REFRIGERANT PIPING AS REQUIRED.
ALTERNATE-200: REPLACE EXISTING CEILING/CEILING TILE, GRID AND LIGHTING WITH NEW ACT-1 AND LIGHTING


KEY NOTES

1. CONTRACTOR SHALL BE REQUIRED TO CORE DRILL ALL HOLES IN WALLS, FLOORS AND CEILINGS TO FACILITATE NEW LINESETS, ELECTRICAL CONDUITS AND CONDENSATE LINES.

2. EXT'G CLG. TILE SHALL BE REMOVED AS REQ'D. TO ALLOW INSTALLATION AND REMOVAL OF HVAC DEVICES, LINESETS, AND ELECTRICAL, AS REQ'D FOR THIS WORK. REINSTALLATION OF ALL CLG'S AS REQ'D. COORDINATE WITH MECHANICAL DRAWINGS.

3. FIRE ALARM DEVICES, SECURITY CAMERA, AND OTHER CEILING MOUNTED DEVICES TO BE REMOVED, TEMPORARILY STORED AND RE-INSTALLED AS REQ'D.

GENERAL NOTES

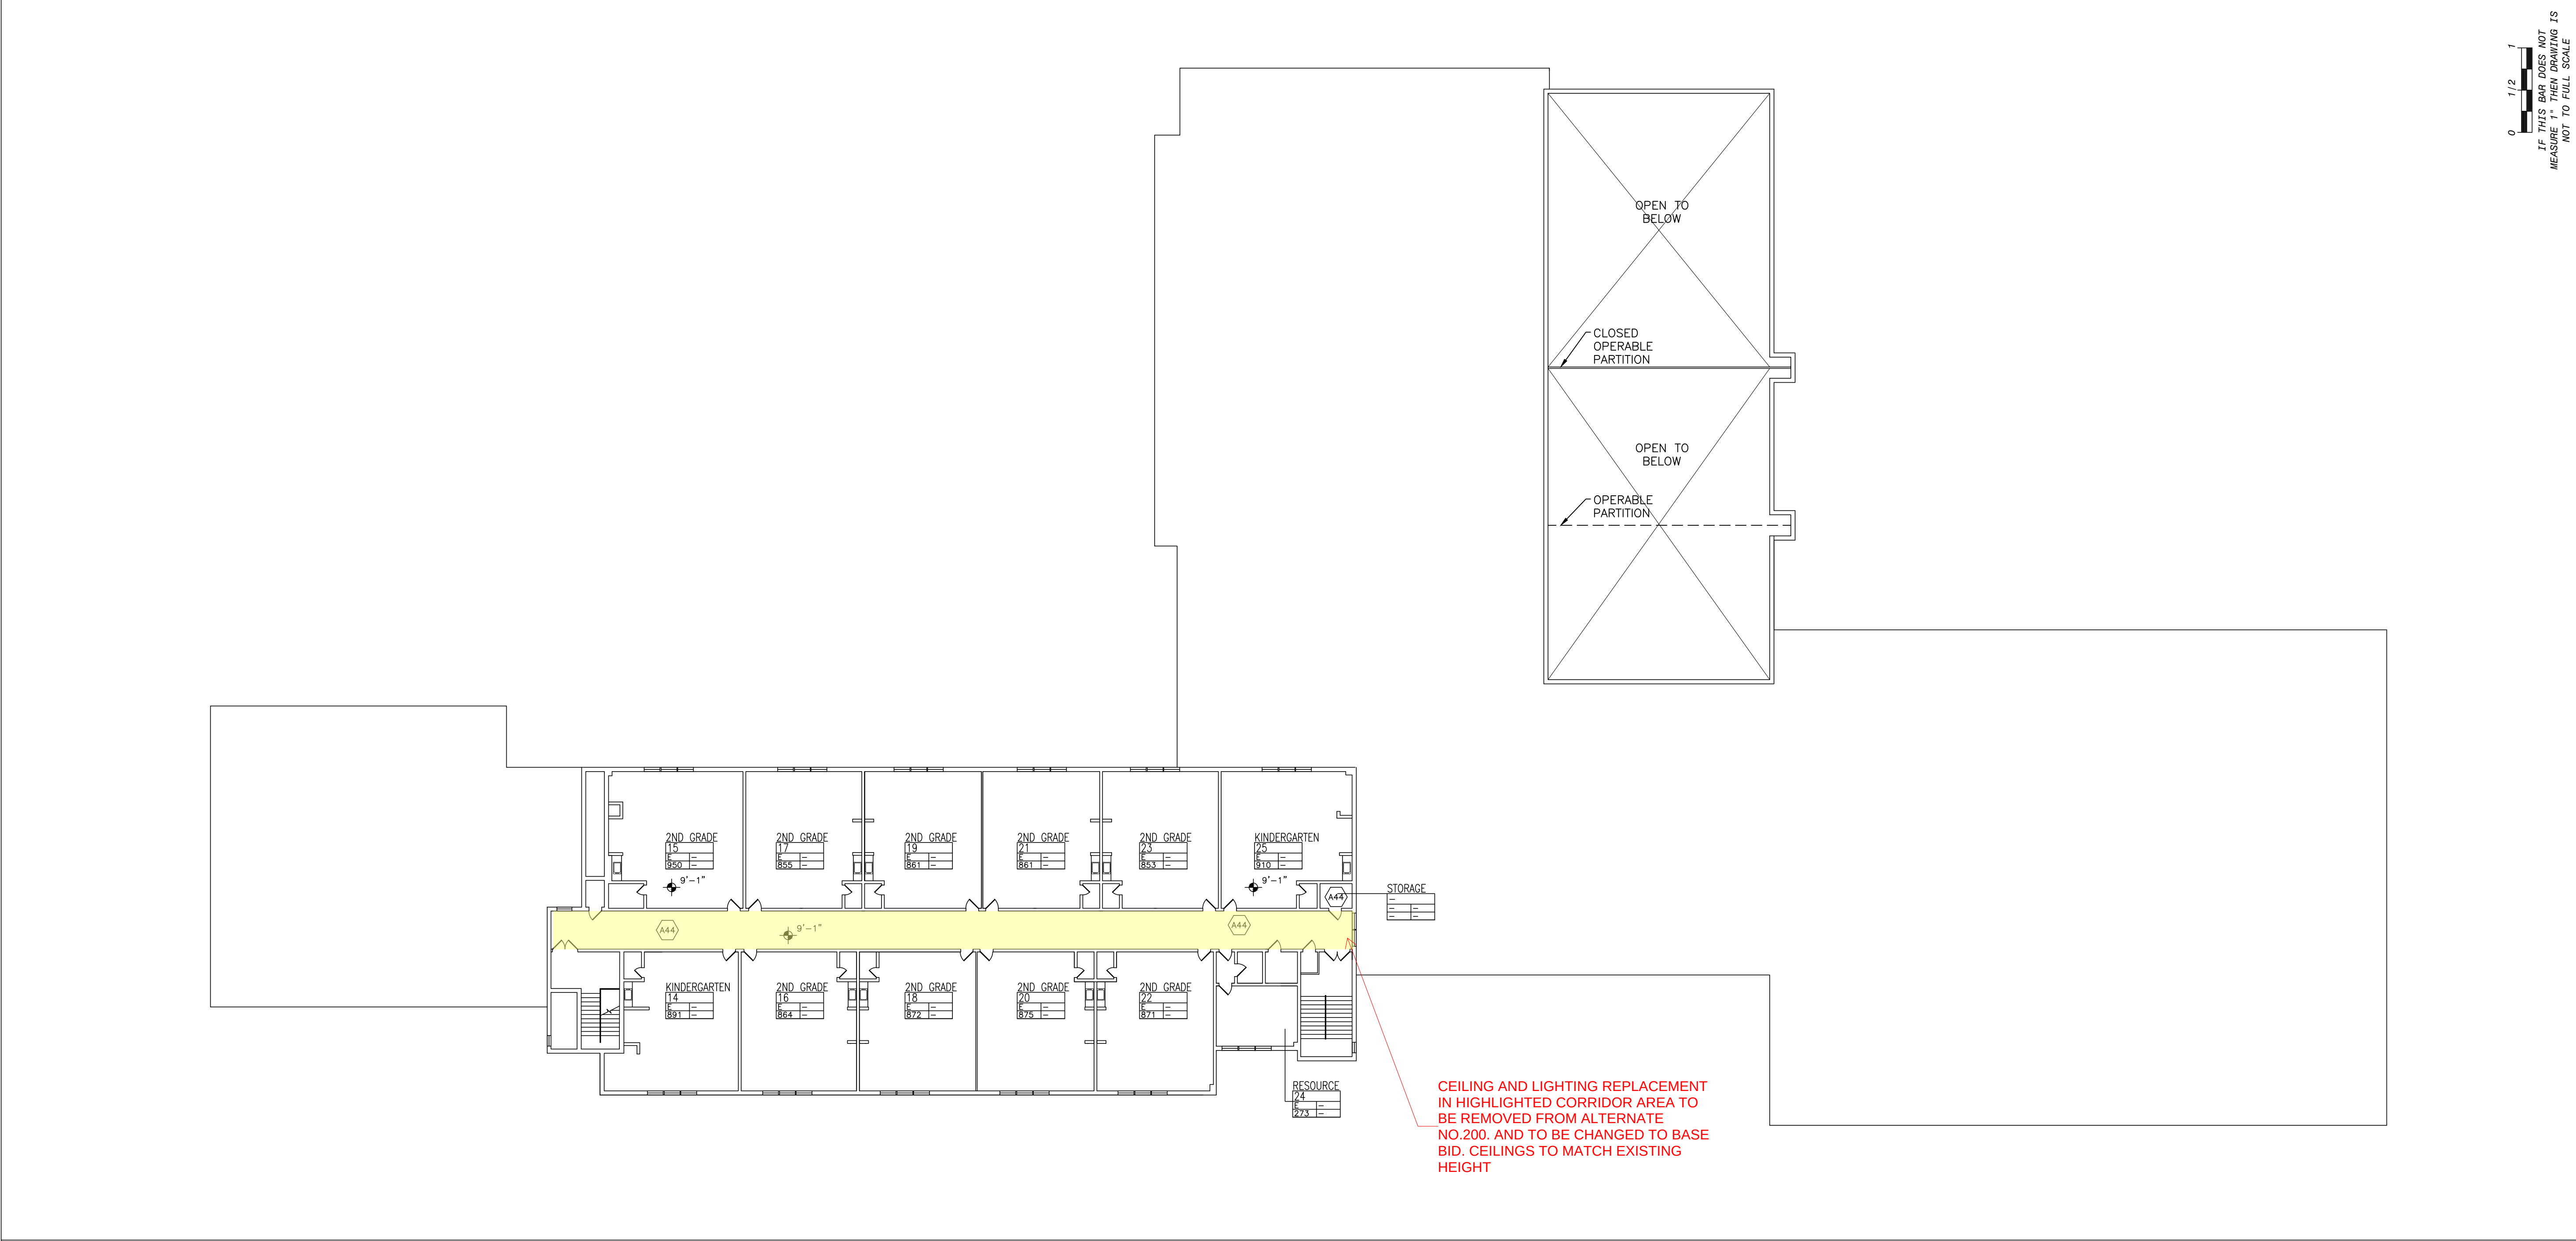

1

PROPOSED SECOND FLOOR REFLECTED CEILING PLAN

SCALE: 1"=20'-0"



IT IS A VIOLATION OF THE LAW FOR ANY PERSON, UNLESS ACTING UNDER THE DIRECTION OF A LICENSED ARCHITECT, TO ALTER AN ITEM IN ANY WAY.
IF THIS BAR DOES NOT MEASURE 1" THEN DRAWING IS NOT TO FULL SCALE

0 1/2 1

0 1/2 1

Drawn by JR

Checked by MS/JC

Project No.

Scale

Date

GREENMAN PEDERSEN, INC
400 BELLA BOULEVARD
MONTEBELLO, NY 10901

GREENMAN PEDERSEN, INC
400 BELLA BOULEVARD
MONTEBELLO, NY 10901

UNIVENT REPLACEMENT AT
STONY POINT, THIELLS
AND WEST HAVERSTRAW
ELEMENTARY SCHOOL

SPES SED# 50-02-01-08-0-014-012
TES SED# 50-02-01-08-0-025-018
WHES SED# 50-02-01-08-0-024-015
7 CURRIER DRIVE
STONY POINT, NY 10980
COUNTY OF ROCKLAND

MSA

MICHAEL SHILALE ARCHITECTS, L.L.P.
140 Park Avenue New York, NY 10022 Tel 914-706-6200
www.shilale.com

© COPYRIGHT, MICHAEL SHILALE ARCHITECTS LLP. ALL RIGHTS RESERVED.

PROPOSED
SECOND FLOOR
RCP PLAN

Drawing Title

TES-A-402

Drawing No.

03-04-25

Revisions

0

No.

03-04-25

Date

REG. EXP. DATE: 12-31-25

No.

	EXISTING THROUGH WALL LOUVER		NEW RELIEF VENT ENCLOSURE
	SUPPLY REGISTER		2' x 2' SUSPENDED CLG GRID
	EXISTING SUPPLY REGISTER		2' x 2' RECESSED LIGHT
	NEW UNIT VENT		RETURN
	NEW FAN COIL UNIT		CEILING ACCESS PANEL
	NEW CEILING CASSETTE		CEILING ELEVATION
	CC-00		EXHAUST


LEGEND

	VOID.
	VOID
	INSTALL NEW 2X2 SUSPENDED ACT-1 CEILING. NEW CEILING HEIGHT TO MATCH EXISTING.
	INSTALL NEW 2X2 RECESSED LIGHTING IN NEW CEILING GRID.
	BASE BID: MODIFY AND REINSTALL EXISTING ACT CEILING/CEILING, CEILING LIGHTS FOR NEW HVAC EQUIPMENT AND REFRIGERANT PIPING AS REQUIRED. ALTERNATE-300: REPLACE EXISTING CEILING/CEILING TILE, GRID AND LIGHTING WITH NEW ACT-1 AND LIGHTING

KEY NOTES

1.	CONTRACTOR SHALL BE REQUIRED TO CORE DRILL ALL HOLES IN WALLS, FLOORS AND CEILINGS TO FACILITATE NEW LINESETS, ELECTRICAL CONDUITS AND CONDENSATE LINES.
2.	EXT'G CLG. TILE SHALL BE REMOVED AS REQ'D. TO ALLOW INSTALLATION AND REMOVAL OF HVAC DEVICES, LINESETS, AND ELECTRICAL, AS REQ'D FOR THIS WORK. REINSTALLATION OF ALL CLG'S AS REQ'D. COORDINATE WITH MECHANICAL DRAWINGS.
3.	FIRE ALARM DEVICES, SECURITY CAMERA, AND OTHER CEILING MOUNTED DEVICES TO BE REMOVED, TEMPORARILY STORED AND RE-INSTALLED AS REQ'D.

GENERAL NOTES

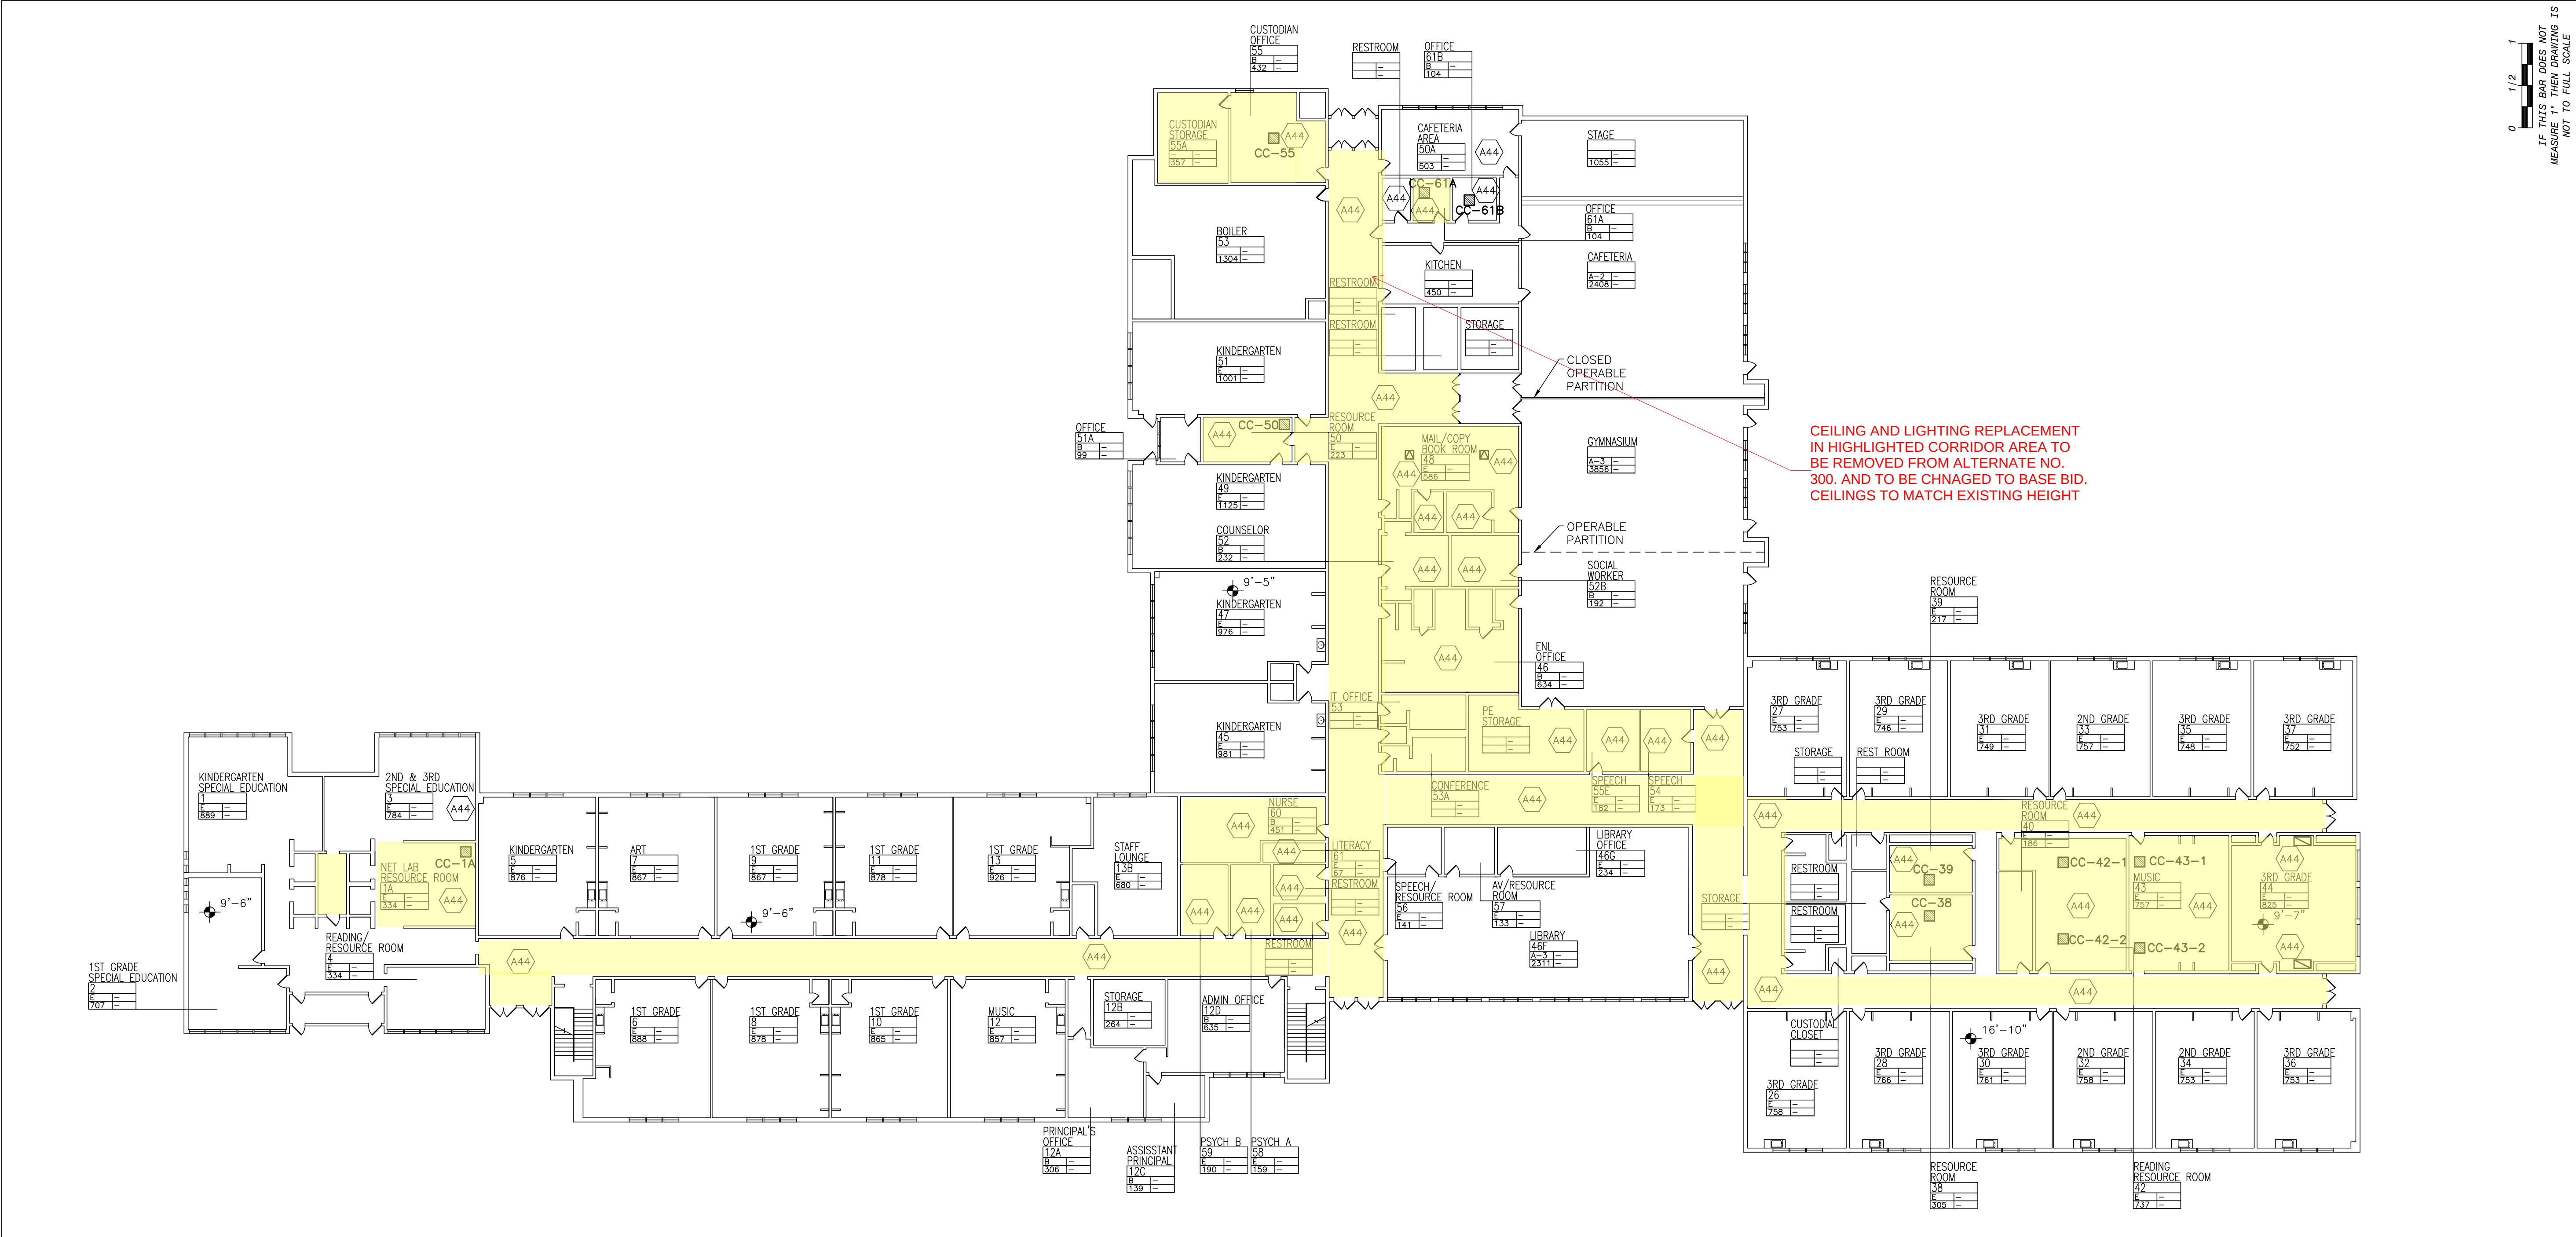

1

PROPOSED FIRST FLOOR RCP

SCALE: 1"=20'-0"



© COPYRIGHT, MICHAEL SHUALE ARCHITECTS LLP, ALL RIGHTS RESERVED.

PROPOSED

FIRST FLOOR

RCP

Drawing No.

WHES-A-401

MICHAEL SHUALE ARCHITECTS, LLP
140 Park Avenue New York, NY 10066 Tel 845-709-9200
www.shuale.com

UNIVENT REPLACEMENT AT
STONY POINT, THIELLS
AND WEST HAVERSTRAW
ELEMENTARY SCHOOL

SPES SBD# 50-02-01-06-0-014-012
TES SBD# 50-02-01-06-0-025-018
WHES SBD# 50-02-01-06-0-024-015

COUNTY OF ROCKLAND

Mechanical & Electrical Engineer:	GREENMAN PEDERSEN, INC 400 BELLA BOULEVARD ROCKLAND, NY 10861
Structural Engineer:	GREENMAN PEDERSEN, INC 400 BELLA BOULEVARD ROCKLAND, NY 10861

Drawn by	JR
Checked by	MS/JC
Project No.	43041
Scale	AS NOTED
Date	03-18-24

0	03-04-25 BIDDING DOCUMENTS	No.	Date	Revisions
REG. EXP. DATE: 12-31-25				

0 1/2 1
IF THIS BID DOES NOT
MEASURE 1" THEN DRAWING IS
NOT TO FULL SCALE

IT IS A VIOLATION OF THE LAW FOR ANY PERSON, UNLESS ACTING UNDER THE DIRECTION OF A LICENSED ARCHITECT, TO ALTER AN ITEM IN ANY WAY.

THROUGH WALL LOUVER

NEW UNIT VENT

UV-00

NEW FAN COIL UNIT

FC-00

NEW CEILING CASSETTE

CC-00

LF

LE

LINEAR FEET OF LINE
SET ENCLOSURE

FLOOR PATCHING TO MATCH
EXISTING PATTERN

SUPPLY REGISTER

RETURN

ACCESS PANEL

LEGEND

A1

INSTALL NEW UNIT VENTILATOR (UV). SEE MECHANICAL DRAWINGS

A2

VOID.

A3

INSTALL NEW AIR HANDLER UNIT (AHU). SEE MECHANICAL DRAWINGS

A4

INSTALL NEW CEILING CASSETTES (CC). SEE MECHANICAL DRAWINGS

A5

INSTALL NEW SUPPLY/RETURN DIFFUSER AND REPLACE CEILING TILES WHERE REQUIRED. SEE MECHANICAL DRAWINGS FOR LOCATION OF DIFFUSERS.

A7

PATCH FLOOR AS REQUIRED WHERE HVAC UNIT WAS REMOVED.

A8

PATCH SOFFIT WHERE LOUVER WAS REMOVED AND MATCH FINISH TO EXISTING.

A9

PROVIDE NEW LOUVER L-1. SEE MECHANICAL DRAWINGS

A10

PATCH EXISTING FLOOR AND WALL WHERE EXISTING UV IS REMOVED

A11

VOID

A12

PROVIDE METAL LINE SET ENCLOSURES AS PER DETAIL 1/A-610. COORDINATE WITH MECHANICAL DRAWINGS FOR LOCATIONS.

KEY NOTES

1. CONTRACTOR SHALL BE REQUIRED TO CORE DRILL ALL HOLES IN WALLS, FLOORS AND CEILINGS TO FACILITATE NEW LINESETS, ELECTRICAL CONDUITS AND CONDENSATE LINES.

2. PATCH EXISTING VCT FLOORING AT BASE UNDER UNI-VENT TO MATCH EXIST. AS REQ'D.

3. PATCH EXISTING PLASTER/GYPSUM AT ALL UV LOCATIONS TO MATCH EXIST. AS REQ'D.

4. EXT'G CLG. TILE SHALL BE REMOVED AS REQ'D. TO ALLOW INSTALLATION AND REMOVAL OF HVAC DEVICES, LINESETS, AND ELECTRICAL, AS REQ'D FOR THIS WORK. REINSTALLATION OF ALL CLG'S AS REQ'D. COORDINATE WITH MECHANICAL DRAWINGS. COORDINATE WITH A-400 SERIES DRAWINGS; REFLECTED CEILING PLANS.

5. FIRE ALARM DEVICES TO BE REMOVED, TEMPORARILY STORED AND RE-INSTALLED AS REQ'D.

6. PROVIDE SPLASH BLOCKS AT ALL UV'S IN FIRST FLOOR.

GENERAL NOTES

0

1/2

7

IF THIS BAR DOES NOT
MEASURE 1" THEN DRAWING IS
NOT TO FULL SCALE

IT IS A VIOLATION OF THE LAW FOR ANY PERSON, UNLESS ACTING UNDER THE DIRECTION OF A LICENSED ARCHITECT, TO ALTER AN ITEM IN ANY WAY.

Drawn by
JR

Checked by
MS/JC

Project No.
43042

Scale

Date
03-04-25

GREENMAN
PEDERSEN, INC
MECHANICAL & ELECTRICAL
ENGINEER
MONTBELLO, NY 10801

GREENMAN
PEDERSEN, INC
STRUCTURAL
ENGINEER
MONTBELLO, NY 10801

UNIVENT REPLACEMENT AT
STONY POINT, THIELS
AND WEST HAVERSTRAW
ELEMENTARY SCHOOL

SPES SED# 50-02-01-08-0-014-012
TES SED# 50-02-01-06-0-025-018
WHES SED# 50-02-01-00-0-024-015
COUNTY OF ROCKLAND
STONY POINT, NY 10980

© COPYRIGHT, MICHAEL SHILALE ARCHITECTS LLP, ALL RIGHTS RESERVED.

Drawing Title
**PROPOSED
FIRST FLOOR
PLAN**

Drawing No.
TES-A-101

UV-1

A12 A1

KINDERGARTEN
SPEC. ED.

807

15LFL

LE

UV-2

A12 A1

1ST GRADE
SPEC. ED.

842

6LFL

LE

UV-3

A12 A1

RESOURCE ROOM
2A

163

6LFL

LE

UV-4

A12 A1 A9

2ND & 3RD
SPEC. ED.

897

6LFL

LE

UV-5

A12 A1

KINDERGARTEN

879

10LFL

LE

UV-7

A1 A12

ART

870

10LFL

LE

UV-9

A1 A12

1ST GRADE

870

10LFL

LE

UV-11

A1 A12

1ST GRADE

876

10LFL

LE

UV-13

A12 A1

1ST GRADE

822

10LFL

LE

UV-17

A12 A1

1ST GRADE

848

10LFL

LE

UV-19

A1 A12

1ST GRADE

848

10LFL

LE

UV-21

A1 A12

1ST GRADE

848

10LFL

LE

UV-23

A12 A1

1ST GRADE

807

10LFL

LE

UV-25

A12 A1

1ST GRADE

827

10LFL

LE

UV-27

A12 A1

1ST GRADE

848

10LFL

LE

UV-29

A12 A1

1ST GRADE

848

10LFL

LE

UV-31

A12 A1

1ST GRADE

848

10LFL

LE

UV-33

A12 A1

1ST GRADE

848

10LFL

LE

UV-35

A12 A1

1ST GRADE

848

10LFL

LE

UV-37

A12 A1

1ST GRADE

848

10LFL

LE

UV-39

A12 A1

1ST GRADE

848

10LFL

LE

UV-41

A12 A1

1ST GRADE

848

10LFL

LE

UV-43

A12 A1

1ST GRADE

848

10LFL

LE

UV-45

A12 A1

1ST GRADE

848

10LFL

LE

UV-47

A12 A1

1ST GRADE

848

10LFL

LE

UV-49

A12 A1

1ST GRADE

848

10LFL

LE

UV-51

A12 A1

1ST GRADE

848

10LFL

LE

UV-53

A12 A1

1ST GRADE

848

10LFL

LE

UV-55

A12 A1

1ST GRADE

848

10LFL

LE

UV-57

A12 A1

1ST GRADE

848

10LFL

LE

UV-59

A12 A1

1ST GRADE

848

10LFL

LE

UV-61

A12 A1

1ST GRADE

848

10LFL

LE

UV-63

A12 A1

1ST GRADE

848

10LFL

LE

UV-65

A12 A1

1ST GRADE

848

10LFL

LE

UV-67

A12 A1

1ST GRADE

848

10LFL

LE

UV-69

A12 A1

1ST GRADE

848

10LFL

LE

UV-71

A12 A1

1ST GRADE

848

10LFL

LE

UV-73

A12 A1

1ST GRADE

848

10LFL

LE

UV-75

A12 A1

1ST GRADE

848

10LFL

LE

UV-77

A12 A1

1ST GRADE

848

10LFL

LE

UV-79

A12 A1

1ST GRADE

848

10LFL

LE

UV-81

A12 A1

1ST GRADE

848

10LFL

LE

UV-83

A12 A1

1ST GRADE

848

10LFL

LE

UV-85

A12 A1

1ST GRADE

848

10LFL

LE

UV-87

A12 A1

1ST GRADE

848

10LFL

LE

UV-89

A12 A1

1ST GRADE

848

10LFL

LE

UV-91

A12 A1

1ST GRADE

848

10LFL

LE

UV-93

A12 A1

1ST GRADE

848

10LFL

LE

UV-95

A12 A1

1ST GRADE

848

10LFL

LE

UV-97

A12 A1

1ST GRADE

848

10LFL

LE

UV-99

A12 A1

1ST GRADE

848

10LFL

LE

UV-101

A12 A1

1ST GRADE

848

10LFL

LE

UV-103

A12 A1

1ST GRADE

848

10LFL

LE

UV-105

A12 A1

1ST GRADE

848

10LFL

LE

UV-107

A12 A1

1ST GRADE

848

10LFL

LE

UV-109

A12 A1

1ST GRADE

848

10LFL

LE

UV-111

A12 A1

1ST GRADE

848

10LFL

LE

UV-113

A12 A1

1ST GRADE

848

10LFL

LE

UV-115

A12 A1

1ST GRADE

848

10LFL

LE

UV-117

A12 A1

1ST GRADE

848

10LFL

LE

UV-119

A12 A1

1ST GRADE

848

10LFL

LE

UV-121

A12 A1

1ST GRADE

848

10LFL

LE

UV-123

A12 A1

1ST GRADE

848

10LFL

LE

UV-125

A12 A1

1ST GRADE

848

10LFL

LE

UV-127

A12 A1

1ST GRADE

848

10LFL

LE

UV-129

A12 A1

1ST GRADE

848

10LFL

LE

UV-131

A12 A1

1ST GRADE

848

10LFL

LE

UV-133

A12 A1

1ST GRADE

848

10LFL

LE

UV-135

A12 A1

1ST GRADE

848

10LFL

LE

UV-137

A12 A1

1ST GRADE

848

10LFL

LE

UV-139

A12 A1

1ST GRADE

848

10LFL

LE

UV-141

A12 A1

1ST GRADE

848

10LFL

LE

UV-143

A12 A1

1ST GRADE

848

10LFL

LE

UV-145

A12 A1

1ST GRADE

848

10LFL

LE

UV-147

A12 A1

1ST GRADE

848

10LFL

LE

UV-149

A12 A1

1ST GRADE

848

10LFL

LE

UV-151

A12 A1

1ST GRADE

848

10LFL

LE

UV-153

A12 A1

1ST GRADE

848

10LFL

LE

UV-155

A12 A1

1ST GRADE

848

10LFL

LE

UV-157

A12 A1

1ST GRADE

848

10LFL

LE

UV-159

A12 A1

1ST GRADE

848

10LFL

LE

UV-161

A12 A1

1ST GRADE

848

10LFL

LE

UV-163

A12 A1

1ST GRADE

848

10LFL

LE

UV-165

A12 A1

1ST GRADE

848

10LFL

LE

UV-167

A12 A1

1ST GRADE

848

10LFL

LE

UV-169

A12 A1

1ST GRADE

848

10LFL

LE

UV-171

A12 A1

1ST GRADE

848

10LFL

LE

UV-173

A12 A1

1ST GRADE

848

10LFL

LE

UV-175

A12 A1

1ST GRADE

848

10LFL

LE

UV-177

A12 A1

1ST GRADE

848

10LFL

LE

UV-179

A12 A1

1ST GRADE

848

10LFL

LE

UV-181

A12 A1

1ST GRADE

848

10LFL

LE

UV-183

A12 A1

1ST GRADE

848

10LFL

LE

UV-185

A12 A1

1ST GRADE

848

10LFL

LE

UV-187

A12 A1

1ST GRADE

848

10LFL

LE

UV-189

A12 A1

1ST GRADE

848

10LFL

LE

UV-191

A12 A1

1ST GRADE

848

10LFL

LE

UV-193

A12 A1

1ST GRADE

848

10LFL

LE

UV-195

A12 A1

1ST GRADE

848

10LFL

LE

UV-197

A12 A1

1ST GRADE

848

10LFL

LE

UV-199

A12 A1

1ST GRADE

848

10LFL

LE

UV-201

A12 A1

1ST GRADE

848

10LFL

LE

UV-203

A12 A1

1ST GRADE

848

10LFL

LE

UV-205

A12 A1

1ST GRADE

848

10LFL

LE

UV-207

A12 A1

1ST GRADE

848

10LFL

LE

UV-209

A12 A1

1ST GRADE

848

10LFL

LE

UV-211

A12 A1

1ST GRADE

848

10LFL

LE

UV-213

A12 A1

1ST GRADE

848

10LFL

LE

UV-215

A12 A1

1ST GRADE

848

10LFL

LE

UV-217

A12 A1

1ST GRADE

848

10LFL

LE

UV-219

A12 A1

1ST GRADE

848

10LFL

LE

UV-221

A12 A1

1ST GRADE

848

10LFL

LE

UV-223

A12 A1

1ST GRADE

848

10LFL

LE

UV-225

A12 A1

1ST GRADE

848

10LFL

LE

UV-227

A12 A1

1ST GRADE

848

10LFL

LE

UV-229

A12 A1

1ST GRADE

848

10LFL

LE

UV-231

A12 A1

1ST GRADE

848

10LFL

LE

UV-233

A12 A1

1ST GRADE

848

10LFL

LE

UV-235

A12 A1

1ST GRADE

848

10LFL

LE

UV-237

A12 A1

1ST GRADE

848

10LFL

LE

UV-239

A12 A1

1ST GRADE

848

10LFL

LE

UV-241

A12 A1

1ST GRADE

848

10LFL

LE

UV-243

A12 A1

1ST GRADE

848

10LFL

LE

UV-245

A12 A1

1ST GRADE

848

10LFL

LE

UV-247

A12 A1

1ST GRADE

848

10LFL

LE

UV-249

A12 A1

1ST GRADE

848

10LFL

LE

UV-251

A12 A1

1ST GRADE

848

10LFL

LE

UV-253

A12 A1

1ST GRADE

848

10LFL

LE

UV-255

A12 A1

1ST GRADE

848

10LFL

LE

UV-257

A12 A1

1ST GRADE

848

10LFL

LE

UV-259

A12 A1

1ST GRADE

848

10LFL

LE

UV-261

A12 A1

1ST GRADE

848

10LFL

LE

UV-263

A12 A1

1ST GRADE

848

10LFL

LE

UV-265

A12 A1

1ST GRADE

848

10LFL

LE

UV-267

A12 A1

1ST GRADE

848

10LFL

LE

UV-269

A12 A1

1ST GRADE

848

10LFL

LE

UV-271

A12 A1

1ST GRADE

848

10LFL

LE

UV-273

A12 A1

1ST GRADE

848

10LFL

LE

UV-275

A12 A1

1ST GRADE

848

10LFL

LE

UV-277

A12 A1

1ST GRADE

848

10LFL

LE

UV-279

A12 A1

1ST GRADE

848

10LFL

LE

UV-281

A12 A1

1ST GRADE

848

10LFL

LE

UV-283

A12 A1

1ST GRADE

848

10LFL

LE

UV-285

A12 A1

1ST GRADE

848

10LFL

LE

UV-287

A12 A1

1ST GRADE

848

10LFL

LE

UV-289

A12 A1

1ST GRADE

848

10LFL

LE

UV-291

A12 A1

1ST GRADE

848

10LFL

LE

UV-293

A12 A1

1ST GRADE

848

10LFL

LE

UV-295

A12 A1

1ST GRADE

848

10LFL

LE

UV-297

A12 A1

1ST GRADE

848

10LFL

LE

UV-299

A12 A1

1ST GRADE

848

10LFL

LE

UV-301

A12 A1

1ST GRADE

848

10LFL

LE

UV-303

A12 A1

1ST GRADE

848

10LFL

LE

UV-305

A12 A1

1ST GRADE

848

10LFL

LE

UV-307

A12 A1

1ST GRADE

848

10LFL

LE

UV-309

A12 A1

1ST GRADE

848

10LFL

LE

UV-311

A12 A1

1ST GRADE

848

10LFL

LE

UV-313

A12 A1

1ST GRADE

848

10LFL

LE

UV-315

A12 A1

1ST GRADE

848

10LFL

LE

UV-317

A12 A1

1ST GRADE

848

10LFL

LE

UV-319

A12 A1

1ST GRADE

848

10LFL

LE

UV-321

A12 A1

1ST GRADE

848

10LFL

LE

UV-323

A12 A1

1ST GRADE

848

10LFL

LE

UV-325

A12 A1

1ST GRADE

848

10LFL

LE

UV-327

A12 A1

1ST GRADE

848

10LFL

LE

UV-329

A12 A1

1ST GRADE

848

10LFL

LE

UV-331

A12 A1

1ST GRADE

848

10LFL

LE

UV-333

A12 A1

1ST GRADE

848

10LFL

LE

UV-335

A12 A1

1ST GRADE

848

10LFL

LE

UV-337

A12 A1

1ST GRADE

848

10LFL

LE

UV-339

A12 A1

1ST GRADE

848

10LFL

LE

UV-341

A12 A1

1ST GRADE

848

10LFL

LE

UV-343

A12 A1

1ST GRADE

848

10LFL

LE

UV-345

A12 A1

1ST GRADE

848

10LFL

LE

UV-347

A12 A1

1ST GRADE

848

10LFL

LE

UV-349

A12 A1

1ST GRADE

848

10LFL

LE

UV-351

A12 A1

1ST GRADE

848

10LFL

LE

UV-353

A12 A1

1ST GRADE

848

10LFL

LE

UV-355

A12 A1

1ST GRADE

848

10LFL

LE

UV-357

A12 A1

1ST GRADE

848

10LFL

LE

UV-359

A12 A1

1ST GRADE

848

10LFL

LE

UV-361

A12 A1

1ST GRADE

848

10LFL

LE

UV-363

A12 A1

1ST GRADE

848

10LFL

LE

UV-365

A12 A1

1ST GRADE

848

10LFL

LE

UV-367

A12 A1

1ST GRADE

848

10LFL

LE

UV-369

A12 A1

1ST GRADE

848

10LFL

LE

UV-371

A12 A1

1ST GRADE

848

10LFL

LE

UV-373

A12 A1

1ST GRADE

848

10LFL

LE

UV-375

A12 A1

1ST GRADE

848

10LFL

LE

UV-377

A12 A1

1ST GRADE

848

10LFL

LE

UV-379

A12 A1

1ST GRADE

848

10LFL

LE

UV-381

A12 A1

1ST GRADE

848

10LFL

LE

UV-383

A12 A1

1ST GRADE

848

10LFL

LE

UV-385

A12 A1

1ST GRADE

848

10LFL

LE

UV-387

A12 A1

1ST GRADE

848

10LFL

LE

UV-389

A12 A1

1ST GRADE

848

10LFL

LE

UV-391

A12 A1

1ST GRADE

848

10LFL

LE

UV-393

A12 A1

1ST GRADE

848

10LFL

LE

UV-395

A12 A1

1ST GRADE

848

10LFL

LE

EXISTING THROUGH WALL LOUVER

EXISTING THROUGH WALL SCUPPER

EXISTING PIPE PENETRATION

EXISTING ROOF DRAIN

NEW ROOF DRAIN

EXISTING VENTILATOR OR MECHANICAL PENETRATION

EXISTING EQUIPMENT PAD

EXISTING ROOF HATCH

EXISTING LADDER

NEW RTU

EXISTING MECHANICAL EQUIPMENT

ROOF VENT

EXISTING SKYLIGHT

EXISTING FRESH AIR INTAKE

EXISTING CHIMNEY

NEW PROTECTION RAILING

LEGEND

A20

INSTALL NEW AIR-COOLING-CONDENSING UNIT (ACCU)

A21

INSTALL NEW RTU. SEE STRUCTURAL AND MECHANICAL DRAWINGS.

A22

NEW MECHANICAL ROOF PENETRATION WITH ROOF FLASHING. SEE DETAIL 4/A-500 AND MECHANICAL DRAWINGS.

A23

INSTALL 125 L.F. OF NEW EQUIPMENT SCREENING FOR NEW CHILLER. CHILLER TO BE INSTALLED UNDER SEPARATE CONTRACT. (SEE DETAIL 7/A-500).

2

KEY NOTES

1.

CONTRACTOR SHALL BE REQUIRED TO COORDINATE WITH ALL MEP AND STRUCTURAL DRAWINGS. SEE MECHANICAL DRAWINGS FOR ALL HVAC ROOFTOP EQUIPMENT.

2.

EXISTING ROOF HAS A WARRANTY ISSUED BY TREMCO. ALL REPAIR WORK MUST BE PERFORMED BY TREMCO AUTHORIZED CONTRACTOR. LETTER FROM TREMCO WILL BE REQUIRED STATING WORK PERFORMED DOES NOT VOID EXISTING WARRANTY AND NEW WORK IS COVERED UNDER EXISTING WARRANTY.

GENERAL NOTES

NOTE: NEW EQUIPMENT SCREENING TO COMPLY WITH CLEARANCE REQUIREMENTS FOR NEW UNITS

0 1/2 7
IF THIS BAR DOES NOT MEASURE 1" THEN DRAWING IS NOT TO FULL SCALE

PLAN NORTH

1

PROPOSED ROOF PLAN

SCALE: 1"=20'-0"

© COPYRIGHT, MICHAEL SHILALE ARCHITECTS LLP. ALL RIGHTS RESERVED.

Drawing Title

PROPOSED ROOF PLAN

TES-A-103

Drawing No.

UNIVENT REPLACEMENT AT STONY POINT, THIELS AND WEST HAVERSTRAW ELEMENTARY SCHOOL

SPES SED# 50-02-01-08-0-014-012
TES SED# 50-02-01-06-0-025-018
WHES SED# 50-02-01-06-0-024-015

7 EIDER DRIVE
STONY POINT, NY 10980

MSA

MICHAEL SHILALE ARCHITECTS, L.L.P.
New York, NY 10006 Tel 945-005-6000
info@shilale.com

GREENMAN PEDERSEN, INC
400 BELLA BOULEVARD
MONTEBELLO, NY 10601

Mechanical & Electrical Engineer:

GREENMAN PEDERSEN, INC
400 BELLA BOULEVARD
MONTEBELLO, NY 10601

Structural Engineer:

Drawn by JR

Checked by MS/JC

Project No. 43042

Scale

Date 03-04-25

IT IS A VIOLATION OF THE LAW FOR ANY PERSON, UNLESS ACTING UNDER THE DIRECTION OF A LICENSED ARCHITECT, TO ALTER AN ITEM IN ANY WAY.

REG. EXP. DATE: 12-31-25

03-19-25 BIDDING ADDENDUM 2

03-04-25 BIDDING DOCUMENTS

No.

Date

Revisions

