

AS PER PER ACT CONGRESS ARCHITECTURAL WORKS COPYRIGHT PROTECTION ACT OF 1990 ALL IDEAS AND DESIGNS INCLUDING DERIVATIVES THEREOF, ALL DRAWINGS AND SPECIFICATIONS CONSTITUTE THE ORIGINAL COPYRIGHT WORK BY FULLER AND DANIELO, P.C. (F&D). THE DRAWINGS AND SPECIFICATIONS AS INSTRUMENTS OF SERVICE BY F&D ARE CREATED BY F&D FOR THIS PROJECT ONLY AND REMAIN THE PROPERTY OF F&D. ANY REPRODUCTION WITHOUT THE PRIOR CONSENT OF F&D IS PROHIBITED.

BARILE GALLAGHER & ASSOCIATES
CONSULTING ENGINEERS
39 MARBLE AVE. PLEASANTVILLE, NY 10570
914.328.6000 GENERAL@BGA-ENG.COM www.BGA-ENG.COM

48 SNELLWOOD ROAD ELMSFORD NEW YORK 10523
TEL 914.898-4444 FAX 914.898-1917
FULLER & DANIELO ARCHITECTS P.C.
Copyright 2024 All Rights Reserved by FULLER & DANIELO P.C.

FULLER
DANIELO
P.C.
ARCHITECTS
PLANNERS


S.E.D. CONTROL NUMBER:
66-23-00-01-0-032-010

BID SCHEDULE #


PROJECT TITLE
YONKERS SCHOOL DISTRICT
PHASE 1 OF 3 FOR WINDOWS, MASONRY,
MECHANICAL, ELECTRICAL & SITE WORK
AT SCHOOL P.S. 32
1 MONTCLAR PLACE, YONKERS, NY 10710

DRAWING TITLE
UPPER LEVEL POWER PLAN

02-05-2024	BID ADDENDUM 5
01-23-2024	BID ADDENDUM 3
12-22-2023	BID
11-06-2020	100% C.D. SUBMISSION
06-01-2020	100% D.D. SUBMISSION
DATE	ISSUED TO
SHEET SIZE 30"x42"	DRAWING NO. E302
SCALE AS NOTED	FILE NO. 19360.00
DRAWN BY BGA	

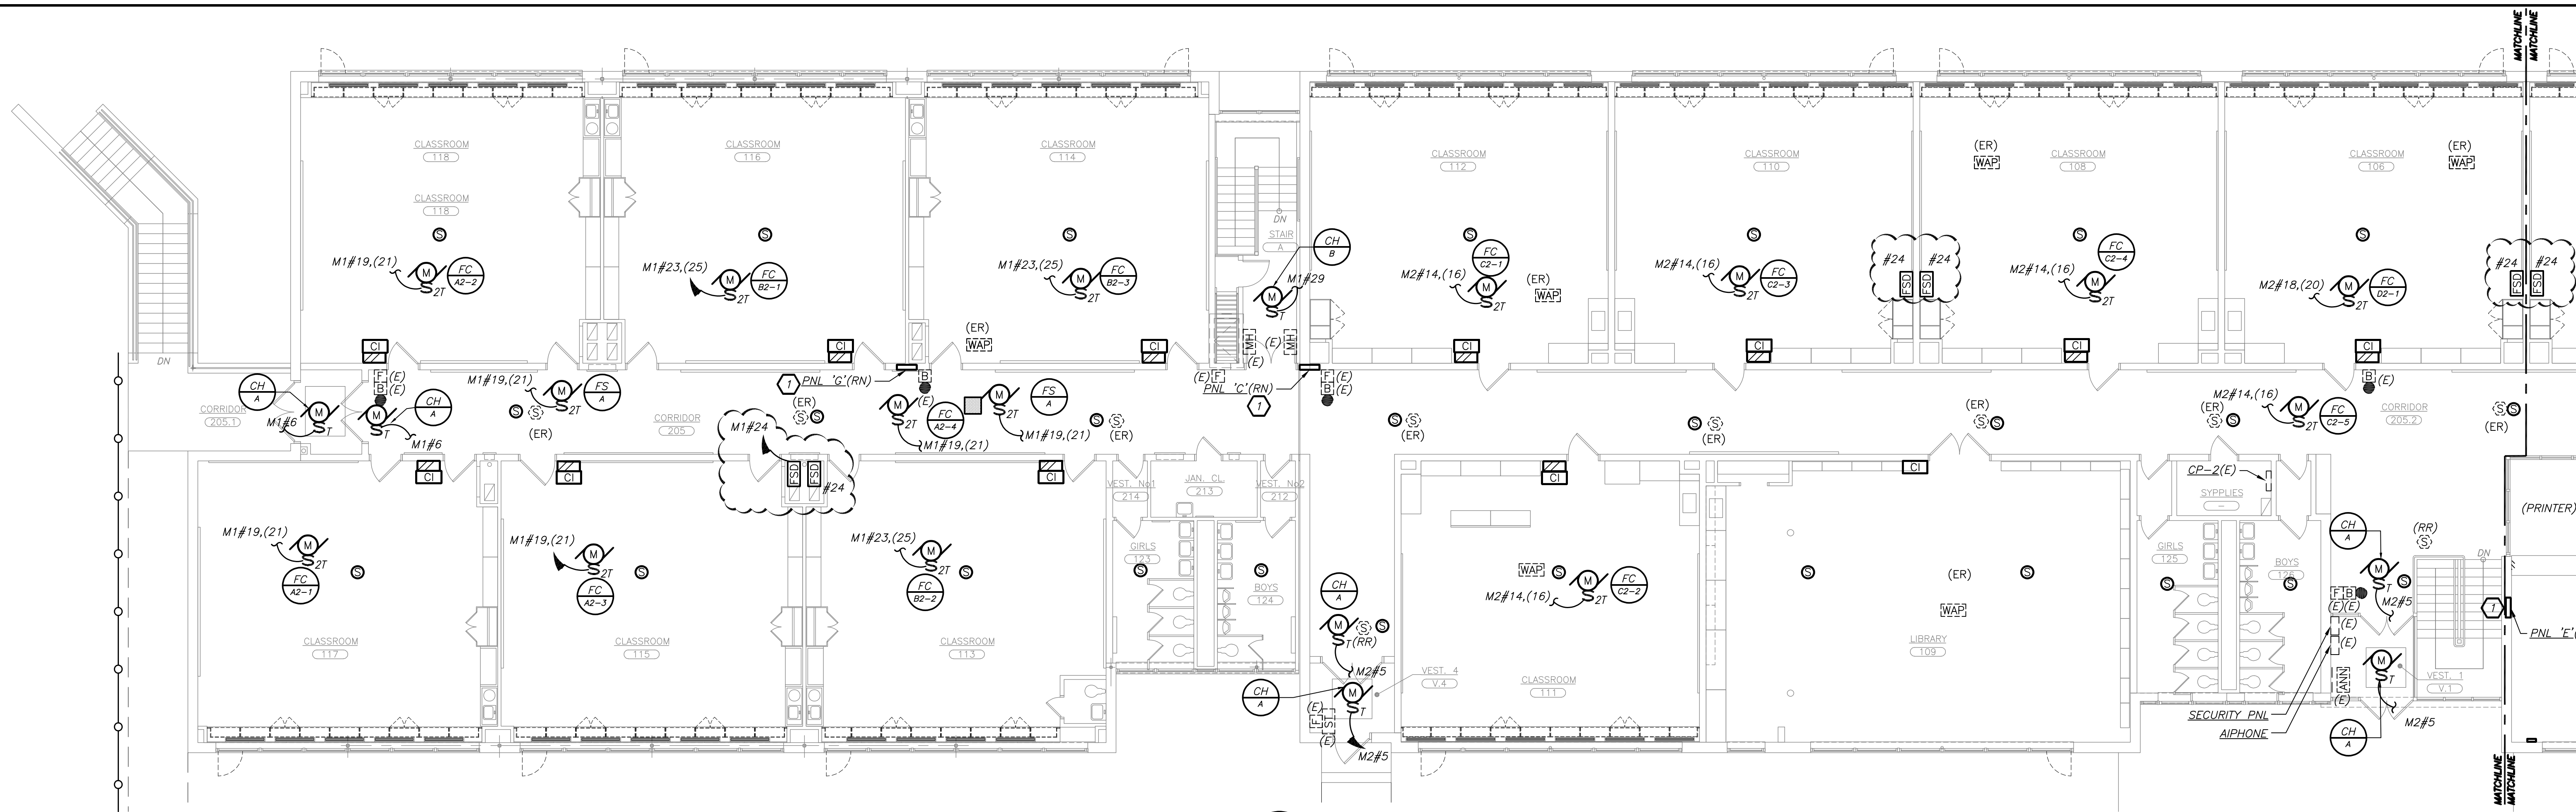

PART UPPER LEVEL FLOOR PLAN
(NEW WORK)

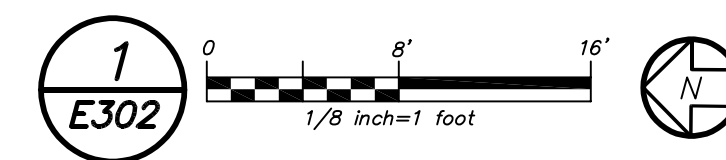


GENERAL NOTES:



- REFER TO ELECTRICAL RISER DIAGRAMS ON DRAWING E501 FOR SCOPE OF WORK.
- REFER TO PANELBOARD SCHEDULES ON DRAWINGS E601 FOR BRANCH CIRCUITING INFORMATION.
- REFER TO DRAWINGS E700 SERIES FOR DETAILS.
- CONTRACTOR TO COORDINATE EXACT LOCATION OF ALL RECEPTACLES IN CLASSROOMS, OFFICES, AND CONFERENCE ROOMS WITH OWNER BEFORE START OF ANY WORK.
- COORDINATE EXACT HAND DRYER LOCATION IN EACH BATHROOM WITH ARCHITECT BEFORE START OF ANY WORK.

WORK NOTES:

- ELECTRICAL CONTRACTOR SHALL DISCONNECT ALL EXISTING CIRCUITS TO REMAIN, REMOVE EXISTING INTERNAL COMPONENTS, MAINTAIN EXISTING BACKBOX AND PROVIDE NEW INTERNAL COMPONENTS. PROVIDE CUSTOM INTERNAL COMPONENTS AND COVER AS REQUIRED. PROVIDE NEW CUSTOM "DOOR-IN-DOOR" TRIM COVER. ANY DAMAGE CAUSED TO SURROUNDING WALL FINISHES SHALL BE PAIRED, PAINTED, ETC. TO MATCH EXISTING. RE-USE EXISTING CONDUITS/PATHWAY AND PROVIDE NEW FEEDERS, MATCH EXISTING FEEDER SIZE. EXTEND ALL WIRING AND CONDUIT AS NECESSARY FOR COMPLETE INSTALLATION. CONTRACTOR SHALL MATCH EXISTING CIRCUIT BREAKERS ARRANGEMENT. REFER TO DETAIL FOR CUSTOM PANELBOARD REQUIREMENTS ON DRAWING 3/E701. REFER TO REPLACEMENT PANEL SCHEDULE ON DRAWING E601.
- CONTRACTOR TO PROVIDE TOTAL OF (3) ADMIN PHONES, BOGEN MODEL #NQ-T1100, AND (2) STAFF PHONES, BOGEN MODEL #NQ-T1001 IN THE MAIN OFFICE. INCLUDE CAT 6 WIRING TO PA HEAD END RACK DOWN STAIRS. CONFIRM EXACT LOCATION BEFORE START OF WORK.
- NEW VFD FOR EF-3. EC TO PROVIDE WIRING TO VFD. COORDINATE EXACT LOCATION WITH HVAC CONTRACTOR.

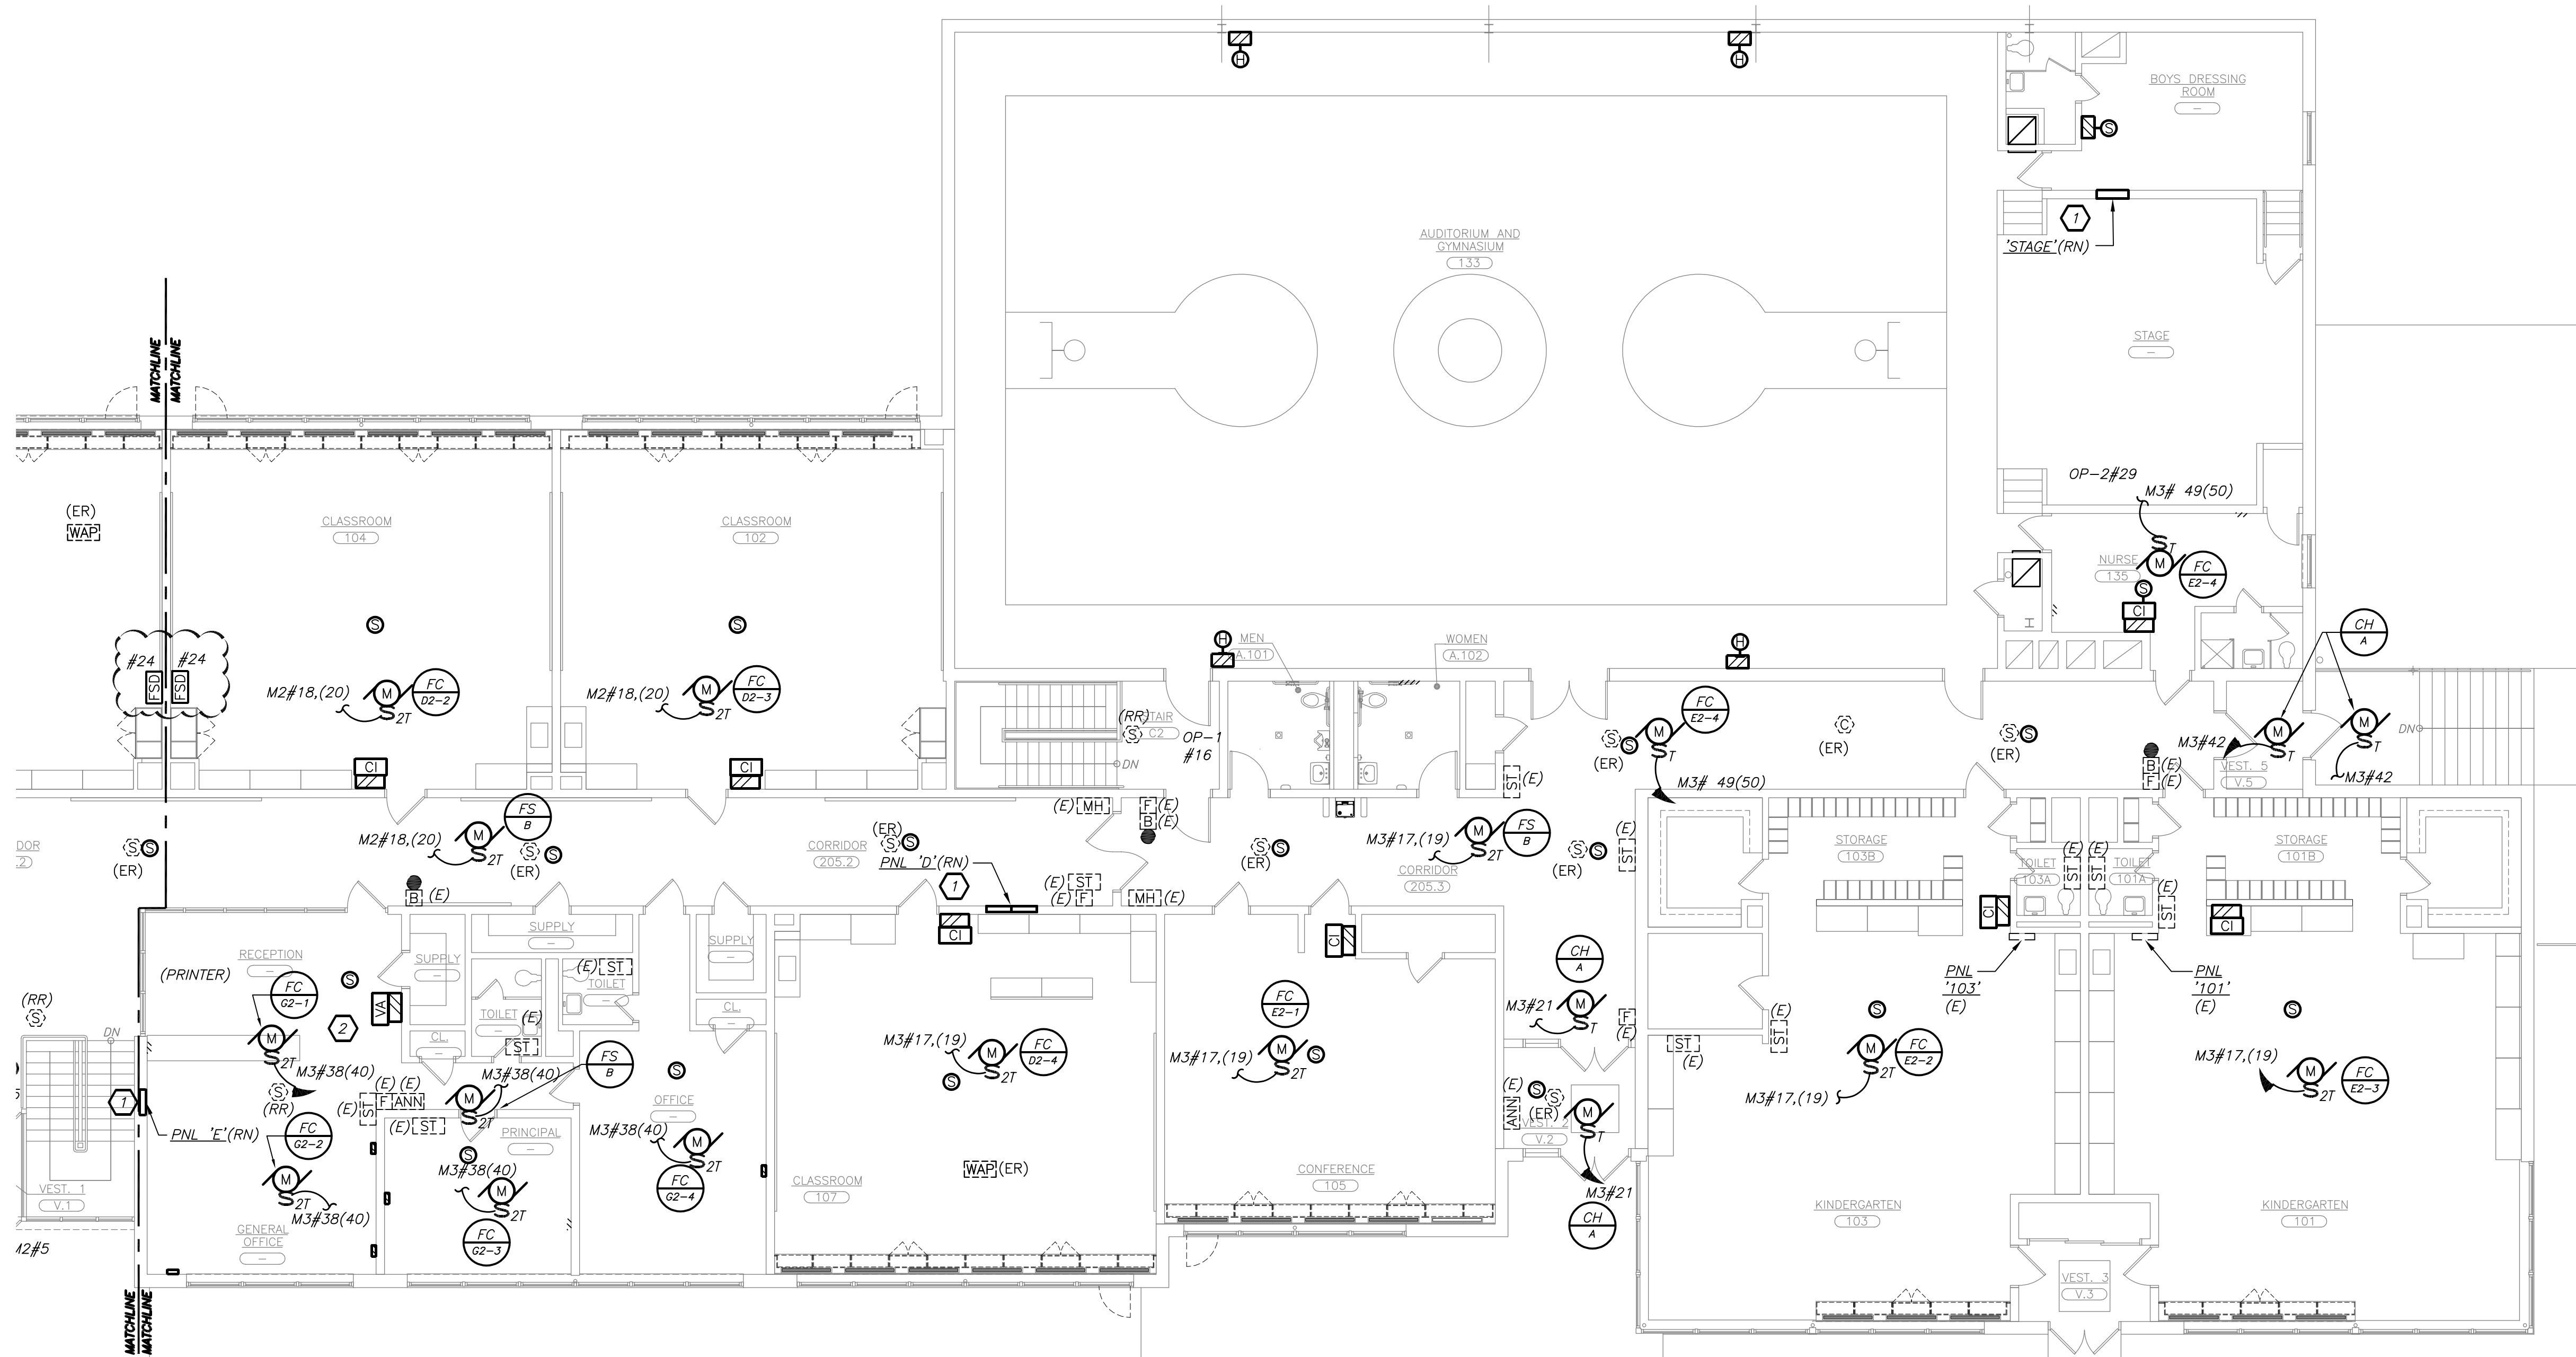

PART UPPER LEVEL FLOOR PLAN
(NEW WORK)

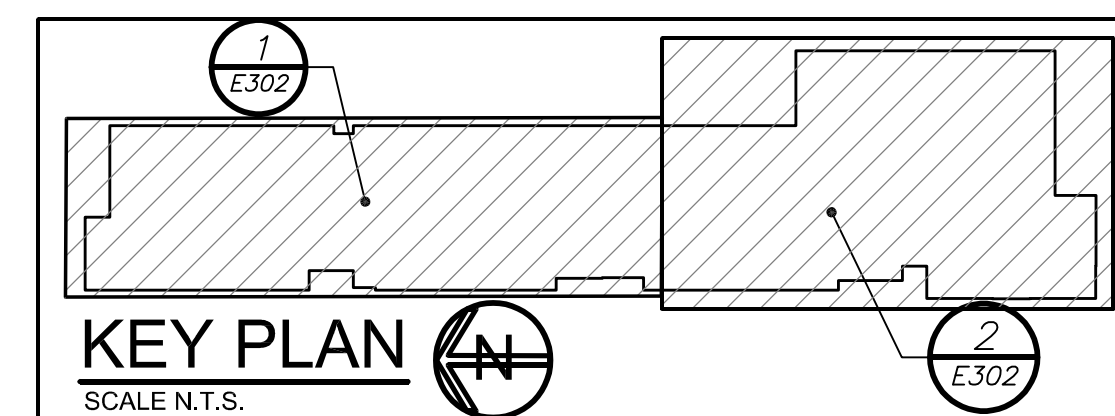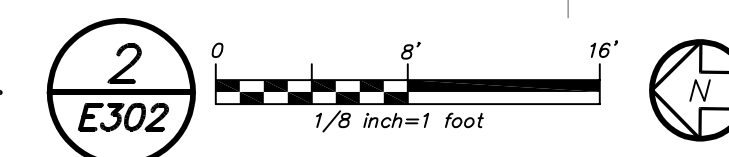

BEFORE FABRICATION THIS CONTRACTOR SHALL
VERIFY ALL MEASUREMENTS AND CONDITIONS ON
JOB AND COORDINATE HIS WORK WITH THE WORK
OF ALL OTHER CONTRACTORS