


FILE NAME: I:\Projects\MEG\NMEG0050.Dwg(0-06-110.dwg) PLOT TIME: Wed, 27 Nov 2019 - 2:53pm LAST SAVE: Wed, 27 Nov 2019 - 2:51pm BY: dsoez

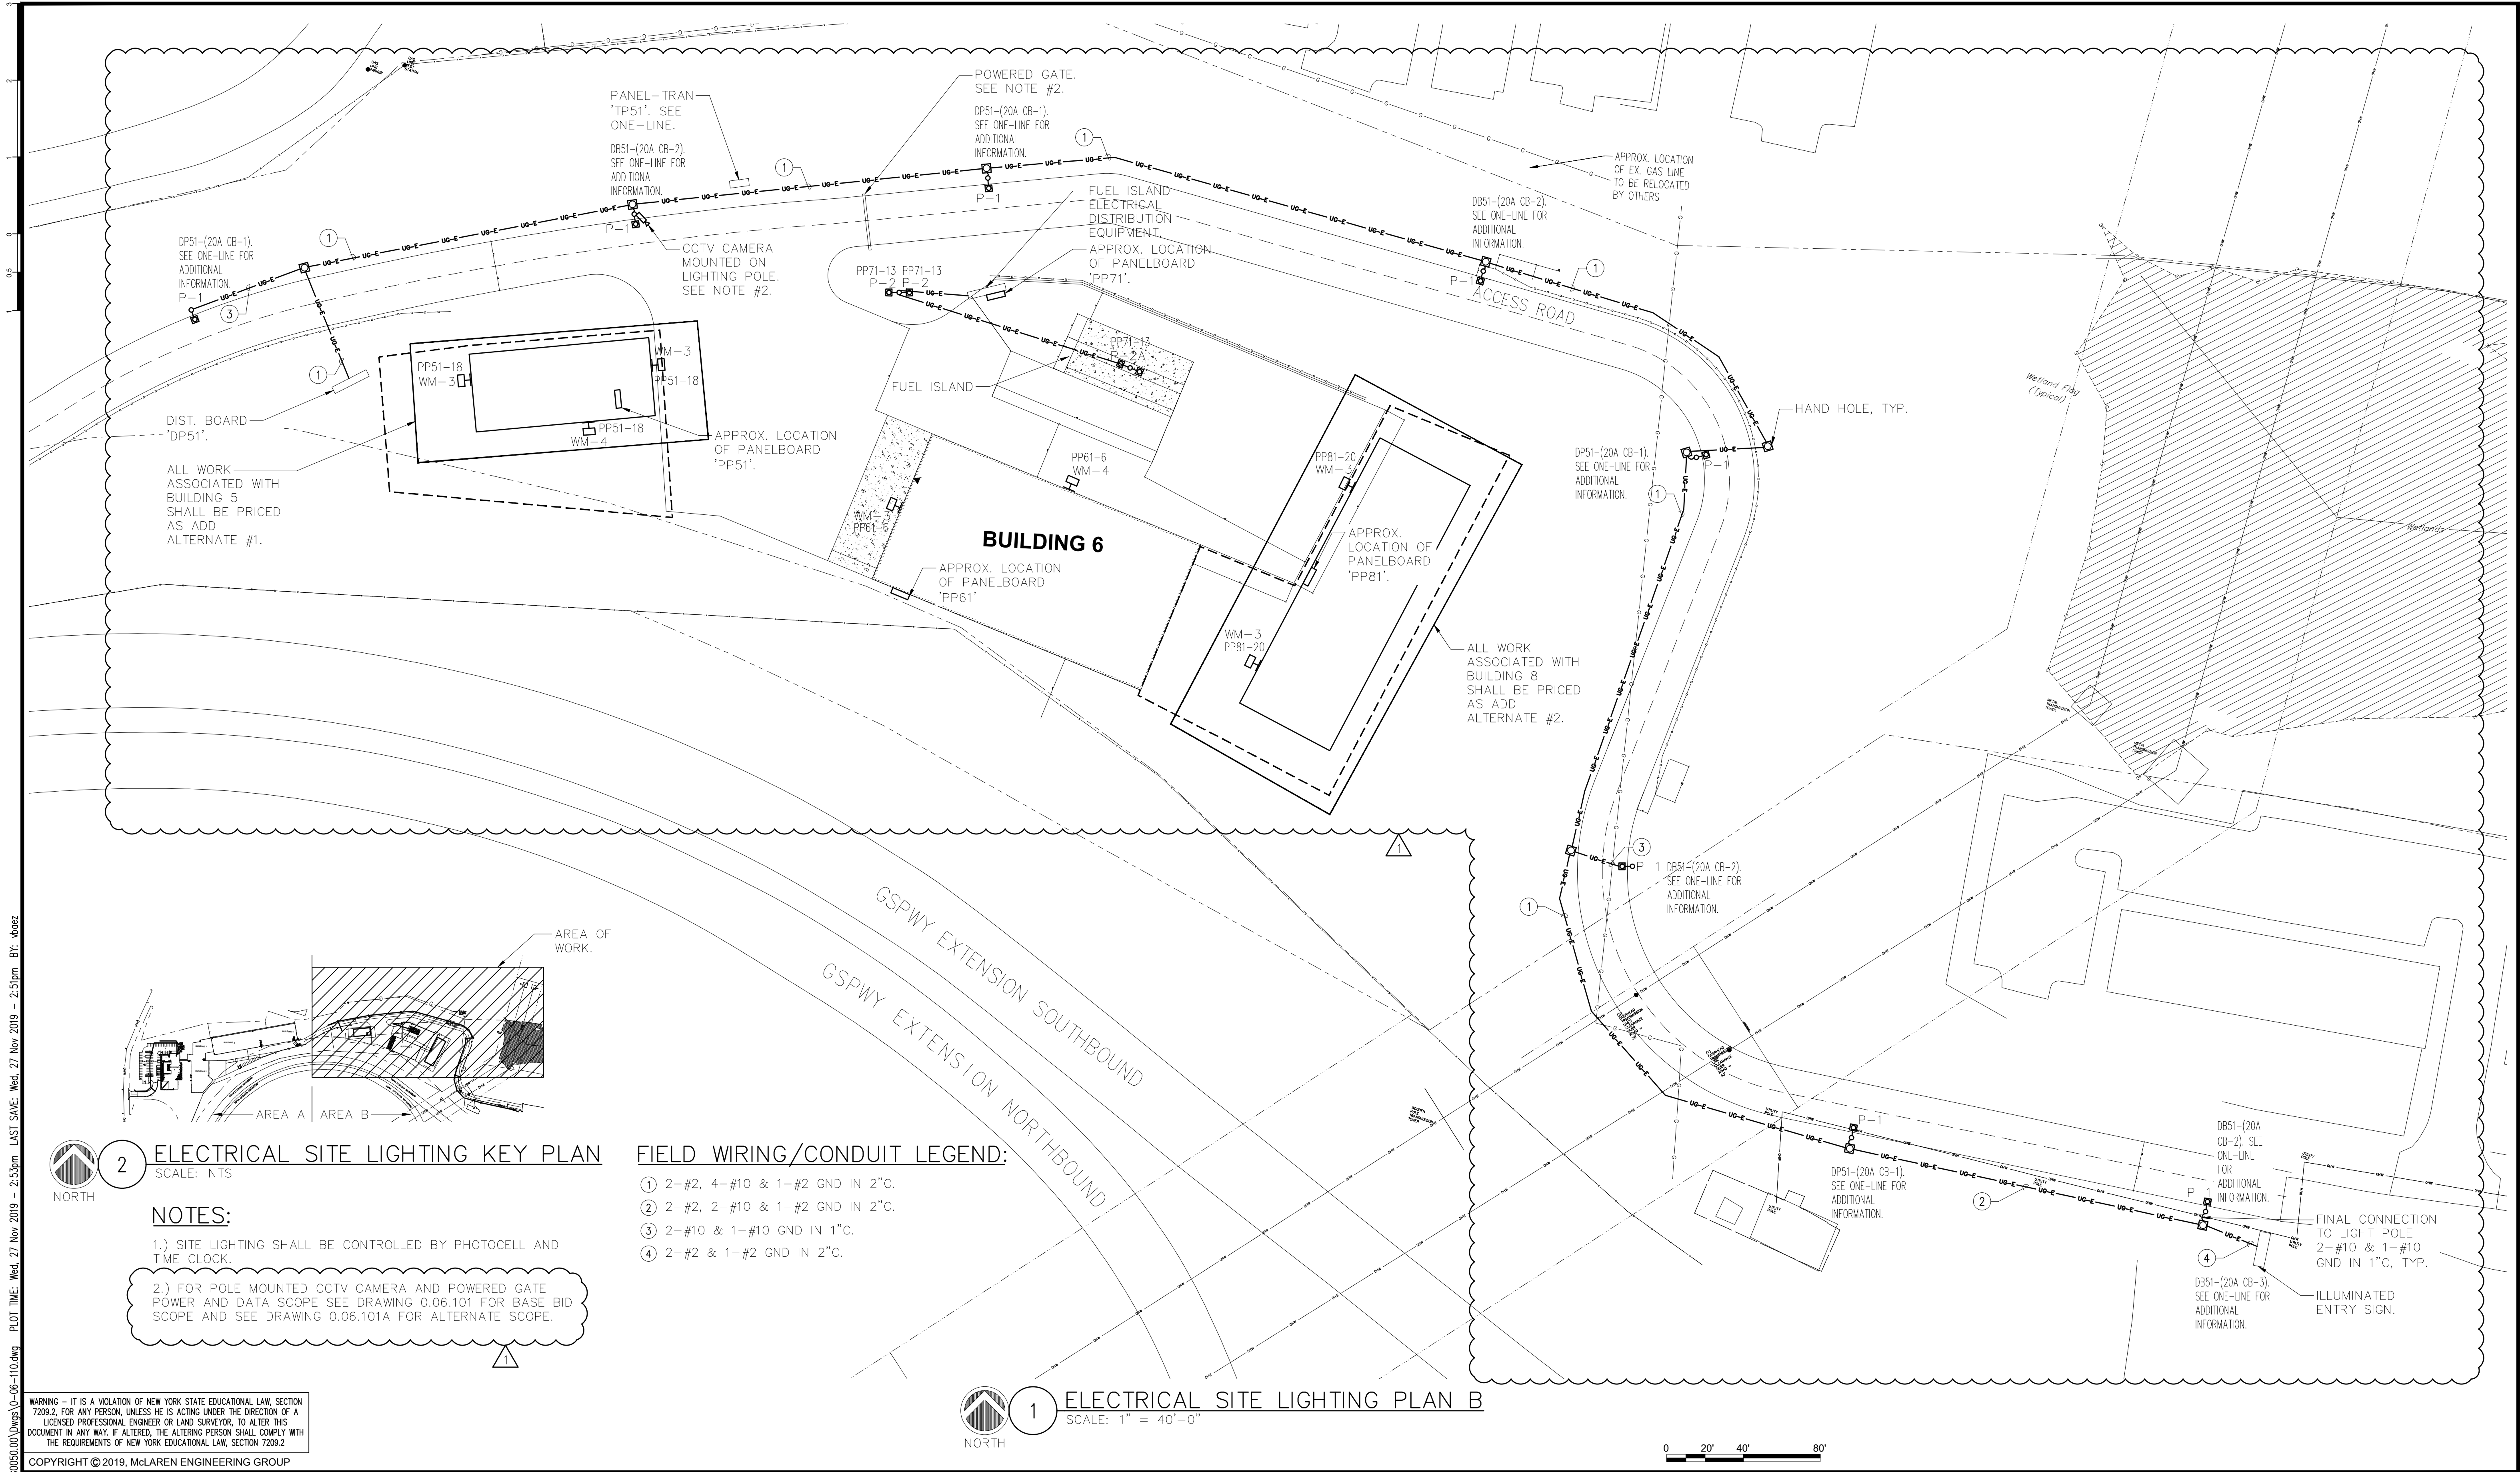

2 ELECTRICAL SITE LIGHTING KEY PLAN

SCALE: NTS

NOTES:

1.) SITE LIGHTING SHALL BE CONTROLLED BY PHOTOCELL AND TIME CLOCK.

2.) FOR POLE MOUNTED CCTV CAMERA AND POWERED GATE POWER AND DATA SCOPE SEE DRAWING 0.06.101 FOR BASE BID SCOPE AND SEE DRAWING 0.06.101A FOR ALTERNATE SCOPE.

FIELD WIRING/CONDUIT LEGEND:

- 1-#2, 4-#10 & 1-#2 GND IN 2"C.
- 2-#2, 2-#10 & 1-#2 GND IN 2"C.
- 2-#10 & 1-#10 GND IN 1"C.
- 2-#2 & 1-#2 GND IN 2"C.



1 ELECTRICAL SITE LIGHTING PLAN B

SCALE: 1" = 40'-0"

0 20' 40' 80'

CONSULTANTS ARCHITECT

STV 100 Years

STV Architects, P.C.
225 Park Avenue South
New York, NY 10003
(212) 777-4400 FAX: (212) 473-2780
www.stvinc.com

MEP ENGINEER

OLA Consulting Engineers

50 Broadway,
Hawthorne, NY 10532
914.747.2800

8 West 38th Street,
Suite 601
New York, NY 10018
646.848.4110
ola.com NMEG0050.00

FACILITIES CONSULTANT

Gannett Fleming

LANDSCAPE ARCHITECT

IQ

Imbiano-Quigley
Landscape Architects

31 Monmouth Ave., 7th Floor
White Plains, New York 10601
admin@iqlandscape.com
(914) 232-4090

PROJECT


COUNTY OF ROCKLAND
CAPITAL PROJECT NO. 1307
HIGHWAY DEPARTMENT /
EMERGENCY OPERATIONS FACILITY
COUNTY OF ROCKLAND, NEW YORK

McLaren ENGINEERING GROUP

applied ingenuity

M. G. McLaren Engineering
and Land Surveying P.C.

530 Chestnut Ridge Road, Woodcliff Lake, NJ 07677
T: 201.775.6000 F: 201.746.8522 www.mgmclaren.com

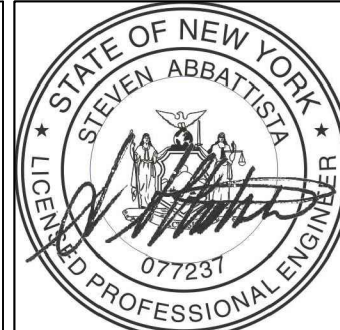

SHEET NAME

**ELECTRICAL SITE LIGHTING
PLAN B**

1	11/27/19	ADDENDUM 07	VB
No.	DATE	REVISION	BY

PROJECT NO. 130439

SCALE As indicated

DATE OCTOBER 30, 2019

DRAWN BY CT

CHECKED BY ML

APPROVED BY DS

ISSUED FOR **BID SET**

DRAWING NO. **0.06.111**

OF SHTS