


FILE NAME: I:\Projects\MEG\NMEG0050.00\Drawings\1-06-121-2.dwg PLOT TIME: Wed, 27 Nov 2019 - 2:30pm LAST SAVE: Wed, 27 Nov 2019 - 2:29pm BY: shaz

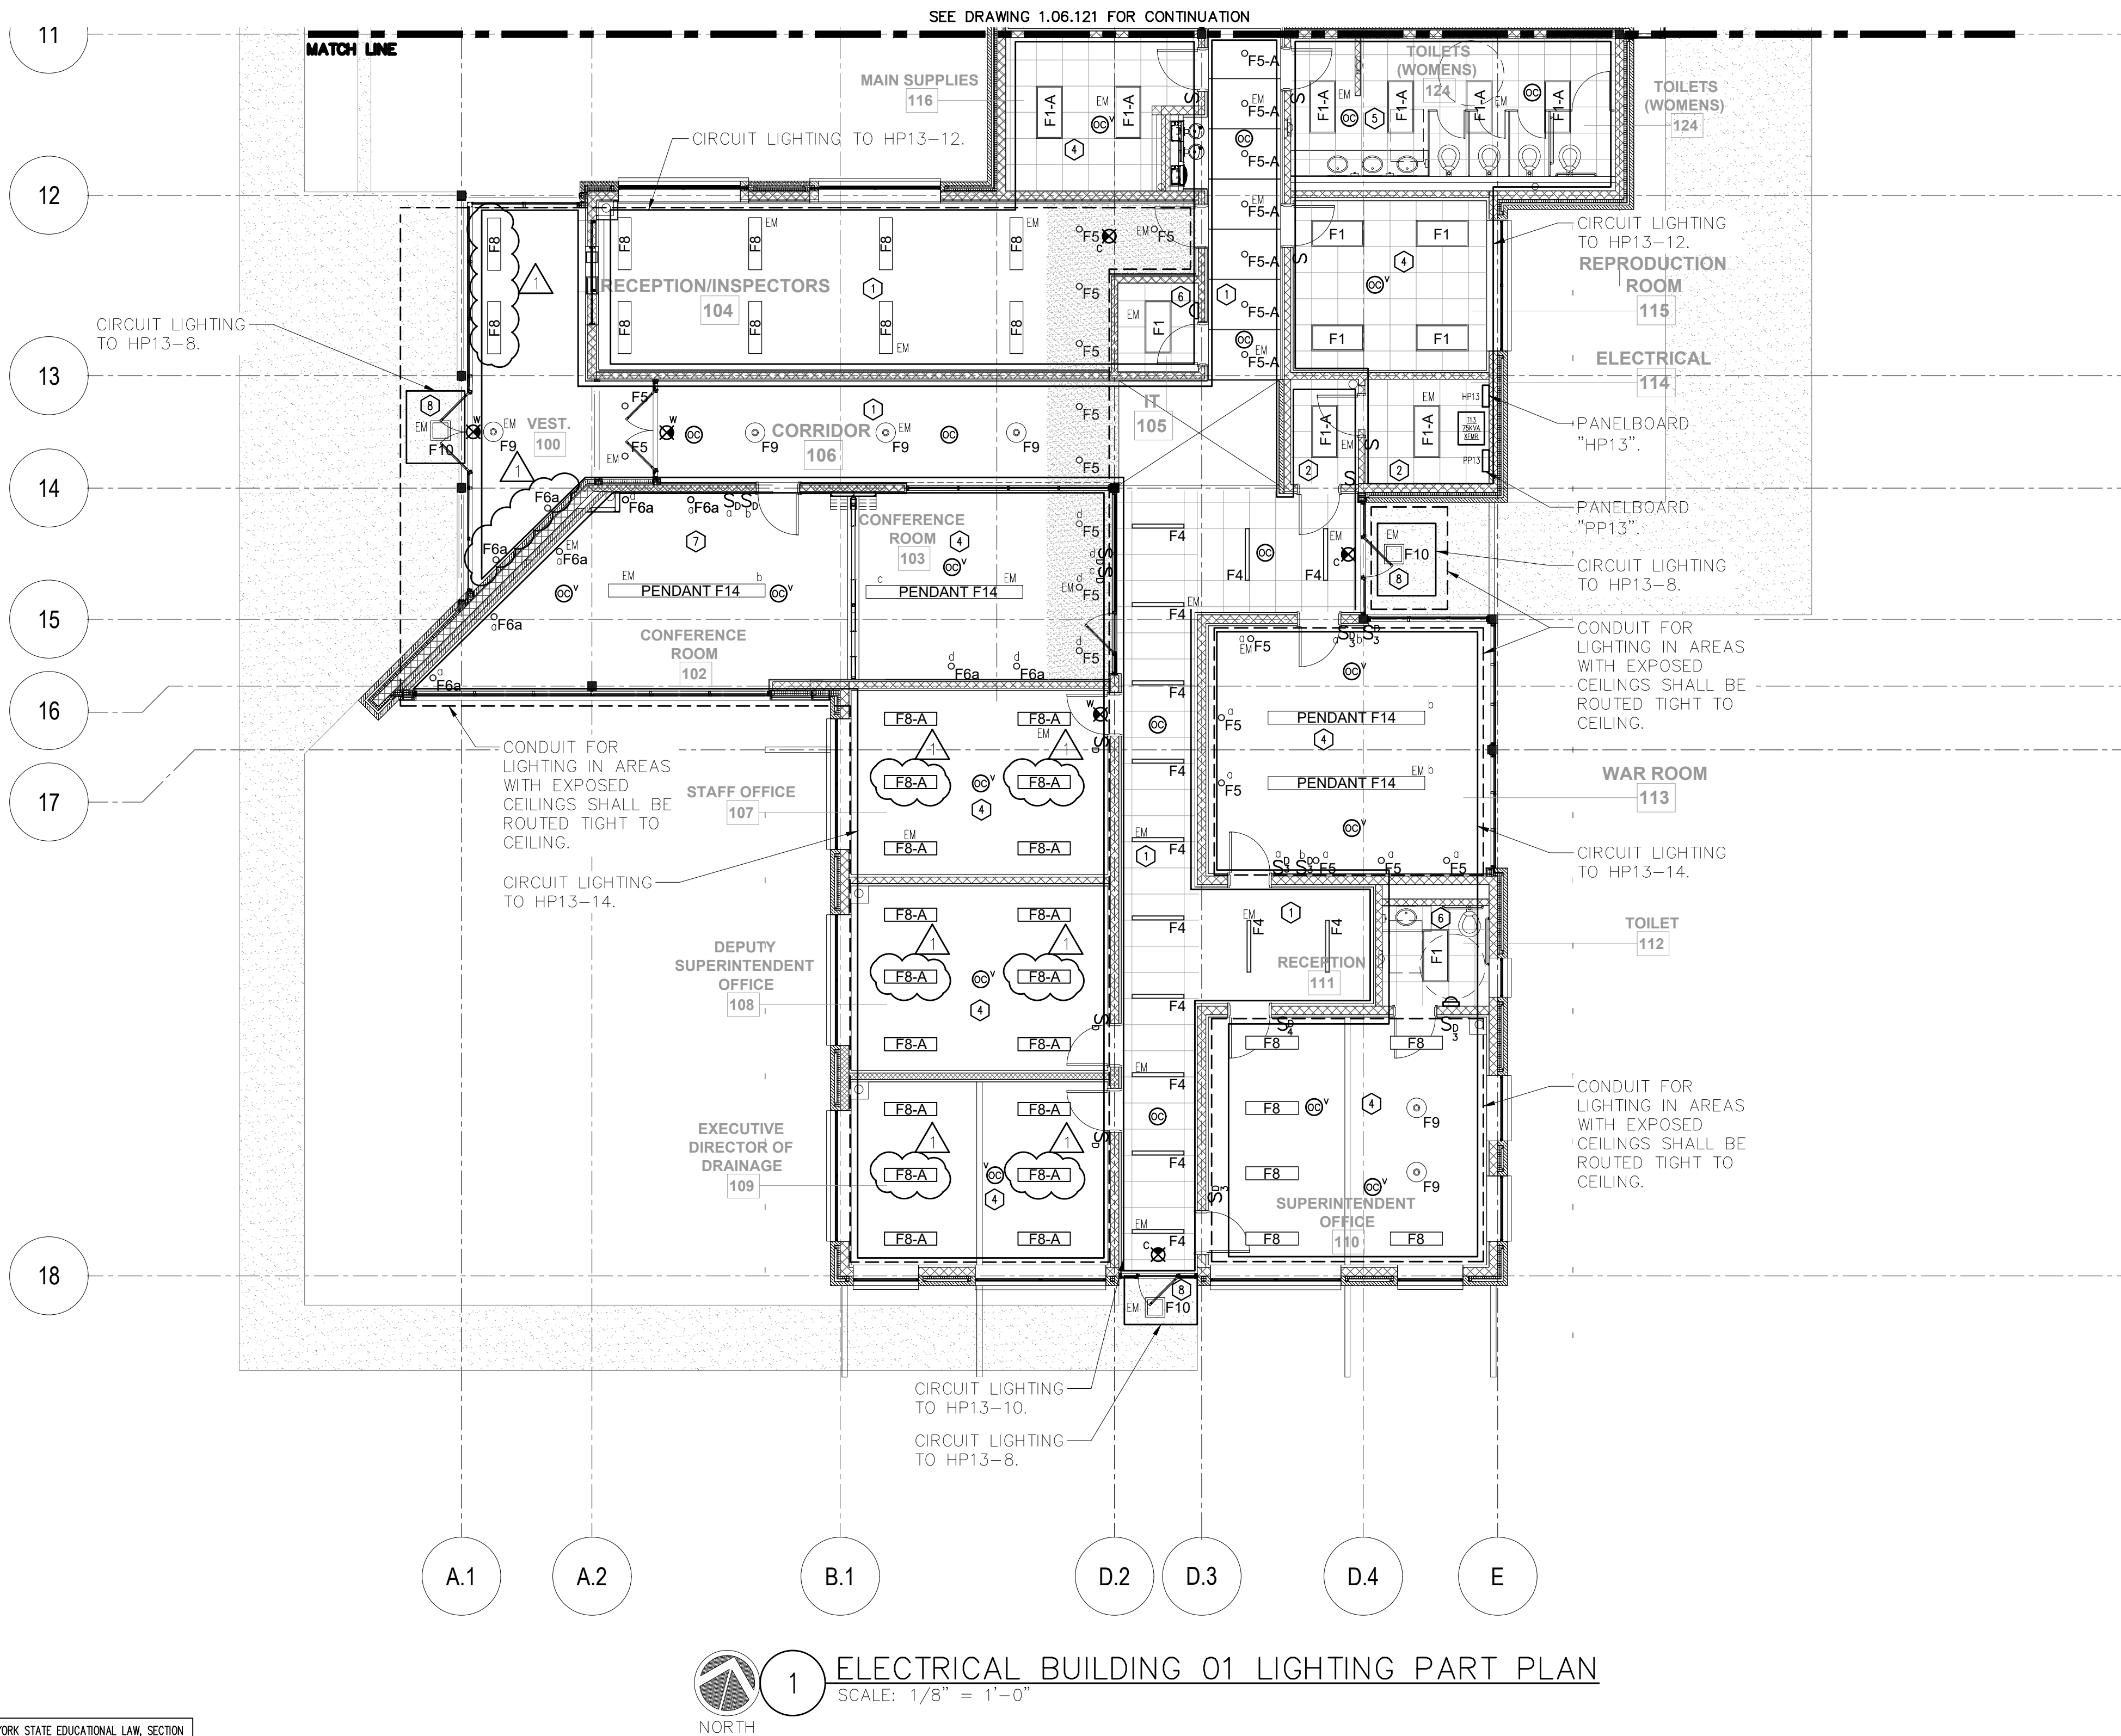


1 ELECTRICAL BUILDING 01 LIGHTING PART PLAN
SCALE: 1/8" = 1'-0"

NOTES:

1.) SEE DRAWINGS 0.06.604 & 0.06.605 FOR LIGHTING FIXTURE SCHEDULE, LIGHTING CONTROL DESIGN INTENT & LIGHTING SYSTEM FUNCTIONAL TESTING/COMMISSIONING NOTES.

LIGHTING CONTROL LEGEND

- 1 - TIME CLOCK WITH OCCUPANCY SENSOR OVERRIDE AFTER HOURS.
- 2 - LINE VOLTAGE ON/OFF WALL SWITCHING.
- 3 - LOW VOLTAGE WALL SWITCH VACANCY SENSOR.
- 4 - LOW VOLTAGE MANUAL ON WALL SWITCH WITH CEILING MOUNT VACANCY AND DIMMING.
- 5 - LOW VOLTAGE WALL SWITCH WITH CEILING MOUNTED OCCUPANCY SENSOR.
- 6 - LOW VOLTAGE WALL SWITCH OCCUPANCY SENSOR.
- 7 - LOW VOLTAGE MANUAL ON DIMMING WALL SWITCH WITH CEILING MOUNTED VACANCY.
- 8 - OUTDOOR PHOTOSENSOR CONTROL.

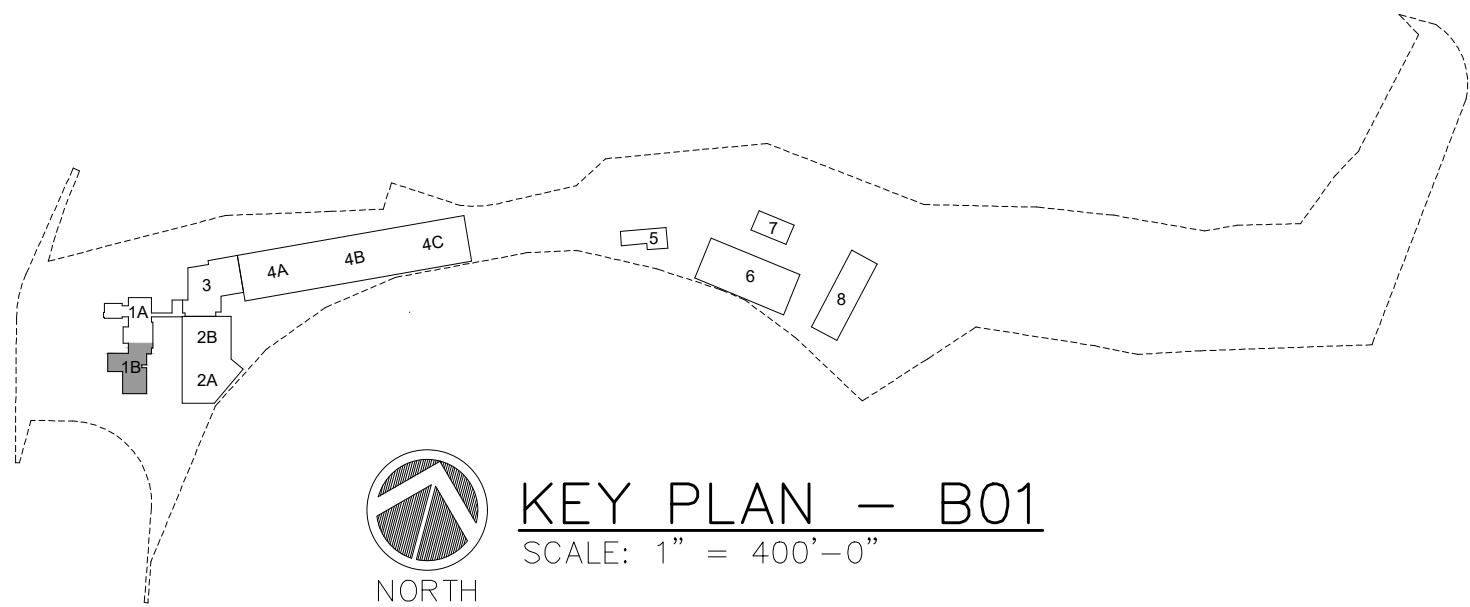

WARNING - IT IS A VIOLATION OF NEW YORK STATE EDUCATIONAL LAW, SECTION 7209.2, FOR ANY PERSON, UNLESS HE IS ACTING UNDER THE DIRECTION OF A LICENSED PROFESSIONAL ENGINEER OR LAND SURVEYOR, TO ALTER THIS DOCUMENT IN ANY WAY. IF ALTERED, THE ALTERING PERSON SHALL COMPLY WITH THE REQUIREMENTS OF NEW YORK EDUCATIONAL LAW, SECTION 7209.2

COPYRIGHT © 2019, McLAREN ENGINEERING GROUP

STV 100 Years
STV Architects, P.C.
225 Park Avenue South
New York, NY 10003
(212) 777-4400 FAX: (212) 473-2780
www.stvinc.com

OLA Consulting Engineers
50 Broadway,
Hawthorne, NY 10532
914.747.2800
8 West 38th Street,
Suite 601
New York, NY 10018
646.648.4110
ola.com NMEG0050.00

Gannett Fleming
FACILITIES CONSULTANT

IQ
Imbiano-Quigley
Landscape Architects
31 Monmouth Ave., 7th Floor
White Plains, New York 10601
admin@iqlandscape.com
(914) 232-4090

PROJECT
**COUNTY OF ROCKLAND
CAPITAL PROJECT NO. 1307
HIGHWAY DEPARTMENT /
EMERGENCY OPERATIONS FACILITY
COUNTY OF ROCKLAND, NEW YORK**

McLaren ENGINEERING GROUP
applied ingenuity
M. G. McLaren Engineering
and Land Surveying P.C.
530 Chestnut Ridge Road, Woodcliff Lake, NJ 07677
T: 201.775.6000 F: 201.746.8522 www.mgmclaren.com



**ELECTRICAL BUILDING 01
LIGHTING PART PLAN**

No.	DATE	REVISION	BY
1	11/27/19	ADDENDUM 07	VB

PROJECT NO. 130439
SCALE As indicated
DATE OCTOBER 30, 2019
DRAWN BY CT
CHECKED BY ML
APPROVED BY DS

ISSUED FOR **BID SET**
DRAWING NO. **1.06.122**
OF SHTS