


FILE NAME: I:\Projects\MEG\NMEG0050.00\Drawings\2-06-121-2.dwg PLOT TIME: Wed, 27 Nov 2019 - 2:31pm LAST SAVE: Wed, 27 Nov 2019 - 2:21pm BY: dkoz

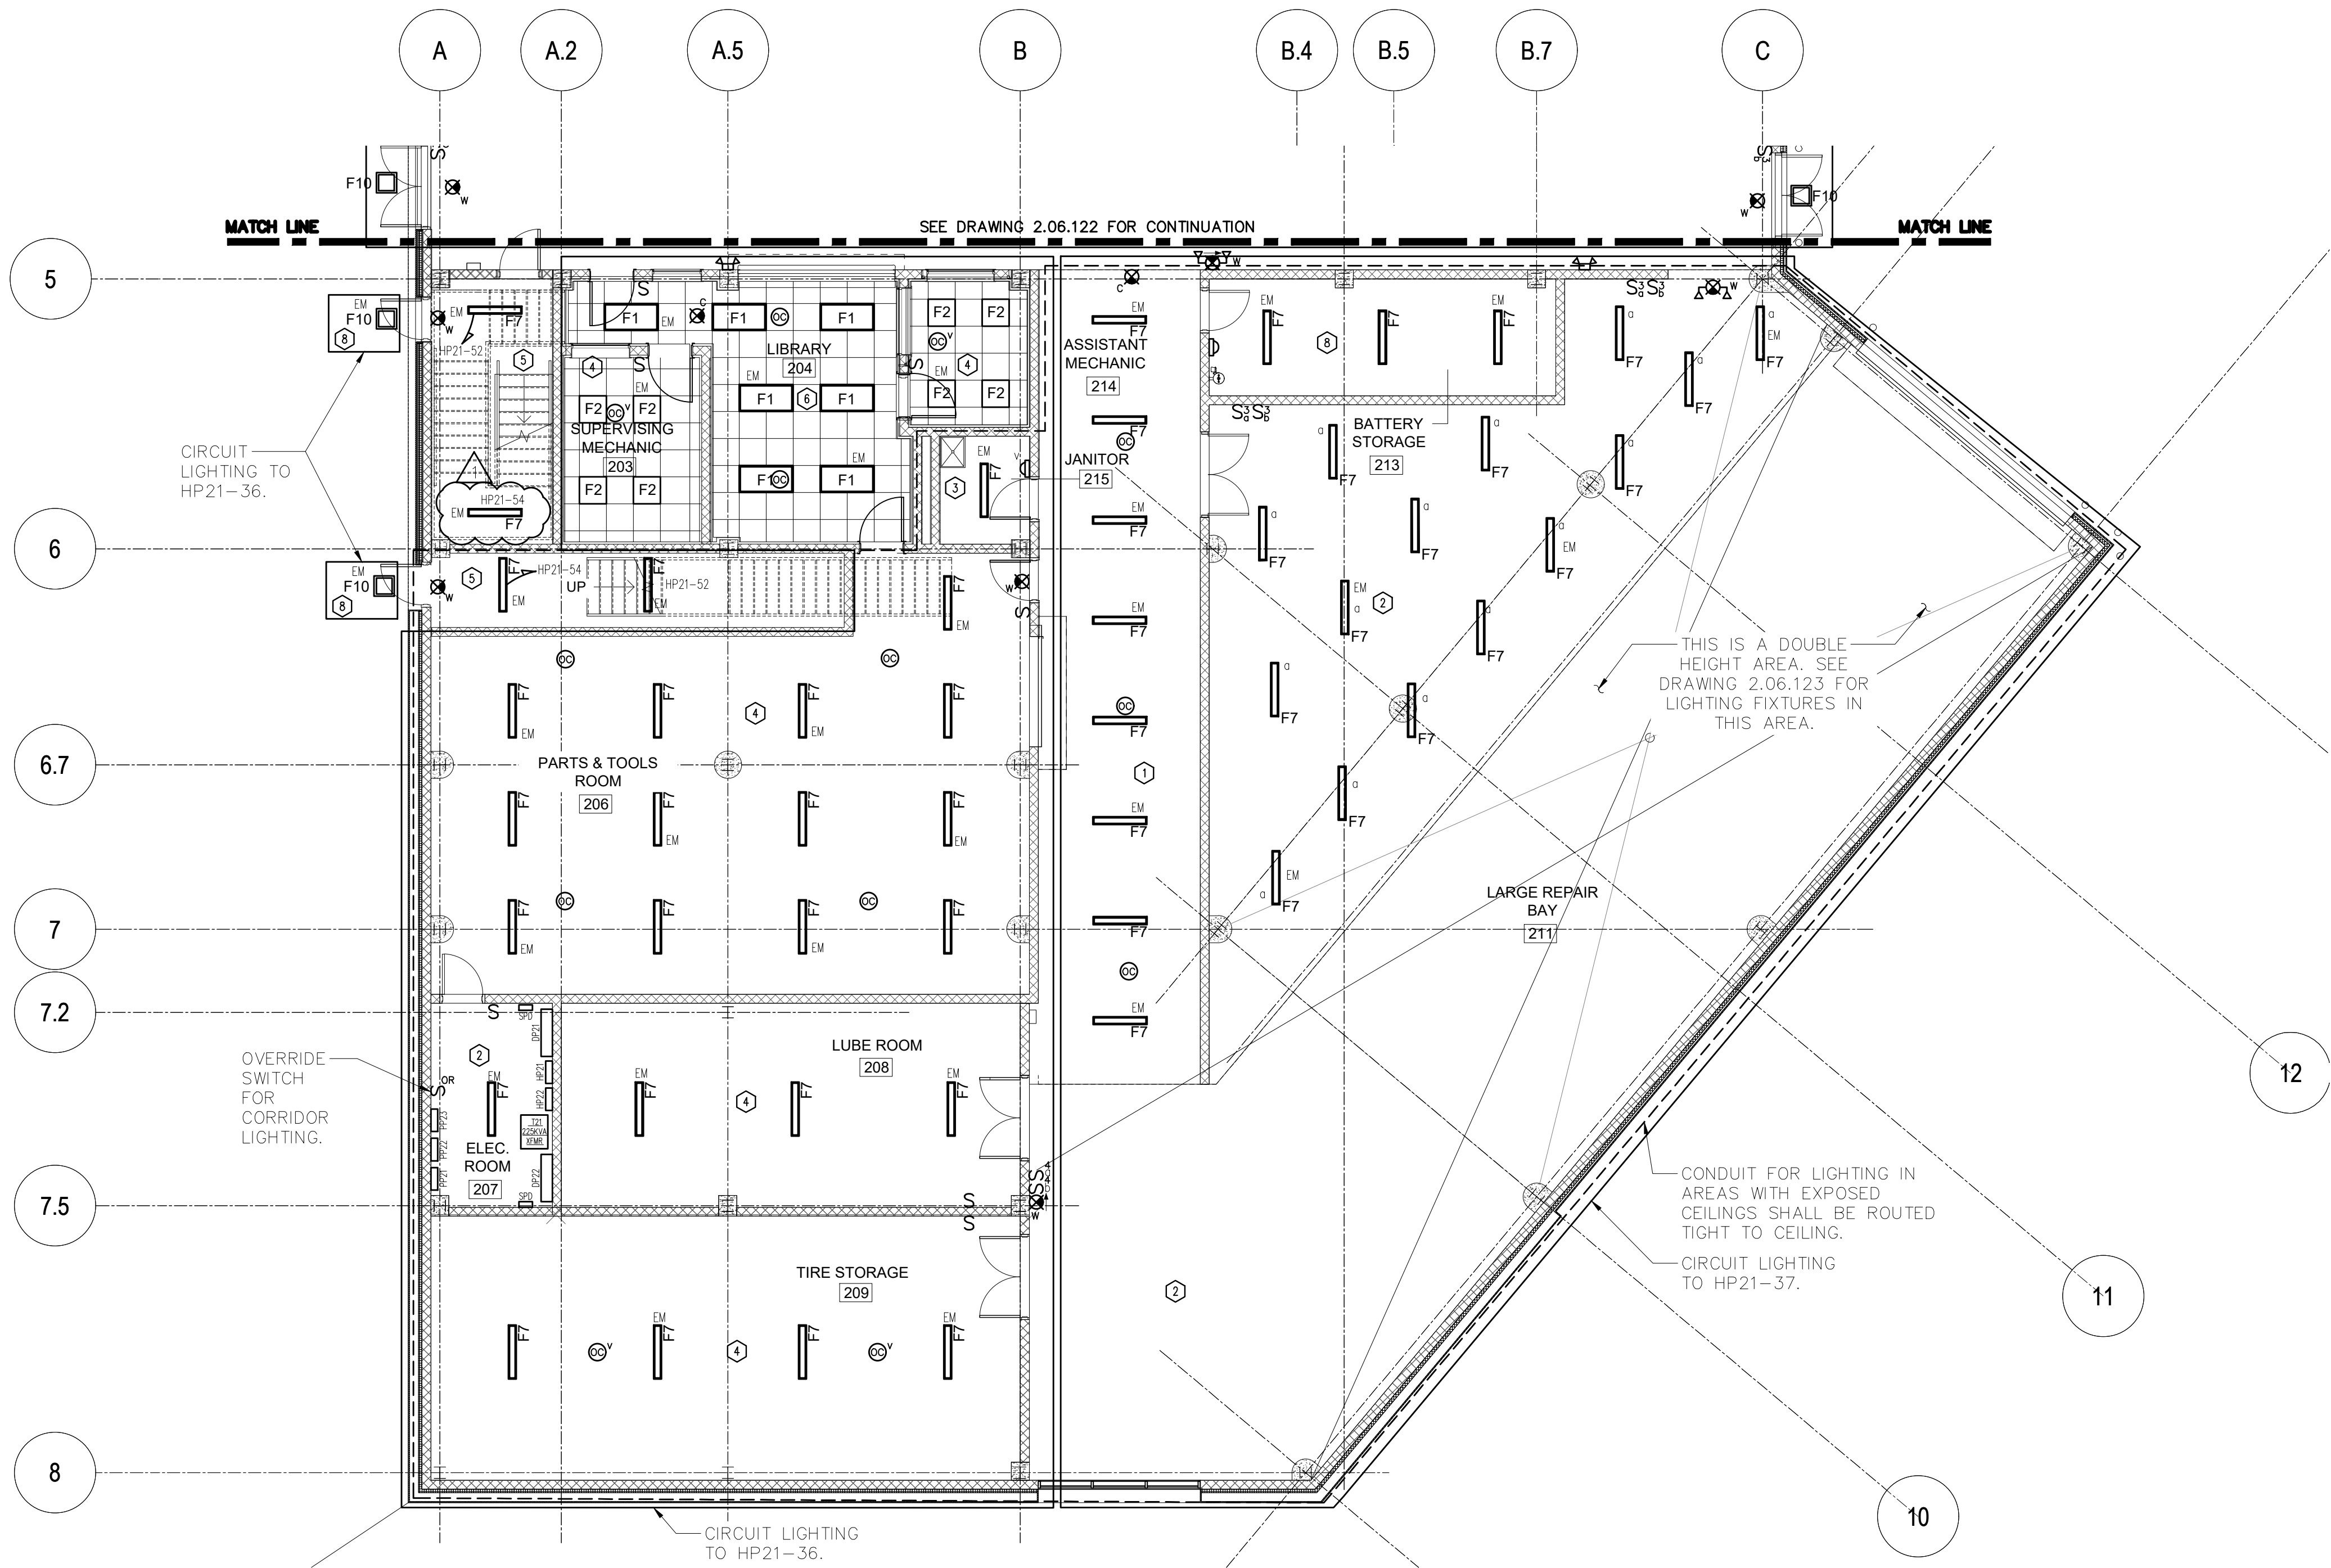


NOTES:

1.) SEE DRAWINGS 0.06.604 & 0.06.605 FOR LIGHTING FIXTURE SCHEDULE, LIGHTING CONTROL DESIGN INTENT & LIGHTING SYSTEM FUNCTIONAL TESTING/COMMISSIONING NOTES.

2.) LUBE ROOM 208 & LARGE REPAIR BAY 211 ARE CLASSIFIED AS HAZARDOUS CLASS 2, DIVISION 2 LOCATIONS UP TO 18" AFF. REFER TO DETAIL 4 ON DRAWING 2.06.503 FOR WIRING INFORMATION.

LIGHTING CONTROL LEGEND

- 1 - TIME CLOCK WITH OCCUPANCY SENSOR AFTER HOURS AND MANUAL OVERRIDE SWITCH.
- 2 - LINE VOLTAGE ON/OFF WALL SWITCHING.
- 3 - LOW VOLTAGE WALL SWITCH VACANCY SENSOR.
- 4 - LOW VOLTAGE MANUAL ON WALL SWITCH WITH CEILING MOUNT VACANCY.
- 5 - OCCUPANCY SENSOR TO 100%, AUTO DIMMED TO 50%.
- 6 - LOW VOLTAGE WALL SWITCH WITH CEILING MOUNTED OCCUPANCY SENSOR.
- 7 - LINE VOLTAGE WALL SWITCH WITH PILOT LIGHT.
- 8 - LOW VOLTAGE WALL SWITCH OCCUPANCY SENSOR.
- 9 - OUTDOOR PHOTOSENSOR CONTROL

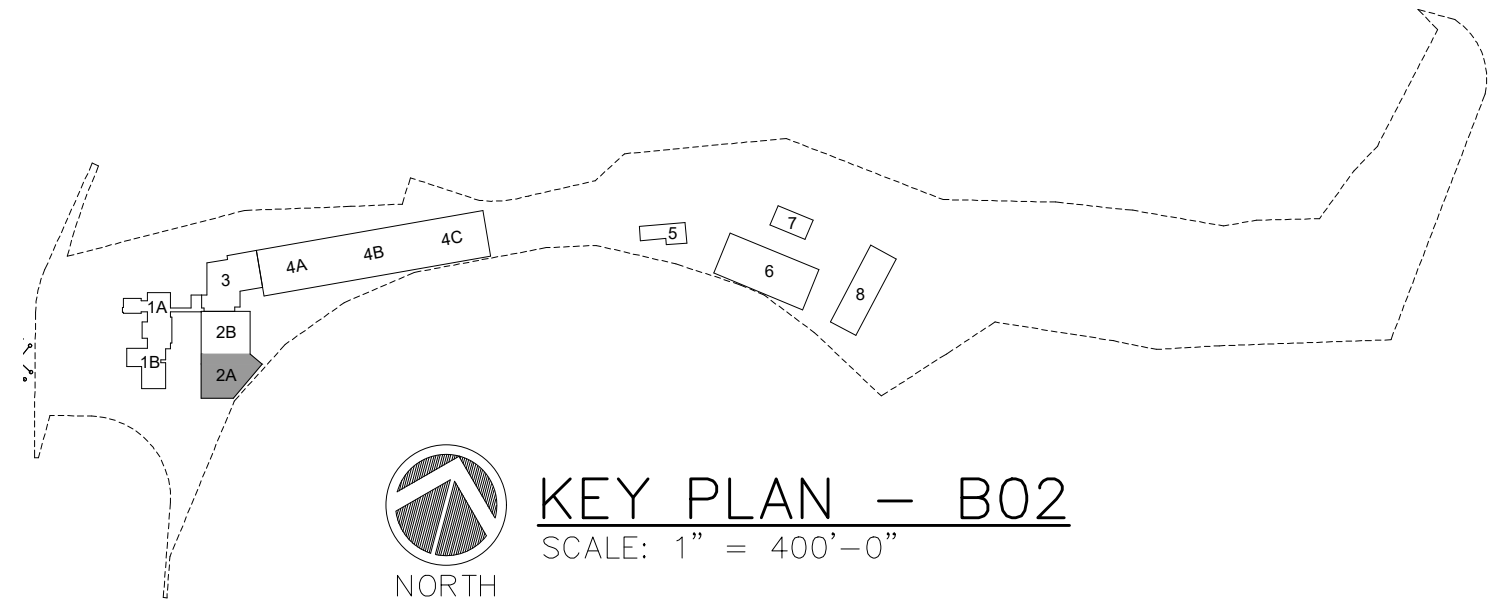

1 ELECTRICAL BUILDING 02 LIGHTING PART PLAN
SCALE: 1/8" = 1'-0"

WARNING - IT IS A VIOLATION OF NEW YORK STATE EDUCATIONAL LAW, SECTION 7209.2, FOR ANY PERSON, UNLESS HE IS ACTING UNDER THE DIRECTION OF A LICENSED PROFESSIONAL ENGINEER OR LAND SURVEYOR, TO ALTER THIS DOCUMENT IN ANY WAY. IF ALTERED, THE ALTERING PERSON SHALL COMPLY WITH THE REQUIREMENTS OF NEW YORK EDUCATIONAL LAW, SECTION 7209.2

COPYRIGHT © 2019, McLAREN ENGINEERING GROUP

CONSULTANTS ARCHITECT

STV 100 Years

STV Architects, P.C.
225 Park Avenue South
New York, NY 10003
(212) 777-4400 FAX: (212) 473-2780
www.stvinc.com

MEP ENGINEER

OLA Consulting Engineers

50 Broadway,
Hawthorne, NY 10532
914.747.2800

8 West 38th Street,
Suite 601
New York, NY 10018
646.648.4110

ola.com NMEG0050.00

FACILITIES CONSULTANT

Gannett Fleming

LANDSCAPE ARCHITECT

IQ

Imbiano-Quigley
Landscape Architects

31 Monmouth Ave., 7th Floor
White Plains, New York 10601
admin@iqlandscape.com
(914) 232-4090

PROJECT

COUNTY OF ROCKLAND
CAPITAL PROJECT NO. 1307
HIGHWAY DEPARTMENT /
EMERGENCY OPERATIONS FACILITY
COUNTY OF ROCKLAND, NEW YORK

McLaren ENGINEERING GROUP

applied ingenuity

M. G. McLaren Engineering
and Land Surveying P.C.

530 Chestnut Ridge Road, Woodcliff Lake, NJ 07677
T: 201.775.6000 F: 201.746.8522 www.mgmclaren.com

STATE OF NEW YORK

STEVEN ABBATISTA

REGISTERED PROFESSIONAL ENGINEER

077237

SHEET NAME

**ELECTRICAL BUILDING 02
LIGHTING PART PLAN**

No.	DATE	ADDENDUM 07 REVISION	BY
1	11/27/19		

PROJECT NO.	130439
SCALE	As indicated
DATE	OCTOBER 30, 2019
DRAWN BY	CT
CHECKED BY	ML
APPROVED BY	DS

ISSUED FOR	BID SET
DRAWING NO.	2.06.121
OF	SHTS