




- NOTES:**
- 1.) SEE DRAWINGS 0.06.604 & 0.06.605 FOR LIGHTING FIXTURE SCHEDULE, LIGHTING CONTROL DESIGN INTENT & LIGHTING SYSTEM FUNCTIONAL TESTING/COMMISSIONING NOTES.
 - 2.) WALL MOUNTED ELEVATOR LIGHT, WEATHERPROOF INCANDESCENT FIXTURE WITH RUGGED, SEAMLESS DIE CAST CONSTRUCTION, FACTORY ASSEMBLED WITH GUARD, AS MANUFACTURED BY APPLETON MODEL #WF10756, 120V, (1) 100W MED BASE INC LAMP OR APPROVED EQUAL.
 - 3.) ELEVATOR PIT LIGHTING FIXTURES SHALL BE CONNECTED TO THE LINE SIDE OF THE PIT GFI RECEPTACLE, CIRCUITED ON PP33-5.

- LIGHTING CONTROL LEGEND**
- 1 - TIME CLOCK WITH OCCUPANCY SENSOR OVERRIDE AFTER HOURS.
 - 2 - LINE VOLTAGE ON/OFF WALL SWITCHING.
 - 3 - LOW VOLTAGE WALL SWITCH VACANCY SENSOR.
 - 4 - LOW VOLTAGE MANUAL ON WALL SWITCH WITH CEILING MOUNT VACANCY.
 - 5 - LOW VOLTAGE WALL SWITCH WITH CEILING MOUNTED OCCUPANCY SENSOR.
 - 6 - OCCUPANCY SENSOR TO 100%, DIMMED AUTOMATICALLY TO 50%.
 - 7 - OUTDOOR PHOTOSENSOR CONTROL

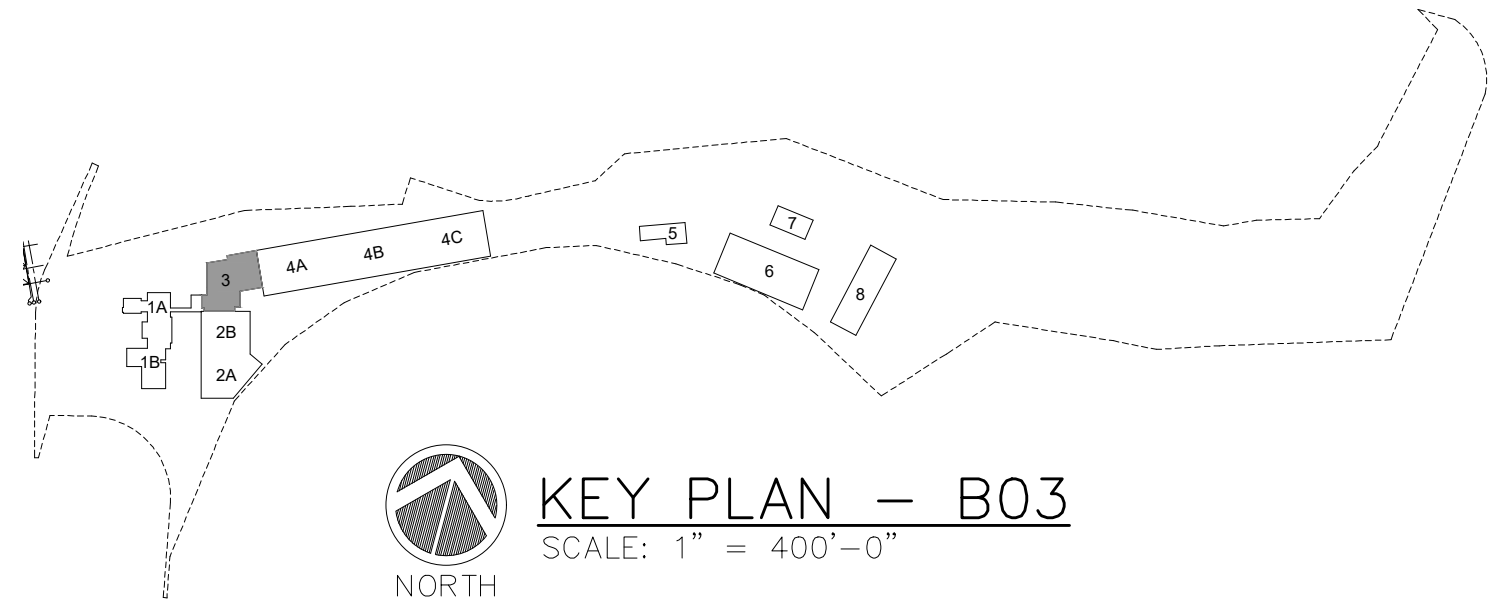

WARNING - IT IS A VIOLATION OF NEW YORK STATE EDUCATIONAL LAW, SECTION 7209.2, FOR ANY PERSON, UNLESS HE IS ACTING UNDER THE DIRECTION OF A LICENSED PROFESSIONAL ENGINEER OR LAND SURVEYOR, TO ALTER THIS DOCUMENT IN ANY WAY. IF ALTERED, THE ALTERING PERSON SHALL COMPLY WITH THE REQUIREMENTS OF NEW YORK EDUCATIONAL LAW, SECTION 7209.2

STV 100 Years
STV Architects, P.C.
225 Park Avenue South
New York, NY 10003
(212) 777-4400 FAX: (212) 473-2780
www.stvinc.com


OLA Consulting Engineers
50 Broadway,
Hawthorne, NY 10532
914.747.2800
8 West 38th Street,
Suite 601
New York, NY 10018
646.648.4110
ola.com NMEG0050.00

Gannett Fleming
FACILITIES CONSULTANT

IQ
Imbiano-Quigley
Landscape Architects
31 Montross Ave., 7th Floor
White Plains, New York 10601
admin@iqlandscape.com
(914) 232-4090

**COUNTY OF ROCKLAND
CAPITAL PROJECT NO. 1307
HIGHWAY DEPARTMENT /
EMERGENCY OPERATIONS FACILITY
COUNTY OF ROCKLAND, NEW YORK**

McLaren
ENGINEERING GROUP
applied ingenuity
M. G. McLaren Engineering
and Land Surveying P.C.
530 Chestnut Ridge Road, Woodcliff Lake, NJ 07677
T: 201.775.6000 F: 201.746.8522 www.mgmclaren.com

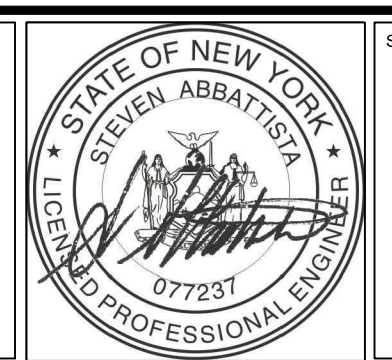

**ELECTRICAL BUILDING 03
LIGHTING PLAN**

PROJECT NO. 130439		ISSUED FOR BID SET	
SCALE As indicated		DRAWING NO. 3.06.121	
DATE OCTOBER 30, 2019		OF SHTS	
DRAWN BY CT			
CHECKED BY ML			
APPROVED BY DS			
1	11/27/19	ADDENDUM 07	VB
No.	DATE	REVISION	BY