


FILE NAME: I:\Projects\MEG\NMEG0050.00.Dwg 3.06-131-2.dwg PLOT TIME: Wed, 27 Nov 2019 - 3:30pm LAST SAVE: Wed, 27 Nov 2019 - 3:25pm BY: vbez

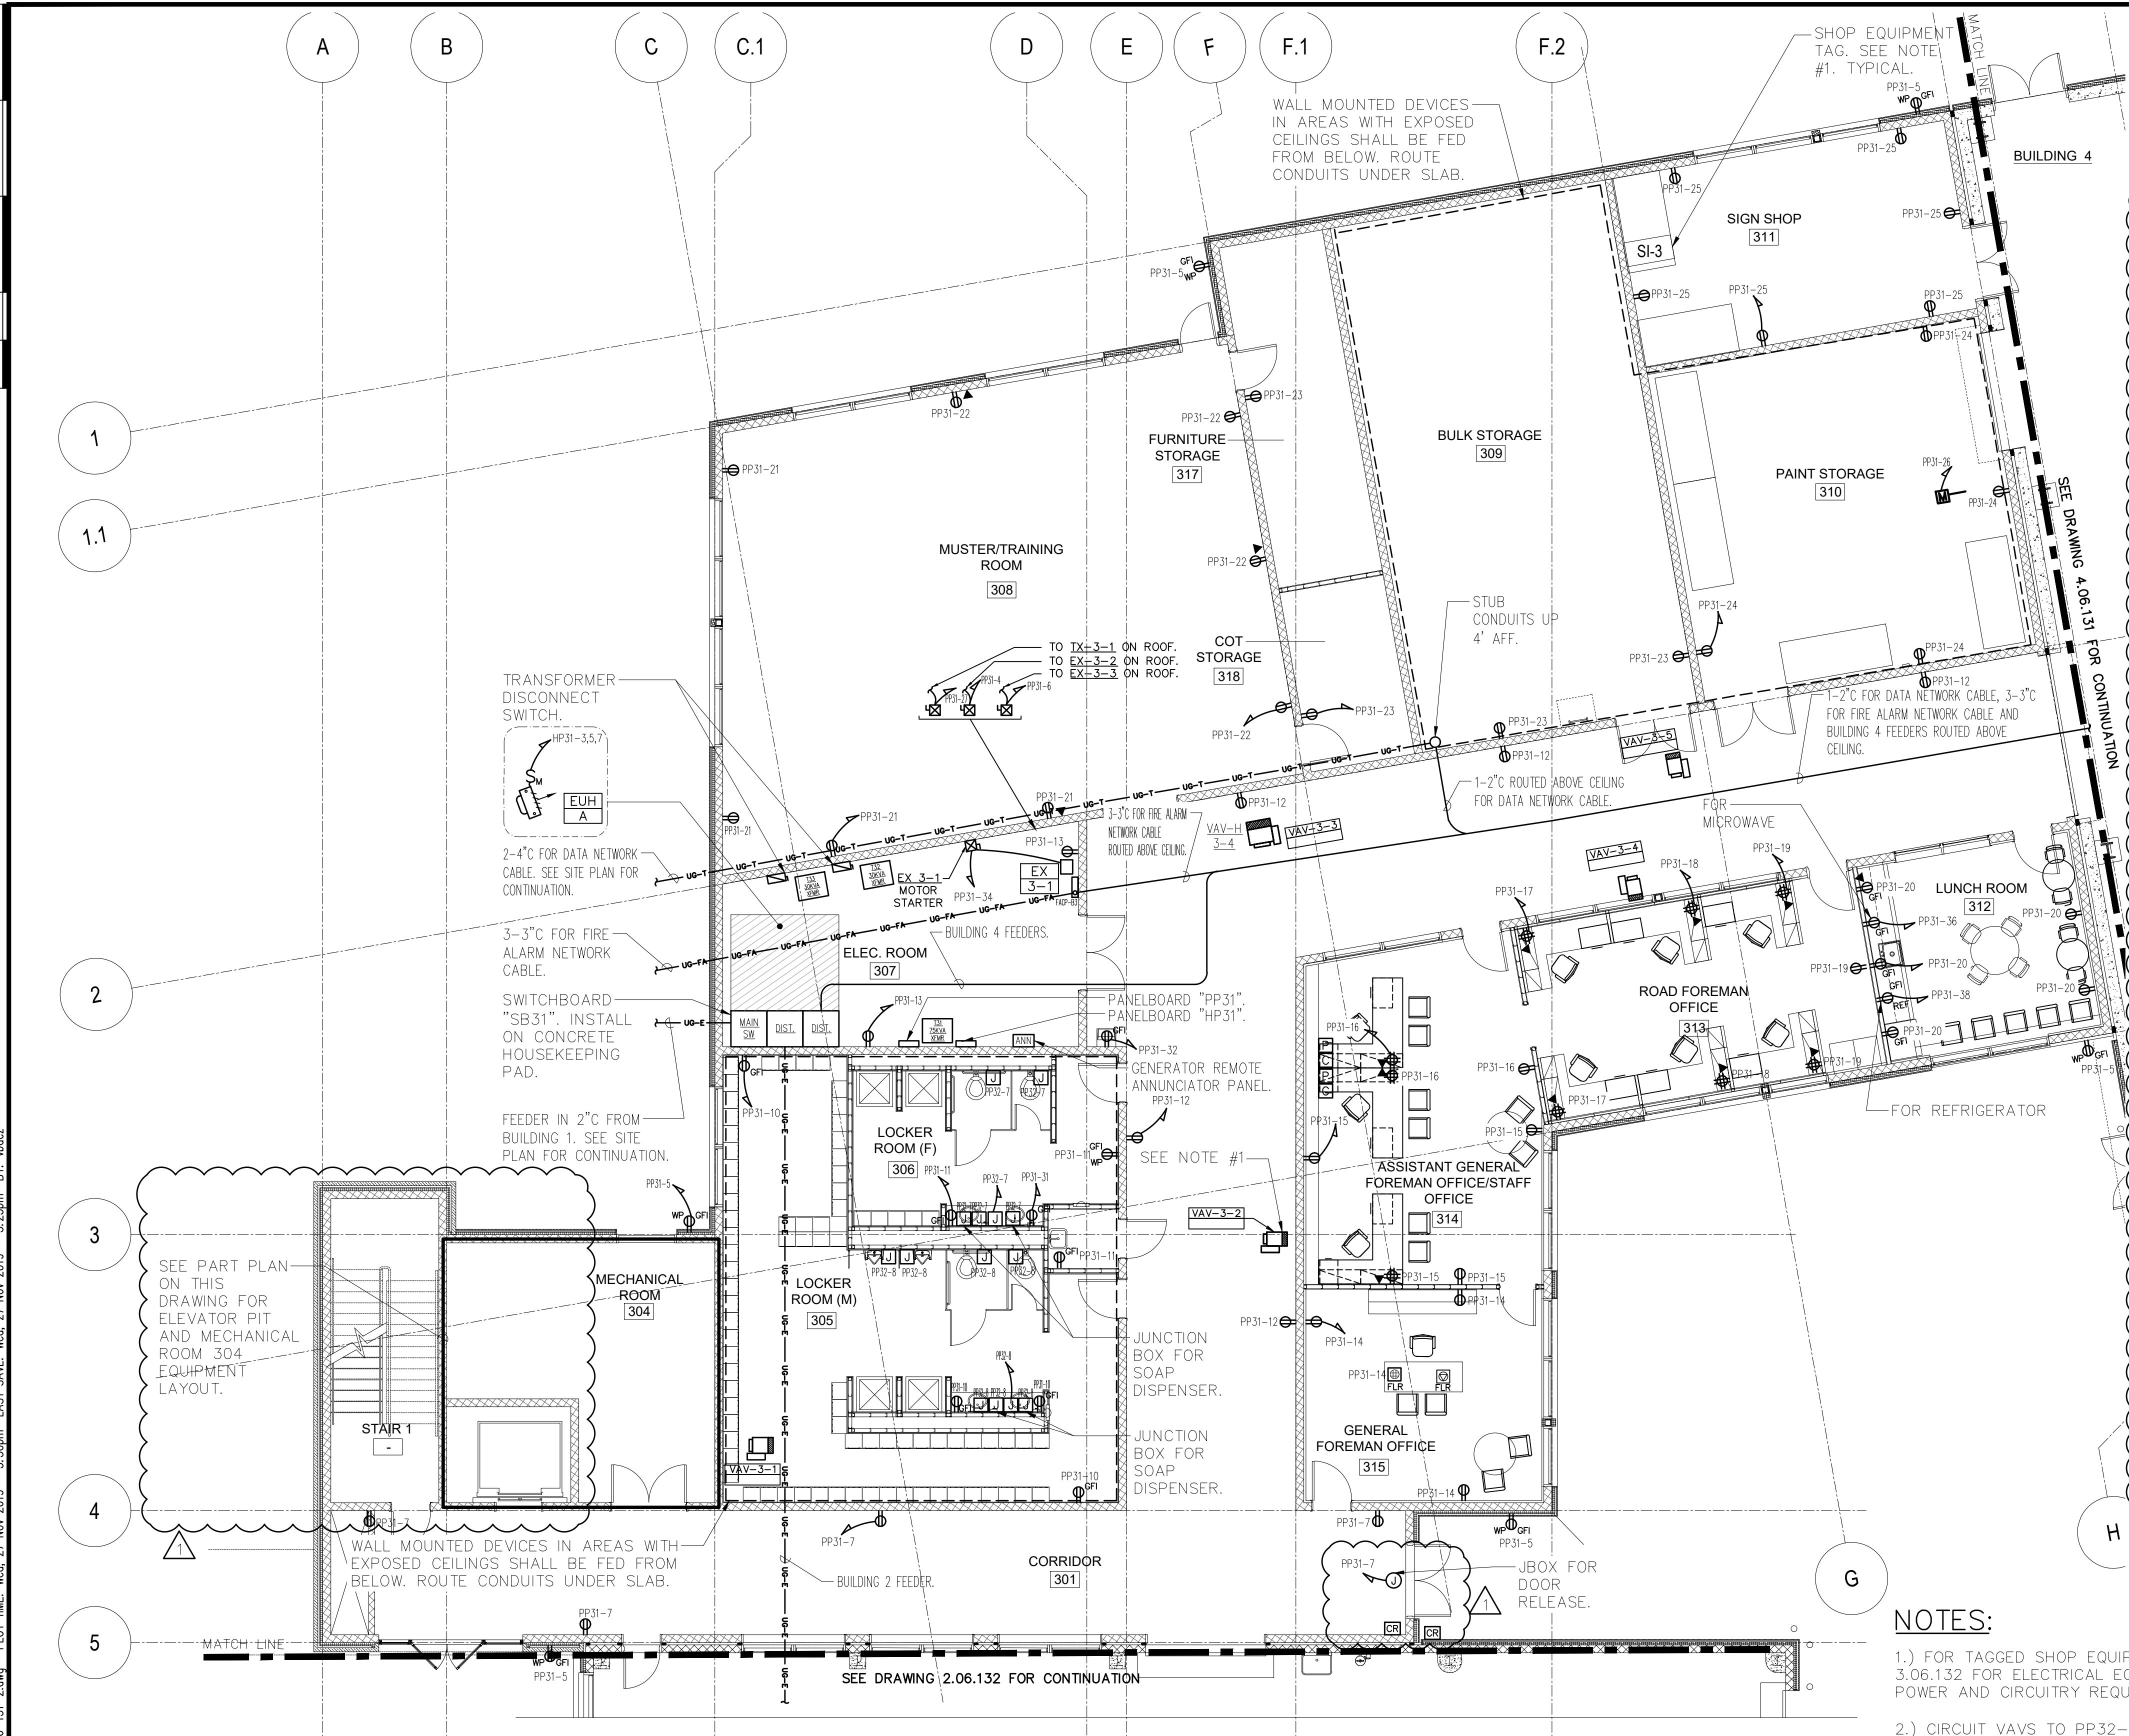

WARNING - IT IS A VIOLATION OF NEW YORK STATE EDUCATIONAL LAW, SECTION 7209.2, FOR ANY PERSON, UNLESS HE IS ACTING UNDER THE DIRECTION OF A LICENSED PROFESSIONAL ENGINEER OR LAND SURVEYOR, TO ALTER THIS DOCUMENT IN ANY WAY. IF ALTERED, THE ALTERING PERSON SHALL COMPLY WITH THE REQUIREMENTS OF NEW YORK EDUCATIONAL LAW, SECTION 7209.2

COPYRIGHT © 2019, McLAREN ENGINEERING GROUP

CONSULTANTS ARCHITECT

STV 100 Years

STV Architects, P.C.
225 Park Avenue South
New York, NY 10003
(212) 777-4400 FAX: (212) 473-2780
www.stvinc.com

MEP ENGINEER

OLA Consulting Engineers

50 Broadway,
Hawthorne, NY 10532
914.747.2800

8 West 38th Street,
Suite 601
New York, NY 10018
646.848.4110
ola.com NMEG0050.00

FACILITIES CONSULTANT

Gannett Fleming

LANDSCAPE ARCHITECT

IQ

Imbiano-Quigley
Landscape Architects

31 Montemore Ave., 7th Floor
White Plains, New York 10601
admin@iqlandscape.com
(914) 232-4000

PROJECT


COUNTY OF ROCKLAND
CAPITAL PROJECT NO. 1307
HIGHWAY DEPARTMENT /
EMERGENCY OPERATIONS FACILITY
COUNTY OF ROCKLAND, NEW YORK

McLaren ENGINEERING GROUP

applied ingenuity

M. G. McLaren Engineering
and Land Surveying P.C.

530 Chestnut Ridge Road, Woodcliff Lake, NJ 07677
T: 201.775.6000 F: 201.746.8522 www.mgmclaren.com

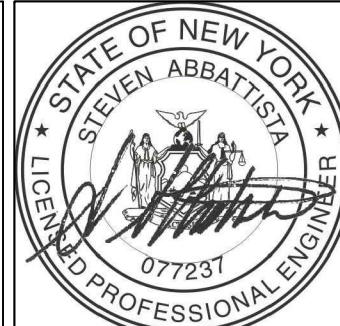

SHEET NAME

**ELECTRICAL BUILDING 03
POWER PLAN**

1	11/27/19	ADDENDUM 07	VB
No.	DATE	REVISION	BY

PROJECT NO. 130439

SCALE As indicated

DATE OCTOBER 30, 2019

DRAWN BY CT


CHECKED BY ML

APPROVED BY DS


ISSUED FOR **BID SET**

DRAWING NO. **3.06.131**

OF SHTS

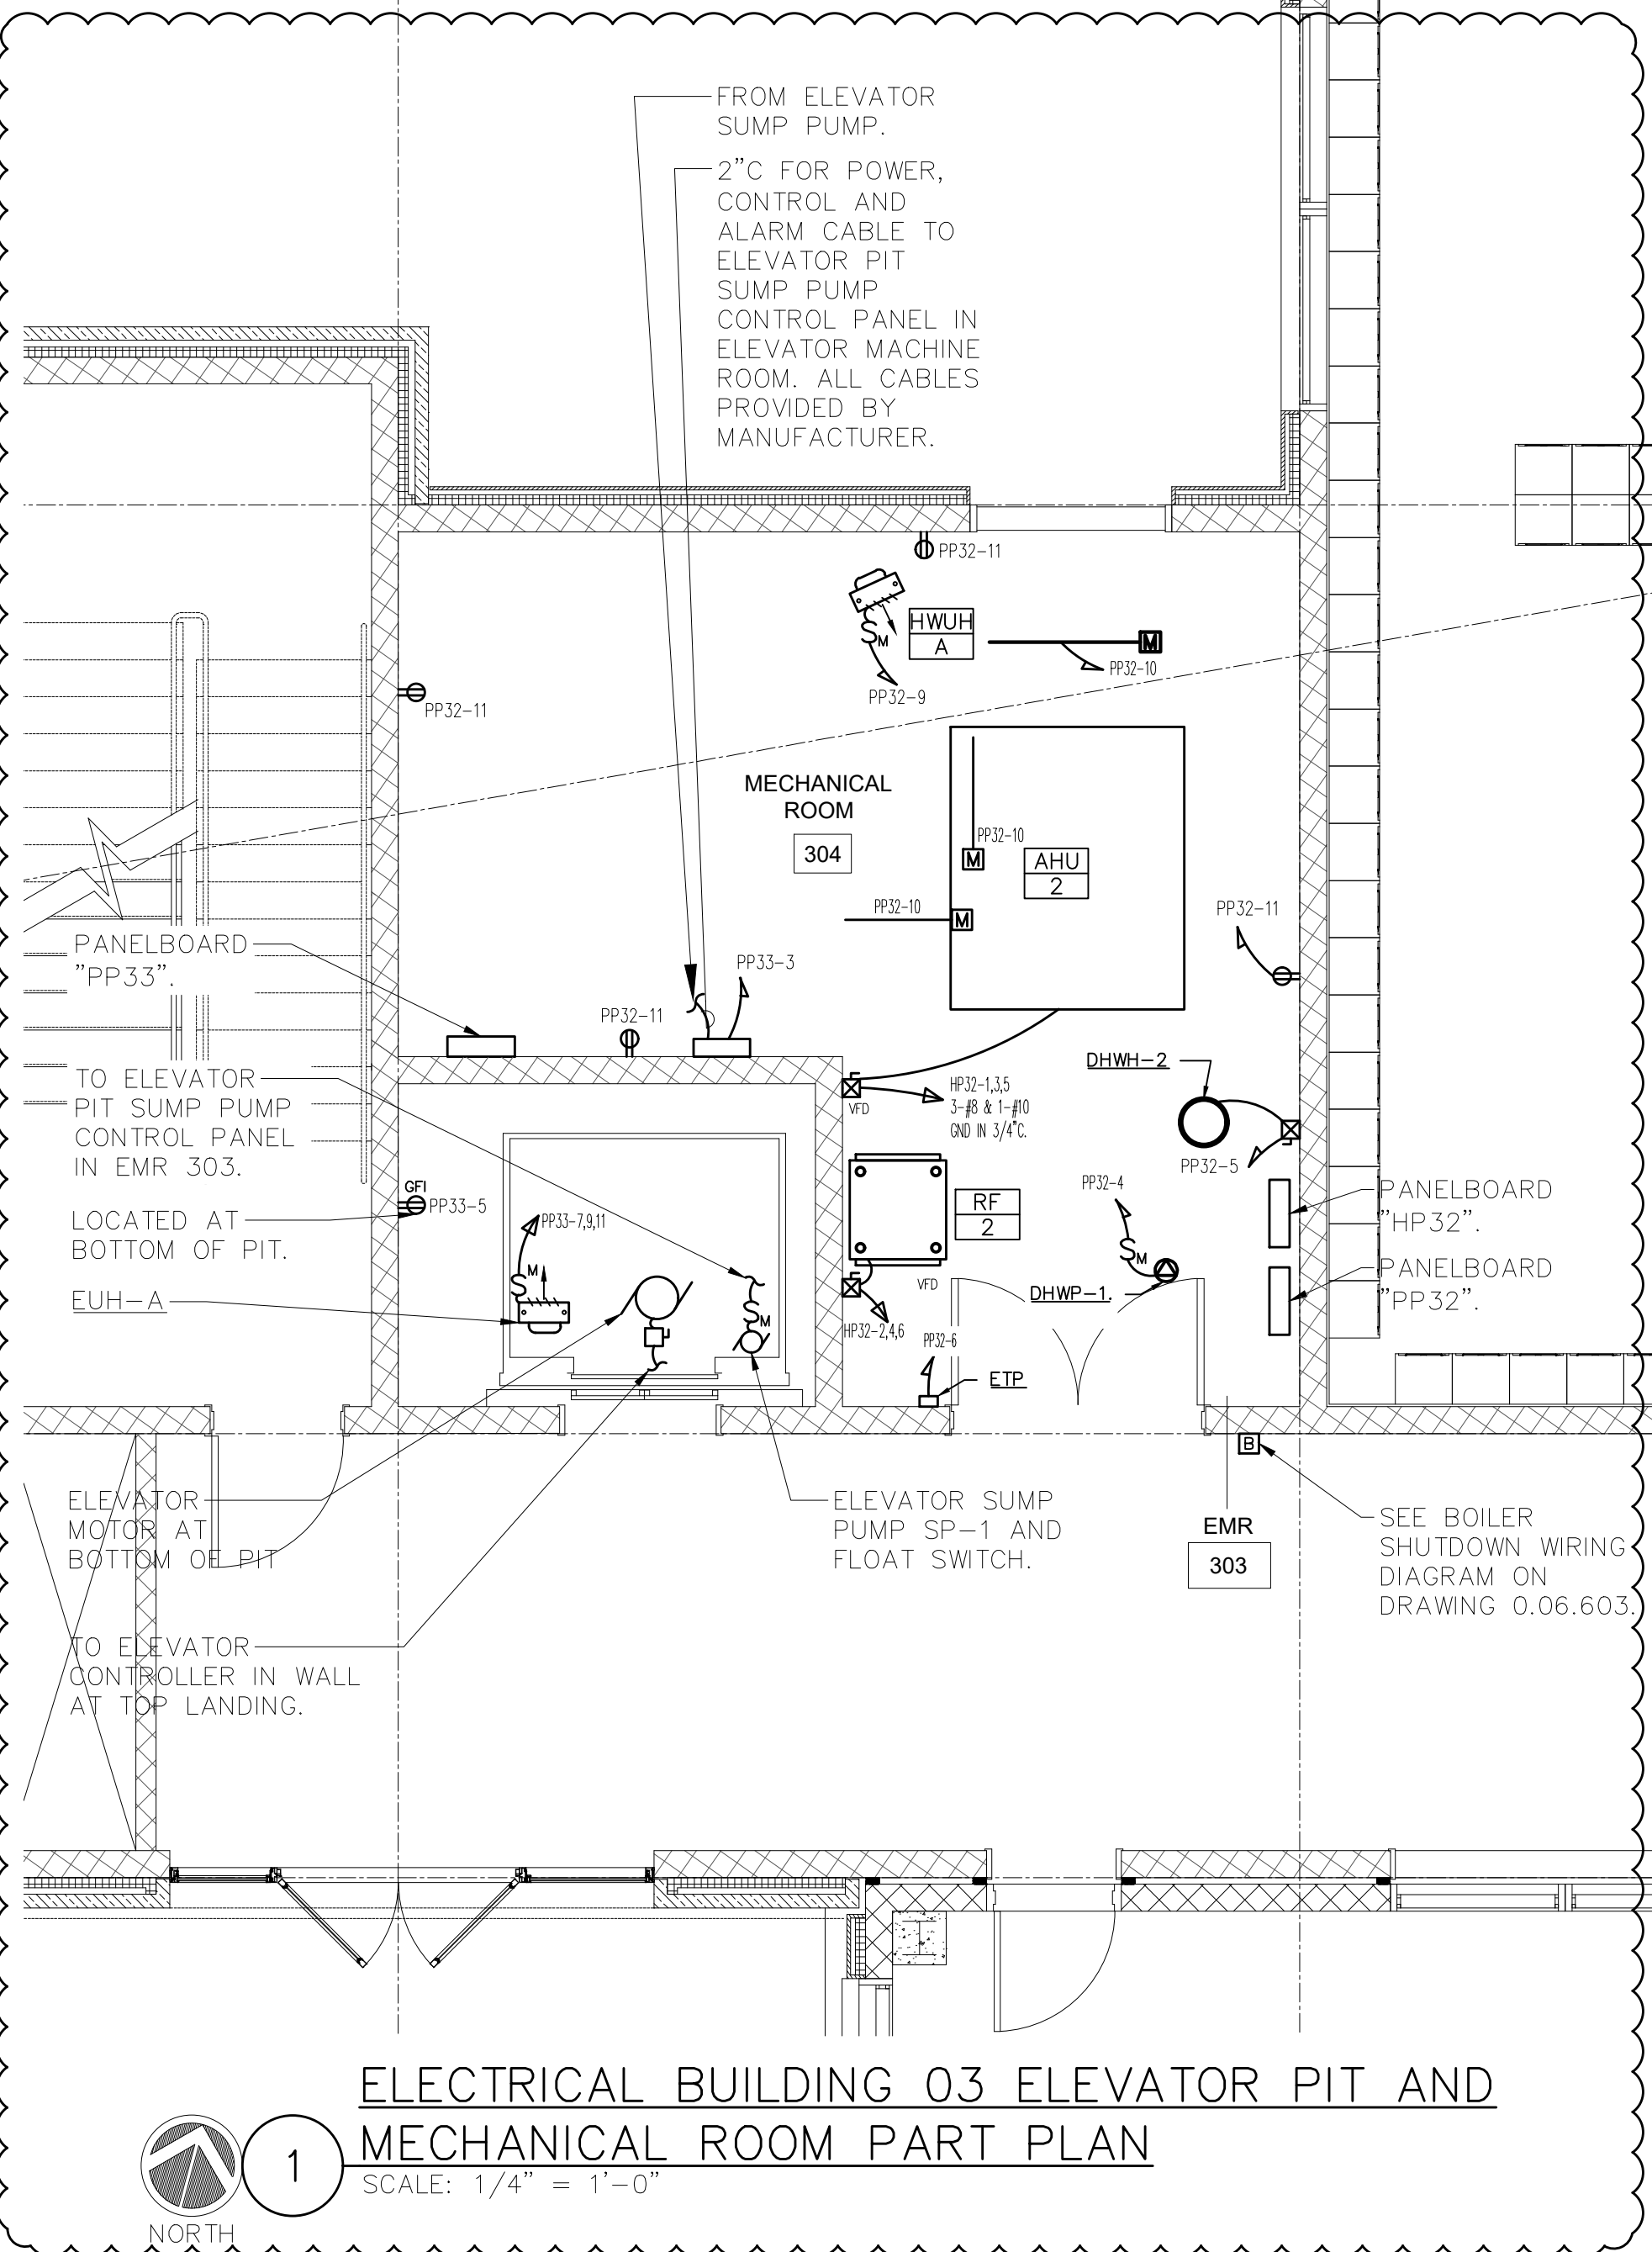

**ELECTRICAL BUILDING 03 ELEVATOR PIT AND
MECHANICAL ROOM PART PLAN**
SCALE: 1/4" = 1'-0"

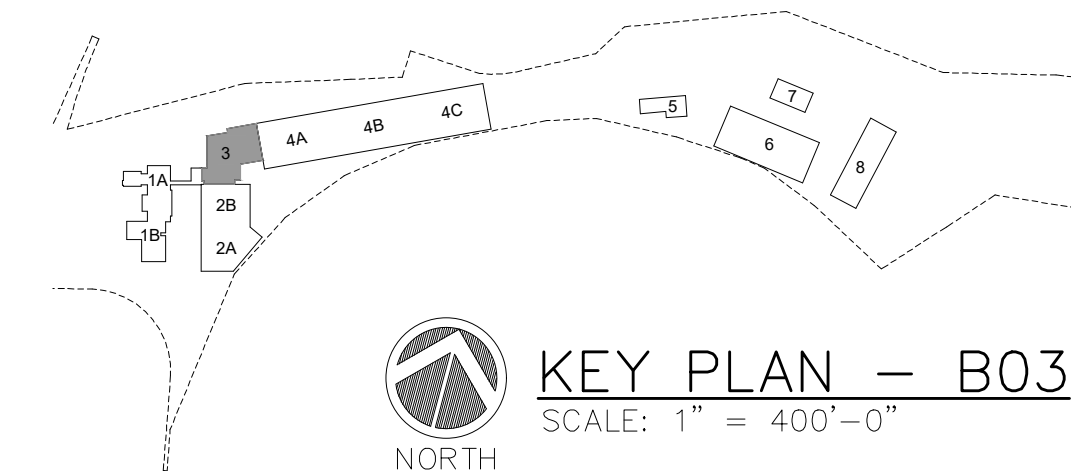

KEY PLAN - B03
SCALE: 1" = 400'-0"

NOTES:

- 1.) FOR TAGGED SHOP EQUIPMENT, SEE DRAWING 3.06.132 FOR ELECTRICAL EQUIPMENT SCHEDULE FOR POWER AND CIRCUITRY REQUIREMENTS.
- 2.) CIRCUIT VAVS TO PP32-1.
- 3.) RECEPTACLES AND WALL MOUNTED DEVICES IN BULK STORAGE 309, PAINT STORAGE 310 AND SIGN SHOP 311 SHALL BE MOUNTED AT 48" AFF MIN.