
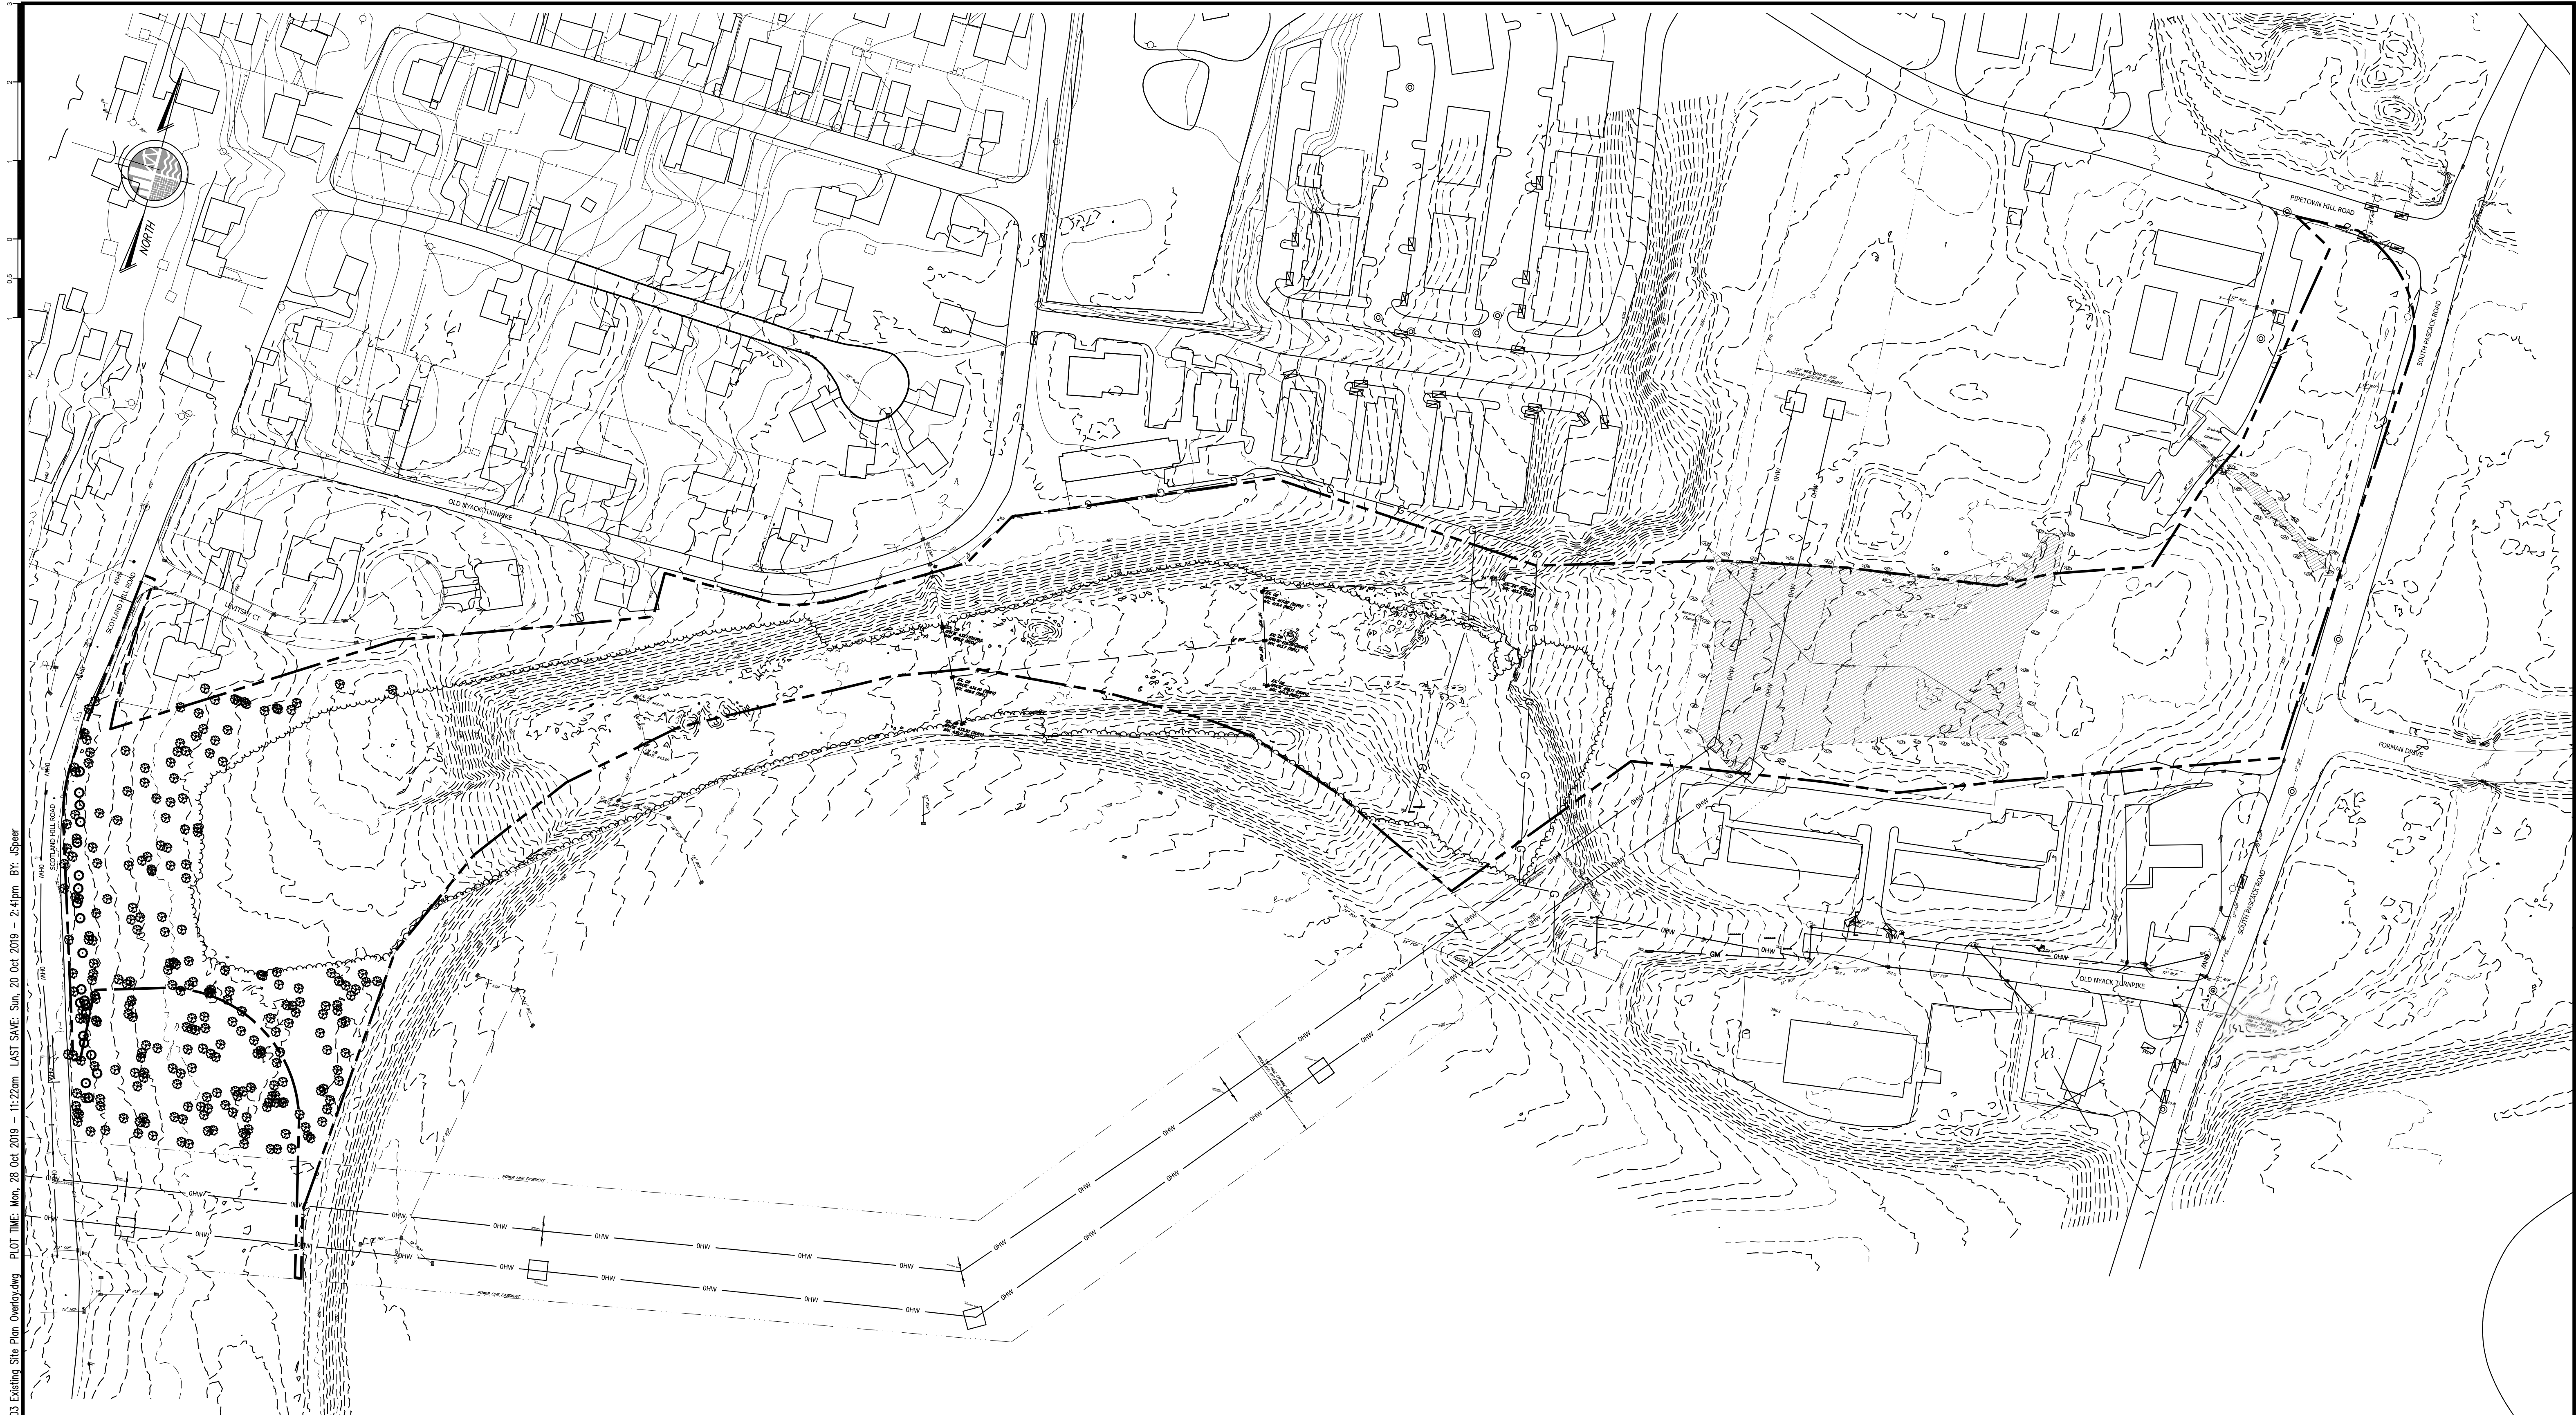



WARNING - IT IS A VIOLATION OF NEW YORK STATE EDUCATIONAL LAW, SECTION 7205.2, FOR ANY PERSON, UNLESS HE OR SHE IS ACTING UNDER THE DIRECTION OF A LICENSED PROFESSIONAL ENGINEER OR LAND SURVEYOR, TO ALTER THIS DOCUMENT IN ANY WAY. IF ALTERED, THE ALTERING PERSON SHALL COMPLY WITH THE REQUIREMENTS OF NEW YORK EDUCATIONAL LAW, SECTION 7205.3.

COPYRIGHT © 2019, McLAREN ENGINEERING GROUP

CONSULTANTS ARCHITECT STV Architects, P.C. 225 Park Avenue South New York, NY 10003 (212) 777-4400 FAX: (212) 473-2780 www.stvinc.com		MEP ENGINEER OLA Consulting Engineers 60 Broadway, Hawthorne, New York 10522 914.747.2800 12 East 49th Street, 11th Fl. New York, NY 10017 646.846.4110 olace.com		FACILITIES CONSULTANT Gannett Fleming		LANDSCAPE ARCHITECT Imbiano-Quigley Landscape Architects 31 Montross Ave., 7th Floor White Plains, New York 10601 admin@iqlandscape.com (914) 232-4090		PROJECT COUNTY OF ROCKLAND CAPITAL PROJECT NO. 1307 HIGHWAY DEPARTMENT / EMERGENCY OPERATIONS FACILITY COUNTY OF ROCKLAND, NEW YORK		McLaren ENGINEERING GROUP M. G. McLaren Engineering and Land Surveying P.C. 530 Chestnut Ridge Road, Woodcliff Lake, NJ 07677 T: 201.775.8000 F: 201.746.8522 www.mgmclaren.com		SEAL		SHEET NAME EXISTING PLAN OVERVIEW		<table><tr><td>No.</td><td>DATE</td><td>REVISION</td><td>BY</td></tr><tr><td> </td><td> </td><td> </td><td> </td></tr><tr><td> </td><td> </td><td> </td><td> </td></tr><tr><td> </td><td> </td><td> </td><td> </td></tr><tr><td> </td><td> </td><td> </td><td> </td></tr><tr><td> </td><td> </td><td> </td><td> </td></tr><tr><td> </td><td> </td><td> </td><td> </td></tr><tr><td> </td><td> </td><td> </td><td> </td></tr><tr><td> </td><td> </td><td> </td><td> </td></tr><tr><td> </td><td> </td><td> </td><td> </td></tr></table>		No.	DATE	REVISION	BY																																					<table><tr><td>PROJECT NO.</td><td>130439</td><td>ISSUED FOR</td><td>BID SET</td></tr><tr><td>SCALE</td><td>AS NOTED</td><td>DRAWING NO.</td><td>0.01.003</td></tr><tr><td>DATE</td><td>OCTOBER 30, 2019</td><td>CHECKED BY</td><td>JMS</td></tr><tr><td>DRAWN BY</td><td>ORR</td><td>APPROVED BY</td><td> </td></tr></table>		PROJECT NO.	130439	ISSUED FOR	BID SET	SCALE	AS NOTED	DRAWING NO.	0.01.003	DATE	OCTOBER 30, 2019	CHECKED BY	JMS	DRAWN BY	ORR	APPROVED BY		<table><tr><td>4</td><td>of</td><td>377</td><td>SHTS</td></tr></table>		4	of	377	SHTS
No.	DATE	REVISION	BY																																																																														
PROJECT NO.	130439	ISSUED FOR	BID SET																																																																														
SCALE	AS NOTED	DRAWING NO.	0.01.003																																																																														
DATE	OCTOBER 30, 2019	CHECKED BY	JMS																																																																														
DRAWN BY	ORR	APPROVED BY																																																																															
4	of	377	SHTS																																																																														

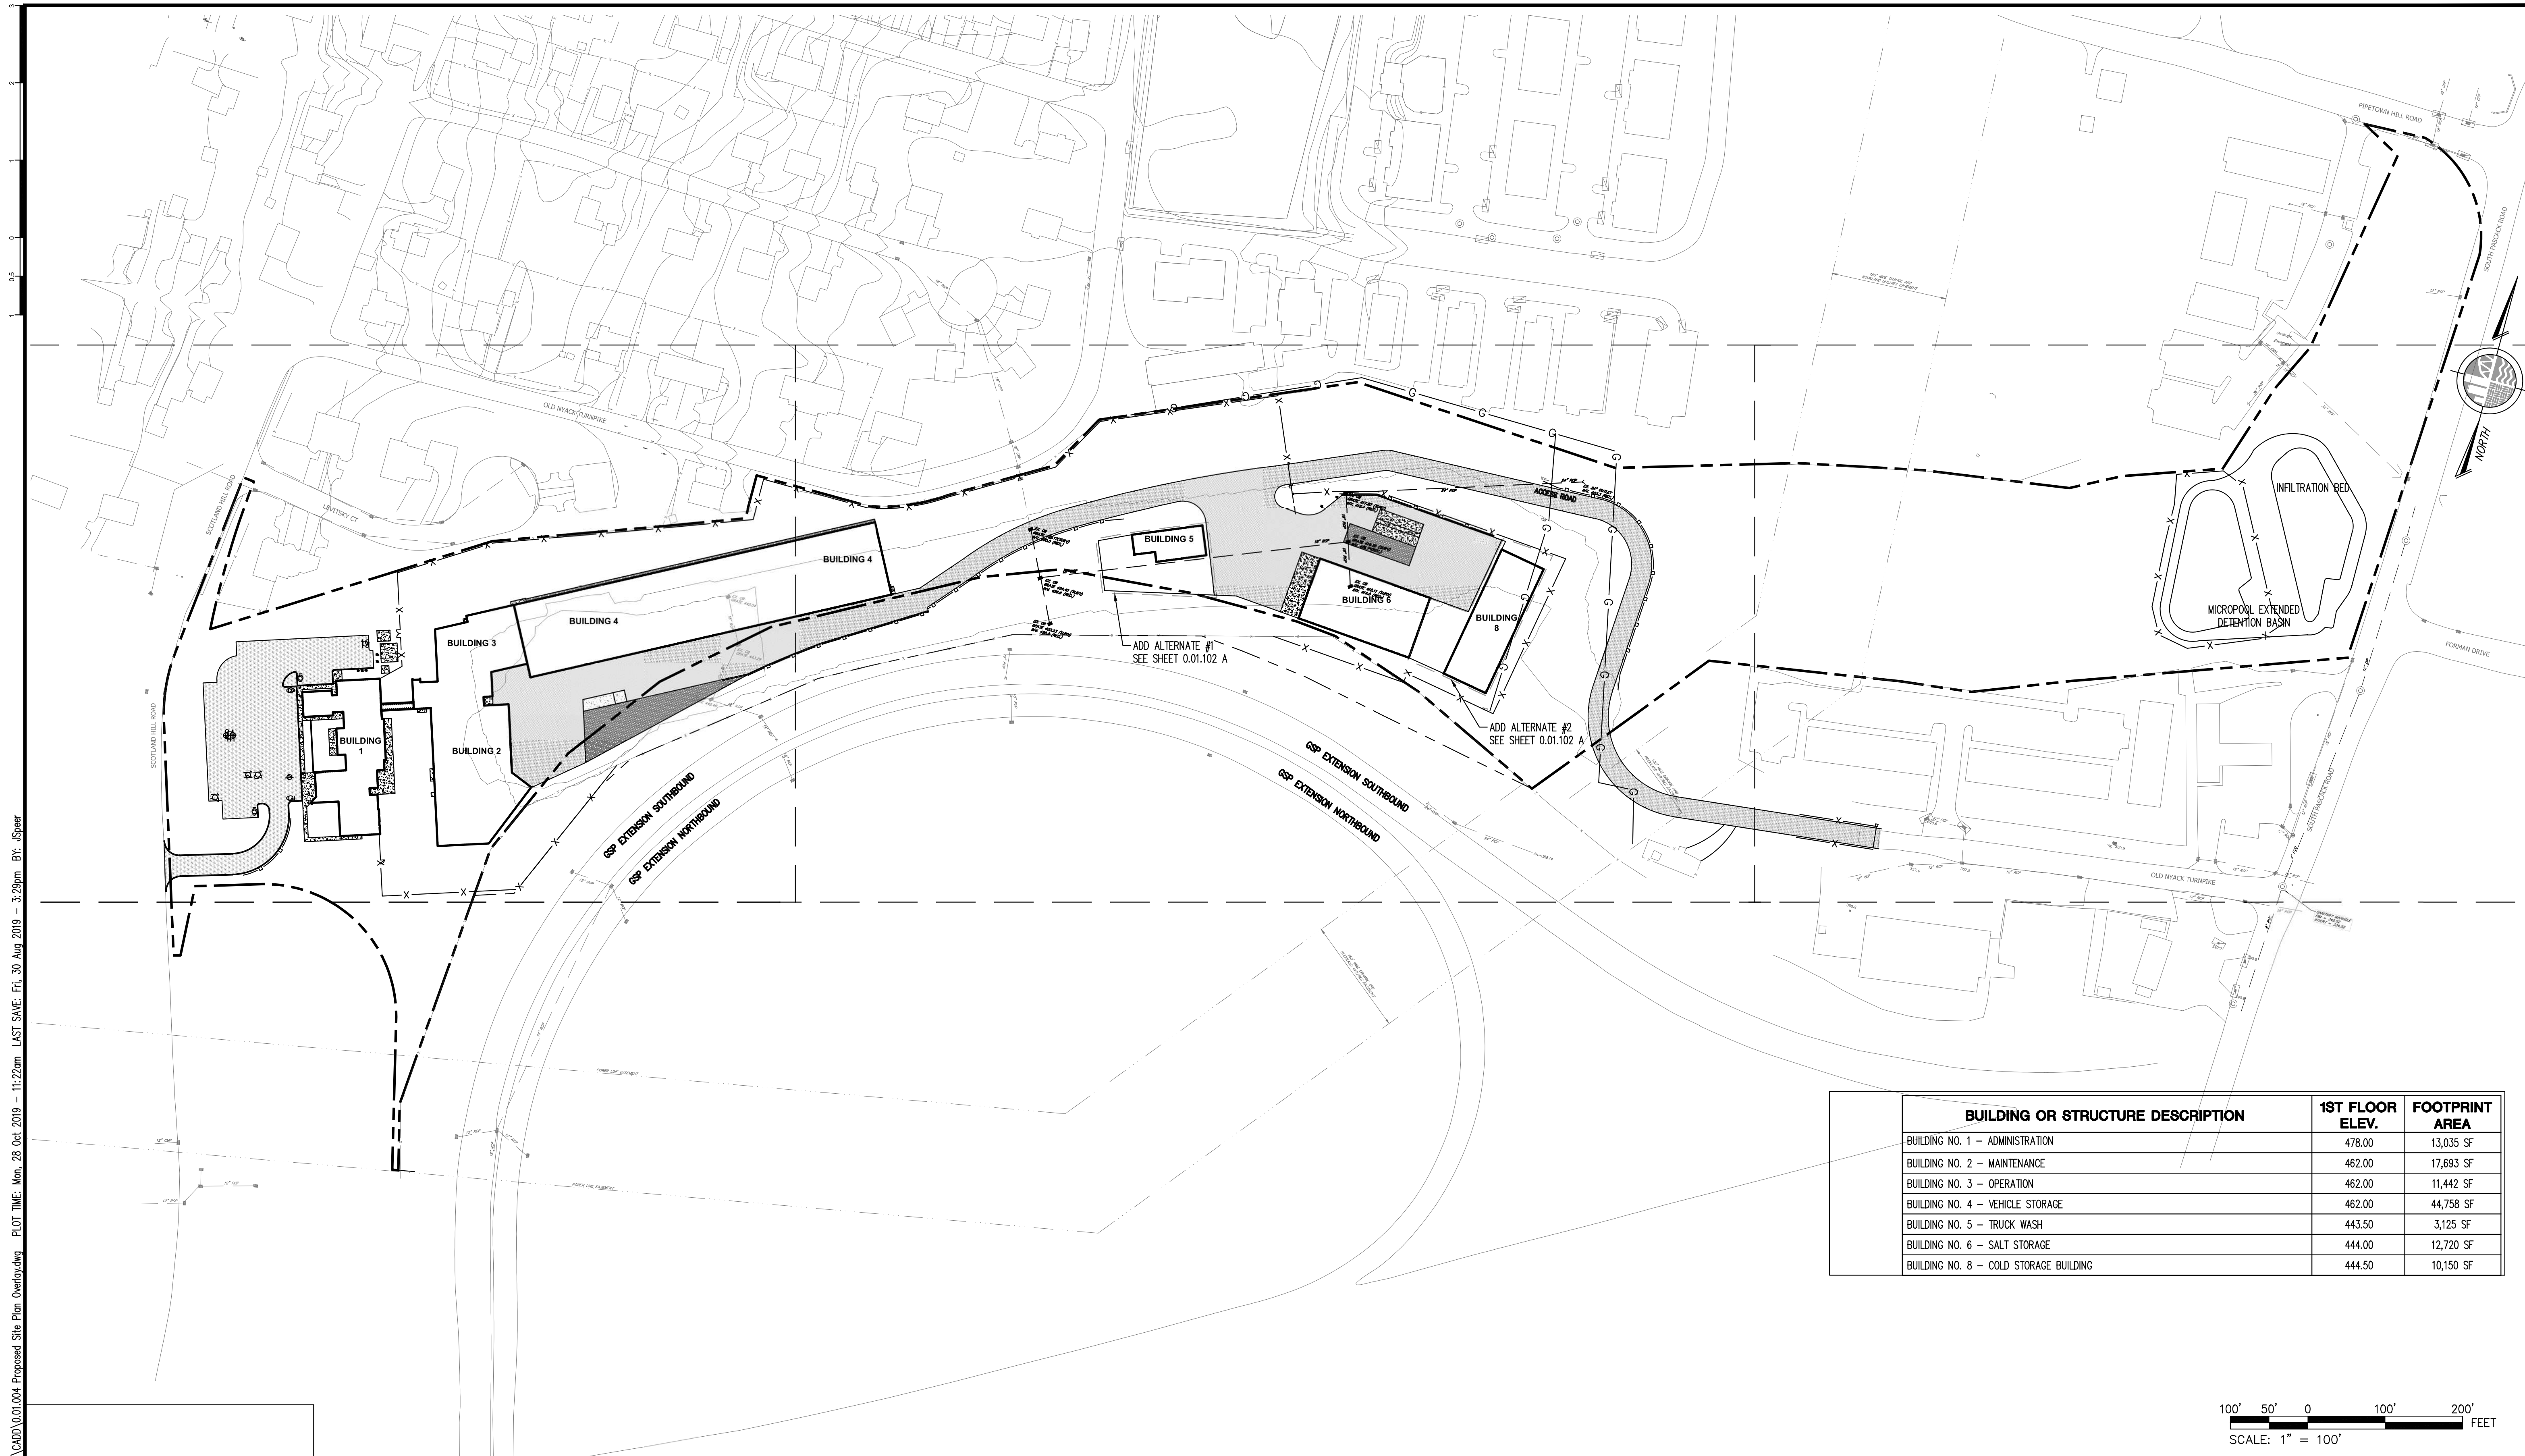



BUILDING OR STRUCTURE DESCRIPTION	1ST FLOOR ELEV.	FOOTPRINT AREA
BUILDING NO. 1 – ADMINISTRATION	478.00	13,035 SF
BUILDING NO. 2 – MAINTENANCE	462.00	17,693 SF
BUILDING NO. 3 – OPERATION	462.00	11,442 SF
BUILDING NO. 4 – VEHICLE STORAGE	462.00	44,758 SF
BUILDING NO. 5 – TRUCK WASH	443.50	3,125 SF
BUILDING NO. 6 – SALT STORAGE	444.00	12,720 SF
BUILDING NO. 8 – COLD STORAGE BUILDING	444.50	10,150 SF

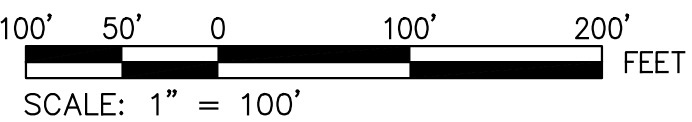

FILE NAME: P:\Proj\30\130439\10_Dwas\CADD\0.01.004 Proposed Site Plan Overlay.dwg PLOT TIME: Mon, 28 Oct 2019 - 11:22am LAST SAVE: Fri, 30 Aug 2019 - 3:29pm BY: JSpeer

 COPYRIGHT © 2019, McLAREN ENGINEERING GROUP

CONSULTANTS ARCHITECT  STV Architects, P.C. 225 Park Avenue South New York, NY 10003 (212) 777-4400 FAX: (212) 473-2780 www.stvinc.com	MEP ENGINEER  OLA Consulting Engineers 50 Broadway, Hawthorne, New York 10522 914.747.2800 12 East 49th Street, 11th Fl. New York, NY 10017 646.844.4170 admin@olaindarch.com olacoe.com	FACILITIES CONSULTANT  Gannett Fleming	LANDSCAPE ARCHITECT  IQ Imbiano-Quigley Landscape Architects 31 Manurecock Ave., 7th Floor White Plains, New York 10601 admin@iqlandscape.com (914) 213-0200	PROJECT COUNTY OF ROCKLAND CAPITAL PROJECT NO. 1307 HIGHWAY DEPARTMENT / EMERGENCY OPERATIONS FACILITY COUNTY OF ROCKLAND, NEW YORK	 McLaren ENGINEERING GROUP M. G. McLaren Engineering and Land Surveying P.C. 530 Chestnut Ridge Road, Woodcliff Lake, NJ 07677 T: 201.775.6000 F: 201.746.8522 www.mgmclaren.com	SEAL 	SHEET NAME PROPOSED SITE PLAN OVERLAY	<table border="1" style="width: 100%; border-collapse: collapse;"> <tr> <td>PROJECT NO.</td> <td>130439</td> </tr> <tr> <td>SCALE</td> <td>AS NOTED</td> </tr> <tr> <td>DATE</td> <td>OCTOBER 30, 2019</td> </tr> <tr> <td>DRAWN BY</td> <td>ORR</td> </tr> <tr> <td>CHECKED BY</td> <td>JMS</td> </tr> <tr> <td>APPROVED BY</td> <td></td> </tr> </table>	PROJECT NO.	130439	SCALE	AS NOTED	DATE	OCTOBER 30, 2019	DRAWN BY	ORR	CHECKED BY	JMS	APPROVED BY		<table border="1" style="width: 100%; border-collapse: collapse;"> <tr> <td>ISSUED FOR</td> <td>BID SET</td> </tr> <tr> <td>DRAWING NO.</td> <td>0.01.004</td> </tr> <tr> <td></td> <td>5 of 377 SHEETS</td> </tr> </table>	ISSUED FOR	BID SET	DRAWING NO.	0.01.004		5 of 377 SHEETS
PROJECT NO.	130439																										
SCALE	AS NOTED																										
DATE	OCTOBER 30, 2019																										
DRAWN BY	ORR																										
CHECKED BY	JMS																										
APPROVED BY																											
ISSUED FOR	BID SET																										
DRAWING NO.	0.01.004																										
	5 of 377 SHEETS																										

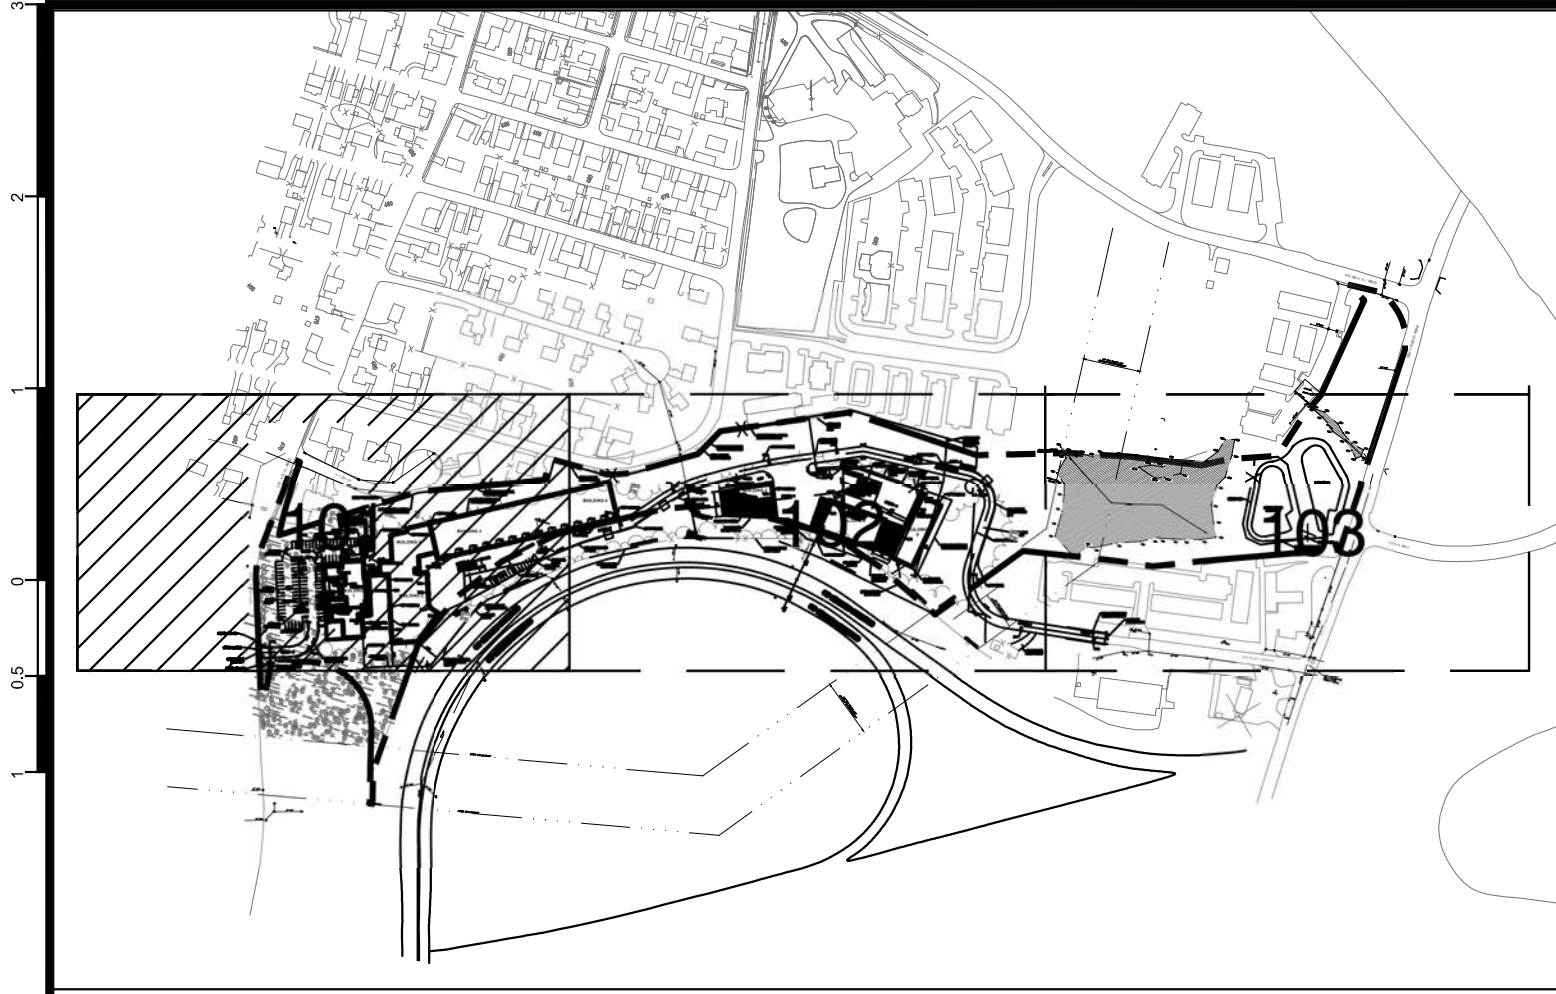

LEGEND

	PAVEMENT - A (LIGHT DUTY)
	PAVEMENT - B (HEAVY DUTY)
	CONCRETE SIDEWALK/RAMP/DOOR PADS
	PROPERTY LINE
	CONCRETE CURB
	DEPRESSED CONCRETE CURB
	PROPOSED 12" STOP BAR
	PROPOSED GUIDERAIL
	PROPOSED CHAINLINK FENCE
	POLE MOUNT DOUBLE LUMINAIRES
	POLE MOUNT SINGLE LUMINAIRES
	WALL MOUNT LUMINAIRES

LUMINAIRE SCHEDULE		
LABEL	TAG	DESCRIPTION
P-1	LED Roadway Lighting	NXT-72M-VOLT- 2ES-7-3
P-2	LSI Industries	MRM-LED-07L-SIL-FI-40-70CRI-IL
P-2A	LSI Industries	MRM-LED-07L-SIL-FI-40-70CRI-IL
WM-3	LSI Industries	XWM-FT-LED-12L-40
WM-4	LSI Industries	XWM-2-LED-12L-40

NOTE: SEE ELECTRIC PLAN 0.06.604

GENERAL CONSTRUCTION AND UTILITY NOTES:


1. THE CONTRACTOR SHALL FIELD VERIFY THE EXACT SIZE, LOCATION, DEPTH AND INVERT OF ALL EXISTING UTILITIES WITH THE LIMITS OF WORK PRIOR TO COMMENCING AND EXCAVATIONS OR OPERATIONS AND REPORT ANY DISCREPANCIES TO THE ENGINEER.
2. THE CONTRACTOR SHALL NOTIFY ALL UTILITY COMPANIES 72 HOURS PRIOR TO THE START OF HIS OPERATIONS AND SHALL COMPLY WITH THE LATEST INDUSTRIAL CODE 53 REGULATIONS.
3. EXCEPT WHERE NOTED ON THE DRAWINGS, THE CONTRACTOR SHALL REMOVE ALL EXISTING UTILITIES WITHIN THE WORK AREA.
4. ALL EXISTING STOCKPILES OF GRAVEL, ASPHALT MILLINGS, ETC. ON THE PROJECT SITE AT THE TIME OF START OF CONSTRUCTION SHALL BECOME THE PROPERTY OF THE CONTRACTOR AND CAN BE USED FOR THE PROPOSED CONSTRUCTION. IN THE EVENT THIS MATERIAL IS NOT NEEDED FOR SITE FILL, IT SHALL BE DISPOSED OFFSITE.
5. ALL EXISTING GUIDE RAIL, TRASH AND DEBRIS WITHIN THE LIMIT OF CONSTRUCTION SHALL BE REMOVED BY THE CONTRACTOR AND DISPOSED OFFSITE IN A LEGAL MANNER.
6. THE CONTRACTOR SHALL SEE THE MECHANICAL AND PLUMBING PLANS FOR THE EXACT LOCATION AND INVERTS OF ALL BUILDING SERVICE CONNECTIONS.
7. THE CONTRACTOR SHALL INSTALL ALL UTILITY SERVICES TO FIVE (5) FEET OUTSIDE OF THE EXTERIOR FACE OF THE BUILDING WALL.
8. ALL UTILITY STRUCTURE CASTINGS SHALL BE ADJUSTED AS NECESSARY TO BE FLUSH WITH THE PROPOSED FINISHED GRADE.
9. ALL STORM DRAIN AND SANITARY SERVICE CONNECTIONS SHALL BE CONSTRUCTED OF EXTRA HEAVY CAST IRON PIPE, DUCTILE IRON PIPE (CL56) OR PVC DRAIN WASTE VENT PIPE AND FITTINGS CONFORMING TO ASTM DS665.
10. ALL PRECAST CONCRETE MANHOLES AND STRUCTURES SHALL BE IN ACCORDANCE WITH ASTM C478.
11. LOCATION OF CHAIN LINK FENCE TO BE COORDINATED IN FIELD PRIOR TO CONSTRUCTION.

SIGN TABLE

LEGEND	MUTCD NO.	SIZE	TEXT
①	R1-1	30" x 30"	STOP
②	R7-8	12" x 18"	RESERVED PARKING (SYMBOL)
③	NYP1-7	12" x 6"	NO STOPPING ANY TIME

NOTES:

1. ALL SIGNS SHALL CONFORM TO THE MANUAL ON UNIFORM TRAFFIC CONTROL DEVICE (MUTCD) AND NYS SUPPLEMENT TO NATIONAL MUTCD FOR STREETS AND HIGHWAY LATEST EDITIONS.
2. ALL SIGN BRACES SHALL MEET THE NYS DOT DETAILS.
3. ALL SIGNS SHALL HAVE A MOUNTING HEIGHT SHALL MEET THE NYS DOT SPECIFICATIONS AND DETAILS.
4. ALL SIGNS SHALL UTILIZE MOUNTING.
5. ALL SIGNS SHALL BE REFLECTORIZED.

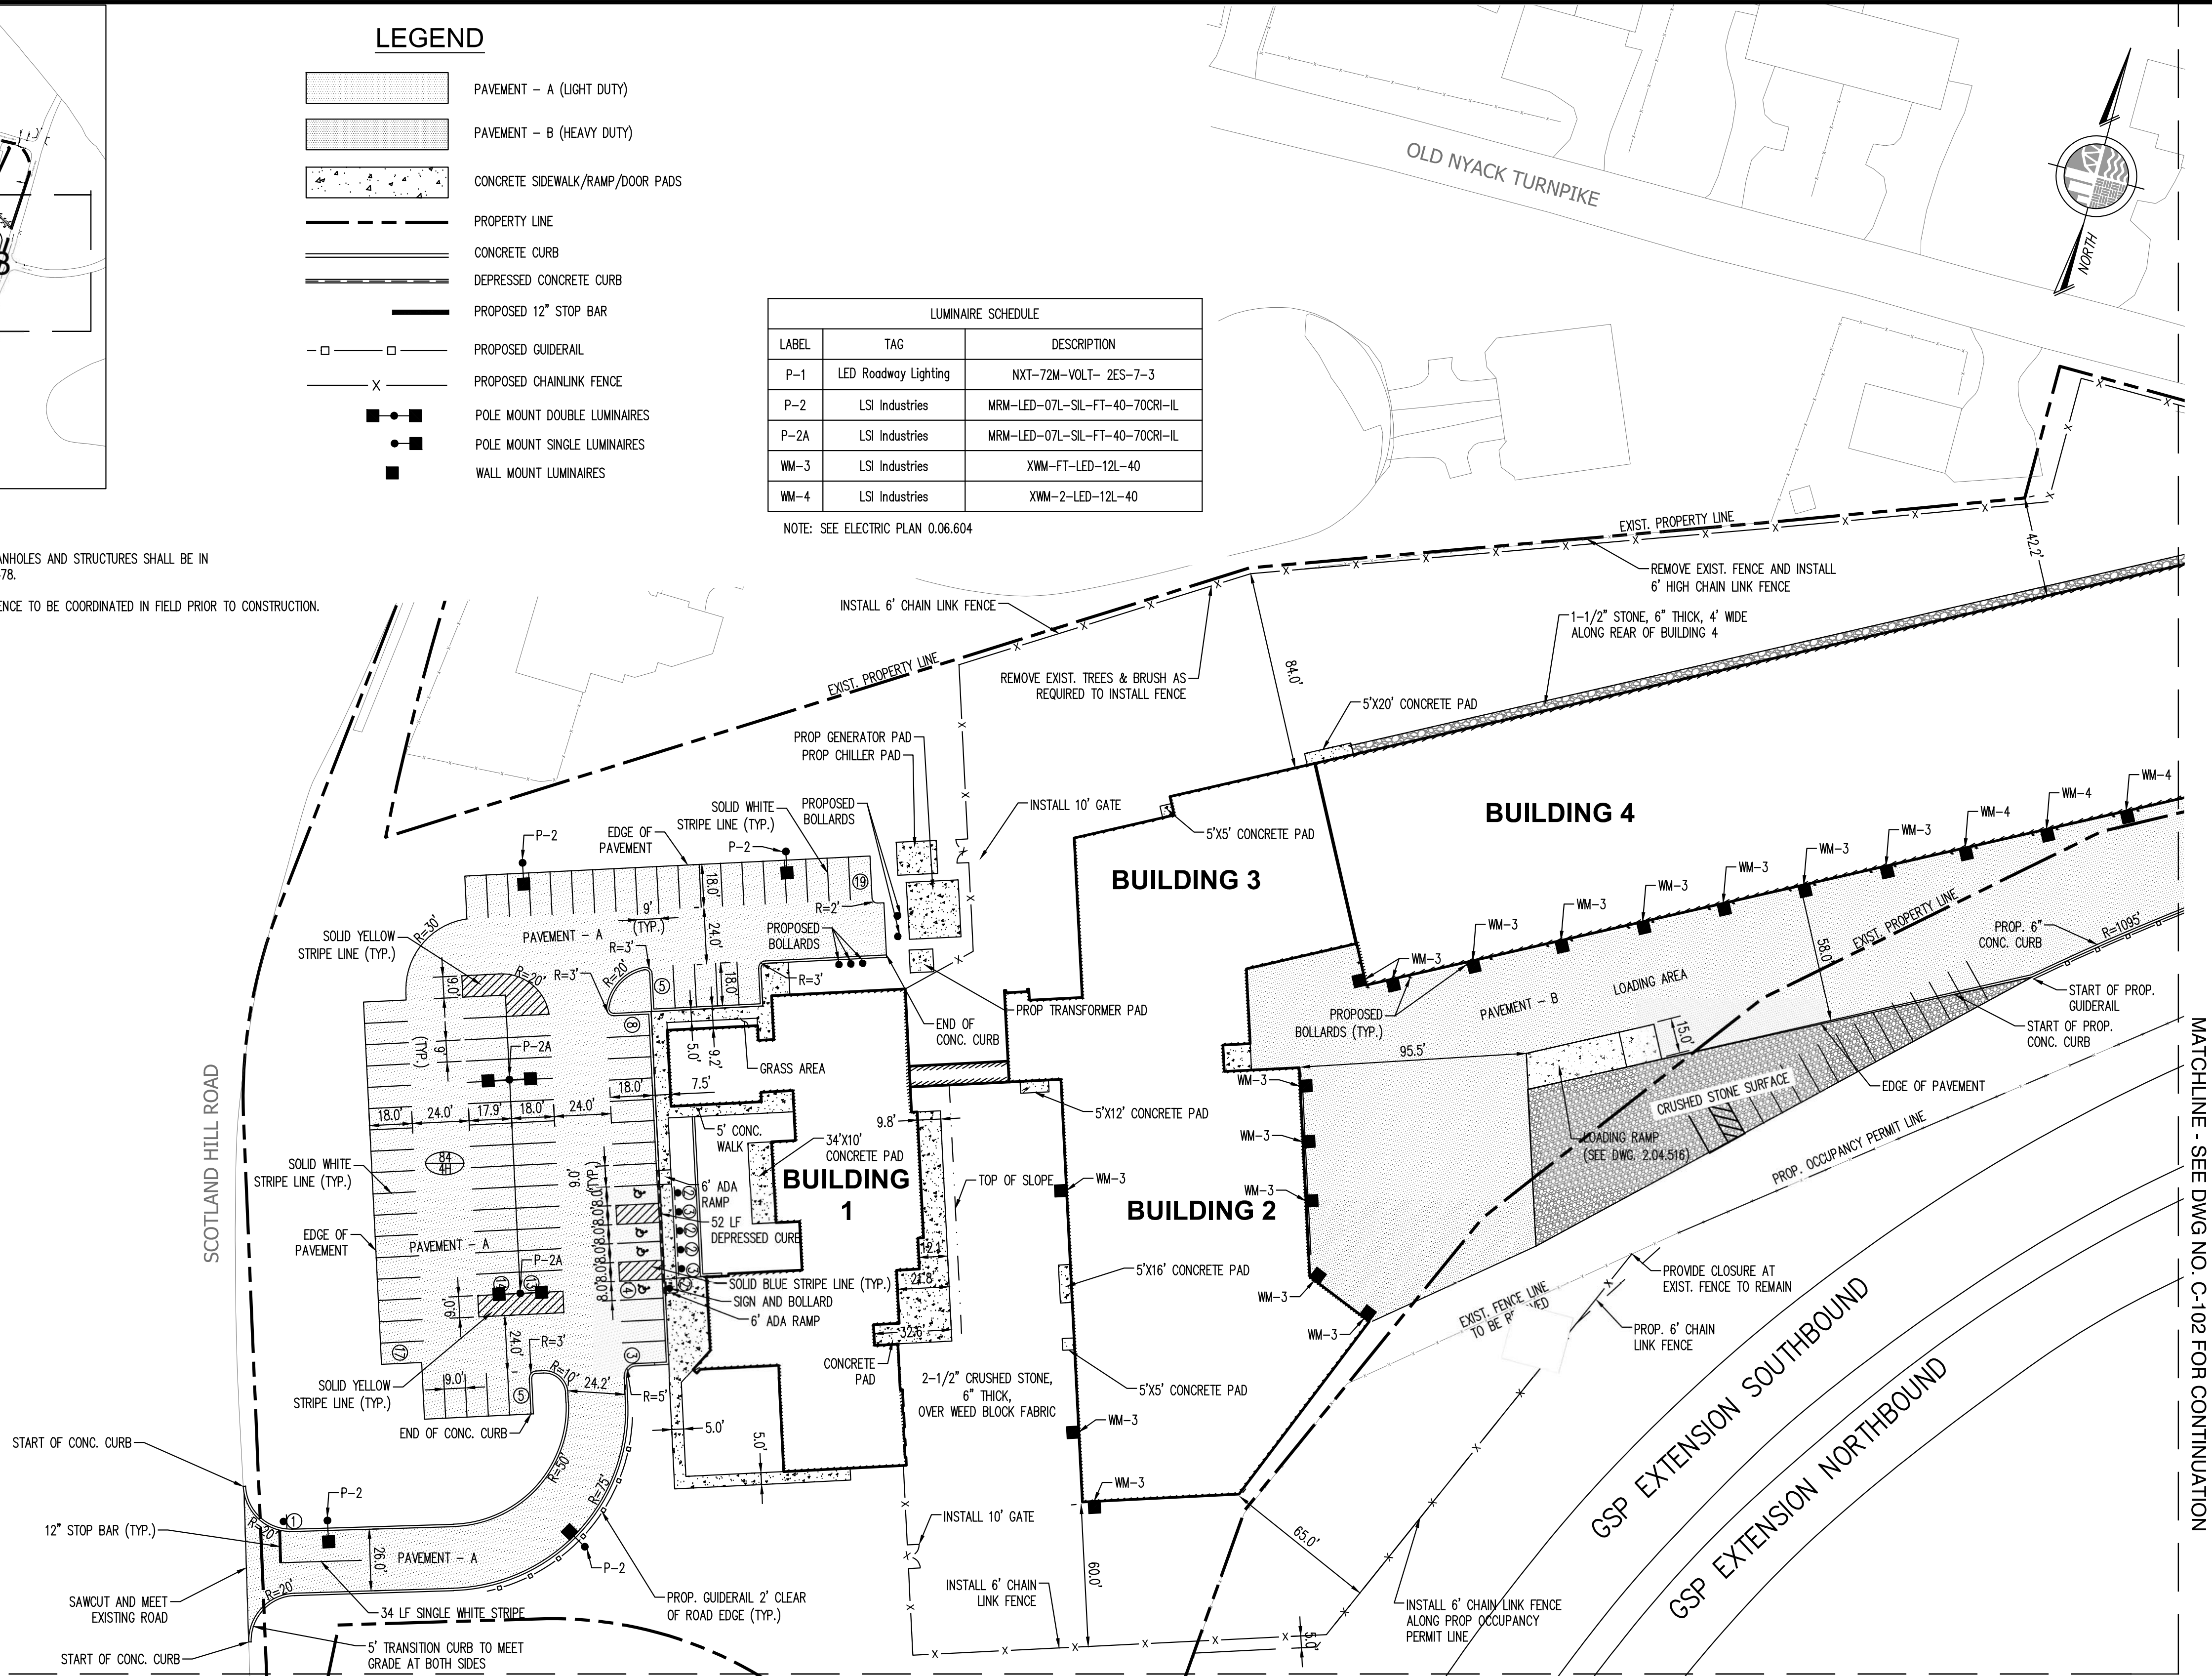

40' 20' 0 40' 80' FEET
SCALE: 1" = 40'

WARNING - IT IS A VIOLATION OF NEW YORK STATE EDUCATIONAL LAW, SECTION 7209.2, FOR ANY PERSON, UNLESS HE OR SHE IS ACTING UNDER THE DIRECTION OF A LICENSED PROFESSIONAL ENGINEER OR LAND SURVEYOR, TO ALTER THIS DOCUMENT IN ANY WAY. IF ALTERED, THE ALTERING PERSON SHALL COMPLY WITH THE REQUIREMENTS OF NEW YORK EDUCATIONAL LAW, SECTION 7209.2

COPYRIGHT © 2019, McLAREN ENGINEERING GROUP

CONSULTANTS ARCHITECT

STV 100 Years

STV Architects, P.C.
225 Park Avenue South
New York, NY 10003
(212) 777-4400 FAX: (212) 473-2780
www.stvinc.com

MEP ENGINEER

OLA Consulting Engineers

60 Broadway, Hawthorne,
New York 10522
914.747.2800

12 East 49th Street, 11th Flr.
New York, NY 10017
940.848.4110
olace.com

FACILITIES CONSULTANT

Gannett Fleming

LANDSCAPE ARCHITECT

IQ

Imbiano-Quigley
Landscape Architects

31 Montross Ave., 7th Floor
White Plains, New York 10601
admin@iqlandscape.com
(914) 232-4000

PROJECT

COUNTY OF ROCKLAND
CAPITAL PROJECT NO. 1307
HIGHWAY DEPARTMENT /
EMERGENCY OPERATIONS FACILITY
COUNTY OF ROCKLAND, NEW YORK

McLaren ENGINEERING GROUP

M. G. McLaren Engineering
and Land Surveying P.C.

530 Chestnut Ridge Road, Woodcliff Lake, NJ 07677
T: 201.775.8000 F: 201.746.8522 www.mgmclaren.com


SEAL

STATE OF NEW YORK
ENGINEER M. G. McLAREN
101180

SHEET NAME

SITE PLAN
(SHEET 1 OF 4)


PROJECT NO.	130439	ISSUED FOR	BID SET
SCALE	AS NOTED	DRAWING NO.	0.01.101
DATE	OCTOBER 30, 2019	6 of 377 SHTS	
DRAWN BY	ORR		
CHECKED BY	JMS		
APPROVED BY			
NO.	DATE	REVISION	BY

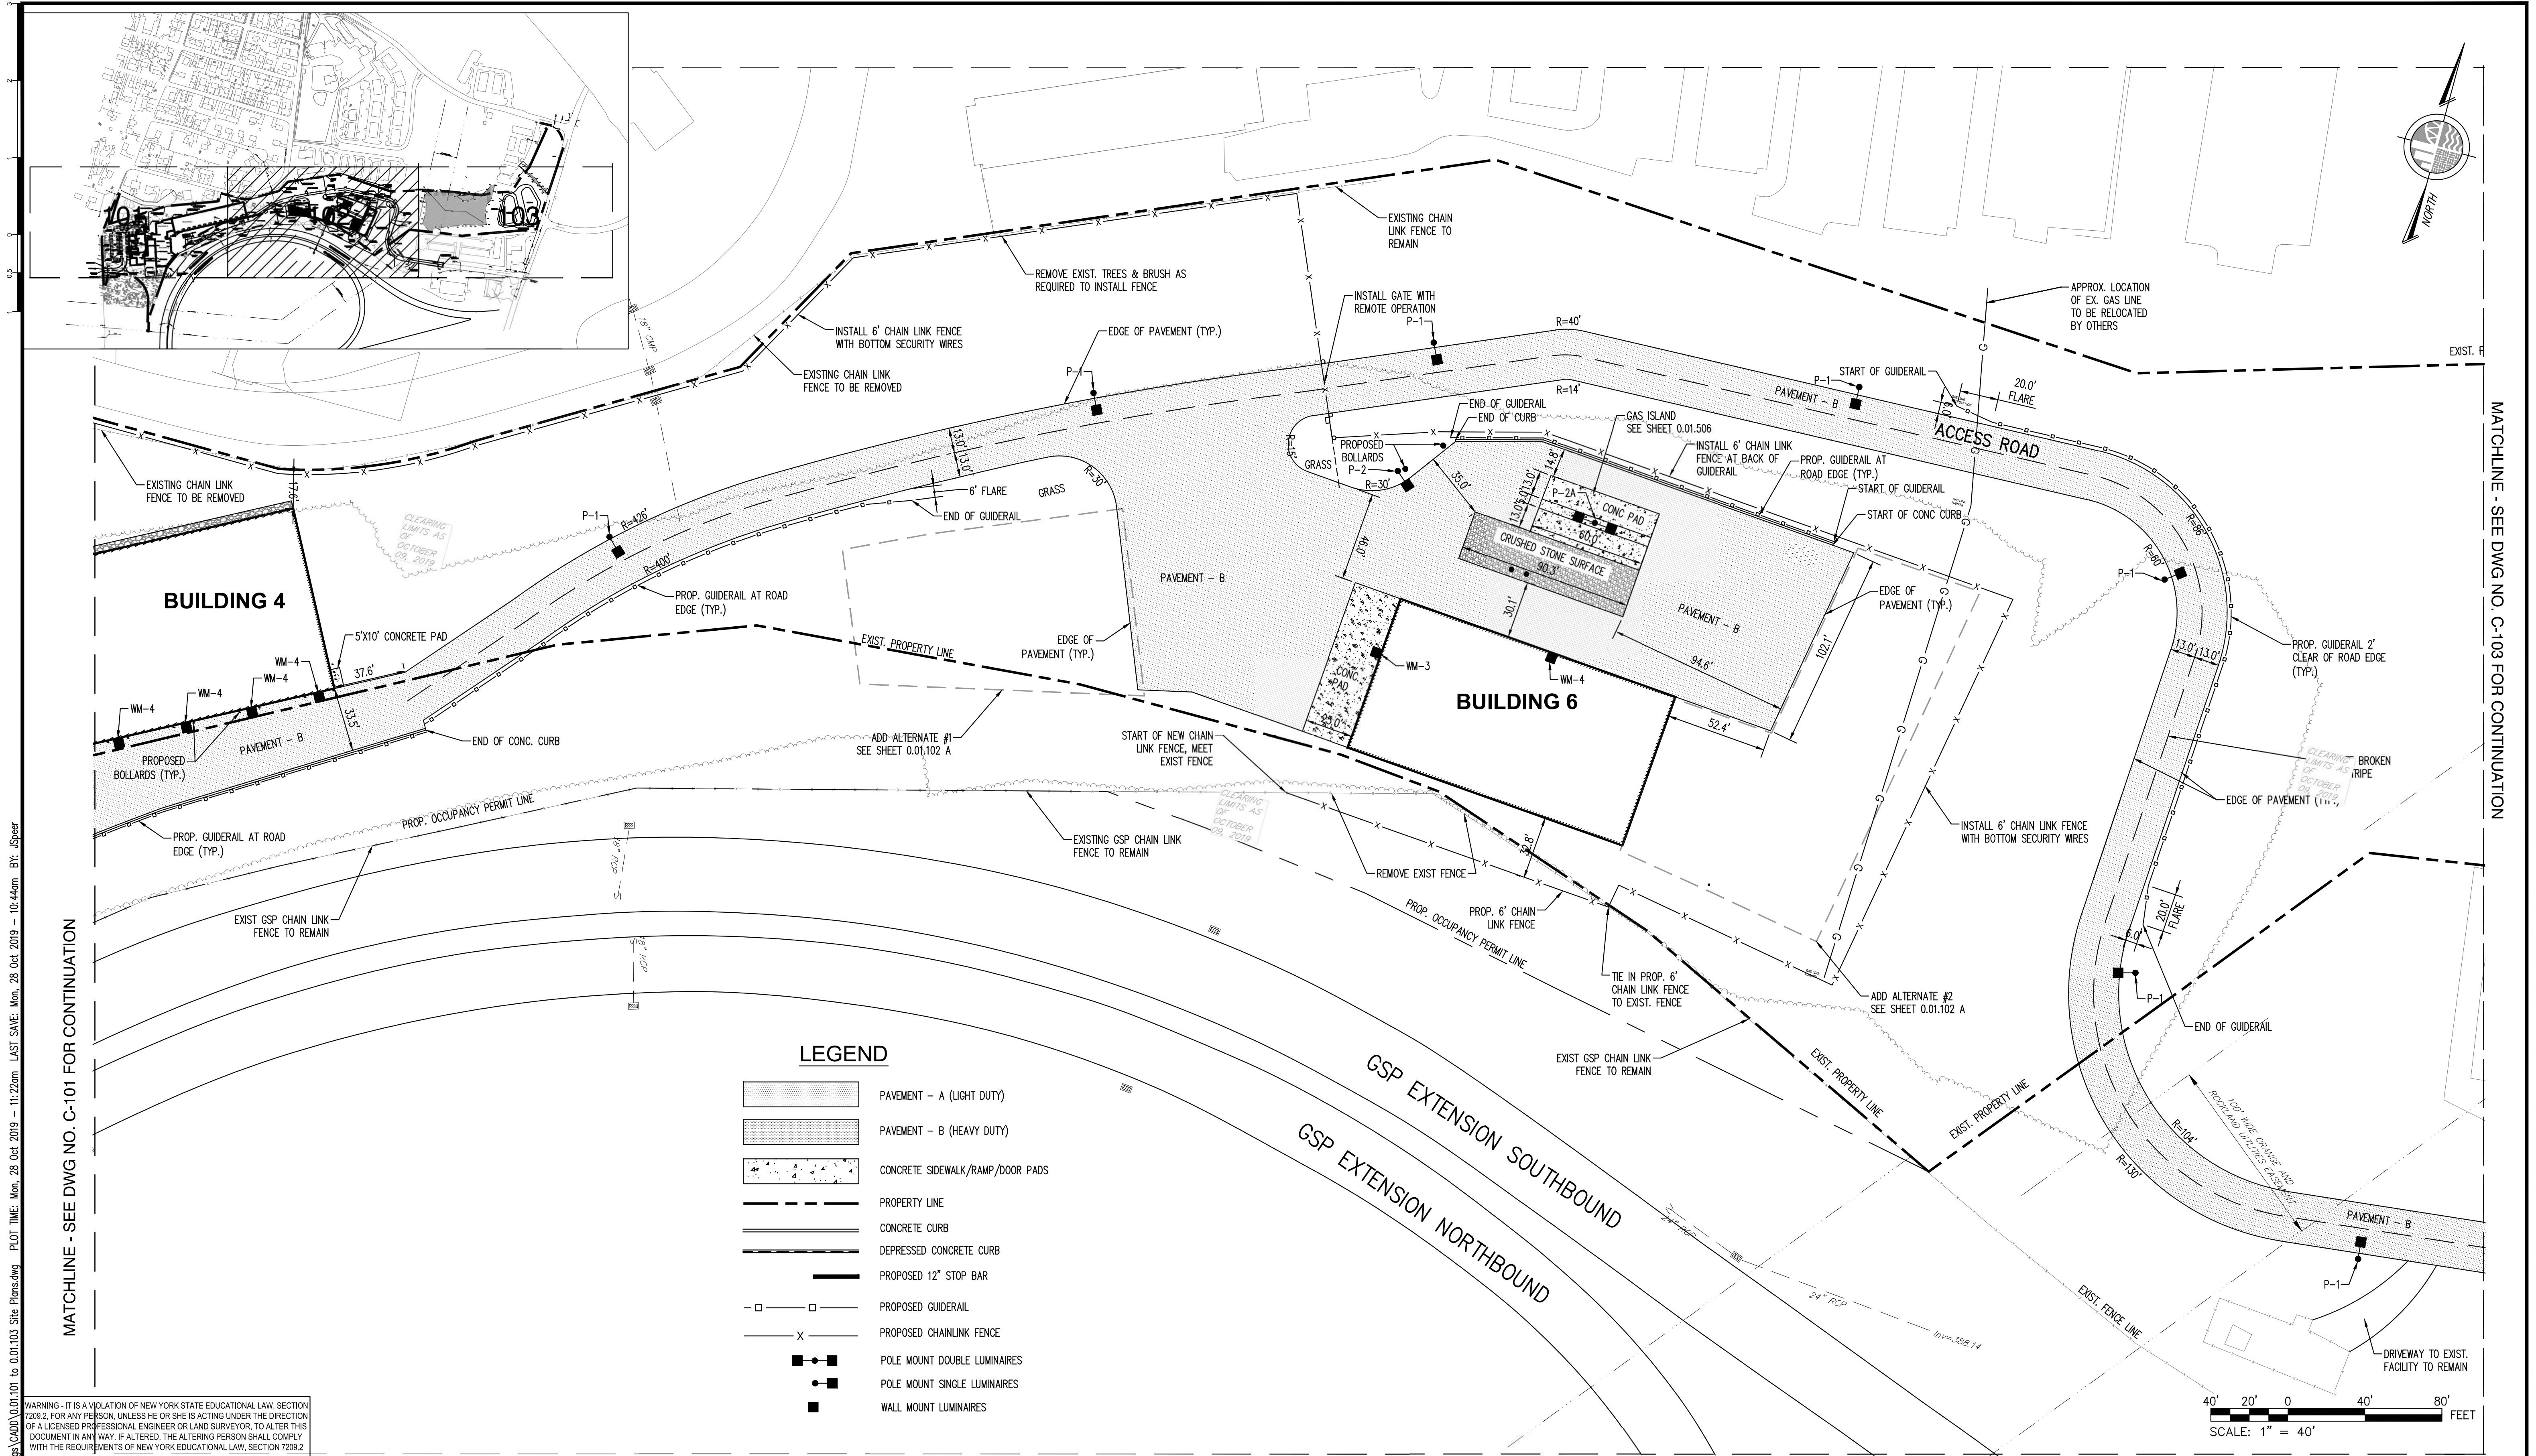

WARNING - IT IS A VIOLATION OF NEW YORK STATE EDUCATIONAL LAW, SECTION 7209.2, FOR ANY PERSON, UNLESS HE OR SHE IS ACTING UNDER THE DIRECTION OF A LICENSED PROFESSIONAL ENGINEER OR LAND SURVEYOR, TO ALTER THIS DOCUMENT IN ANY WAY. IF ALTERED, THE ALTERING PERSON SHALL COMPLY WITH THE REQUIREMENTS OF NEW YORK EDUCATIONAL LAW, SECTION 7209.2

COPYRIGHT © 2019, McLAREN ENGINEERING GROUP

CONSULTANTS ARCHITECT STV 100 Years STV Architects, P.C. 225 Park Avenue South New York, NY 10003 (212) 777-4400 FAX: (212) 473-2780 www.stvinc.com	MEP ENGINEER OLA Consulting Engineers OLA Consulting Engineers 60 Broadway, Hawthorne, New York 10522 914.747.2800 12 East 49th Street, 11th Fl. New York, NY 10017 646.848.4110 ola.com	FACILITIES CONSULTANT Gannett Fleming	LANDSCAPE ARCHITECT IQ Imbiano-Quigley Landscape Architects 31 Montross Ave., 7th Floor White Plains, New York 10601 admin@iqlandscape.com (914) 232-4090	PROJECT COUNTY OF ROCKLAND CAPITAL PROJECT NO. 1307 HIGHWAY DEPARTMENT / EMERGENCY OPERATIONS FACILITY COUNTY OF ROCKLAND, NEW YORK	McLaren ENGINEERING GROUP M. G. McLaren Engineering and Land Surveying P.C. 530 Chestnut Ridge Road, Woodcliff Lake, NJ 07677 T: 201.775.8000 F: 201.746.8522 www.mgmclaren.com	SEAL STATE OF NEW YORK ENGINEER 101180	SHEET NAME SITE PLAN (SHEET 2 OF 4)	<table><tr><td>No.</td><td>DATE</td><td>REVISION</td><td>BY</td></tr><tr><td> </td><td> </td><td> </td><td> </td></tr><tr><td> </td><td> </td><td> </td><td> </td></tr><tr><td> </td><td> </td><td> </td><td> </td></tr><tr><td> </td><td> </td><td> </td><td> </td></tr><tr><td> </td><td> </td><td> </td><td> </td></tr></table>	No.	DATE	REVISION	BY																					PROJECT NO. 130439 SCALE AS NOTED DATE OCTOBER 30, 2019 DRAWN BY ORR CHECKED BY JMS APPROVED BY	ISSUED FOR BID SET DRAWING NO. 0.01.102 7 OF 377 SHTS
No.	DATE	REVISION	BY																															

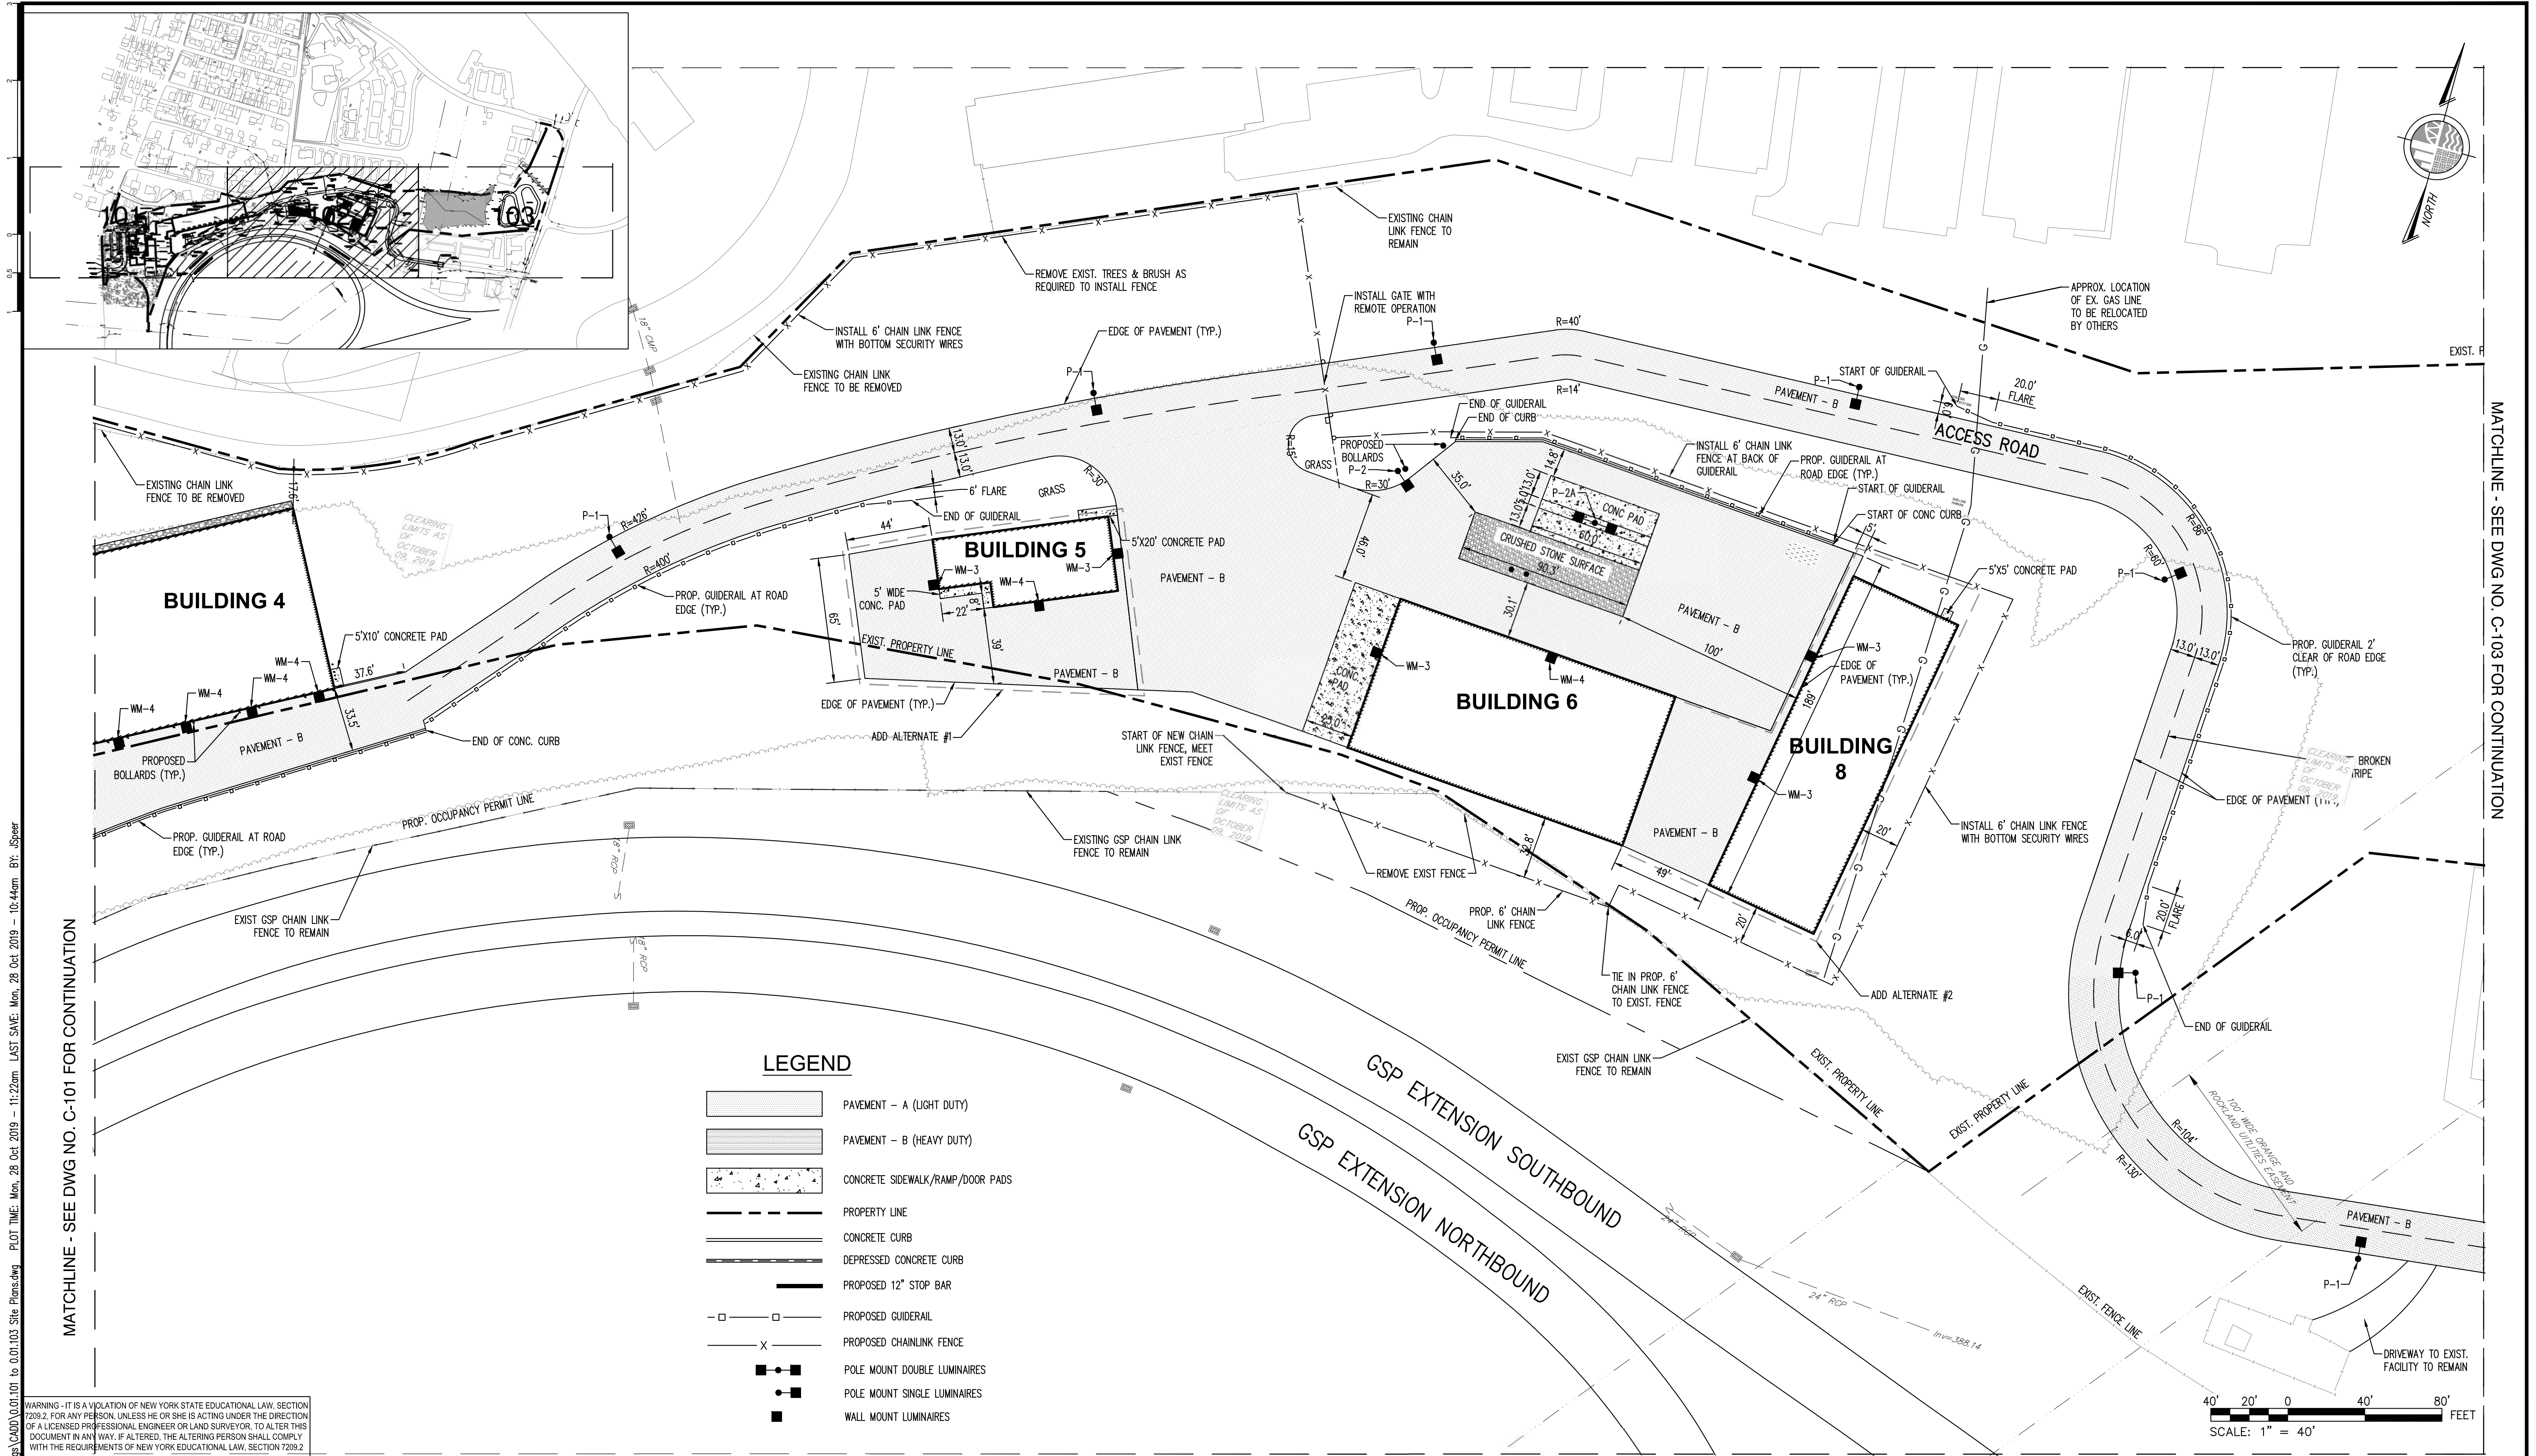

CONSULTANTS ARCHITECT

STV 100 Years

STV Architects, P.C.
225 Park Avenue South
New York, NY 10003
(212) 777-4400 FAX: (212) 473-2780
www.stvinc.com

MEP ENGINEER

OLA Consulting Engineers

OLA Consulting Engineers
50 Broadway, Hawthorne,
New York 10022
914.747.2800
12 East 49th Street, 11th Fl.
New York, NY 10017
646.549.4110
olace.com

FACILITIES CONSULTANT

Gannett Fleming

LANDSCAPE ARCHITECT

IQ

Imbiano-Quigley
Landscape Architects
31 Montross Ave., 7th Floor
White Plains, New York 10601
admin@iqlandscape.com
(914) 232-4090

PROJECT

COUNTY OF ROCKLAND
CAPITAL PROJECT NO. 1307
HIGHWAY DEPARTMENT /
EMERGENCY OPERATIONS FACILITY
COUNTY OF ROCKLAND, NEW YORK

McLaren ENGINEERING GROUP

M. G. McLaren Engineering
and Land Surveying P.C.
530 Chestnut Ridge Road, Woodcliff Lake, NJ 07677
T: 201.775.8000 F: 201.746.8522 www.mgmlaren.com

SEAL

STATE OF NEW YORK
ENGINEER
M. G. McLaren
101180

SHEET NAME

SITE PLAN
(SHEET 3 OF 4)

No.	DATE	REVISION	BY

PROJECT NO. 130439

SCALE AS NOTED

DATE OCTOBER 30, 2019

DRAWN BY ORR


CHECKED BY JMS

APPROVED BY

ISSUED FOR **BID SET**

DRAWING NO. **0.01.102A**


8 of 377 SHS

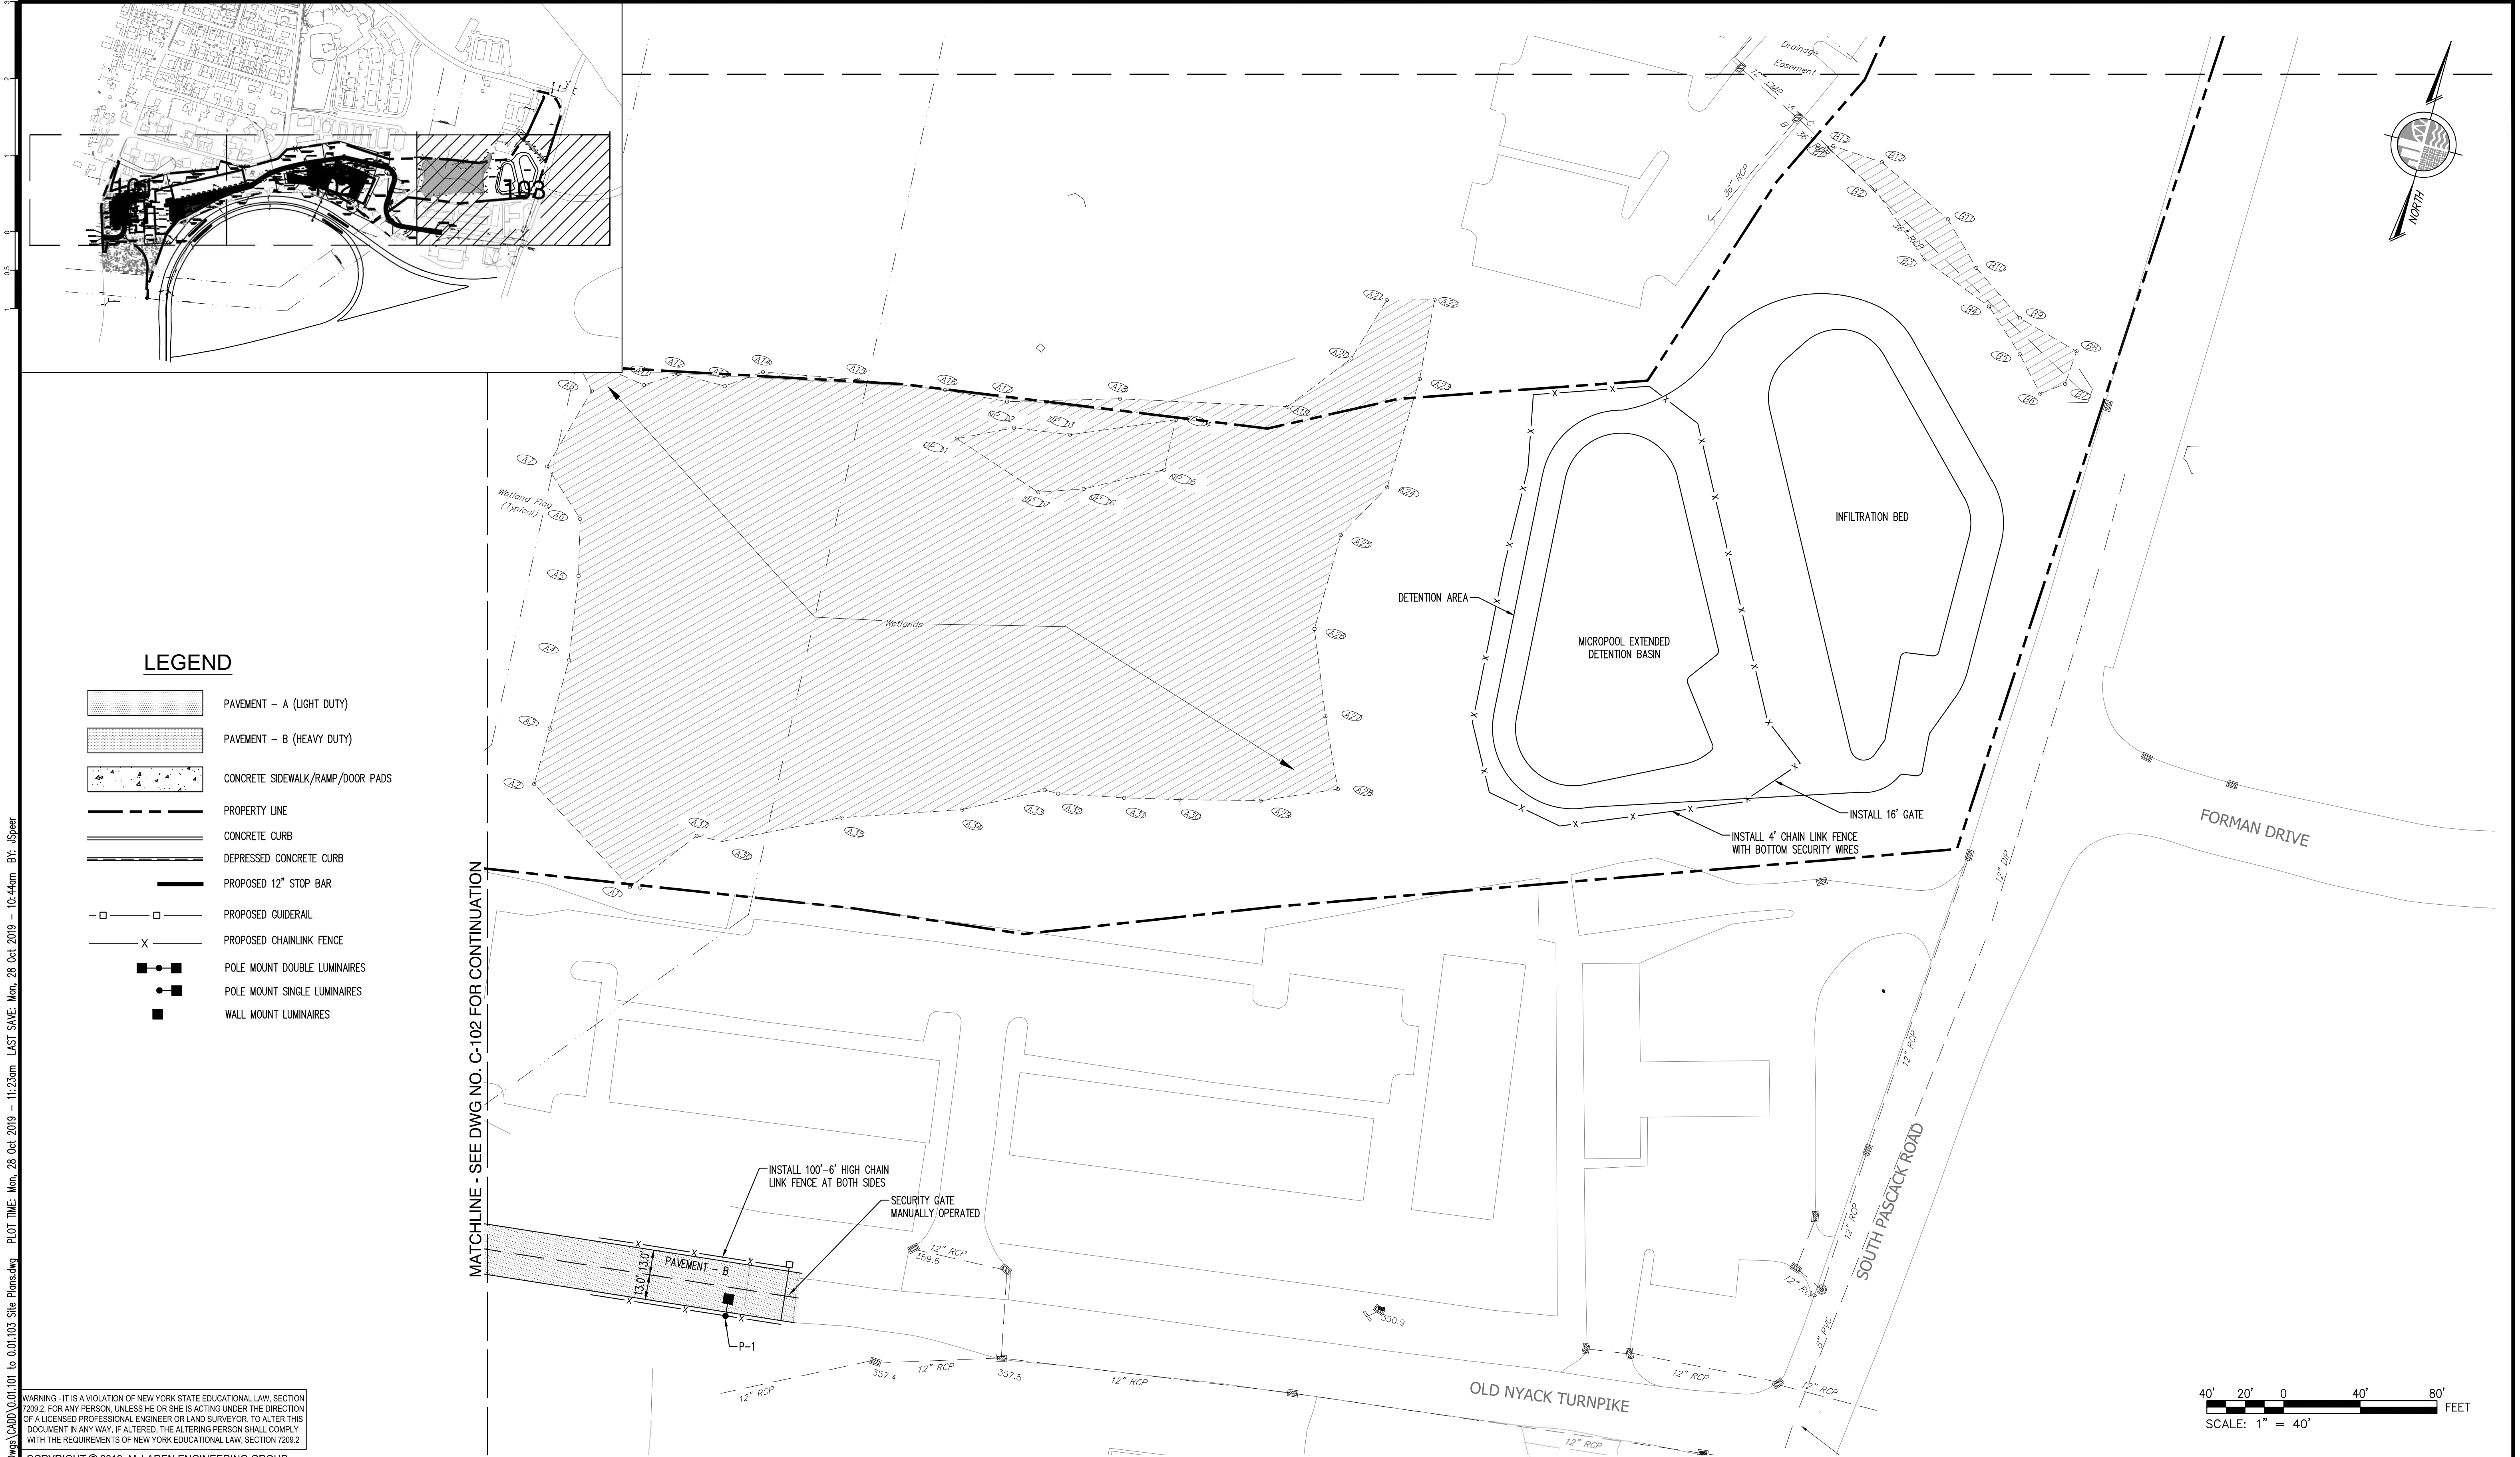

WARNING - IT IS A VIOLATION OF NEW YORK STATE EDUCATIONAL LAW, SECTION 7209.2, FOR ANY PERSON, UNLESS HE OR SHE IS ACTING UNDER THE DIRECTION OF A LICENSED PROFESSIONAL ENGINEER OR LAND SURVEYOR, TO ALTER THIS DOCUMENT IN ANY WAY. IF ALTERED, THE ALTERING PERSON SHALL COMPLY WITH THE REQUIREMENTS OF NEW YORK EDUCATIONAL LAW, SECTION 7209.2

COPYRIGHT © 2019, McLAREN ENGINEERING GROUP


CONSULTANTS ARCHITECT STV Architects, P.C. 225 Park Avenue South New York, NY 10003 (212) 777-4400 FAX: (212) 473-2780 www.stvinc.com	MEP ENGINEER OLA Consulting Engineers 60 Broadway, Hawthorne, New York 10522 914.747.2800 12 East 49th Street, 11th Flr. New York, NY 10017 646.548-4110 olace.com	FACILITIES CONSULTANT Gannett Fleming	LANDSCAPE ARCHITECT Imbiano-Quigley Landscape Architects 31 Main Street, New York 10001 admin@iqlandscape.com (914) 252-4090	PROJECT COUNTY OF ROCKLAND CAPITAL PROJECT NO. 1307 HIGHWAY DEPARTMENT / EMERGENCY OPERATIONS FACILITY COUNTY OF ROCKLAND, NEW YORK	McLaren ENGINEERING GROUP M. G. McLaren Engineering and Land Surveying P.C. 530 Chestnut Ridge Road, Woodcliff Lake, NJ 07677 T: 201.775.6000 F: 201.746.8522 www.mgmlaren.com	SEAL	SHEET NAME SITE PLAN (SHEET 4 OF 4)	<table><tr><td>No.</td><td>DATE</td><td>REVISION</td><td>BY</td></tr><tr><td> </td><td> </td><td> </td><td> </td></tr><tr><td> </td><td> </td><td> </td><td> </td></tr><tr><td> </td><td> </td><td> </td><td> </td></tr><tr><td> </td><td> </td><td> </td><td> </td></tr><tr><td> </td><td> </td><td> </td><td> </td></tr><tr><td> </td><td> </td><td> </td><td> </td></tr><tr><td> </td><td> </td><td> </td><td> </td></tr><tr><td> </td><td> </td><td> </td><td> </td></tr><tr><td> </td><td> </td><td> </td><td> </td></tr></table>	No.	DATE	REVISION	BY																																					PROJECT NO. 130439 SCALE AS NOTED DATE OCTOBER 30, 2019 DRAWN BY ORR CHECKED BY JMS APPROVED BY	ISSUED FOR BID SET DRAWING NO. 0.01.103 9 OF 377 SHTS
No.	DATE	REVISION	BY																																															

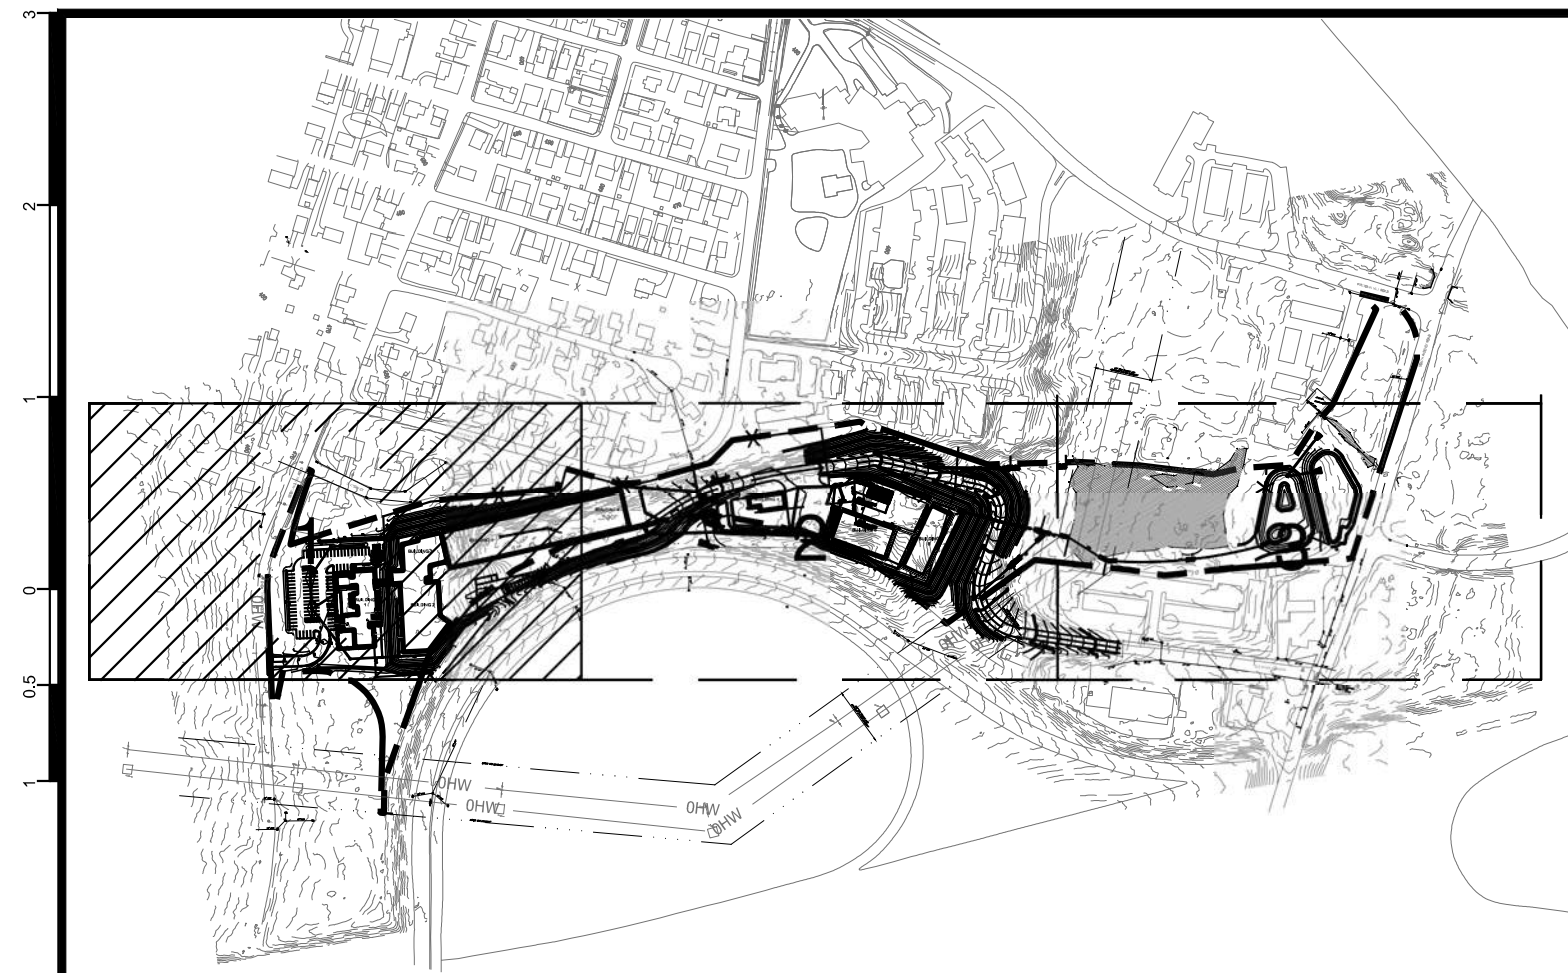



STRUCTURE ID		13	14	15	16	17	18	19	20	21	22	23	24	25	26	27	28	32	33	34	36	53	54	55	56	57	58	59
STRUCTURE TYPE		CB-Curb	CB	CB	CB	CB	CB	MH	MH	CB	CB	CB	CB	CB	DI	DI	DI	CB	CB	CB	C.O.	DI	DI	DI	DI	DI	CB	CB
TOP GRATE/RIM ELEVATION		460.80	460.50	460.50	461.00	461.00	461.00	468.00	477.00	477.00	475.80	475.80	475.50	475.50	461.00	461.00	461.00	477.50	477.50	477.50	477.00	461.00	461.00	461.00	461.00	461.00	461.00	461.00
DOWNSTREAM PIPE	PIPE SIZE (INCHES)	30	30	24	24	24	24	18	18	18	18	18	12	12	18	18	18	12	12	12	8	24	24	24	24	12	12	12
	PIPE MATERIAL	HDPE	HDPE	HDPE	HDPE	HDPE	HDPE	HDPE	HDPE	HDPE	HDPE	HDPE	HDPE	HDPE	HDPE	HDPE	HDPE	HDPE	HDPE	HDPE	HDPE	HDPE	HDPE	HDPE	HDPE	HDPE	HDPE	HDPE
	PIPE LENGTH (FEET)	92.0	120.0	105.0	106.0	100.0	79.0	17.0	28.0	83.0	165.0	81.0	95.0	85.0	50.0	50.0	50.0	87.0	30.0	30.0	184.0	126.0	121.0	121.0	121.0	59.0	51.0	50.0
	PIPE SLOPE (%)	0.58	0.53	0.58	0.58	0.50	0.58	10.00	10.00	1.20	0.42	0.57	0.55	0.55	0.40	0.40	0.44	0.44	0.43	0.43	0.44	0.56	0.50	0.46	0.49	0.44	0.44	0.44
PIPE INVERT ELEVATIONS	IN (N)			453.17	453.78		455.20		472.72	469.45	470.14	470.60			455.40	455.60	456.57					456.12	456.72	457.28	457.87	457.30	457.35	457.74
	IN (S)																	471.02	471.15			456.12	456.72	457.28	457.87	457.30	457.35	457.74
	IN (W)	451.42	452.56			454.28	455.50	462.50	468.45									471.52				454.62	455.22	455.78	456.87	457.13		
	IN (E)																											
	OUT	451.42	452.06	453.17	453.78	454.28	454.74	457.20	465.30	469.45	470.14	470.60	471.12	471.59	455.40	455.60	455.82	471.02	471.15	471.28	473.53	453.92	454.62	455.22	455.78	456.87	457.13	457.35
SUMP ELEVATION		449.92	450.56	451.67	452.28	452.78	453.24			467.95	468.64	469.10	469.62	470.09	453.90	454.10	454.32	469.52	469.65	469.78		452.42	453.12	453.72	454.28	455.37	455.63	455.85

LEGEND

- 106 EXISTING MAJOR CONTOUR
- 111 EXISTING MINOR CONTOUR
- PROPOSED CONTOURS
- PROPERTY LINE
- 107.3 + SPOT GRADE
- TW 112.0 + TOP OF WALL
- BW 100.0 + BOTTOM OF WALL
- TC 92.5 + TOP OF CURB
- BC 92.0 + BOTTOM OF CURB
- PROPOSED STORM MANHOLE(MH) /SANITARY MANHOLE(SMH)
- PROPOSED DRAIN INLET (DI) /CATCH BASIN (CB)

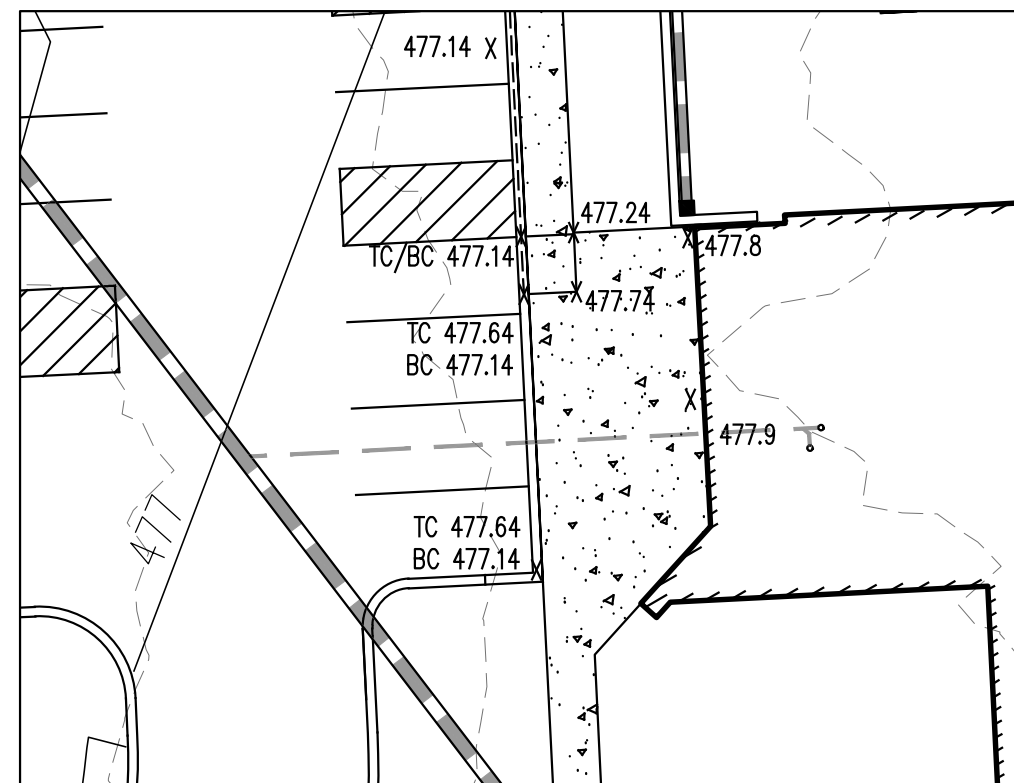

MAIN ENTRANCE GRADING DETAIL

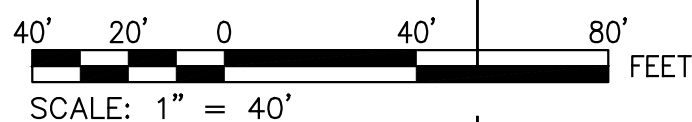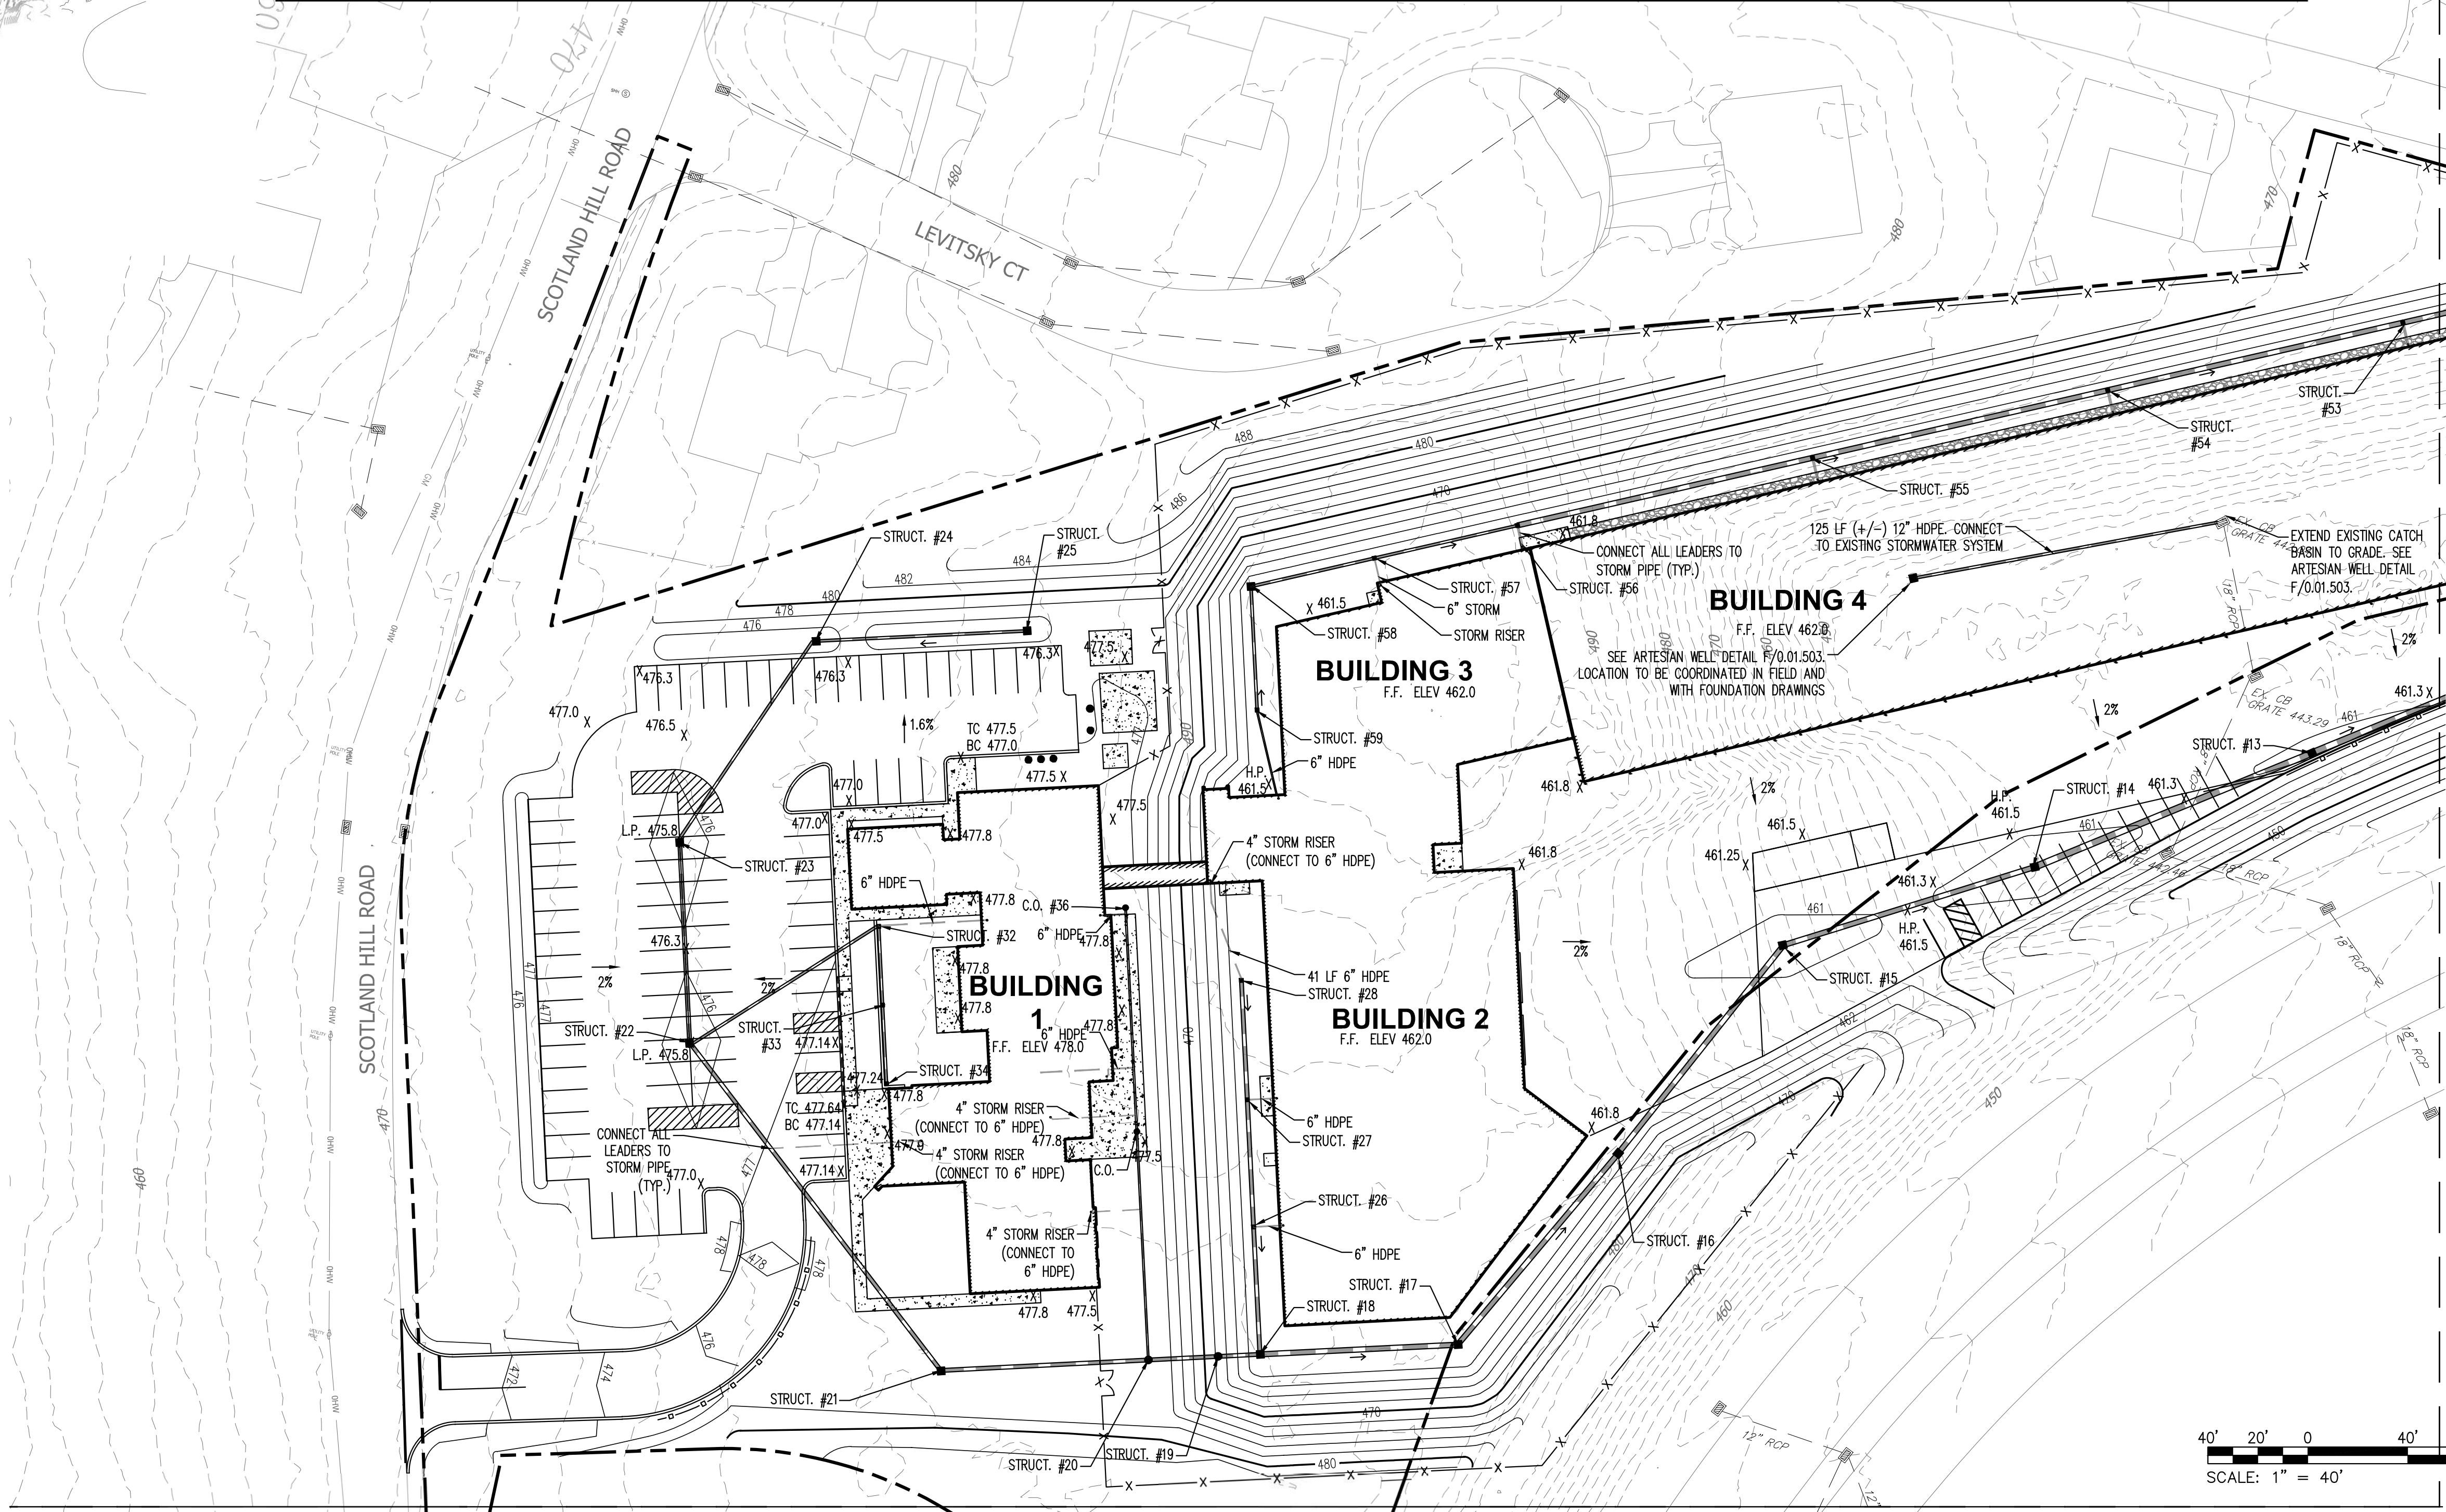

MATCHLINE - SEE DWG NO. C-202 FOR CONTINUATION

COPYRIGHT © 2019, McLAREN ENGINEERING GROUP

CONSULTANTS ARCHITECT

STV 100 Years

STV Architects, P.C.
225 Park Avenue South
New York, NY 10003
(212) 777-4400 FAX: (212) 473-2780
www.stvinc.com

MEP ENGINEER

OLA Consulting Engineers

60 Broadway, Hawthorne,
New York 10522
914.747.2800

12 East 49th Street, 11th Fl.
New York, NY 10017
646.548-4110
ola.com

FACILITIES CONSULTANT

Gannett Fleming

LANDSCAPE ARCHITECT

IQ

Imbiano-Quigley
Landscape Architects

31 Monmouth Ave., 7th Floor
White Plains, New York 10601
admin@iqlandscape.com
(914) 252-4090

PROJECT

COUNTY OF ROCKLAND
CAPITAL PROJECT NO. 1307
HIGHWAY DEPARTMENT /
EMERGENCY OPERATIONS FACILITY
COUNTY OF ROCKLAND, NEW YORK

McLaren ENGINEERING GROUP

M. G. McLaren Engineering
and Land Surveying P.C.

530 Chestnut Ridge Road, Woodcliff Lake, NJ 07677
T: 201.775.8000 F: 201.746.8522 www.mgmclaren.com

SEAL

STATE OF NEW YORK
ENGINEER

SHEET NAME

GRADING AND DRAINAGE PLAN
(SHEET 1 OF 4)

PROJECT NO.	130439	ISSUED FOR	BID SET
SCALE	AS NOTED	DRAWING NO.	0.01.201
DATE	OCTOBER 30, 2019	APPROVED BY	JMS
DRAWN BY	ORR	BY	
CHECKED BY	JMS	REVISION	
APPROVED BY		DATE	
No.	DATE	REVISION	BY