

DEPARTMENT OF GENERAL SERVICES, PURCHASING DIVISION

Dr. Robert L. Yeager Health Center
50 Sanatorium Rd, Building A
Pomona, New York 10970
Phone: (845) 364-3820 Fax: (845) 364-3809
Email: purchasing@co.rockland.ny.us

Paul Brennan, FNIGP, CPPO
Director of Purchasing

ADDENDUM # 13

**CAPITAL PROJECT 3414:
CONSTRUCTION OF NEW HIGHWAY FACILITY**

The information in this addendum supersedes any contradictory information set forth in the contract documents. Acknowledge receipt of this addendum in the space provided on the signature page of the bid proposal. Failure to do so, may subject the bidder to disqualification. This addendum forms a part of the contract documents.

This is a reissue of Dwgs 3.06.121, 3.06.131, 3.06.601, 3.12.121, 5.06.121, 5.06.131, 5.06.601, 1.06.601, 2.06.121. The addendum number shown in the description block (lower right-hand corner) was incorrectly added and should be corrected to read "Revision 1" however the date of revision is correct. The drawings are being uploaded as separate attachments.

SIGNED:

Paul J. Brennan

**PAUL J. BRENNAN, FNIGP, CPPO
DIRECTOR OF PURCHASING**

ADDENDUM

12/11/19

FILE NAME: I:\Projects\MEG\NMEG0050.00\Drawings\1-06-601-2.dwg PLOT TIME: Wed, 27 Nov 2019 - 3:30pm LAST SAVE: Wed, 27 Nov 2019 - 3:27pm BY: dbeez


HP12 PANEL SCHEDULE									
MAIN RATING: <u>225A</u>			MAIN C.B.: <u>MLO</u>		KAIC RATING: <u>65KAIC</u>				
VOLTAGE: <u>480Y/277V</u>			PHASE: <u>3</u>		WIRE: <u>4</u>		MOUNTING: <u>SURFACE</u>		
CIRC. NO.	LOAD DESCRIPTION	BKR. AMPS	NO. OF POLES	NO. OF POLES	BKR. AMPS	LOAD DESCRIPTION	CIRC. NO.		
1	LTG – RMS 117/119/120/121/122/123/126	20	1	3	*	TRANSFORMER – T12	2		
3	LTG – RMS 125/127/128/129	20	1				4		
5	LTG – CORRIDOR	20	1				6		
7	LTG – EXTERIOR	20	1				8		
9	LTG – EXTERIOR	20	1	–	–	–	10		
11	LTG – ENTRY SIGN	20	1	–	–	–	12		
13	LTG – EXTERIOR	20	1	–	–	–	14		
15	–	–	–	–	–	–	16		
17	–	–	–	–	–	–	18		
19	–	–	–	–	–	–	20		
21	–	–	–	–	–	–	22		
23	–	–	–	–	–	–	24		
25	–	–	–	–	–	–	26		
27	–	–	–	–	–	–	28		
29	–	–	–	–	–	–	30		
31	–	–	–	–	–	–	32		
33	–	–	–	–	–	–	34		
35	SPARE	20	1	1	20	SPARE	36		
37	SPARE	20	1	1	20	SPARE	38		
39	SPARE	20	1	1	20	SPARE	40		
41	SPARE	20	1	1	20	SPARE	42		
LK – PROVIDE LOCKING TABS ON C.B.; GF – GFI TYPE C.B.; AF – ARC FAULT TYPE C.B.; ST – SHUNT TRIP C.B.									
NOTES:									
1.) * – SEE ONE–LINE DIAGRAM FOR BREAKER SIZE.									

PP11 PANEL SCHEDULE									
MAIN RATING: <u>400A</u>			MAIN C.B.: <u>250A</u>			KAIC RATING: <u>22KAIC</u>			
VOLTAGE: <u>208Y/120V</u>			PHASE: <u>3</u>		WIRE: <u>4</u>		MOUNTING: <u>SURFACE</u>		
CIRC. NO.	LOAD DESCRIPTION	BKR. AMPS	NO. OF POLES	NO. OF POLES	BKR. AMPS	LOAD DESCRIPTION	CIRC. NO.		
1	REC – RM 126	20	1	1	20	REC – RM 126	2		
3	SPARE	20	1	1	20	SPARE	4		
5	REC – RM 121/122	20	1	1	20	REC – CORR 130/OFFICE 120	6		
7	REC – OFFICE 120	20	1	1	20	REC – OFFICE 120	8		
9	REC – OFFICE 120	20	1	1	20	REC – OFFICE 120	10		
11	REC – OFFICE 120	20	1	1	20	REC – OUTDOOR	12		
13	REC – RM 119	20	1	1	20	REC – RM 119	14		
15	REC – RM 117	20	1	1	20	REC – RM 123	16		
17	SPARE	20	1	2	60	GEN 2 LOAD CENTER	18		
19	GEN SYSTEM CONTROLLER	20	1	1	20	DOOR RELEASE – NORTH CORR.	20		
21	GEN 1 LOAD CENTER	60	2				22		
23				1	20	DOOR RELEASE – CORR. NEAR MER	24		
25	REC – ROOF	20	1	1	20	REC – RM 125/127	26		
27	TX–1–1 – ROOF	15	1	1	20	SPARE	28		
29	EX–1–1	15	1	1	20	SPARE	30		
31	HOTBOX – HEATER	20	1	1	20	SPARE	32		
33	HOTBOX – HEATER	20	1	1	20	REC – RM 108/109	34		
35	HOTBOX – REC/LTG	20	1	1	20	SPARE	36		
37	SPARE	20	1	1	20	SPARE	38		
39	SPARE	20	1	1	20	HVAC CONTROLS	40		
41	SPARE	20	1	1	20	HVAC CONTROLS	42		
LK – PROVIDE LOCKING TABS ON C.B.; GF – GFI TYPE C.B.; AF – ARC FAULT TYPE C.B.; ST – SHUNT TRIP C.B.									
NOTES:									

HP13 PANEL SCHEDULE									
MAIN RATING: <u>225A</u>			MAIN C.B.: <u>MLO</u>		KAIC RATING: <u>35KAIC</u>				
VOLTAGE: <u>480Y/277V</u>			PHASE: <u>3</u>		WIRE: <u>4</u>		MOUNTING: <u>SURFACE</u>		
CIRC. NO.	LOAD DESCRIPTION	BKR. AMPS	NO. OF POLES	NO. OF POLES	BKR. AMPS	LOAD DESCRIPTION	CIRC. NO.		
1	LTG — EXTERIOR	20	1	3	*	TRANSFORMER — T13	2		
3	—	—	—				4		
5	—	—	—				6		
7	—	—	—				8		
9	—	—	—	1	20	LTG — EXTERIOR	10		
11	—	—	—	1	20	LTG — CORRIDOR	12		
13	—	—	—	1	20	LTG — RM 104/105/114/115/116/124	14		
15	—	—	—	1	20	LTG — RM 102/103/107/108/109/110/112/113	16		
17	—	—	—	—	—	—	18		
19	—	—	—	—	—	—	20		
21	—	—	—	—	—	—	22		
23	—	—	—	—	—	—	24		
25	—	—	—	—	—	—	26		
27	—	—	—	—	—	—	28		
29	—	—	—	—	—	—	30		
31	—	—	—	—	—	—	32		
33	—	—	—	—	—	—	34		
35	SPARE	20	1	1	20	SPARE	36		
37	SPARE	20	1	1	20	SPARE	38		
39	SPARE	20	1	1	20	SPARE	40		
41	SPARE	20	1	1	20	SPARE	42		
LK — PROVIDE LOCKING TABS ON C.B.; GF — GFI TYPE C.B.; AF — ARC FAULT TYPE C.B.; ST — SHUNT TRIP C.B.									
NOTES:									
1.) * — SEE ONE–LINE DIAGRAM FOR BREAKER SIZE.									

PP12 PANEL SCHEDULE									
MAIN RATING: <u>225A</u>			MAIN C.B.: <u>225A</u>			KAIC RATING: <u>22KAIC</u>			
VOLTAGE: <u>208Y/120V</u>			PHASE: <u>3</u>		WIRE: <u>4</u>		MOUNTING: <u>SURFACE</u>		
CIRC. NO.	LOAD DESCRIPTION	BKR. AMPS	NO. OF POLES	NO. OF POLES	BKR. AMPS	LOAD DESCRIPTION	CIRC. NO.		
1	REC – CHILLER	20	1	1	20	SPARE	2		
3	SPARE	20	1	1	20	SPARE	4		
5	SPARE	20	1	1	20	SPARE	6		
7	SPARE	20	1	1	20	SPARE	8		
9	SPARE	20	1	1	20	SPARE	10		
11	SPARE	20	1	1	20	SPARE	12		
13	SPARE	20	1	1	20	REC – GLYCOL TANK RM 128	14		
15	SPARE	20	1	1	20	SPARE	16		
17	ACCU–2	15	2	1	20	SPARE	18		
19				1	20	SPARE	20		
21	JBOX – RM 123	20	1	1	20	SPARE	22		
23	SPARE	20	1	1	20	VAVS	24		
25	HAND DRYER – RM 123	20	1	1	20	VAVS	26		
27	HAND DRYER – RM 123	20	1	1	20	SPARE	28		
29	SPARE	20	1	1	20	SPARE	30		
31	SPARE	20	1	1	20	SPARE	32		
33	SPARE	20	1	1	20	SPARE	34		
35	SPARE	20	1	1	20	SPARE	36		
37	SPARE	20	1	1	20	SPARE	38		
39	SPARE	20	1	1	20	SPARE	40		
41	SPARE	20	1	1	20	SPARE	42		
LK – PROVIDE LOCKING TABS ON C.B.; GF – GFI TYPE C.B.; AF – ARC FAULT TYPE C.B.; ST – SHUNT TRIP C.B.									
NOTES:									

PP13 PANEL SCHEDULE									
MAIN RATING: <u>400A</u>			MAIN C.B.: <u>250A</u>			KAIC RATING: <u>22KAIC</u>			
VOLTAGE: <u>208Y/120V</u>			PHASE: <u>3</u>		WIRE: <u>4</u>		MOUNTING: <u>SURFACE</u>		
CIRC. NO.	LOAD DESCRIPTION	BKR. AMPS	NO. OF POLES	NO. OF POLES	BKR. AMPS	LOAD DESCRIPTION	CIRC. NO.		
1	REC – ROOF	20	1	1	20	SPARE	2		
3	REC – OUTDOORS	20	1	1	20	SPARE	4		
5	REC – RM 109/110	20	1	1	20	REC – RM 108/109	6		
7	REC – RM 107/108	20	1	1	20	REC – RM 110	8		
9	REC – RM 107	20	1	1	20	REC – RM 107	10		
11	REC – RM 113/114	20	1	1	20	REC – RM 113	12		
13	REC – RM 113	20	1	1	20	REC – RM 113	14		
15	REC – RM 111	20	1	1	20	REC – CORR 106	16		
17	REC – RM 112	20	1	1	20	REC – OUTDOORS	18		
19	REC – RM 103	20	1	1	20	HAND DRYER – RM 112	20		
21	REC – RM 102	20	1	1	20	JBOX – RM 112	22		
23	HAND DRYER – RM 124	20	1	1	20	REC – RM 103	24		
25	TX–1–3 – RM 112	15	1	1	20	REC – RM 102	26		
27	SPARE	20	1	1	15	TX–1–2 – ROOF	28		
29	REC – RM 115	20	1	1	20	REC – RM 105	30		
31	REC – RM 105	20	1	1	20	REC – RM 104	32		
33	REC – RM 104	20	1	1	20	REC – RM 104	34		
35	REC – RM 124	20	1	1	20	REC – RM 104/116	36		
37	JBOX – RM 124	20	1	1	20	JBOX – WATER FOUNTAIN	38		
39	HAND DRYER – RM 124	20	1	1	20	REC – BOTTLE FILLER	40		
41	REC – RM 104	20	1	1	20	REC – RM 115	42		
43	REC – RM 115	20	1	1	20	REC – RM 115	44		
45	REC – RM 115	20	2	1	20	SPARE	46		
47				1	20	DOOR RELEASE – CORR. 106 NORTHWEST	48		
49	HVAC CONTROLS	20	1	1	20	DOOR RELEASE – CORR. 106 SOUTH	50		
51	HVAC CONTROLS	20	1	–	–		52		
53	–	–	–	–	–		54		
55	–	–	–	–	–		56		
57	–	–	–	–	–		58		
59	–	–	–	–	–		60		
61	–	–	–	–	–		62		
63	–	–	–	–	–		64		
65	SPARE	20	1	1	20	SPARE	66		
67	SPARE	20	1	1	20	SPARE	68		
69	SPARE	20	1	1	20	SPARE	70		
71	SPARE	20	1	1	20	SPARE	72		
LK – PROVIDE LOCKING TABS ON C.B.; GF – GFI TYPE C.B.; AF – ARC FAULT TYPE C.B.; ST – SHUNT TRIP C.B.									
NOTES:									

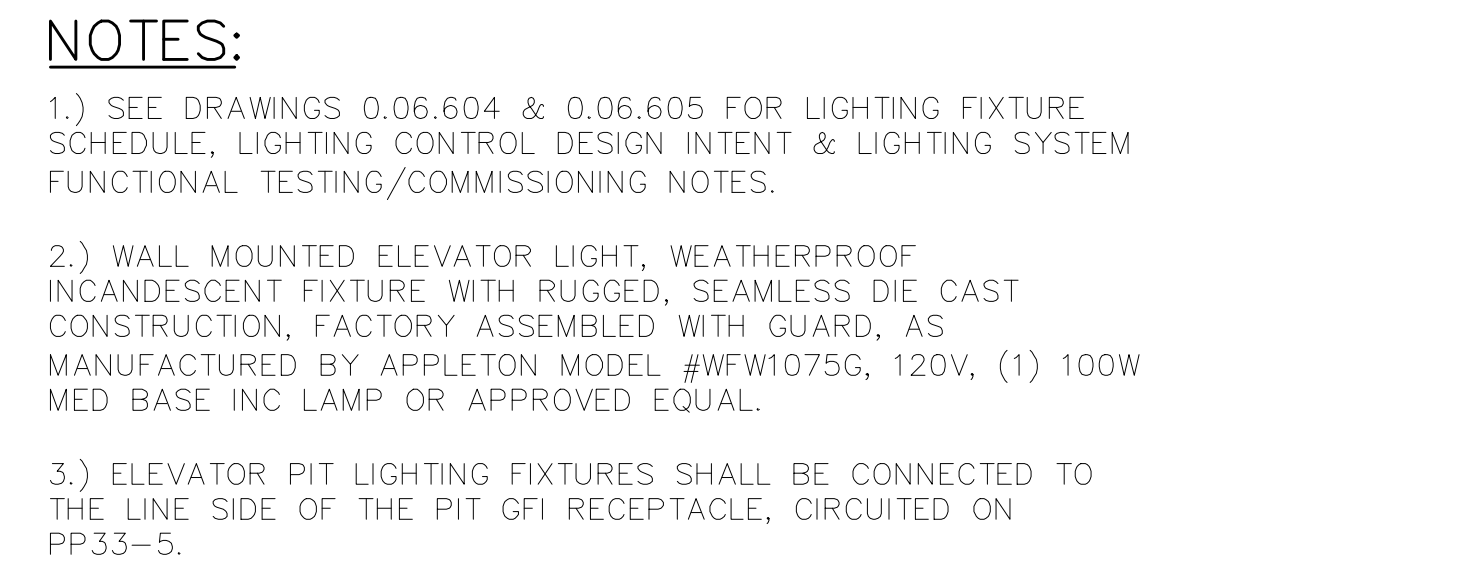

- ① - TIME CLOCK WITH OCCUPANCY SENSOR OVERRIDE AFTER HOURS.
- ② - LINE VOLTAGE ON/OFF WALL SWITCHING.
- ③ - LOW VOLTAGE WALL SWITCH VACANCY SENSOR.
- ④ - LOW VOLTAGE MANUAL ON WALL SWITCH WITH CEILING MOUNT VACANCY.
- ⑤ - LOW VOLTAGE WALL SWITCH WITH CEILING MOUNTED OCCUPANCY SENSOR.
- ⑥ - OCCUPANCY SENSOR TO 100%, DIMMED AUTOMATICALLY TO 50%.
- ⑦ - OUTDOOR PHOTOSENSOR CONTROL



COPYRIGHT © 2019, McLAREN ENGINEERING GROUP

F NAME:	I:\Projects\MFG\NMEG0050 00\Nms\3-06-121.dwg	PLOT TIME:	Wed 27 Nov 2019 - 2:33pm	LAST SAVE:	Wed 27 Nov 2019 - 2:22pm	BY:	vbn07
---------	--	------------	--------------------------	------------	--------------------------	-----	-------

FILE NAME: I:\Projects\MEG\NMEG0050.00\Drawings\3.06-131-2.dwg PLOT TIME: Wed, 27 Nov 2019 - 3:30pm LAST SAVE: Wed, 27 Nov 2019 - 3:25pm BY: vbez

WARNING - IT IS A VIOLATION OF NEW YORK STATE EDUCATIONAL LAW, SECTION 7209.2, FOR ANY PERSON, UNLESS HE IS ACTING UNDER THE DIRECTION OF A LICENSED PROFESSIONAL ENGINEER OR LAND SURVEYOR, TO ALTER THIS DOCUMENT IN ANY WAY. IF ALTERED, THE ALTERING PERSON SHALL COMPLY WITH THE REQUIREMENTS OF NEW YORK EDUCATIONAL LAW, SECTION 7209.2

COPYRIGHT © 2019, McLAREN ENGINEERING GROUP

CONSULTANTS ARCHITECT

STV 100 Years

STV Architects, P.C.
225 Park Avenue South
New York, NY 10003
(212) 777-4400 FAX: (212) 473-2780
www.stvinc.com

MEP ENGINEER

OLA Consulting Engineers

50 Broadway,
Hawthorne, NY 10532
914.747.2800

8 West 38th Street,
Suite 601
New York, NY 10018
646.848.4110
ola.com NMEG0050.00

FACILITIES CONSULTANT

Gannett Fleming

LANDSCAPE ARCHITECT

IQ

Imbiano-Quigley
Landscape Architects

31 Montemore Ave., 7th Floor
White Plains, New York 10601
admin@iqlandscape.com
(914) 232-4000

PROJECT


COUNTY OF ROCKLAND
CAPITAL PROJECT NO. 1307
HIGHWAY DEPARTMENT /
EMERGENCY OPERATIONS FACILITY
COUNTY OF ROCKLAND, NEW YORK

McLaren ENGINEERING GROUP

applied ingenuity

M. G. McLaren Engineering
and Land Surveying P.C.

530 Chestnut Ridge Road, Woodcliff Lake, NJ 07677
T: 201.775.6000 F: 201.746.8522 www.mgmclaren.com

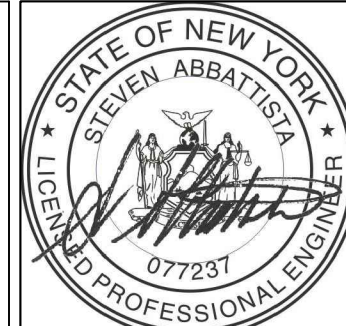

SHEET NAME

**ELECTRICAL BUILDING 03
POWER PLAN**

1	11/27/19	ADDENDUM 07	VB
No.	DATE	REVISION	BY

PROJECT NO. 130439

SCALE As indicated

DATE OCTOBER 30, 2019

DRAWN BY CT


CHECKED BY ML

APPROVED BY DS

ISSUED FOR **BID SET**

DRAWING NO. **3.06.131**

OF SHTS

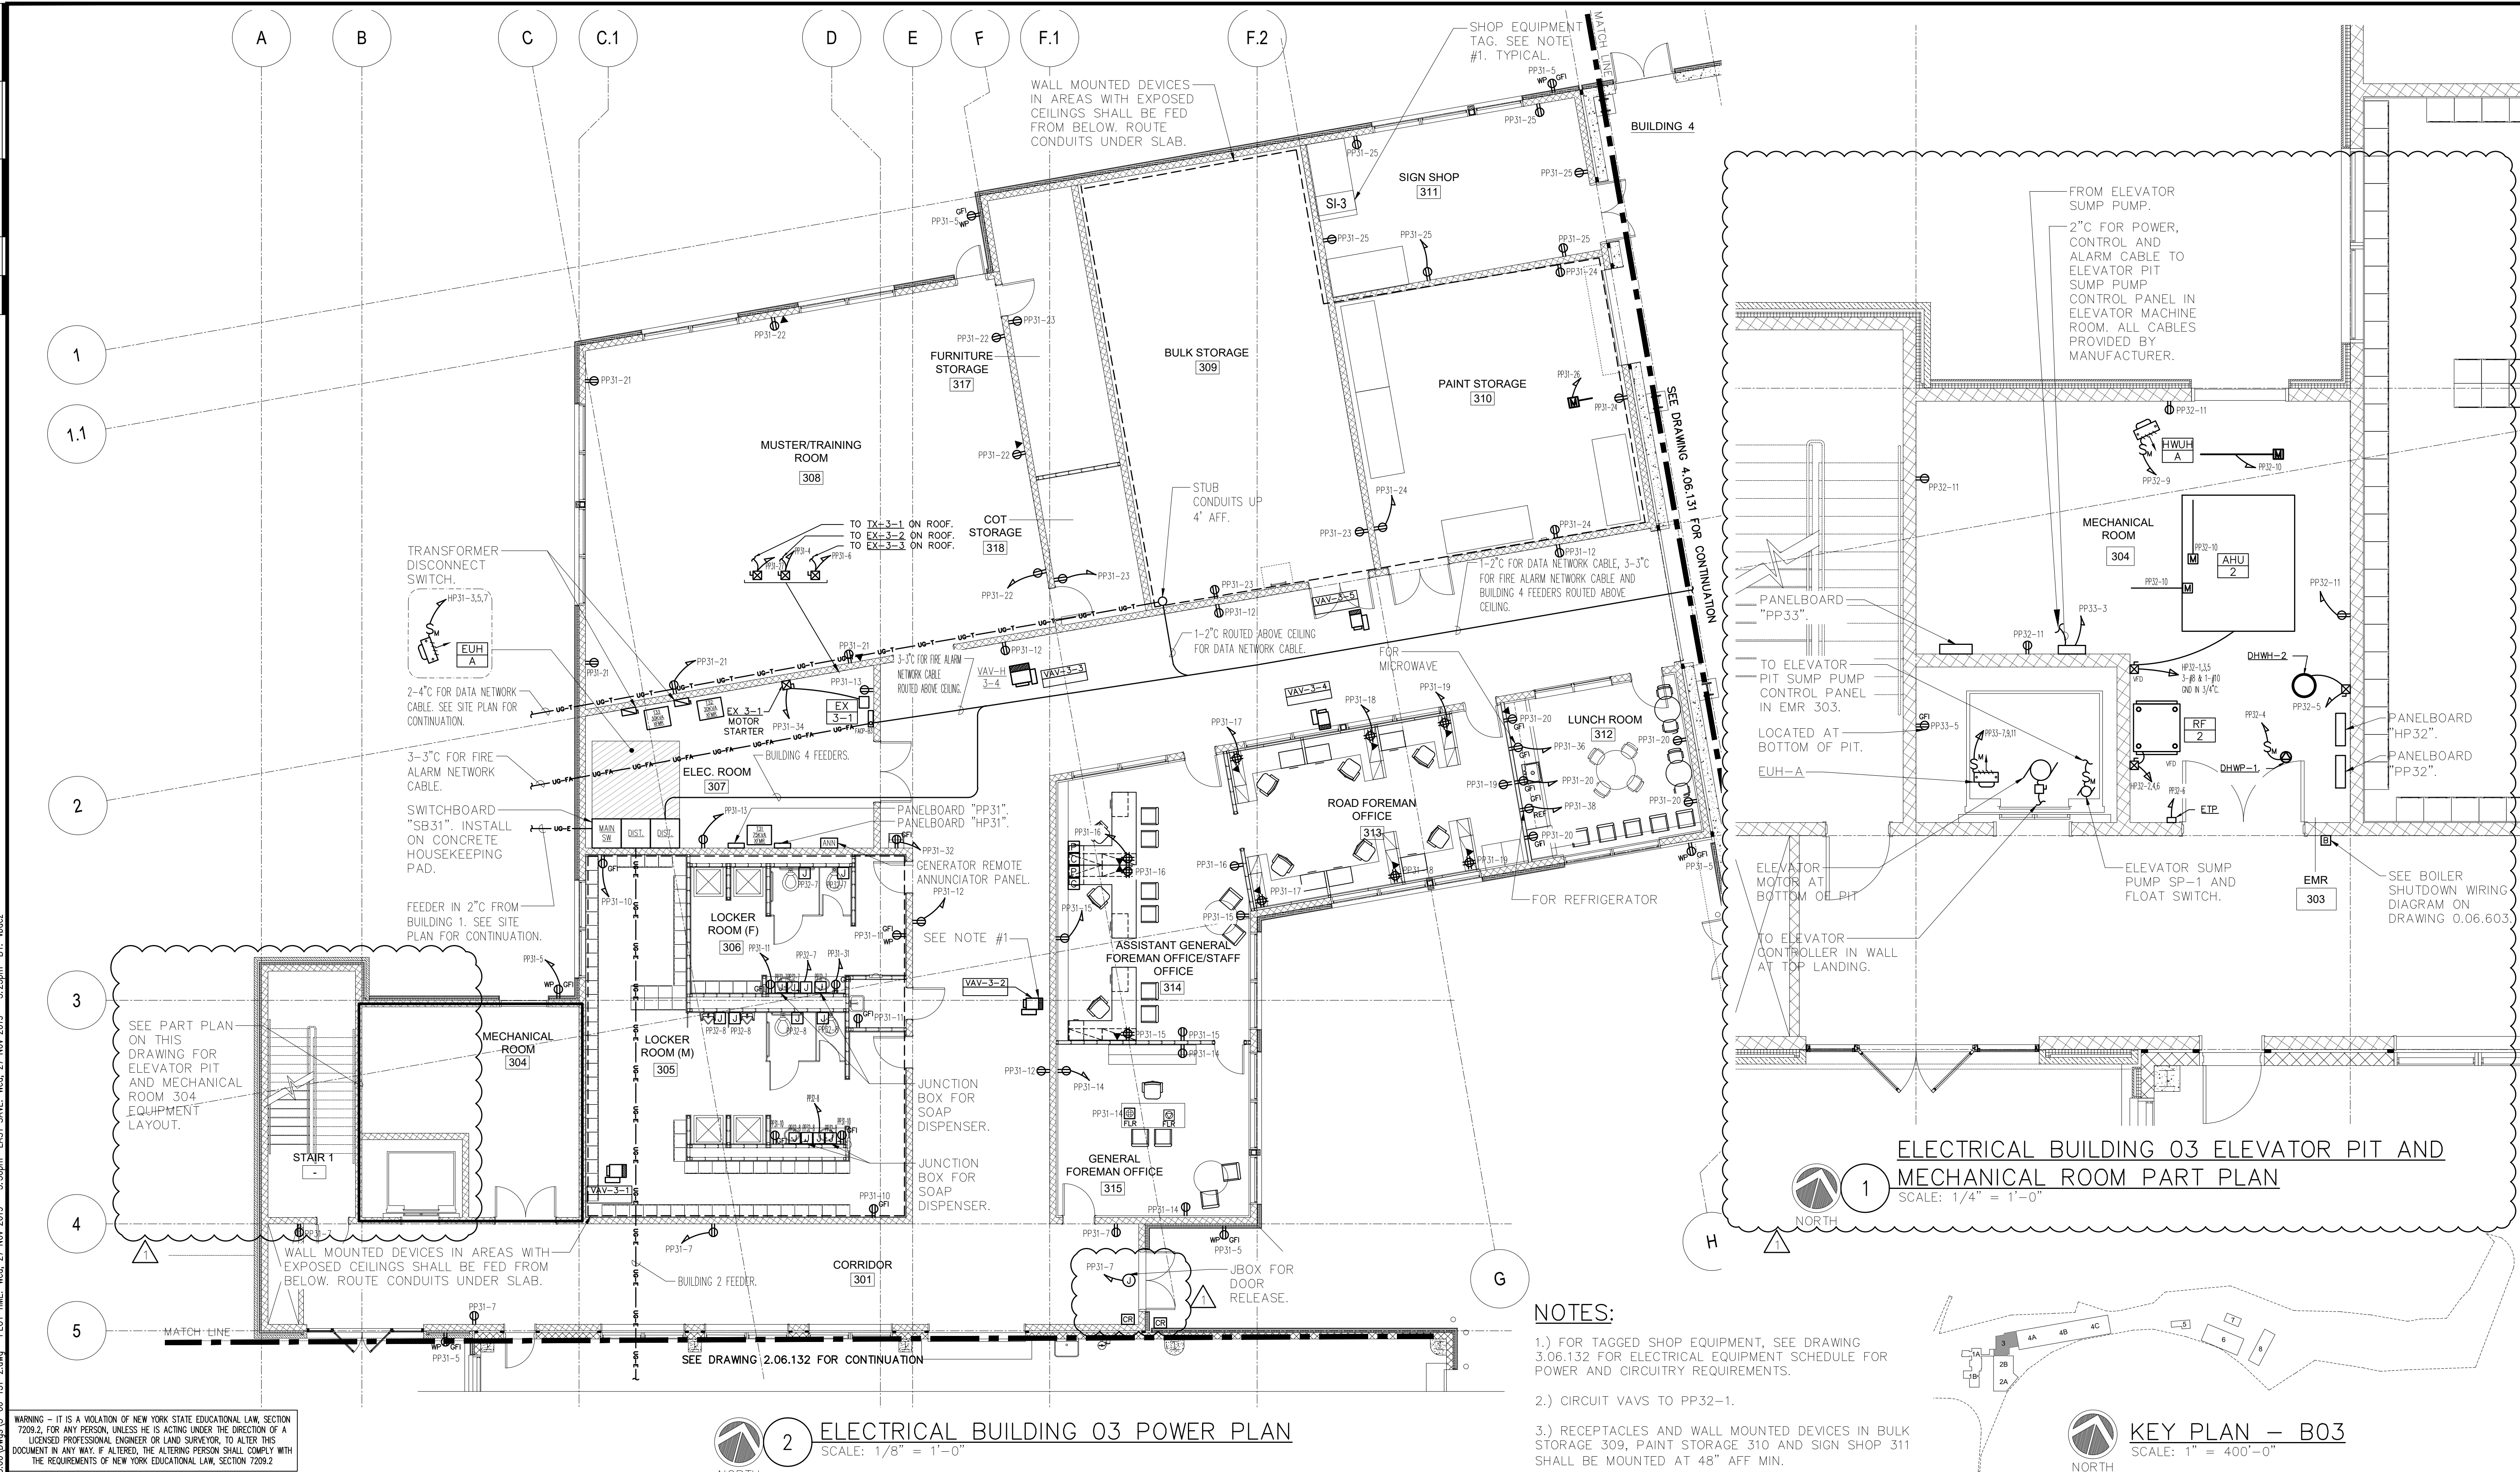

2 ELECTRICAL BUILDING 03 POWER PLAN
SCALE: 1/8" = 1'-0"

NOTES:

- 1.) FOR TAGGED SHOP EQUIPMENT, SEE DRAWING 3.06.132 FOR ELECTRICAL EQUIPMENT SCHEDULE FOR POWER AND CIRCUITRY REQUIREMENTS.
- 2.) CIRCUIT VAVS TO PP32-1.
- 3.) RECEPTACLES AND WALL MOUNTED DEVICES IN BULK STORAGE 309, PAINT STORAGE 310 AND SIGN SHOP 311 SHALL BE MOUNTED AT 48" AFF MIN.

1 ELECTRICAL BUILDING 03 ELEVATOR PIT AND MECHANICAL ROOM PART PLAN
SCALE: 1/4" = 1'-0"

KEY PLAN - B03
SCALE: 1" = 400'-0"


FILE NAME: I:\Projects\MEG\NMEG0050.Dwg; 3:06:50; 27 Nov 2019 -- 2:35pm LAST SAVE: Wed, 27 Nov 2019 -- 2:24pm BY: wbez

PP31 PANEL SCHEDULE									
MAIN RATING: <u>400A</u>			MAIN C.B.: <u>250A</u>			KAIC RATING: <u>22KAIC</u>			
VOLTAGE: <u>208/120V</u>			PHASE: <u>3</u>		WIRE: <u>4</u>		MOUNTING: <u>SURFACE</u>		
CIRC. NO.	LOAD DESCRIPTION	BKR. AMPS	NO. OF POLES	NO. OF POLES	BKR. AMPS	LOAD DESCRIPTION	CIRC. NO.		
1	SI-1	20	1	1	20	SPARE	2		
3	SI-3	20	1	1	15	EX-3-2	4		
5	RECP WP/GFI OUTSIDE	20	1	1	15	EX-3-3	6		
7	RECP CORRIDOR	20	1	1	20	SPARE	8		
9	ELEVATOR SHUNT TRIP CB	20	1	1	20	RECP LOCKER ROOM (M)	10		
11	RECP LOCKER ROOM (F)	20	1	1	20	RECP CORRIDOR	12		
13	RECP ELECTRICAL ROOM	20	1	1	20	RECP GENERAL MAIN OFFICE	14		
15	RECP GENERAL FORMAN OFFICE	20	1	1	20	RECP GENERAL FORMAN OFFICE	16		
17	RECP ROAD FOREMAN OFFICE	20	1	1	20	RECP ROAD FOREMAN OFFICE	18		
19	RECP ROAD FOREMAN OFFICE	20	1	1	20	RECP LUNCH ROOM	20		
21	RECP MUSTER/TRAINING ROOM	20	1	1	20	RECP MUSTER/TRAINING ROOM	22		
23	RECP FURNITURE/COAT/BULK STORAGE	20	1	1	20	RECP PAINT STORAGE	24		
25	RECP SIGN SHOP	20	1	1	20	MOTORIZED DAMPER - PAINT STORAGE 310	26		
27	TX-3-1	20	1	-	-	-	28		
29	REC - CORRIDOR 130	20	1	-	-	-	30		
31	REC - RM 306	20	1	1	20	WATER FOUNTAIN	32		
33	-	-	-	1	15	EX-3-1	34		
35	SPARE	20	1	1	20	RECP MICROWAVE	36		
37	SPARE	20	1	1	20	RECP REFRIGERATOR	38		
39	SPARE	20	1	1	20	SPARE	40		
41	SPARE	20	1	1	20	SPARE	42		
43	-	-	-	-	-	-	44		
45	-	-	-	-	-	-	46		
47	-	-	-	-	-	-	48		
49	-	-	-	-	-	-	50		
51	-	-	-	-	-	-	52		
53	-	-	-	-	-	-	54		
55	-	-	-	-	-	-	56		
57	-	-	-	-	-	-	58		
59	SPARE	20	1	1	20	SPARE	60		
61	SPARE	20	1	1	20	SPARE	62		
63	SPARE	20	1	1	20	SPARE	64		
65	SPARE	20	1	1	20	SPARE	66		
LK - PROVIDE LOCKING TABS ON C.B.; GF - GFI TYPE C.B.; AF - ARC FAULT TYPE C.B.; ST - SHUNT TRIP C.B.									
NOTES:									

HP31 PANEL SCHEDULE							
MAIN RATING: <u>225A</u>		MAIN C.B.: <u>MLO</u>		KAIC RATING: <u>65KAIC</u>			
VOLTAGE: <u>480/277V</u>		PHASE: <u>3</u>		WIRE: <u>4</u>		MOUNTING: <u>SURFACE</u>	
CIRC. NO.	LOAD DESCRIPTION	BKR. AMPS	NO. OF POLES	NO. OF POLES	BKR. AMPS	LOAD DESCRIPTION	CIRC. NO.
1	CORRIDOR LIGHTING 130	20	1	1	20	LIGHTING	2
3							4
5	EUH-A – ELEC. ROOM 307	15	3	3	*	TRANSFORMER – T31	6
7							8
9	STAIR 1 LTG – SOUTH SIDE	20	1	1	20	STAIR 1 LTG – NORTH SIDE	10
11	–	–	–	1	20	LIGHTING	12
13	–	–	–	1	20	EXTERIOR LIGHTING	14
15	–	–	–	–	–	–	16
17	–	–	–	–	–	–	18
19	–	–	–	–	–	–	20
21	–	–	–	–	–	–	22
23	–	–	–	–	–	–	24
25	–	–	–	–	–	–	26
27	–	–	–	–	–	–	28
29	–	–	–	–	–	–	30
31	–	–	–	–	–	–	32
33	–	–	–	–	–	–	34
35	SPARE	20	1	1	20	SPARE	36
37	SPARE	20	1	1	20	SPARE	38
39	SPARE	20	1	1	20	SPARE	40
41	SPARE	20	1	1	20	SPARE	42
LK – PROVIDE LOCKING TABS ON C.B.; GF – GFI TYPE C.B.; AF – ARC FAULT TYPE C.B.; ST – SHUNT TRIP C.B.							
NOTES:							
1.) * – SEE ONE–LINE DIAGRAM FOR BREAKER SIZE.							

PP32 PANEL SCHEDULE									
MAIN RATING: <u>125A</u>			MAIN C.B.: <u>MLO</u>			KAIC RATING: <u>10KAIC</u>			
VOLTAGE: <u>208/120V</u>			PHASE: <u>3</u>		WIRE: <u>4</u>		MOUNTING: <u>SURFACE</u>		
CIRC. NO.	LOAD DESCRIPTION	BKR. AMPS	NO. OF POLES	NO. OF POLES	BKR. AMPS	LOAD DESCRIPTION	CIRC. NO.		
1	VAV'S	20	1	1	20	SPARE	2		
3	SPARE	20	1	1	15	DHWH-1 - RM 304	4		
5	DHWP-1 - RM 304	15	1	1	15	ETP - RM 304	6		
7	JBOX - RM 306	20	1	1	20	JBOX - RM 305	8		
9	HWUH-A - RM 304	20	1	1	20	MOTORIZED DAMPERS - RM 304	10		
11	REC - RM 304	20	1	1	20	REC - ROOF	12		
13	BOILER BREAK GLASS	15	1	1	20	REC - ROOF	14		
15	-	-	-	-	-	-	16		
17	-	-	-	-	-	-	18		
19	-	-	-	-	-	-	20		
21	-	-	-	1	20	HVAC CONTROLS	22		
23	-	-	-	1	20	HVAC CONTROLS	24		
25	-	-	-	-	-	-	26		
27	-	-	-	-	-	-	28		
29	-	-	-	-	-	-	30		
31	-	-	-	-	-	-	32		
33	-	-	-	-	-	-	34		
35	SPARE	20	1	1	20	SPARE	36		
37	SPARE	20	1	1	20	SPARE	38		
39	SPARE	20	1	1	20	SPARE	40		
41	SPARE	20	1	1	20	SPARE	42		
LK - PROVIDE LOCKING TABS ON C.B.; GF - GFI TYPE C.B.; AF - ARC FAULT TYPE C.B.; ST - SHUNT TRIP C.B.									
NOTES:									

HP32 PANEL SCHEDULE							
MAIN RATING: <u>225A</u>		MAIN C.B.: <u>MLO</u>		KAIC RATING: <u>35KAIC</u>			
VOLTAGE: <u>480/277V</u>		PHASE: <u>3</u>		WIRE: <u>4</u>		MOUNTING: <u>SURFACE</u>	
CIRC. NO.	LOAD DESCRIPTION	BKR. AMPS	NO. OF POLES	NO. OF POLES	BKR. AMPS	LOAD DESCRIPTION	CIRC. NO.
1	AHU-2	35	3	3	15	RF-2	2
3							4
5							6
7	EUH-A	15	3	-	-	-	8
9				-	-	-	10
11				-	-	-	12
13	-	-	-	-	-	-	14
15	-	-	-	-	-	-	16
17	-	-	-	-	-	-	18
19	-	-	-	-	-	-	20
21	-	-	-	-	-	-	22
23	-	-	-	-	-	-	24
25	-	-	-	-	-	-	26
27	-	-	-	-	-	-	28
29	-	-	-	-	-	-	30
31	-	-	-	-	-	-	32
33	-	-	-	-	-	-	34
35	SPARE	20	1	1	20	SPARE	36
37	SPARE	20	1	1	20	SPARE	38
39	SPARE	20	1	1	20	SPARE	40
41	SPARE	20	1	1	20	SPARE	42
LK - PROVIDE LOCKING TABS ON C.B.; GF - GFI TYPE C.B.; AF - ARC FAULT TYPE C.B.; ST - SHUNT TRIP C.B.							
NOTES:							

 
PP33 PANEL SCHEDULE									
MAIN RATING: <u>125A</u>			MAIN C.B.: <u>MLO</u>		KAIC RATING: <u>10KAIC</u>				
VOLTAGE: <u>208/120V</u>			PHASE: <u>3</u>		WIRE: <u>4</u>		MOUNTING: <u>SURFACE</u>		
CIRC. NO.	LOAD DESCRIPTION	BKR. AMPS	NO. OF POLES	NO. OF POLES	BKR. AMPS	LOAD DESCRIPTION	CIRC. NO.		
1		-	-	1	20	ELEV. CONTROLLER	2		
3	ELEV. SUMP PUMP CONTROLLER	20	1	1	20	ELEV. CAR LIGHTING	4		
5	REC/LIGHTING - ELEV PIT	20	1		-	-	6		
7				-	-		8		
9	EUH-A	15	3	-	-		10		
11				-	-		12		
13	-	-	-	-	-		14		
15	-	-	-	-	-		16		
17	-	-	-	-	-		18		
19	-	-	-	-	-		20		
21	-	-	-	-	-		22		
23	-	-	-	-	-		24		
25	-	-	-	-	-		26		
27	-	-	-	-	-		28		
29	-	-	-	-	-		30		
31	-	-	-	-	-		32		
33	-	-	-	-	-		34		
35	SPARE	20	1	1	20	SPARE	36		
37	SPARE	20	1	1	20	SPARE	38		
39	SPARE	20	1	1	20	SPARE	40		
41	SPARE	20	1	1	20	SPARE	42		

LK - PROVIDE LOCKING TABS ON C.B.; GF - GFI TYPE C.B.; AF - ARC FAULT TYPE C.B.;

ST - SHUNT TRIP C.B.

NOTES:

FILE NAME: I:\Projects\MEG\05050.00\Drawings\5-06-121.dwg PLOT TIME: Wed, 27 Nov 2019 - 3:25pm LAST SAVE: Wed, 27 Nov 2019 - 3:24pm BY: mlls

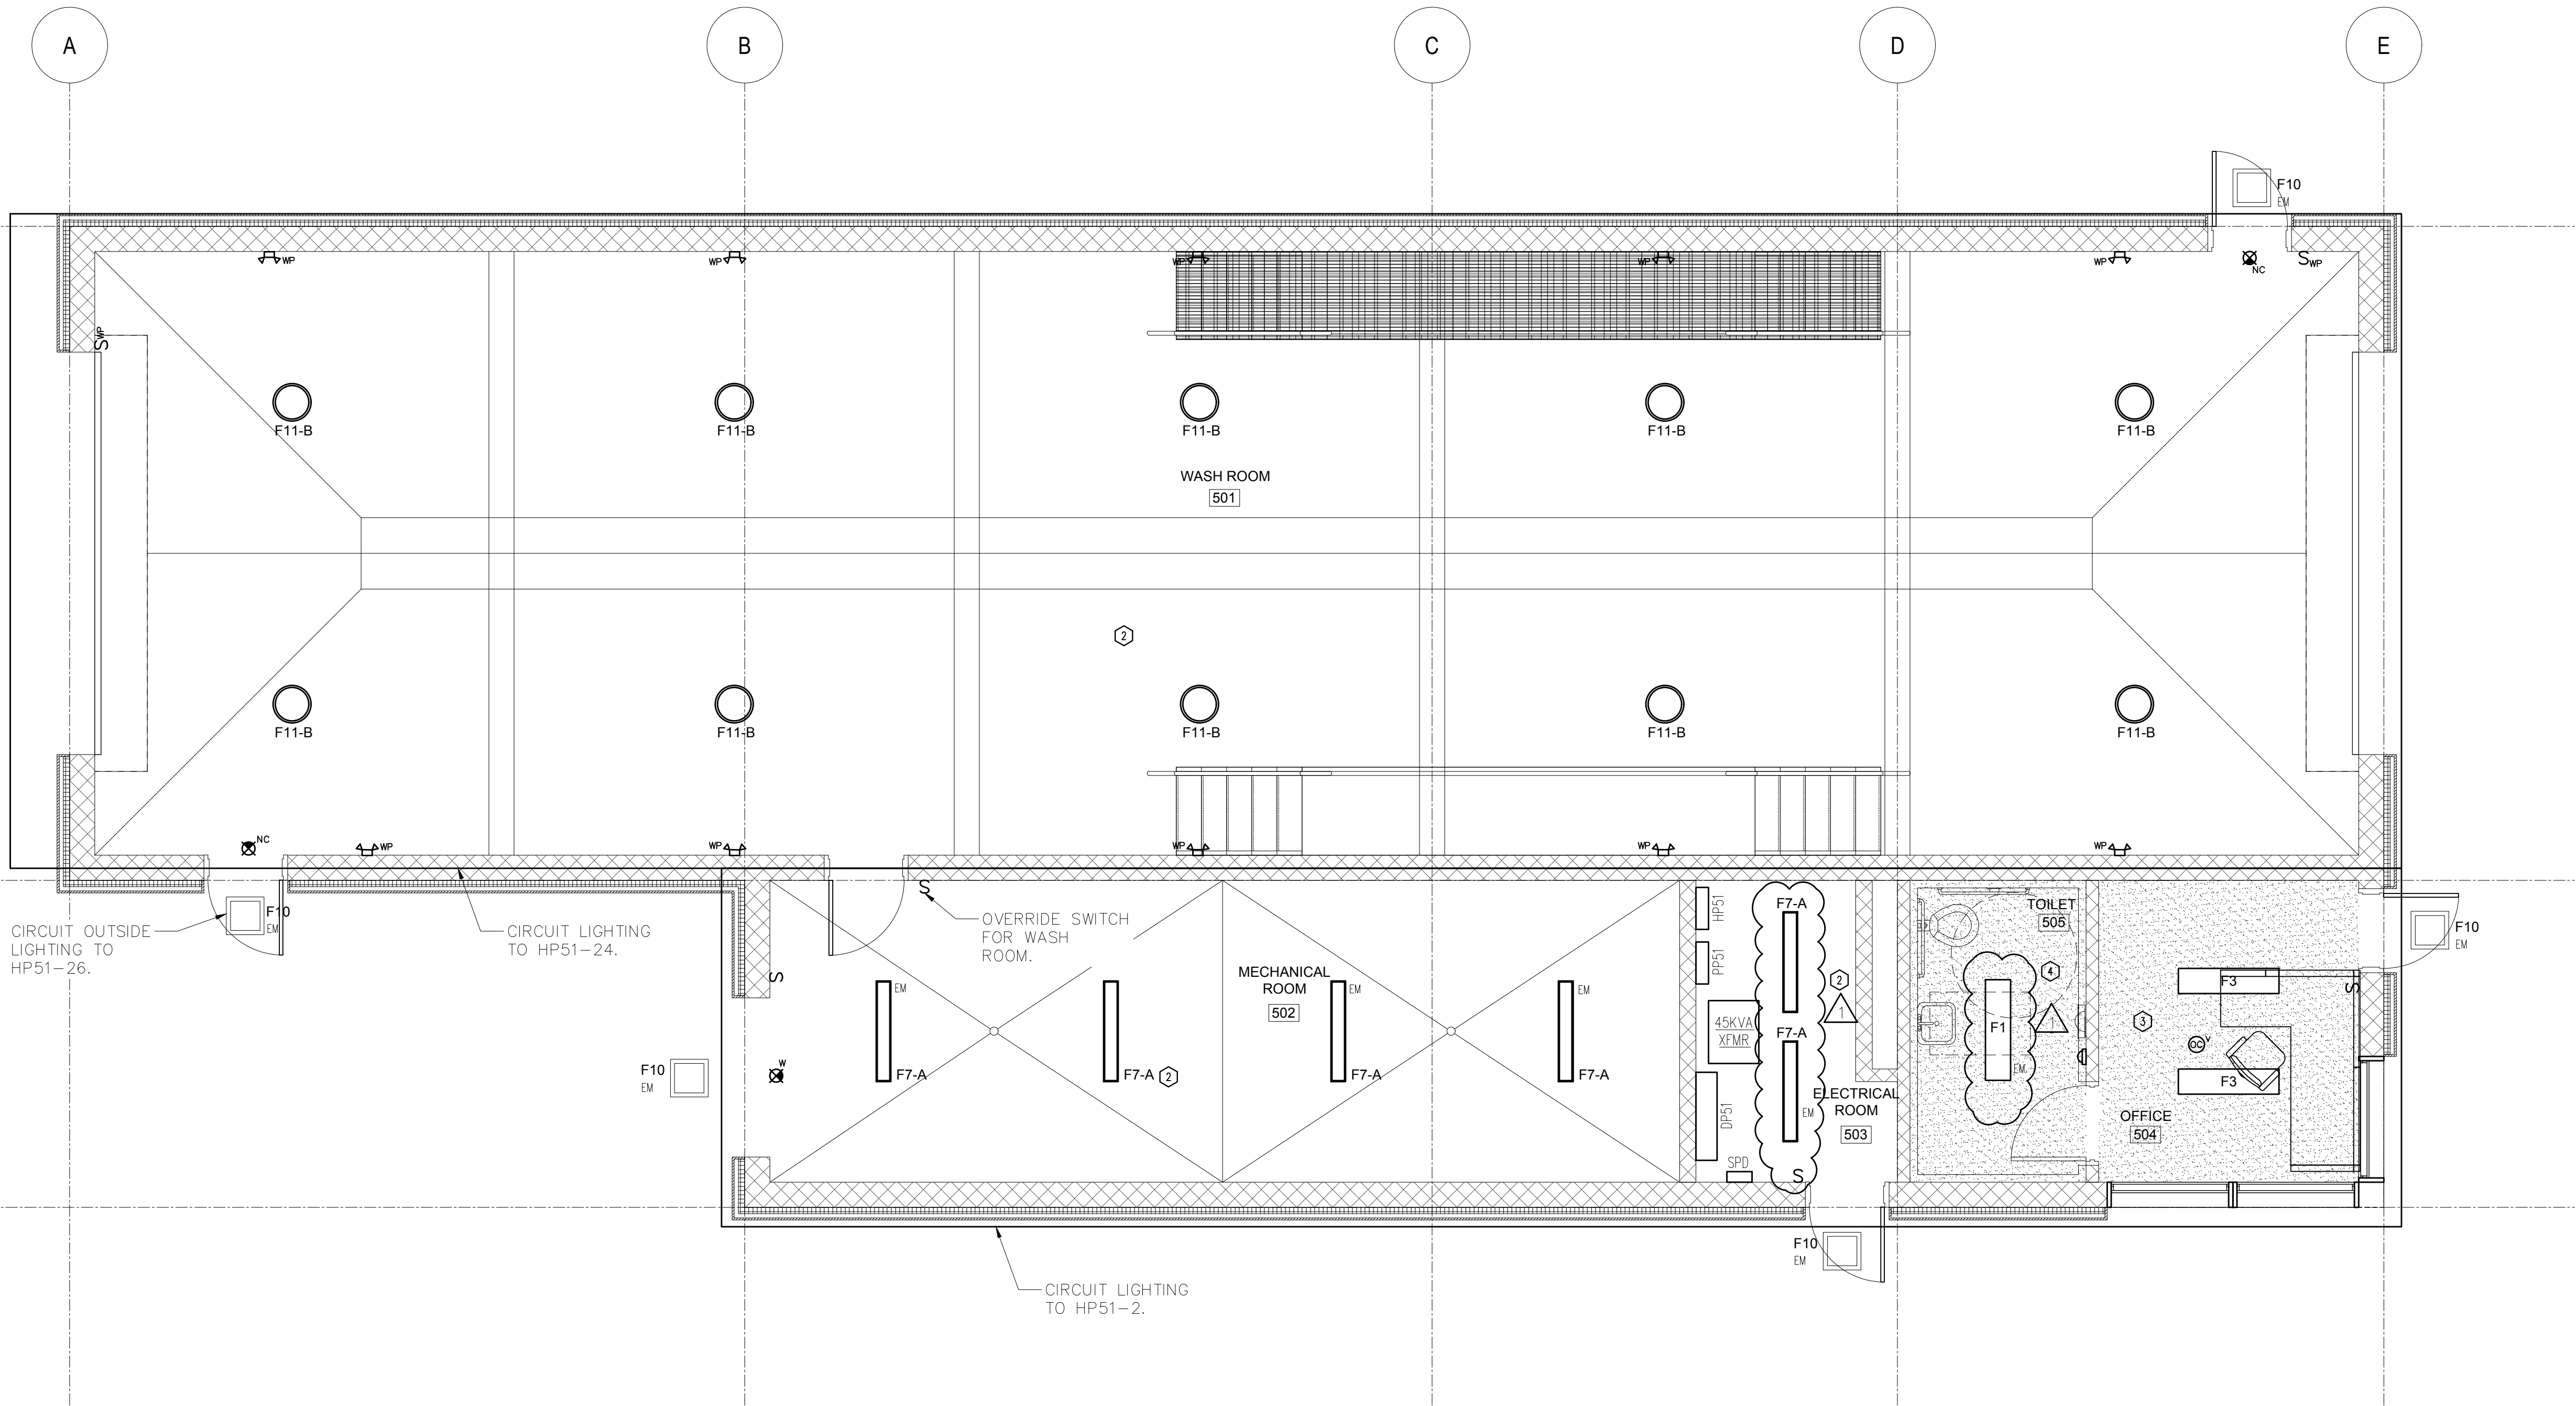


LIGHTING CONTROL LEGEND

- ① - TIME CLOCK WITH OCCUPANCY SENSOR OVERRIDE AFTER HOURS. (NOT USED)
- ② - LINE VOLTAGE ON/OFF WALL SWITCHING.
- ③ - LOW VOLTAGE MANUAL ON WALL SWITCH WITH CEILING MOUNT VACANCY.
- ④ - LOW VOLTAGE WALL SWITCH OCCUPANCY SENSOR.

ADD ALTERNATE #1

ALL WORK ASSOCIATED WITH BUILDING 5 SHALL BE PRICED AS PART OF ADD ALTERNATE #1.

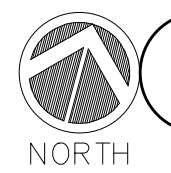


1 ELECTRICAL BUILDING 05 LIGHTING PLAN

SCALE: 1/4" = 1'-0"

NOTES:

- 1.) SEE DRAWINGS 0.06.604 & 0.06.605 FOR LIGHTING FIXTURE SCHEDULE, LIGHTING CONTROL DESIGN INTENT & LIGHTING SYSTEM FUNCTIONAL TESTING/COMMISSIONING NOTES.
- 2.) ALL CONDUITS IN WASH ROOM AND MECHANICAL ROOM SHALL BE SCHEDULE 80 PVC.

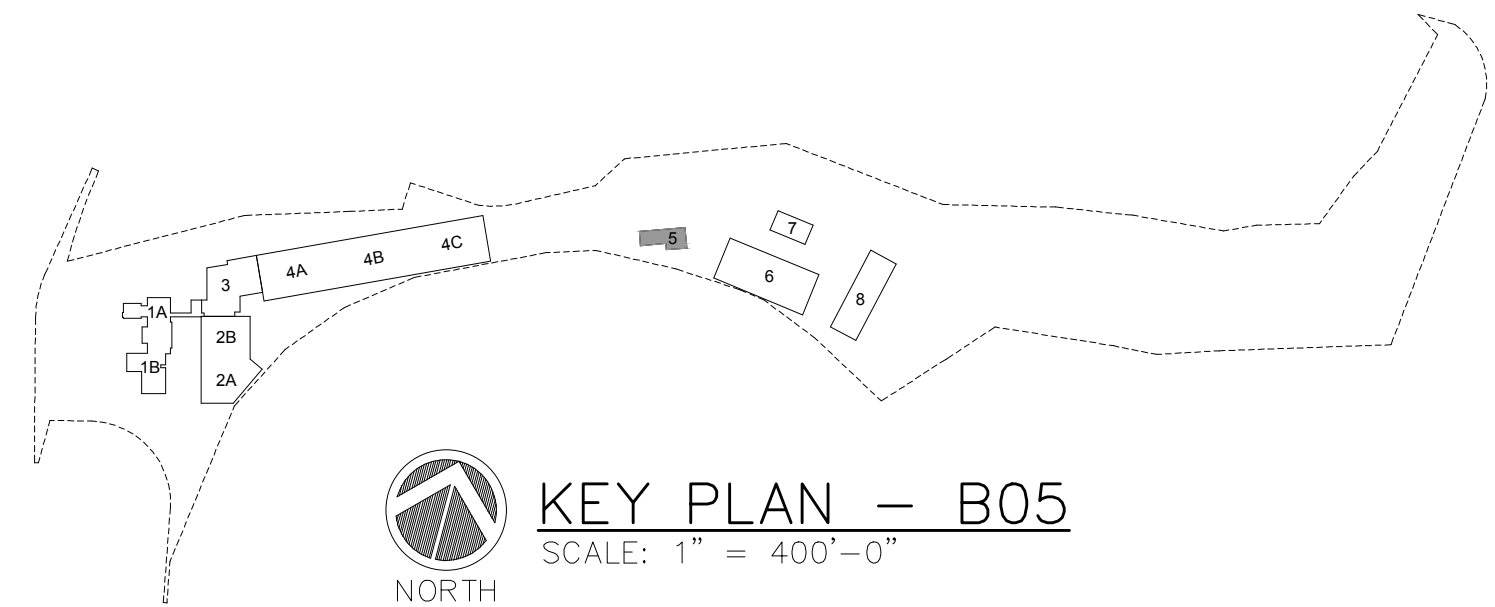

KEY PLAN - B05

SCALE: 1" = 400'-0"

WARNING - IT IS A VIOLATION OF NEW YORK STATE EDUCATIONAL LAW, SECTION 7209.2, FOR ANY PERSON, UNLESS HE IS ACTING UNDER THE DIRECTION OF A LICENSED PROFESSIONAL ENGINEER OR LAND SURVEYOR, TO ALTER THIS DOCUMENT IN ANY WAY. IF ALTERED, THE ALTERING PERSON SHALL COMPLY WITH THE REQUIREMENTS OF NEW YORK EDUCATIONAL LAW, SECTION 7209.2

COPYRIGHT © 2019, McLAREN ENGINEERING GROUP

STV 100 Years
STV Architects, P.C.
225 Park Avenue South
New York, NY 10003
(212) 777-4400 FAX: (212) 473-2780
www.stvinc.com


OLA Consulting Engineers
50 Broadway,
Hawthorne, NY 10532
914.747.2800
8 West 38th Street,
Suite 501
New York, NY 10018
646.648.4110
ola.com NMEG0050.00

Gannett Fleming

IQ
Imbiano-Quigley
Landscape Architects
31 Monmouth Ave., 7th Floor
White Plains, New York 10601
admin@iqlandscape.com
(914) 232-6090

PROJECT
**COUNTY OF ROCKLAND
CAPITAL PROJECT NO. 1307
HIGHWAY DEPARTMENT /
EMERGENCY OPERATIONS FACILITY**
COUNTY OF ROCKLAND, NEW YORK

McLaren
ENGINEERING GROUP
applied ingenuity
M. G. McLaren Engineering
and Land Surveying P.C.
530 Chestnut Ridge Road, Woodcliff Lake, NJ 07677
T: 201.775.6000 F: 201.746.8522 www.mgmclaren.com

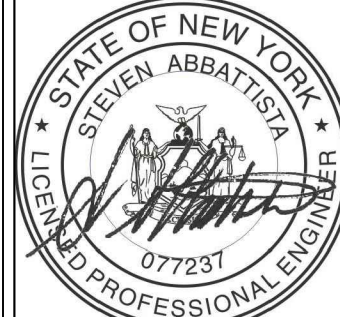


ELECTRICAL BUILDING 05 LIGHTING PLAN

No.	DATE	ADDENDUM 07 REVISION	BY
1	11/27/19		

PROJECT NO. 130439
SCALE As indicated
DATE OCTOBER 30, 2019
DRAWN BY CT
CHECKED BY ML
APPROVED BY DS

ISSUED FOR
BID SET
DRAWING NO.
5.06.121
OF SHTS

FILE NAME: I:\Projects\MEG\NMEG0050.Dwg; 15-06-131-2.dwg PLOT TIME: Wed, 27 Nov 2019 - 2:54pm LAST SAVE: Wed, 27 Nov 2019 - 2:52pm BY: shaez

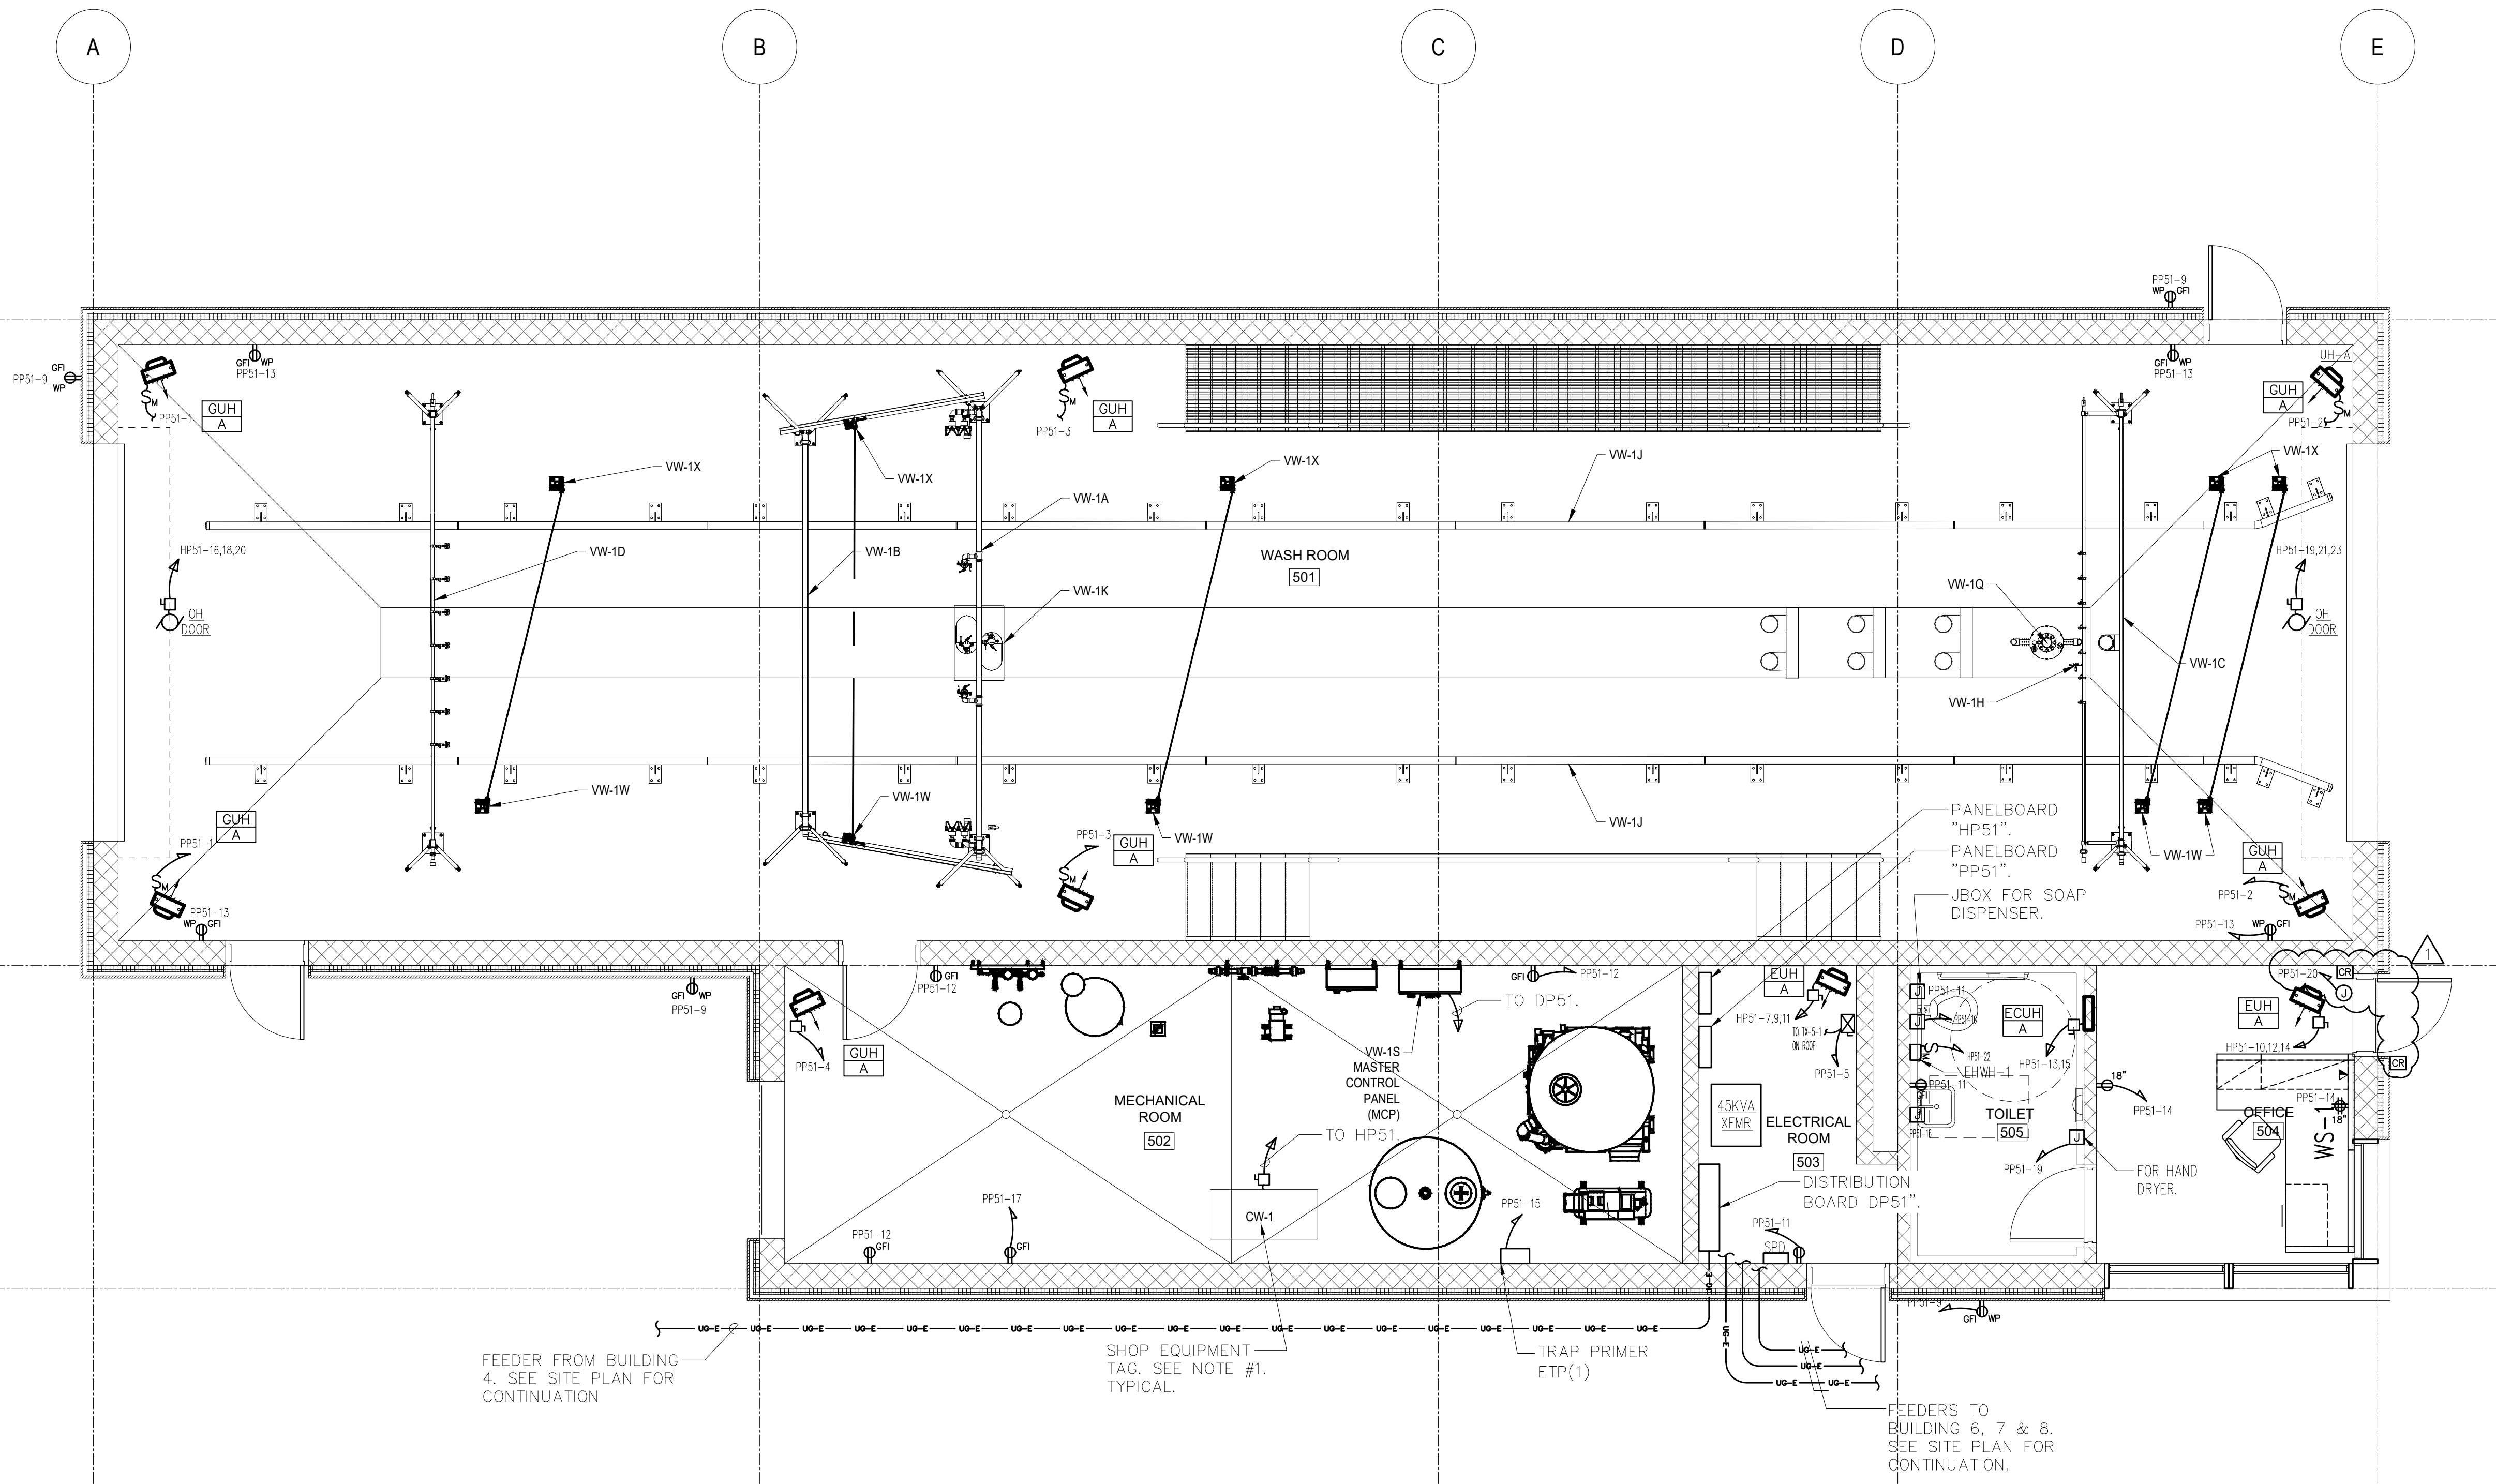

ADD ALTERNATE #1
ALL WORK ASSOCIATED WITH BUILDING 5 SHALL BE PRICED AS PART OF ADD ALTERNATE #1.




ELECTRICAL BUILDING 05 POWER PLAN

SCALE: 1/4" = 1'-0"

NOTES:

- 1.) FOR TAGGED SHOP EQUIPMENT, SEE DRAWING 5.06.601 FOR ELECTRICAL EQUIPMENT SCHEDULE FOR POWER AND CIRCUITRY REQUIREMENTS.
- 2.) THE ELECTRICAL CONTRACTOR SHALL PROVIDE UNDERSLAB CONDUITS FROM THE MASTER CONTROL PANEL (ITEM: VW-1S) TO SYSTEM COMPONENTS. COORDINATE EXACT LOCATIONS WITH TRUCK WASH EQUIPMENT INSTALLER. SEE DRAWING 5.06.133.
- 3.) RECEPTACLES SHALL BE MOUNTED AT 48" AFF U.O.N.
- 4.) ALL CONDUITS IN WASH ROOM AND MECHANICAL ROOM SHALL BE SCHEDULE 80 PVC.

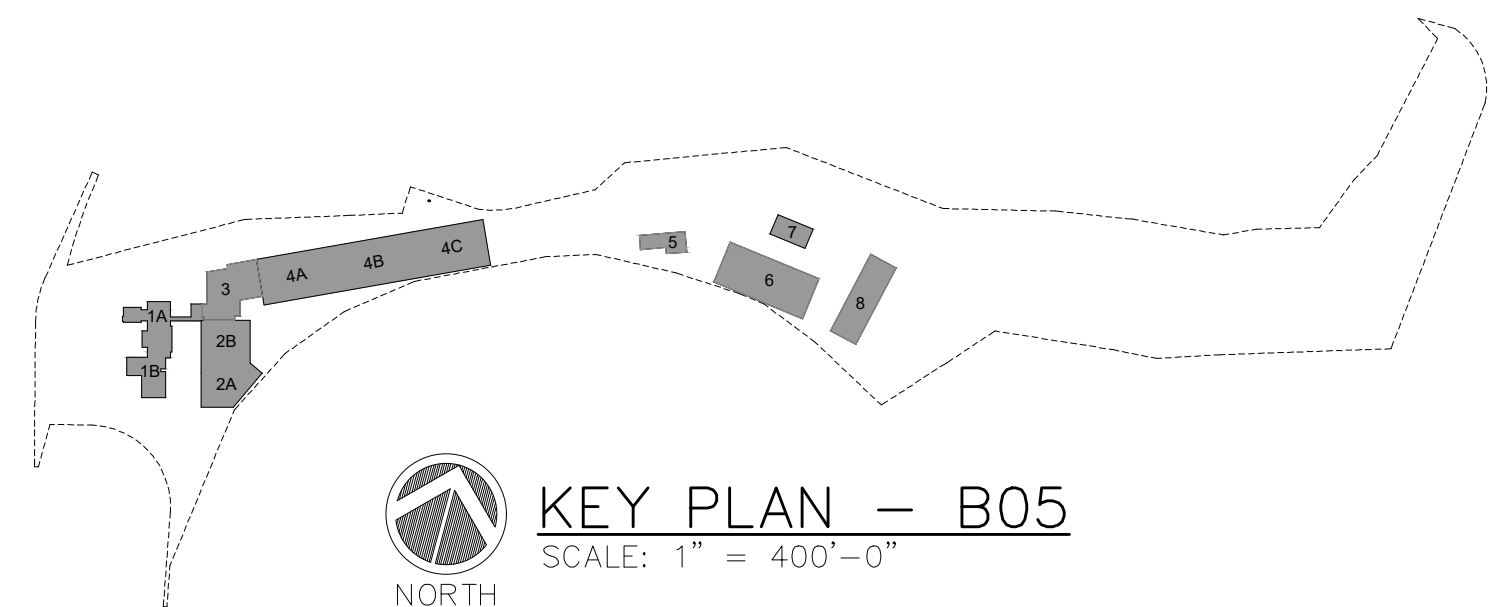

KEY PLAN - B05
SCALE: 1" = 400'-0"

WARNING - IT IS A VIOLATION OF NEW YORK STATE EDUCATIONAL LAW, SECTION 7209.2, FOR ANY PERSON, UNLESS HE IS ACTING UNDER THE DIRECTION OF A LICENSED PROFESSIONAL ENGINEER OR LAND SURVEYOR, TO ALTER THIS DOCUMENT IN ANY WAY. IF ALTERED, THE ALTERING PERSON SHALL COMPLY WITH THE REQUIREMENTS OF NEW YORK EDUCATIONAL LAW, SECTION 7209.2

COPYRIGHT © 2019, McLAREN ENGINEERING GROUP

STV 100 Years
STV Architects, P.C.
225 Park Avenue South
New York, NY 10003
(212) 777-4400 FAX: (212) 473-2780
www.stvinc.com


OLA Consulting Engineers
50 Broadway,
Hawthorne, NY 10532
914.747.2800
8 West 38th Street,
Suite 601
New York, NY 10018
646.648.4110
ola.com NMEG0050.00

Gannett Fleming
FACILITIES CONSULTANT

IQ
Imbiano-Quigley
Landscape Architects
31 Montemorel Ave., 7th Floor
White Plains, New York 10601
admin@iqlandscape.com
(914) 232-6090

PROJECT
**COUNTY OF ROCKLAND
CAPITAL PROJECT NO. 1307
HIGHWAY DEPARTMENT /
EMERGENCY OPERATIONS FACILITY
COUNTY OF ROCKLAND, NEW YORK**

McLaren
ENGINEERING GROUP
applied ingenuity
M. G. McLaren Engineering
and Land Surveying P.C.
530 Chestnut Ridge Road, Woodcliff Lake, NJ 07677
T: 201.775.6000 F: 201.746.8522 www.mgmclaren.com

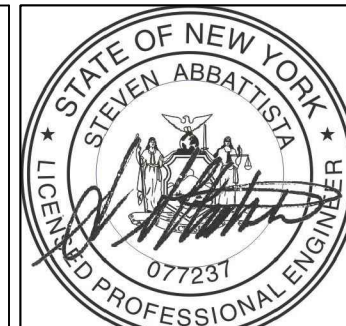

**ELECTRICAL BUILDING 05
POWER PLAN**

No.	DATE	REVISION	BY
1	11/27/19	ADDENDUM 07	VB

PROJECT NO. 130439
SCALE As indicated
DATE OCTOBER 30, 2019
DRAWN BY CT
CHECKED BY ML
APPROVED BY DS

ISSUED FOR **BID SET**
DRAWING NO. **5.06.131**
OF SHTS

FILE NAME: I:\Projects\MEG\NMEG0050.00.Dwg\5-06-601.dwg PLOT TIME: Wed, 27 Nov 2019 -- 3:30pm LAST SAVE: Wed, 27 Nov 2019 -- 3:27pm BY: wbez

WARNING - IT IS A VIOLATION OF NEW YORK STATE EDUCATIONAL LAW, SECTION 7209.2, FOR ANY PERSON, UNLESS HE IS ACTING UNDER THE DIRECTION OF A LICENSED PROFESSIONAL ENGINEER OR LAND SURVEYOR, TO ALTER THIS DOCUMENT IN ANY WAY. IF ALTERED, THE ALTERING PERSON SHALL COMPLY WITH THE REQUIREMENTS OF NEW YORK EDUCATIONAL LAW, SECTION 7209.2

COPYRIGHT © 2019, McLAREN ENGINEERING GROUP

CONSULTANTS
ARCHITECT



STV Architects, P.C.
225 Park Avenue South
New York, NY 10003
(212) 777-4400 FAX: (212) 473-2780
www.stvinc.com

MEP ENGINEER



OLA Consulting Engineers
50 Broadway,
Hawthorne, NY 10532
914.747.2800
8 West 38th Street,
Suite 601
New York, NY 10018
646.848.4110
olaee.com NMEG0050.00

FACILITIES
CONSULTANT



LANDSCAPE
ARCHITECT



Imbiano-Quigley
Landscape Architects
31 Monmouth Ave., 7th Floor
White Plains, New York 10601
admin@iqlandscape.com
(914) 232-6090

PROJECT

COUNTY OF ROCKLAND
CAPITAL PROJECT NO. 1307
HIGHWAY DEPARTMENT /
EMERGENCY OPERATIONS FACILITY
COUNTY OF ROCKLAND, NEW YORK



McLaren
ENGINEERING GROUP
applied ingenuity
M. G. McLaren Engineering
and Land Surveying P.C.
530 Chestnut Ridge Road, Woodcliff Lake, NJ 07677
T: 201.775.6000 F: 201.746.8522 www.mgmclaren.com



SHEET NAME

ELECTRICAL BUILDING 05
SCHEDULES

1	11/27/19	ADDENDUM 07	VB
No.	DATE	REVISION	BY

PROJECT NO. 130439

SCALE As indicated

DATE OCTOBER 30, 2019

DRAWN BY CT

CHECKED BY ML

APPROVED BY DS

ISSUED FOR BID SET

DRAWING NO. 5.06.601

OF SHTS

BUILDING 5 SHOP EQUIPMENT SCHEDULE															
ITEM NO.	QTY	ITEM DESCRIPTION	ELECTRICAL											REMARKS	
			FLAMPS	KW	HP	VOLTS	PHASE	DIRECT	PLUG	NEMA	ELECTRICAL AFF. (IN)	CIRCUIT BREAKER	PANEL		WIRE SIZE
CW-1	1	STEAM CLEANER/PRESSURE WASHER	11	-	-	460	3	X	-	-	18"	3P-30A	HP51-1,3,5	3-#12 & 1-#12 GND IN 3/4"C.	PROVIDE 30A, 600V DISC. SWITCH.
VW-1S	1	MASTER CONTROL PANEL	150	-	-	460	3	X	-	-	-	3P-150A	DP51	3-#1/0 & 1-#6 GND IN 1-1/2"C.	
NOTES:															
1.) COORDINATE ALL ELECTRICAL EQUIPMENT REQUIREMENTS, EXISTING EQUIPMENT, VOLTAGE, PHASE, NEMA RECEPTACLE CONFIGURATION, CONNECTIONS, HEIGHTS, ETC WITH EQUIPMENT PURCHASED.															

ADD ALTERNATE #1
ALL WORK ASSOCIATED WITH BUILDING 5 SHALL BE PRICED AS PART OF ADD ALTERNATE #1.

HP51 PANEL SCHEDULE														
MAIN RATING: <u>400A</u>			MAIN C.B.: <u>MLO</u>			KAIC RATING: <u>35KAIC</u>								
VOLTAGE: <u>480/277V</u>			PHASE: <u>3</u>		WIRE: <u>4</u>		MOUNTING: <u>SURFACE</u>							
CIRC. NO.	LOAD DESCRIPTION		BKR. AMPS	NO. OF POLES	NO. OF POLES	BKR. AMPS	LOAD DESCRIPTION		CIRC. NO.					
1	CW-1		30	3	1	20	LIGHTING		2					
3					*	TRANSFORMER - T51	4							
5							6							
7	EUH-A	15	3	3			15	EUH-A	8					
9					10									
11					12									
13	ECUH-A		15	2	3	20	OH DOOR - 501	14						
15								16						
17								18						
19	SPARE		20	1	3	20	OH DOOR - 501	20						
21								OH DOOR - 501A	20	3	1	20	EHWH-1 - TOILET 505	22
23											1	20	LIGHTING	24
25	-	-	-	-	1	20	OUTSIDE LIGHTING				26			
27	-	-	-	-	-	-	-	28						
29	-	-	-	-	-	-	-	30						
31	-	-	-	-	-	-	-	32						
33	-	-	-	-	-	-	-	34						
35	SPARE		20	1	1	20	SPARE	36						
37	SPARE		20	1	1	20	SPARE	38						
39	SPARE		20	1	1	20	SPARE	40						
41	SPARE		20	1	1	20	SPARE	42						
LK - PROVIDE LOCKING TABS ON C.B.; GF - GFI TYPE C.B.; AF - ARC FAULT TYPE C.B.; ST - SHUNT TRIP C.B.														
NOTES:														
1.) * - SEE ONE-LINE DIAGRAM FOR BREAKER SIZE.														

PP51 PANEL SCHEDULE									
MAIN RATING: <u>225A</u>			MAIN C.B.: <u>150A</u>			KAIC RATING: <u>22KAIC</u>			
VOLTAGE: <u>208/120V</u>			PHASE: <u>3</u>		WIRE: <u>4</u>		MOUNTING: <u>SURFACE</u>		
CIRC. NO.	LOAD DESCRIPTION	BKR. AMPS	NO. OF POLES	NO. OF POLES	BKR. AMPS	LOAD DESCRIPTION	CIRC. NO.		
1	GUH-A (2)	15	1	1	15	GUH-A (2)	2		
3	GUH-A (2)	15	1	1	15	GUH-A	4		
5	TX-5-1	15	1	1	20	SPARE	6		
7	SPARE	20	1	1	20	SPARE	8		
9	RECP WP/GFI OUTSIDE	20	1	1	15	SPARE	10		
11	RECP ELECTRICAL ROOM/TOILET	20	1	1	20	RECP MECHANICAL ROOM	12		
13	RECP WASH ROOM	20	1	1	20	RECP OFFICE	14		
15	ETP(1) - MECHANICAL ROOM 502	20	1	1	20	JBOX TOILET	16		
17	REC - MECH RM 502	20	1	1	20	SITE LIGHTING	18		
19	HAND DRYER - RM 505	20	1	1	20	DOOR RELEASE - OFFICE 504	20		
21	-	-	-	-	-	-	22		
23	-	-	-	-	-	-	24		
25	-	-	-	-	-	-	26		
27	-	-	-	-	-	-	28		
29	-	-	-	1	20	FACP-B5	30		
31	-	-	-	-	-	-	32		
33	-	-	-	-	-	-	34		
35	SPARE	20	1	1	20	SPARE	36		
37	SPARE	20	1	1	20	SPARE	38		
39	SPARE	20	1	1	20	SPARE	40		
41	SPARE	20	1	1	20	SPARE	42		
LK - PROVIDE LOCKING TABS ON C.B.; GF - GFI TYPE C.B.; AF - ARC FAULT TYPE C.B.; ST - SHUNT TRIP C.B.									
NOTES:									

