


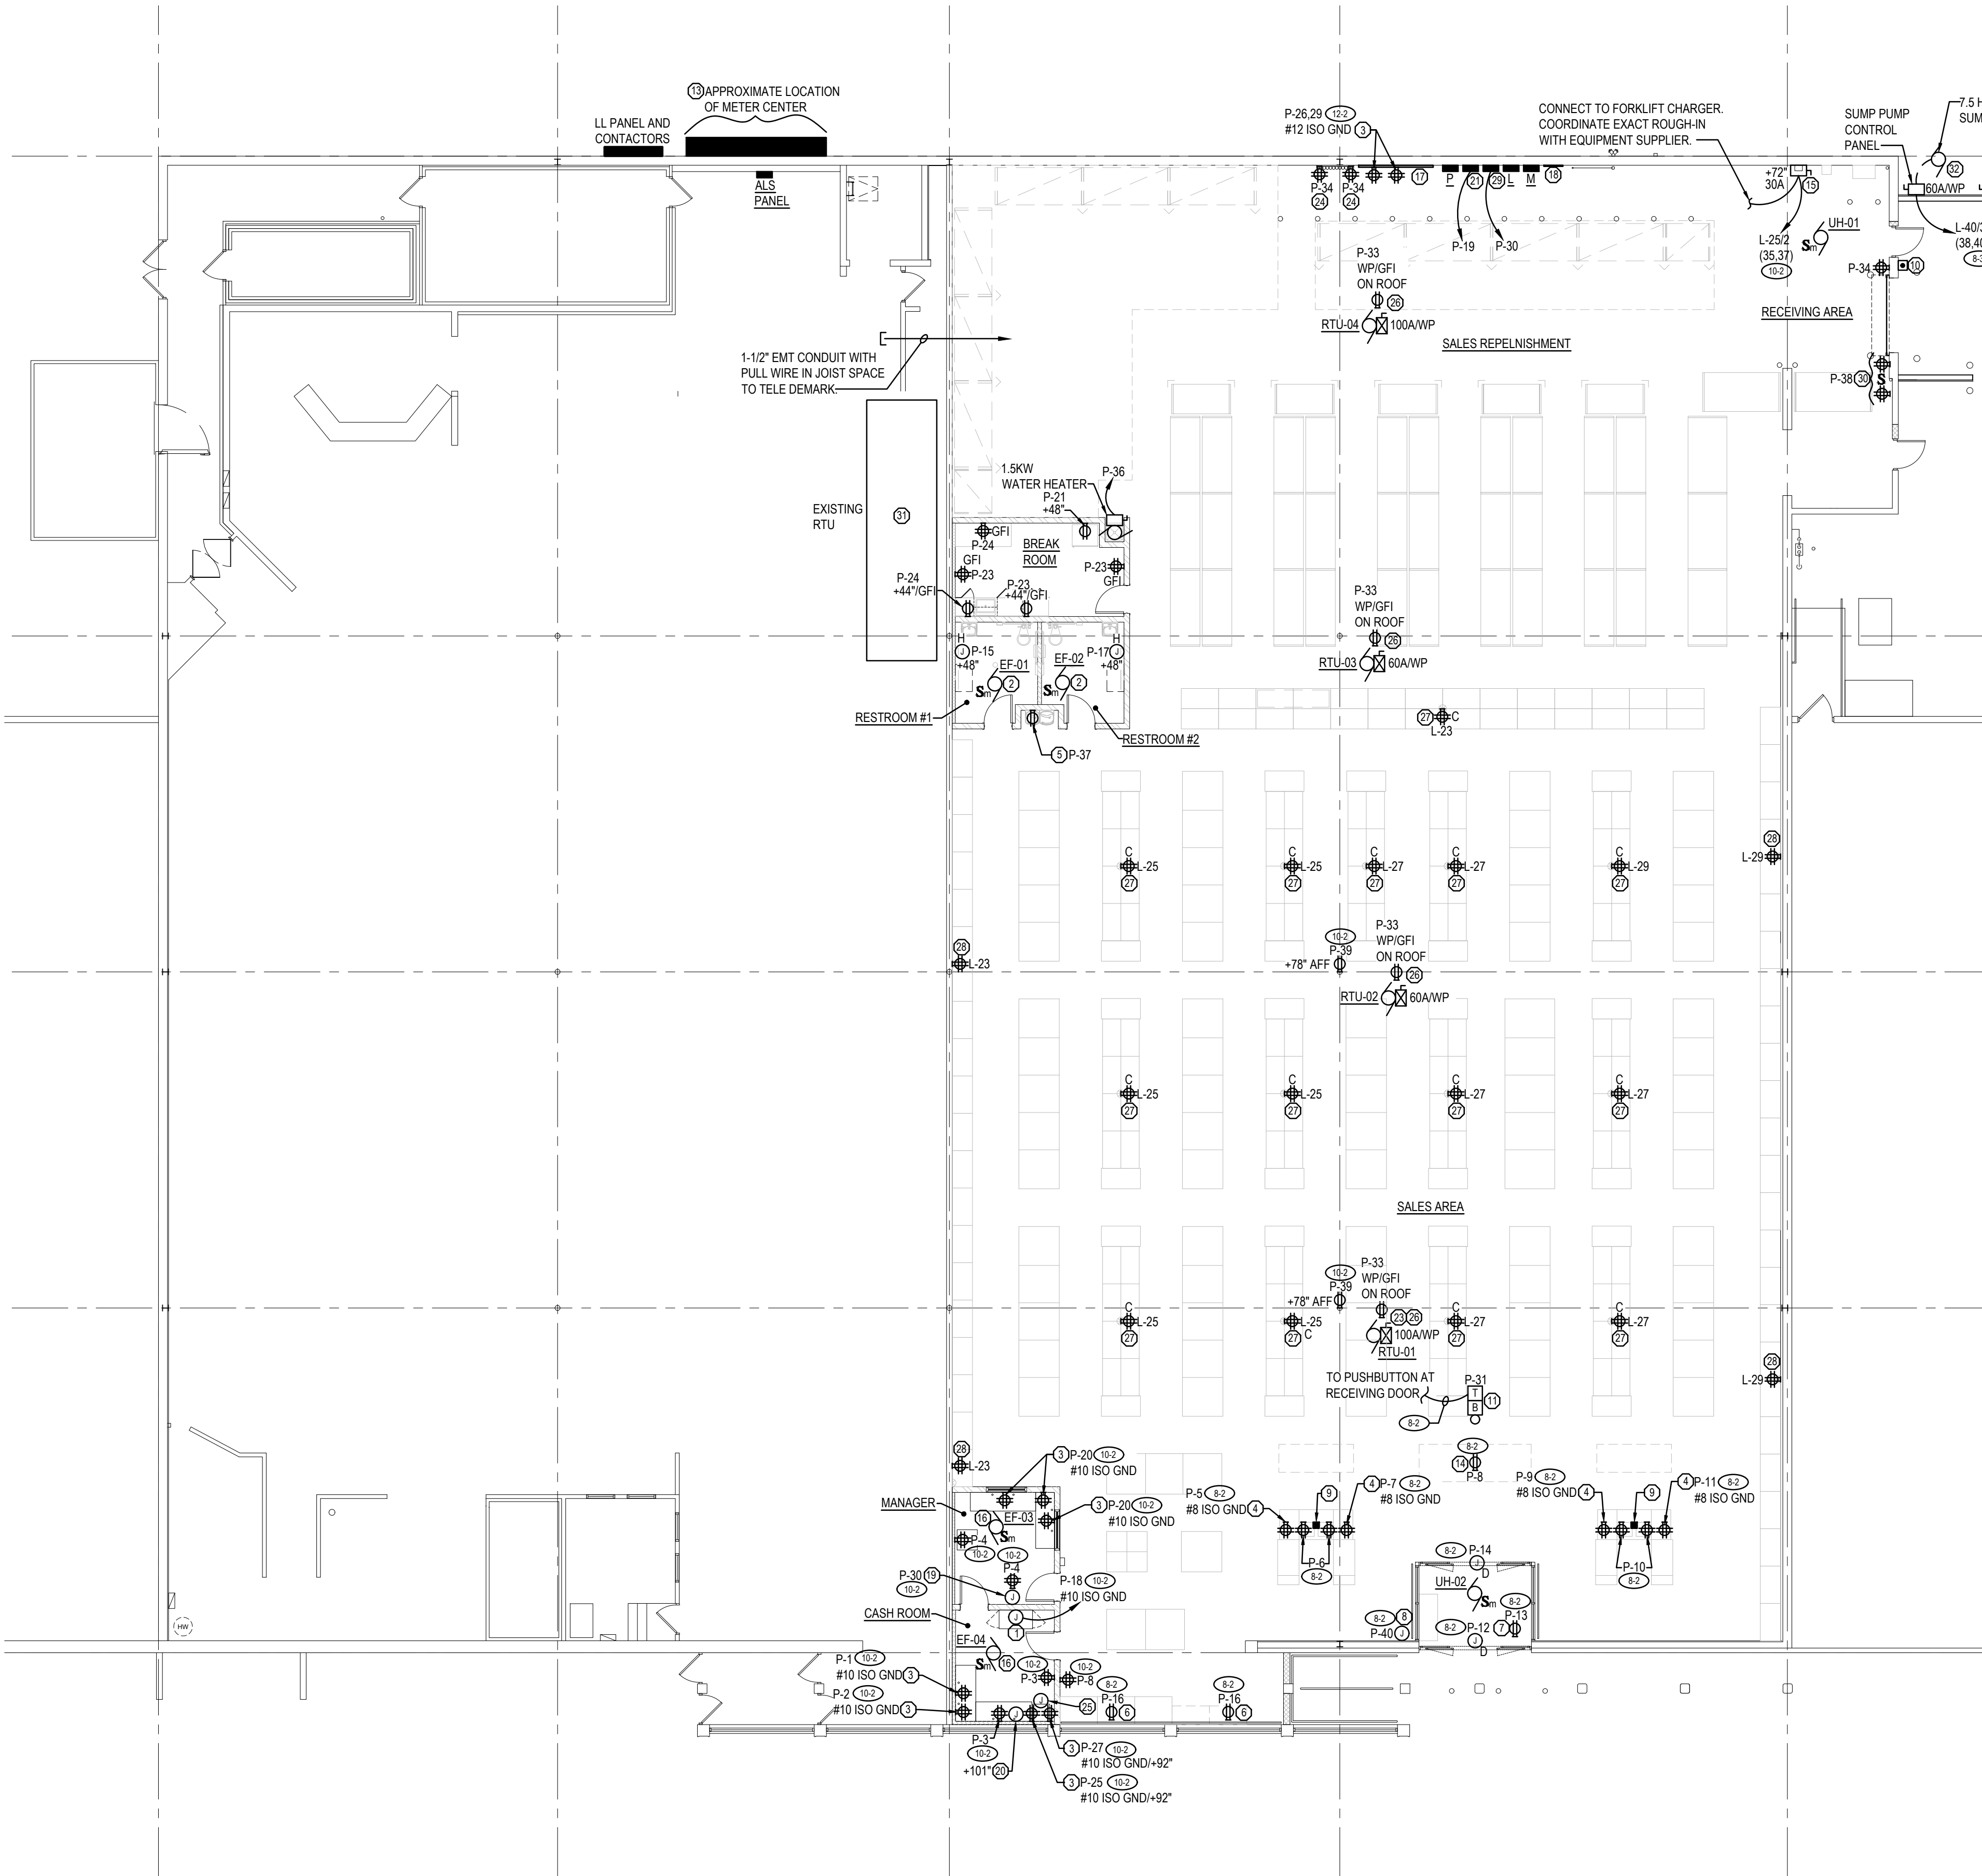


FOR GENERAL ELECTRICAL DEMOLITION NOTES
AND POWER PLAN NOTES, SEE SHEET E1.0A.

CONDUITS OR MOUNTING HARDWARE SHALL NOT
BE DIRECTLY MOUNTED TO THE ROOF DECK.

MECHANICAL EQUIPMENT SCHEDULE								
MARK	DESCRIPTION	LOAD	VOLTAGE & PHASE	PANEL	CIRCUIT	C.B.	WIRE	NOTES
RTU-1	ROOF TOP UNIT	71 MCA	208V-3PH	M	1,3,5	903	2-3	1,3
RTU-2	ROOF TOP UNIT	52 MCA	208V-3PH	M	2,4,6	603	6-3	1,3
RTU-3	ROOF TOP UNIT	52 MCA	208V-3PH	M	7,9,11	603	6-3	1,3
RTU-4	ROOF TOP UNIT	71 MCA	208V-3PH	M	8,10,12	903	2-3	1,3
UH-01	UNIT HEATER	1.8 KW	120V-1PH	P	22	301	10-2	1,3
UH-02	UNIT HEATER	4 KW	208V-1PH	L	39,41	252	10-2	1,2
EF-1	EXHAUST FAN #1	0.1 KW	120V-1PH	P	41	201	12-2	1,2,4
EF-2	EXHAUST FAN #2	0.1 KW	120V-1PH	P	41	201	12-2	1,2,4
EF-3	EXHAUST FAN #3	0.1 KW	120V-1PH	P	35	201	12-2	1,2,5
EF-4	EXHAUST FAN #4	0.1 KW	120V-1PH	P	35	201	12-2	1,2,5

- MECHANICAL EQUIPMENT SCHEDULE NOTES:
1. VERIFY LOAD, LOCATION AND CONNECTION REQUIREMENTS WITH MECHANICAL & PLUMBING DESIGN DRAWINGS, SHOP DRAWINGS, AND MECHANICAL & PLUMBING CONTRACTOR IN THE FIELD. ADJUST CONNECTION DEVICE, MOUNTING HEIGHT, WIRE, CONDUIT AND CIRCUIT BREAKER AS REQUIRED IN ORDER TO POWER THE EQUIPMENT. COORDINATE WITH THE EQUIPMENT INSTALLING CONTRACTOR PRIOR TO ROUGH-IN.
 2. PROVIDE A LOCAL NEMA 3R HEAVY DUTY NON FUSED DISCONNECT SWITCH SIZED PER EQUIPMENT NAMEPLATE DATA.
 3. PROVIDE A LOCAL NEMA 3R HEAVY DUTY FUSED DISCONNECT SWITCH SIZED AND FUSED PER EQUIPMENT NAMEPLATE DATA. WIRE AHEAD OF THE INTEGRAL UNIT BREAKER.
 4. CONTROL CIRCUIT WITH TIME CLOCK.
 5. WIRE TO 120 VOLT TSTAT AND LOUVER.

POWER PLAN
SCALE 3/32" = 1'-0"

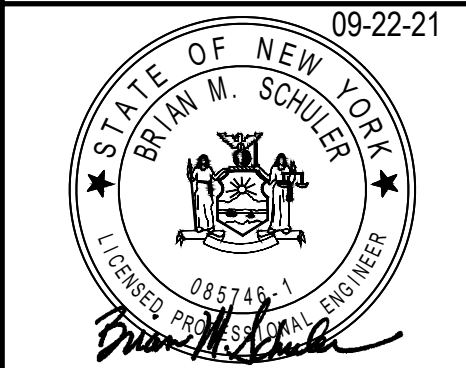

ADA ARCHITECTS SERVICES, P.C.
17710 Detroit Avenue
Phone (216) 521-5134
Fax (216) 521-4824
www.adaarchitects.com

HARBOR FREIGHT TOOLS

314 NY ROUTE 59
NYACK, NY 10960

THESE DOCUMENTS CONTAIN INFORMATION PROPRIETARY TO ADA ARCHITECTS SERVICES, P.C.
UNAUTHORIZED USE OF THESE DOCUMENTS IS EXPRESSLY PROHIBITED UNLESS AGREED UPON IN WRITING.

DO NOT SCALE THESE DRAWINGS

REVISIONS	
#	DATE
1	
2	
3	
4	
5	
6	
7	
8	
9	

POWER PLAN	
DATE	9/22/21
JOB NO.	20420
E1.0	
SHEET NO.	