




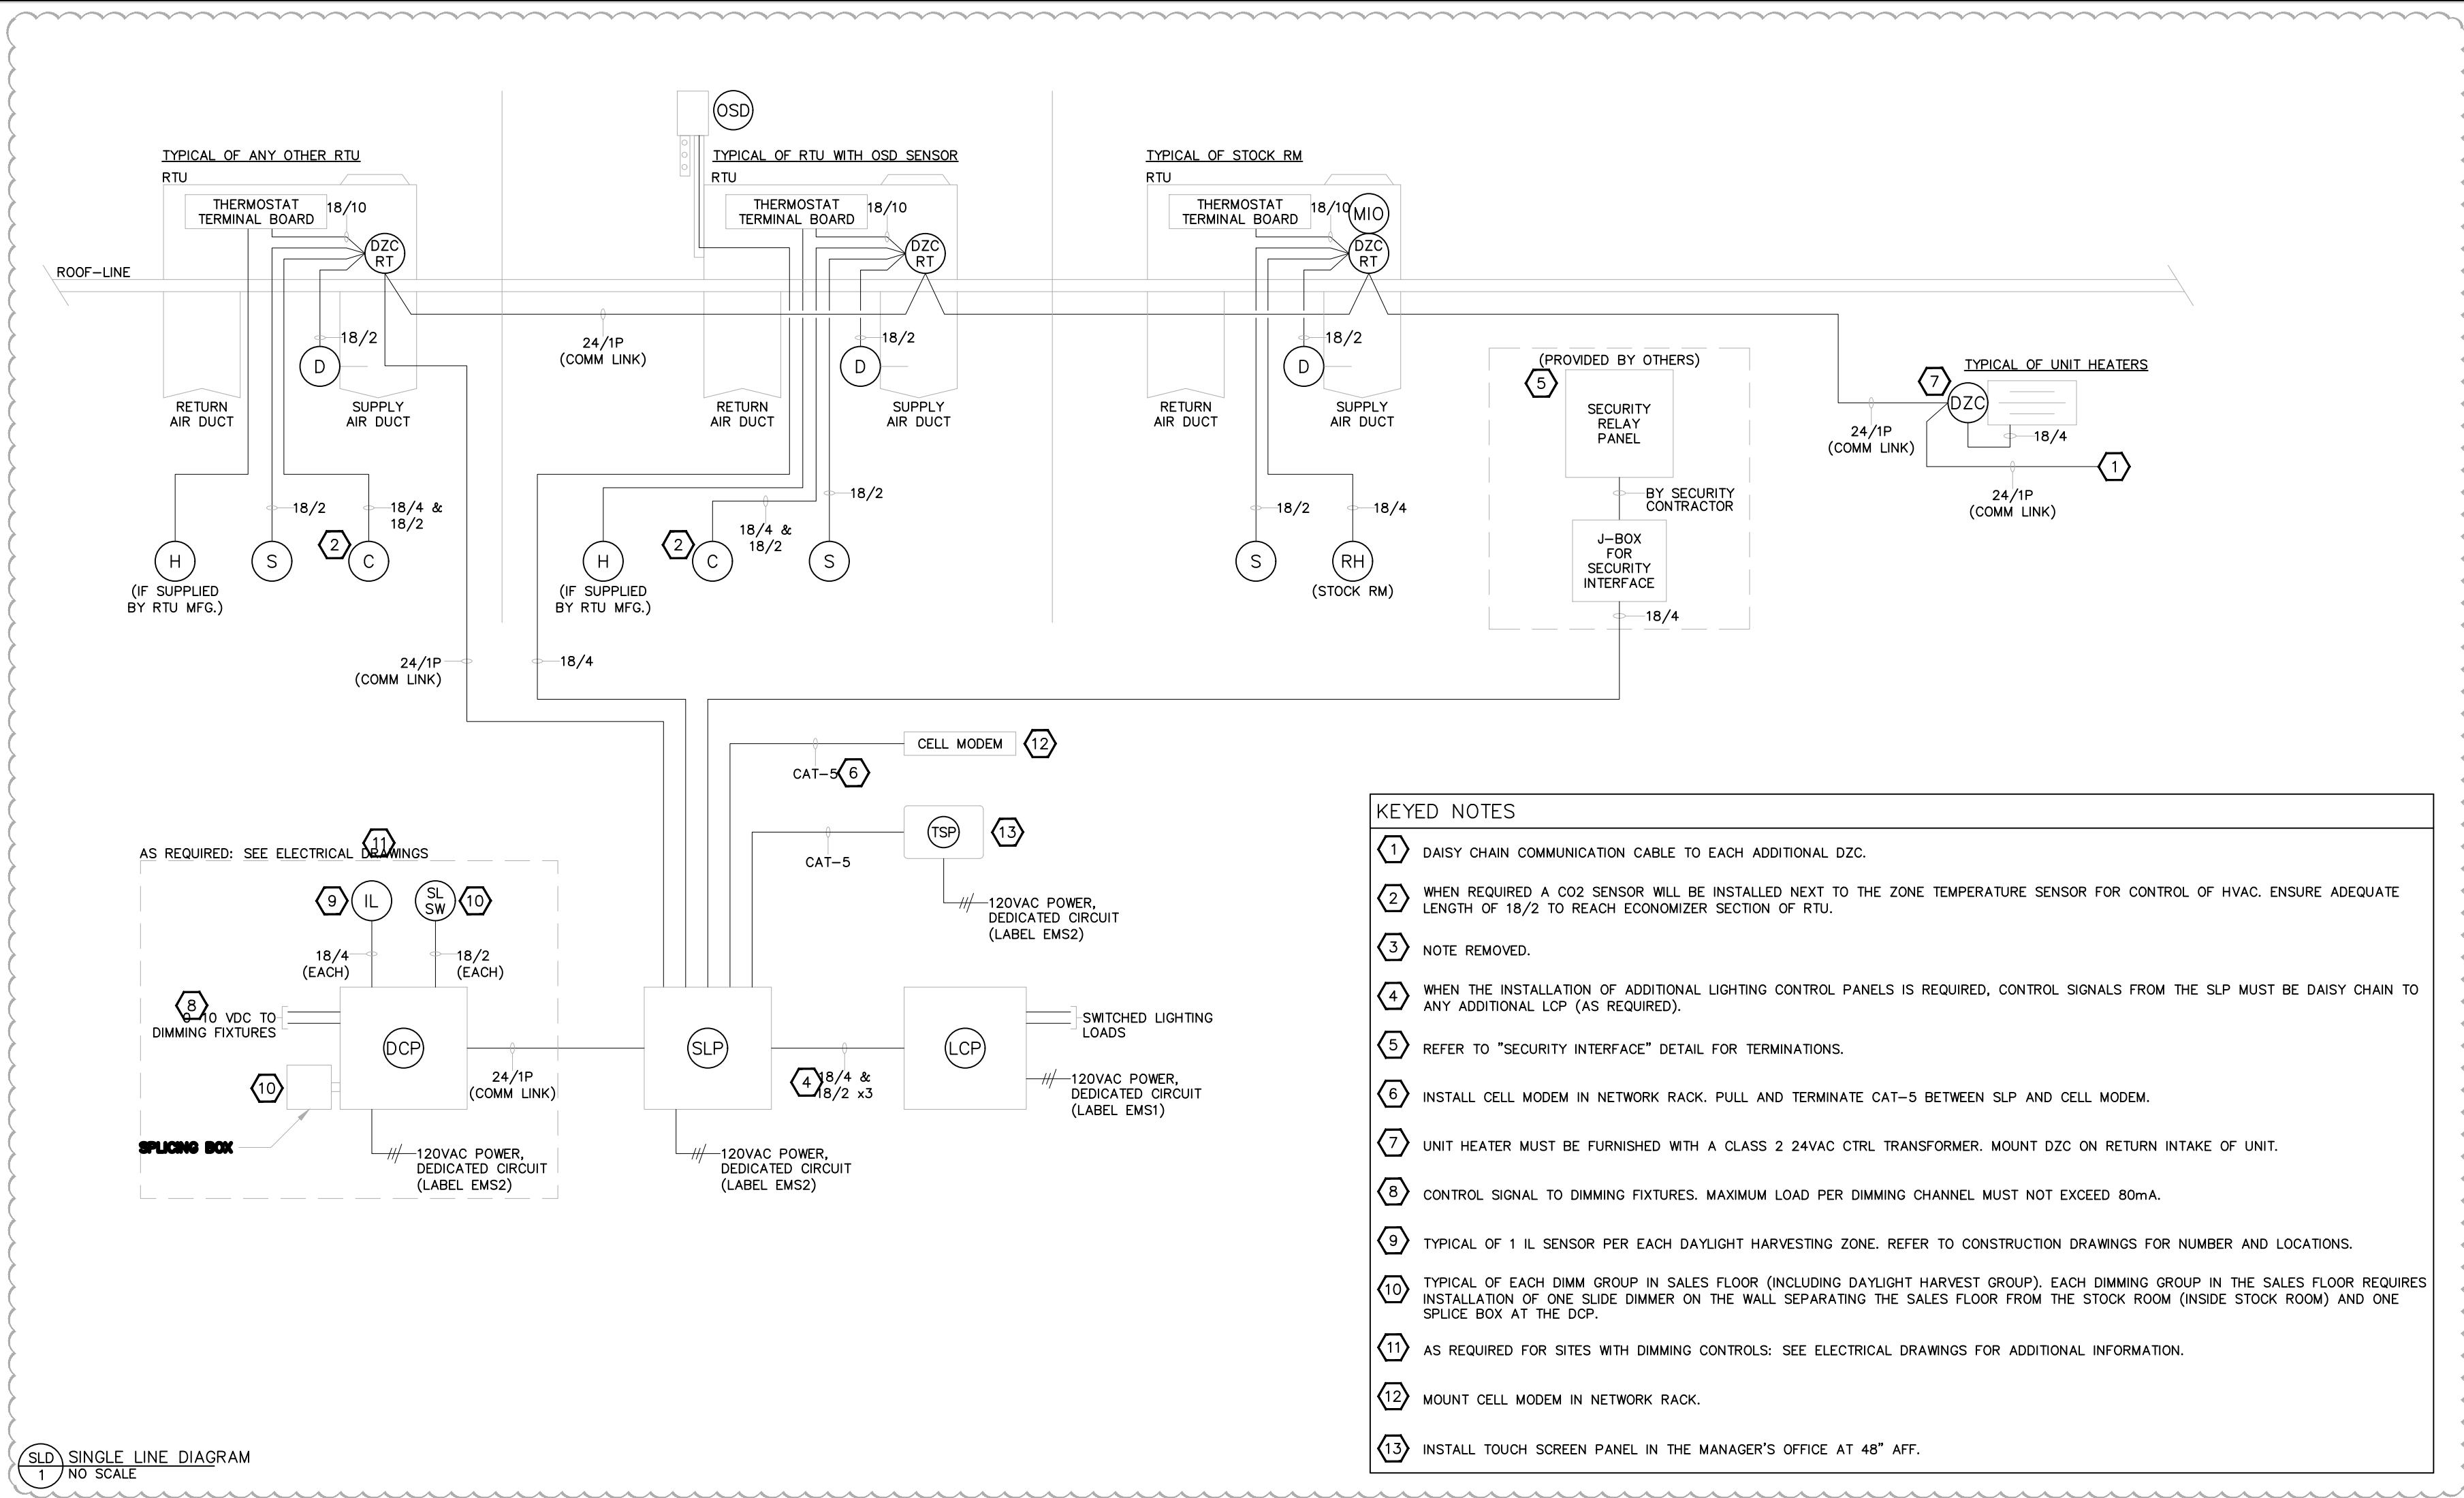


SLD SINGLE LINE DIAGRAM
1 NO SCALE

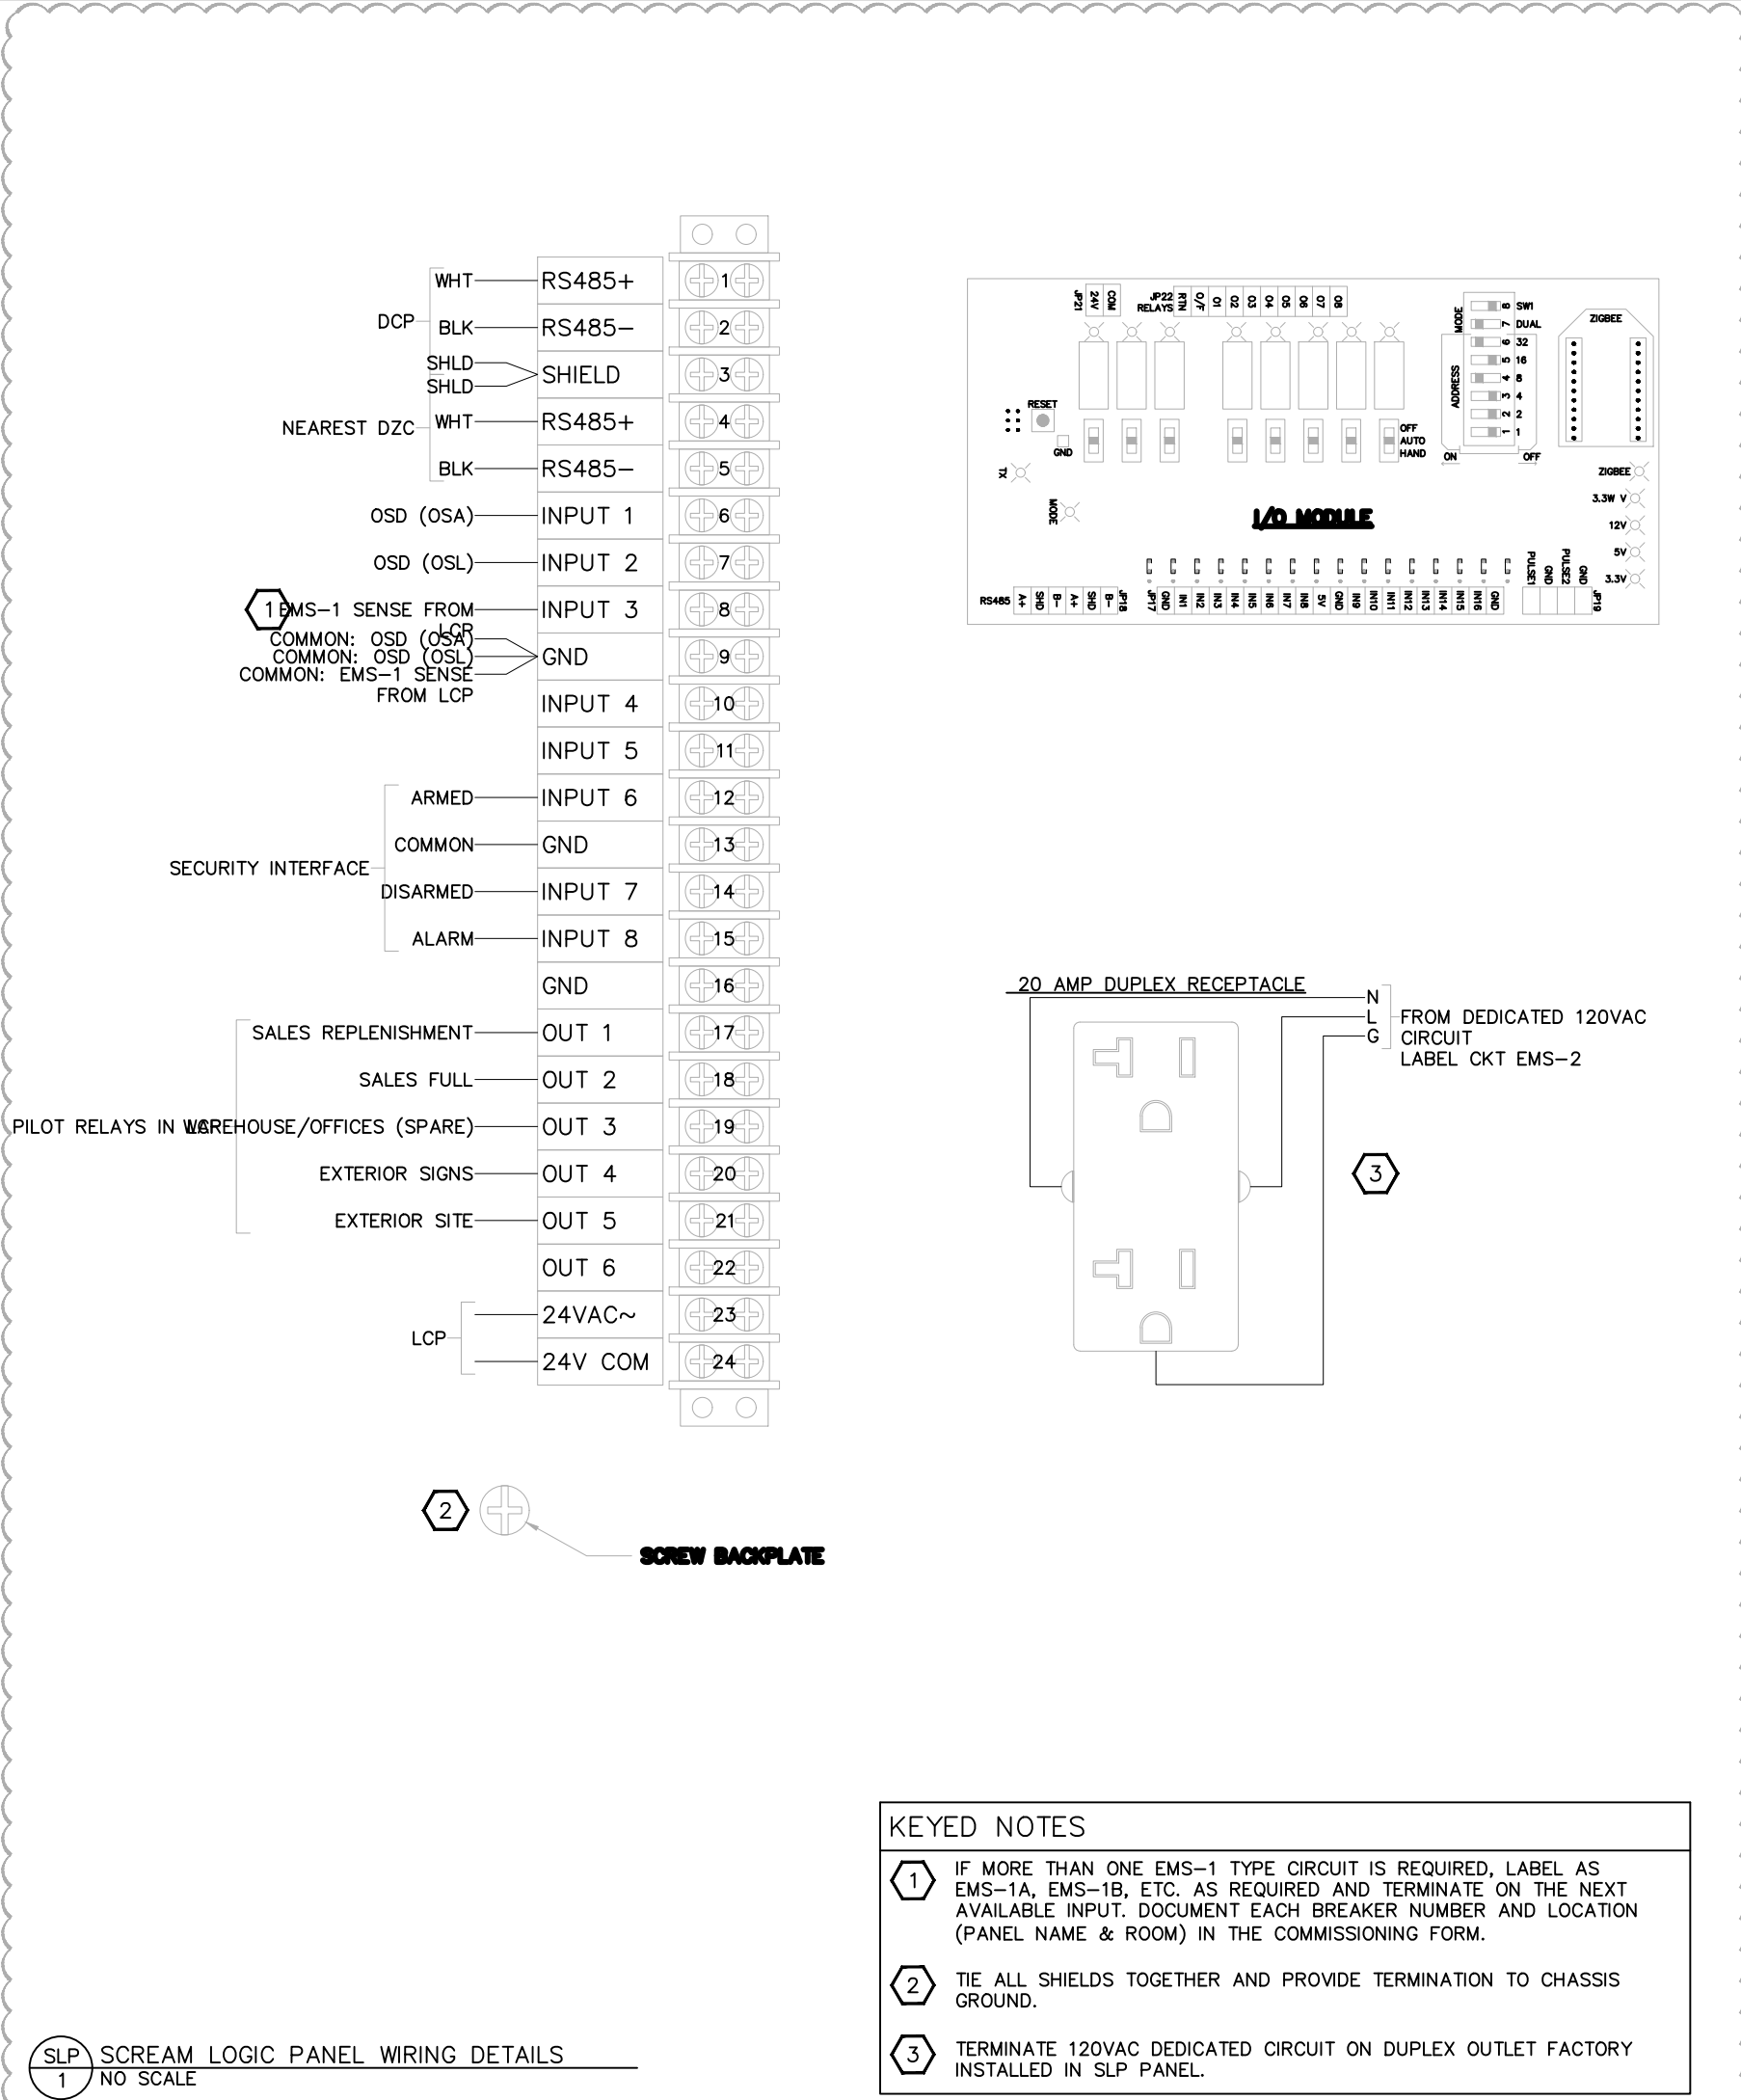


SLP SCREAM LOGIC PANEL WIRING DETAILS
1 NO SCALE

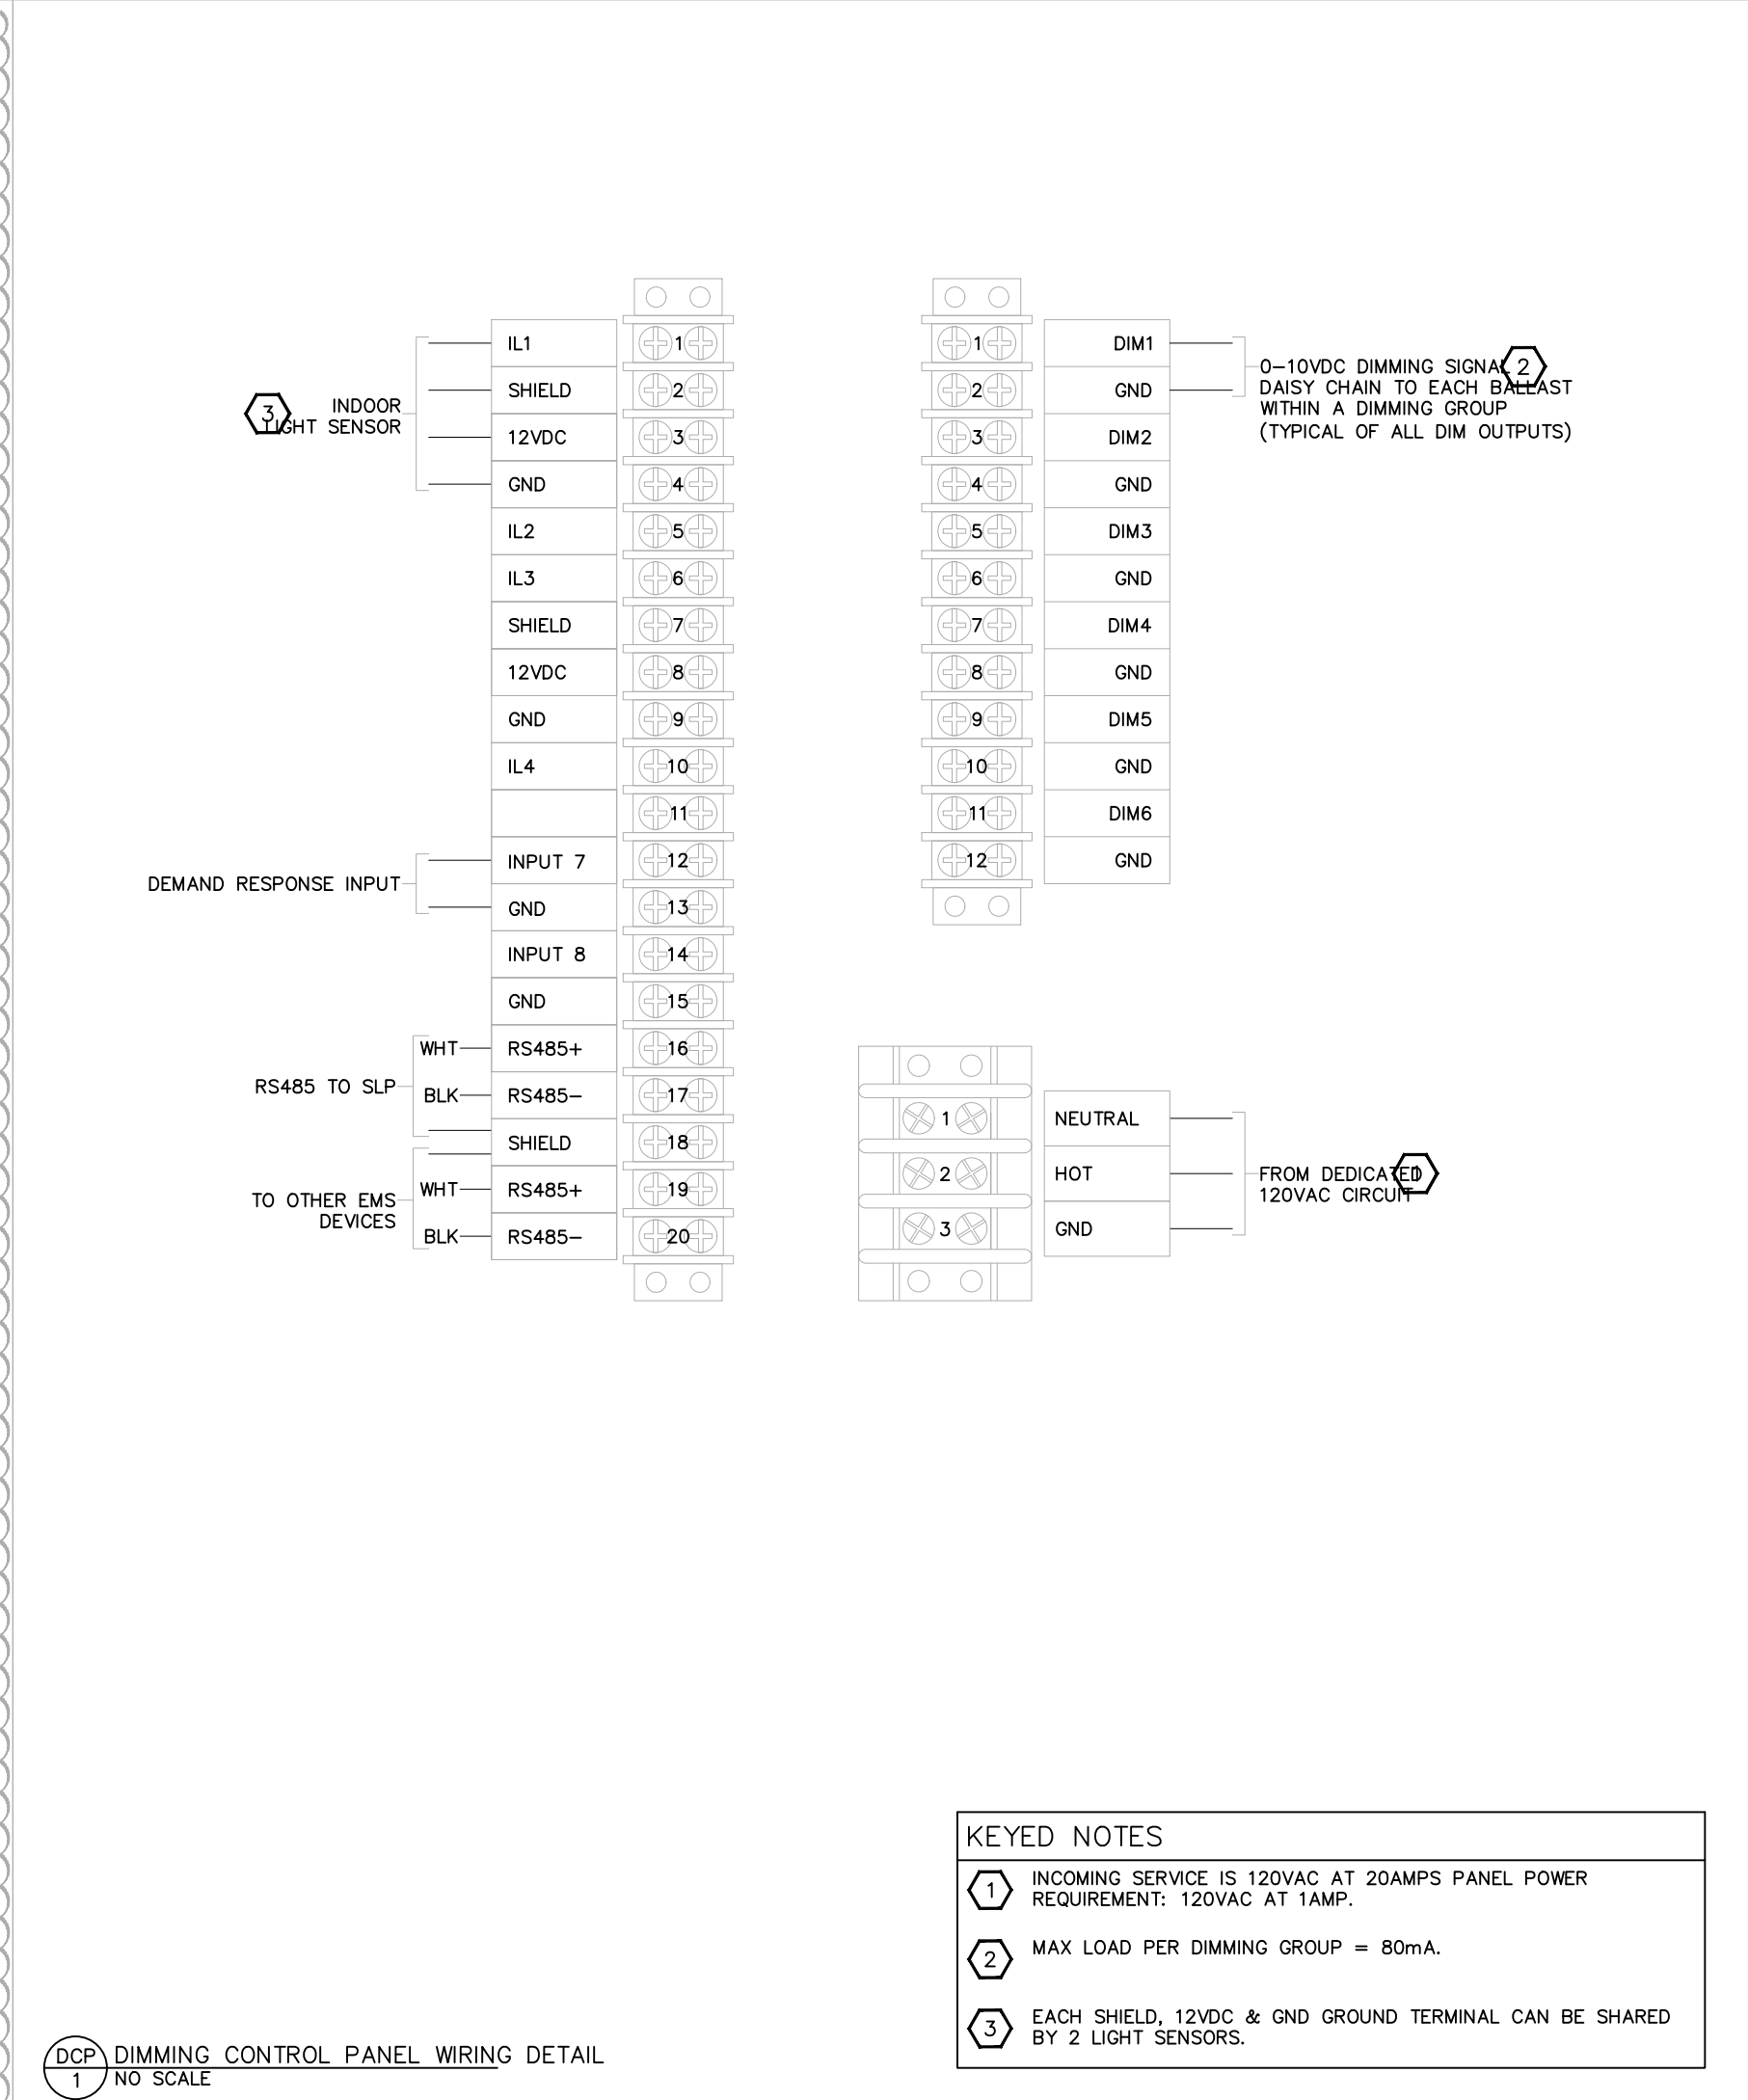


DCP DIMMING CONTROL PANEL WIRING DETAIL
1 NO SCALE

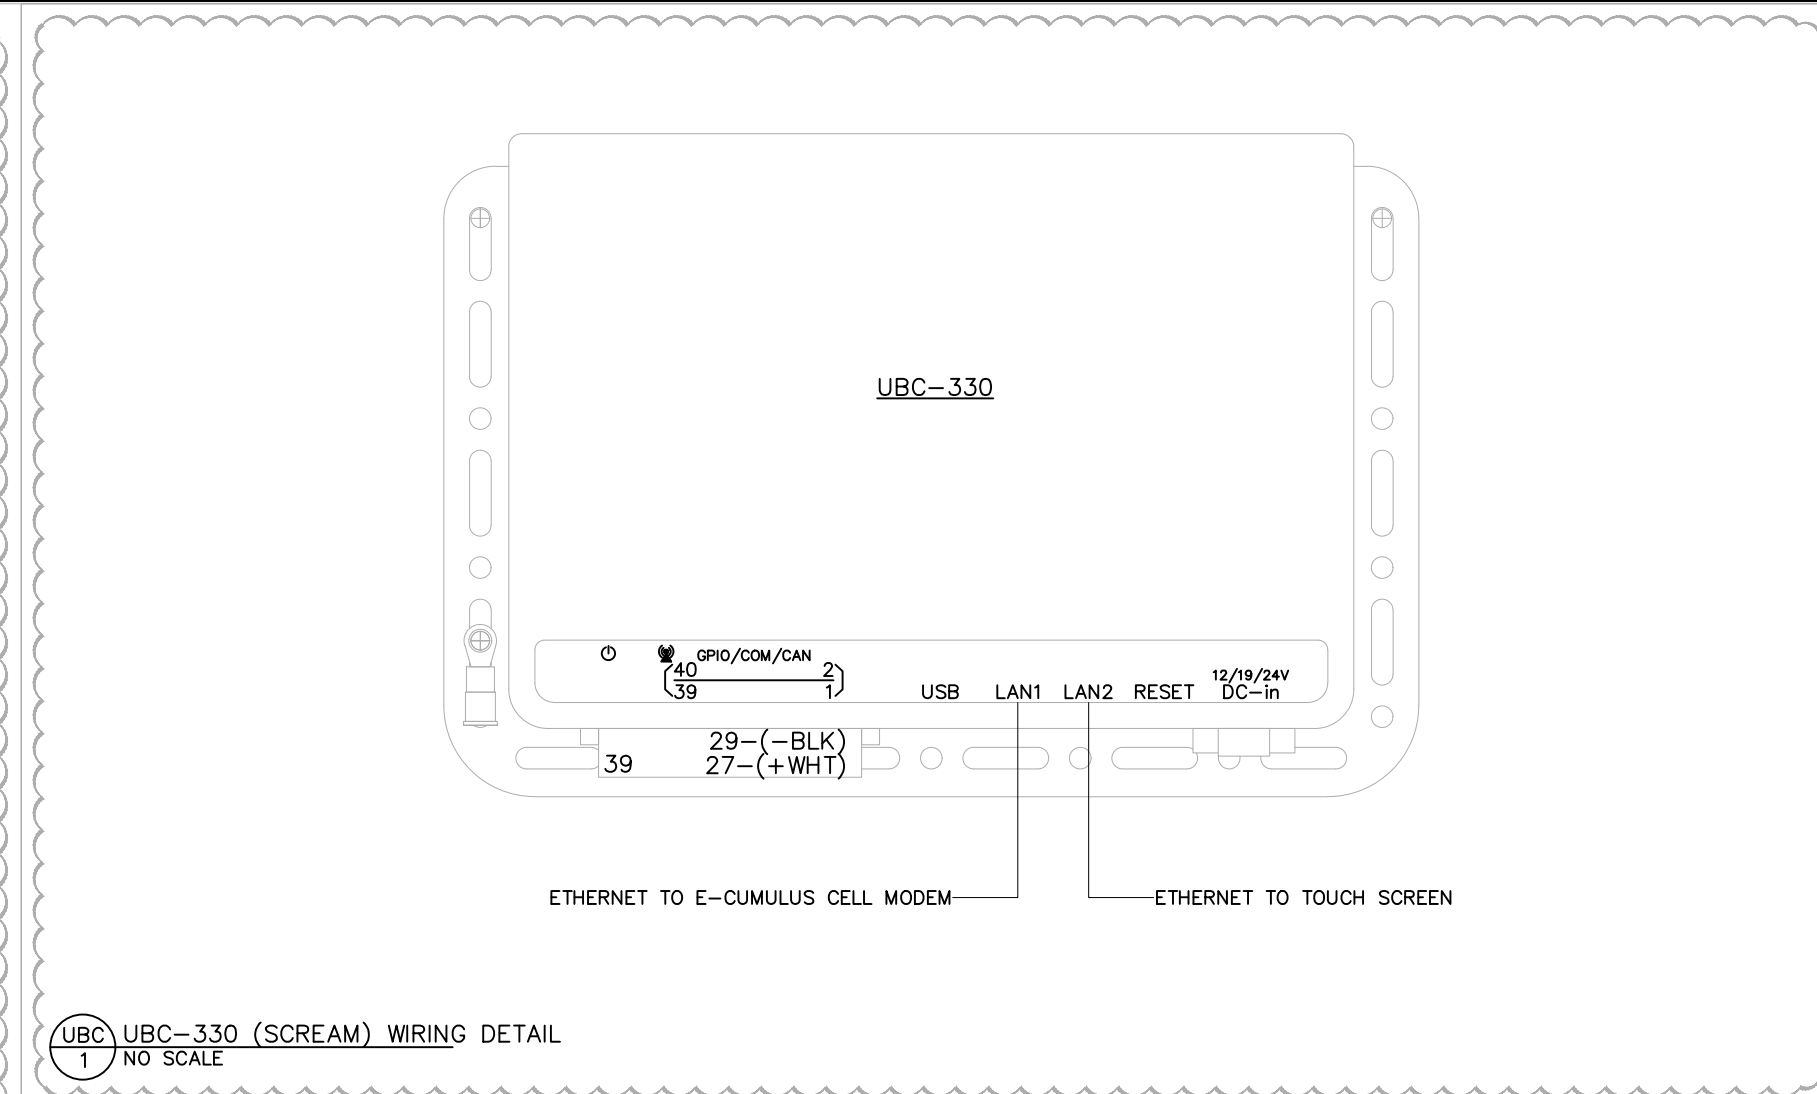

UBC-330 (SCREAM) WIRING DETAIL
1 NO SCALE

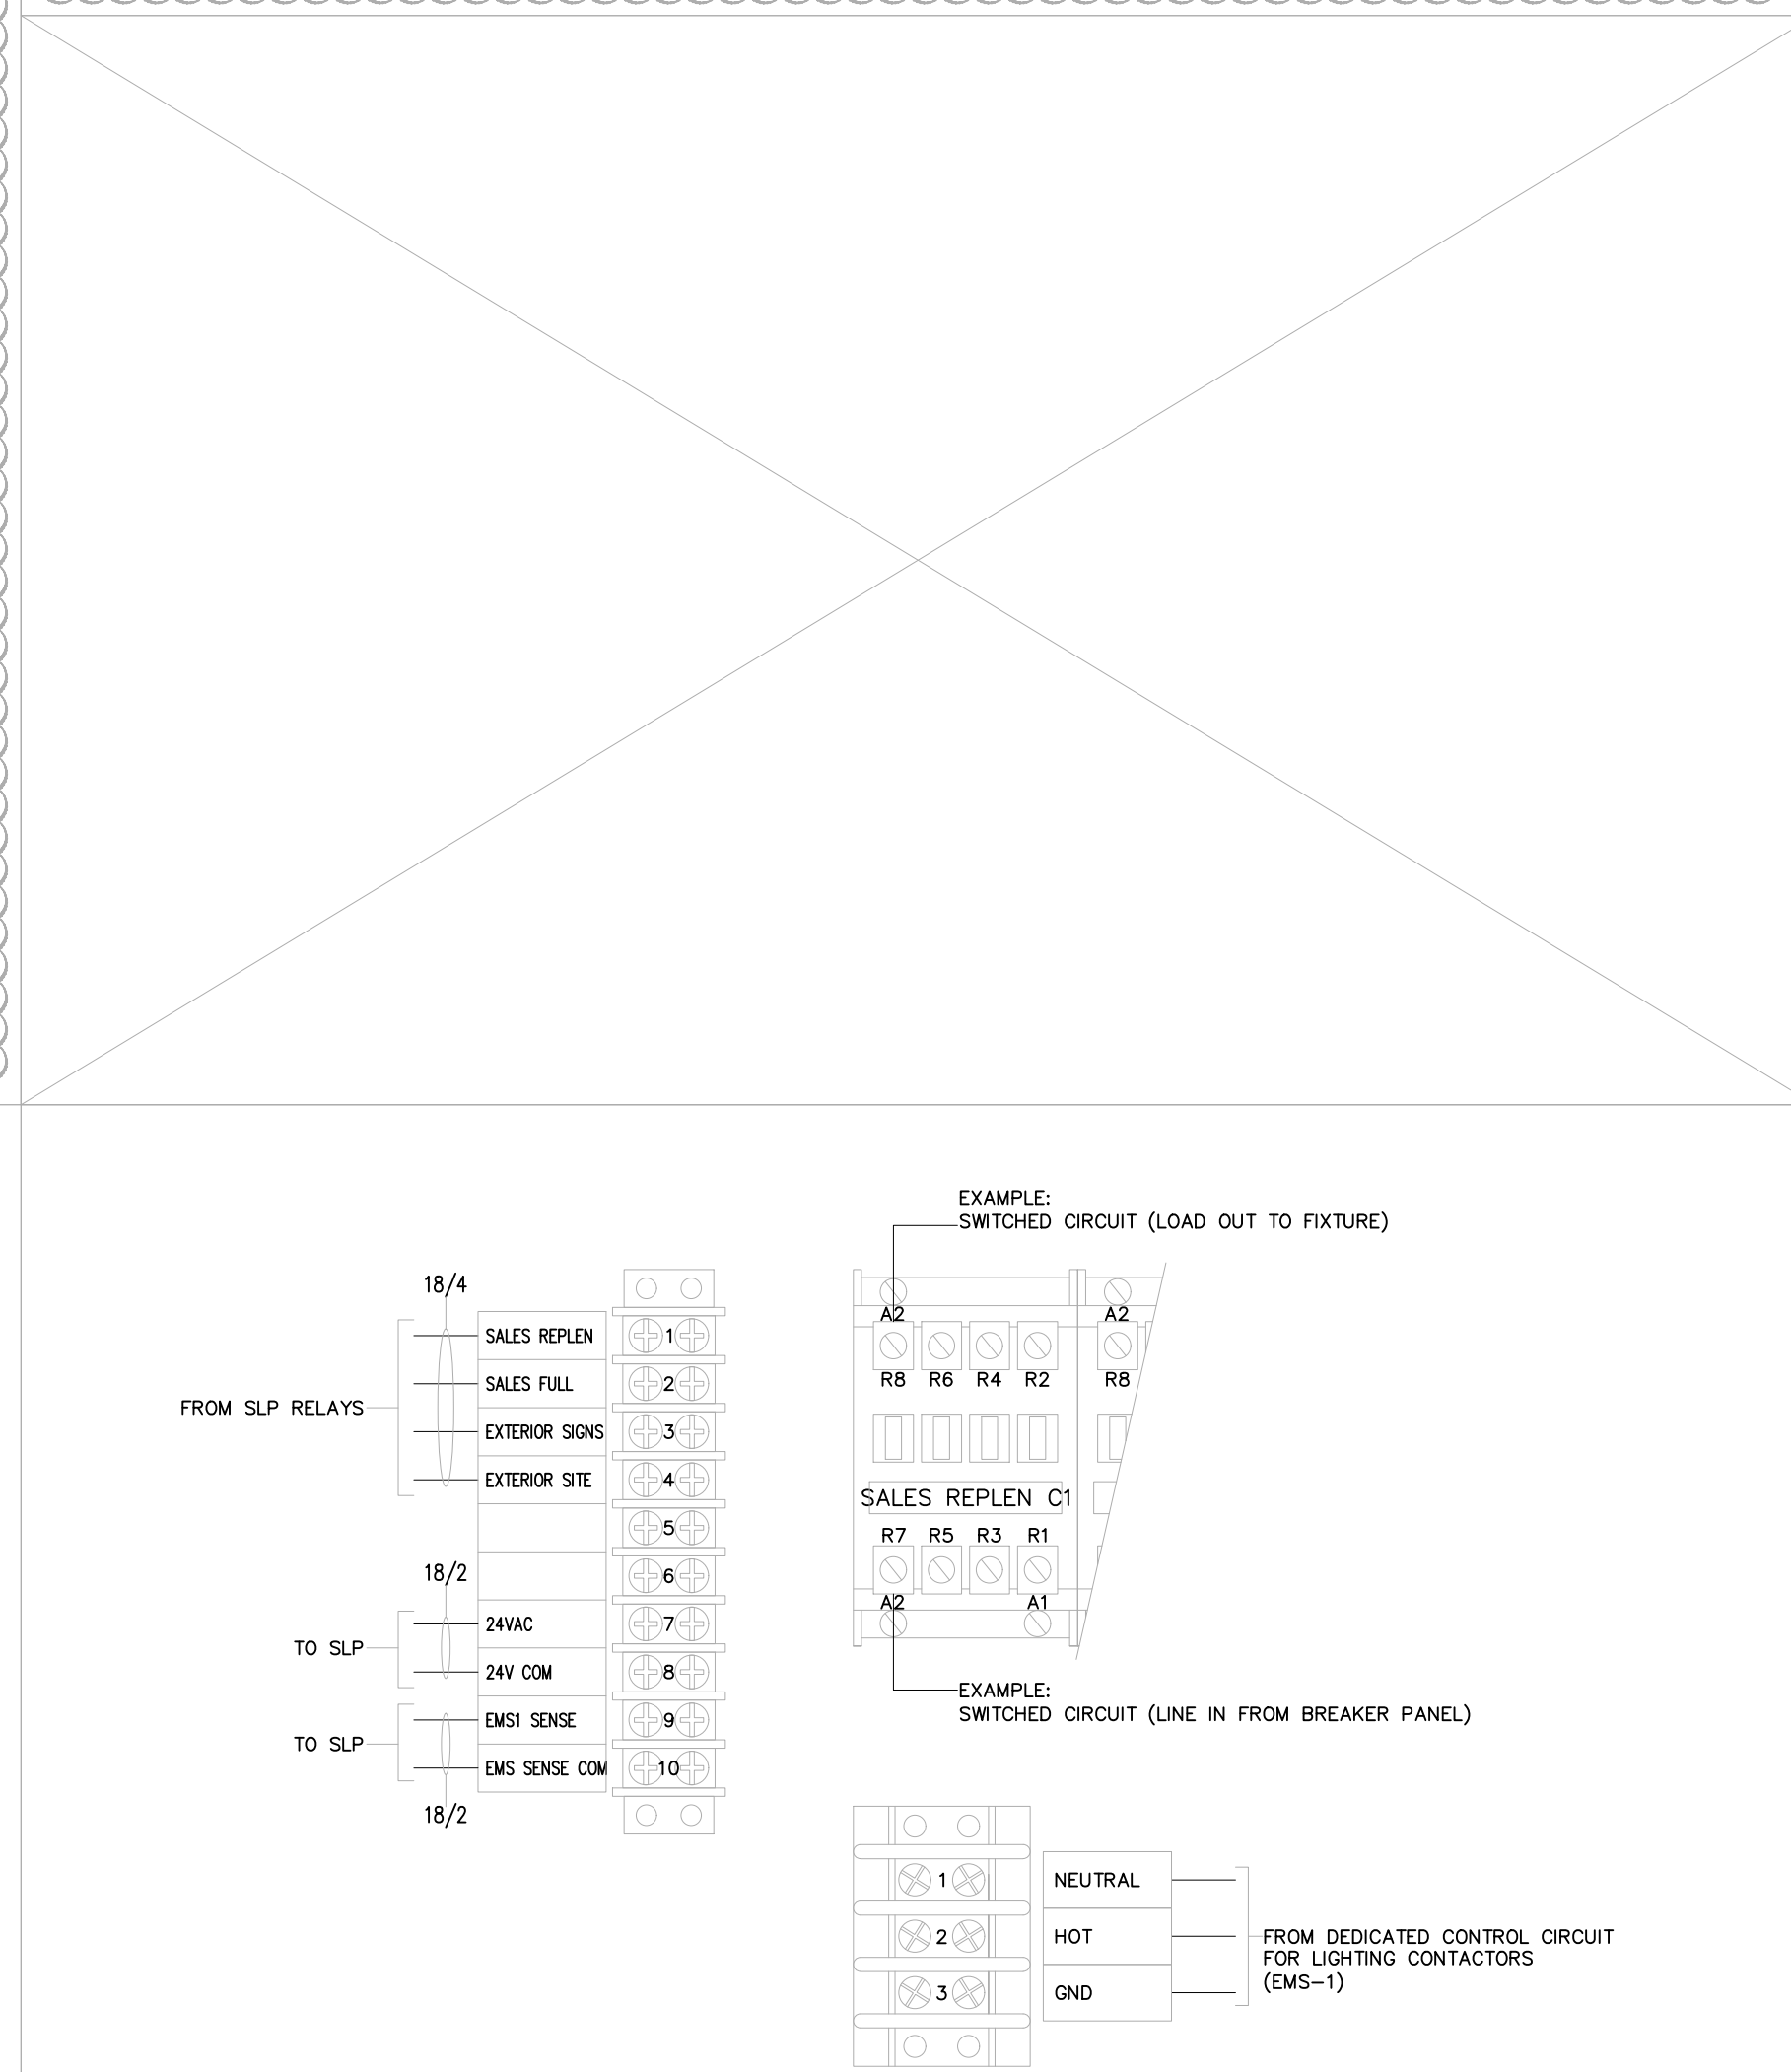

LCP LIGHTING CONTROL PANEL WIRING DETAIL
1 NO SCALE

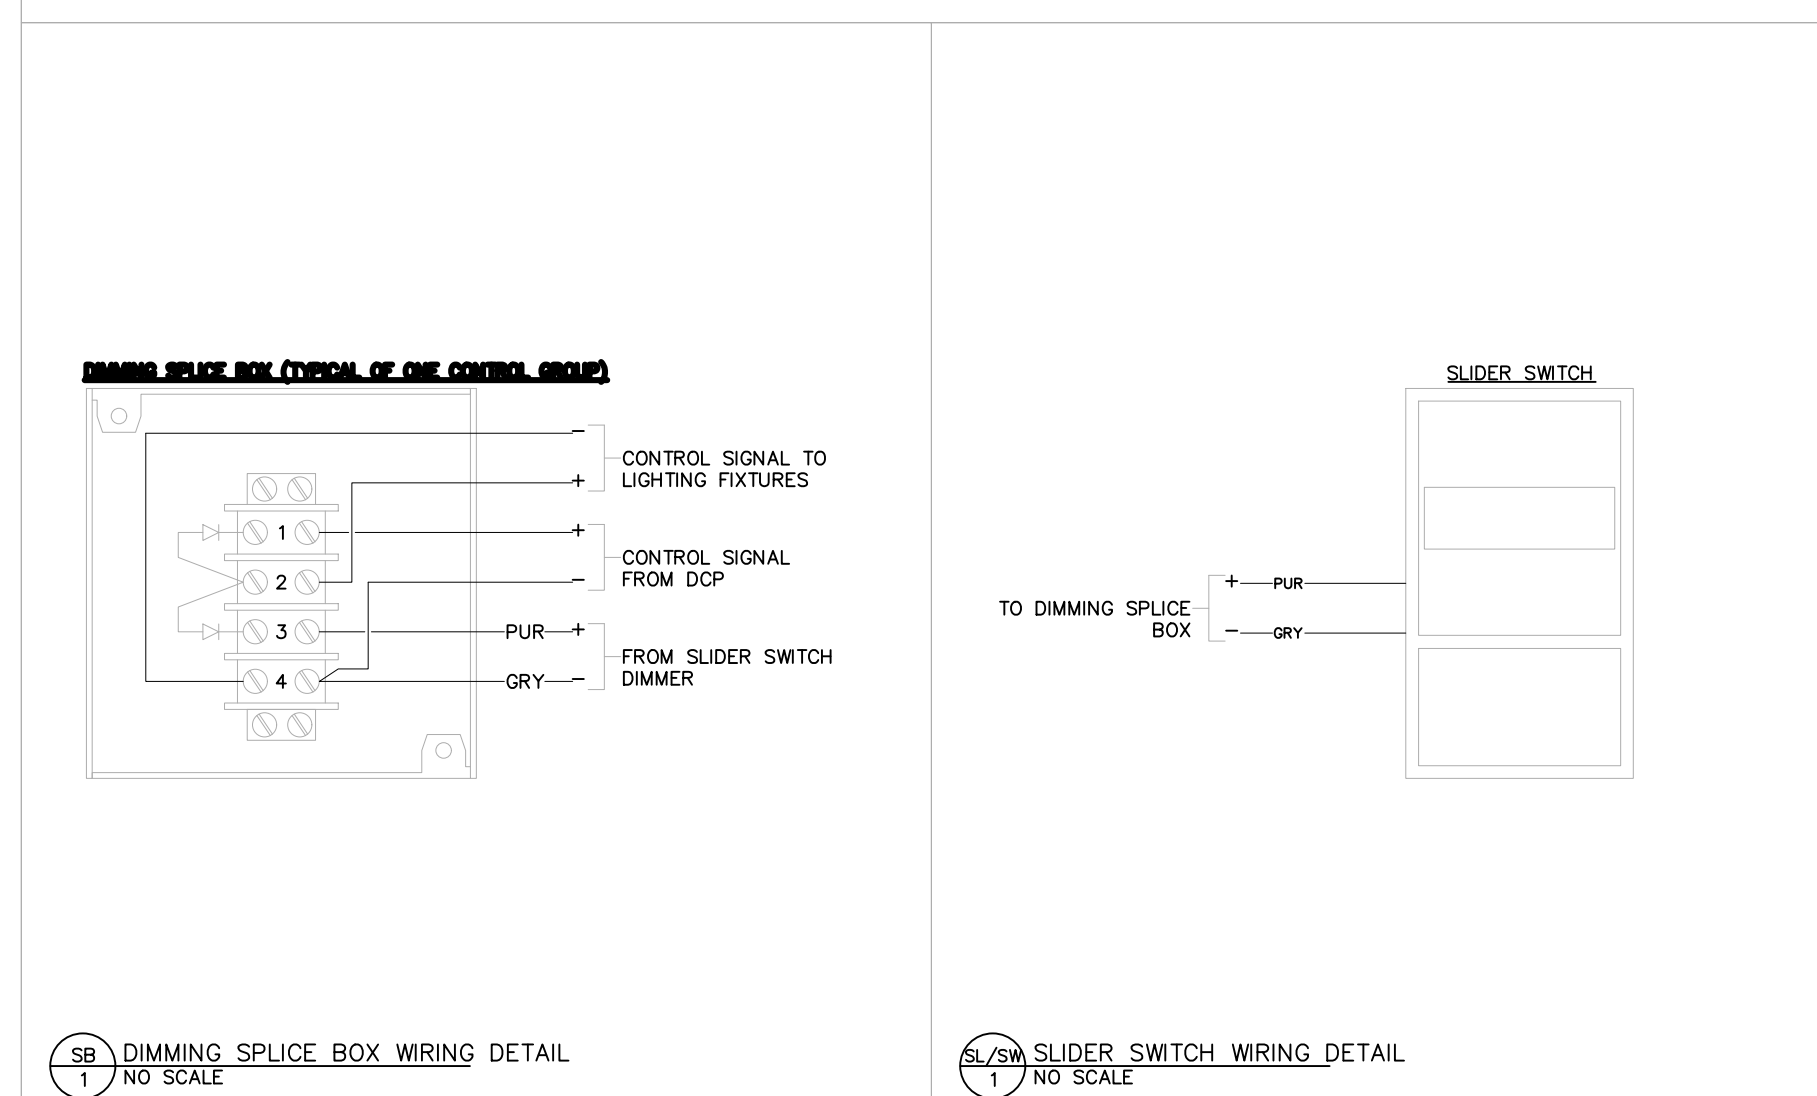

SB DIMMING SPLICE BOX WIRING DETAIL
1 NO SCALE

SSW SLIDER SWITCH WIRING DETAIL
1 NO SCALE

Project: **HARBOR FREIGHT**
NEW CONSTRUCTION

Description: **PROTOTYPICAL NATIONAL EMS BID SET**

Date: 11-15-17

Scale: NTS

Drawing File Name/Origin: Harbor Freight-Bid Set-Rev8.dwg

REVISIONS

#	DESCRIPTION	DATE	BY	DWG.
0	Initial Release	11-15-17	MS	
3	Revised	4-23-18	MS	
4	Revised	8-12-19	MS	
5	Revised	10-10-19	MS	
6	Revised	3-3-20	MS	
7	Revised	4-13-20	MS	
8	Revised	6-2-20	MS	

EMS-2

SIEMENS
9225 BEE CAVES ROAD, BLDG. B, SUITE 100,
AUSTIN, TEXAS 78733 Phone: 512-421-6257