




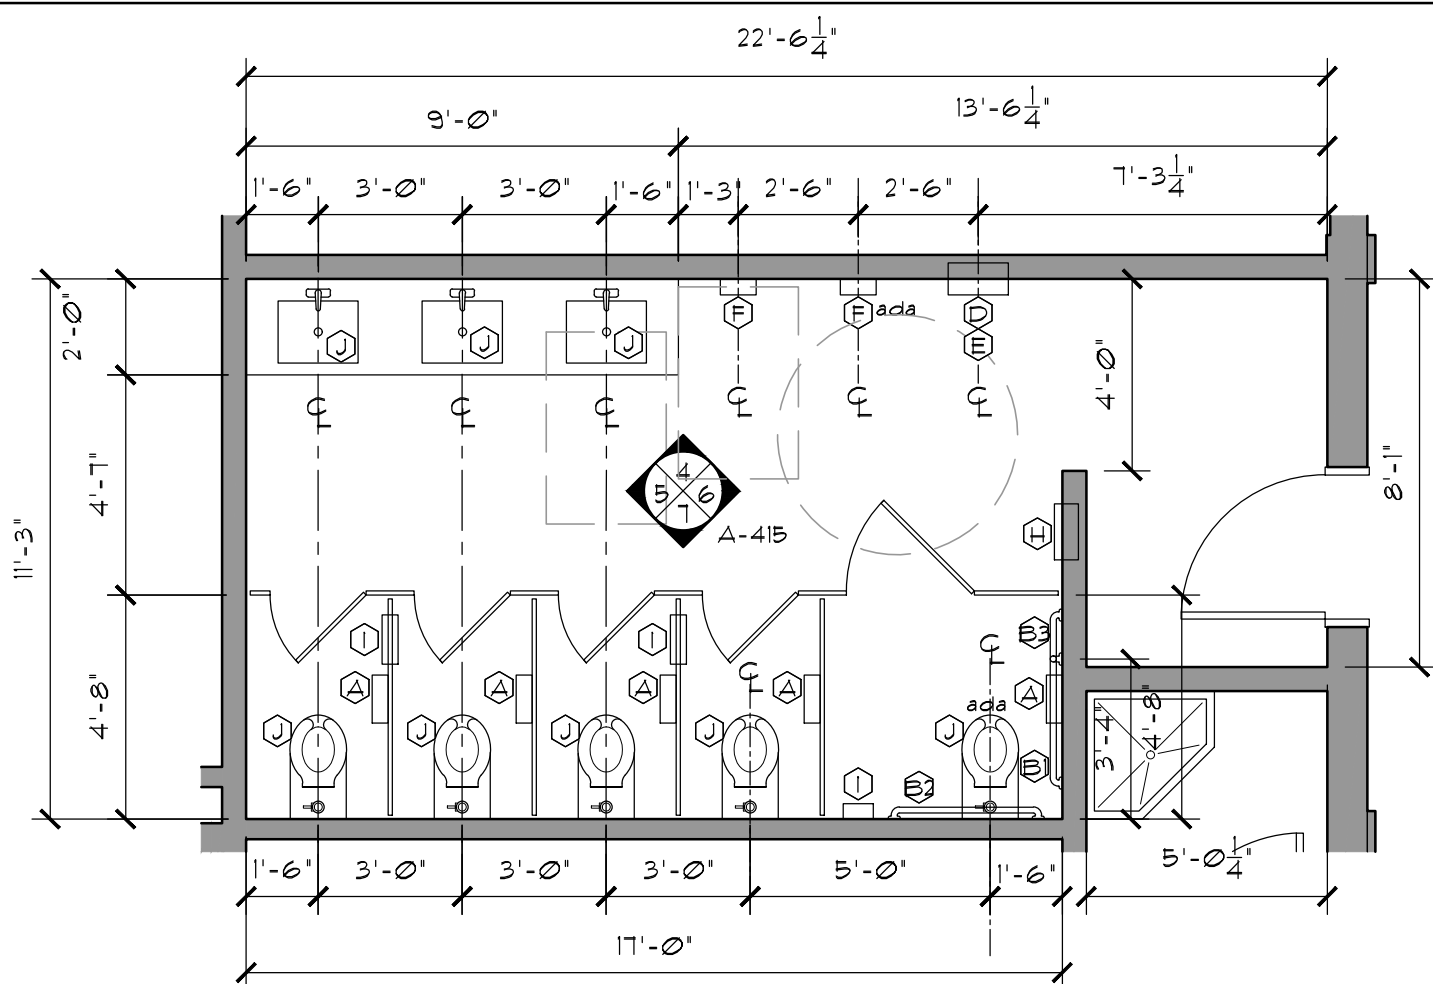


1 WOMEN'S RESTROOM (ROOM 128)
PARTIAL PLAN
SCALE: 1/4"=1'-0"

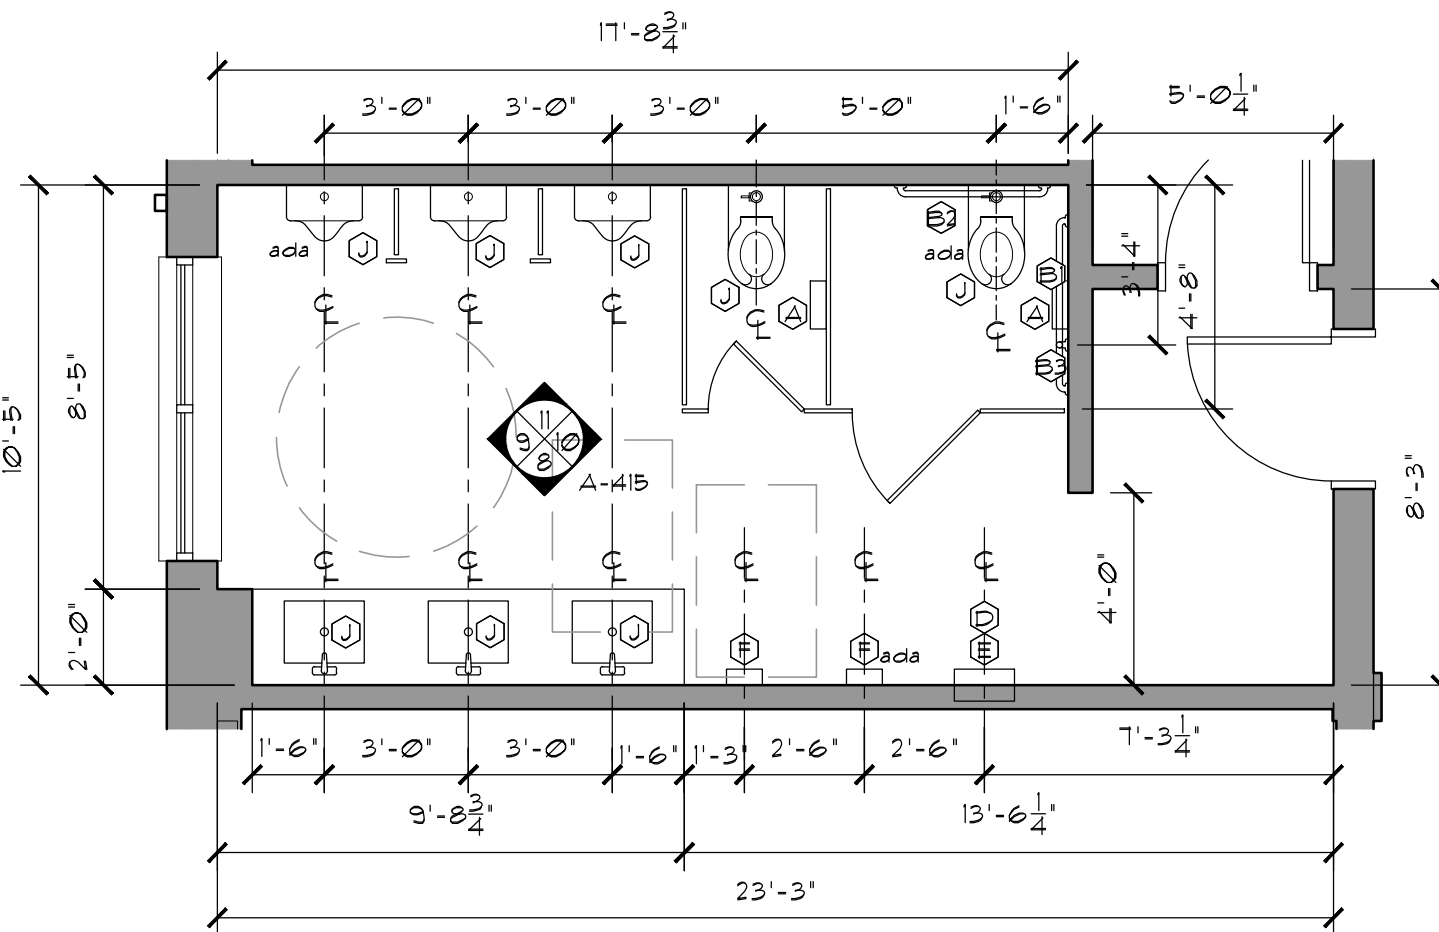


2 MEN'S RESTROOM (ROOM 131)
PARTIAL PLAN
SCALE: 1/4"=1'-0"

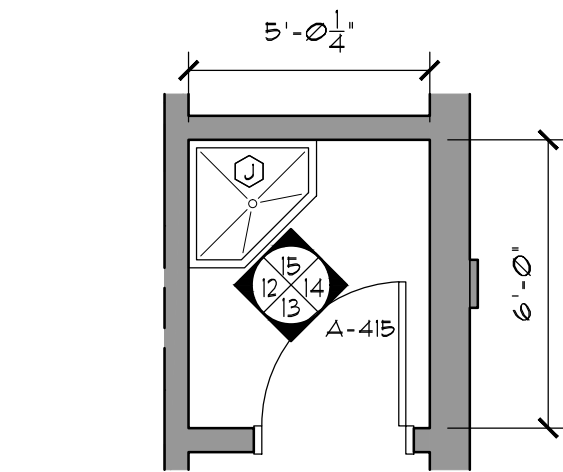


3 JANITOR'S CLOSET (ROOM 130)
PARTIAL PLAN
SCALE: 1/4"=1'-0"

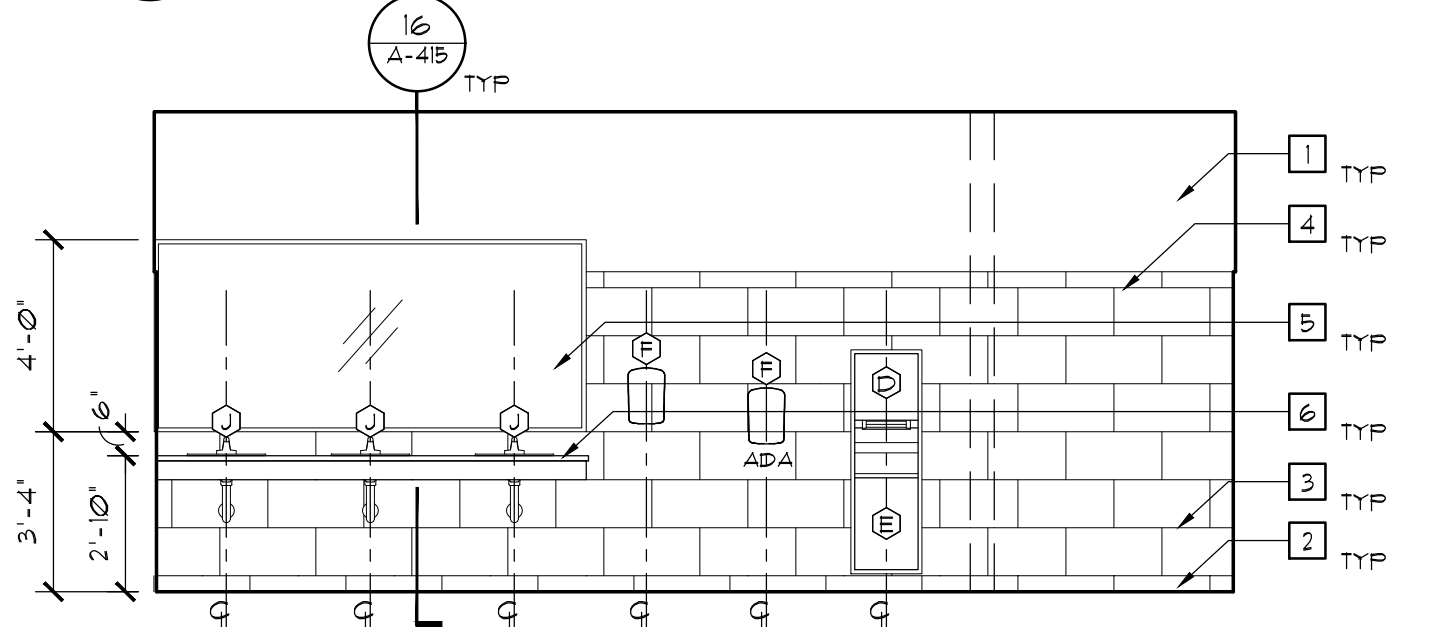


4 WOMEN'S RESTRM ELEV.
SCALE: 1/4"=1'-0"

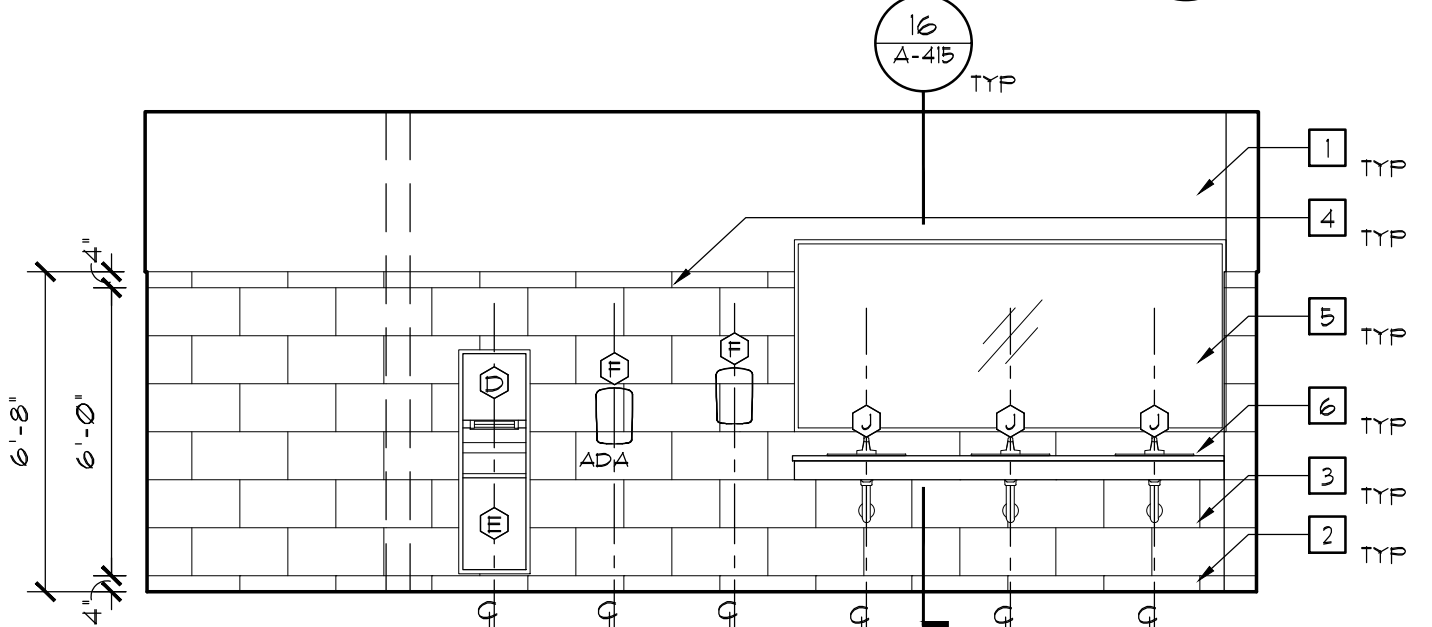


8 MEN'S RESTRM ELEV.
SCALE: 1/4"=1'-0"

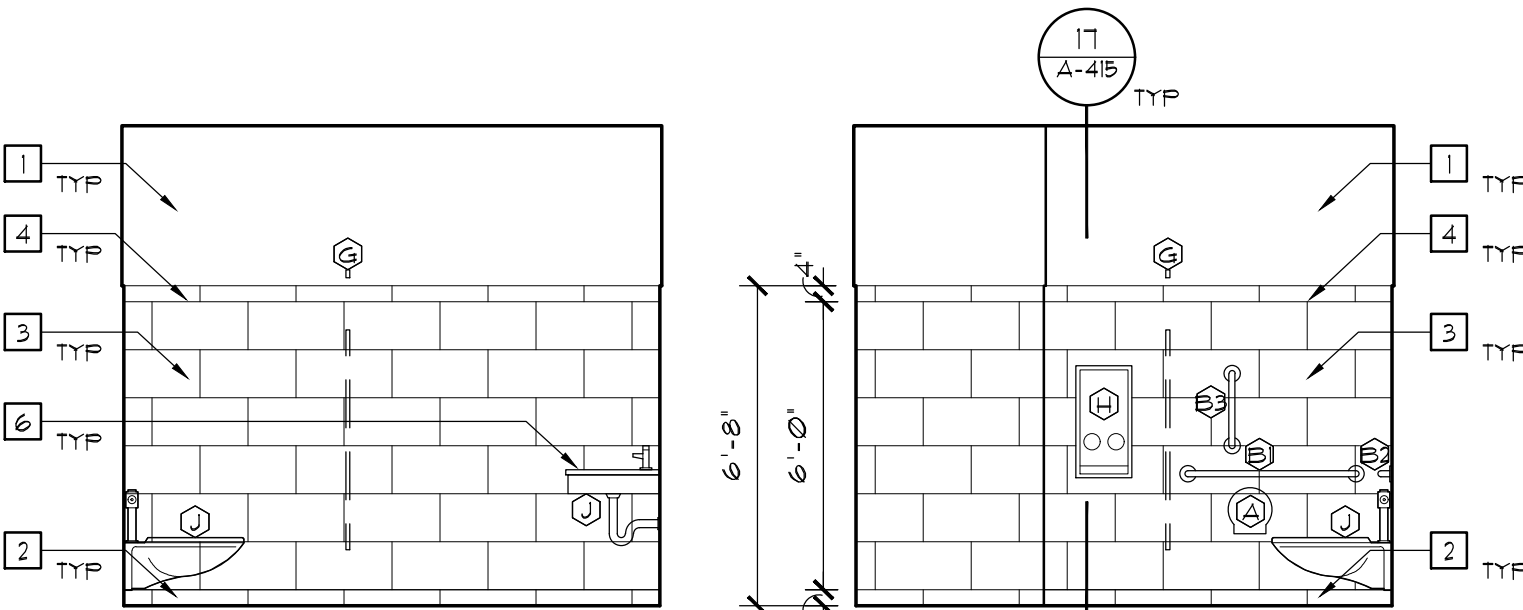


5 WOMEN'S RESTRM ELEV.
SCALE: 1/4"=1'-0"

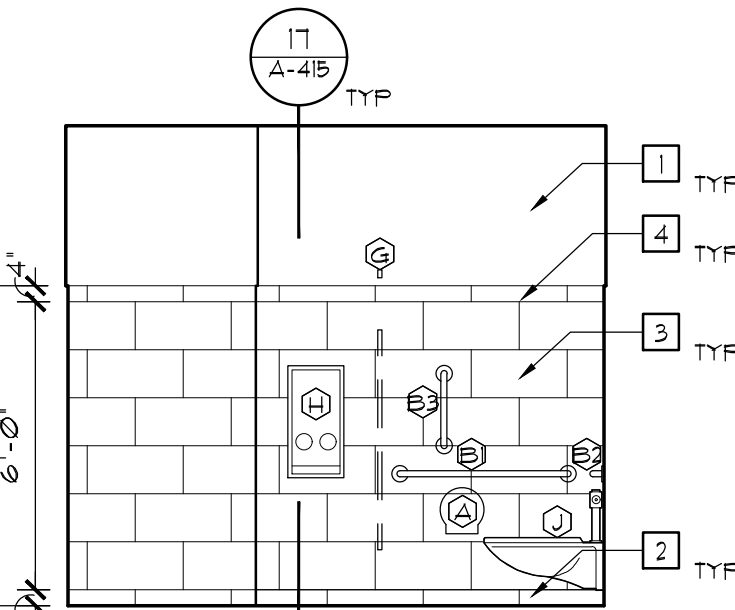


6 WOMEN'S RESTRM ELEV.
SCALE: 1/4"=1'-0"

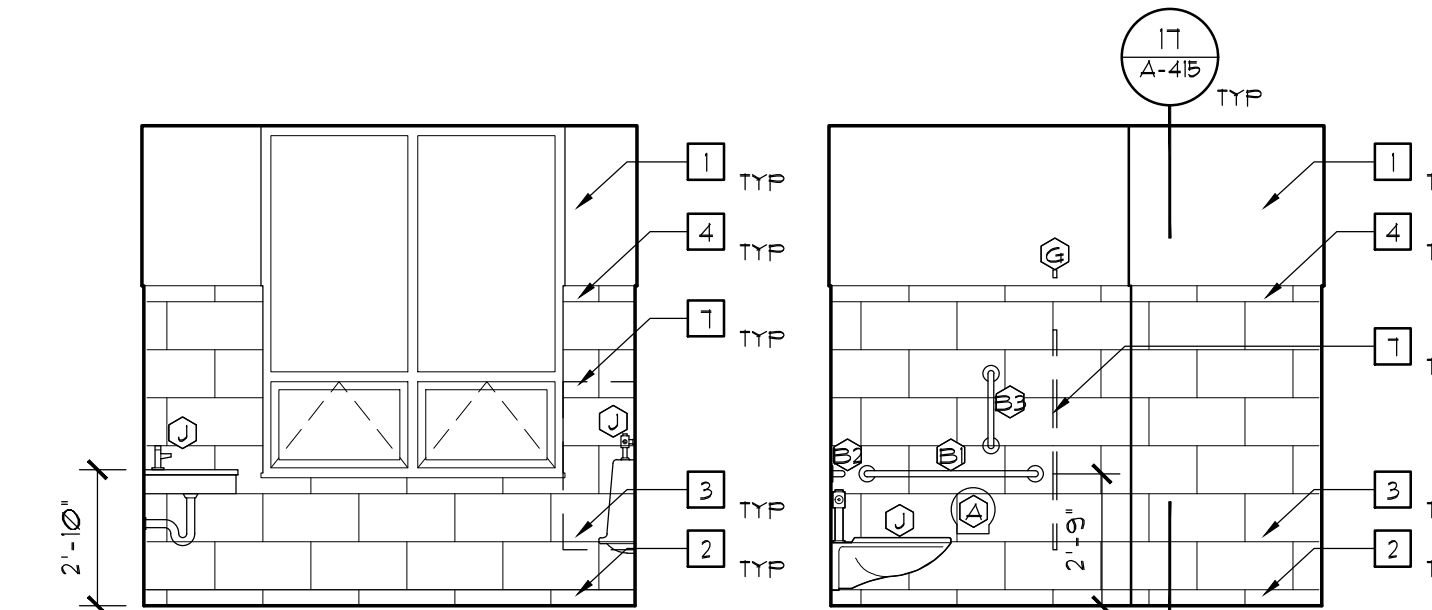


9 MEN'S RESTRM ELEV.
SCALE: 1/4"=1'-0"

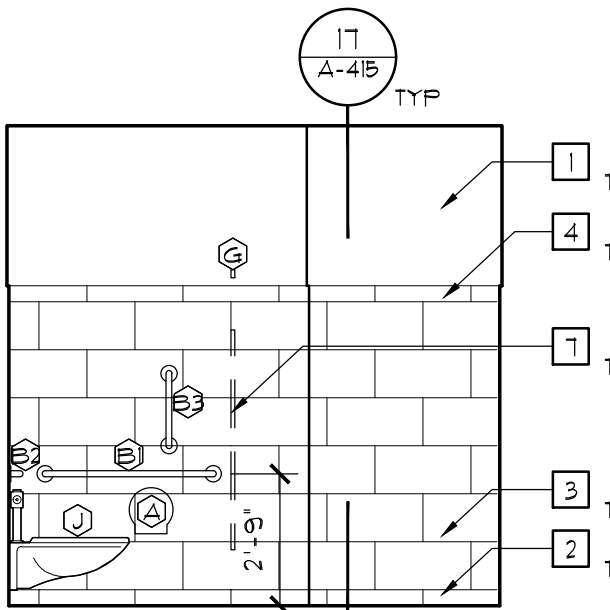

10 MEN'S RESTRM ELEV.
SCALE: 1/4"=1'-0"

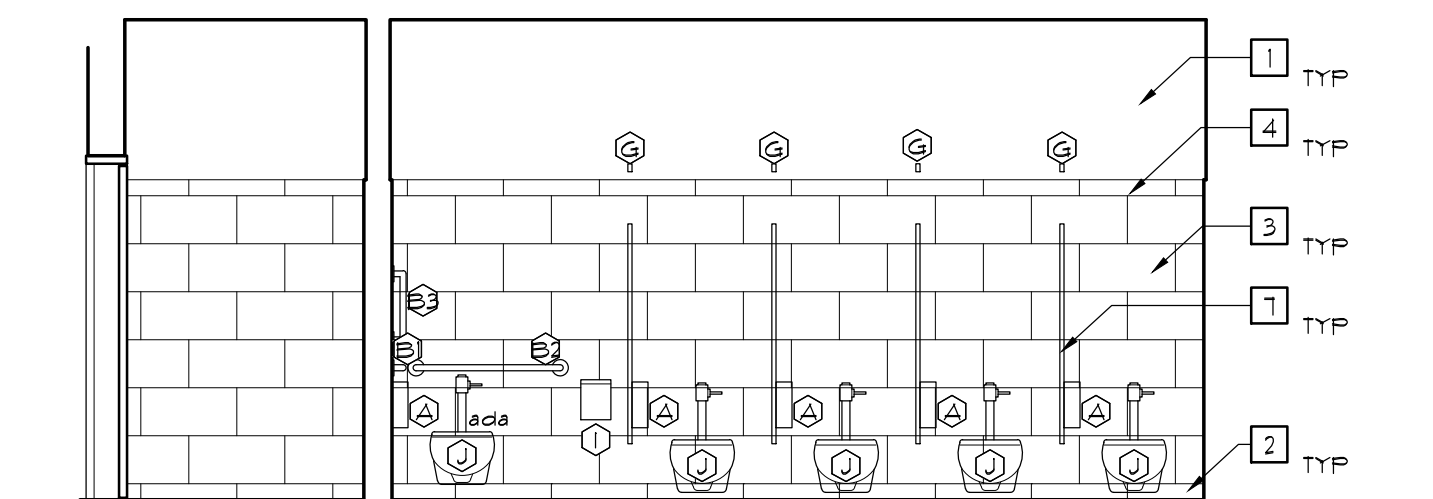


7 WOMEN'S RESTRM ELEV.
SCALE: 1/4"=1'-0"

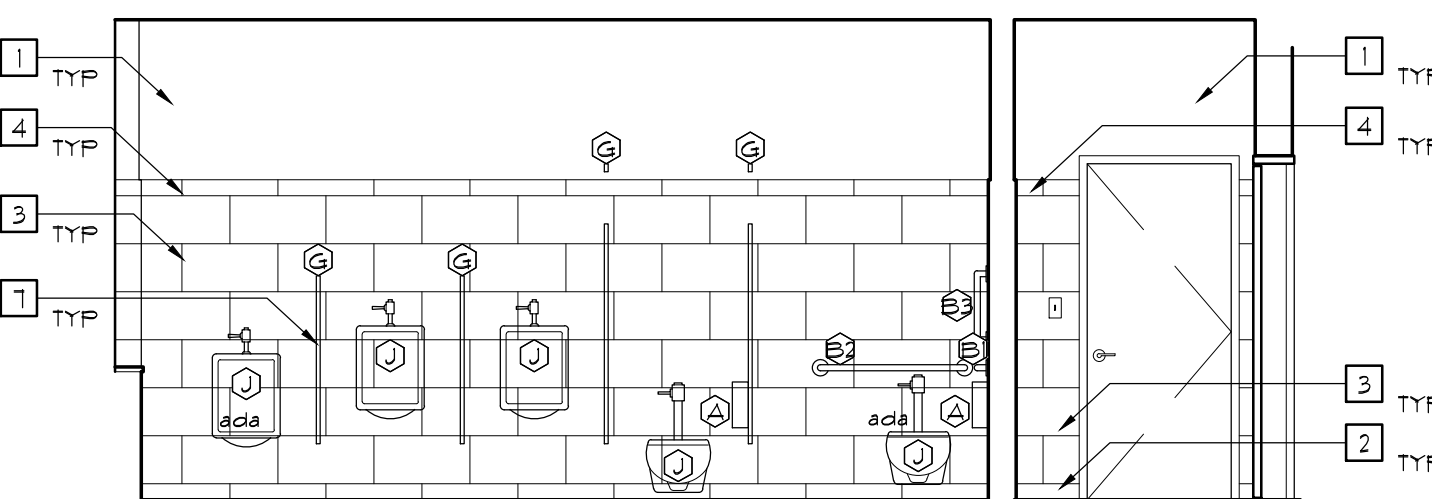

11 MEN'S RESTRM ELEV.
SCALE: 1/4"=1'-0"




12 JANITOR CL. ELEV.
SCALE: 1/4"=1'-0"

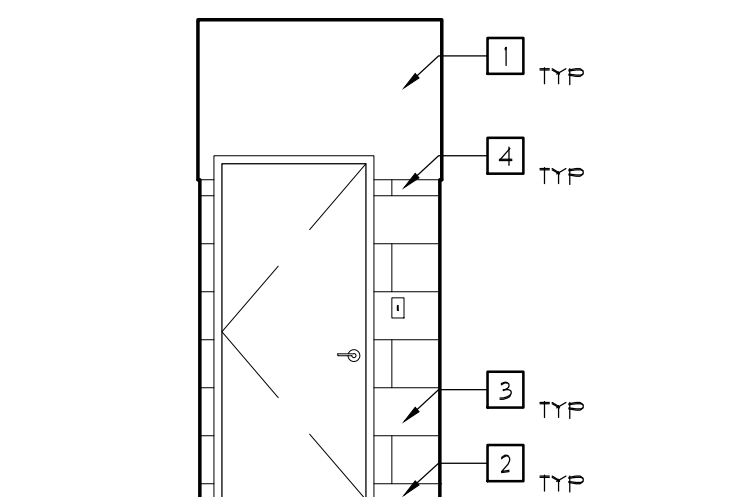

13 JANITOR CL. ELEV.
SCALE: 1/4"=1'-0"




14 JANITOR CL. ELEV.
SCALE: 1/4"=1'-0"

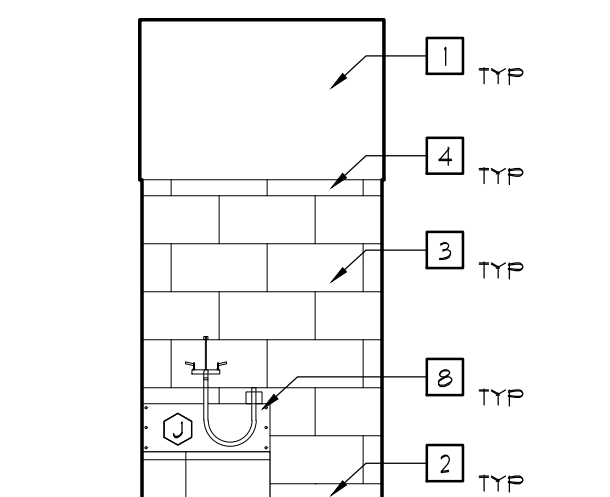


15 JANITOR CL. ELEV.
SCALE: 1/4"=1'-0"


RESTROOM ACCESSORY SCHEDULE		
SYMBOL	DESCRIPTION	PRODUCT DETAILS/NOTES
(A)	TOILET TISSUE DISPENSER	TO BE PROVIDED BY OWNER FOR GC TO INSTALL
(B)	GRAB BAR	BOBRICK B-5806 X 42, 1/2" DIA TUBING, CONCEALED FLANGE, COVER SNAPS OVER MOUNTING FLANGE TO CONCEAL SCREWS. B1 (42"), B2 (36"), B3 (18")
(C)	SOAP DISPENSER	TO BE PROVIDED BY OWNER FOR COUNTERTOP PLACEMENT
(D)	PAPER TOWEL DISPENSER	BOBRICK 3361-50 AUTOMATIC ROLL PAPER TOWEL DISPENSER WITHIN BOBRICK B-3914 RECESSED CABINET, STAINLESS STEEL
(E)	WASTE RECEPTACLE	BOBRICK 368-60 18 GALLON WASTE RECEPTACLE WITHIN BOBRICK B-3914 RECESSED CABINET, STAINLESS STEEL
(F)	ADA HAND DRYER	EXCEL ThinAir HAND DRYER (3 3/8" PROJECTION)
(G)	PARTITION SYSTEM	1" THICK SOLID PLASTIC PARTITION, FURNISHED WITH STAINLESS STEEL HARDWARE AND ACCESSORIES. SEE SPEC.
(H)	SANITARY NAPKIN DISPENSER	BOBRICK B-3106, STAINLESS STEEL, SEMI-RECESSED
(I)	SANITARY NAPKIN DISPOSAL	BOBRICK B-4354 FOR PARTITION MOUNTED AND B-210 FOR SURFACE MOUNTED AT ADA STALLS, STAINLESS STEEL
(J)	PLUMBING FIXTURE	SEE PLUMBING FIXTURE SCHEDULE
(K)	DIAPER CHANGING STATION	BOBRICK KOALA KARE KB200-85

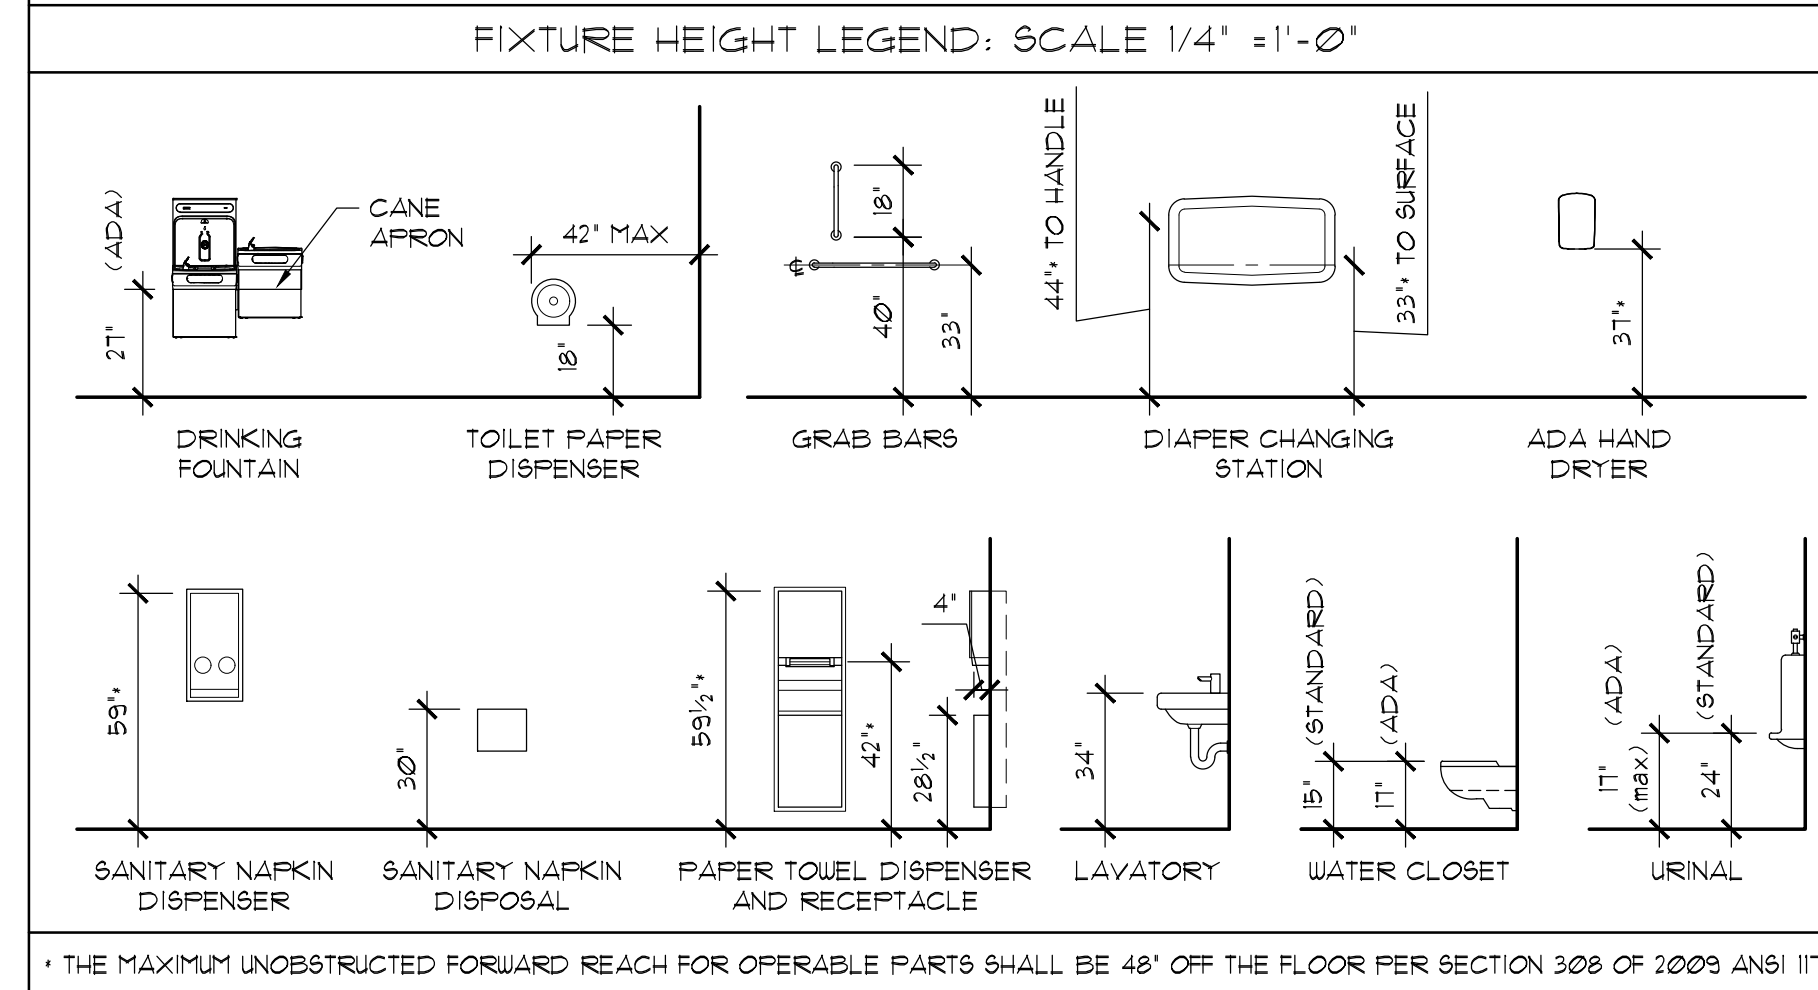


* THE MAXIMUM UNOBSTRUCTED FORWARD REACH FOR OPERABLE PARTS SHALL BE 48" OFF THE FLOOR PER SECTION 308 OF 2009 ANSI (11)

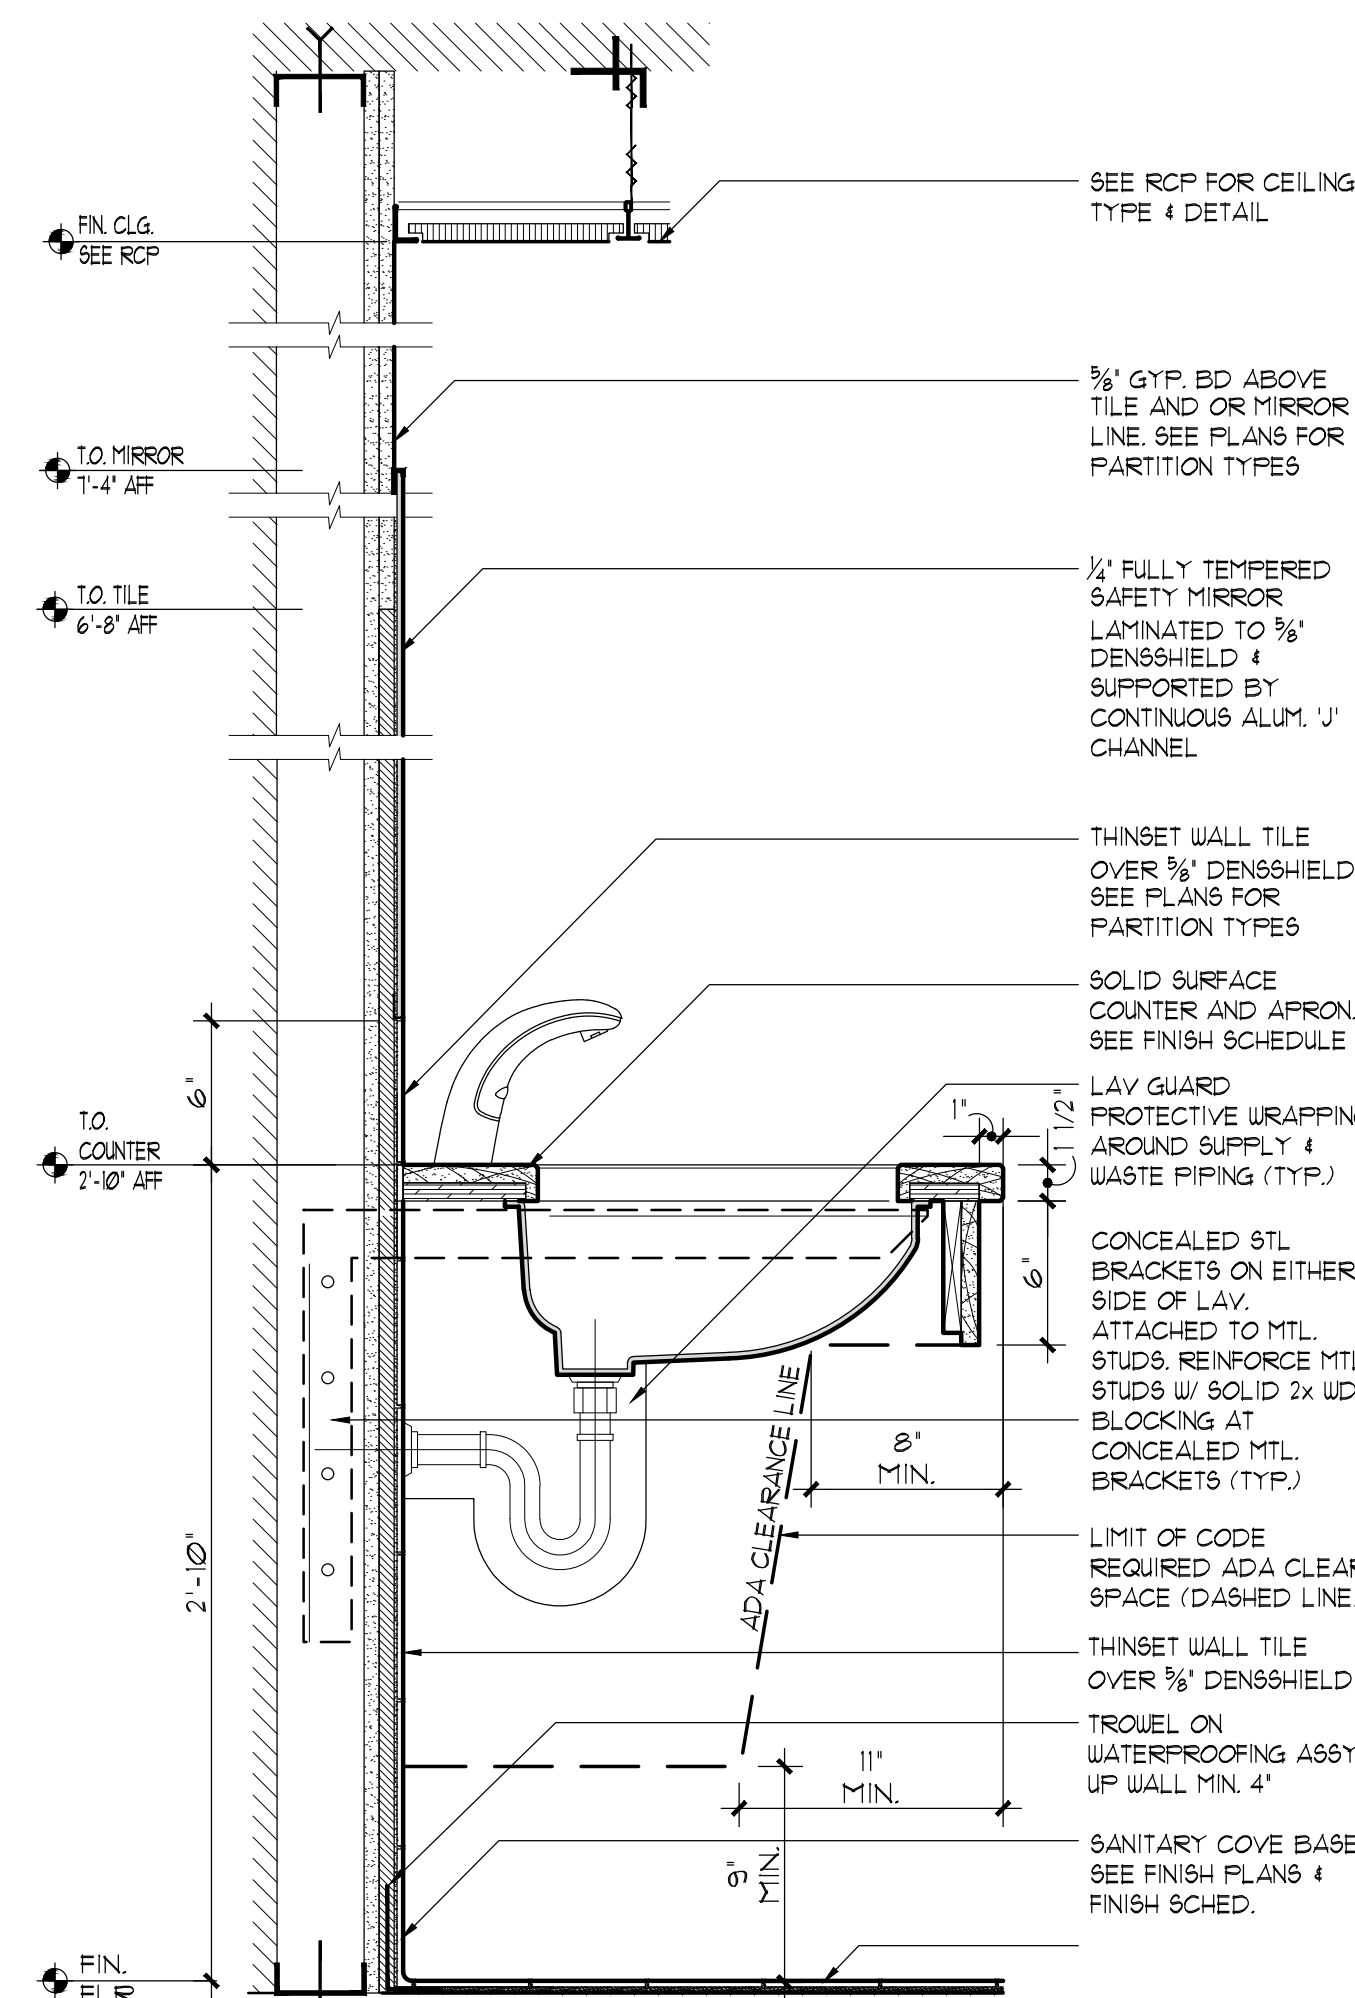


16 SECTION DETAIL
SCALE: 1-1/2"=1'-0"

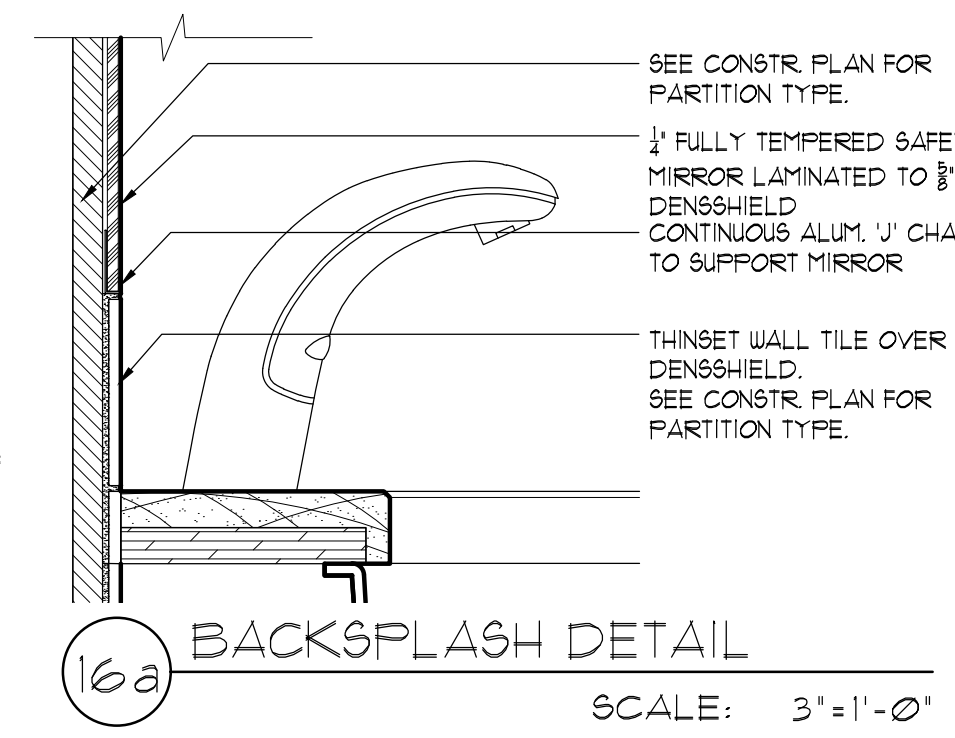

16a BACKSPASH DETAIL
SCALE: 3"=1'-0"

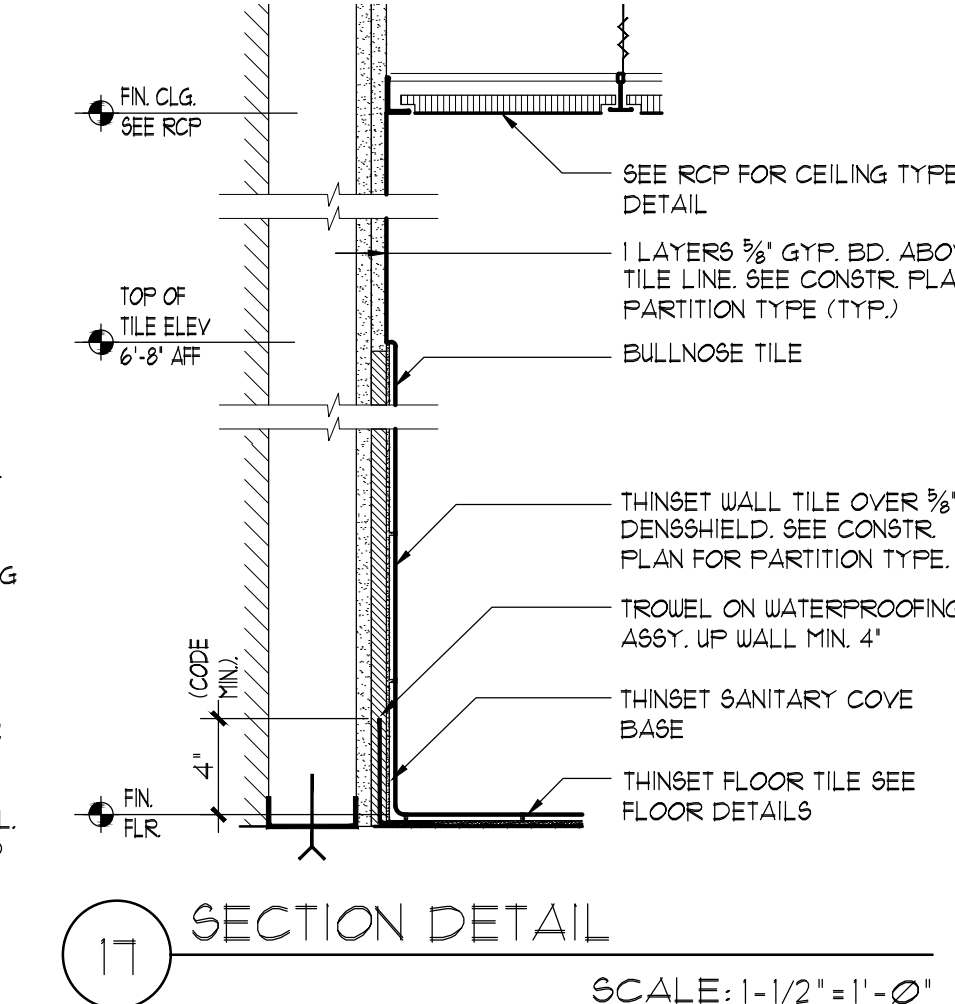

17 SECTION DETAIL
SCALE: 1-1/2"=1'-0"

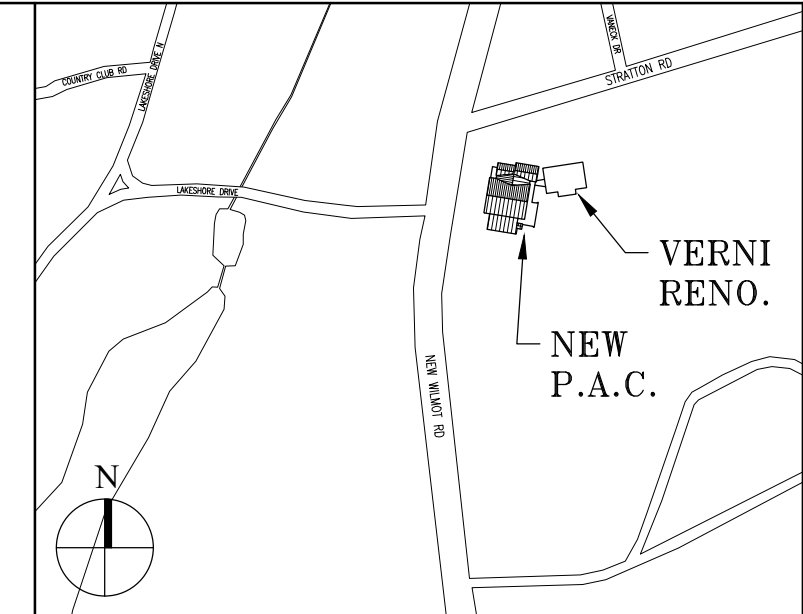

Key Plan (not to scale)

- TOILET ROOM TYPICAL NOTES:
- 1 GYP. BD. PAINT (SEE FINISH SCHEDULE)
 - 2 SANITARY COVE, SEE FINISH SCHEDULE
 - 3 PORCELAIN TILE, SEE FINISH SCHEDULE
 - 4 BULLNOSE TILE
 - 5 MIRROR (SEE DETAILS AND SPECS)
 - 6 CAESARSTONE COUNTER, SKIRT AND SIDE PANEL
 - 7 TOILET PARTITIONS
 - 8 MOP SINK, FAUCET, S/S GUARD

7.	6/01/2021	ISSUED FOR BID
6.	5/07/2021	RE-ISSUED FOR BUILDING PERMIT REVIEW
5.	2/01/2021	ISSUED FOR BUILDING PERMIT REVIEW
4.	10/14/2020	ISSUED FOR PLANNING BOARD REVIEW
3.	9/23/2020	RESUBMITTED FOR ZONING REVIEW
2.	8/28/2020	ISSUED FOR PRELIMINARY DOB REVIEW
1.	1/10/2020	ISSUED FOR DD ESTIMATE
No.	Date	Revision/Submission
STRUCTURAL & SITE CIVIL ENGINEER		
DOMINICK R. PILLA		
ASSOCIATES, P.C.		
143 MAIN STREET		
NYACK, NY 10960		
845-727-7793		
MEP ENGINEER		
JMV CONSULTING		
ENGINEERING, P.C.		
37 W. 39 STREET, STE 703		
NEW YORK, NY 10018		
212-852-9855		
ROOFING CONSULTANT		
WATSKY ASSOCIATES		
20 MADISON AVENUE		
VALHALLA, NY 10595		
914-948-3450		

Stamp

Project Title
IONA PREPARATORY SCHOOL
ADDITION AND ALTERATION TO THE
PAUL VERNI FINE ARTS CENTER

Project Address
IONA PREPARATORY SCHOOL
255 Wilmot Road
New Rochelle, NY 10804

Drawing Title
INTERIOR ELEVATIONS
TOILETS PAC BLDG & JC CLOSET

Scale	Job No.	Date	Drawing No.
AS NOTED	1618	04/03/2019	A-415
Drawn	JPE		

Peter Gisolfi Associates
Architects Landscape Architects, LLP
566 Warburton Avenue
Hastings on Hudson, NY 10706
914 478 3677

PETER GISOLFI ASSOCIATES