



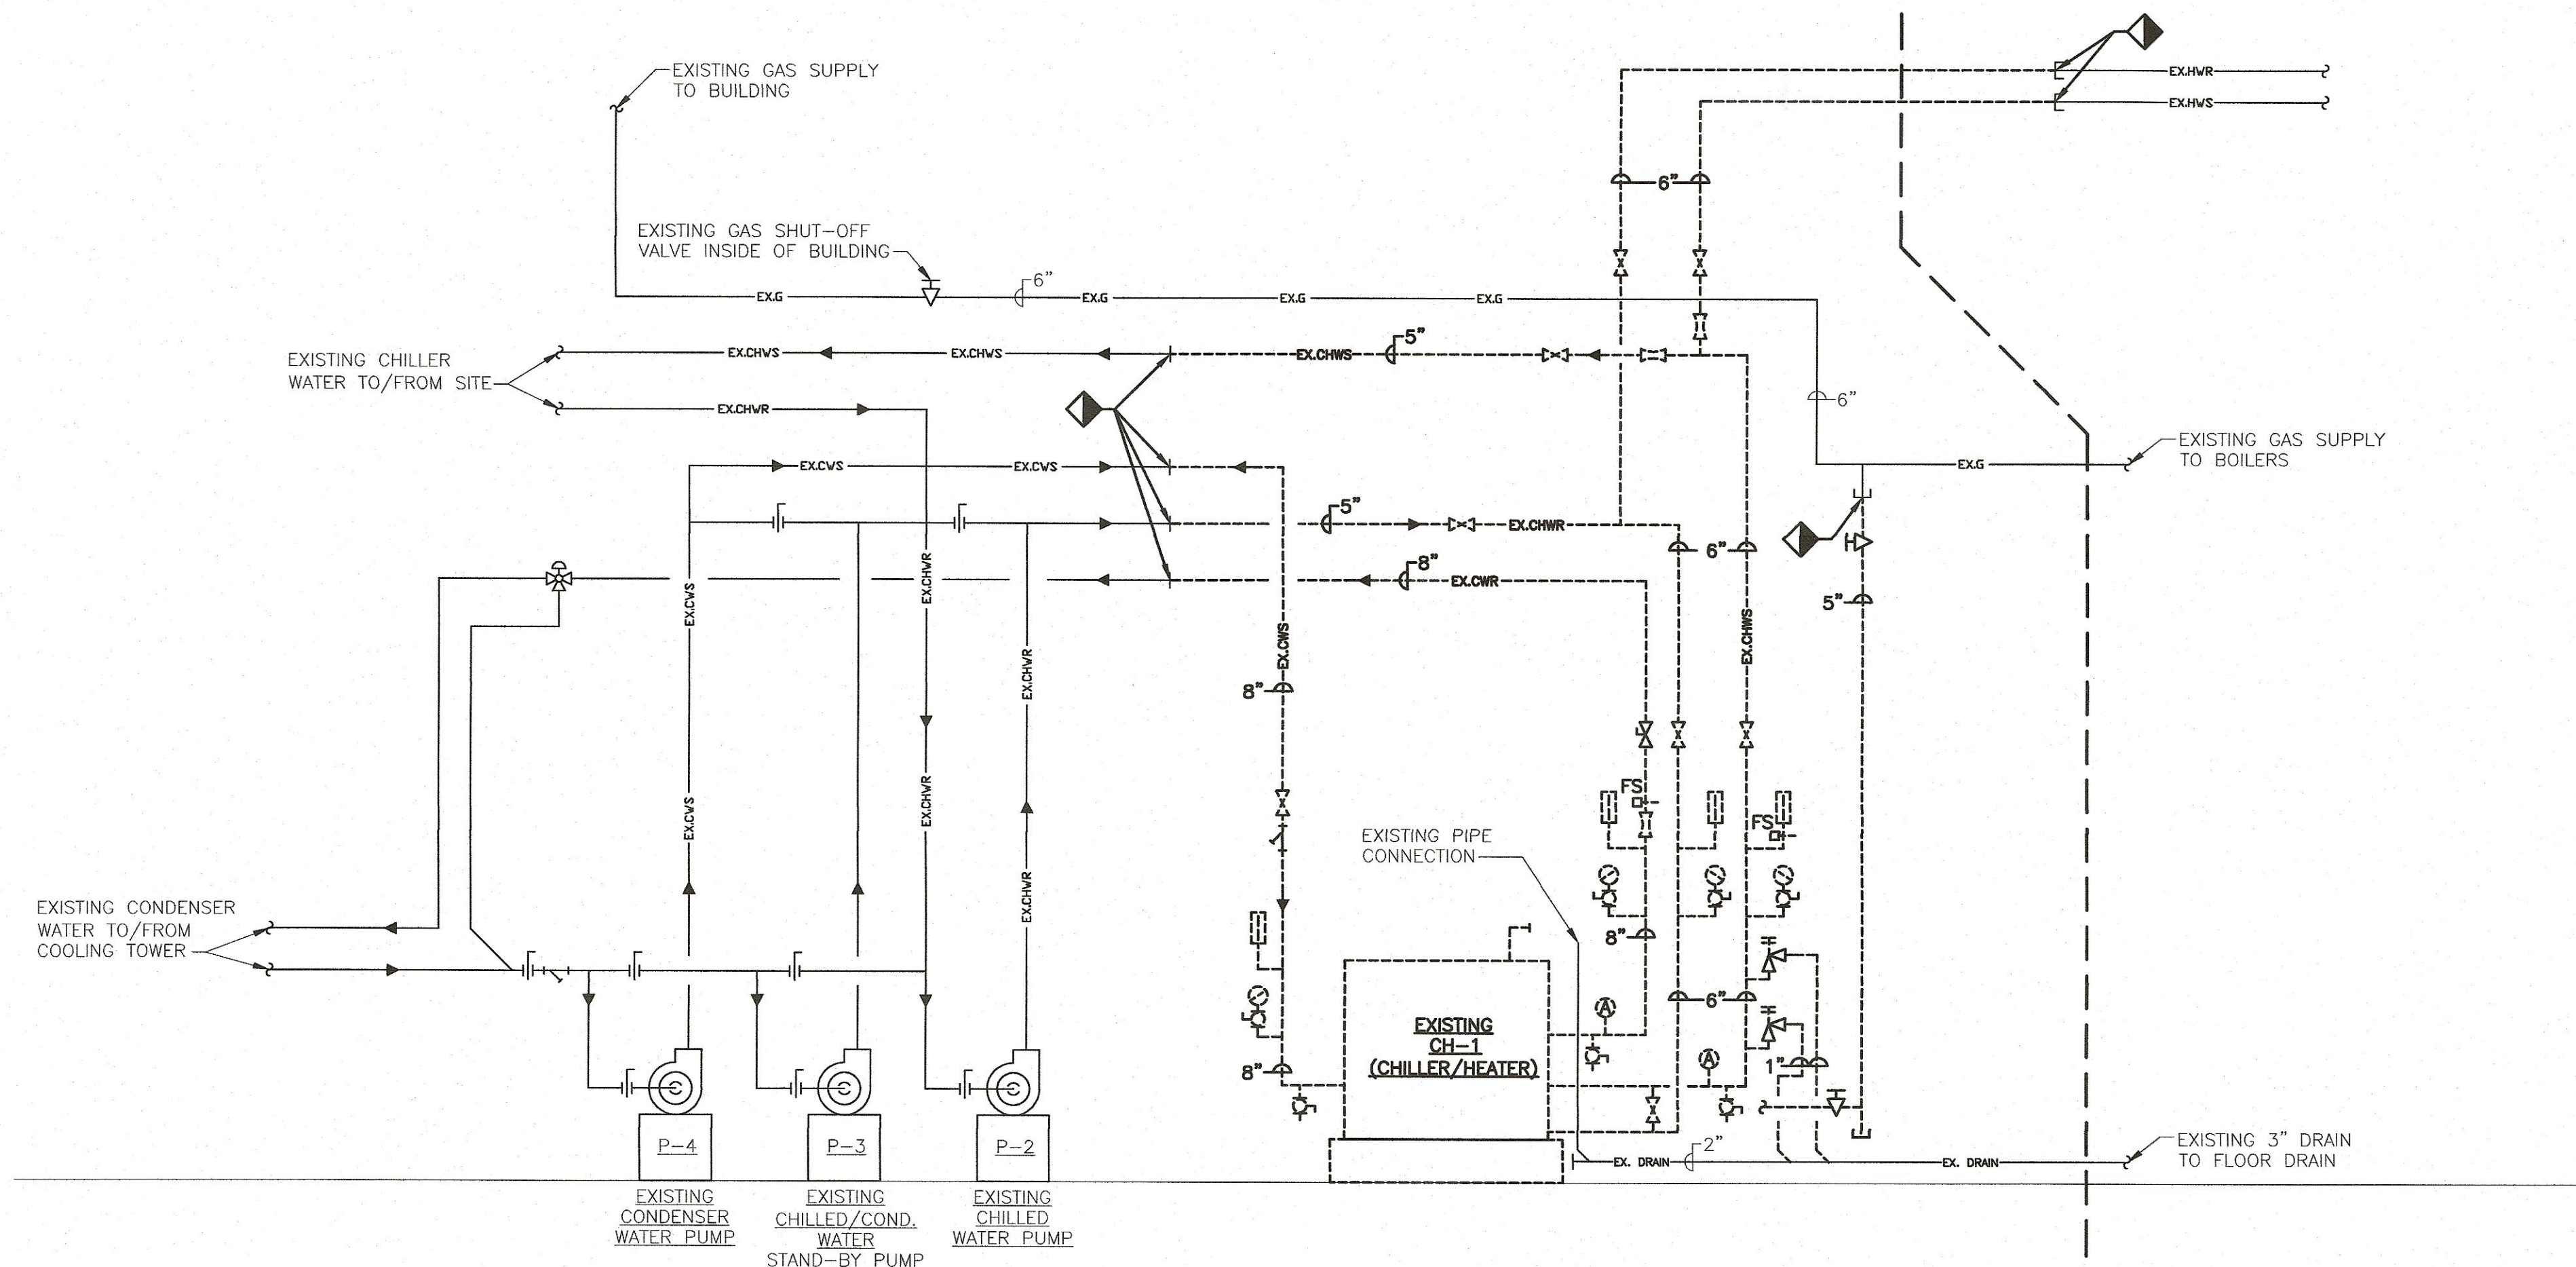

1 PARTIAL DEMOLITION FLOW DIAGRAM
N.T.S.

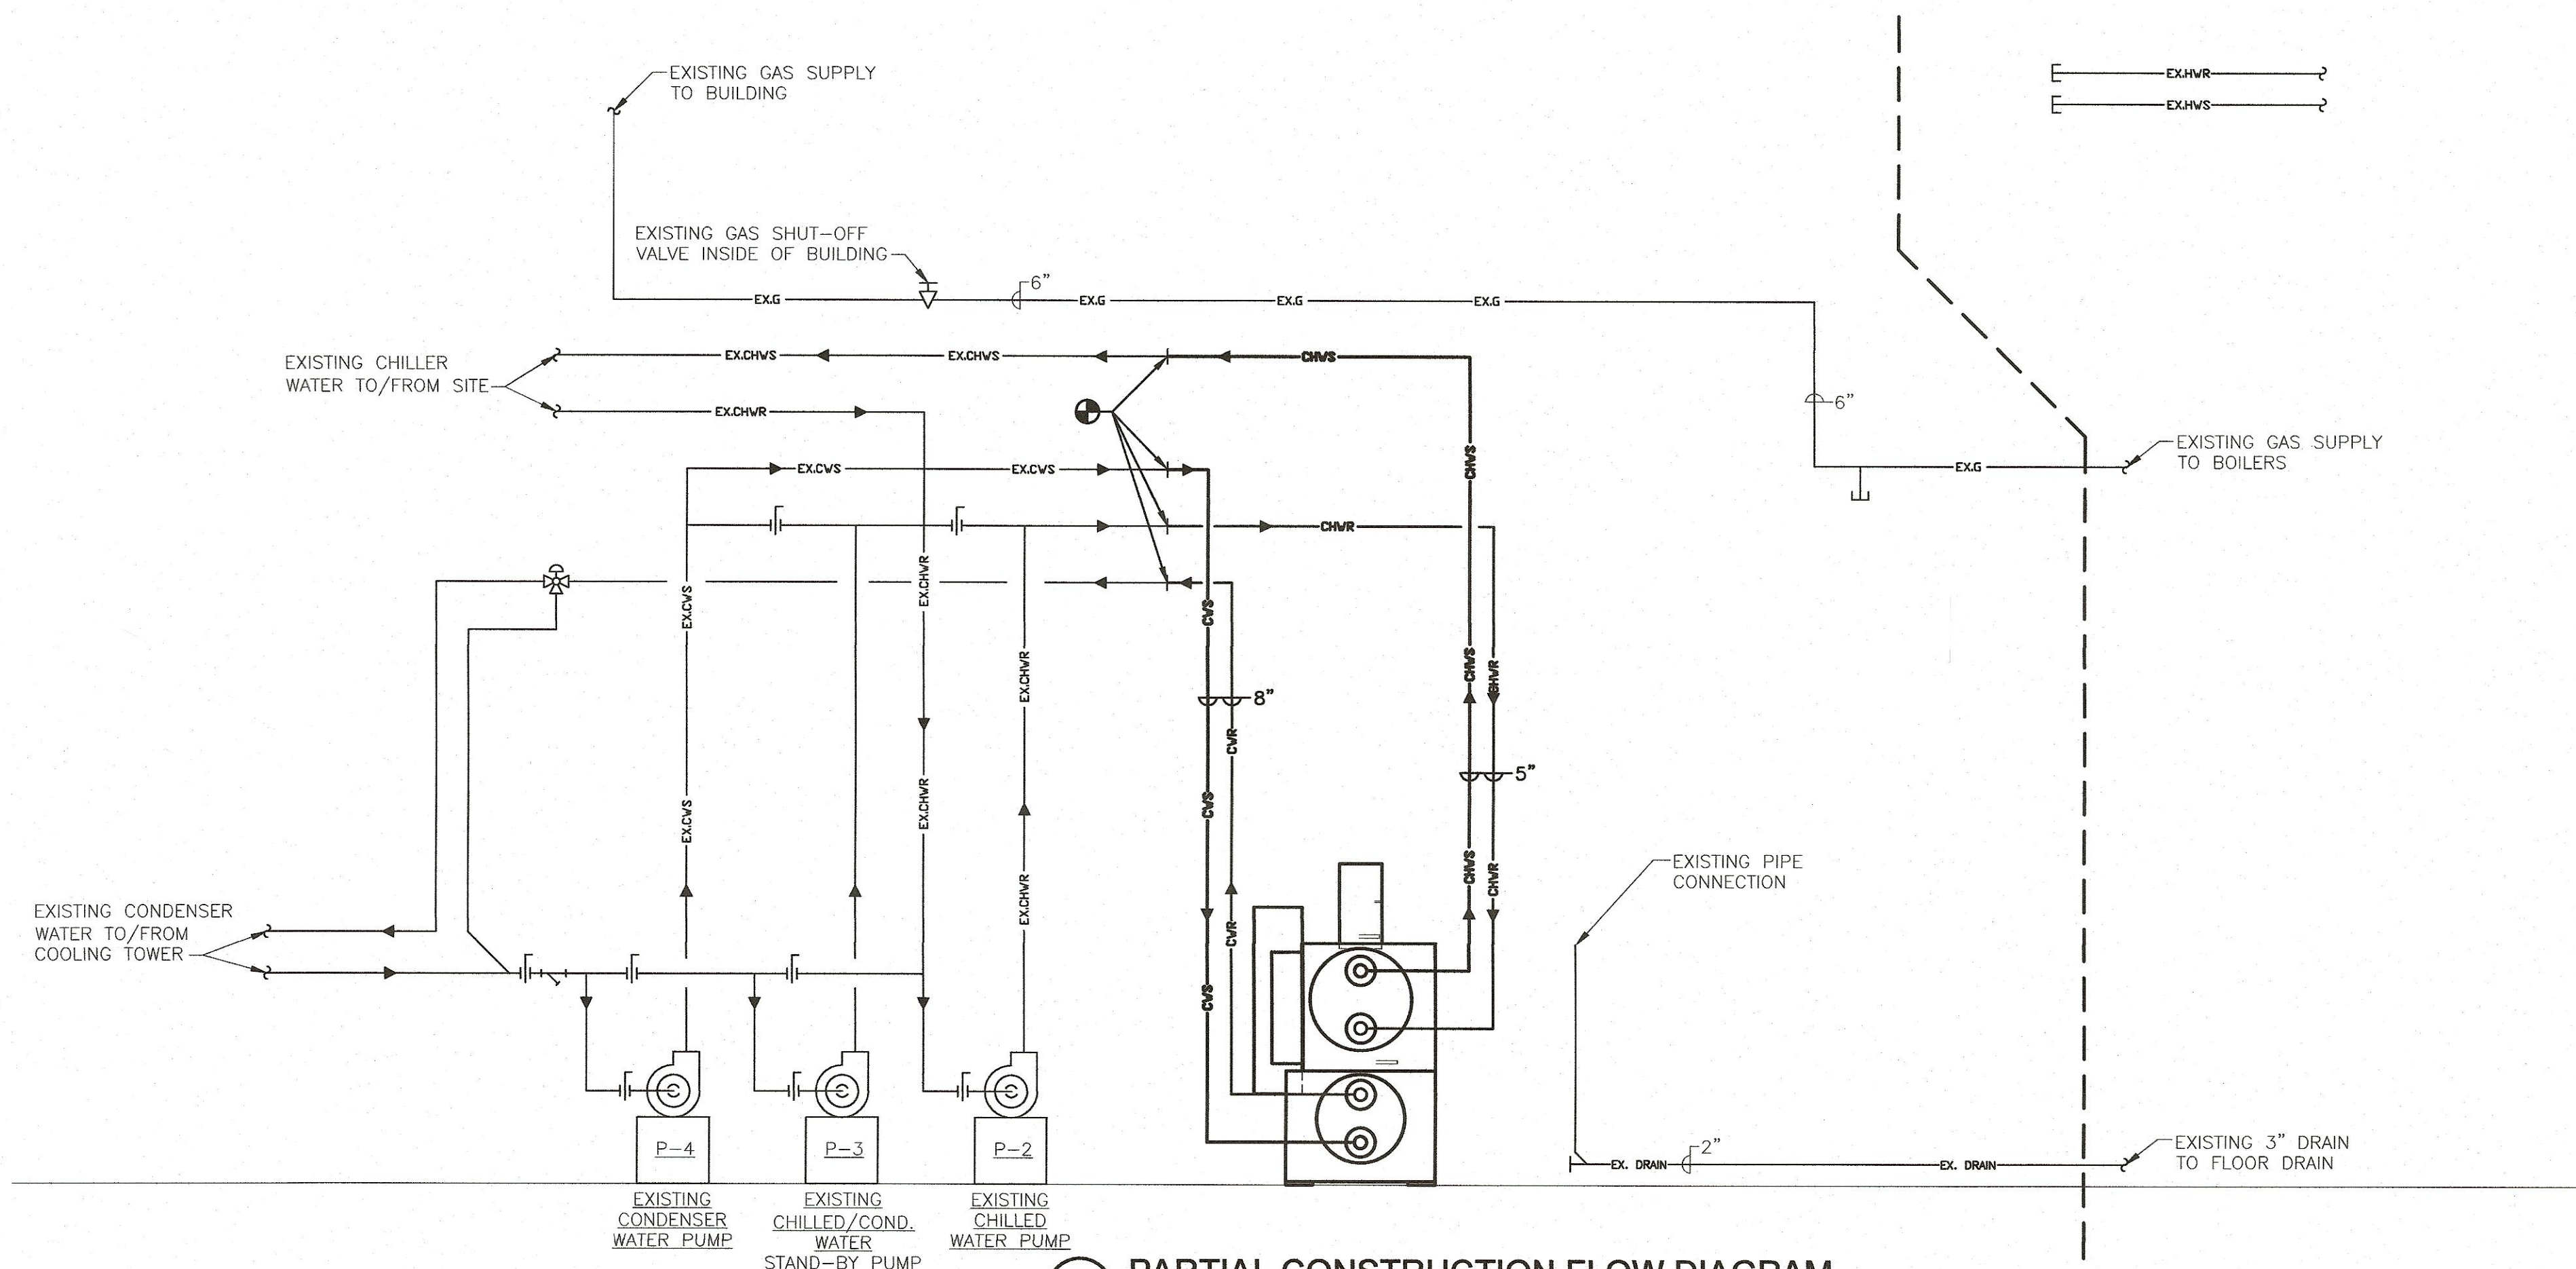

2 PARTIAL CONSTRUCTION FLOW DIAGRAM
N.T.S.

NOTE:

- SEE 1/MEP-701 FOR HW VALVES, STRAINS, GAUGES AND APPEARANCES.

GENERAL NOTES:

- REFER TO FLOOR PLANS FOR EXACT LOCATIONS OF DISCONNECT AND RECONNECT.
- REFER TO DETAIL 1/MEP-701 FOR A DETAILED PIPING LAYOUT OF CHILLER CONNECTIONS.

REV #	DATE	REMARKS:	ISSUE #	DATE	ISSUED FOR:
			1	9/2/21	BID

1/8" 1/4" 1/2" 0 1" 2"

REFERENCE SCALE

UNAUTHORIZED ALTERATION OR ADDITION TO A PLAN BEARING A LICENSED PROFESSIONAL ENGINEER'S SEAL IS A VIOLATION OF SECTION 7209, SUB-DIVISION 2 OF THE N.Y. STATE EDUCATION LAW.

FELLENZER ENGINEERING LLP

22 Mulberry St., Suite 2A, Middletown, NY 10940
t 845-343-1481 fx 845-343-4986

181 Church St., Suite 100, Poughkeepsie, NY 12601
t 845-454-9704 fx 855-320-8735

PROJECT TITLE: **OCCC SHEPARD STUDENT CENTER CHILLER REPLACEMENT**
115 SOUTH STREET, MIDDLETOWN, NY 10940

DRAWING TITLE: **FLOW DIAGRAMS**

DESIGNED BY: JDD	DRAWN BY: WPB	APPROVED BY: EDF	APPROVED BY: EDF	DRAWING #: MEP-601
DATE: 09/02/2021	SCALE: AS SHOWN	FE PROJECT #: 20-357	PAGE 6	OF 8