


SUNY ORANGE
MIDDLETOWN CAMPUS
115 SOUTH STREET, MIDDLETOWN NY


ROWLEY CENTER FOR SCIENCE AND ENGINEERING
IT ROOM ELECTRICAL & COOLING UPGRADE



LOCATION MAP

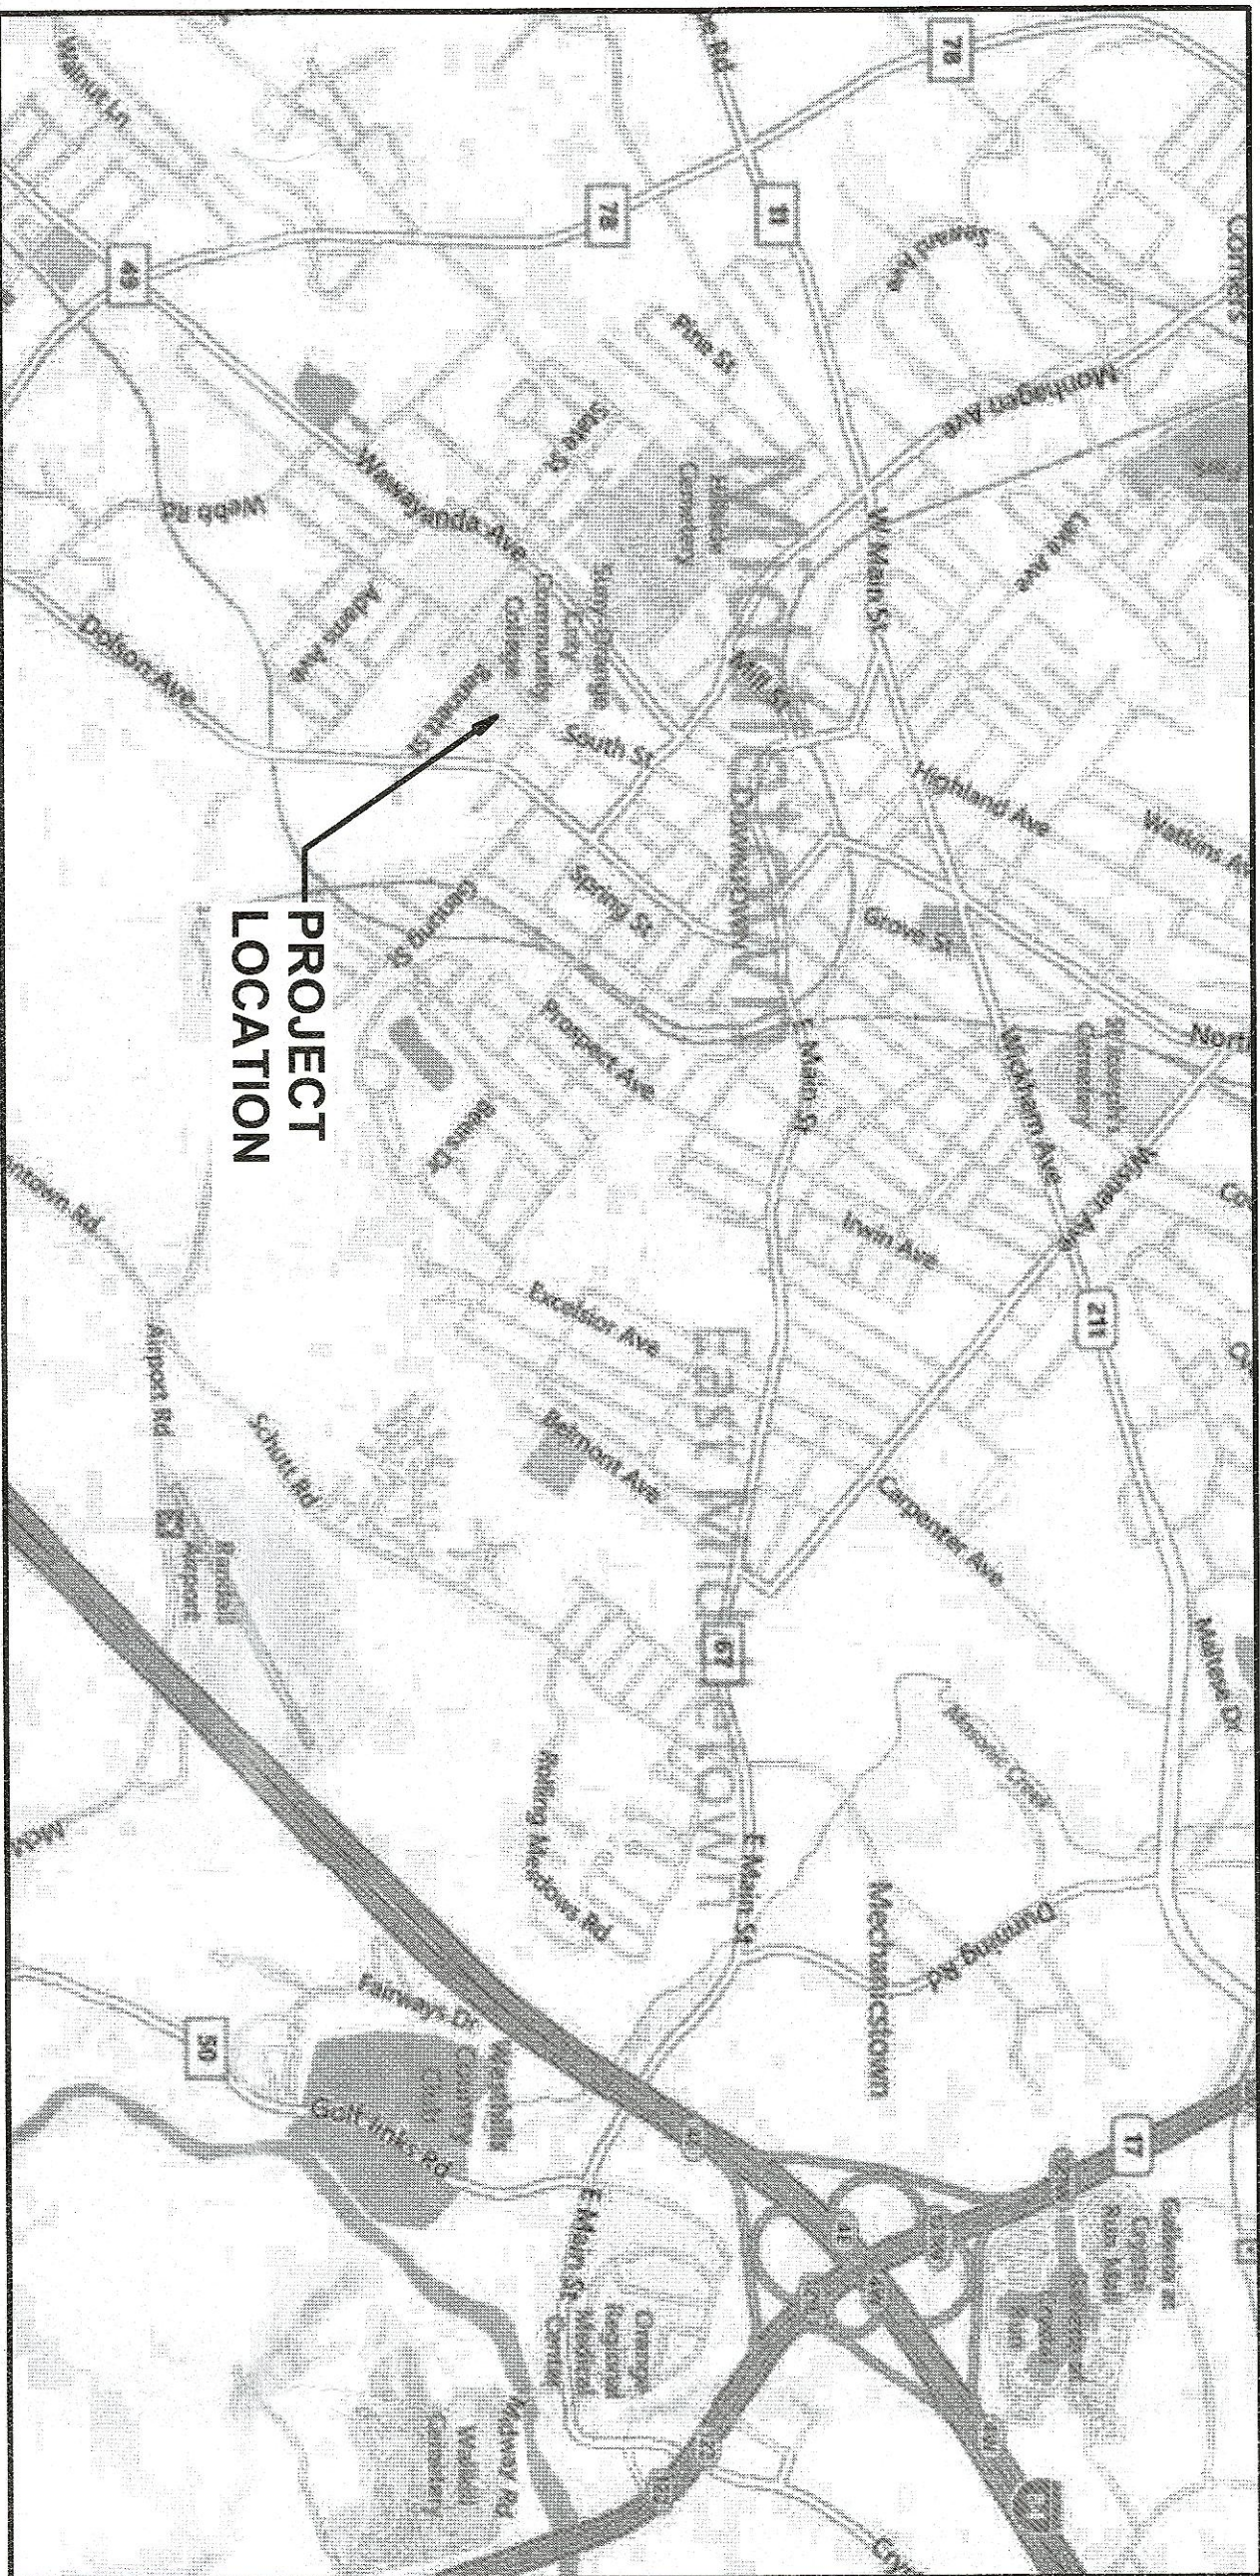


CAMPUS MAP

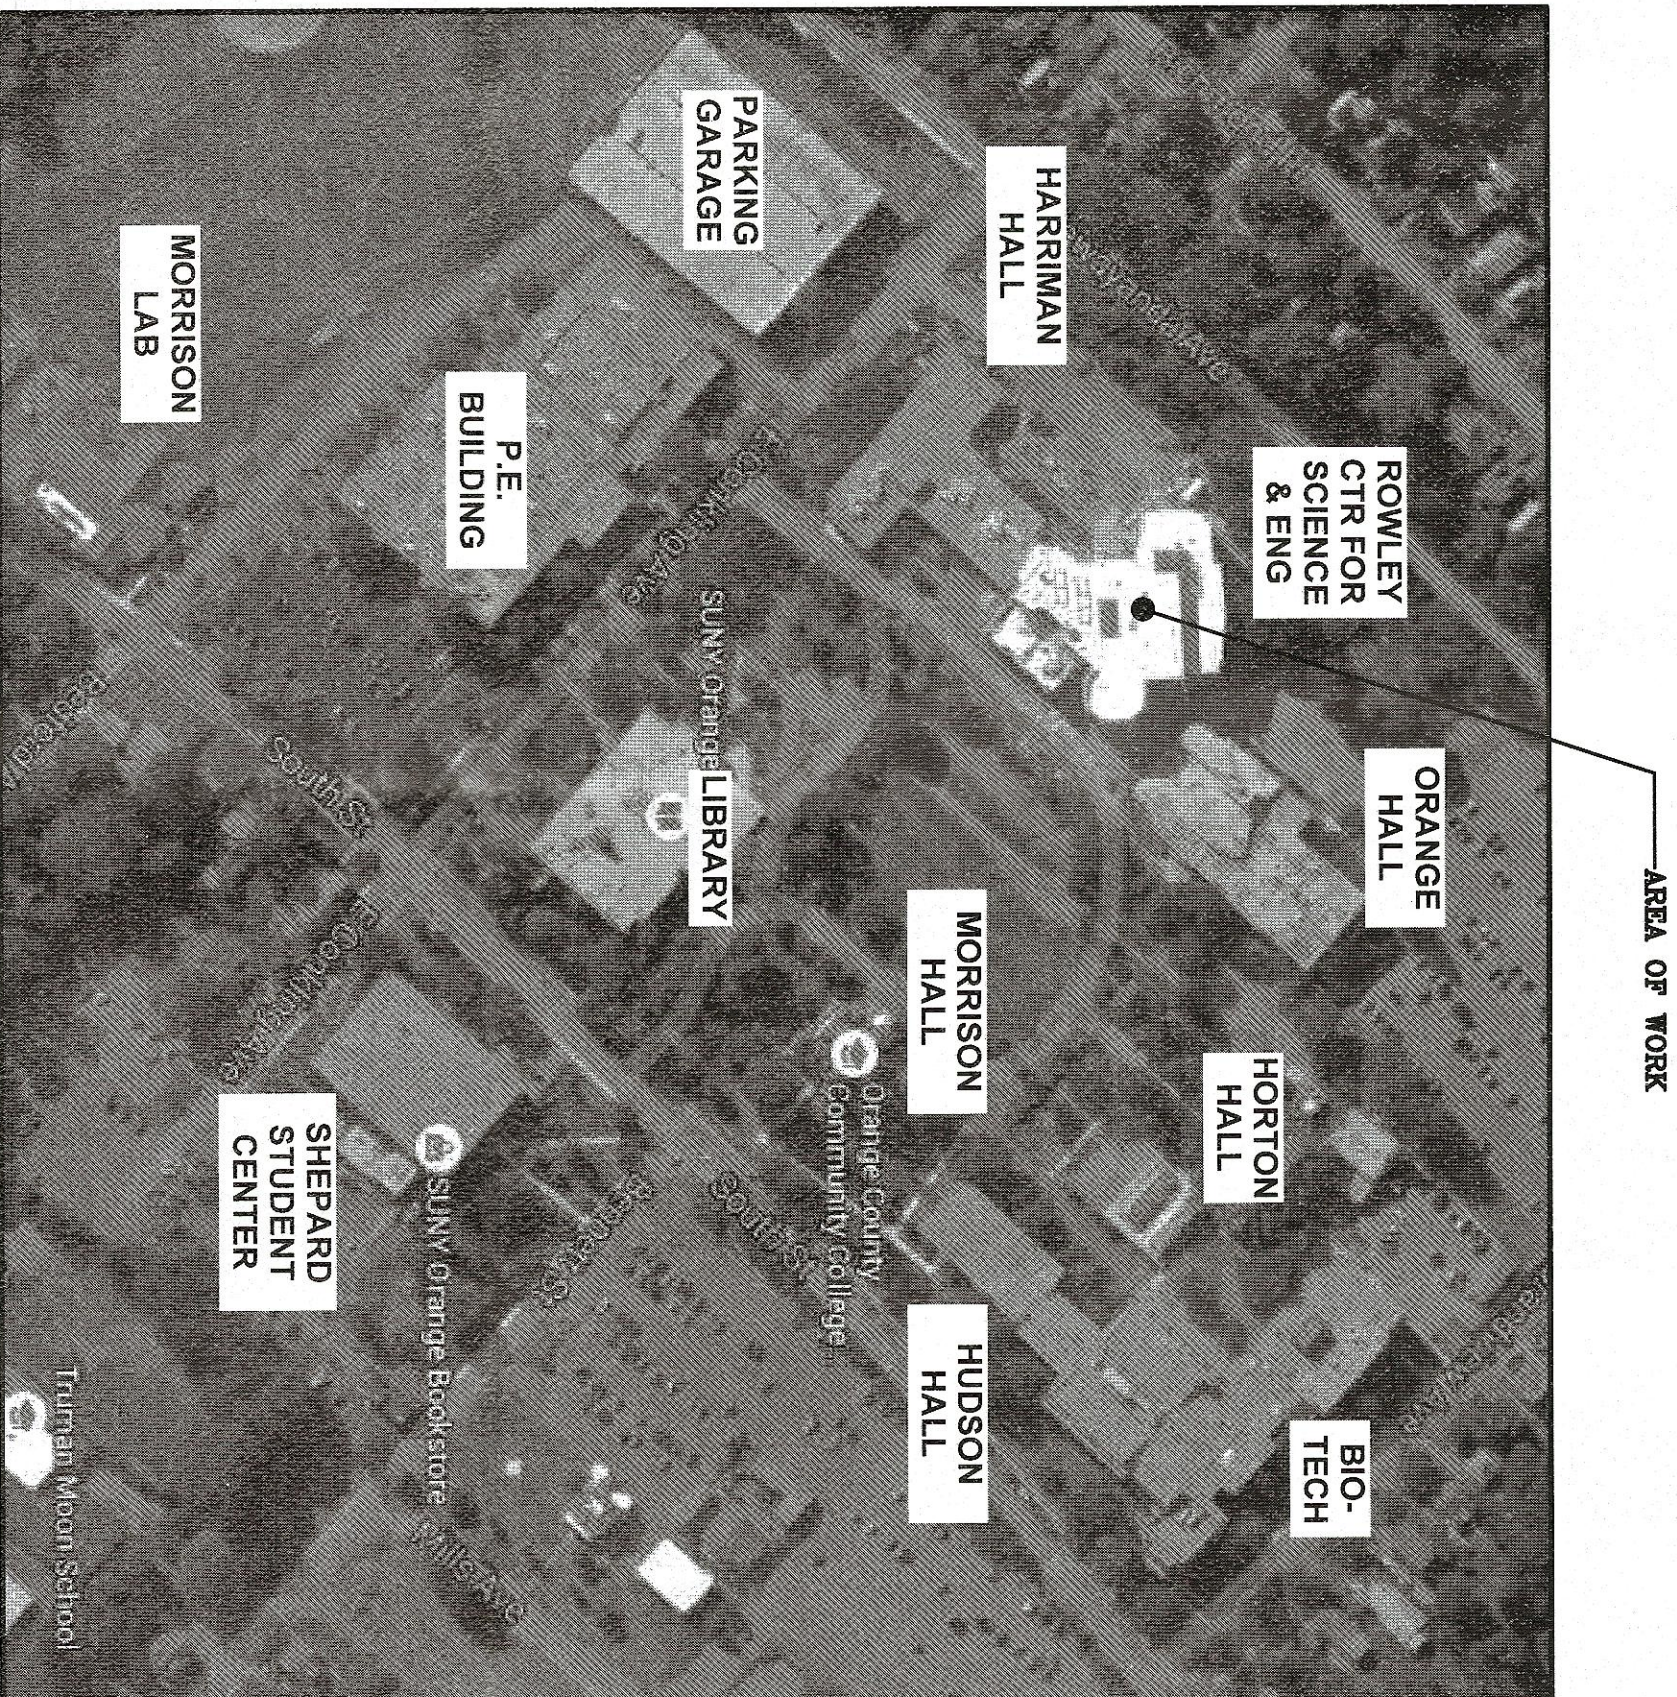

DRAWING LIST

PAGE	DWG. #	DRAWING TITLE
1	TS	TITLE SHEET
2	HE-001	STUDENTS, NOTES & ABBREVIATIONS
3	HE-101	MECHANICAL/ELECTRICAL GROUND FLOOR PLAN
4	HE-701	EQUIPMENT & PIPING DETAILS

REV #	DATE	REMARKS	ISSUE #	DATE	ISSUED FOR

 

UNAUTHORIZED ALTERATION OR ADDITION TO A PLAN BEARING A PROFESSIONAL ENGINEER'S SEAL VIOLATES NEW YORK STATE EDUCATION LAW, SECTION 2609, SUB DIVISION 2 OF THE N.Y. STATE EDUCATION LAW.

FELLENGER
ENGINEERING LLP

22 Mackery St., Suite 2A
Middletown, NY 10940
Tel: 845-343-1481 Fax: 845-343-4886

115 South St., Suite 110
Middletown, NY 10940
Tel: 845-454-9704 Fax: 855-320-8735

www.felle.com

SUNY ORANGE: ROWLEY CSE IT ROOM
ELECTRICAL & COOLING UPGRADE
115 SOUTH STREET, MIDDLETOWN, NY 10940

DRAWING TITLE			
DESIGNED BY	DRAWN BY	APPROVED BY	DATE
ELT	SPB	ELT	3/17/21
DATE	AS SHOWN	15-273	PAGE 1 OF 4