


6 THIRD FLOOR SHOWER/TOILET DEMOLITION PLAN (RM305)  
SCALE: 1/2" = 1'-0"



7 THIRD FLOOR SHOWER/TOILET DEMOLITION PLAN (RM303)  
SCALE: 1/2" = 1'-0"

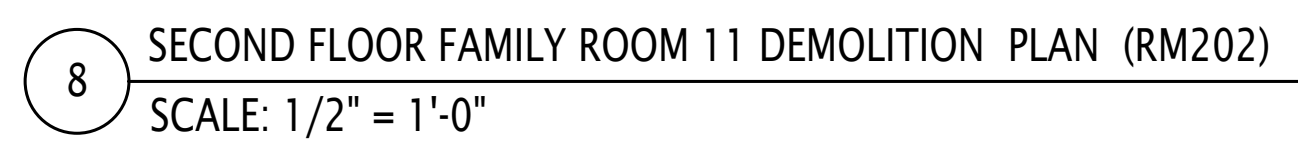

8 SECOND FLOOR FAMILY ROOM 11 DEMOLITION PLAN (RM202)  
SCALE: 1/2" = 1'-0"



9 SECOND FLOOR FAMILY ROOM 10 DEMOLITION PLAN (RM206)  
SCALE: 1/2" = 1'-0"

**TYPICAL AT WINDOWS: REFER TO ADD ALTERNATE NO. C-2.3 AND 3. SEE PROJECT MANUAL SECTION 012300 FOR DESCRIPTION**

- REFER TO PLUMBING, MECHANICAL, ELECTRICAL DRAWINGS FOR M/E/P REMOVALS

D11 – REMOVE EXISTING PLUMBING FIXTURES AND EXPOSED PIPING BY PLUMBING CONTRACTOR.

D12 – REMOVE RAISED PLATFORM AND FRAMING INCLUDING STAIR TREADS

D13 – REMOVE FLOOR FINISH AND FLOORING SUBSTRATES TO EXISTING SLAB. CLEAN SLAB OF RESIDUE AND OTHER MATERIAL FOR NEW FINISH. SEE ALSO HAZMAT DWGS FOR REMOVAL AND ABATEMENT OF A.C.M.

D14 – REMOVE EXISTING DOOR, HARDWARE AND FRAME IN ITS ENTIRETY.

D15 – REMOVE EXISTING WALL FINISH TO INCLUDE, BUT NOT LIMITED TO CERAMIC TILE, PLASTIC WALL PANELS, ADHESIVES, ETC.

D16 – REMOVE EXISTING PLASTIC LAMINATE BASE CABINET AND COUNTER WHERE APPLICABLE

D17 – REMOVE EXISTING TOILET AND SHOWER PARTITIONS AND ASSOCIATED FRAMING AND MOUNTING BRACKETS/SUPPORTS

D18 – REMOVE EXISTING WALL/PARTITION TO UNDERSIDE OF SLAB ABOVE.

D19 – REMOVE EXISTING DRAPES, BLINDS AND ASSOCIATED MOUNTING HARDWARE

D20 – REMOVE EXISTING SHOWER HEAD CONTROLS AND SHOWER DRAIN BY PLUMBING CONTRACTOR

D21 – REMOVE EXISTING TOILET ACCESSORIES TO INCLUDE BUT NOT LIMITED TO MIRRORS, GRAB BARS, SOAP DISPENSER, SHOWER RODS AND CURTAINS, TISSUE AND TOILET PAPER DISPENSERS, BABY CHANGING UTENS.


D22 – REMOVE EXISTING WALL FAN AND MOUNT PANEL ELECT DISCONNECT BY EC PROVIDE TEMPORARY INTILL WINDOW PANEL

D23 – REMOVE EXISTING PREFAB. SHOWER ENCLOSURE INCLUDING GYPSUM SOFFIT

D24 – REMOVE EXISTING SUSPENDED ACoustICAL CEILING TILE, GRID SYSTEM AND SUSPENSION SYSTEM.

D25 – REMOVE EXISTING METAL GRILLE

420 COLUMBUS AVENUE,  
VALHALLA, NY 10595

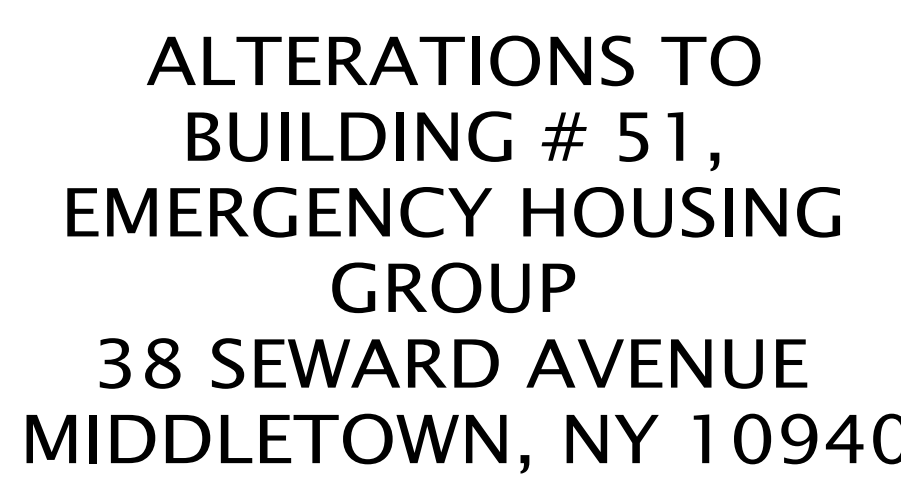[illegible]

DRAWING NO.

# A-700