



4 THIRD FLOOR DAY ROOM & MEN'S DORM POWER PLAN  
SCALE: 1/4" = 1'-0"

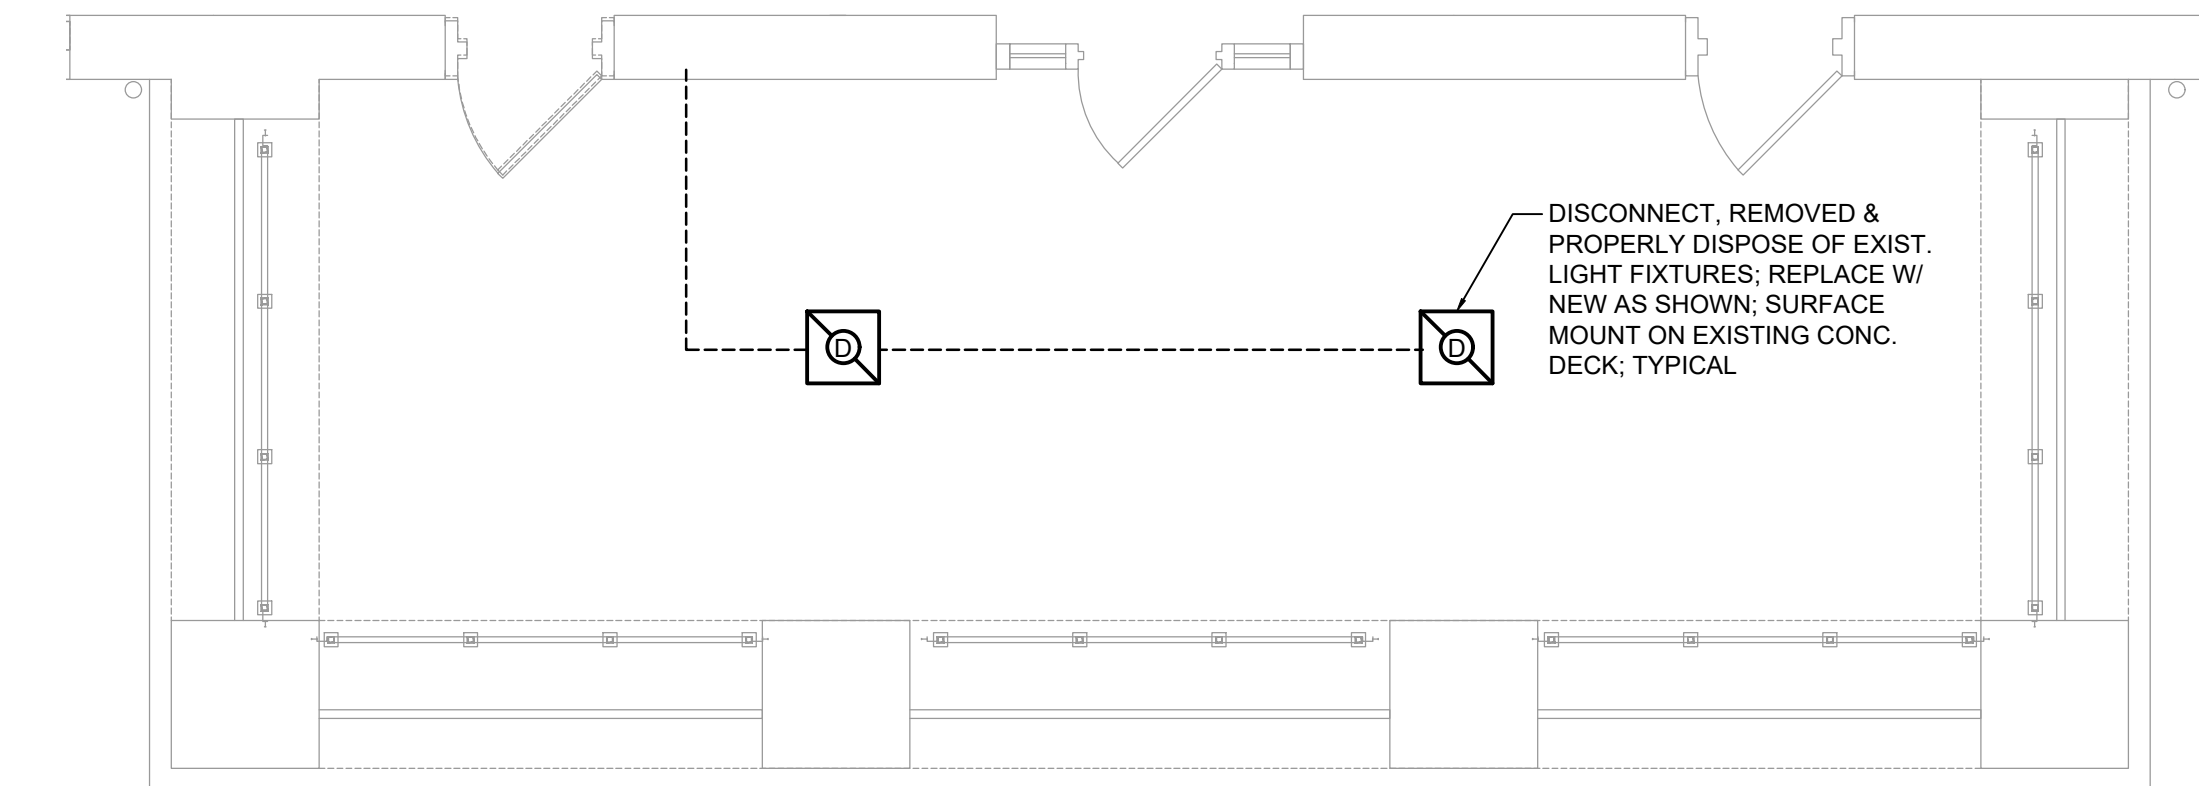

3 THIRD FLOOR PORTICO LIGHTING PLAN  
SCALE: 1/4" = 1'-0"

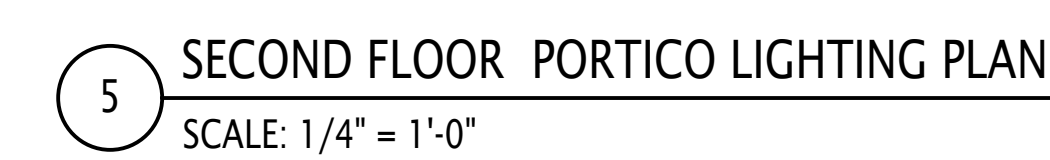

MATTHEW G. BLAKE, P.E., LEED AP  
NY - 89039 NJ - GE050037 PA - PE079303  
MA - 53197 CT - 32283 FL - 85928

1	03-19-2021	ISSUED FOR BID
ISSUE NO.	ISSUE DATE	DESCRIPTION



E-202