


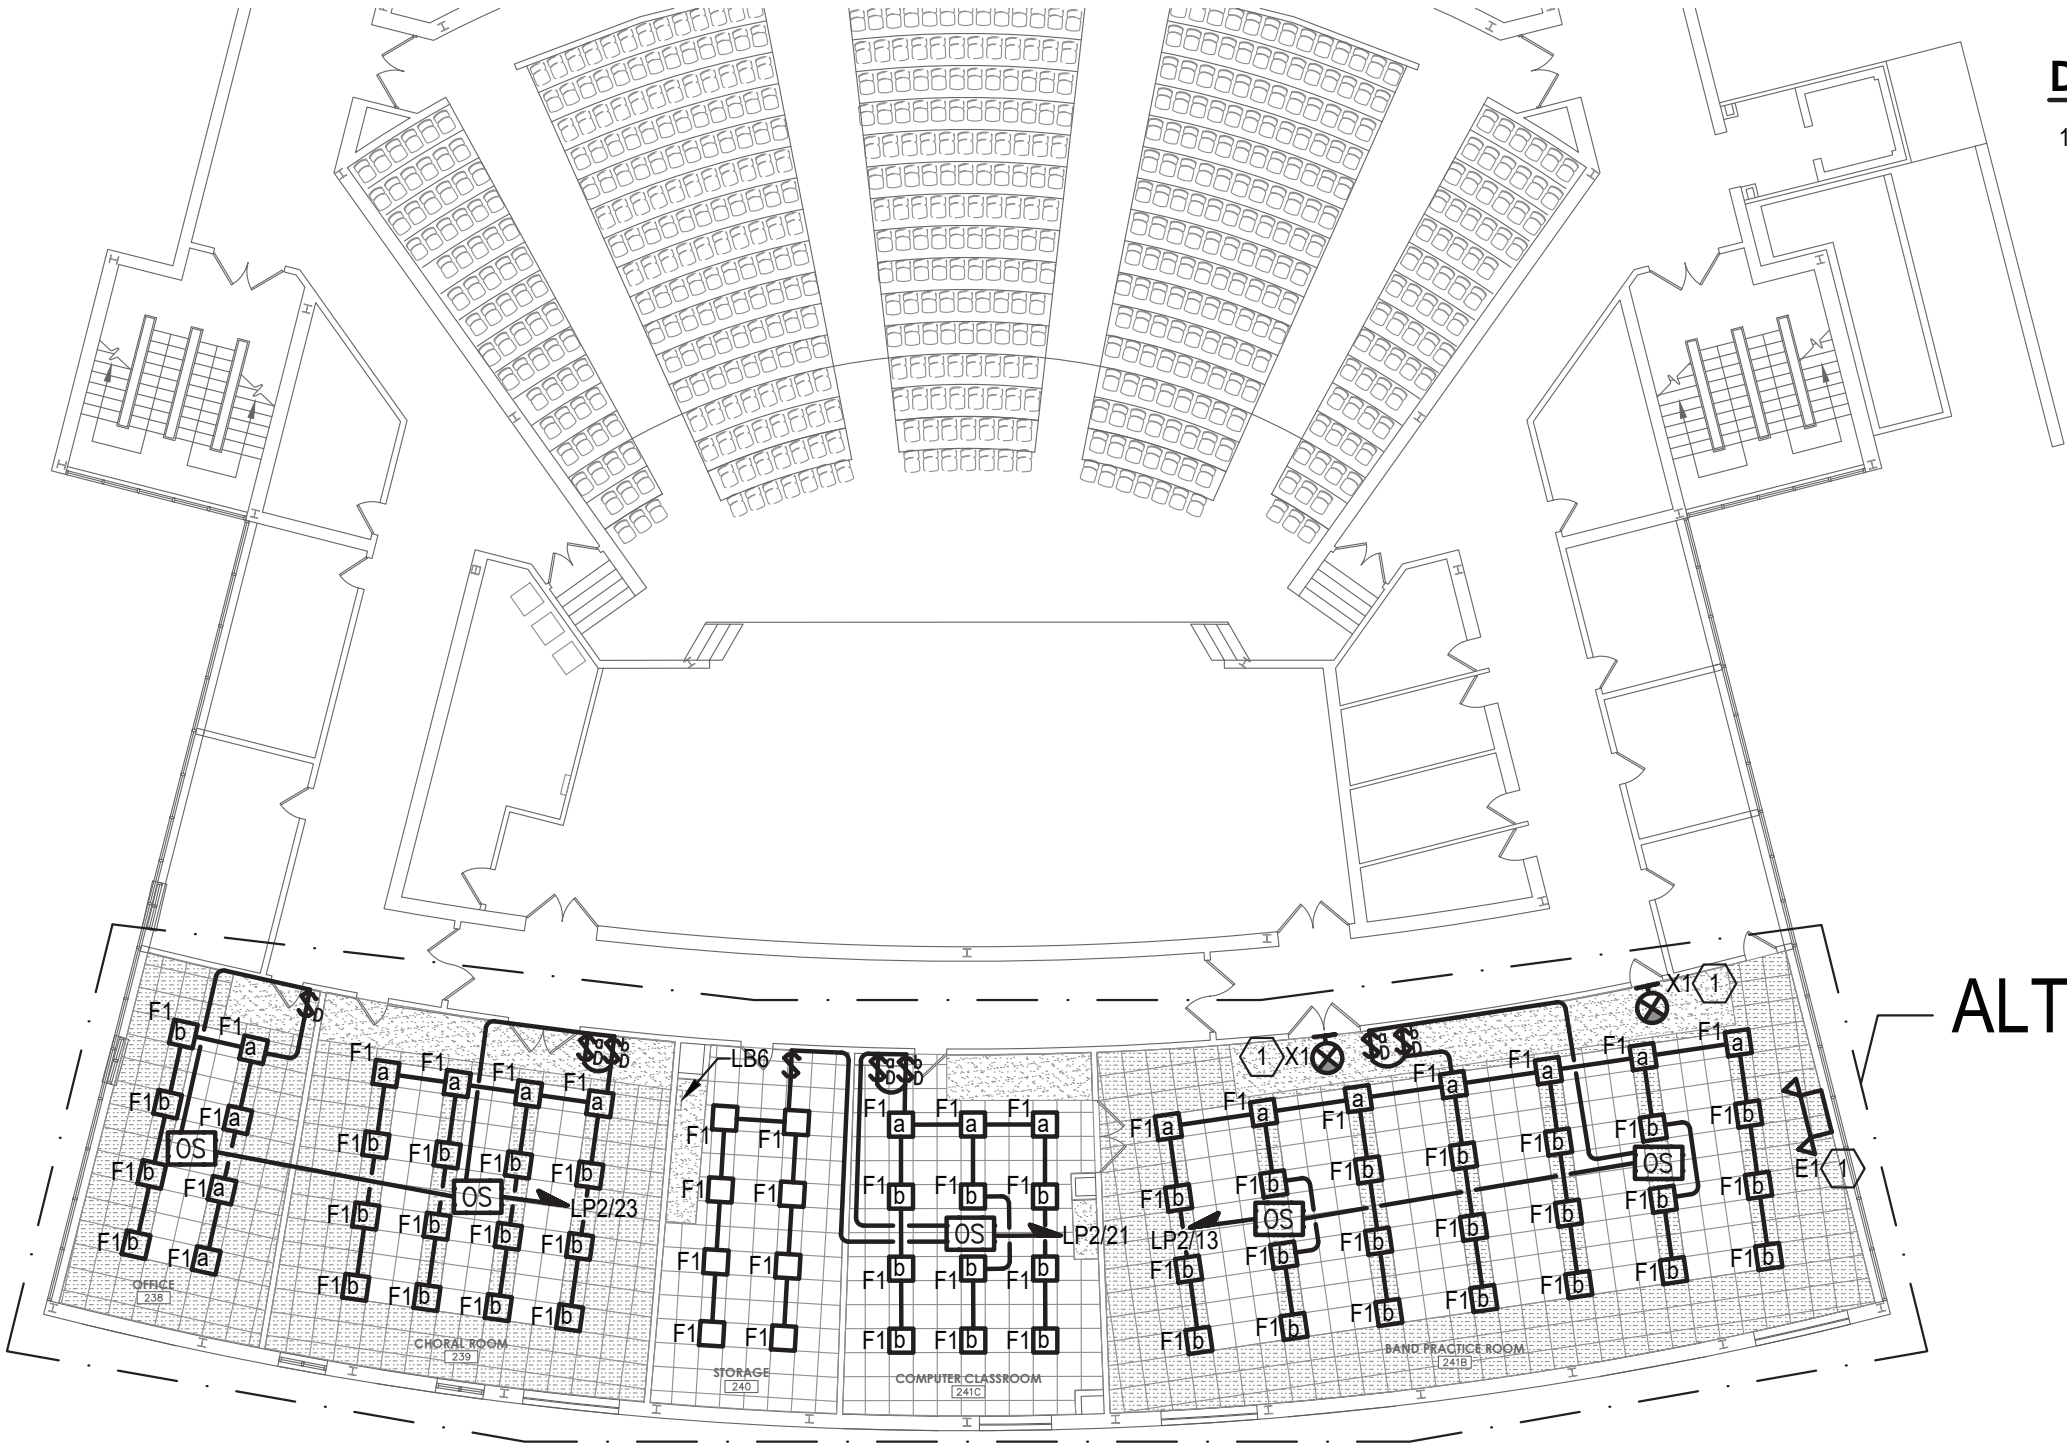

DRAWING NOTES:

1. CONNECT TO UN-SWITCHED LOCAL LIGHTING CIRCUIT.

ALTERNATE 4-E

1

INTERMEDIATE LEVEL - AREA A

SCALE: 1/16" = 1'-0"



S.E.D. NUMBER : █ PEEKSKILL HIGH SCHOOL: 66-15-00-01-0-010-022 █ HILLCREST ELEMENTARY: 66-15-00-01-0-004-016 █ URIAH HILL ELEMENTARY: 66-15-00-01-0-007-015
BEFORE WORK IS STARTED, CONTRACTOR SHALL VERIFY ALL THE DIMENSIONS AT THE SITE AND IMMEDIATELY NOTIFY THE ARCHITECT OF ALL DISCREPANCIES.
ALTERATION OF THIS DOCUMENT BY OTHER THAN AN AUTHORIZED LICENSED REGISTERED ARCHITECT IS ILLEGAL AND A VIOLATION OF SECTION 7307 OF THE NEW YORK STATE EDUCATION LAW.

Drawing Title :

INTERMEDIATE LEVEL
LIGHTING PLAN - AREA A

HIGH SCHOOL

APN : 1901.2 | Date : 02/16/2021

Dwn by : SDK

**Alterations to School District Facilities
Phase Two**

Peekskill City School District
Peekskill, New York



Mosaic Associates Architects
The Pinar Building, 2 Third Street, Suite 440, Troy, NY 12180

**SK
E01**