



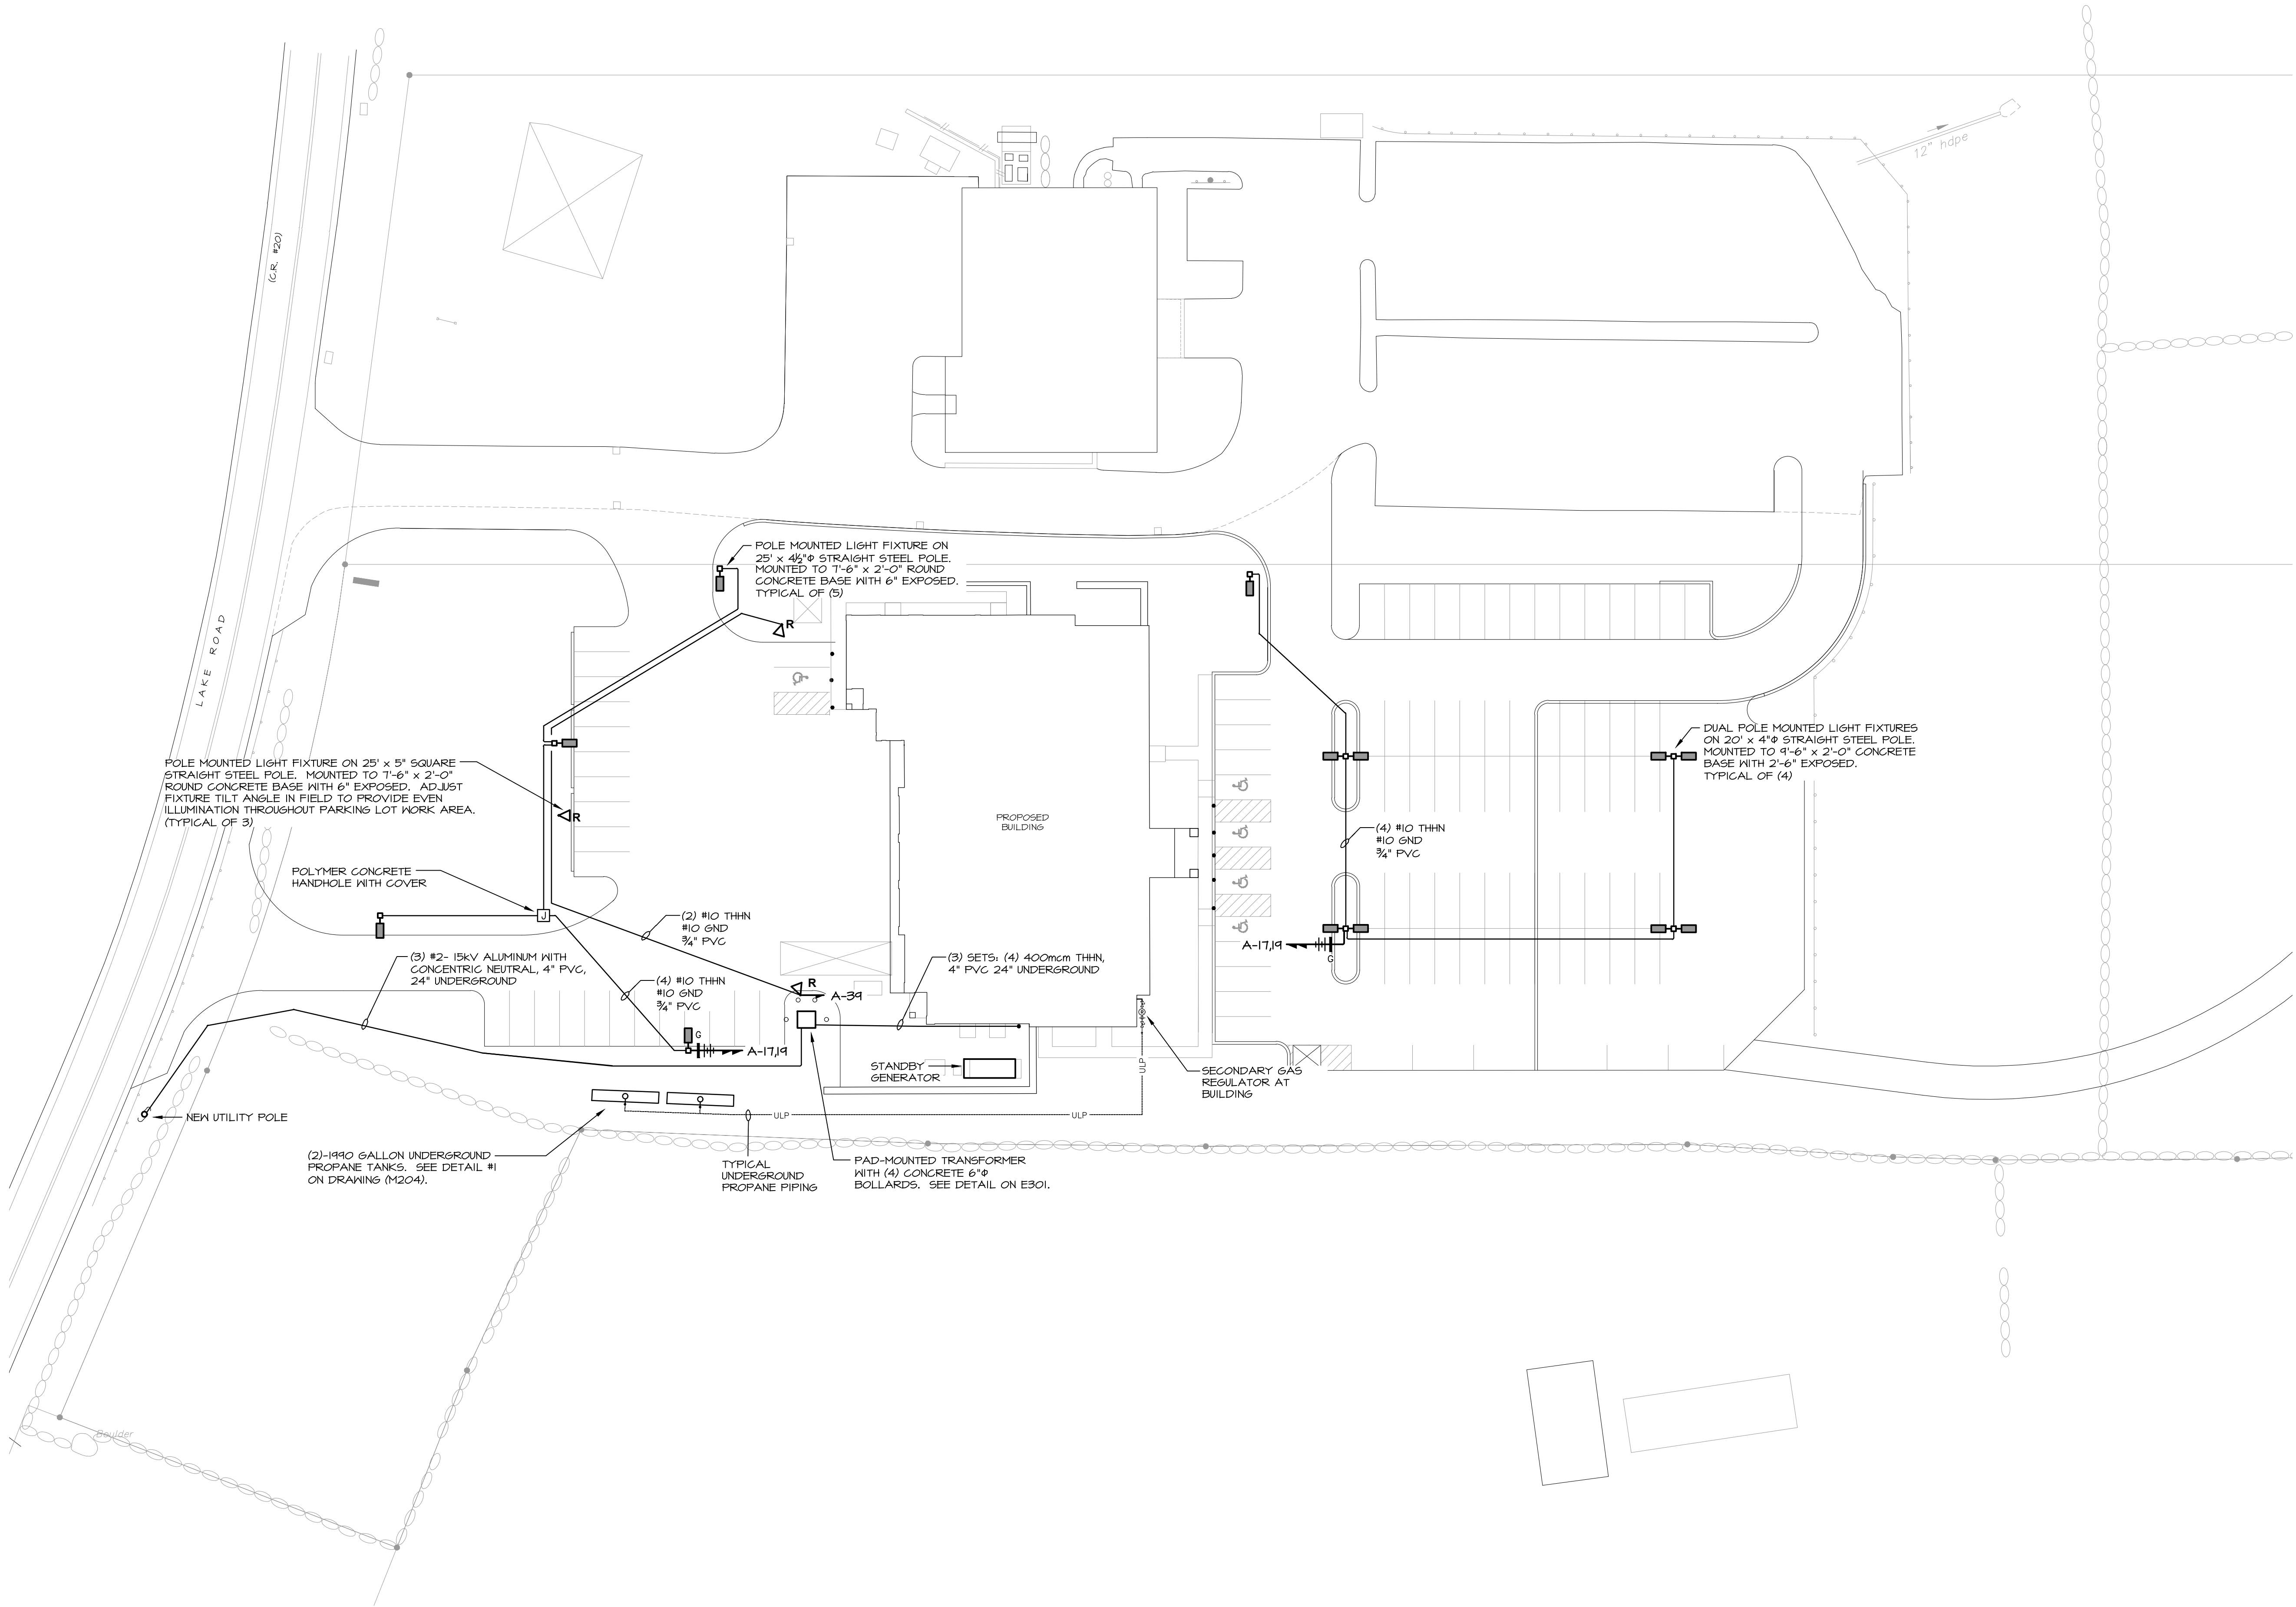

1 SITE PLAN
MEP SCALE: 1" = 30'-0"

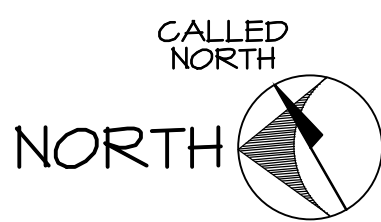

MA

MITCHELL ASSOCIATES ARCHITECTS

29 THACHER PARK ROAD
VOORHEESVILLE, NY 12186
(518) 765-4511 FAX (518) 765-2450
WWW.MITCHELL-ARCHITECTS.COM

EMERGENCY SERVICE

FACILITIES

CONSULTANTS:
INSITE ENGINEERING SURVEYING
& LANDSCAPE ARCHITECTURE, P.C.
3 GARRET PLACE
CARMEL, NY 10512
(845) 225-9690 FAX: (845) 225-9717

CRAIG A. MALONEY P.E.
STRUCTURAL ENGINEERING CONSULTANT
3 BENEDICT COURT
BALLSTON SPA, NY 12020
(518) 584-9844 FAX: (518) 584-9855

GERARD ASSOCIATES
CONSULTING ENGINEERS, P.C.
MECHANICAL, PLUMBING
AND ELECTRICAL
223 MAIN STREET
GOSHEN, NY 10924
(845) 241-1272
GARD011

COPYRIGHT 2012
MITCHELL ASSOCIATES ARCHITECTS
UNAUTHORIZED ALTERATION OR ADDITION
TO THIS DOCUMENT IS A VIOLATION OF LAW

NEW STATION FOR PUTNAM VALLEY FIRE STATION #1

OSCAWANA LAKE ROAD
PUTNAM VALLEY, NEW YORK

REVISION HISTORY		
	DATE	DESCRIPTION
△		
△		
△		
△		
△		
△		
△		

MEP: SITE PLAN

SCALE: AS NOTED
DWS. BY: KC
DWS. DATE: 8/14/2020
STATUS: BID DRAWINGS

MEP I