
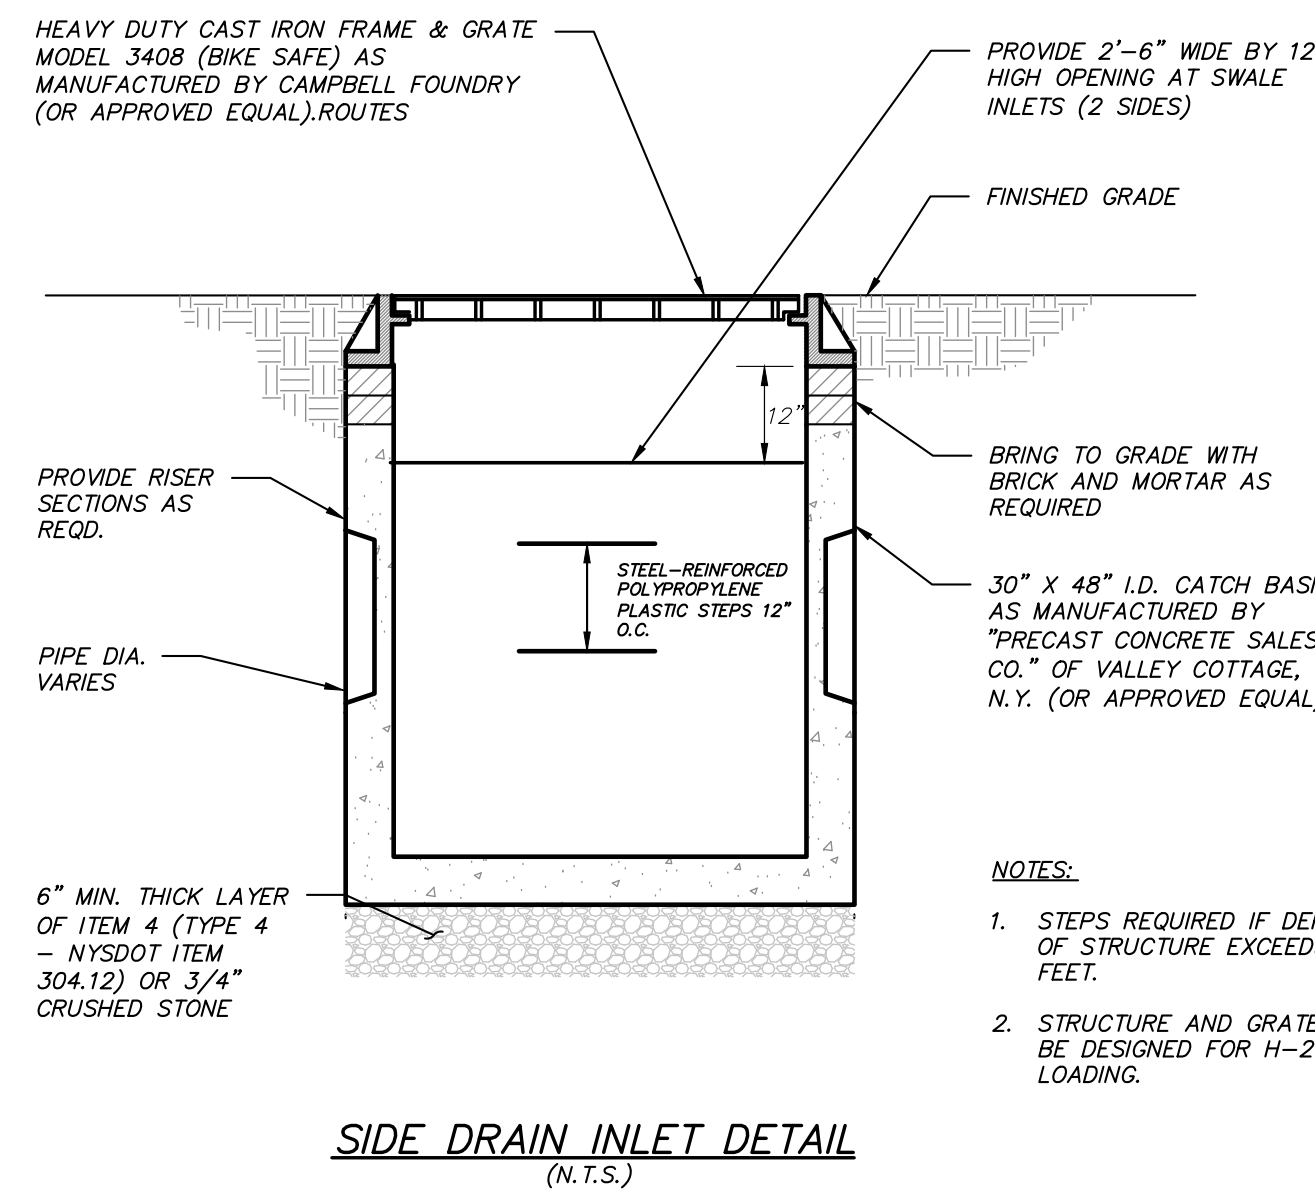
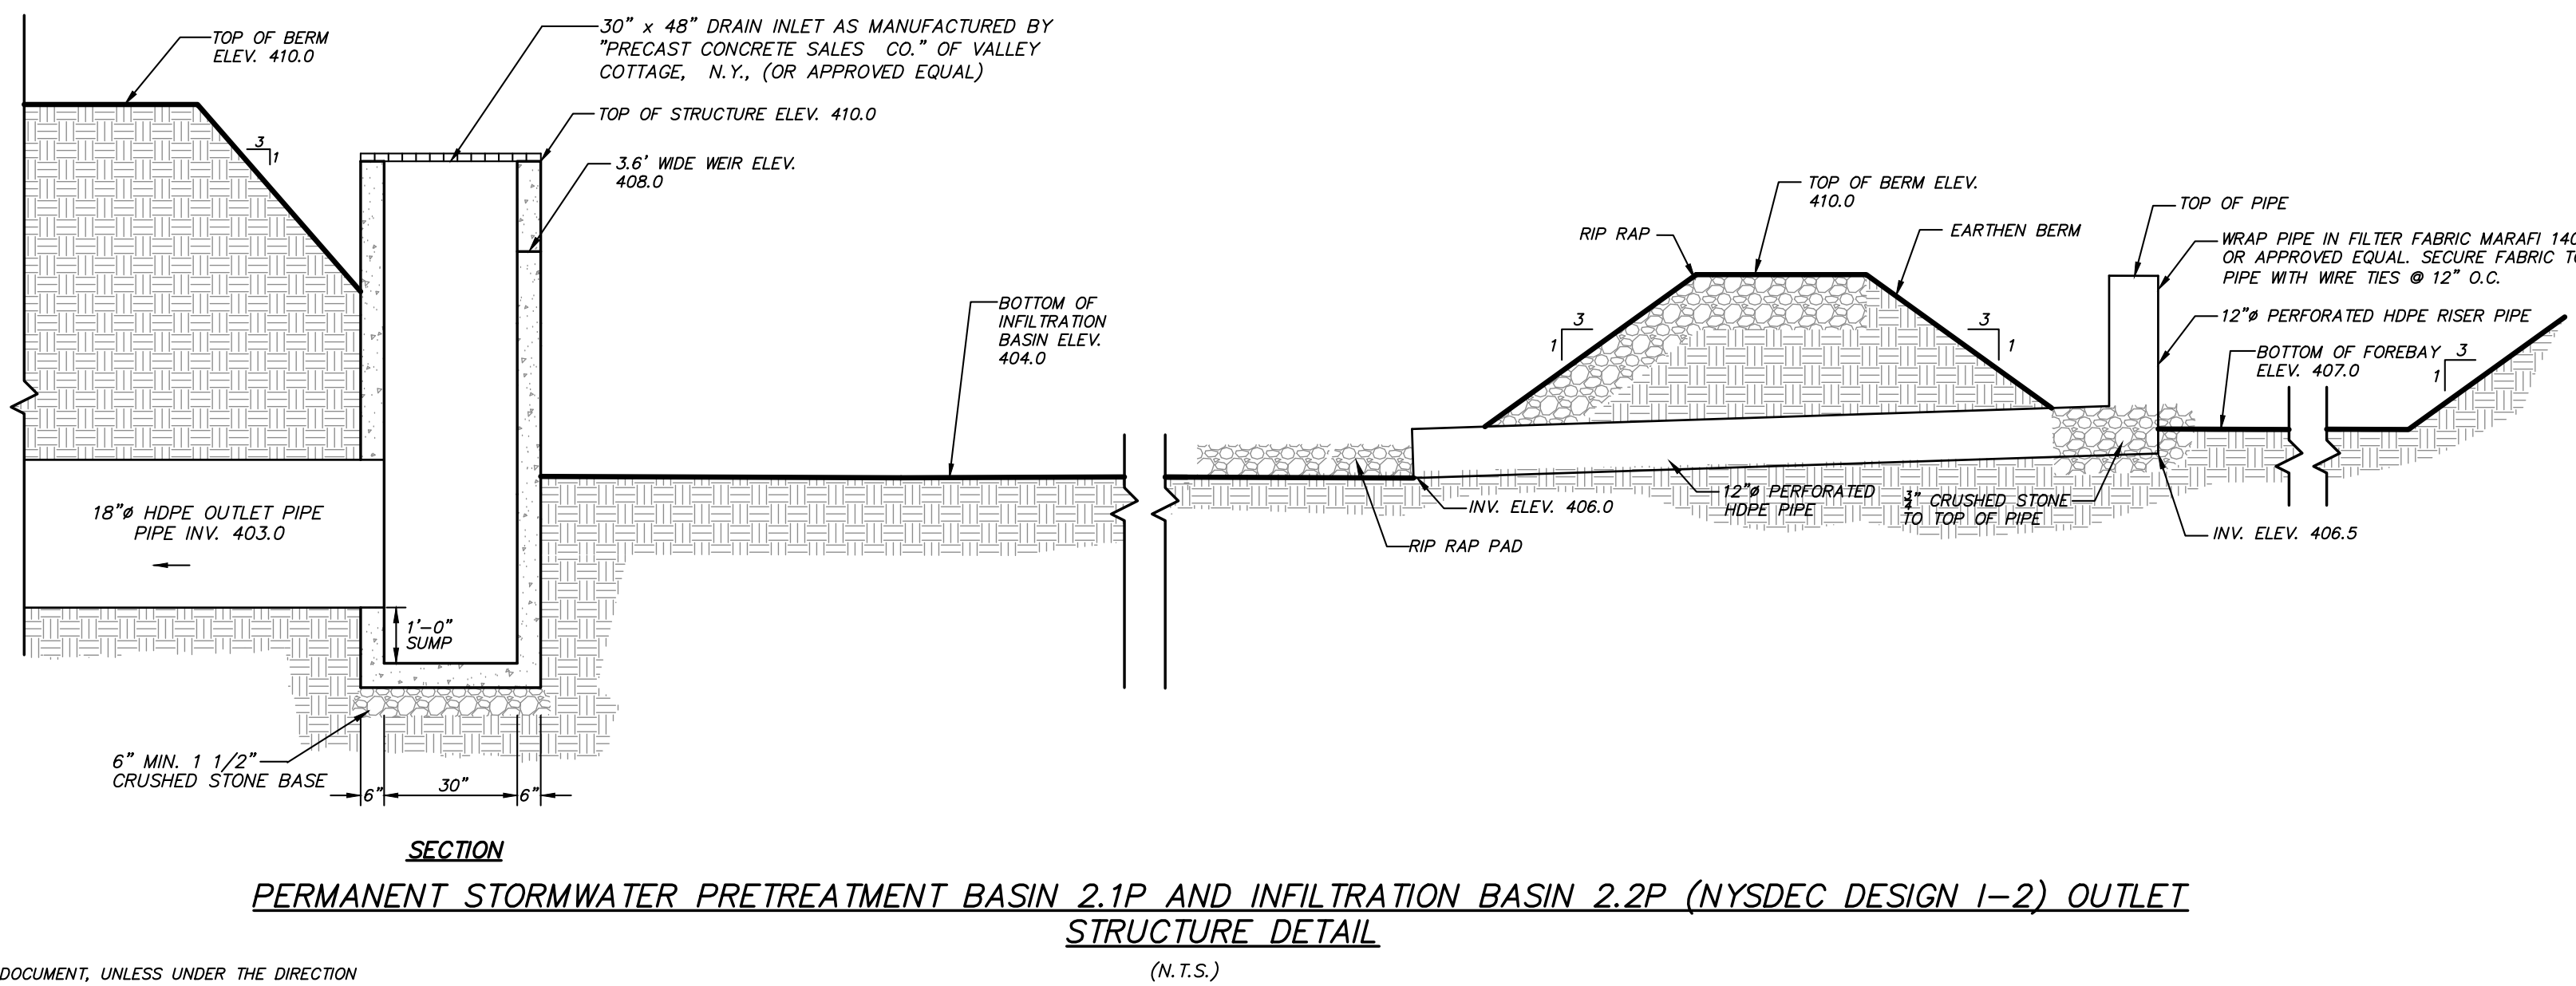
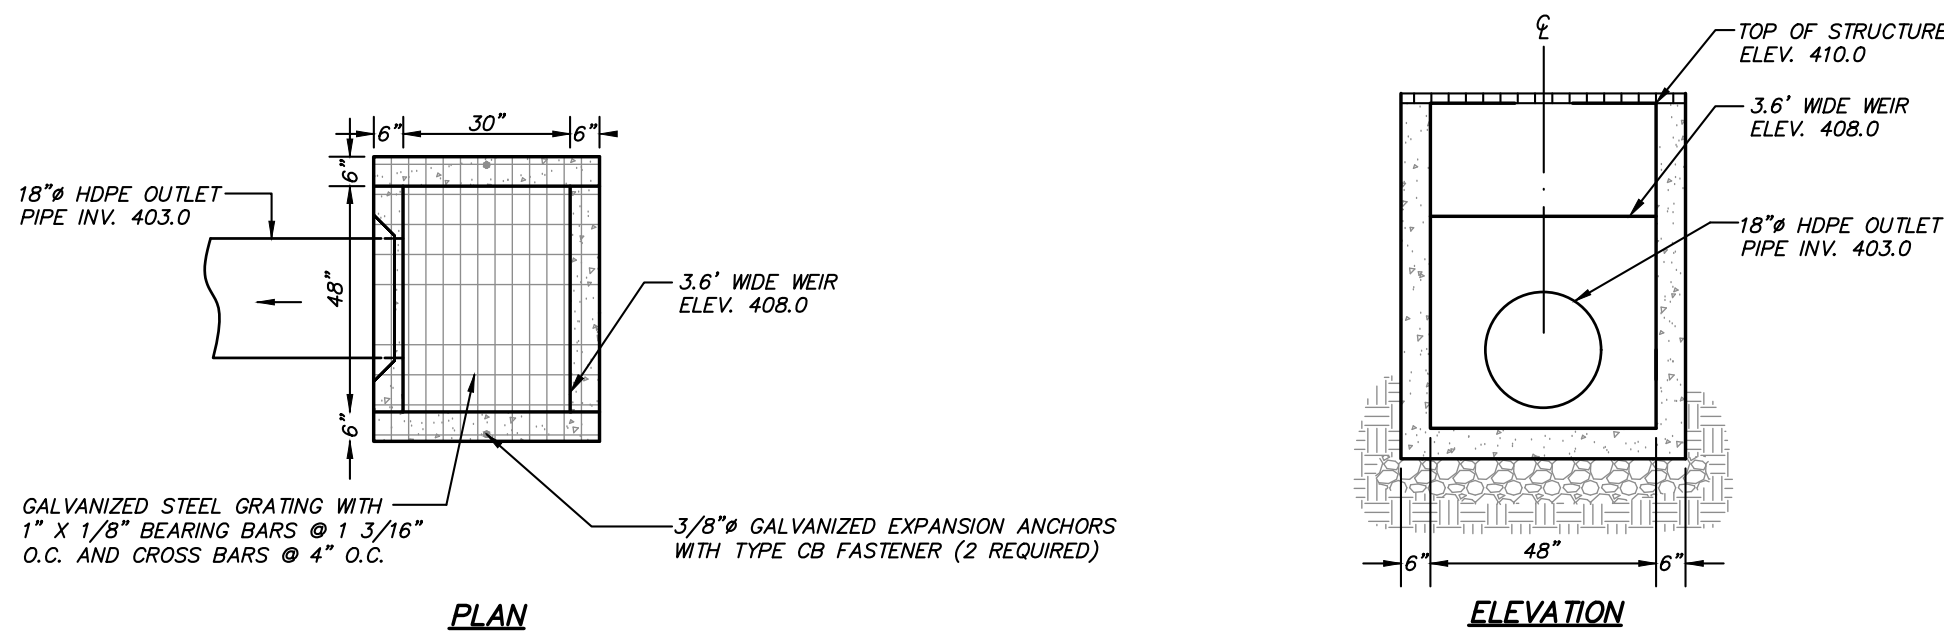
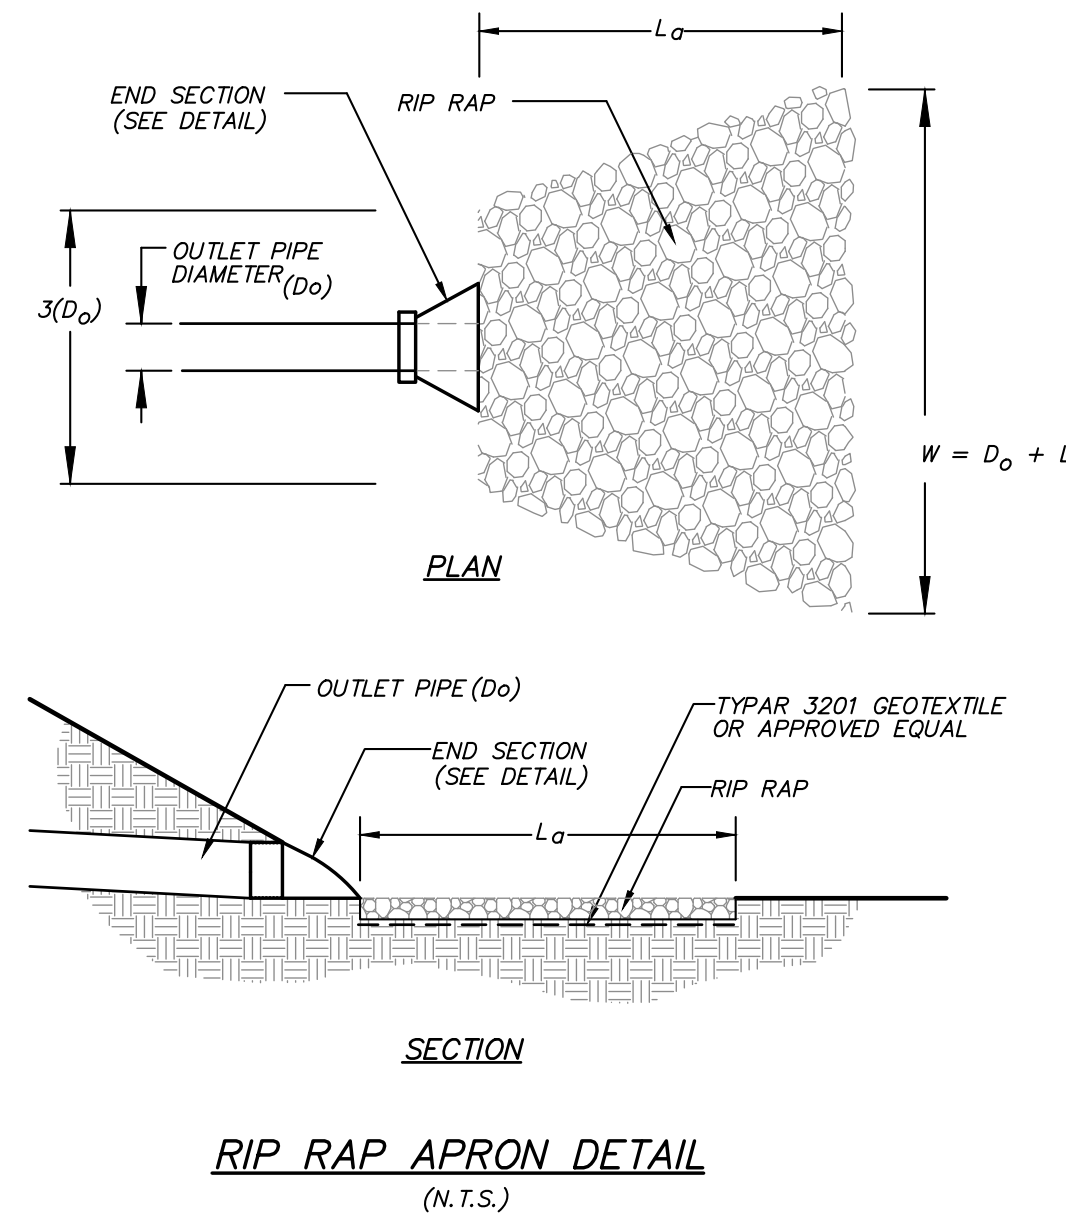



END SECTION/HEADWALL	OUTLET PIPE DIAMETER (D _o)	(D ₉₀) RIP RAP SIZE	MAX. RIP RAP SIZE	MIN. RIPRAP BLANKET THICKNESS	LA (MIN.)
ES 2	12"	6"	9"	14"	8 FT.
ES 5	15"	6"	9"	14"	10 FT.
ES 6	15"	6"	9"	14"	10 FT.
ES 10	12"	6"	9"	14"	14 FT.
ES 13	18"	9"	14"	20"	14 FT.
ES 15	18"	9"	14"	20"	14 FT.

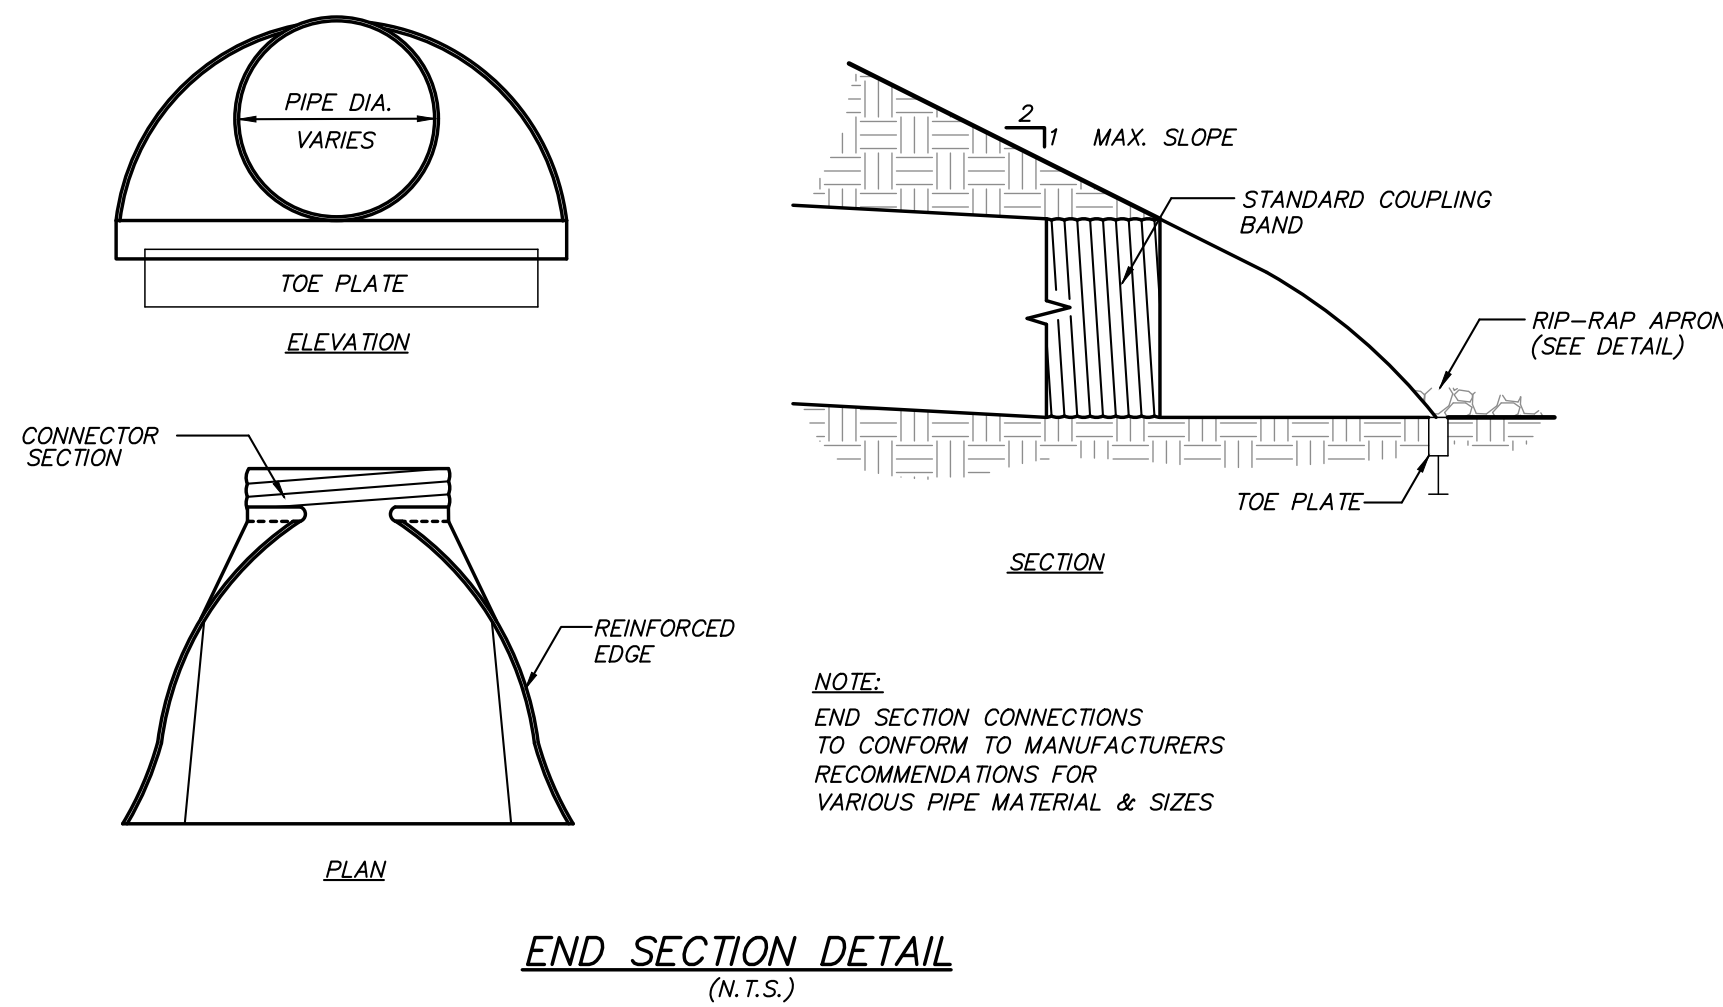

11	1-27-21	REVISED PER PCDHF COMMENTS	MEU
10	12-7-20	REVISED PER TOWN & PCDHF COMMENTS	JWM
9	8-13-20	ISSUED FOR BID	JWM
8	2-18-20	REVISED PER TOWN COMMENTS	GM
7	1-21-20	REVISED PER TOWN COMMENTS	GM
6	1-8-20	REVISED FOR ZBA SUBMISSION	GM
5	11-6-19	REVISED FOR ZBA SUBMISSION	GM
4	9-13-19	REVISED PER TOWN COMMENTS	MEU
3	07-29-19	REVISED FOR PLANNING BOARD SUBMISSION	KAM
2	02-24-17	REVISED FOR COORDINATED REVIEW	SJC
1	11-30-16	REVISED FOR TEAM REVIEW	MEU
NO.	DATE	REVISION	BY

**INSITE**
ENGINEERING, SURVEYING &
LANDSCAPE ARCHITECTURE, P.C.

3 Garrett Place
Carmel, NY 10512
(845) 225-9690
(845) 225-9717 fax
www.insite-eng.com

PROJECT:
**PUTNAM VALLEY FIRE STATION #1
AND AMENDED SITE PLAN FOR
PUTNAM VALLEY AMBULANCE CORPS**
OSCANNA LAKE ROAD, TOWN OF PUTNAM VALLEY, COUNTY OF PUTNAM, NEW YORK

DRAWING:
SITE DETAILS

PROJECT NUMBER	09105.100	PROJECT MANAGER	J.J.C.	DRAWING NO.	SHEET
DATE	7-29-19	DRAWN BY	D.L.M.	D-2	7
SCALE	AS SHOWN	CHECKED BY	E.N.S.		

11