

29 THACHER PARK ROAD
VOORHEESVILLE, NY 12186
(518) 765-4571 FAX (518) 765-2950
WWW.MITCHELL-ARCHITECTS.COM

EMERGENCY
SERVICE

FACILITIES

CONSULTANTS:

INSITE ENGINEERING SURVEYING

LANDSCAPE ARCHITECTURE, P.C.
3 GARRETT PLACE
CARMEL, NY 10512
(845) 225-9690 FAX: (845) 225-9117

CRAIG A. MALONEY, P.E.

STRUCTURAL ENGINEERING CONSULTANT
3 BENEDICT COURT
BALLSTON SPA, NY 12020
(518) 584-9944 FAX: (518) 584-9955

GERARD ASSOCIATES

CONSULTING ENGINEERS, P.C.
MECHANICAL, PLUMBING,
AND ELECTRICAL
223 MAIN STREET
GOSHEN, N.Y. 10924
(845) 291-2372 FAX: (845) 291-9329

COPYRIGHT 2012

MITCHELL ASSOCIATES ARCHITECTS
UNAUTHORIZED ALTERATION OR ADDITION
TO THIS DOCUMENT IS A VIOLATION OF LAW

NEW STATION
FOR

PUTNAM VALLEY
FIRE STATION #1

OSCAWANA LAKE ROAD
PUTNAM VALLEY, NEW YORK


[illegible]

ROOF PLAN

SCALE: 1/8" = 1'-0"
DWG. BY: JDA
DWG. DATE: 8/14/2020
STATUS: BID DRAWINGS

A104

PLOT TIME: 11:09 AM

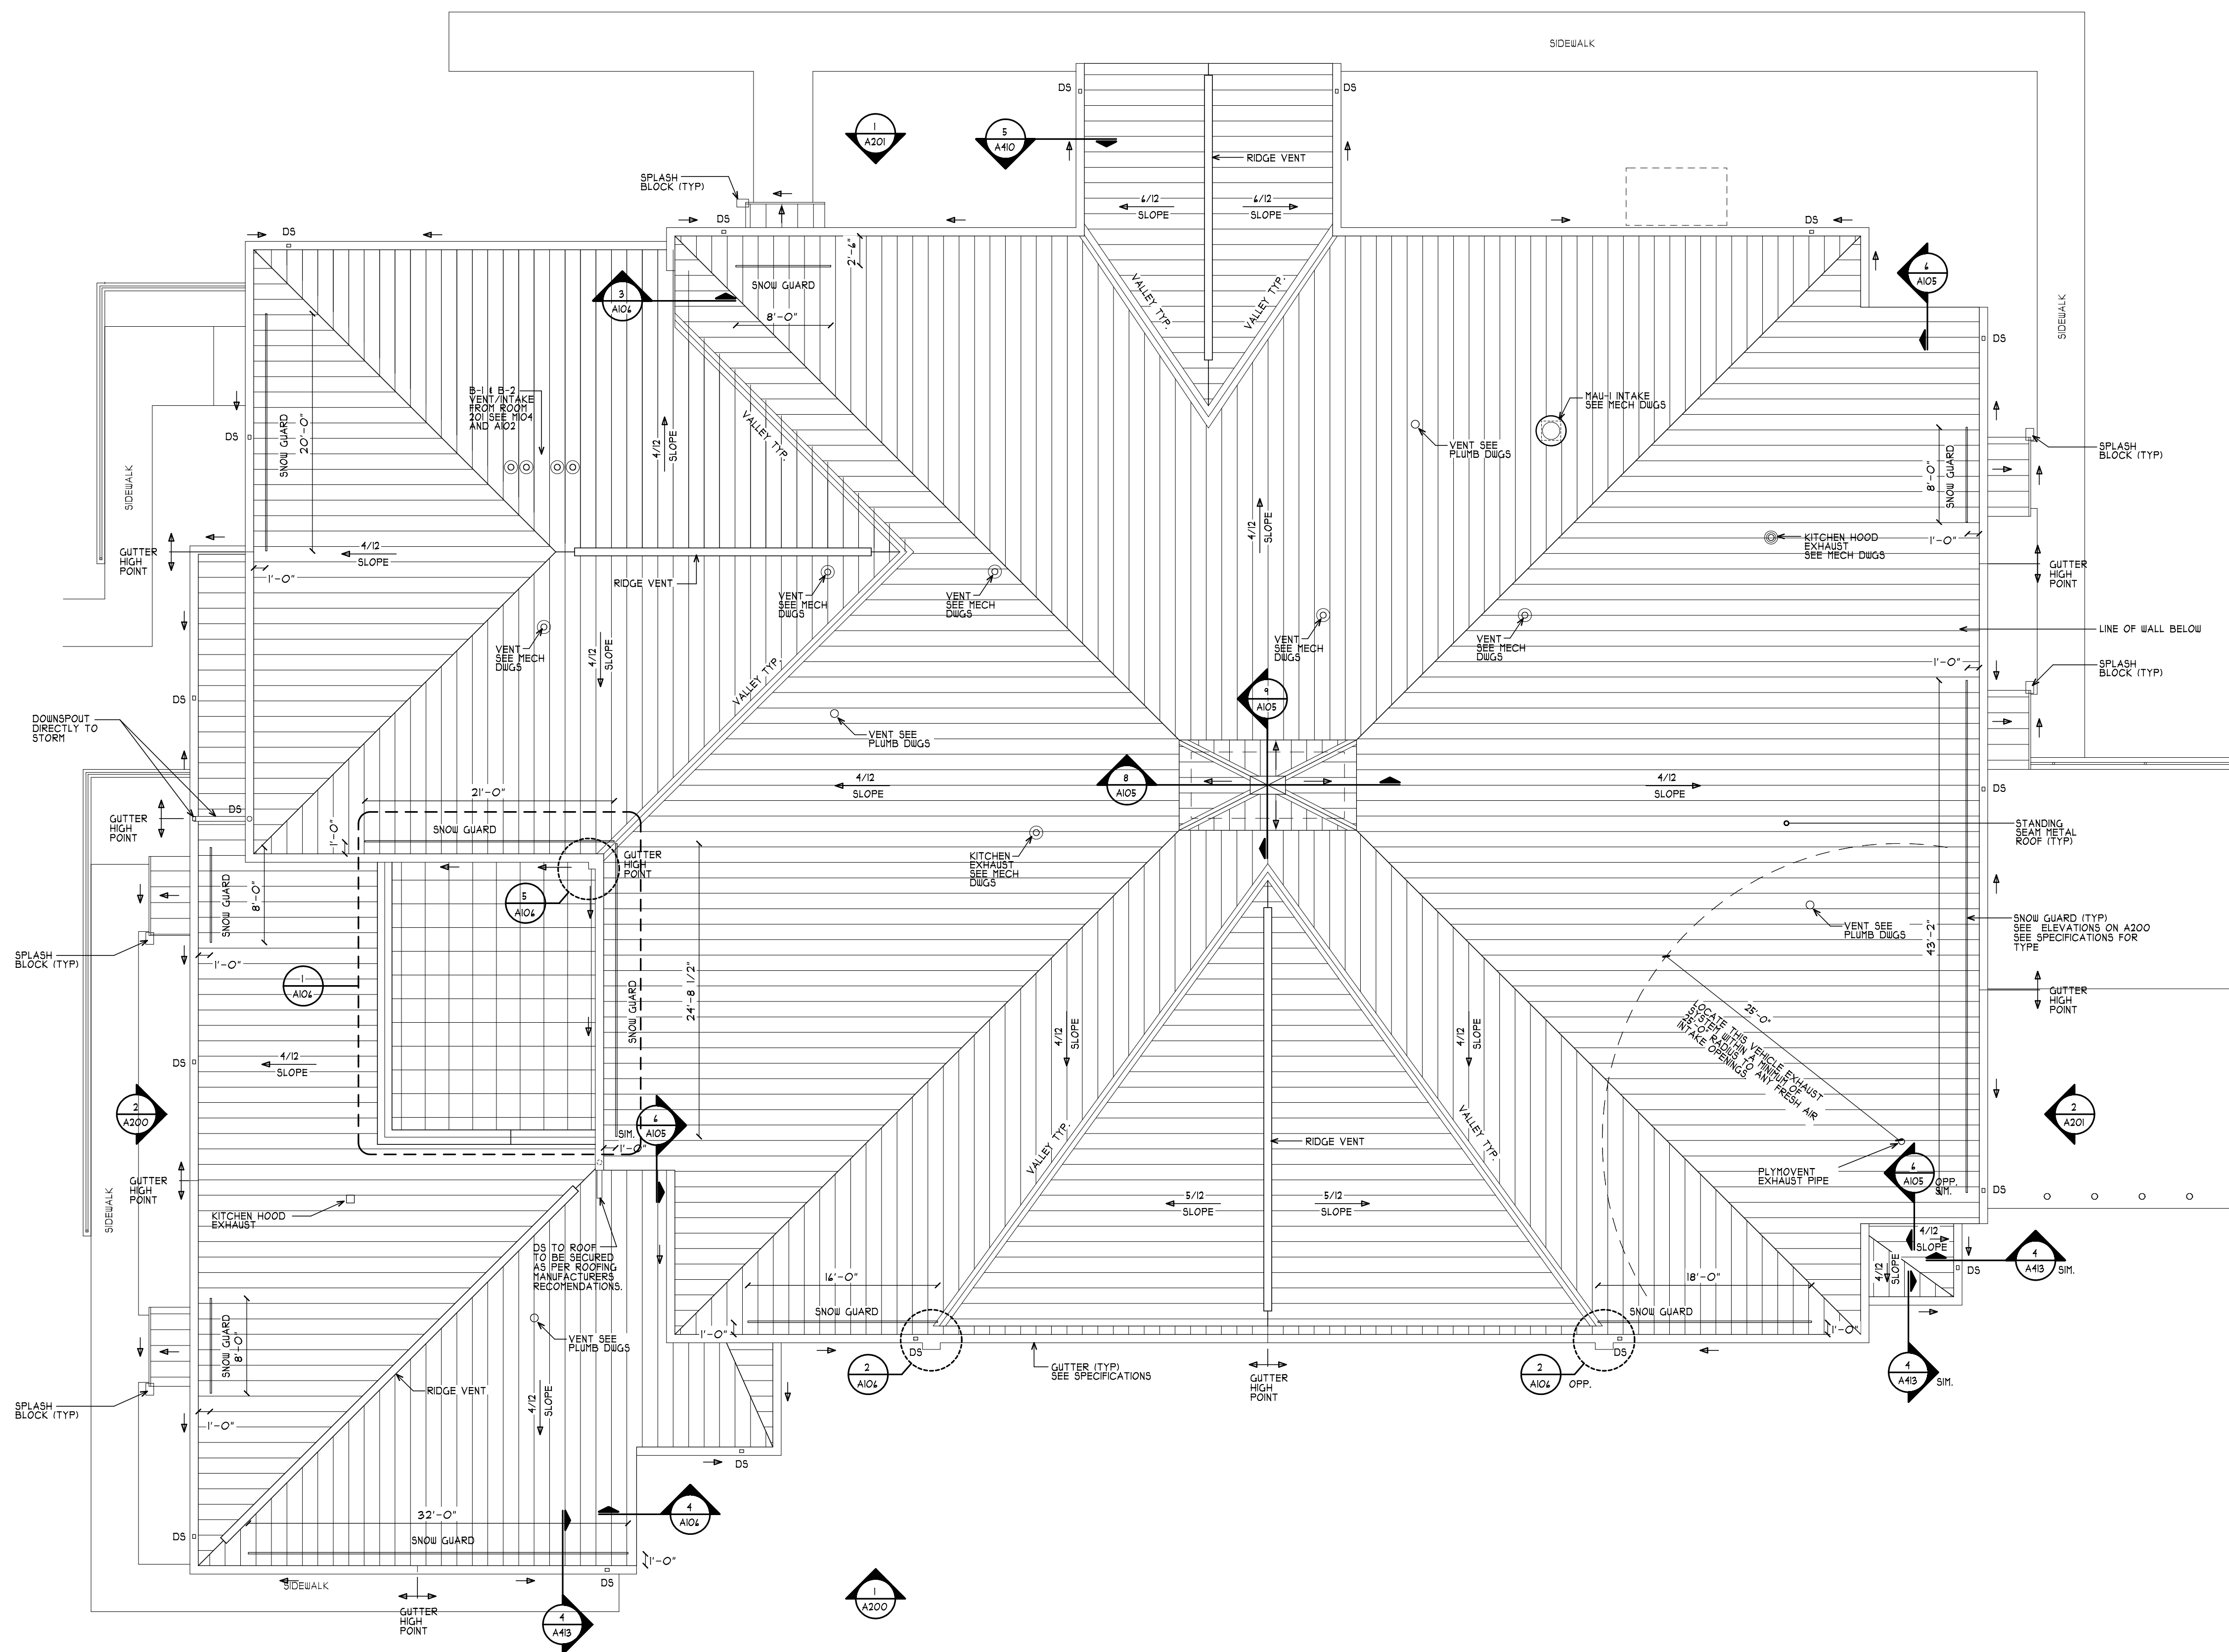

1 ROOF PLAN
A104 SCALE: 1/8" = 1'-0"

