



DWG ID#: S:\J Drive\Putnam Valley\NPV_A104


5 COLLECTION BOX DETAIL
A-106 SCALE: 1-1/2" = 1'-0"

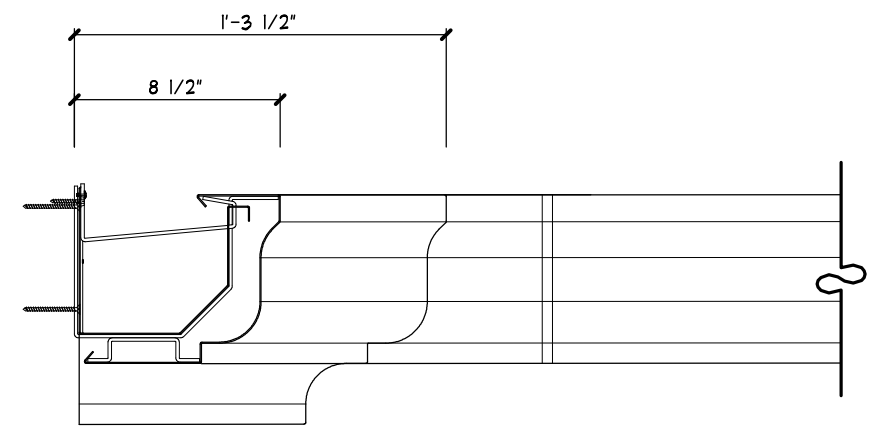


A

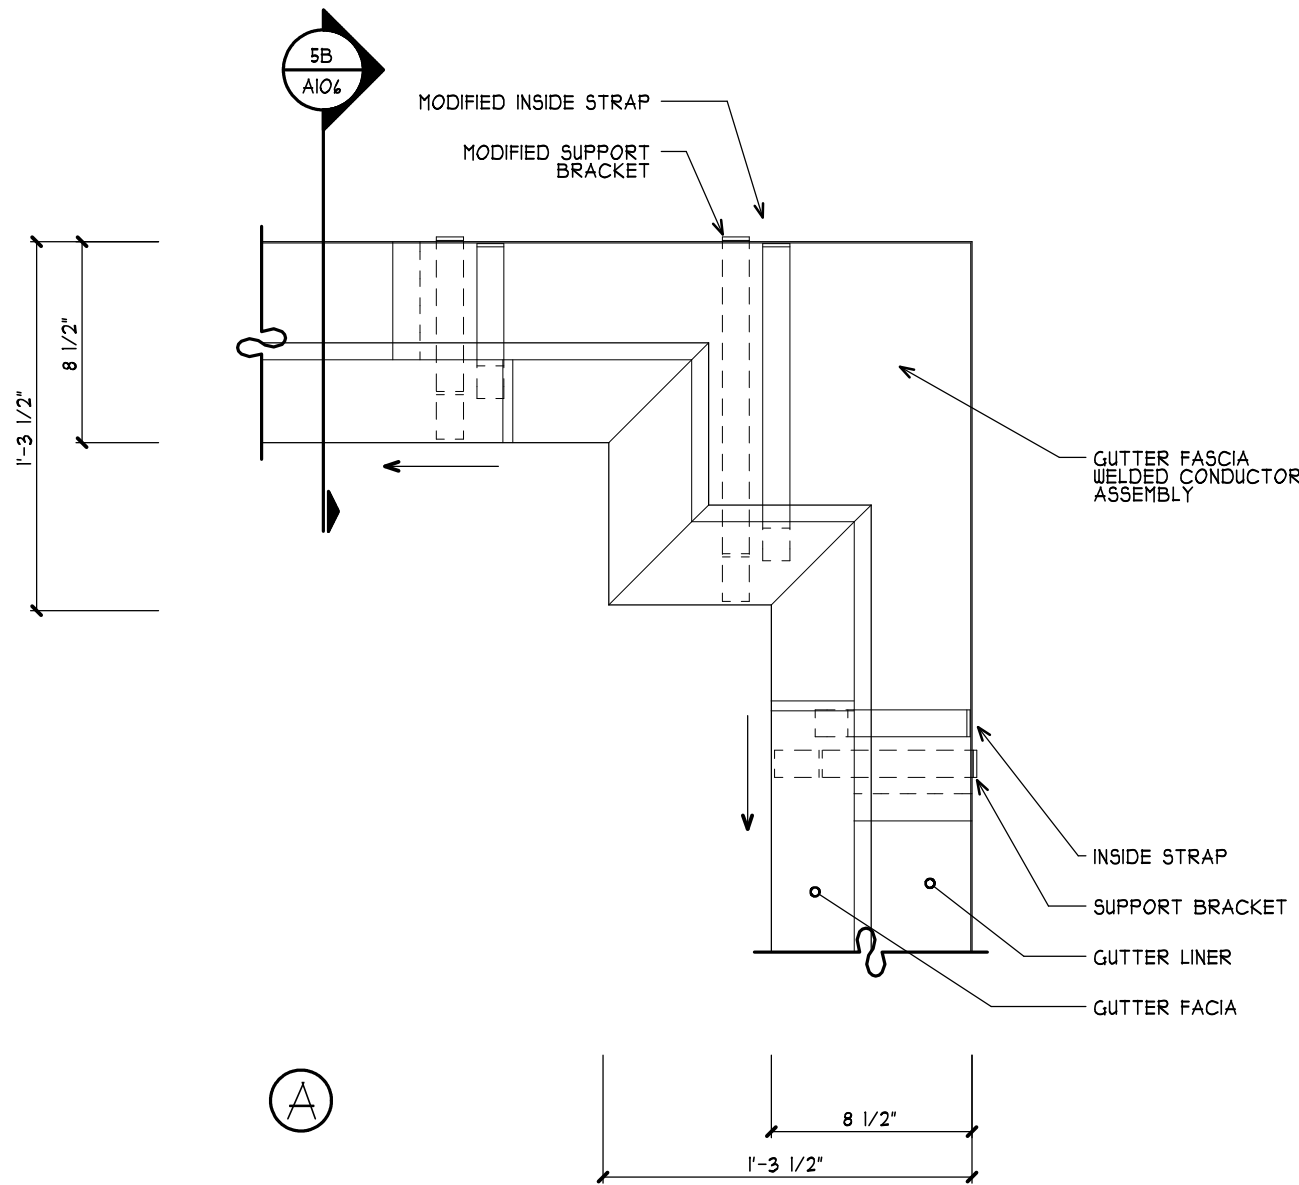


4 GABLE END WALL SECTION
A106 SCALE: 1" = 1'-0" 1/A104

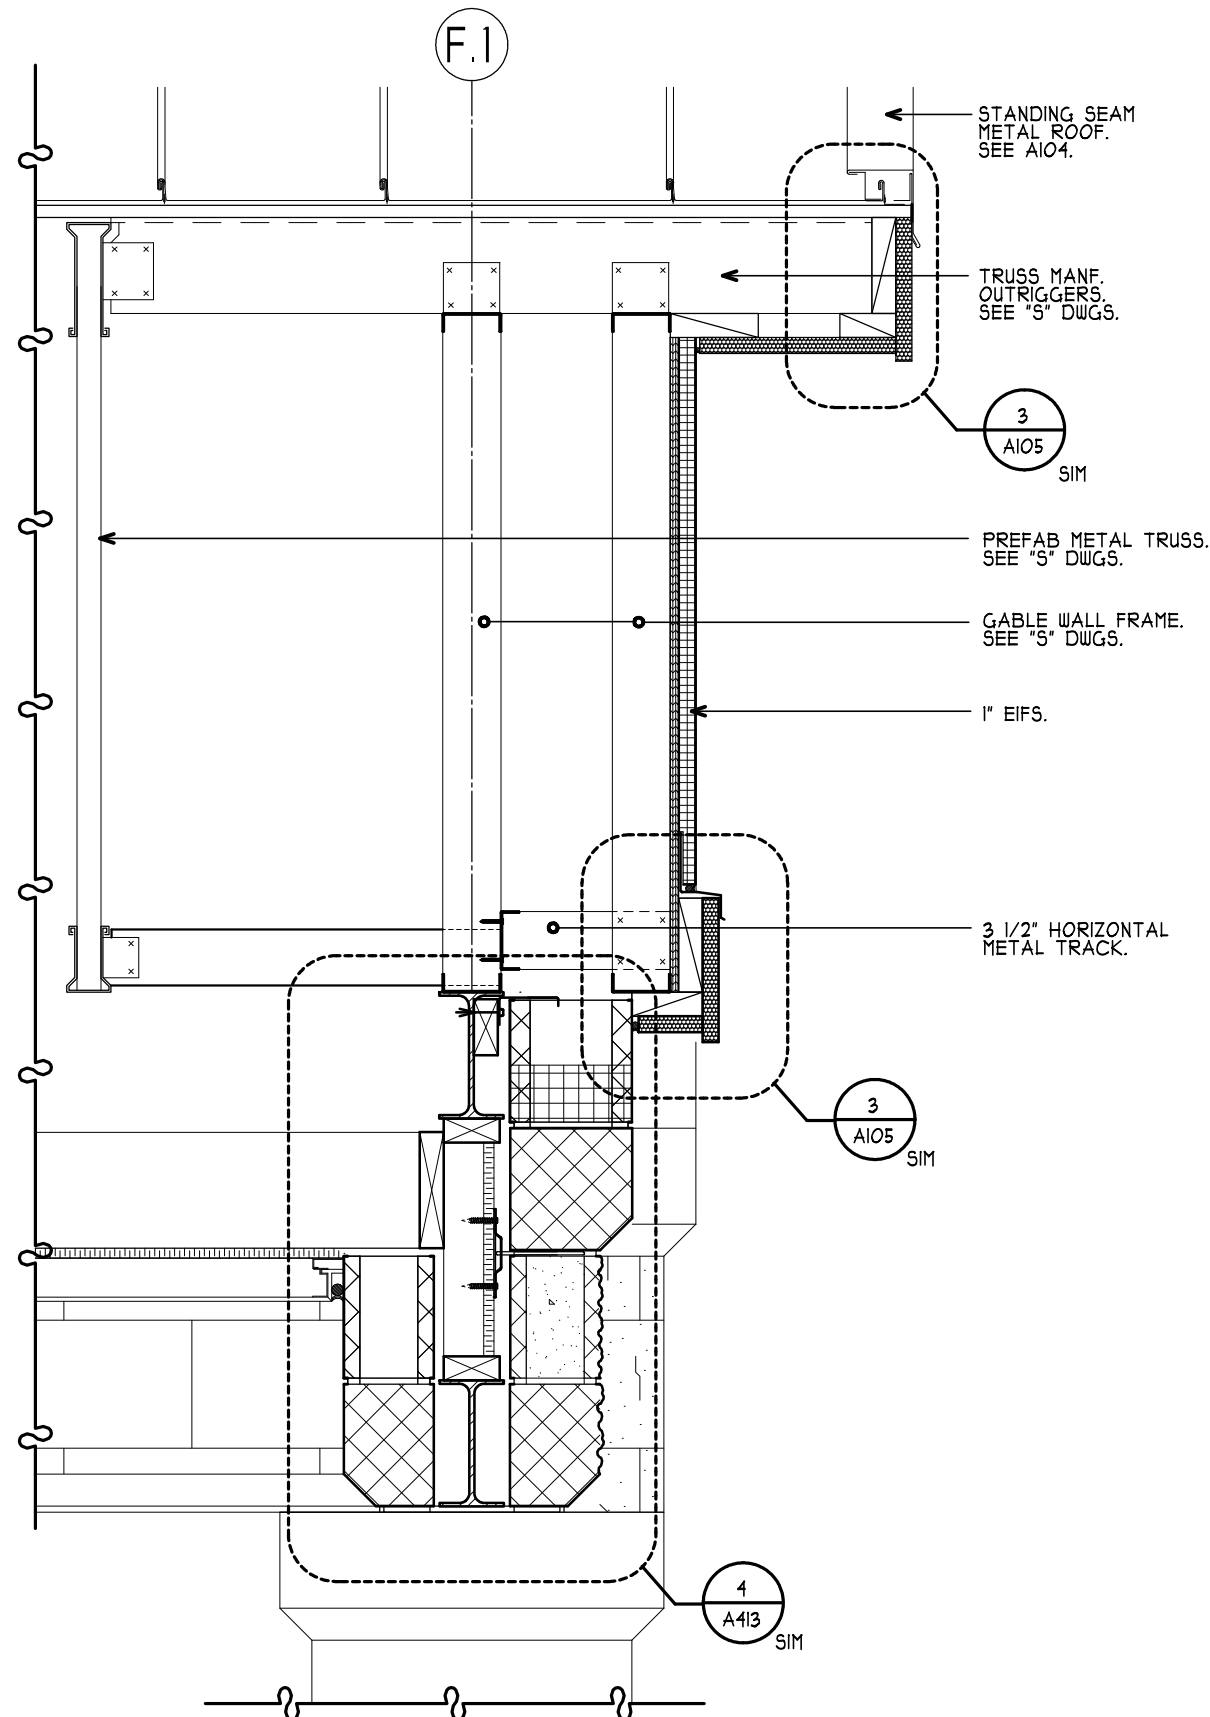


3 COLLECTION BOX DETAIL
A-106 SCALE: 1-1/2" = 1'-0"

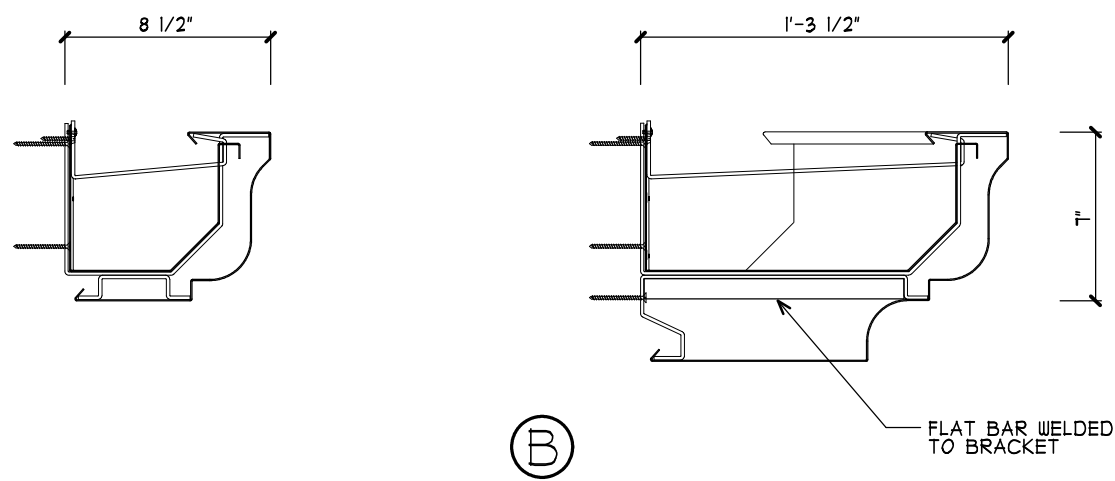

2 COLLECTION BOX DETAIL
A-106 SCALE: 1-1/2" = 1'-0"

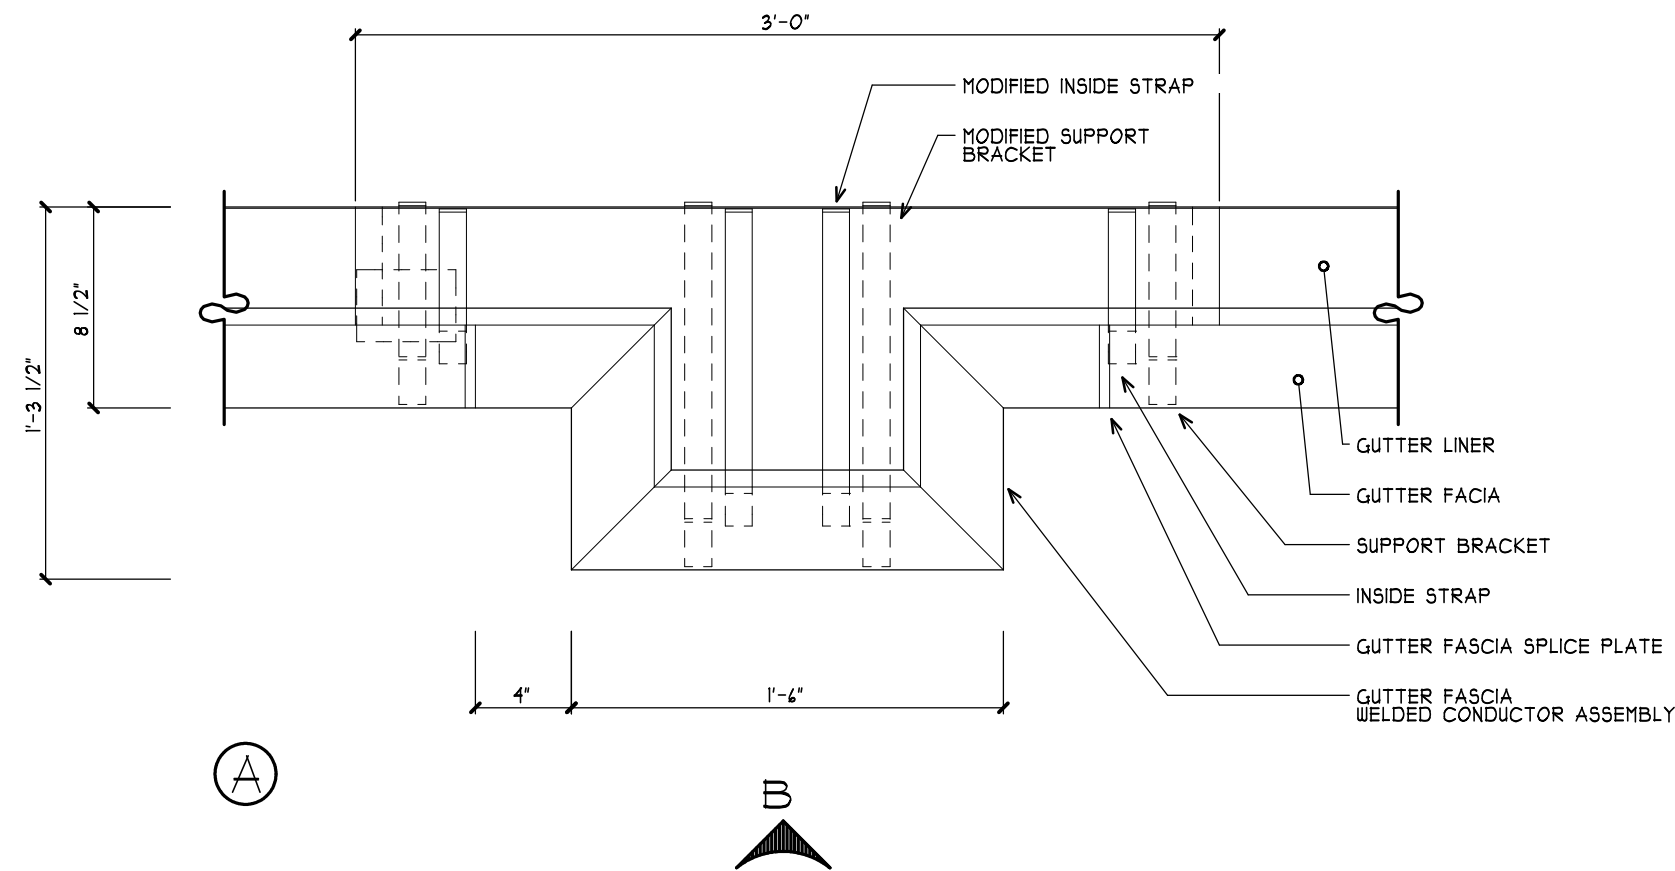

1 PATIO OVERFLOW SCUPPER FRAMING PLAN
A106 SCALE: 1/4" = 1'-0"

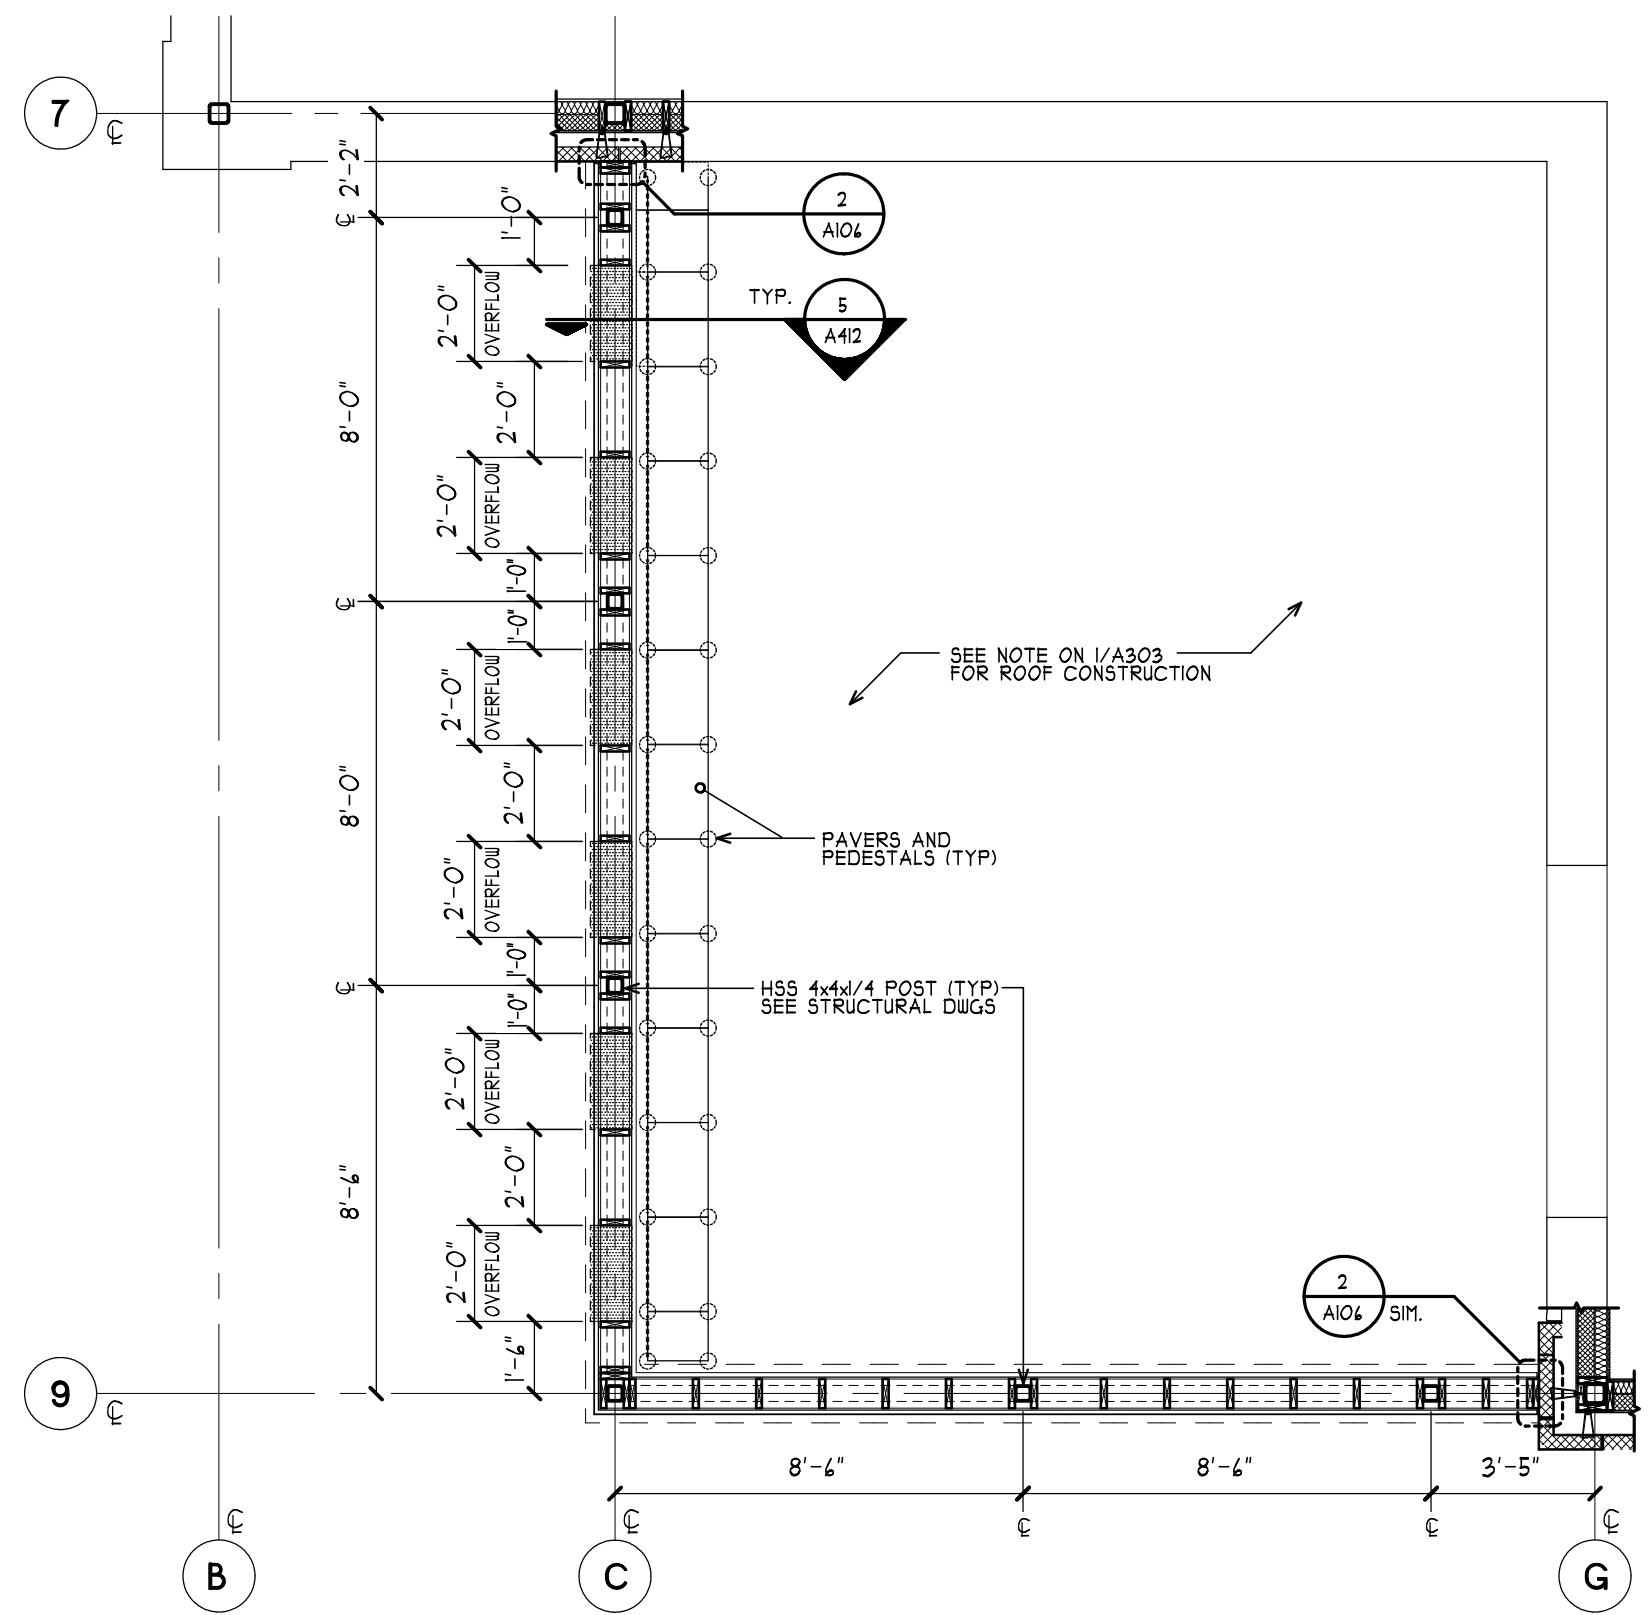

MA

Mitchell Associates Architects PLLC

29 THACHER PARK ROAD
VOORHEESVILLE, NY 12184
(518) 745-4511 FAX (518) 745-2180
WWW.MITCHELL-ARCHITECTS.COM

EMERGENCY SERVICE

FACILITIES

CONSULTANTS:

INSITE ENGINEERING SURVEYING & LANDSCAPE ARCHITECTURE, P.C.
3 GARRETT PLACE
CARMEL, NY 10512
(845) 225-9490 FAX: (845) 225-9111

CRAIG A. MALONEY, P.E.
STRUCTURAL ENGINEERING CONSULTANT
3 BENEDICT COURT
BALLSTON SPA, NY 12020
(518) 584-9944 FAX: (518) 584-9955

GERARD ASSOCIATES
CONSULTING ENGINEERS, P.C.
MECHANICAL, PLUMBING, AND ELECTRICAL
223 MAIN STREET
GOSHEN, NY 10824
(845) 291-1212 FAX: (845) 291-1939

NEW STATION FOR PUTNAM VALLEY FIRE STATION #1

OSCAWANA LAKE ROAD
PUTNAM VALLEY, NEW YORK

REVISION HISTORY

	DATE	DESCRIPTION
▲		
▲		
▲		
▲		
▲		
▲		

ROOF PLAN DETAILS

SCALE: AS NOTED
DWG. BY: JDA
DWG. DATE: 8/14/2020
STATUS: BID DRAWINGS

A106

PLOT TIME: 11:54 AM