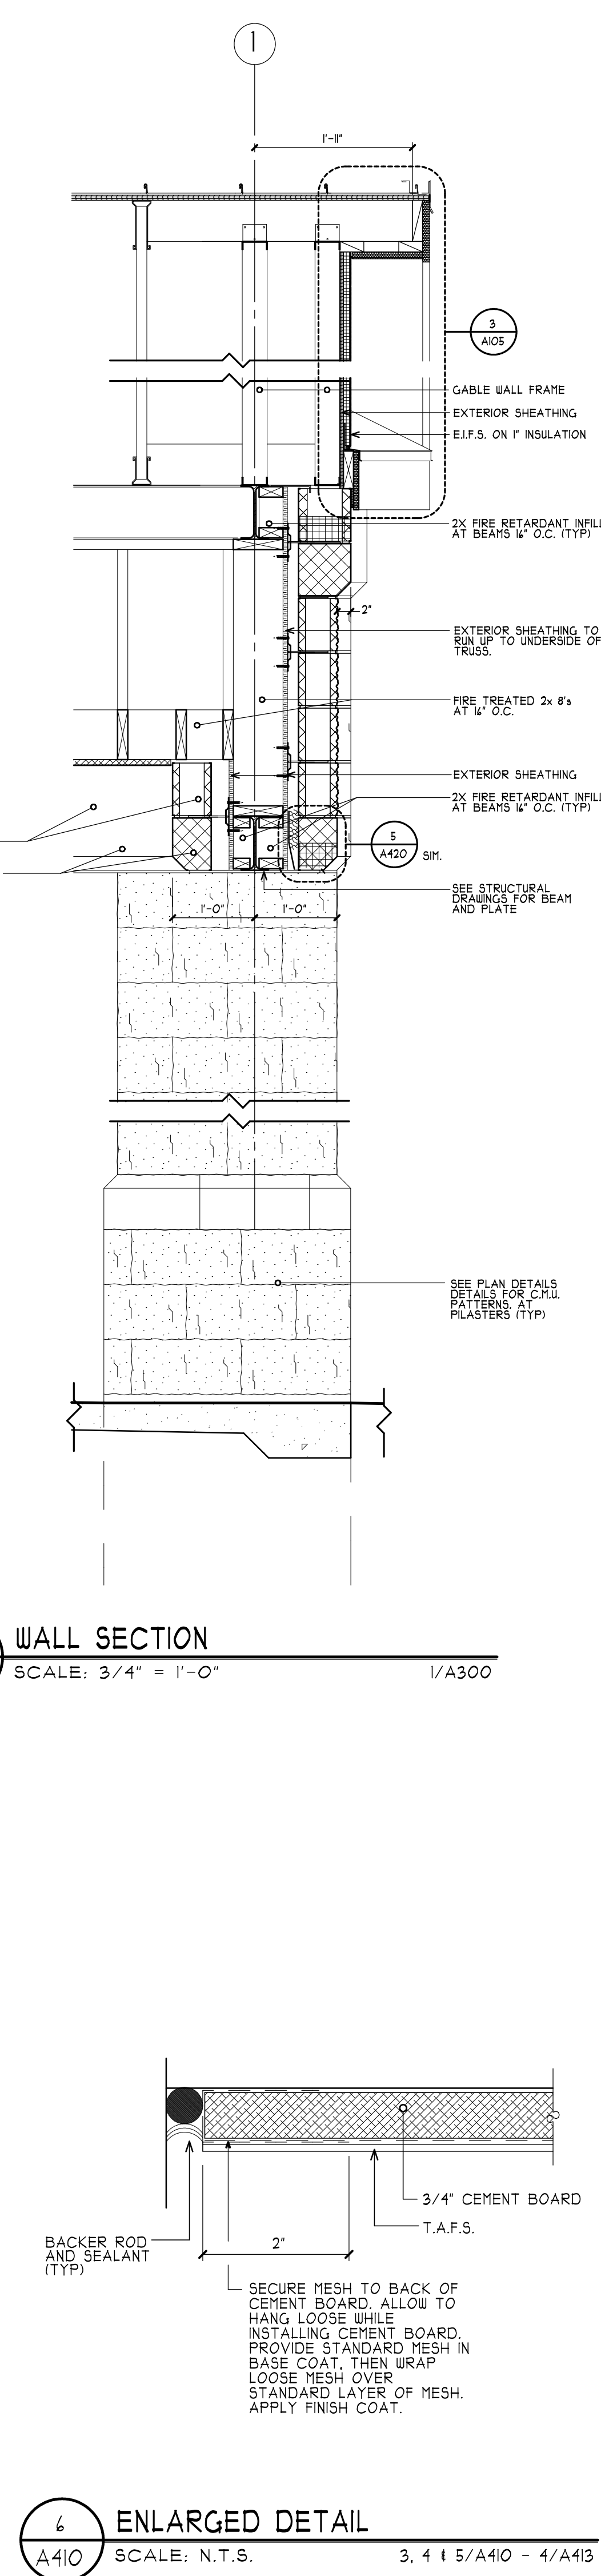
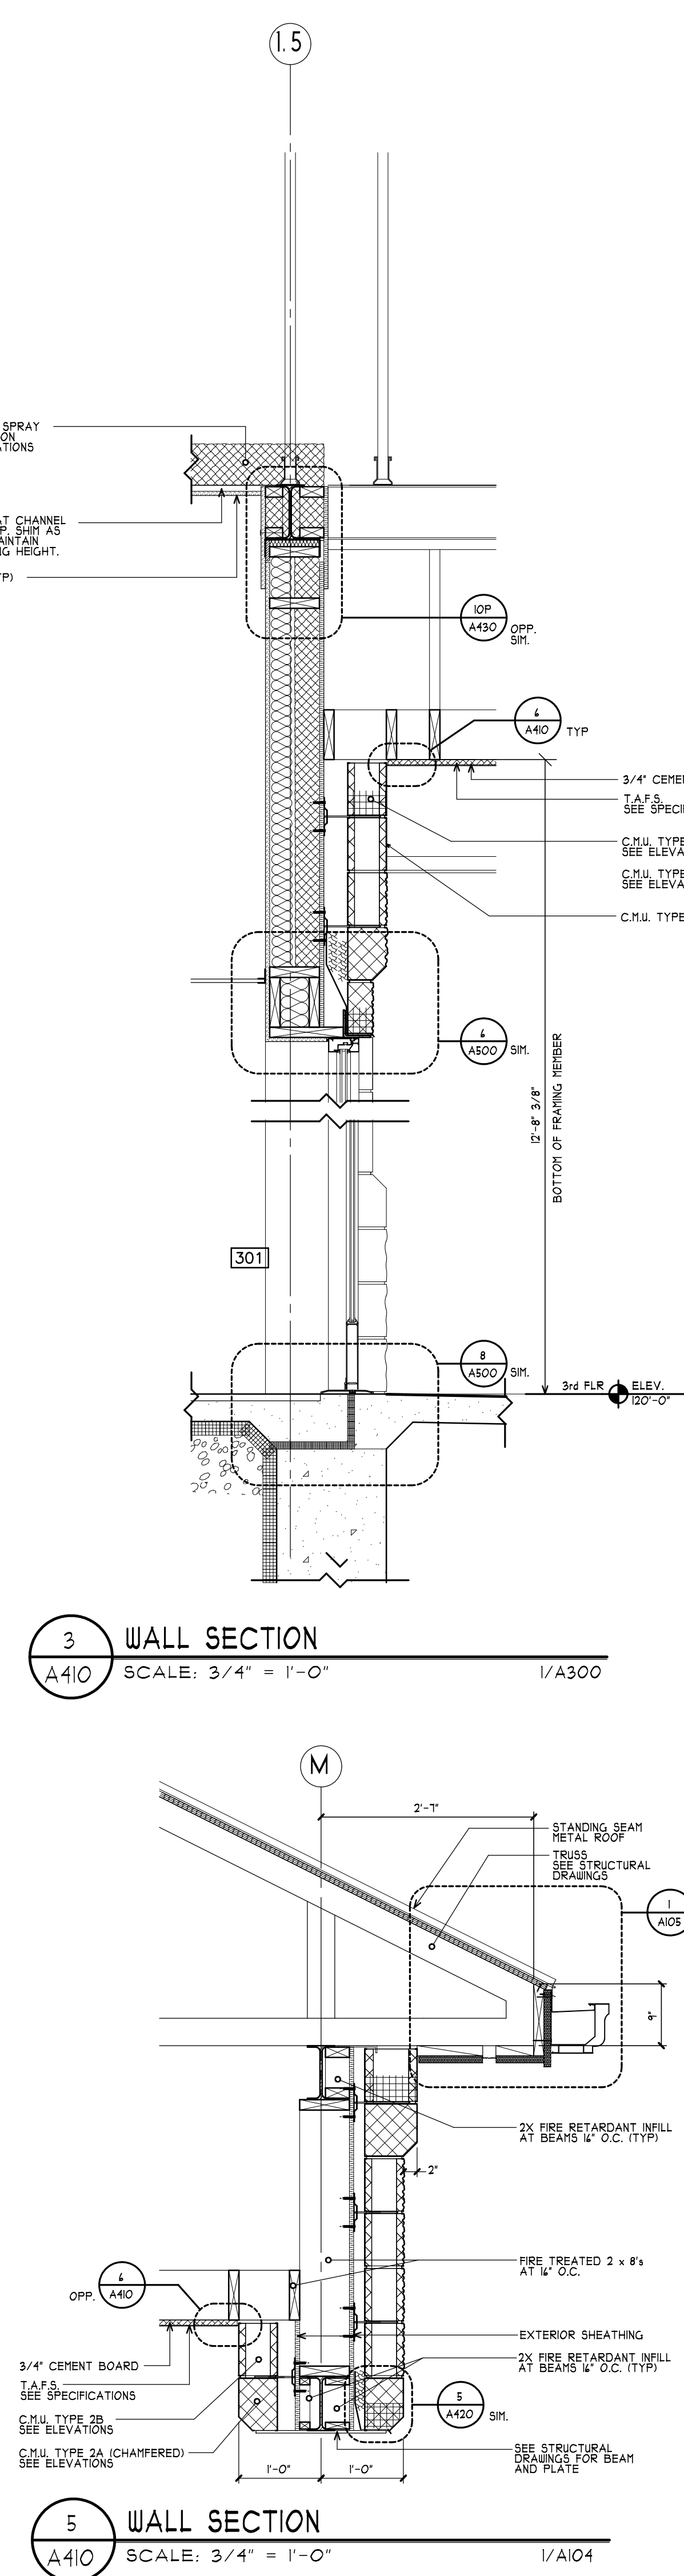
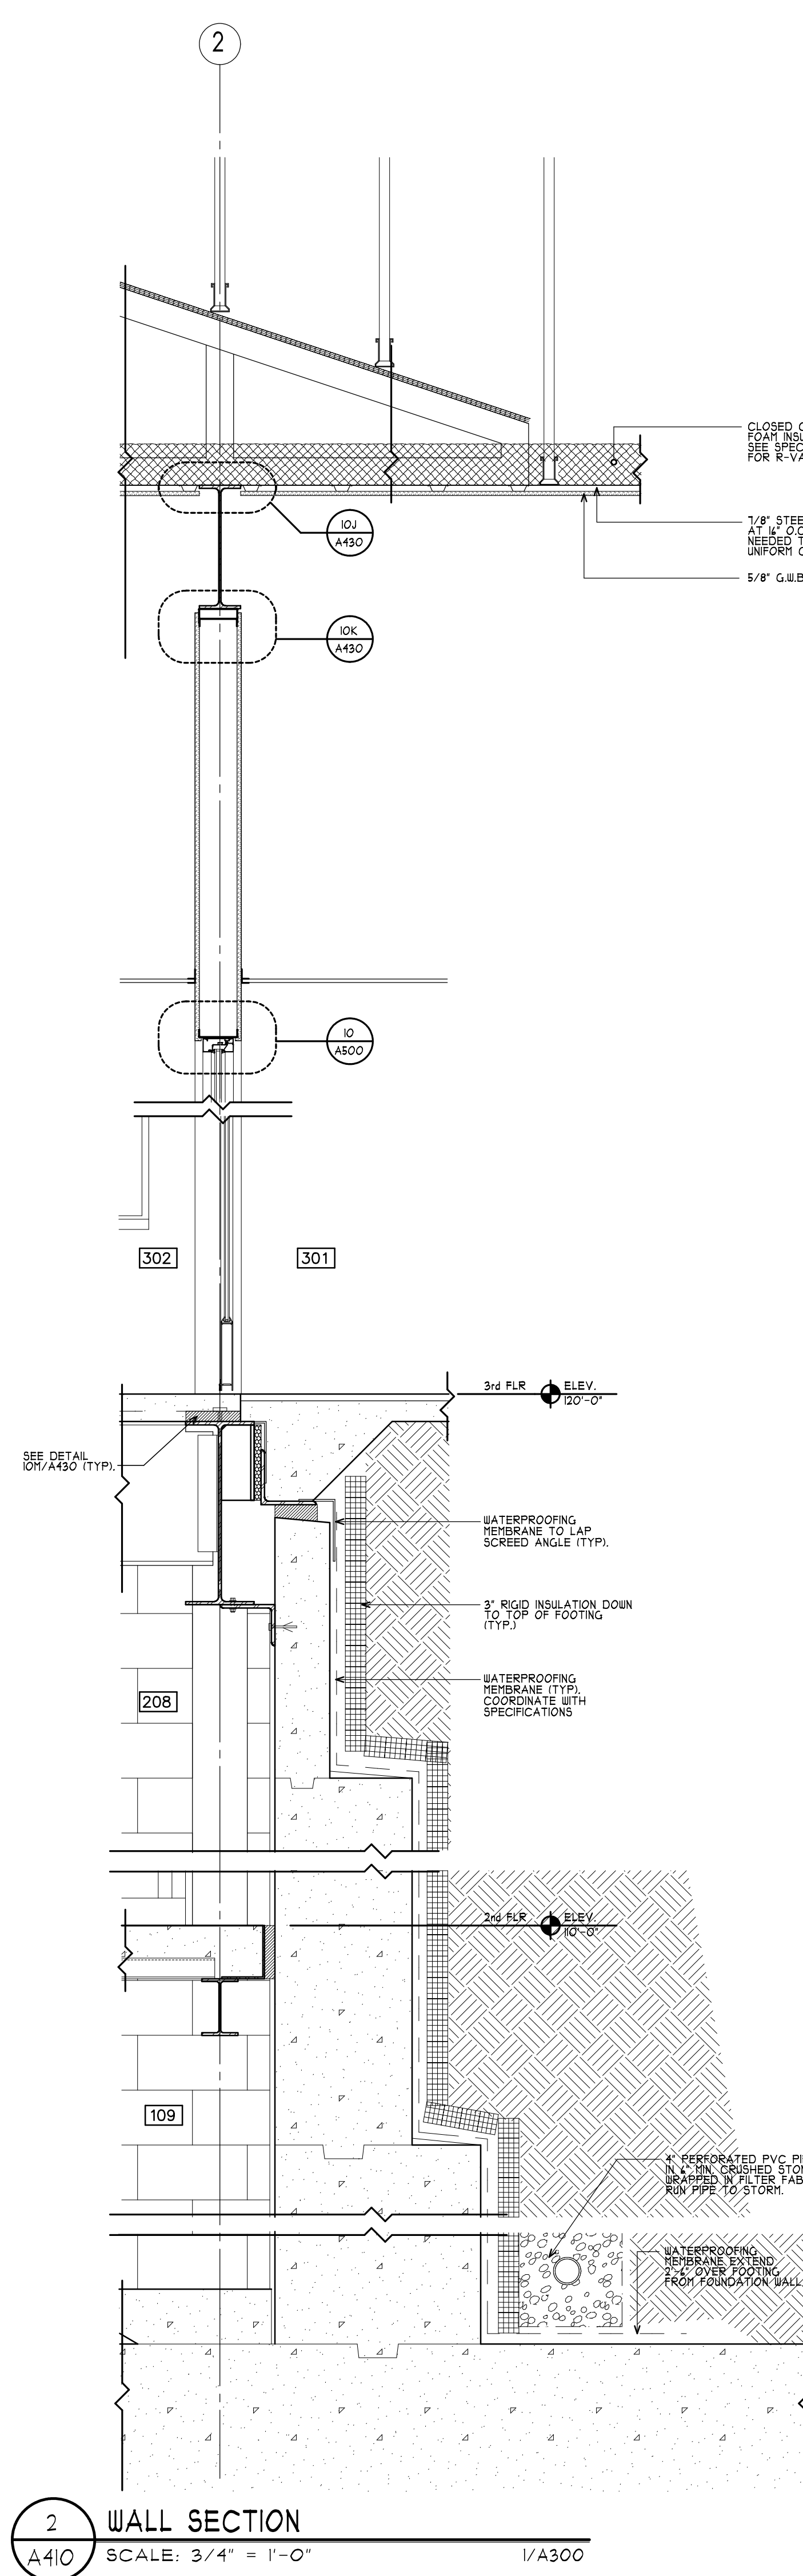
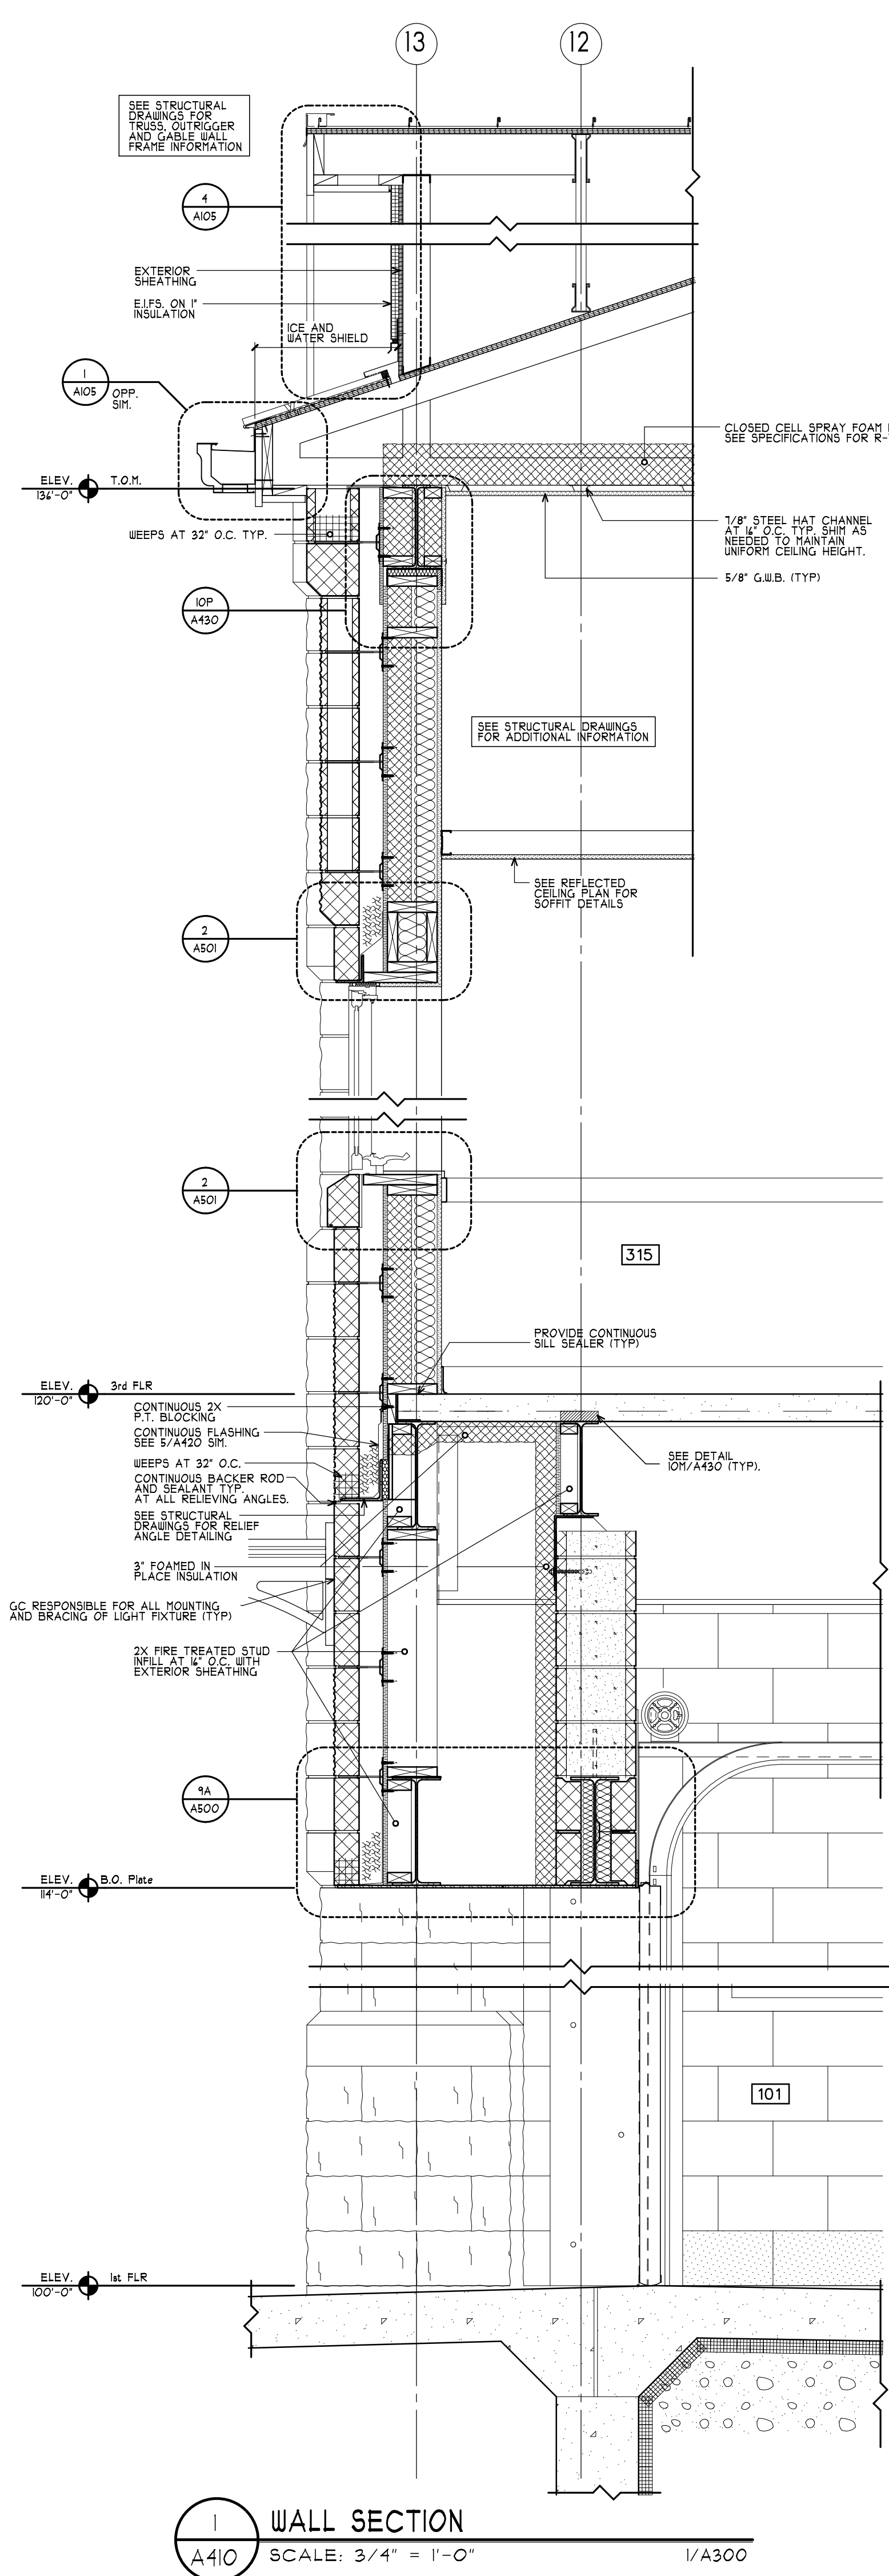


MA

**MITCHELL
ASSOCIATES
ARCHITECTS
PLLC**

29 THACHER PARK ROAD
VORHEESVILLE, NY 12186
(518) 745-4571 FAX (518) 745-2950
WWW.MITCHELL-ARCHITECTS.COM

EMERGENCY
SERVICE
FACILITIES

CONSULTANTS:
INSITE ENGINEERING SURVEYING
& LANDSCAPE ARCHITECTURE, P.C.
3 GARRETT PLACE
CARMEL, NY 10512
(845) 225-9490 FAX: (845) 225-9717

CRAIG A. MALONEY, P.E.
STRUCTURAL ENGINEERING CONSULTANT
3 BENEDICT COURT
BALLSTON SPA, NY 12020
(518) 584-9944 FAX: (518) 584-9955

GERARD ASSOCIATES
CONSULTING ENGINEERS, P.C.
MECHANICAL, PLUMBING,
AND ELECTRICAL
223 MAIN STREET
GOSHEN, NY 10924
(845) 291-1212 FAX: (845) 291-1939

COPYRIGHT 2012
MITCHELL ASSOCIATES ARCHITECTS
UNAUTHORIZED ALTERATION OR ADDITION
TO THIS DOCUMENT IS A VIOLATION OF LAW

NEW STATION
FOR
PUTNAM VALLEY
FIRE STATION #1

OSCAWANA LAKE ROAD
PUTNAM VALLEY, NEW YORK

[illegible]

WALL SECTIONS

SCALE: AS NOTED
DWG. BY: JDC, JDA
DWG DATE: 8/14/2020
STATUS: BID DRAWINGS

A410

PLOT TIME: 12:16 PM