
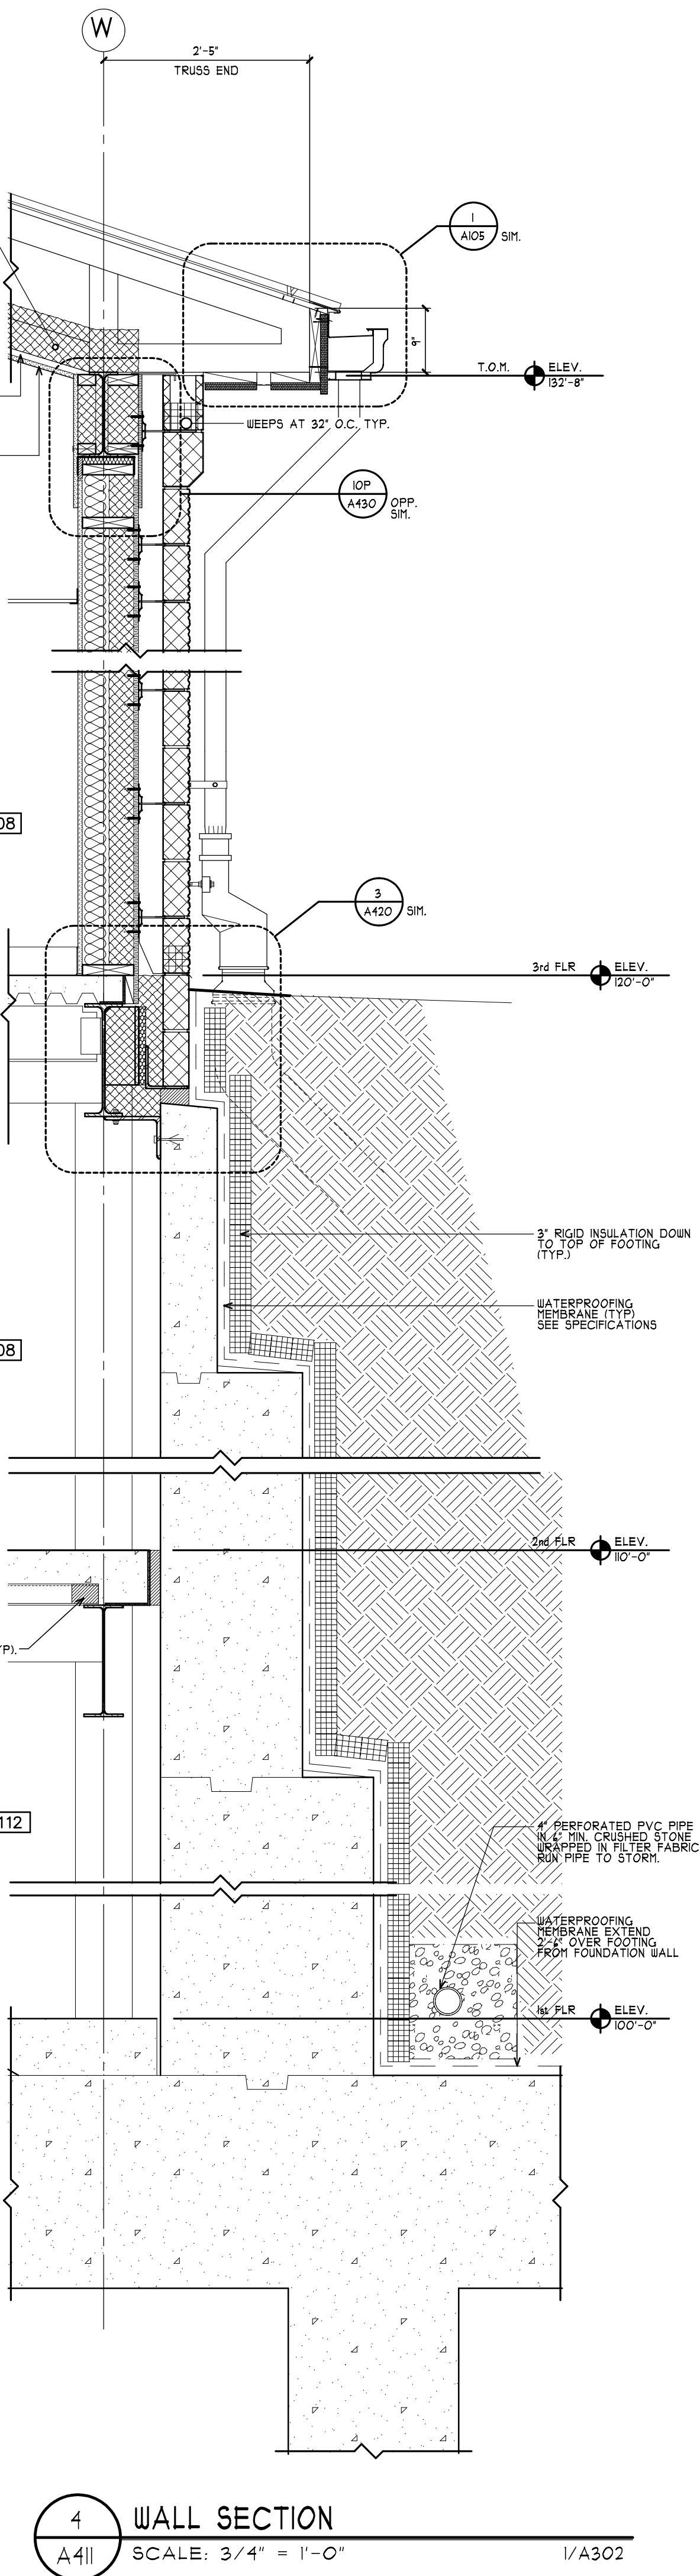
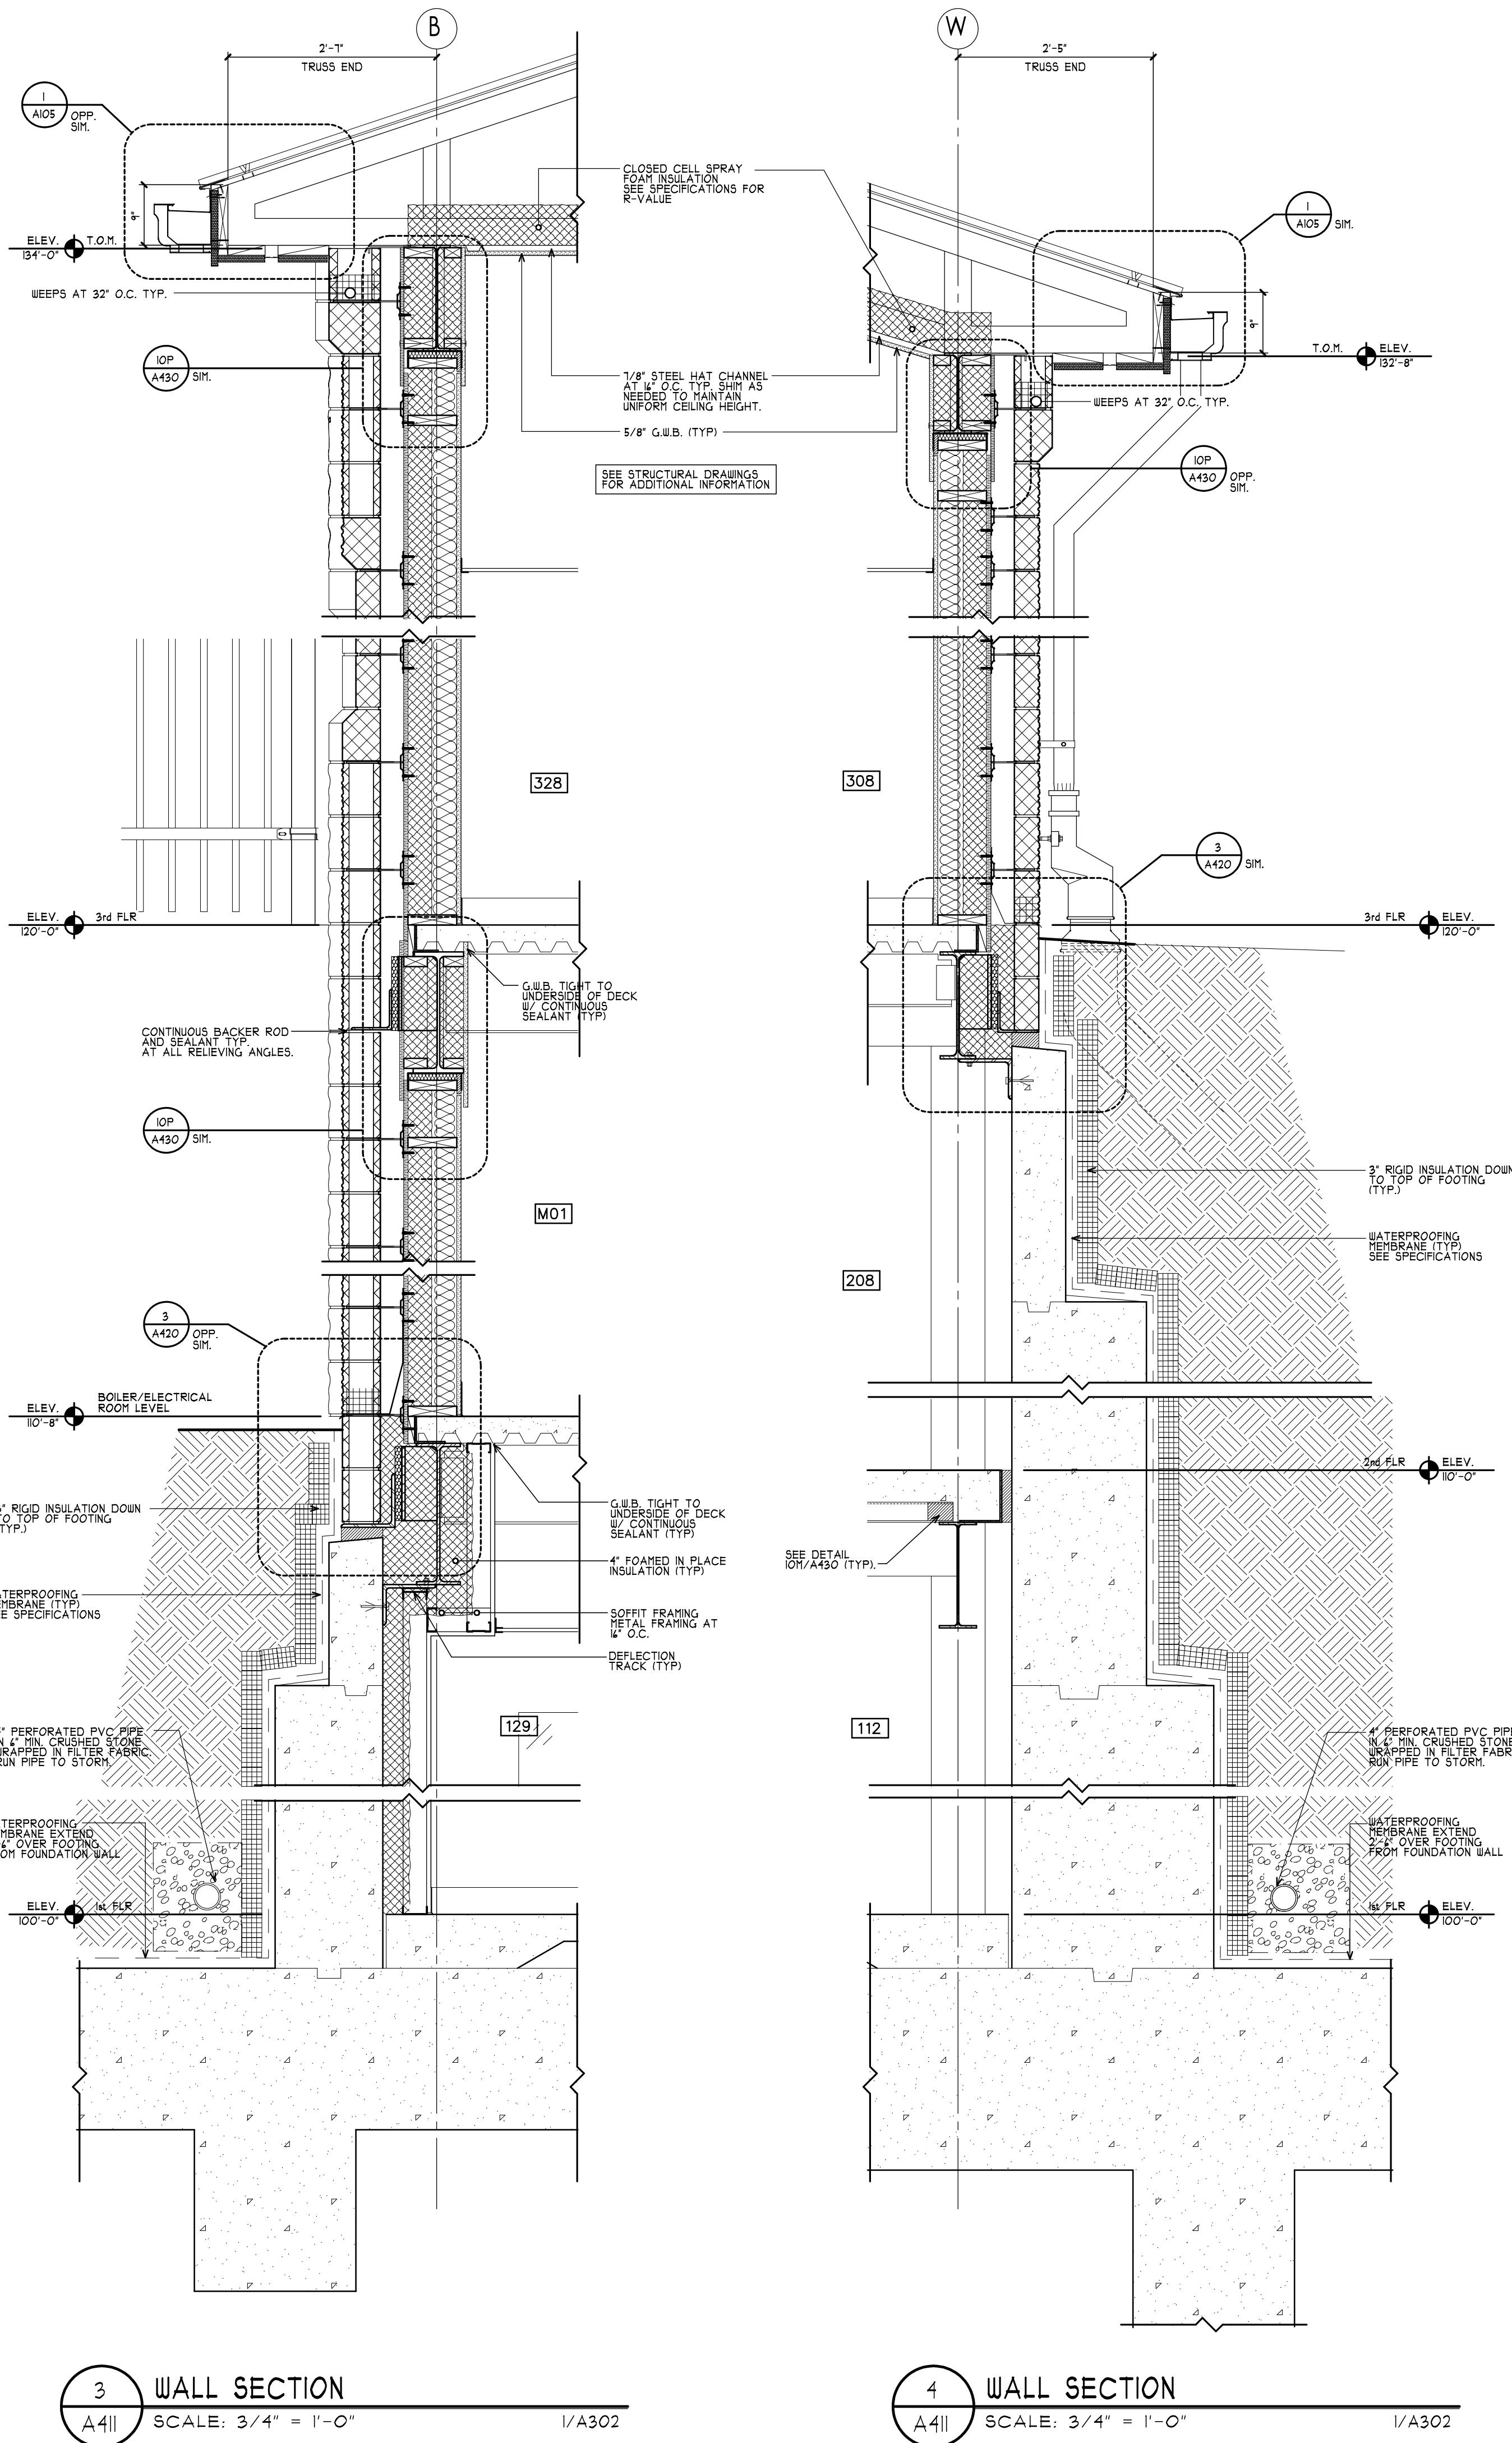
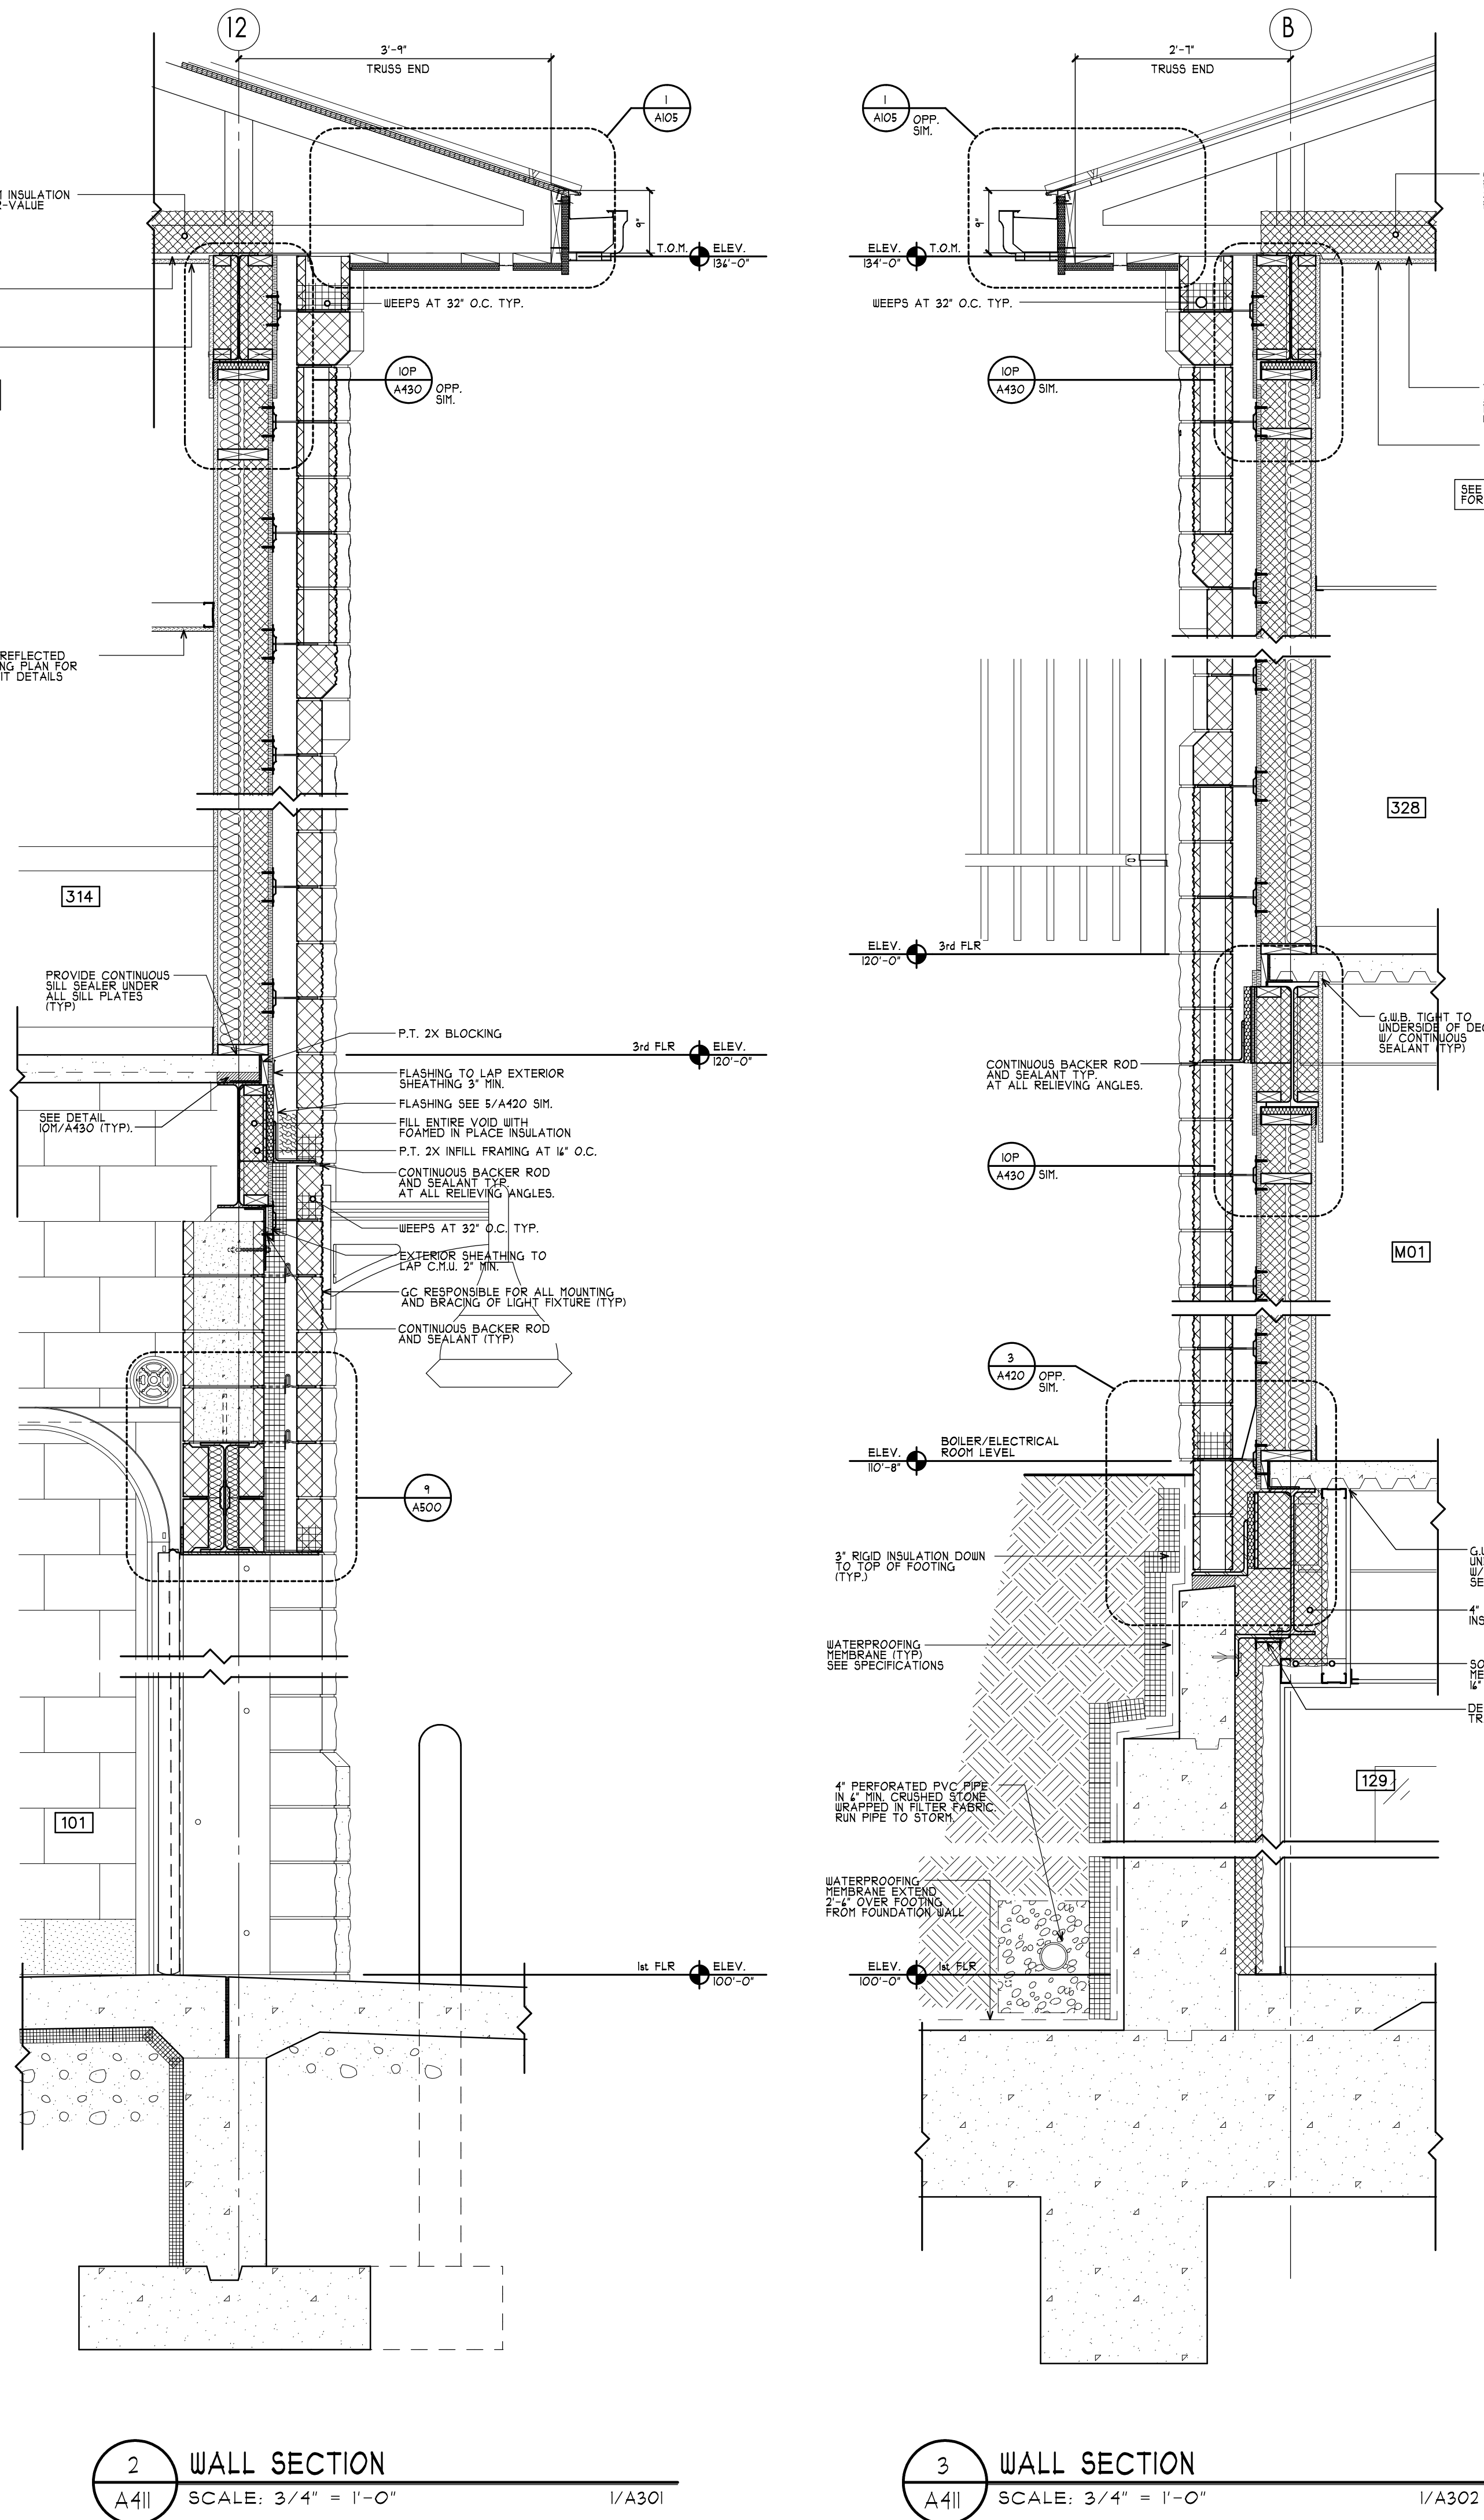


DWG ID#: S:\J Drive\Putnam Valley\PV_A410 Wall Section

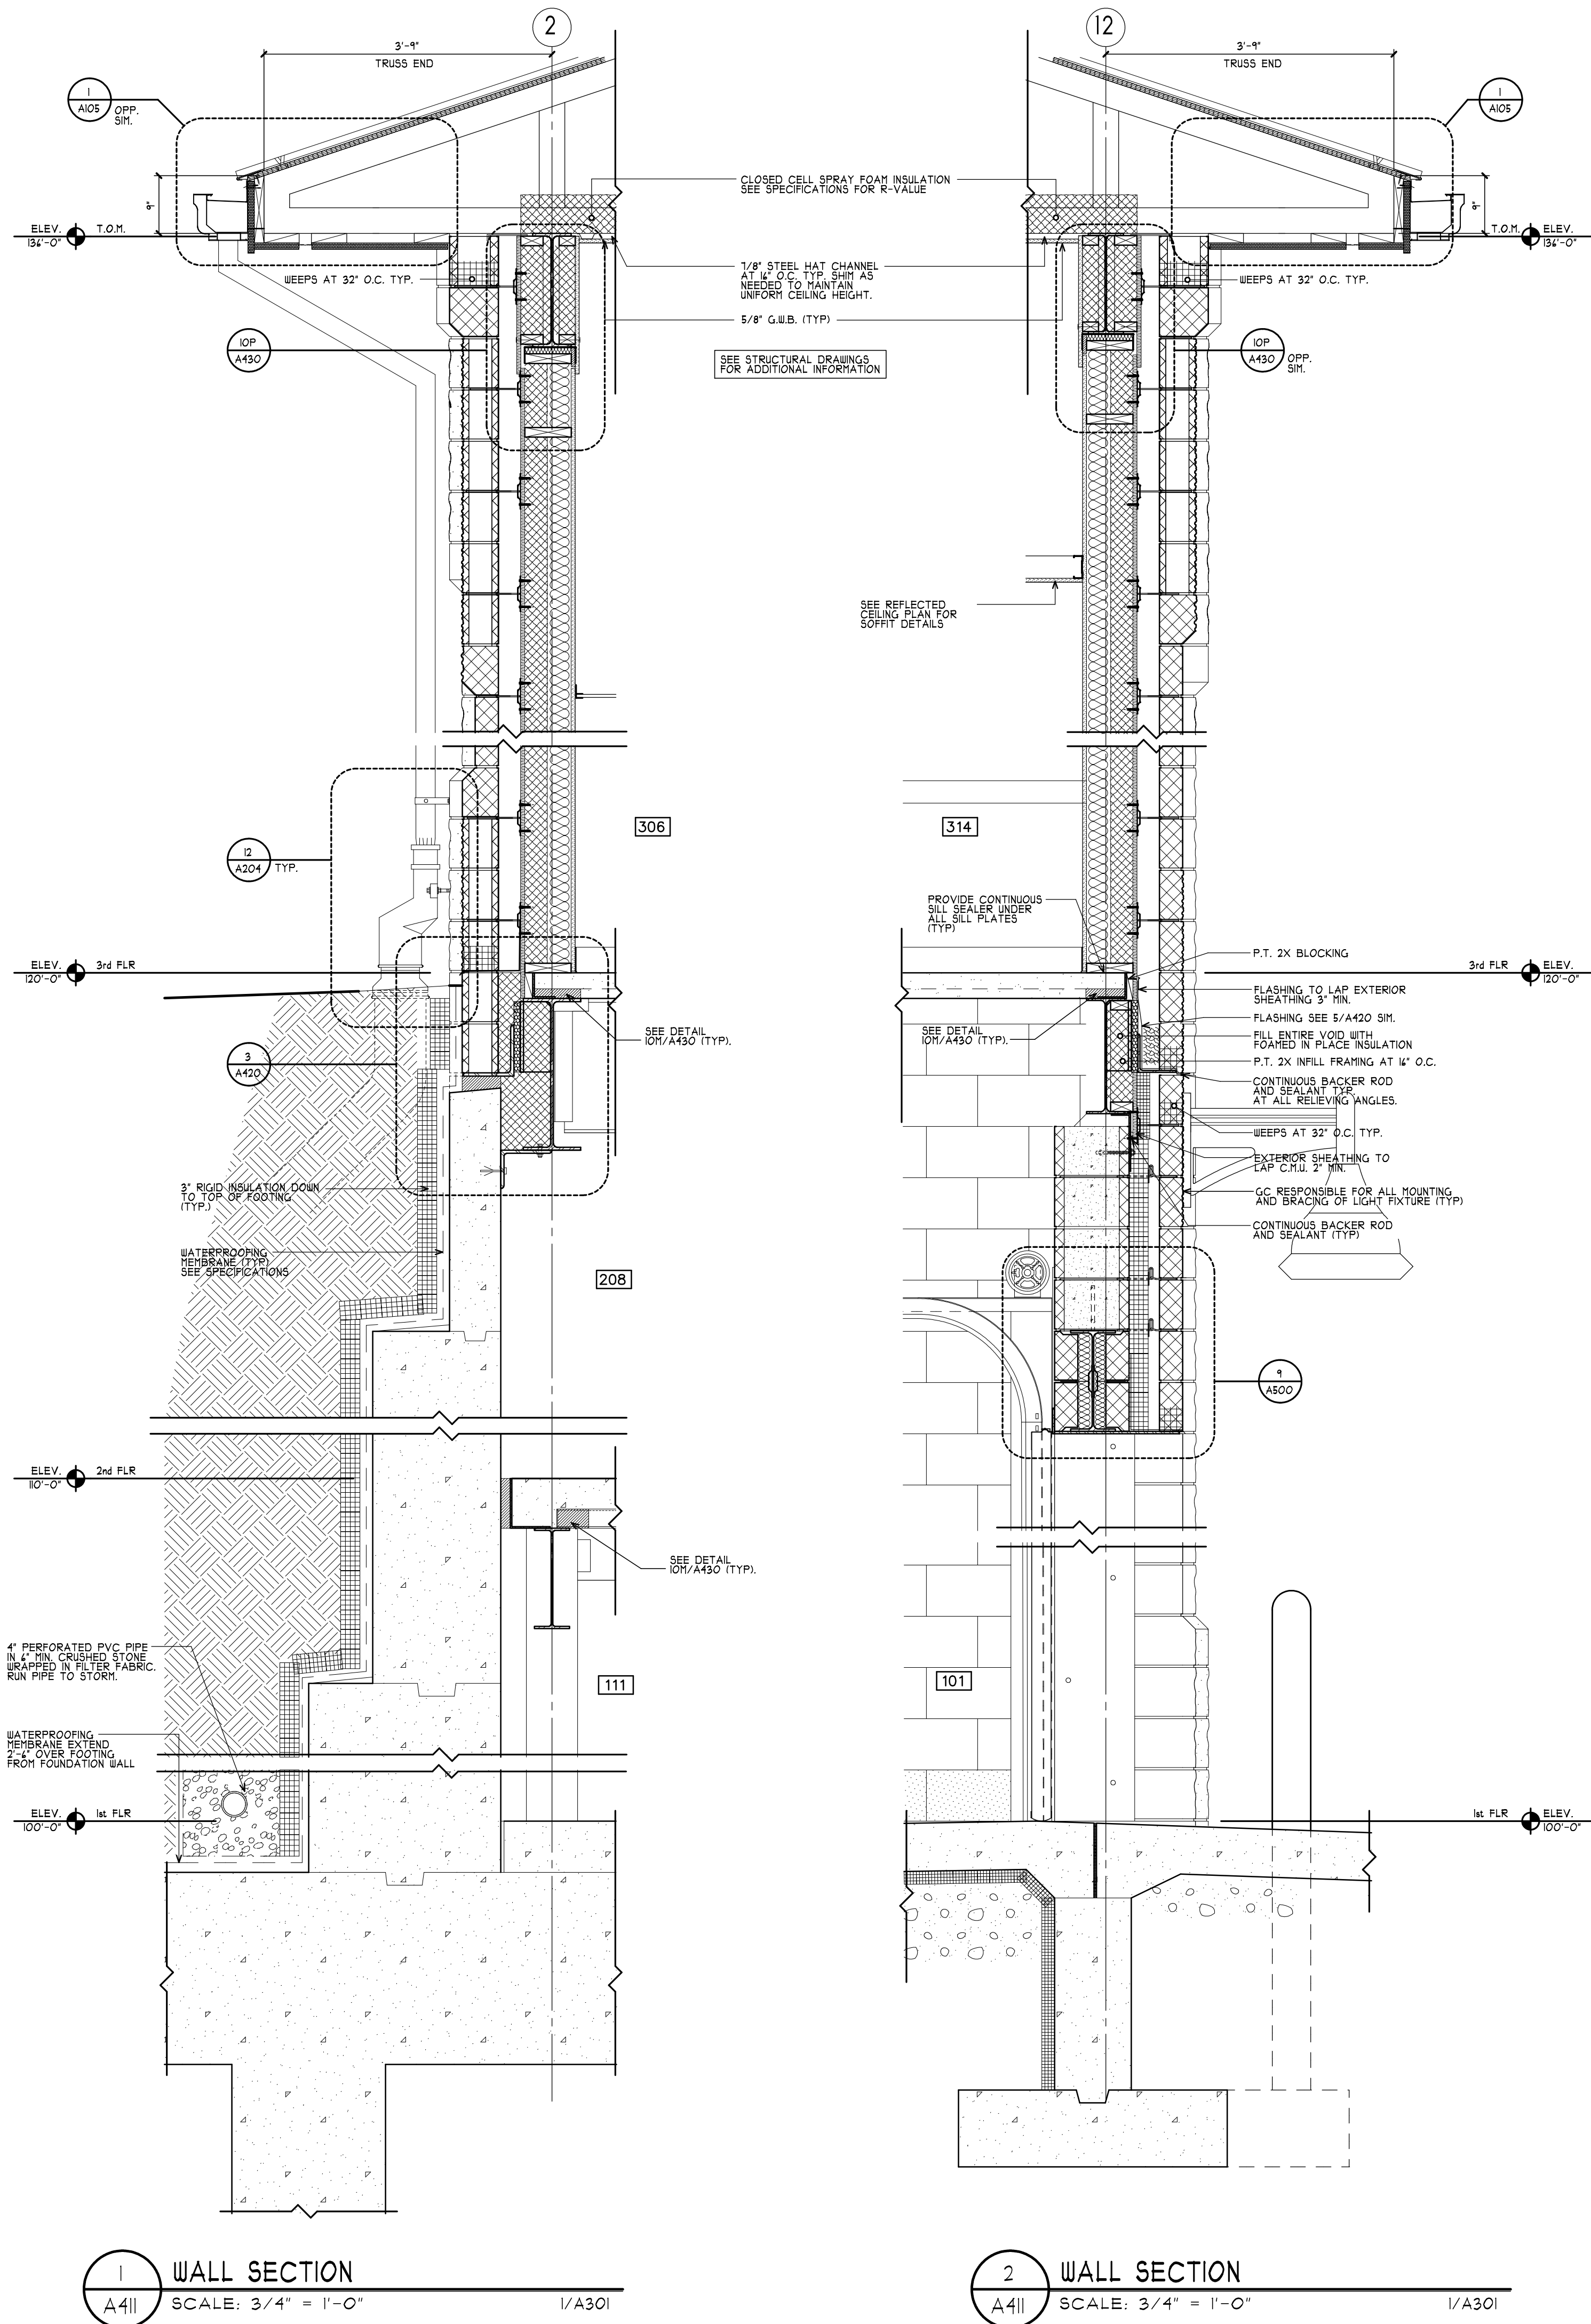

MA

MITCHELL ASSOCIATES ARCHITECTS PLLC

24 THACHER PARK ROAD
VOORHEESVILLE, NY 12186
(518) 745-4571 FAX (518) 745-2950
WWW.MITCHELL-ARCHITECTS.COM

EMERGENCY SERVICE

FACILITIES

CONSULTANTS:

INSITE ENGINEERING SURVEYING
& LANDSCAPE ARCHITECTURE, P.C.
3 GARRETT PLACE
CARMEL, NY 10512
(845) 225-4100 FAX: (845) 225-9117

CRAIG A. MALONEY, P.E.
STRUCTURAL ENGINEERING CONSULTANT
3 BENEDICT COURT
BALLSTON SPA, NY 12020
(518) 584-4444 FAX: (518) 584-4955

GERARD ASSOCIATES
CONSULTING ENGINEERS, P.C.
MECHANICAL, PLUMBING,
AND ELECTRICAL
223 MAIN STREET
GOSHEN, NY 10924
(845) 291-1212 FAX: (845) 291-1939

COPYRIGHT 2020
MITCHELL ASSOCIATES ARCHITECTS
UNAUTHORIZED ALTERATION OR ADDITION
TO THIS DOCUMENT IS A VIOLATION OF LAW

NEW STATION
FOR
PUTNAM VALLEY
FIRE STATION #1

OSCAWANA LAKE ROAD
PUTNAM VALLEY, NEW YORK

REVISION HISTORY

DATE	DESCRIPTION
▲	
▲	
WALL SECTIONS

SCALE: AS NOTED
DWG. BY: JDA
DWG DATE: 8/14/2020
STATUS: BID DRAWINGS

A411

PLOT TIME: 2:45 PM