
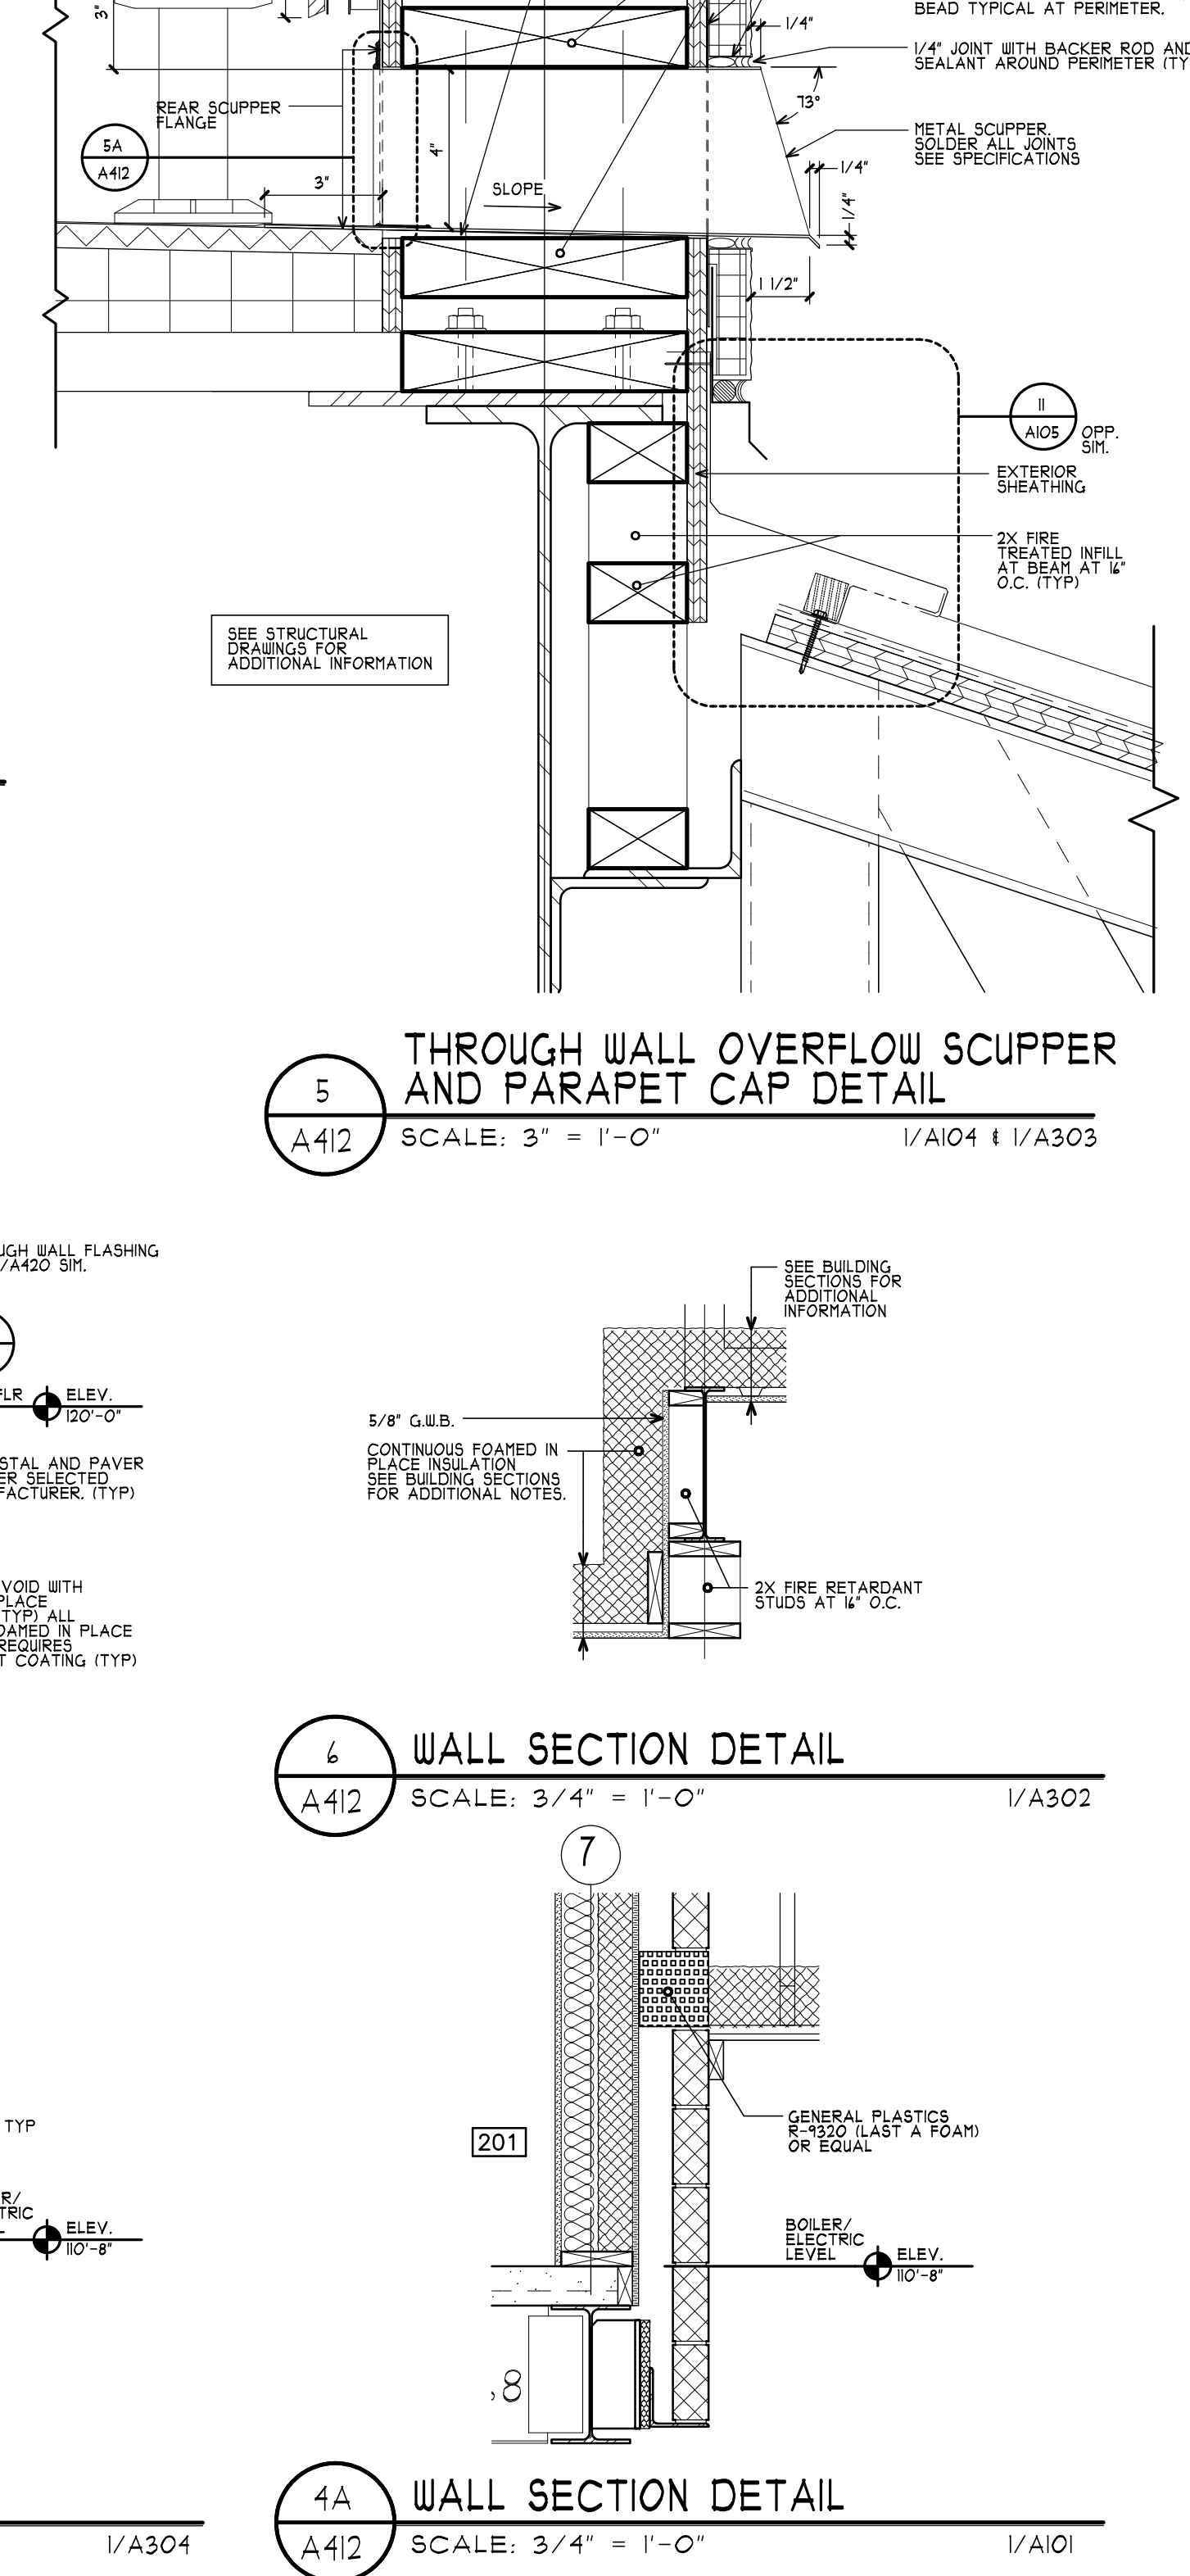
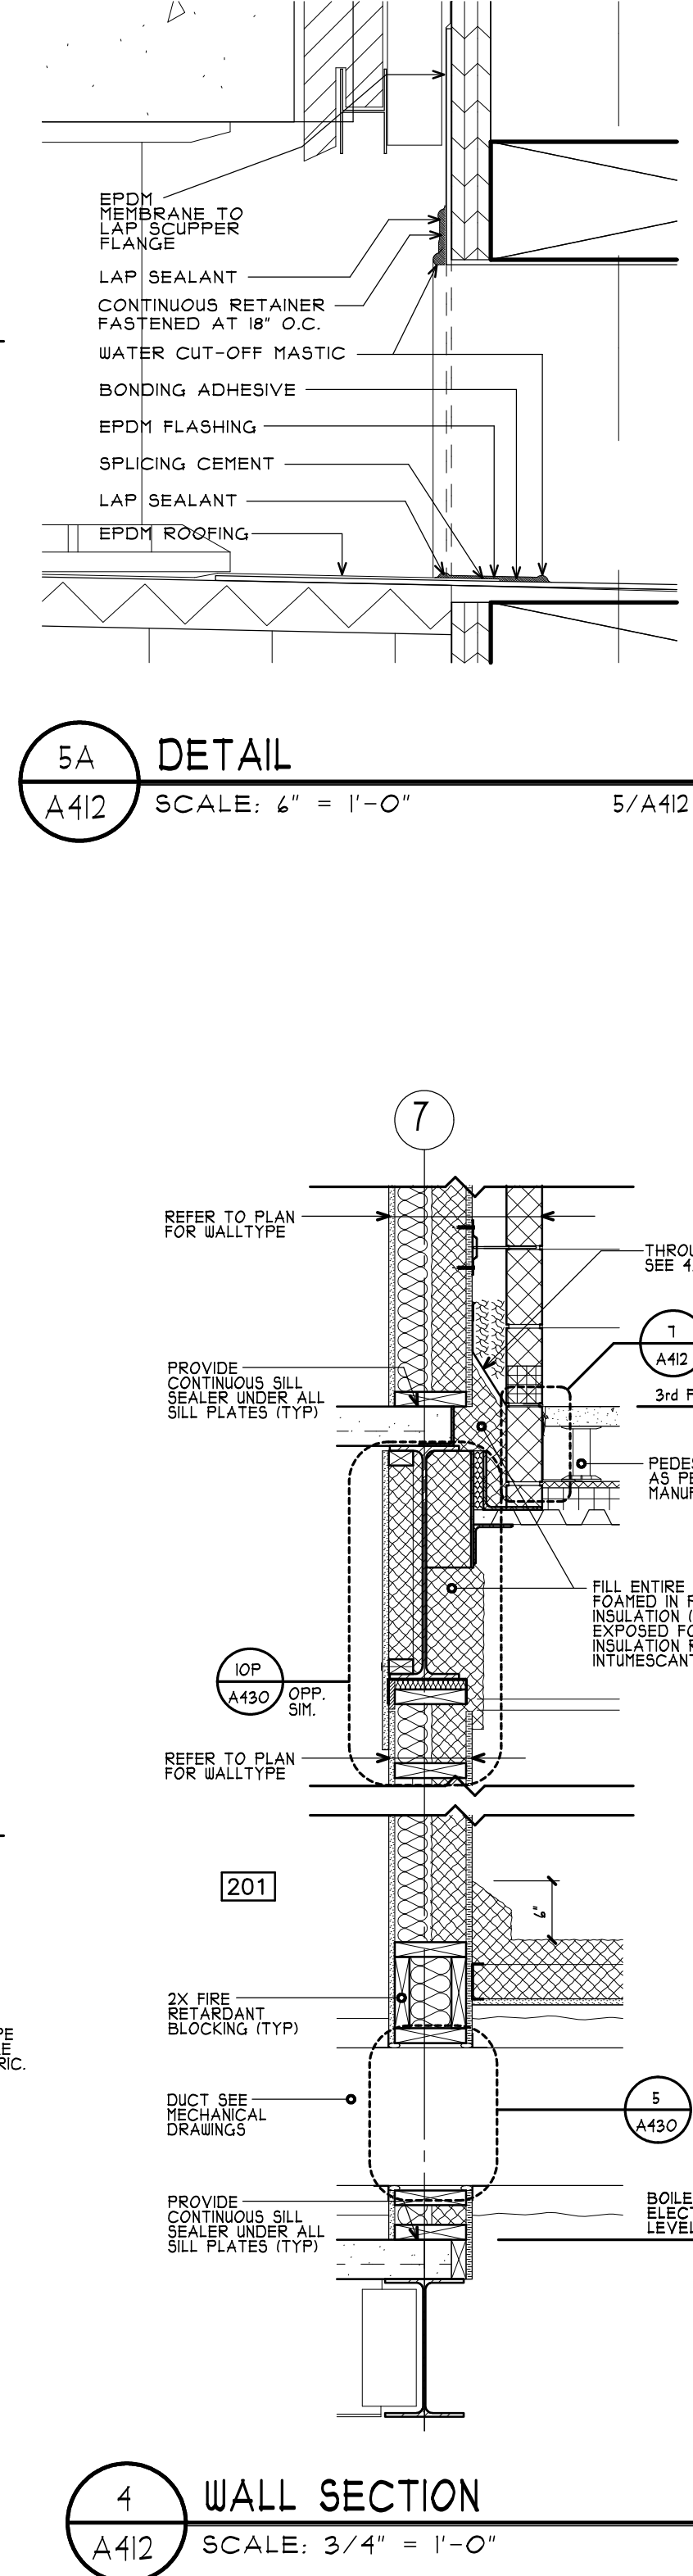
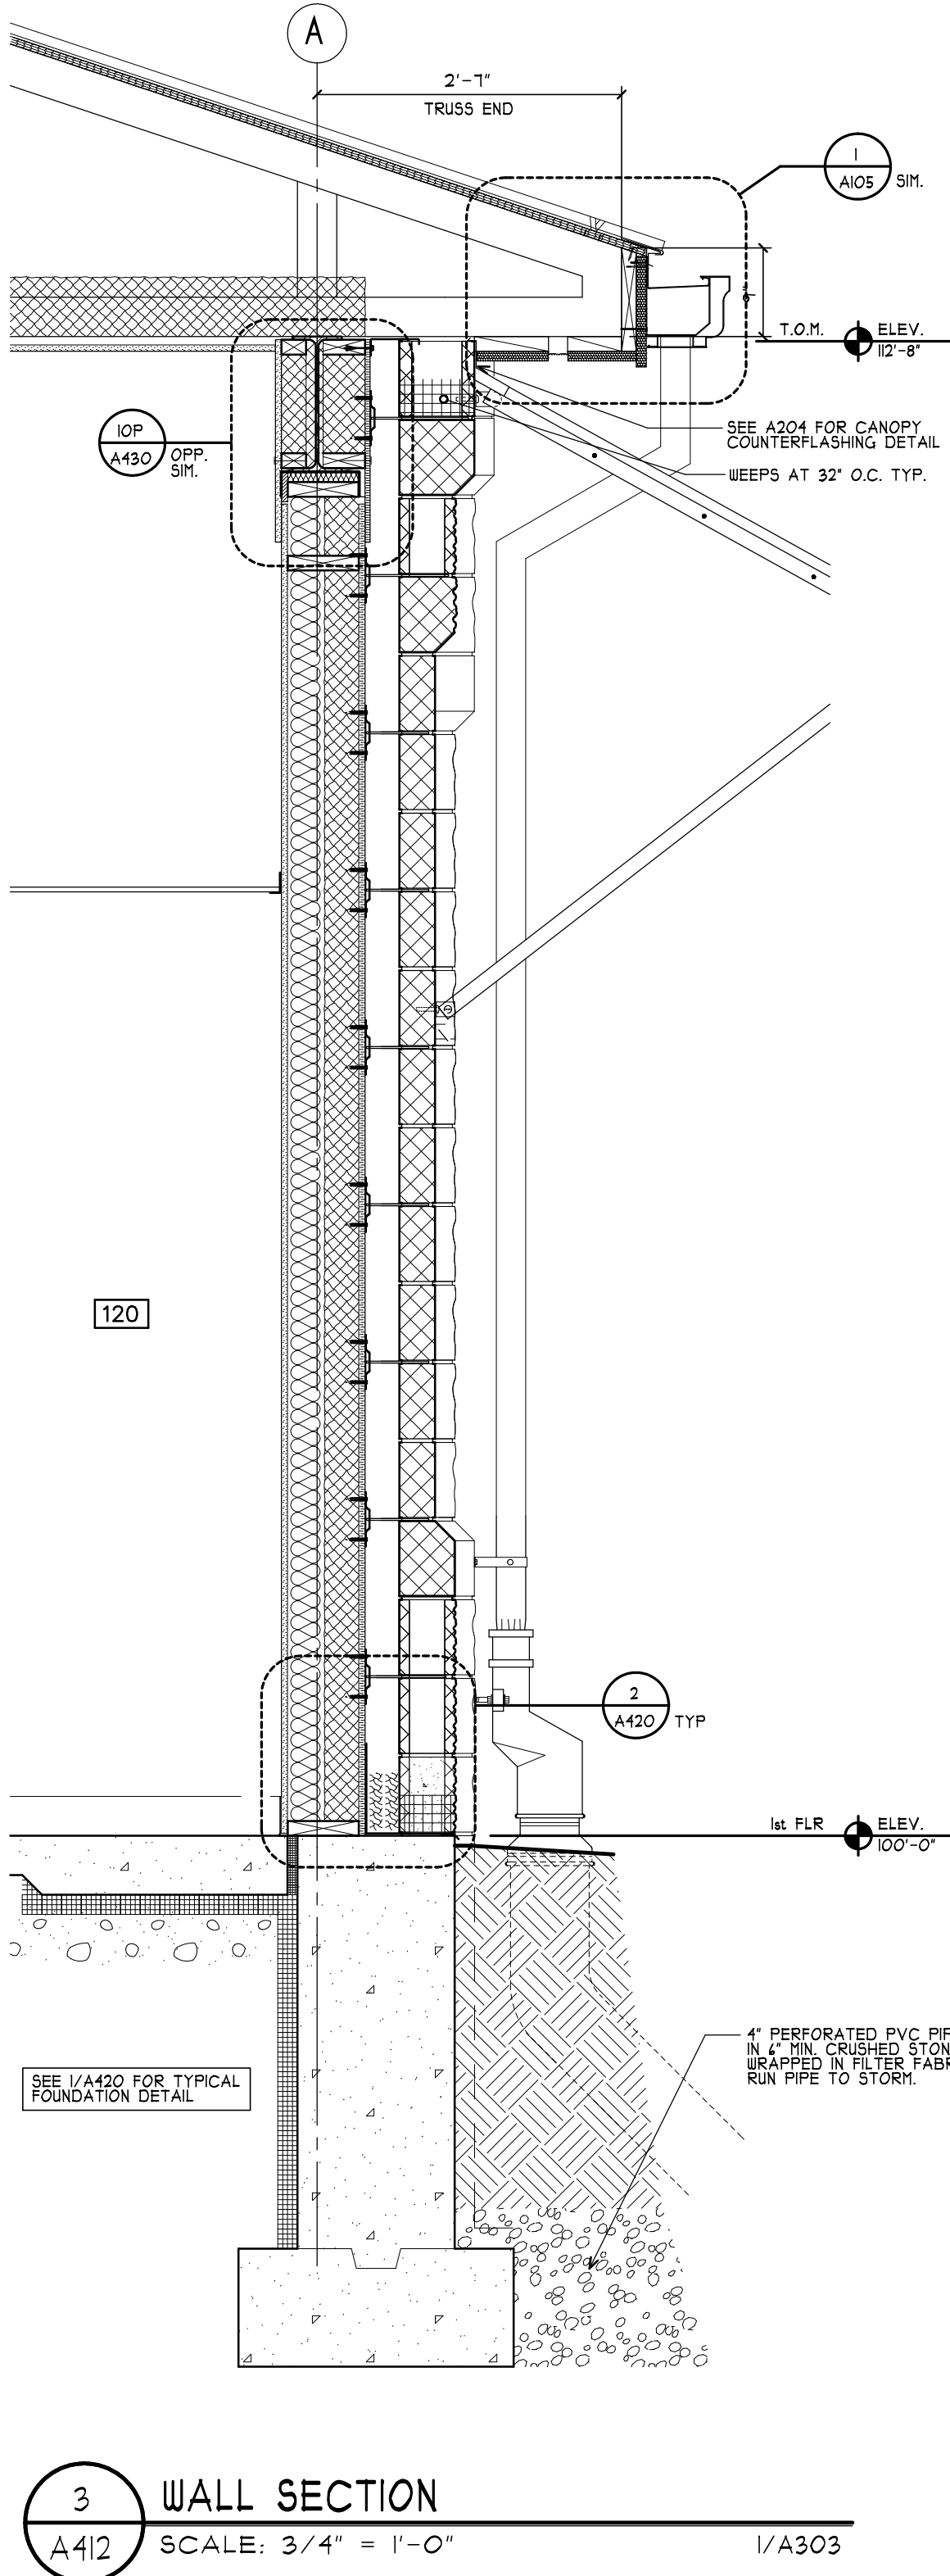
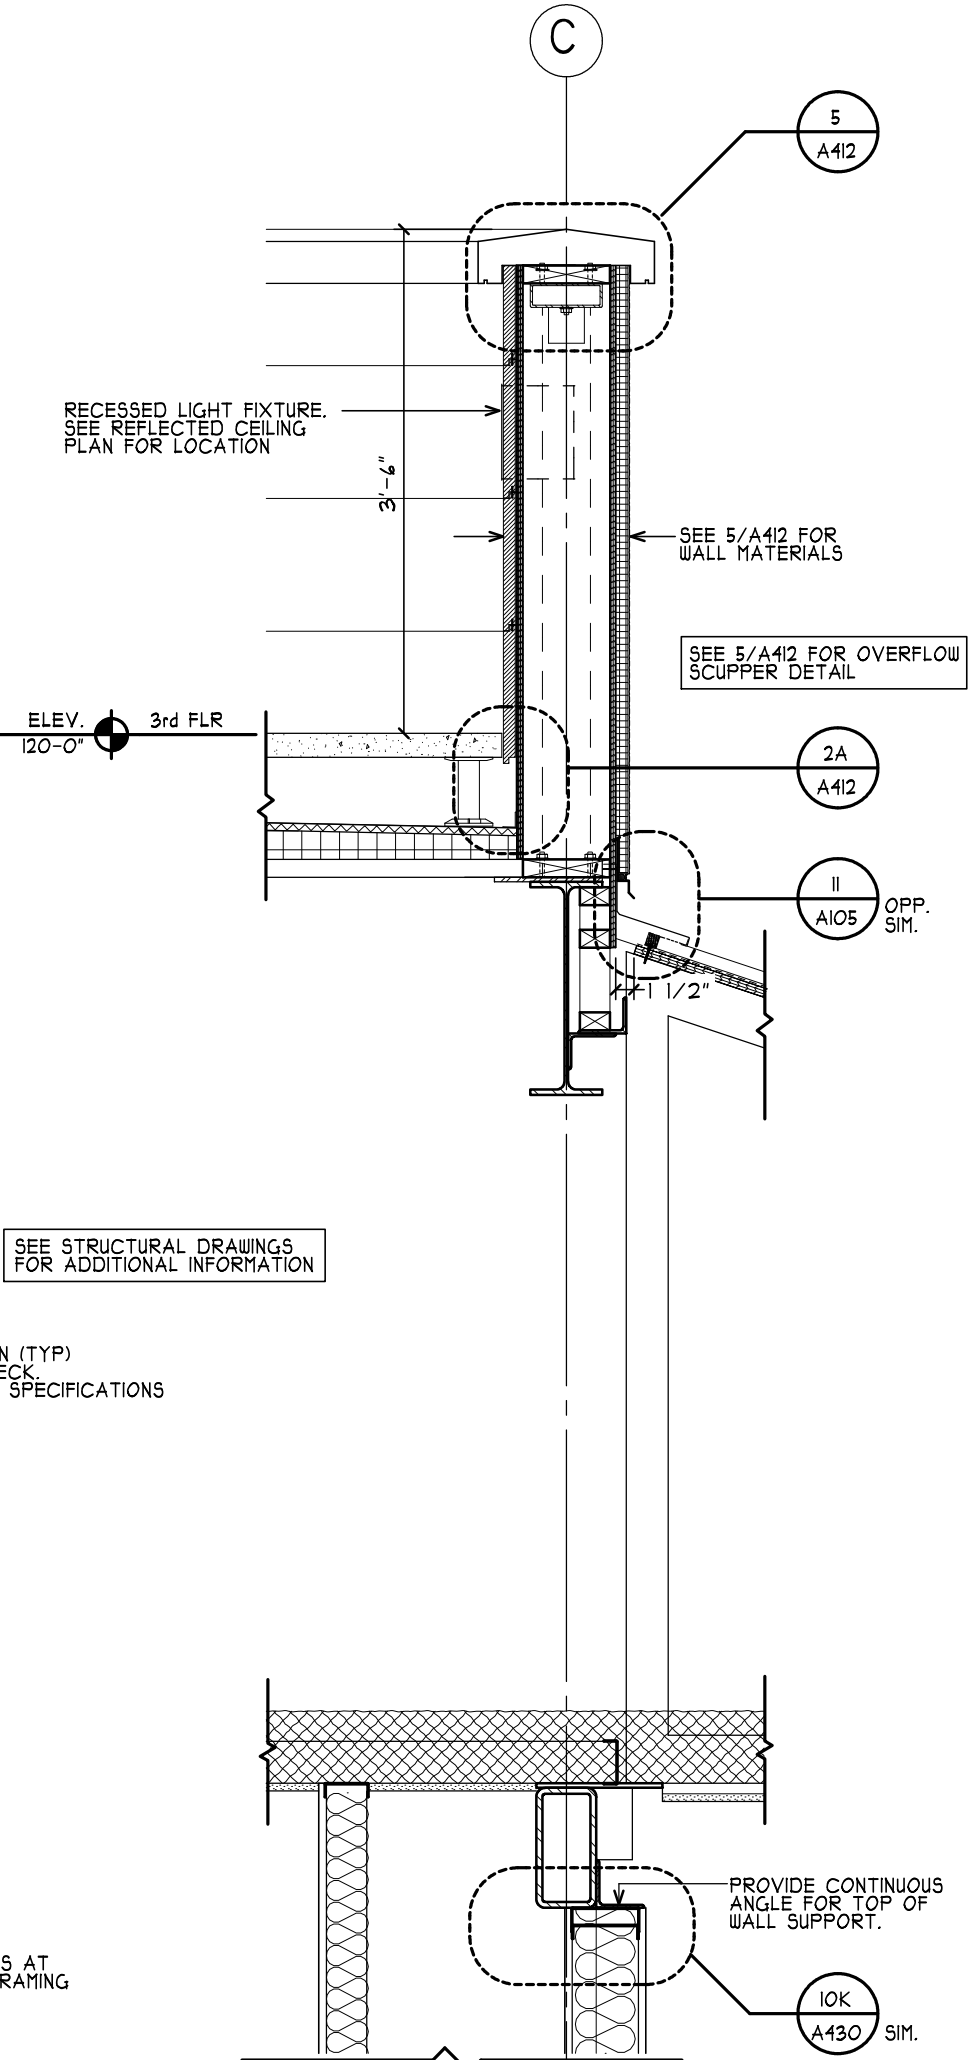
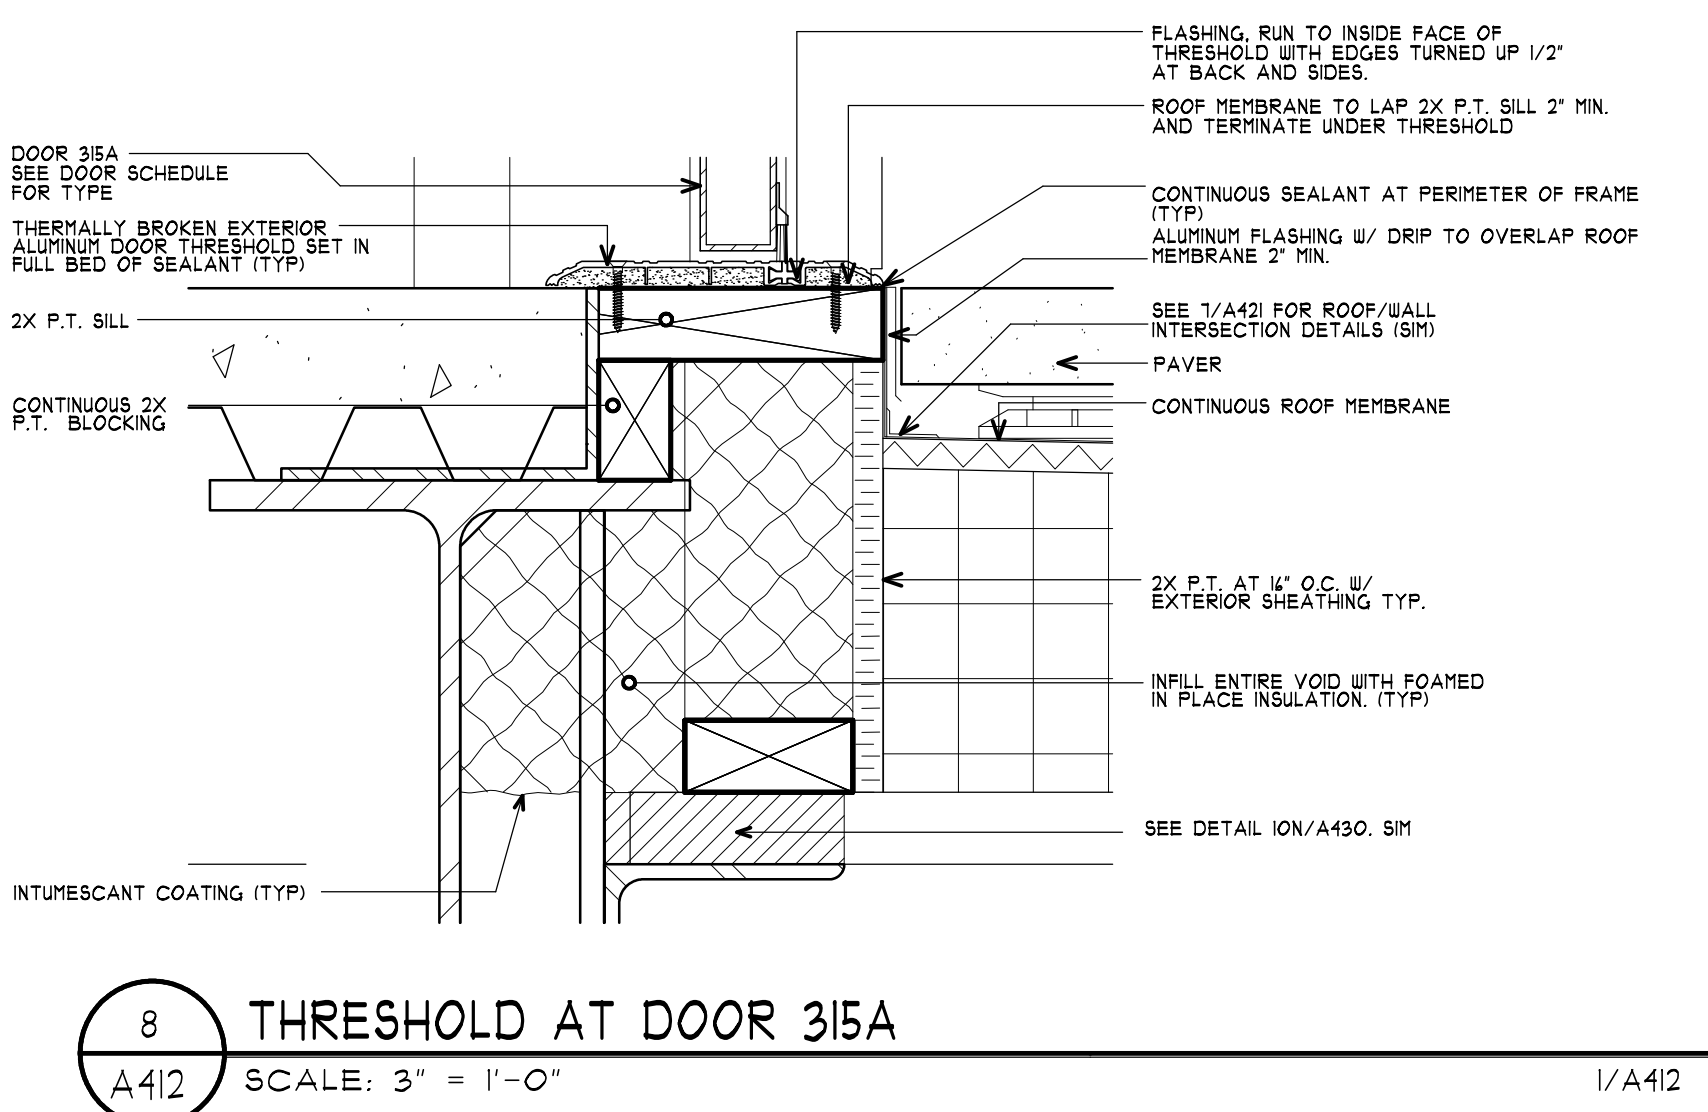
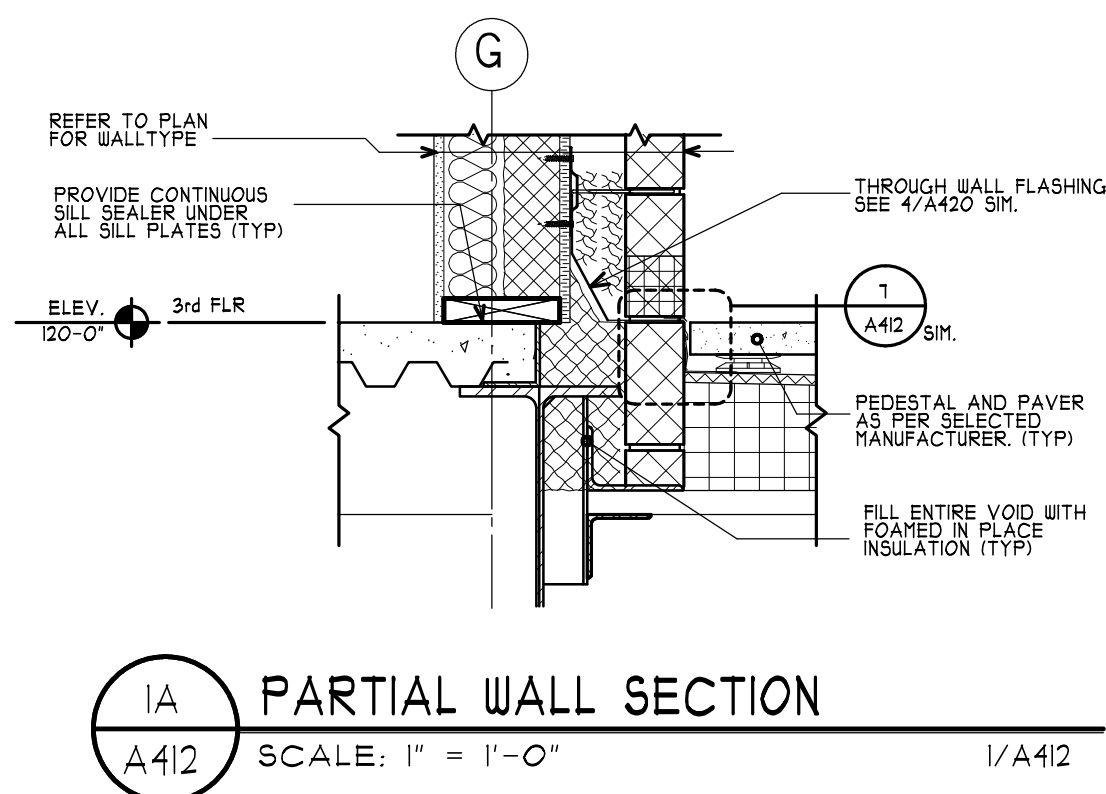


DWG ID#: S:\J Drive\Putnam Valley\PV_A412 Wall Section

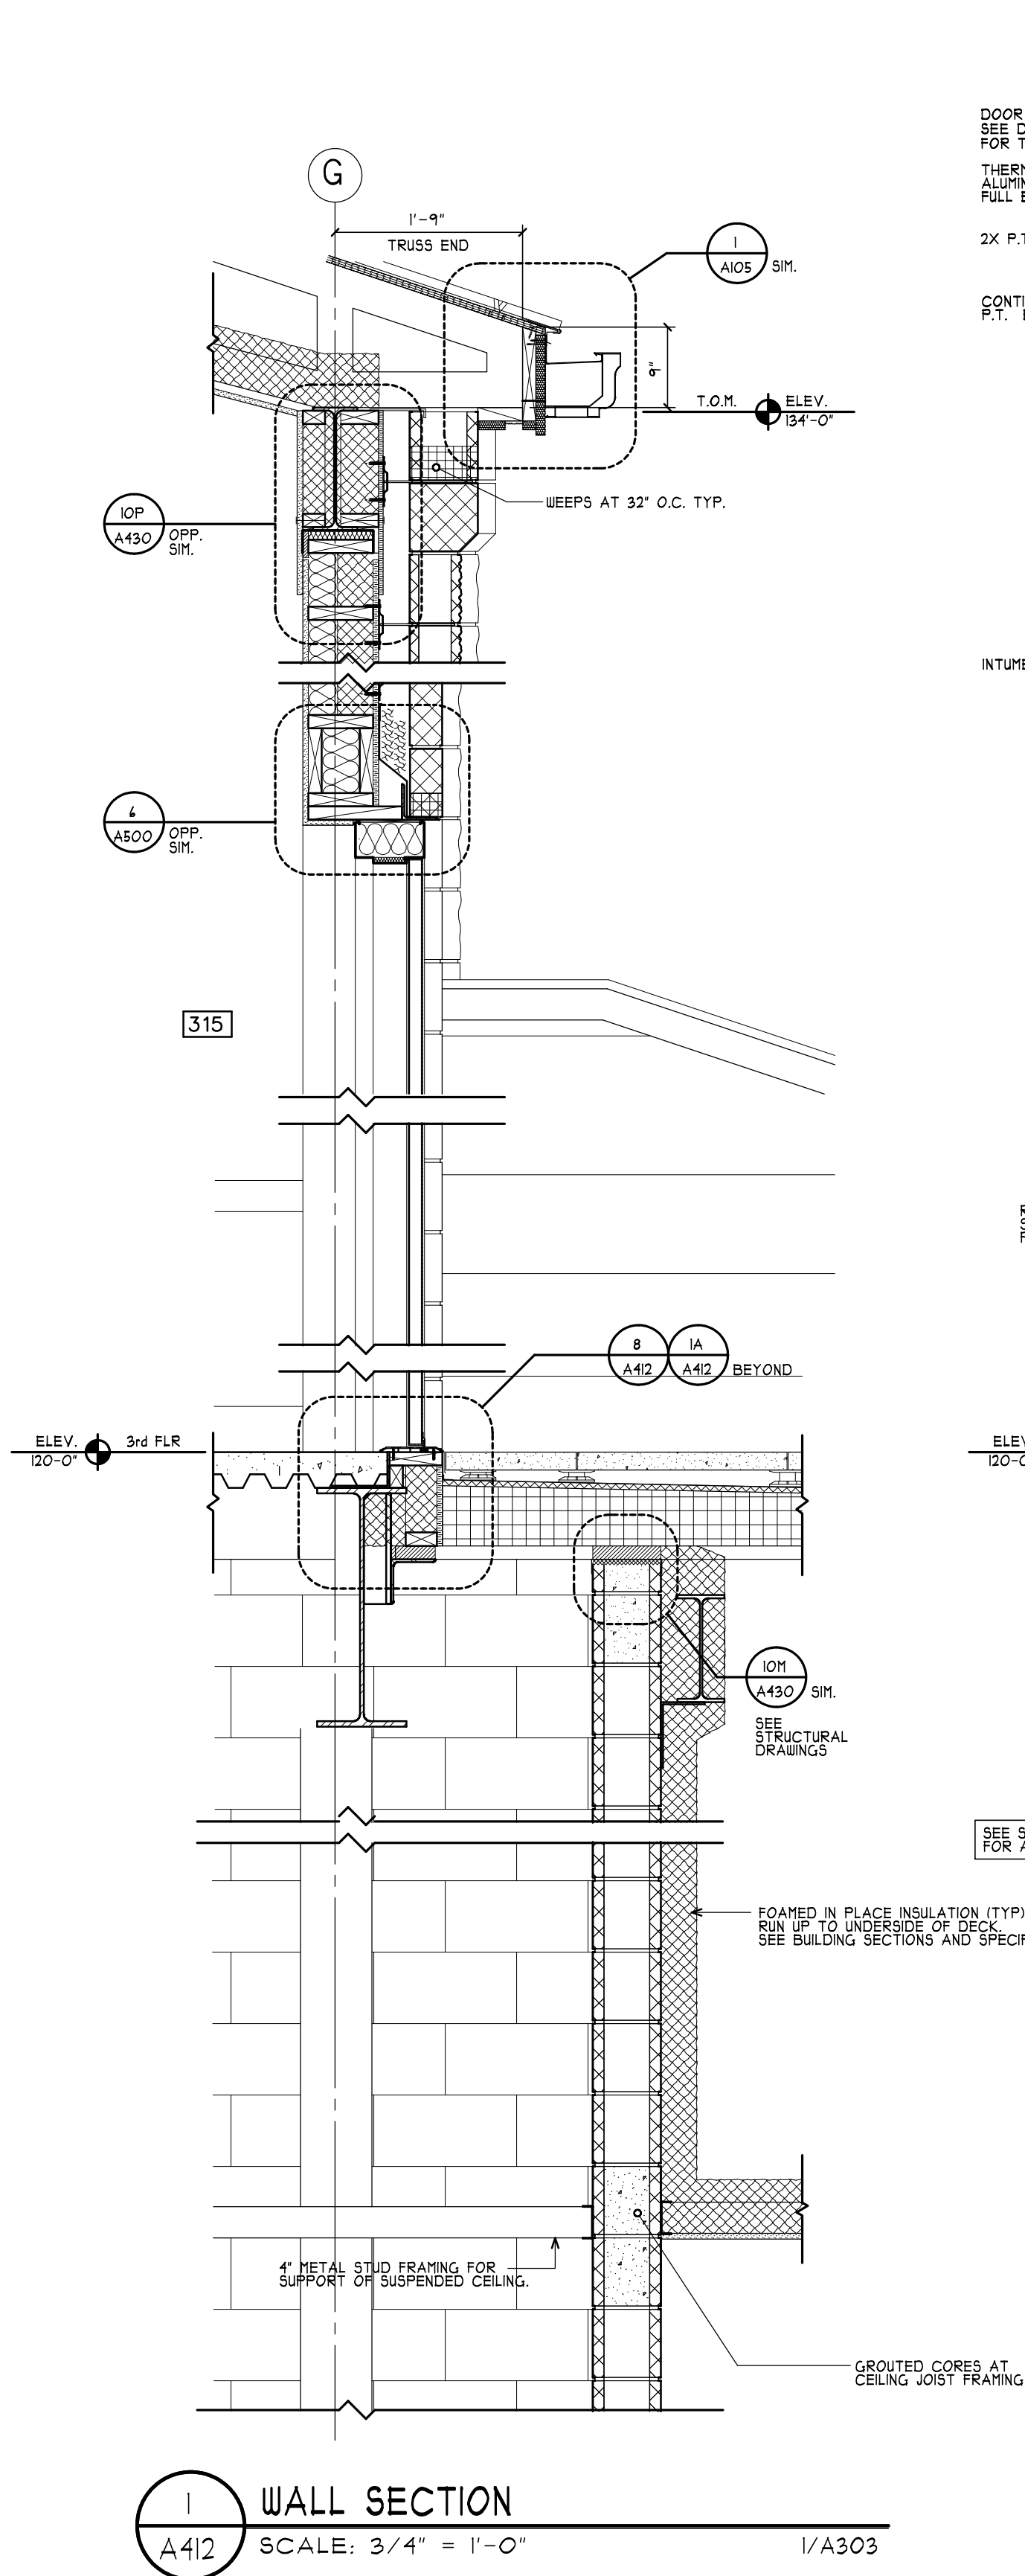

MA

MITCHELL ASSOCIATES ARCHITECTS PLLC

24 THACHER PARK ROAD
VOORHEESVILLE, NY 12186
(518) 745-4571 FAX (518) 745-2950
WWW.MITCHELL-ARCHITECTS.COM

EMERGENCY SERVICE

FACILITIES

CONSULTANTS:

INSITE ENGINEERING SURVEYING & LANDSCAPE ARCHITECTURE, P.C.
3 GARRETT PLACE
CARMEL, NY 10512
(845) 225-4140 FAX: (845) 225-4917

CRAIG A. MALONEY, P.E.
STRUCTURAL ENGINEERING CONSULTANT
3 BENEDICT COURT
BALSTON SPA, NY 12020
(518) 584-4444 FAX: (518) 584-4955

GERARD ASSOCIATES
CONSULTING ENGINEERS, P.C.
MECHANICAL, PLUMBING, AND ELECTRICAL
223 MAIN STREET
GOSHEN, NY 10924
(845) 291-1212 FAX: (845) 291-1939

COPYRIGHT 2020
MITCHELL ASSOCIATES ARCHITECTS
UNAUTHORIZED ALTERATION OR ADDITION
TO THIS DOCUMENT IS A VIOLATION OF LAW

NEW STATION FOR PUTNAM VALLEY FIRE STATION #1

OSCAWANA LAKE ROAD
PUTNAM VALLEY, NEW YORK

REVISION HISTORY	
DATE	DESCRIPTION
▲	
▲	
SCALE: AS NOTED
DWG. BY: JDA
DWG DATE: 8/14/2020
STATUS: BID DRAWINGS

A412

PLT TIME: 2:32 PM