



DWG ID#: S:\V Drive\Putnam Valley\NV_A600

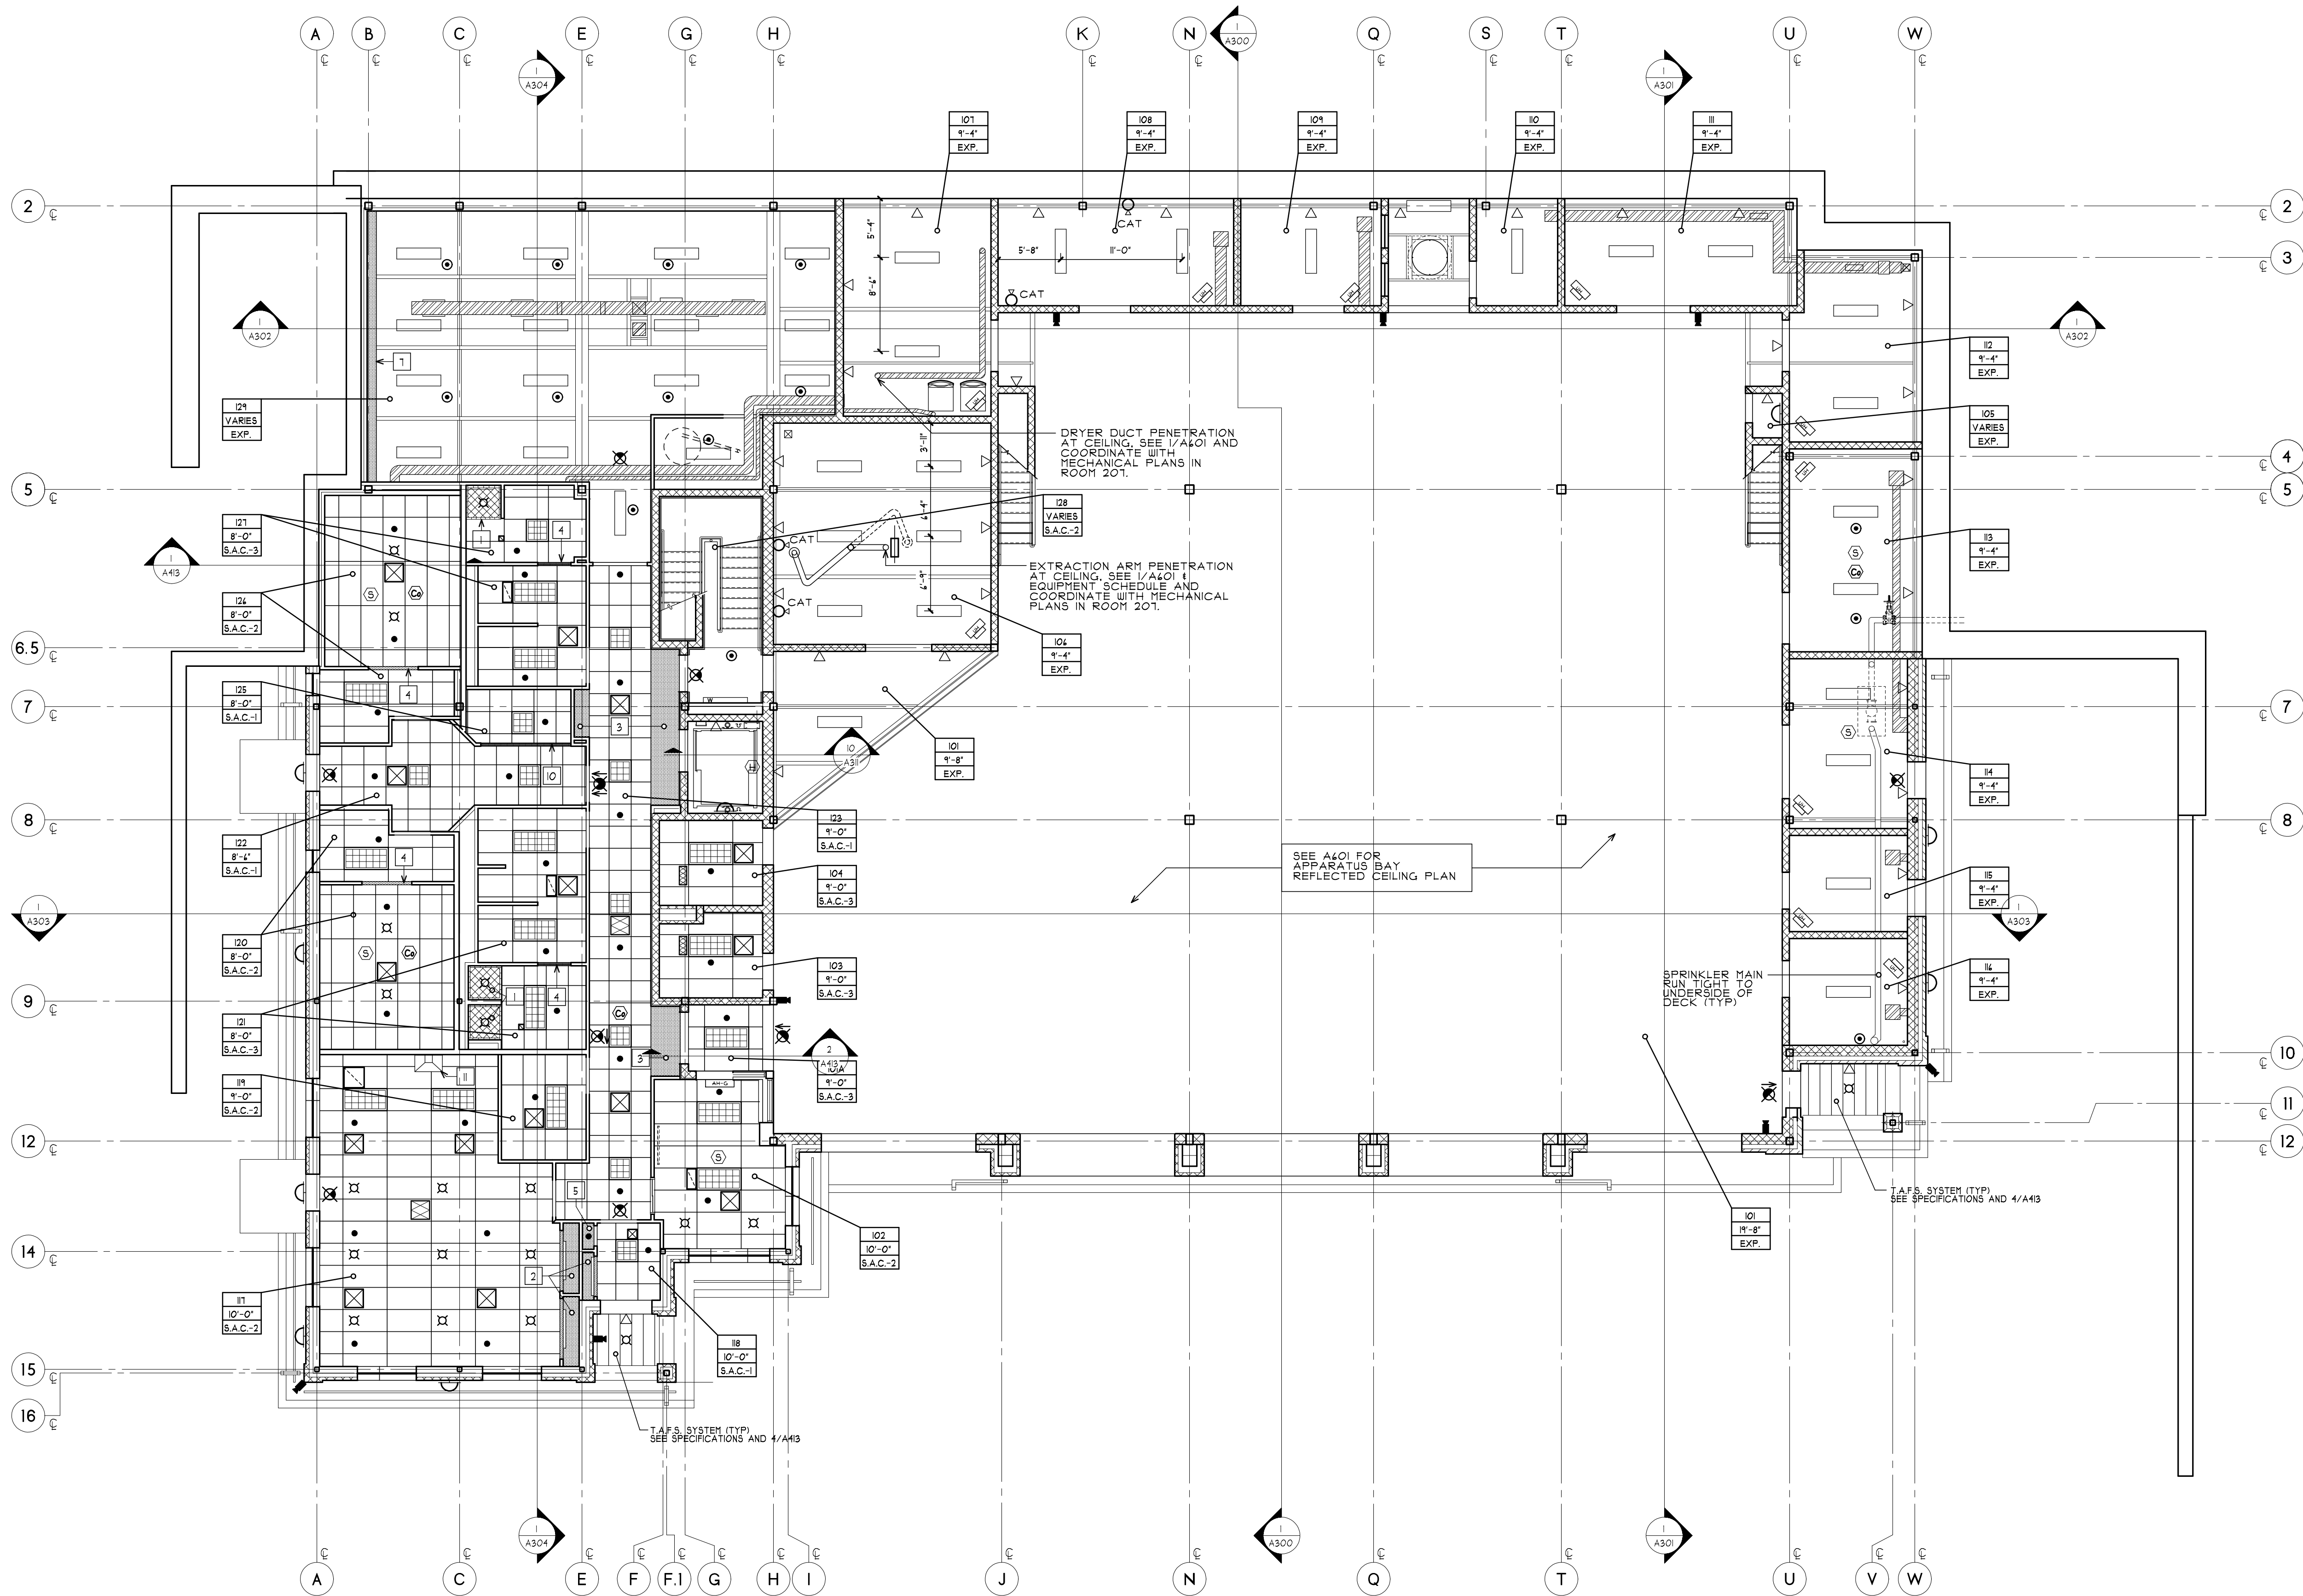

1
A600
1st FLOOR
REFLECTED CEILING PLAN
SCALE: 1/8" = 1'-0"

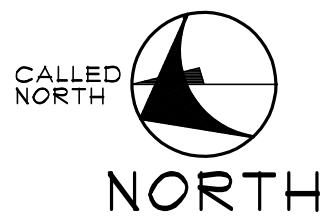

REFLECTED CEILING LEGEND

GENERAL:

- ROOM NUMBER
- CEILING HEIGHT
- CEILING MATERIAL
- G.W.B. CEILING
- S.A.C.-1
ACT CEILING 2X2
CENTER IN ROOM (TYP)
- S.A.C.-2
ACT CEILING 2X4
CENTER IN ROOM (TYP)
- S.A.C.-3
R.R. CEILING 2X4
CENTER IN ROOM (TYP)

LIGHTING:

- 2'x4' LAY-IN
- 2'x2' LAY-IN
- SURFACE MOUNT OR PENDANT MOUNT
LIGHT FIXTURE
(SEE ELECTRICAL DRAWINGS)
- LIGHT FIXTURE, SEE ELECTRICAL DRAWINGS
- UNDER COUNTER LIGHT FIXTURE
- WALL MOUNTED FIXTURE
- RECESSED DOWN LIGHT
- EXIT LIGHT
(FILL INDICATES LETTERED SIDE)
(ARROW INDICATES DIRECTION)

MEFP:

- CLG. DIFFUSER GRILLE
2'x2'
- EXHAUST GRILLE
SEE MECHANICAL DWGS FOR SIZES
- PLENUM RETURN AIR GRILLE
SEE MECHANICAL DWGS FOR SIZES
- SEE "M" DRAWINGS
- DUCTLESS SPLIT HEAT PUMP
SEE MECHANICAL DRAWINGS
- UNIT HEATER
SEE MECHANICAL DRAWINGS
- EXPOSED SPRINKLER
HEAD
- RECESSED SPRINKLER HEAD
- SIDE WALL SPRINKLER HEAD
SEE SPRINKLER DRAWINGS
- DROP SPRINKLER HEAD
SEE SPRINKLER DRAWINGS
- COMBINATION COMPRESSED AIR
DROP AND ELECTRIC POWER
DROP, SEE PLUMBING AND
ELECTRICAL DRAWINGS, FIELD
VERIFY LOCATION WITH
OWNER (TYP)
- ELECTRIC POWER DROP
SEE ELECTRICAL DRAWINGS
(FIELD VERIFY LOCATION W/
OWNER (TYP))
- COMPRESSED AIR
WALL MOUNTED TAP (SEE
PLUMBING DRAWINGS)
(FIELD VERIFY LOCATION W/
OWNER (TYP))
- SMOKE DETECTOR
(SEE ELECTRICAL DRAWINGS)
- HEAT DETECTOR
(SEE ELECTRICAL DRAWINGS)
- CEILING FAN
- CARBON MONOXIDE DETECTOR
(SEE ELECTRICAL DRAWINGS)
- SPEAKER
(SEE ELECTRICAL DRAWINGS FOR
EXTENT OF INSTALLATION)
- FUTURE SECURITY CAMERA
(SEE ELECTRICAL DRAWINGS FOR
EXTENT OF INSTALLATION)

GENERAL NOTES


- SEE BUILDING SECTIONS AND ELEVATIONS FOR LIGHT
FIXTURE HEIGHTS, U.O.N.
- REFER TO MEFP AND FIRE PROTECTION DRAWINGS
FOR ADDITIONAL INFORMATION.

RCP KEY NOTES

- SEE 1/A120 FOR SHOWER SOFFIT NOTES
- DISPLAY CASE, SEE DETAIL 9/A130
- G.W.B. SOFFIT # 8'-4"
- G.W.B. SOFFIT # 1'-4"
- G.W.B. SOFFIT # 9'-0"
- G.W.B. SOFFIT # 8'-8"
- G.W.B. SOFFIT # 8'-0"
- G.W.B. SOFFIT # 11'-4"
- PROJECTOR MOUNT SEE A100'S AND EQUIPMENT
SCHEDULE.
- G.W.B. SOFFIT # 1'-4"
- PROVIDE A S.S. DUCTWORK EXTENSION TO ABOVE THE S.A.C.
OF THE SAME MATERIAL AS THE RANGE HOOD DUCT.
- 2X30 INSULATED ACCESS HATCH, COORDINATE WITH TRUSS
LOCATION, SEE SPECIFICATIONS
- G.W.B. SOFFIT # 4" BELOW S.A.C. HEIGHT, 3 1/2" METAL
SLIDS WITH 5/8" SHEETROCK (TYP) OPENING TO BE
LOCATED IN ROOM UP TO UNDERSIDE OF TRUSS BEARING AT
ACCESS HATCH, COORDINATE ALL DIMENSIONS WITH ACCESS
HATCH PLACEMENT AND TRUSS LOCATION.

1st FLOOR ROOM LEGEND

NO.	NAME	NO.	NAME
101	APPARATUS BAY	11	HYDRATION ROOM
102	VESTIBULE	12	BAY ROOM
103	RADIO ROOM	13	VESTIBULE
104	UNISEX LAVATORY	14	CLOSET
105	JANITOR	15	H.K. STORAGE
106	RED BAG	16	BUNK ROOM #1
107	ENGINEER'S WORK ROOM	17	BOY'S LAV/SHOWER
108	LAUNDRY	18	CORRIDOR
109	COMPRESSOR	19	ELEVATOR
110	GEAR STORAGE	20	HOUSEKEEPING
111	STORAGE #1	21	BUNK ROOM #2
112	HOSE STORAGE	22	BOY'S LAV/SHOWER
113	ELECTRICAL	23	STAIR
114	FIRE PUMP	24	EXERCISE
115	DECON	25	PUMP ROOM

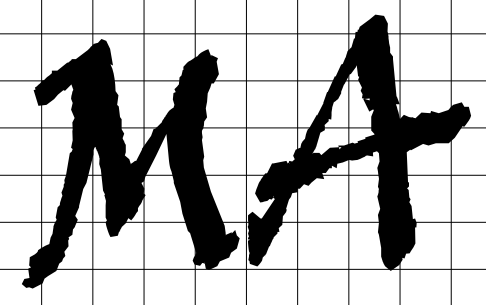

**MITCHELL
ASSOCIATES
ARCHITECTS
PLLC**

24 THACHER PARK ROAD
VOORHEESVILLE, NY 12186
(518) 745-4511 FAX (518) 745-2950
WWW.MITCHELL-ARCHITECTS.COM

EMERGENCY SERVICE

FACILITIES

CONSULTANTS:

INSITE ENGINEERING SURVEYING
LANDSCAPE ARCHITECTURE, P.C.
3 GARRETT PLACE
CARMEL, NY 12052
(845) 225-4100 FAX: (845) 225-4117

CRAIG A. MALONEY, P.E.
STRUCTURAL ENGINEERING CONSULTANT
3 BENEDICT COURT
BALLSTON SPA, NY 12020
(518) 584-4444 FAX: (518) 584-4455

GERARD ASSOCIATES
CONSULTING ENGINEERS, P.C.
MECHANICAL, PLUMBING,
AND ELECTRICAL
223 MAIN STREET
GOSHEN, NY 10924
(845) 291-1212 FAX: (845) 291-1934

COPYRIGHT 2020
MITCHELL ASSOCIATES ARCHITECTS
UNAUTHORIZED ALTERATION OR ADDITION
TO THIS DOCUMENT IS A VIOLATION OF LAW

NEW STATION FOR PUTNAM VALLEY FIRE STATION #1

OSCAWANA LAKE ROAD
PUTNAM VALLEY, NEW YORK

REVISION HISTORY

DATE	DESCRIPTION

1st FLOOR REFLECTED CEILING PLAN

SCALE: 1/8" = 1'-0"
DWG. BY: JDA
DWG DATE: 8/14/2020
STATUS: BID DRAWINGS

A600