

MITCHELL ASSOCIATES ARCHITECTS PLLC

29 THACHER PARK ROAD
VOORHEESVILLE, NY 12186
(518) 745-4571 FAX (518) 745-2950
WWW.MITCHELL-ARCHITECTS.COM

EMERGENCY SERVICE FACILITIES

CONSULTANTS:
INSITE ENGINEERING SURVEYING & LANDSCAPE ARCHITECTURE, P.C.
3 GARRETT PLACE
CARMEL, NY 12012
(845) 225-9100 FAX: (845) 225-9111

CRAIG A. MALONEY, P.E.
STRUCTURAL ENGINEERING CONSULTANT
3 BENEDICT COURT
BALLSTON SPA, NY 12020
(518) 584-9444 FAX: (518) 584-9455

GERARD ASSOCIATES CONSULTING ENGINEERS, P.C.
MECHANICAL, PLUMBING, AND ELECTRICAL
223 MAIN STREET
GOSHEN, NY 10924
(845) 291-2112 FAX: (845) 291-9334

COPYRIGHT 2022
MITCHELL ASSOCIATES ARCHITECTS
UNAUTHORIZED ALTERATION OR ADDITION
TO THIS DOCUMENT IS A VIOLATION OF LAW

NEW STATION FOR PUTNAM VALLEY FIRE STATION #1

OSCAWANA LAKE ROAD
PUTNAM VALLEY, NEW YORK

REVISION HISTORY	
DATE	DESCRIPTION

2nd FLOOR REFLECTED CEILING PLAN

SCALE: 1/8" = 1'-0"
DWG. BY: JDA
DUG DATE: 8/14/2020
STATUS: BID DRAWINGS

A601

REFLECTED CEILING LEGEND

GENERAL:

- ROOM NUMBER
- CEILING HEIGHT
- CEILING MATERIAL
- G.W.B. CEILING
- S.A.C.-1 ACT CEILING 2X2 CENTER IN ROOM (TYP)
- S.A.C.-2 ACT CEILING 2X4 CENTER IN ROOM (TYP)
- S.A.C.-3 ACT CEILING 2X4 CENTER IN ROOM (TYP)

LIGHTING:

- 2'x4' LAY-IN
- 2'x2' LAY-IN
- SURFACE MOUNT OR PENDANT MOUNT LIGHT FIXTURE (SEE ELECTRICAL DRAWINGS)
- LIGHT FIXTURE. SEE ELECTRICAL DRAWINGS
- UNDER COUNTER LIGHT FIXTURE
- WALL MOUNTED FIXTURE
- RECESSED DOWN LIGHT
- EXIT LIGHT (FILL INDICATES LETTERED SIDE) (ARROW INDICATES DIRECTION)

MEFP:


- CLG. DIFFUSER GRILLE 2'x2'
- EXHAUST GRILLE (SEE MECHANICAL DWGS FOR SIZES)
- PLENUM RETURN AIR GRILLE (SEE MECHANICAL DWGS FOR SIZES)
- SEE 'M' DRAWINGS
- DUCTLESS SPLIT HEAT PUMP (SEE MECHANICAL DRAWINGS)
- UNIT HEATER (SEE MECHANICAL DRAWINGS)
- EXPOSED SPRINKLER HEAD
- RECESSED SPRINKLER HEAD
- SIDE WALL SPRINKLER HEAD (SEE SPRINKLER DRAWINGS)
- DROP SPRINKLER HEAD (SEE SPRINKLER DRAWINGS)
- COMBINATION COMPRESSED AIR DROP AND ELECTRIC POWER DROP (SEE PLUMBING AND ELECTRICAL DRAWINGS) (FIELD VERIFY LOCATION W/ OWNER (TYP))
- ELECTRIC POWER DROP (SEE ELECTRICAL DRAWINGS) (FIELD VERIFY LOCATION W/ OWNER (TYP))
- COMPRESSED AIR WALL MOUNTED TAP (SEE PLUMBING DRAWINGS) (FIELD VERIFY LOCATION W/ OWNER (TYP))
- SMOKE DETECTOR (SEE ELECTRICAL DRAWINGS)
- HEAT DETECTOR (SEE ELECTRICAL DRAWINGS)
- CEILING FAN
- CARBON MONOXIDE DETECTOR (SEE ELECTRICAL DRAWINGS)
- SPEAKER (SEE ELECTRICAL DRAWINGS FOR EXTENT OF INSTALLATION)
- FUTURE SECURITY CAMERA (SEE ELECTRICAL DRAWINGS FOR EXTENT OF INSTALLATION)

GENERAL NOTES

- SEE BUILDING SECTIONS AND ELEVATIONS FOR LIGHT FIXTURE HEIGHTS. U.O.N.
- REFER TO MEFP AND FIRE PROTECTION DRAWINGS FOR ADDITIONAL INFORMATION.

RCP KEY NOTES

- SEE 1/A120 FOR SHOWER SOFFIT NOTES
- DISPLAY CASE. SEE DETAIL 1/A130
- G.W.B. SOFFIT # 8'-4"
- G.W.B. SOFFIT # 7'-4"
- G.W.B. SOFFIT # 9'-0"
- G.W.B. SOFFIT # 8'-8"
- G.W.B. SOFFIT # 8'-0"
- G.W.B. SOFFIT # 11'-4"
- PROJECTOR MOUNT SEE A100'S AND EQUIPMENT SCHEDULE.
- G.W.B. SOFFIT # 7'-4"
- PROVIDE A 3/8" DIA. DUCTWORK EXTENSION TO ABOVE THE S.A.C. OF THE SAME MATERIAL AS THE RANGE HOOD DUCT.
- 2X2X0 INSULATED ACCESS HATCH. COORDINATE WITH TRUSS LOCATION. SEE SPECIFICATIONS.
- G.W.B. SOFFIT # 4" BELOW S.A.C. HEIGHT. 3 1/2" METAL STUDS WITH 5/8" SHEETROCK (TYP) OPENING TO BE SHEETROCK UP TO UNDERSIDE OF TRUSS SHEATHING AT ACCESS HATCH. COORDINATE ALL DIMENSIONS WITH ACCESS HATCH PLACEMENT AND TRUSS LOCATION.

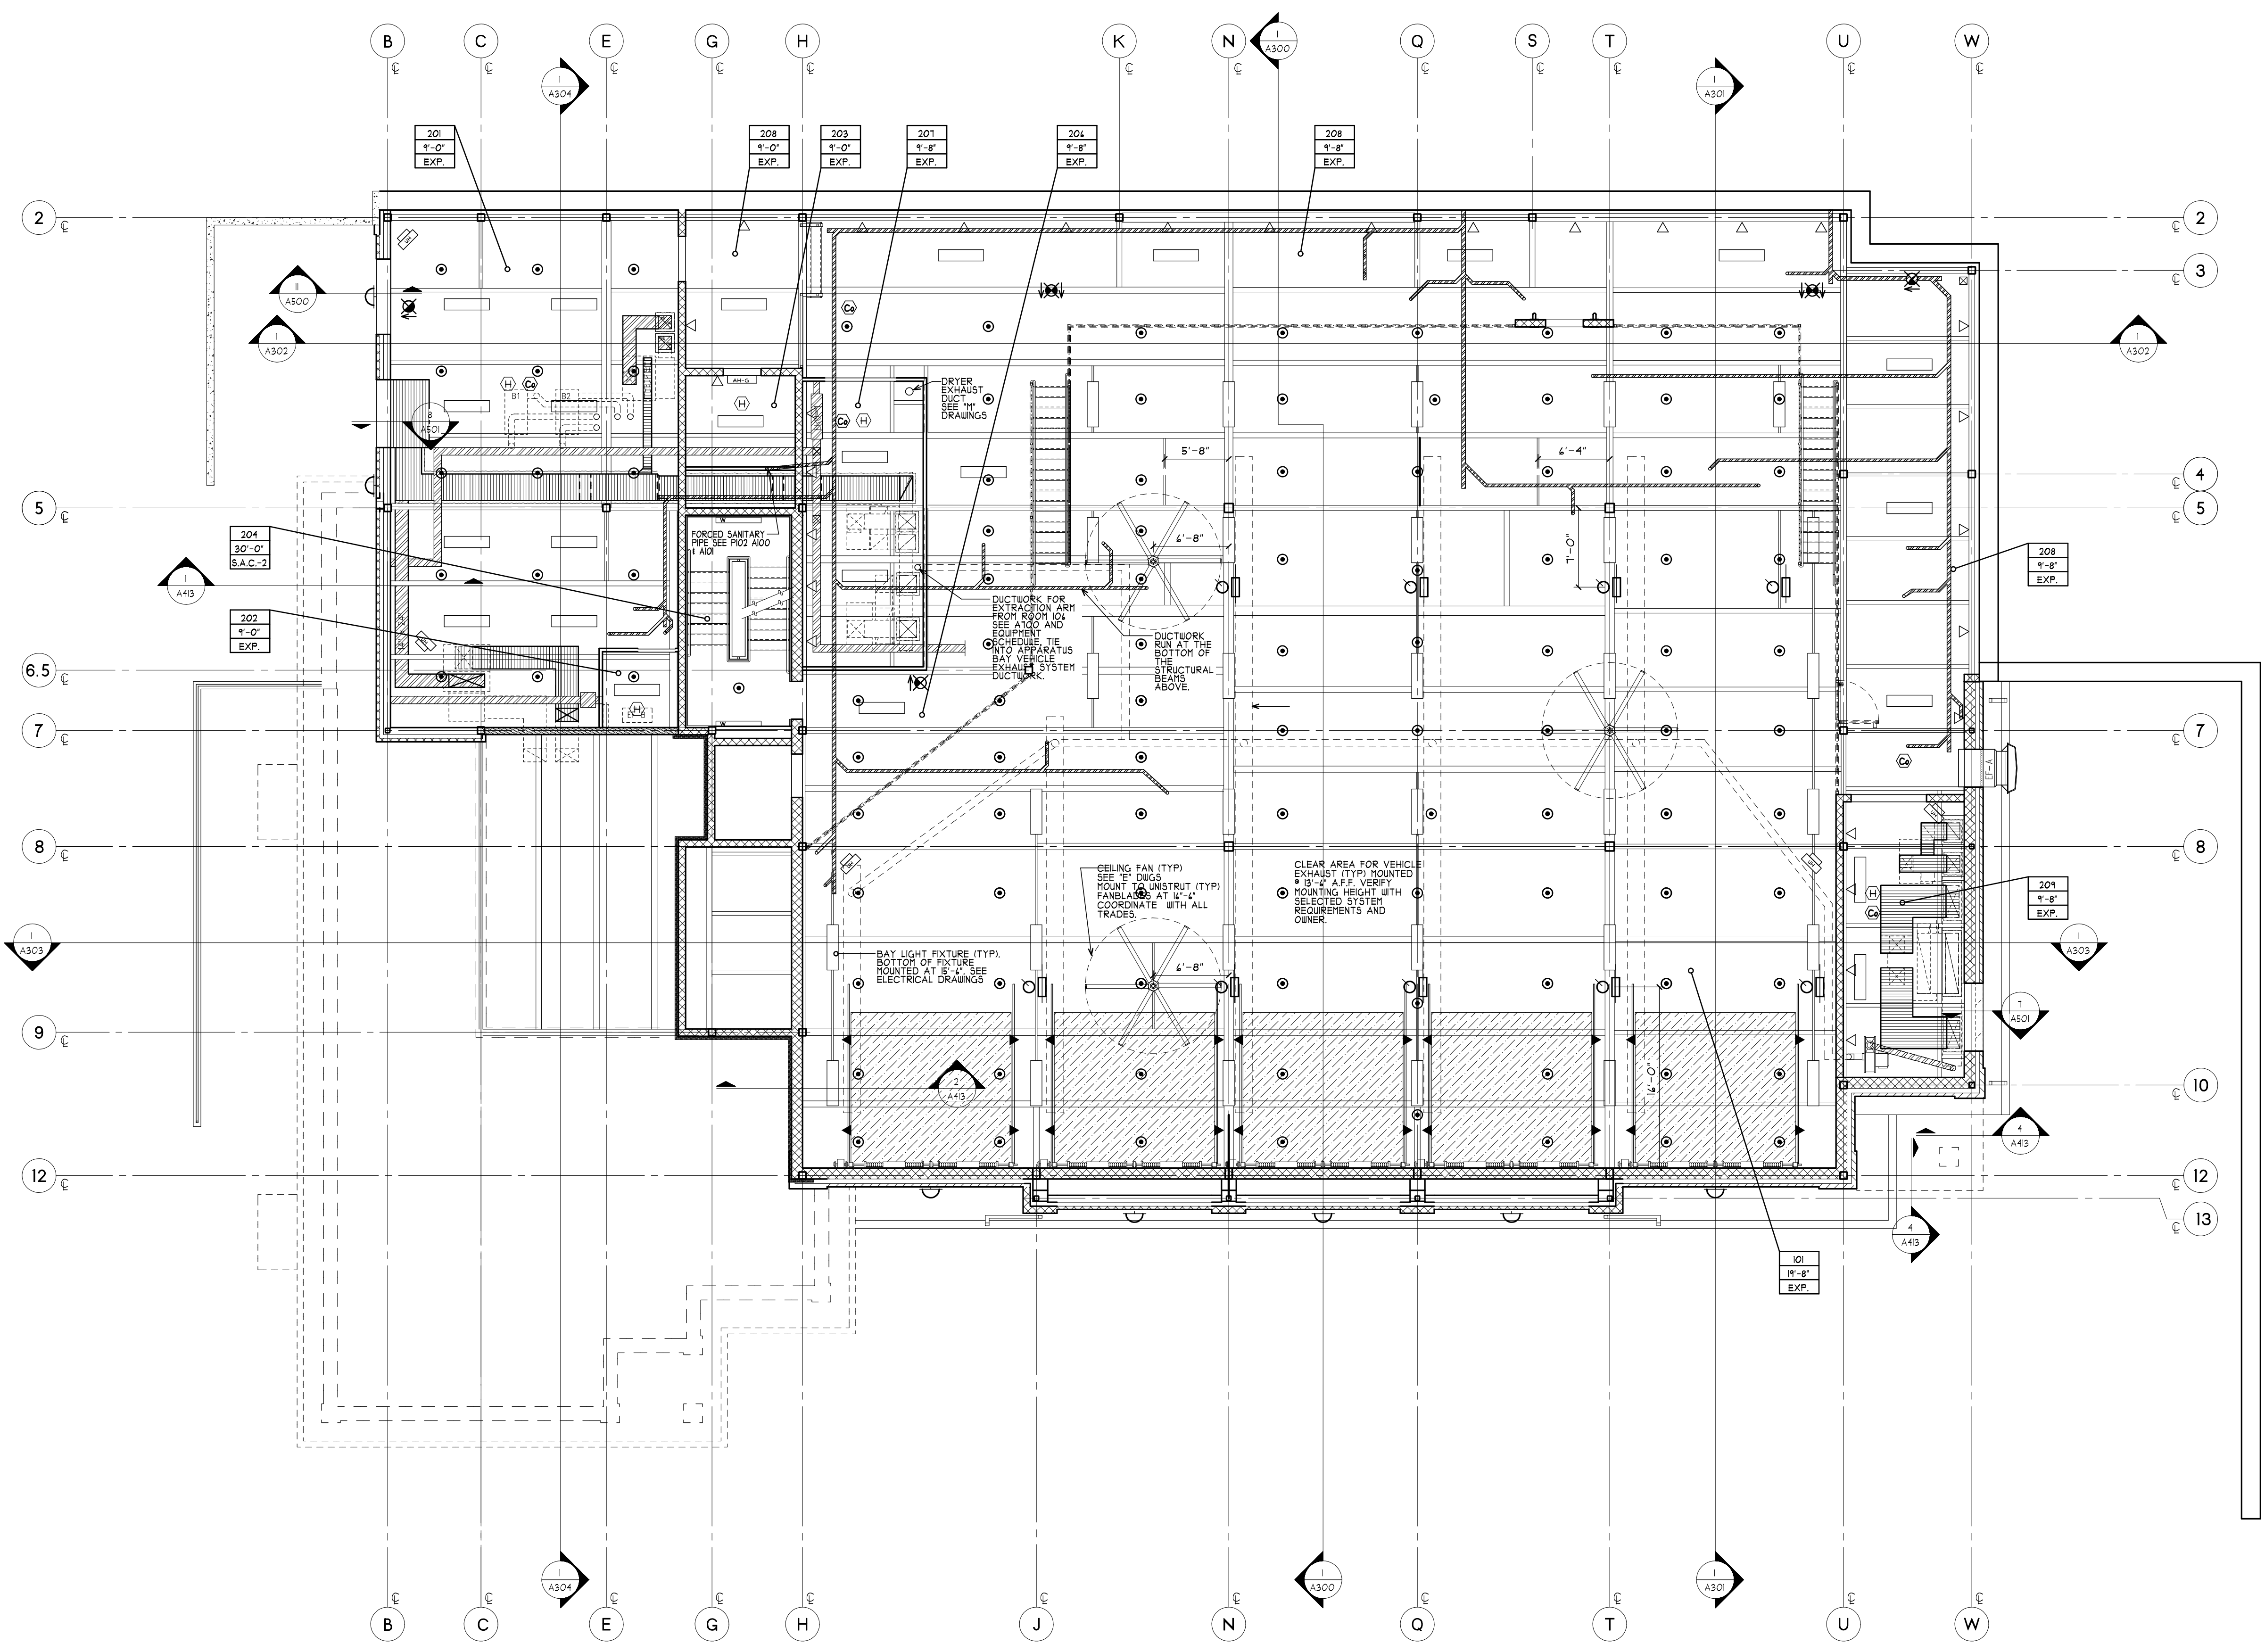

2nd FLOOR REFLECTED CEILING PLAN
SCALE: 1/8" = 1'-0"
CALLED NORTH

2nd FLOOR ROOM LEGEND

NO.	NAME	NO.	NAME
201	BOILER/ELEC ROOM	204	MEZZANINE
202	ELEVATOR MACHINE ROOM	205	MECHANICAL 1
203	SERVER	208	MEZZANINE
204	STAR	209	MECHANICAL 2
205	ELEVATOR		