
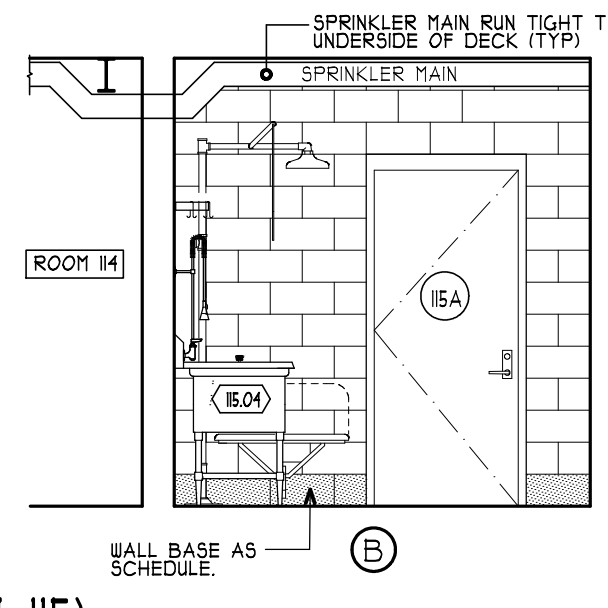
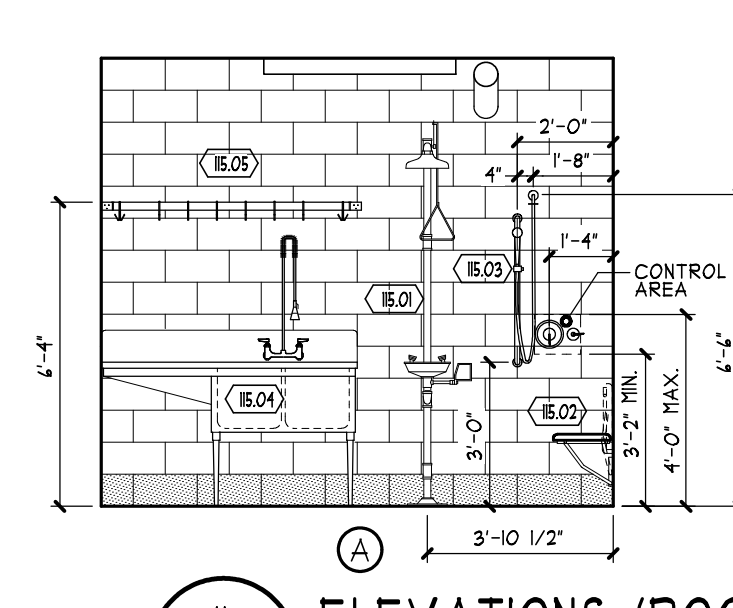
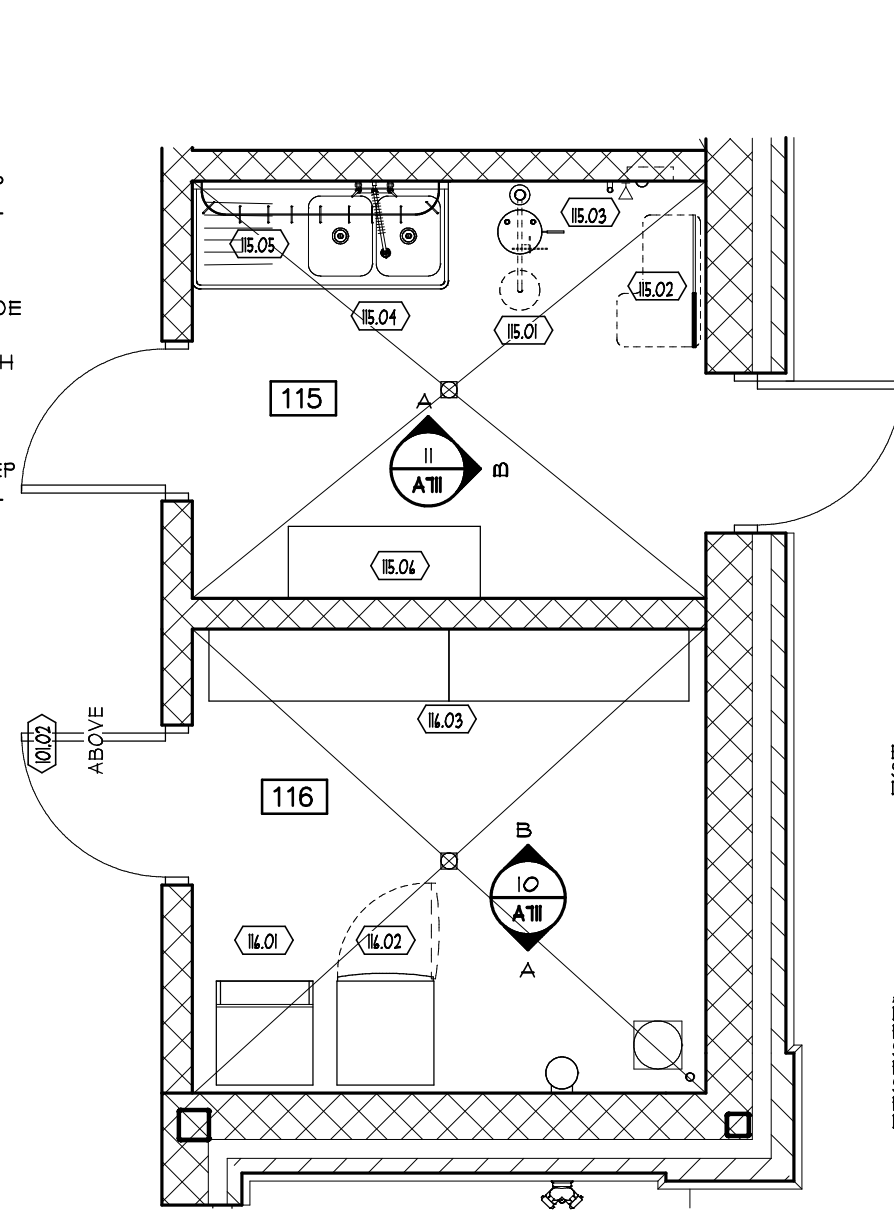
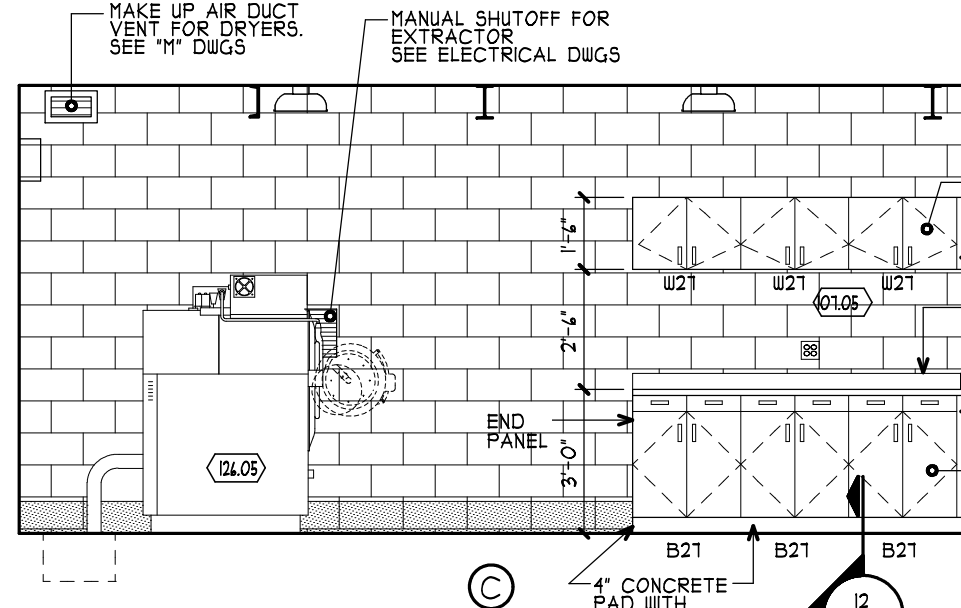
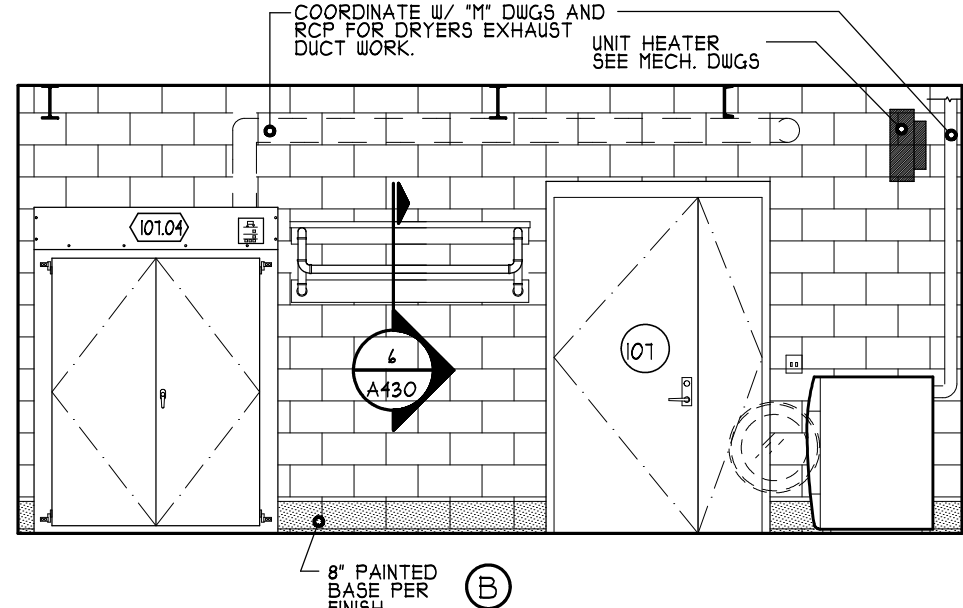


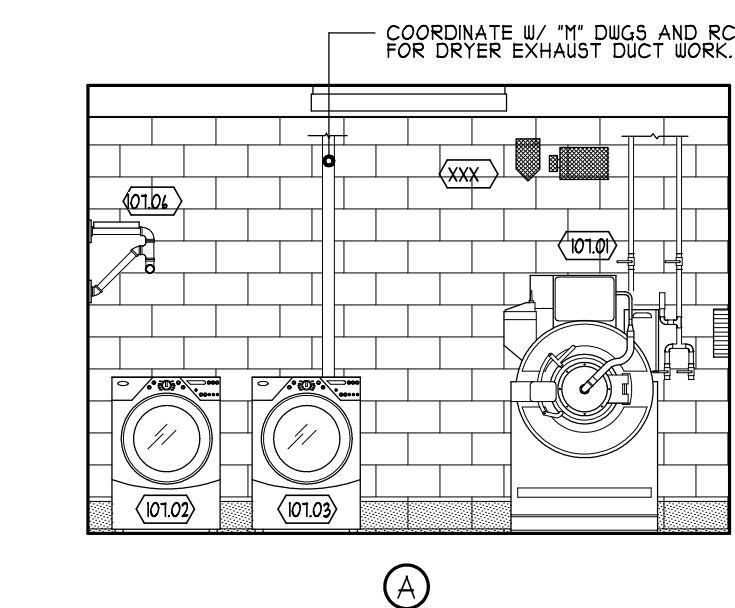



CASEWORK GENERAL NOTES	
1.	SEE SPECIFICATION FOR FF#E DESIGNATIONS. (EXX)
2.	SEE DWG A730 FOR CASEWORK SECTIONS AND DETAILS.

CASEWORK LEGEND	
CABINET TYPE:	CABINET WIDTH (IN.)
B	BASE CABINET W/TOP DRAWER, (D) ADJUSTABLE HEIGHT SHELF
BC	CORNER BASE CABINET
SDB	SLIDING DRAWER BASE CABINET, NO DRAWERS
#DB	DRAWER BASE CABINET WITH (R: 2, 3, 4, 5) DRAWERS
SB	SINK BASE W/FALSE DRAWER FRONT, NO SHELVES
SBC	SINK BASE CORNER UNIT W/FALSE DRAWER FRONT, NO SHELVES
TC	TALL CABINET, SEE DWG FOR HEIGHT
BBF	BOX, BOX FILE BASE CABINET
W	WALL CABINET W/ (D) ADJUSTABLE HEIGHT SHELVES
WC	WALL CORNER CABINET W/ (D) ADJUSTABLE HEIGHT SHELVES
WO	OPEN-FRONT WALL CABINET W/ (D) ADJUSTABLE HEIGHT SHELVES



CASEWORK NOTES:

- ALL COUNTERTOPS TO BE 2'-0" DEEP WITH 4" SIDE AND BACKSPASH WHERE COUNTERTOPS ABUT WALLS, UNLESS OTHERWISE NOTED.
- ALL SINKS TO BE CENTERED IN BASE CABINETS UNLESS OTHERWISE NOTED.
- ALL COUNTERTOPS TO BE SCRIBED TO UNLESS OTHERWISE NOTED.
- ALL BASE CABINETS TO BE 2'-0" DEEP UNLESS OTHERWISE NOTED.
- ALL WALL CABINETS TO BE 1'-0" DEEP UNLESS OTHERWISE NOTED.
- PROVIDE FILLER STRIPS WHERE CABINETS ABUT WALLS AND CORNERS AND WHERE NECESSARY TO ALLOW PROPER OPERATION OF DOORS, DRAWERS AND APPLIANCES.
- PROVIDE FINISHED END PANELS WHERE CABINET ENDS ARE EXPOSED.
- TOP SURFACES OF ALL WALL CABINETS THAT ARE NOT TIGHT TO A SOFFIT SHALL HAVE NO GAPS OR VOIDS.
- COORDINATE LAYOUT OF CABINETS WITH ANY APPLIANCES.
- PROVIDE ADEQUATE BLOCKING IN ALL WALLS WHERE CABINETS, SHELVING OR EQUIPMENT ARE TO BE MOUNTED.




8 ELEVATIONS (ROOM 107)
A711 SCALE: 1/4" = 1'-0"

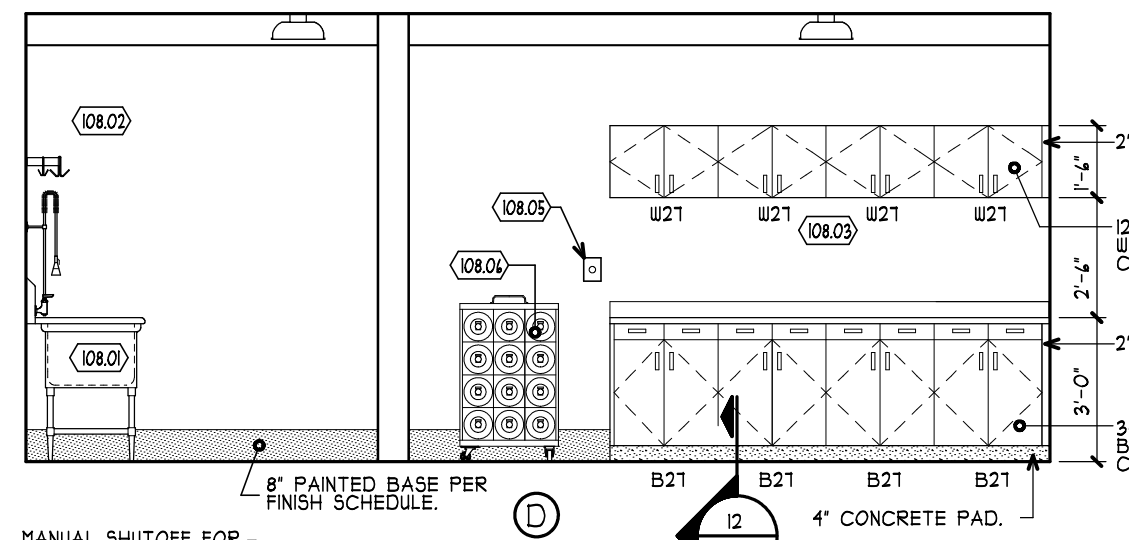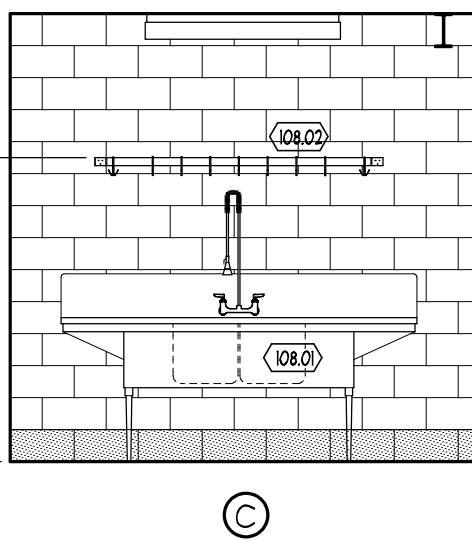




8A EXTRACTOR ELEVATION (ROOM 107)
A711 SCALE: 1/4" = 1'-0"

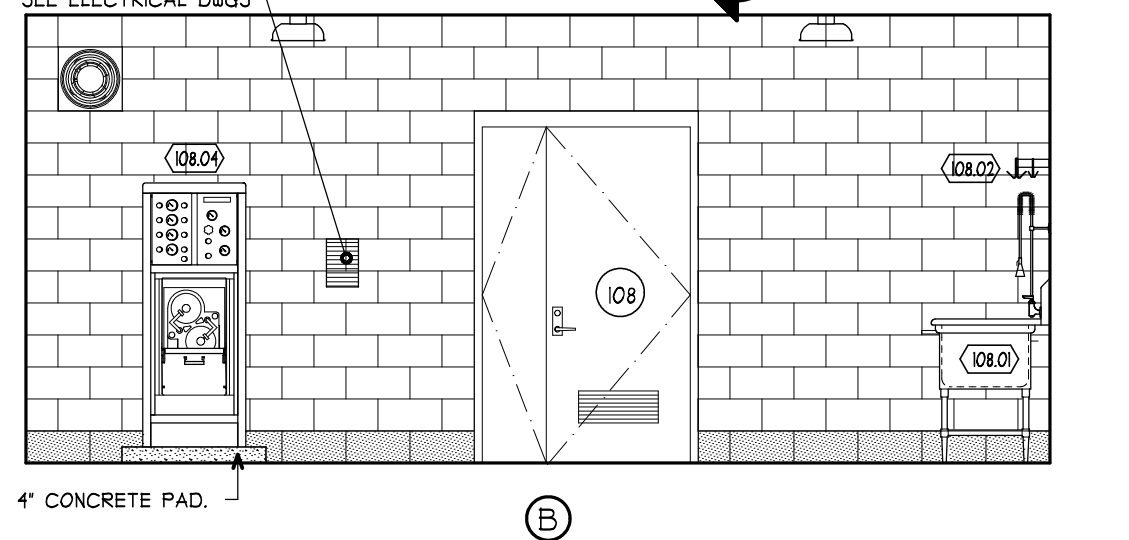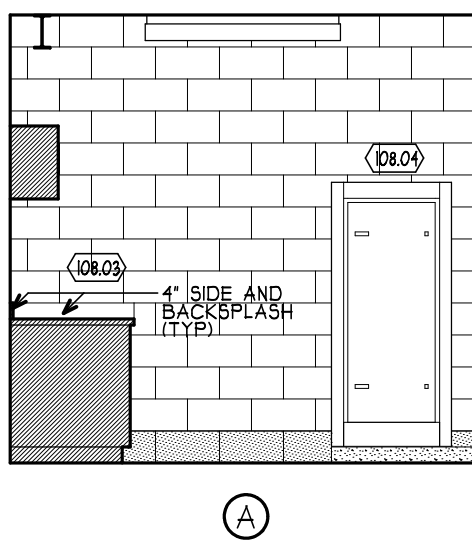



1 ELEVATIONS (ROOM 108)
A711 SCALE: 1/4" = 1'-0"

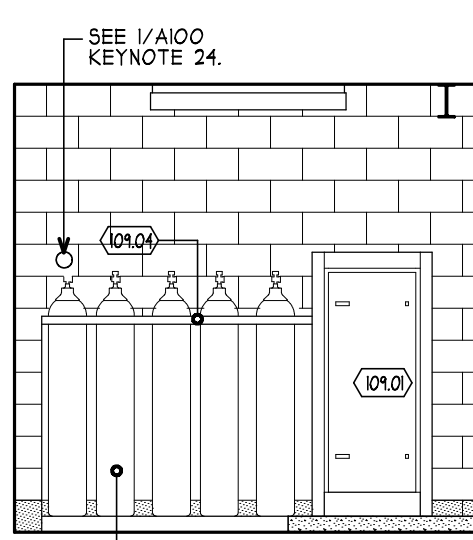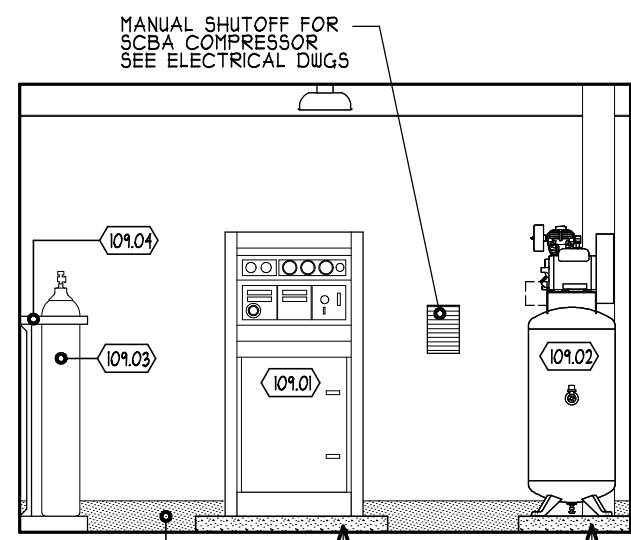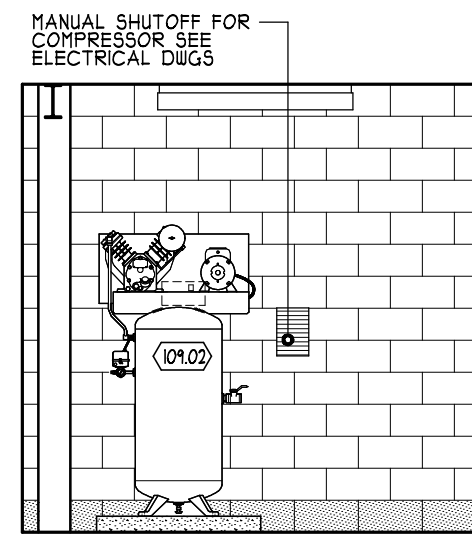

6 ELEVATIONS (ROOM 109)
A711 SCALE: 1/4" = 1'-0"

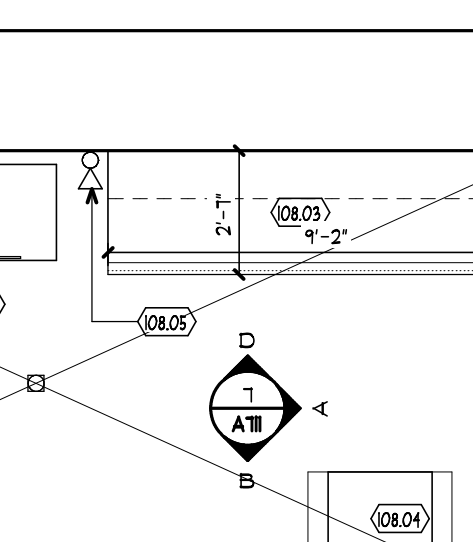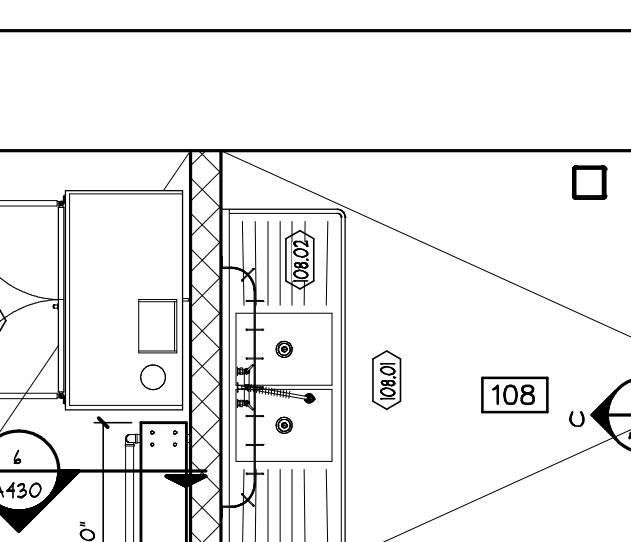
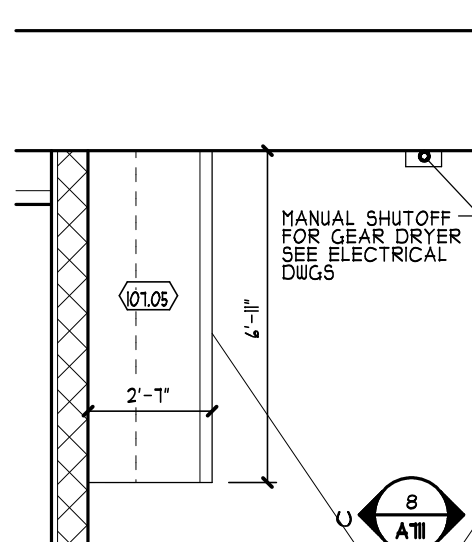


5A EXTRACTOR TROUGH
A711 SCALE: 1/2" = 1'-0"

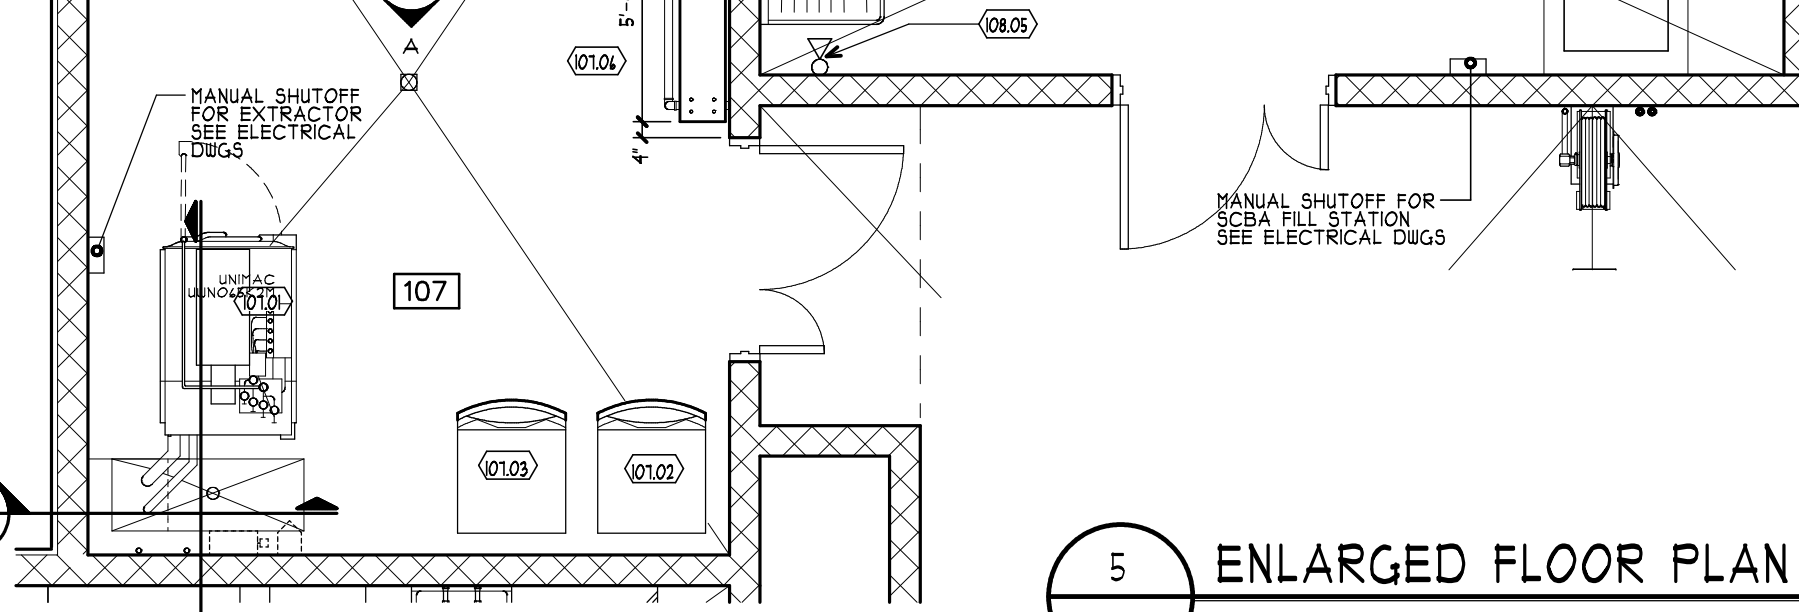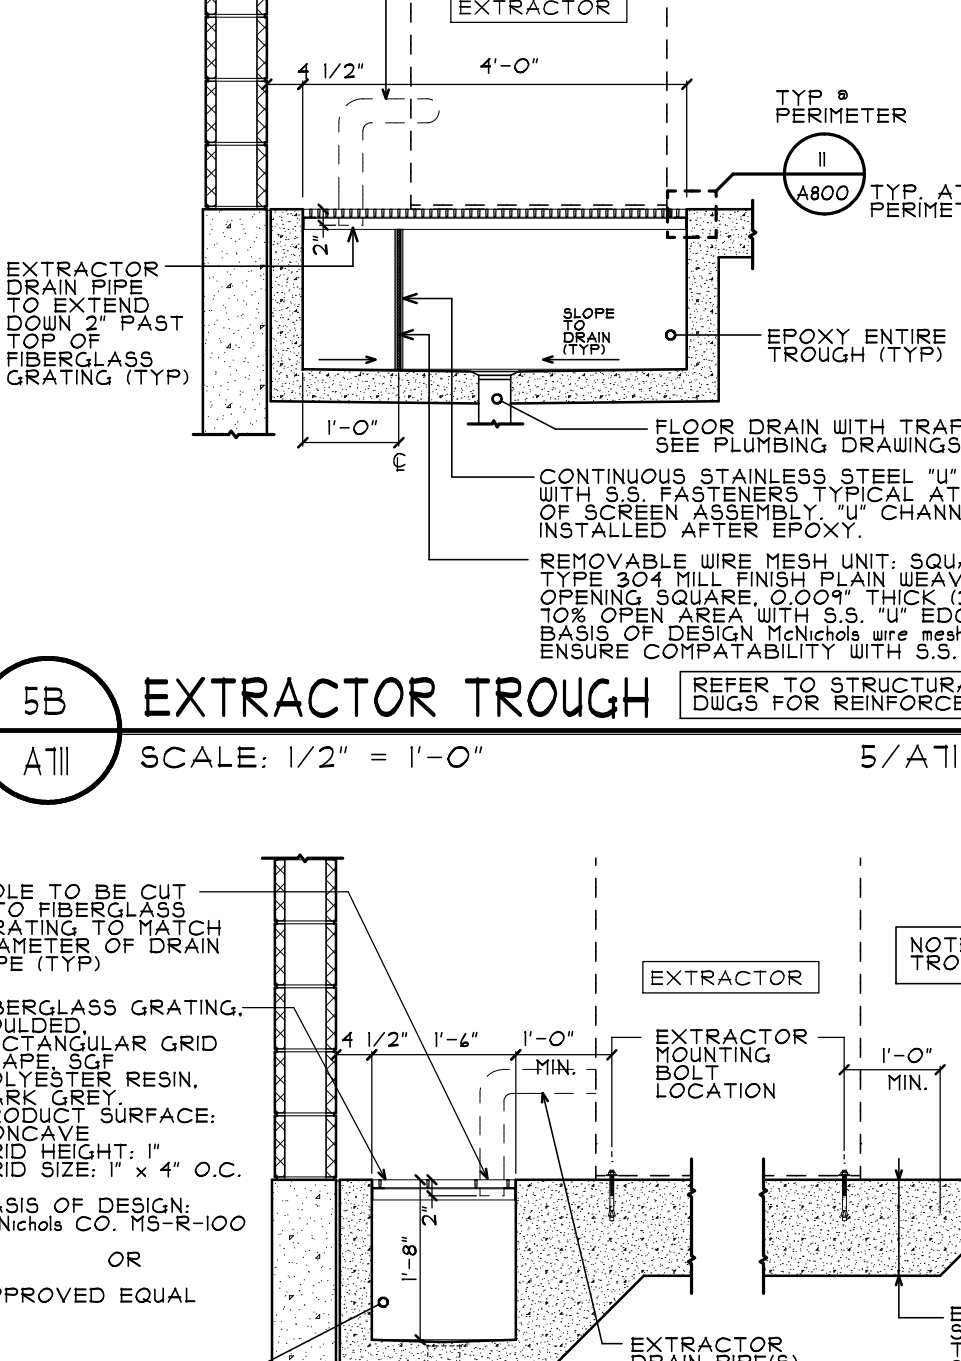





5 ENLARGED FLOOR PLAN
A711 SCALE: 1/4" = 1'-0"

2 ELEVATIONS (ROOM 110)
A711 SCALE: 1/4" = 1'-0"



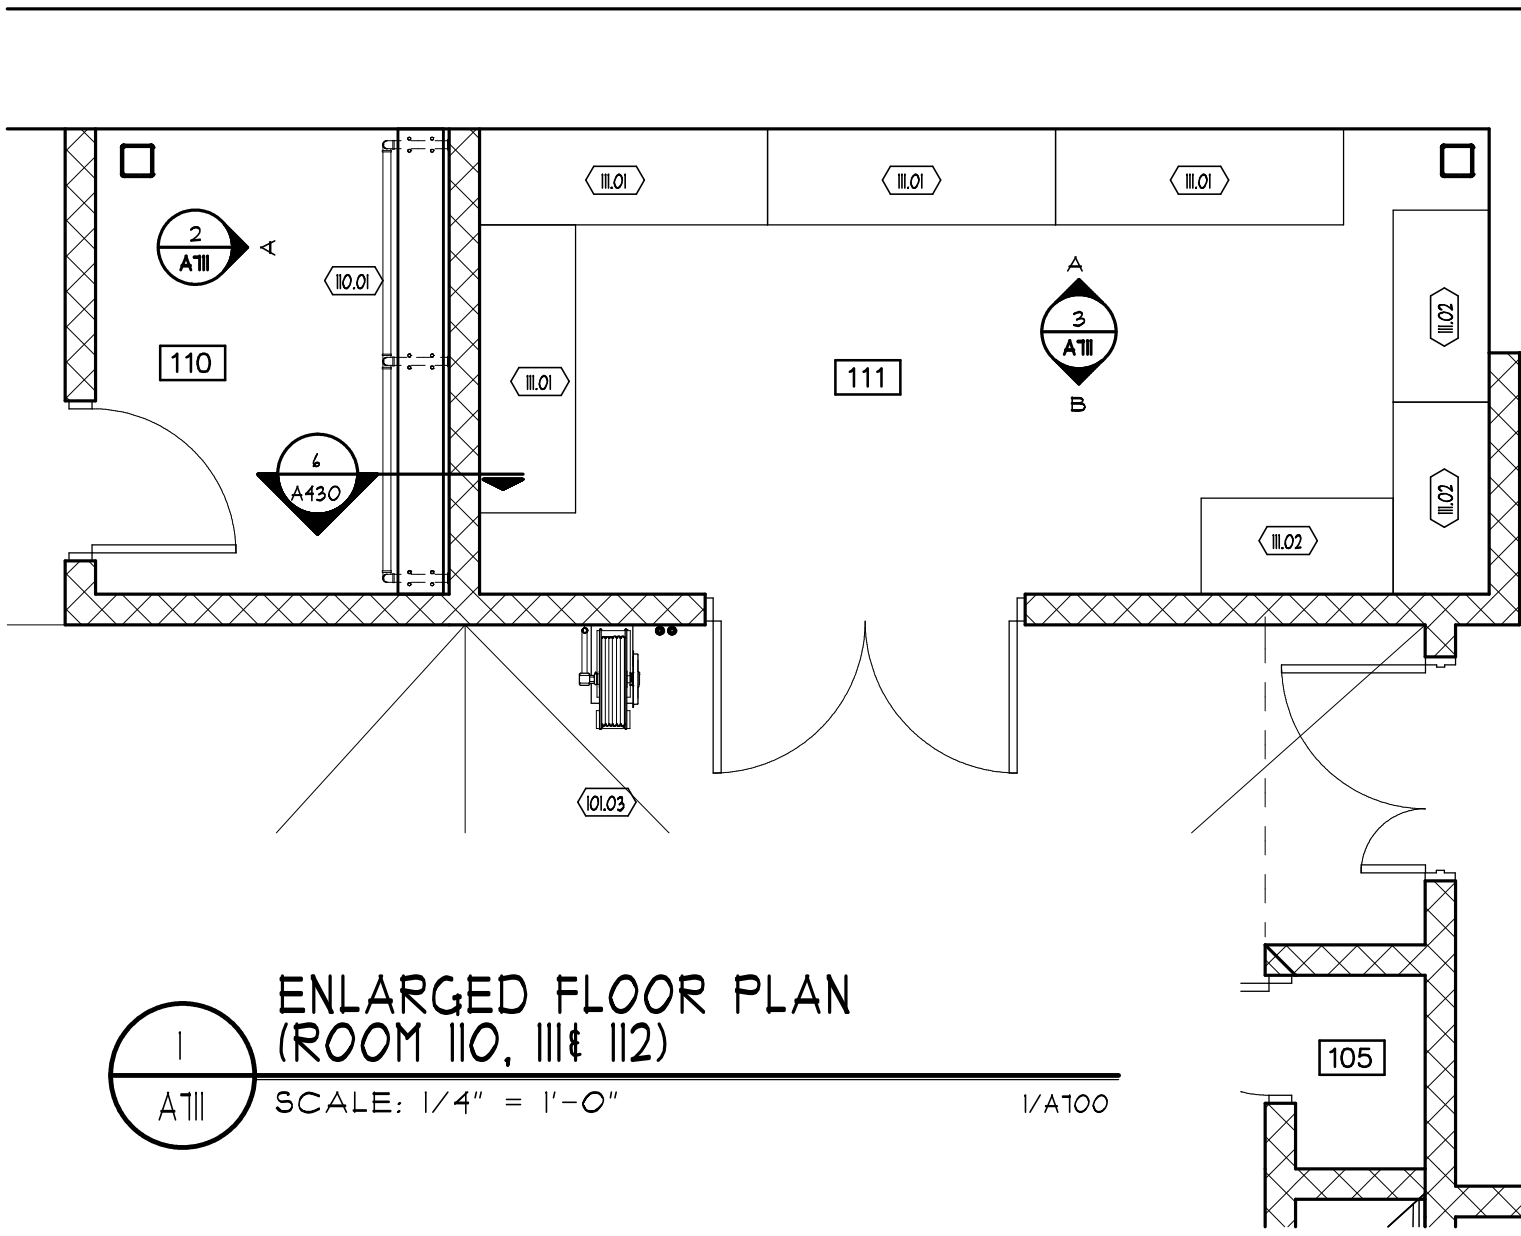
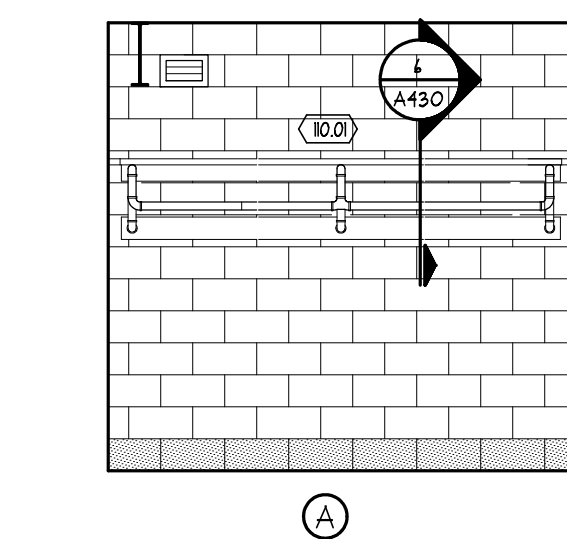


1 ENLARGED FLOOR PLAN (ROOM 110, 111 & 112)
A711 SCALE: 1/4" = 1'-0"

4 ELEVATIONS (ROOM 112)
A711 SCALE: 1/4" = 1'-0"

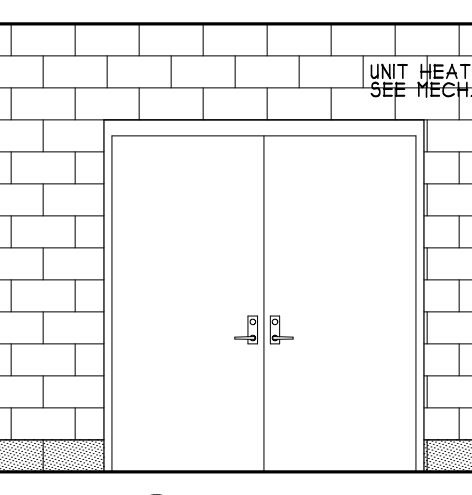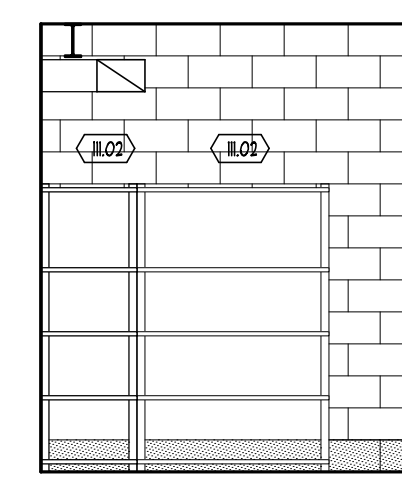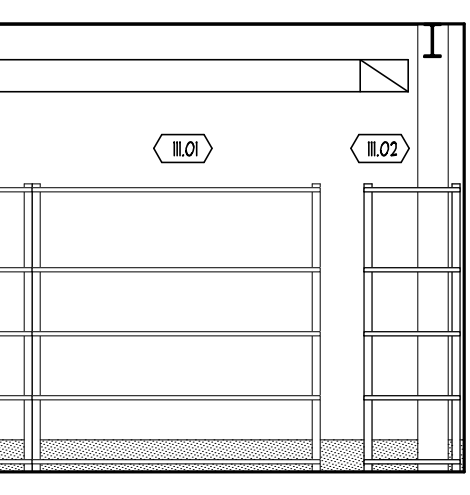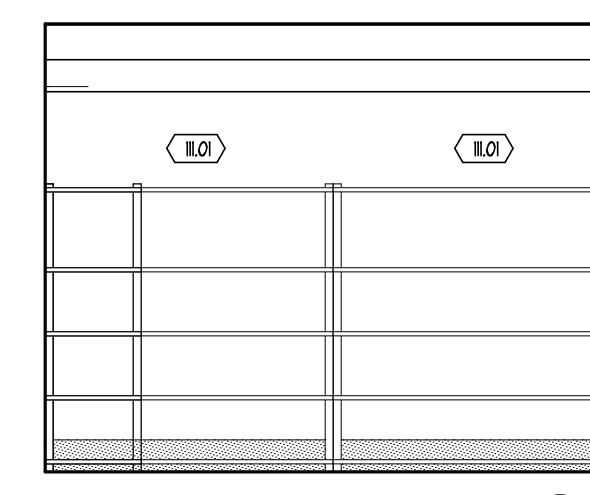

3 ELEVATIONS (ROOM 111)
A711 SCALE: 1/4" = 1'-0"

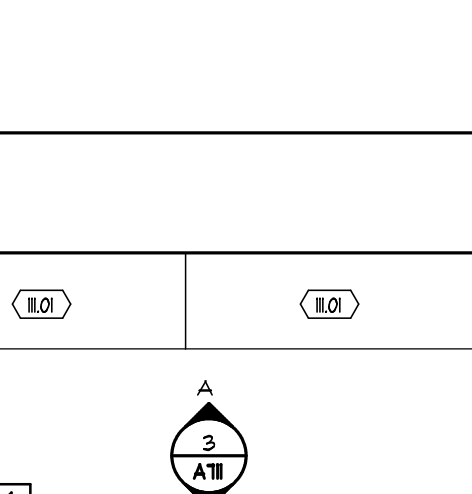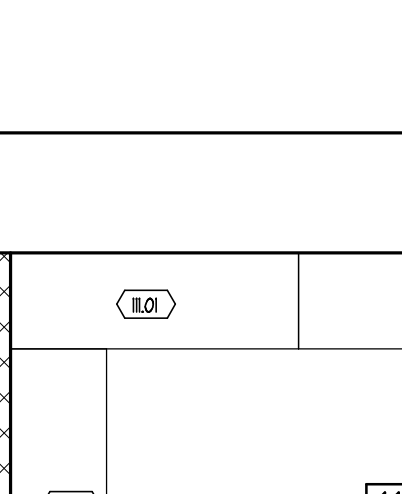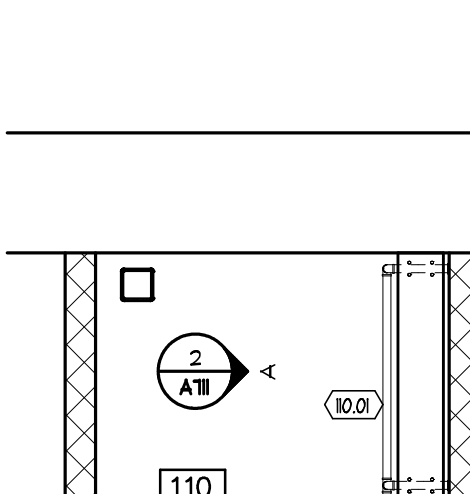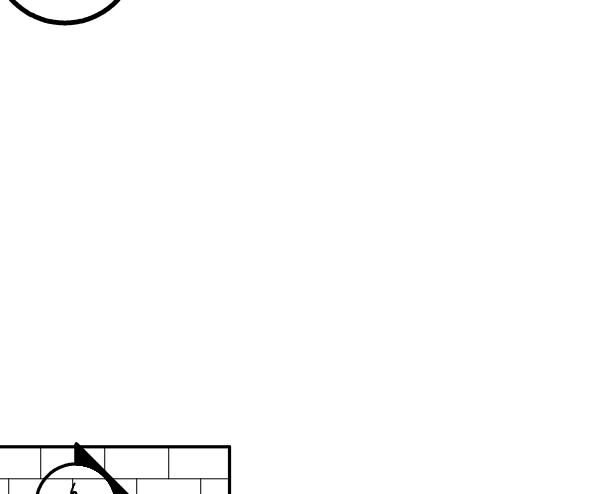

CASEWORK KEY NOTES	
C1	SOLID SURFACE COUNTERTOP W/O BACKSPASH, SIZE AS SHOWN
C2	SOLID SURFACE COUNTERTOP WITH 4" BACKSPASH, SIZE AS SHOWN
C3	1/2" PLYWOOD SUPPORT BELOW W/ PLASTIC LAMINATE SIDES AND VINYL EDGE MOLD AT FRONT EDGE
C4	NOT USED.
C5	3/4" PLYWOOD SKIRT W/PLASTIC LAMINATE ALL SIDES AND VINYL EDGE MOLD BOTTOM EDGE
C6	18" X 24" METAL SUPPORT BRACKET
C7	PLASTIC LAMINATED WALL CABINET W/ VINYL EDGE MOLD & ADJUSTABLE SHELF, NO DOORS
C8	3" DIA STAINLESS STEEL LEG
C9	PENCIL DRAWER
C10	CABLE GROMMET
C11	3/4" PLYWOOD SHELVES W/PLASTIC LAMINATE AND VINYL EDGE MOLD ON STANDARDS AND BRACKETS
C12	PRIVACY SCREEN
C13	NOT USED.
C14	INTERMEDIATE BRACE FOR UPPER RADIO ROOM COUNTER TOP
C15	RADIO ROOM CONSOLE CENTER SUPPORT-SEE DETAILS

NOTE: SEE OFFICE ELEVATIONS FOR CURRENT COMPONENT LOCATIONS AND OFFICE EQUIPMENT.

MA

MITCHELL ASSOCIATES ARCHITECTS PLLC

29 THACHER PARK ROAD
VOORHEESVILLE, NY 12186
(518) 745-4571 FAX (518) 745-2950
WWW.MITCHELL-ARCHITECTS.COM

EMERGENCY SERVICE

FACILITIES

CONSULTANTS:

INSITE ENGINEERING SURVEYING & LANDSCAPE ARCHITECTURE, P.C.

3 GARRETT PLACE
CARMEL, NY 12052
(845) 225-9100 FAX: (845) 225-9117

CRAIG A. MALONEY, P.E.

STRUCTURAL ENGINEERING CONSULTANT

3 BENEDICT COURT
BALLSTON SP, NY 12020
(518) 584-9944 FAX: (518) 584-9955

GERARD ASSOCIATES

CONSULTING ENGINEERS, P.C.

MECHANICAL, PLUMBING, AND ELECTRICAL

223 MAIN STREET
GOSHEN, NY 10924
(845) 291-2112 FAX: (845) 291-1939

COPYRIGHT 2002
MITCHELL ASSOCIATES ARCHITECTS
UNAUTHORIZED ALTERATION OR ADDITION
TO THIS DOCUMENT IS A VIOLATION OF LAW

NEW STATION

FOR

PUTNAM VALLEY FIRE STATION #1

OSCAWANA LAKE ROAD
PUTNAM VALLEY, NEW YORK

REVISION HISTORY	
DATE	DESCRIPTION

ENLARGED FLOOR PLANS & INTERIOR ELEVATIONS OF FF#E

SCALE: AS NOTED
DWG BY: JDC, JDA
DWG DATE: 8/14/2020
STATUS: BID DRAWINGS

A711

PLOT TIME: 3.44 PM