


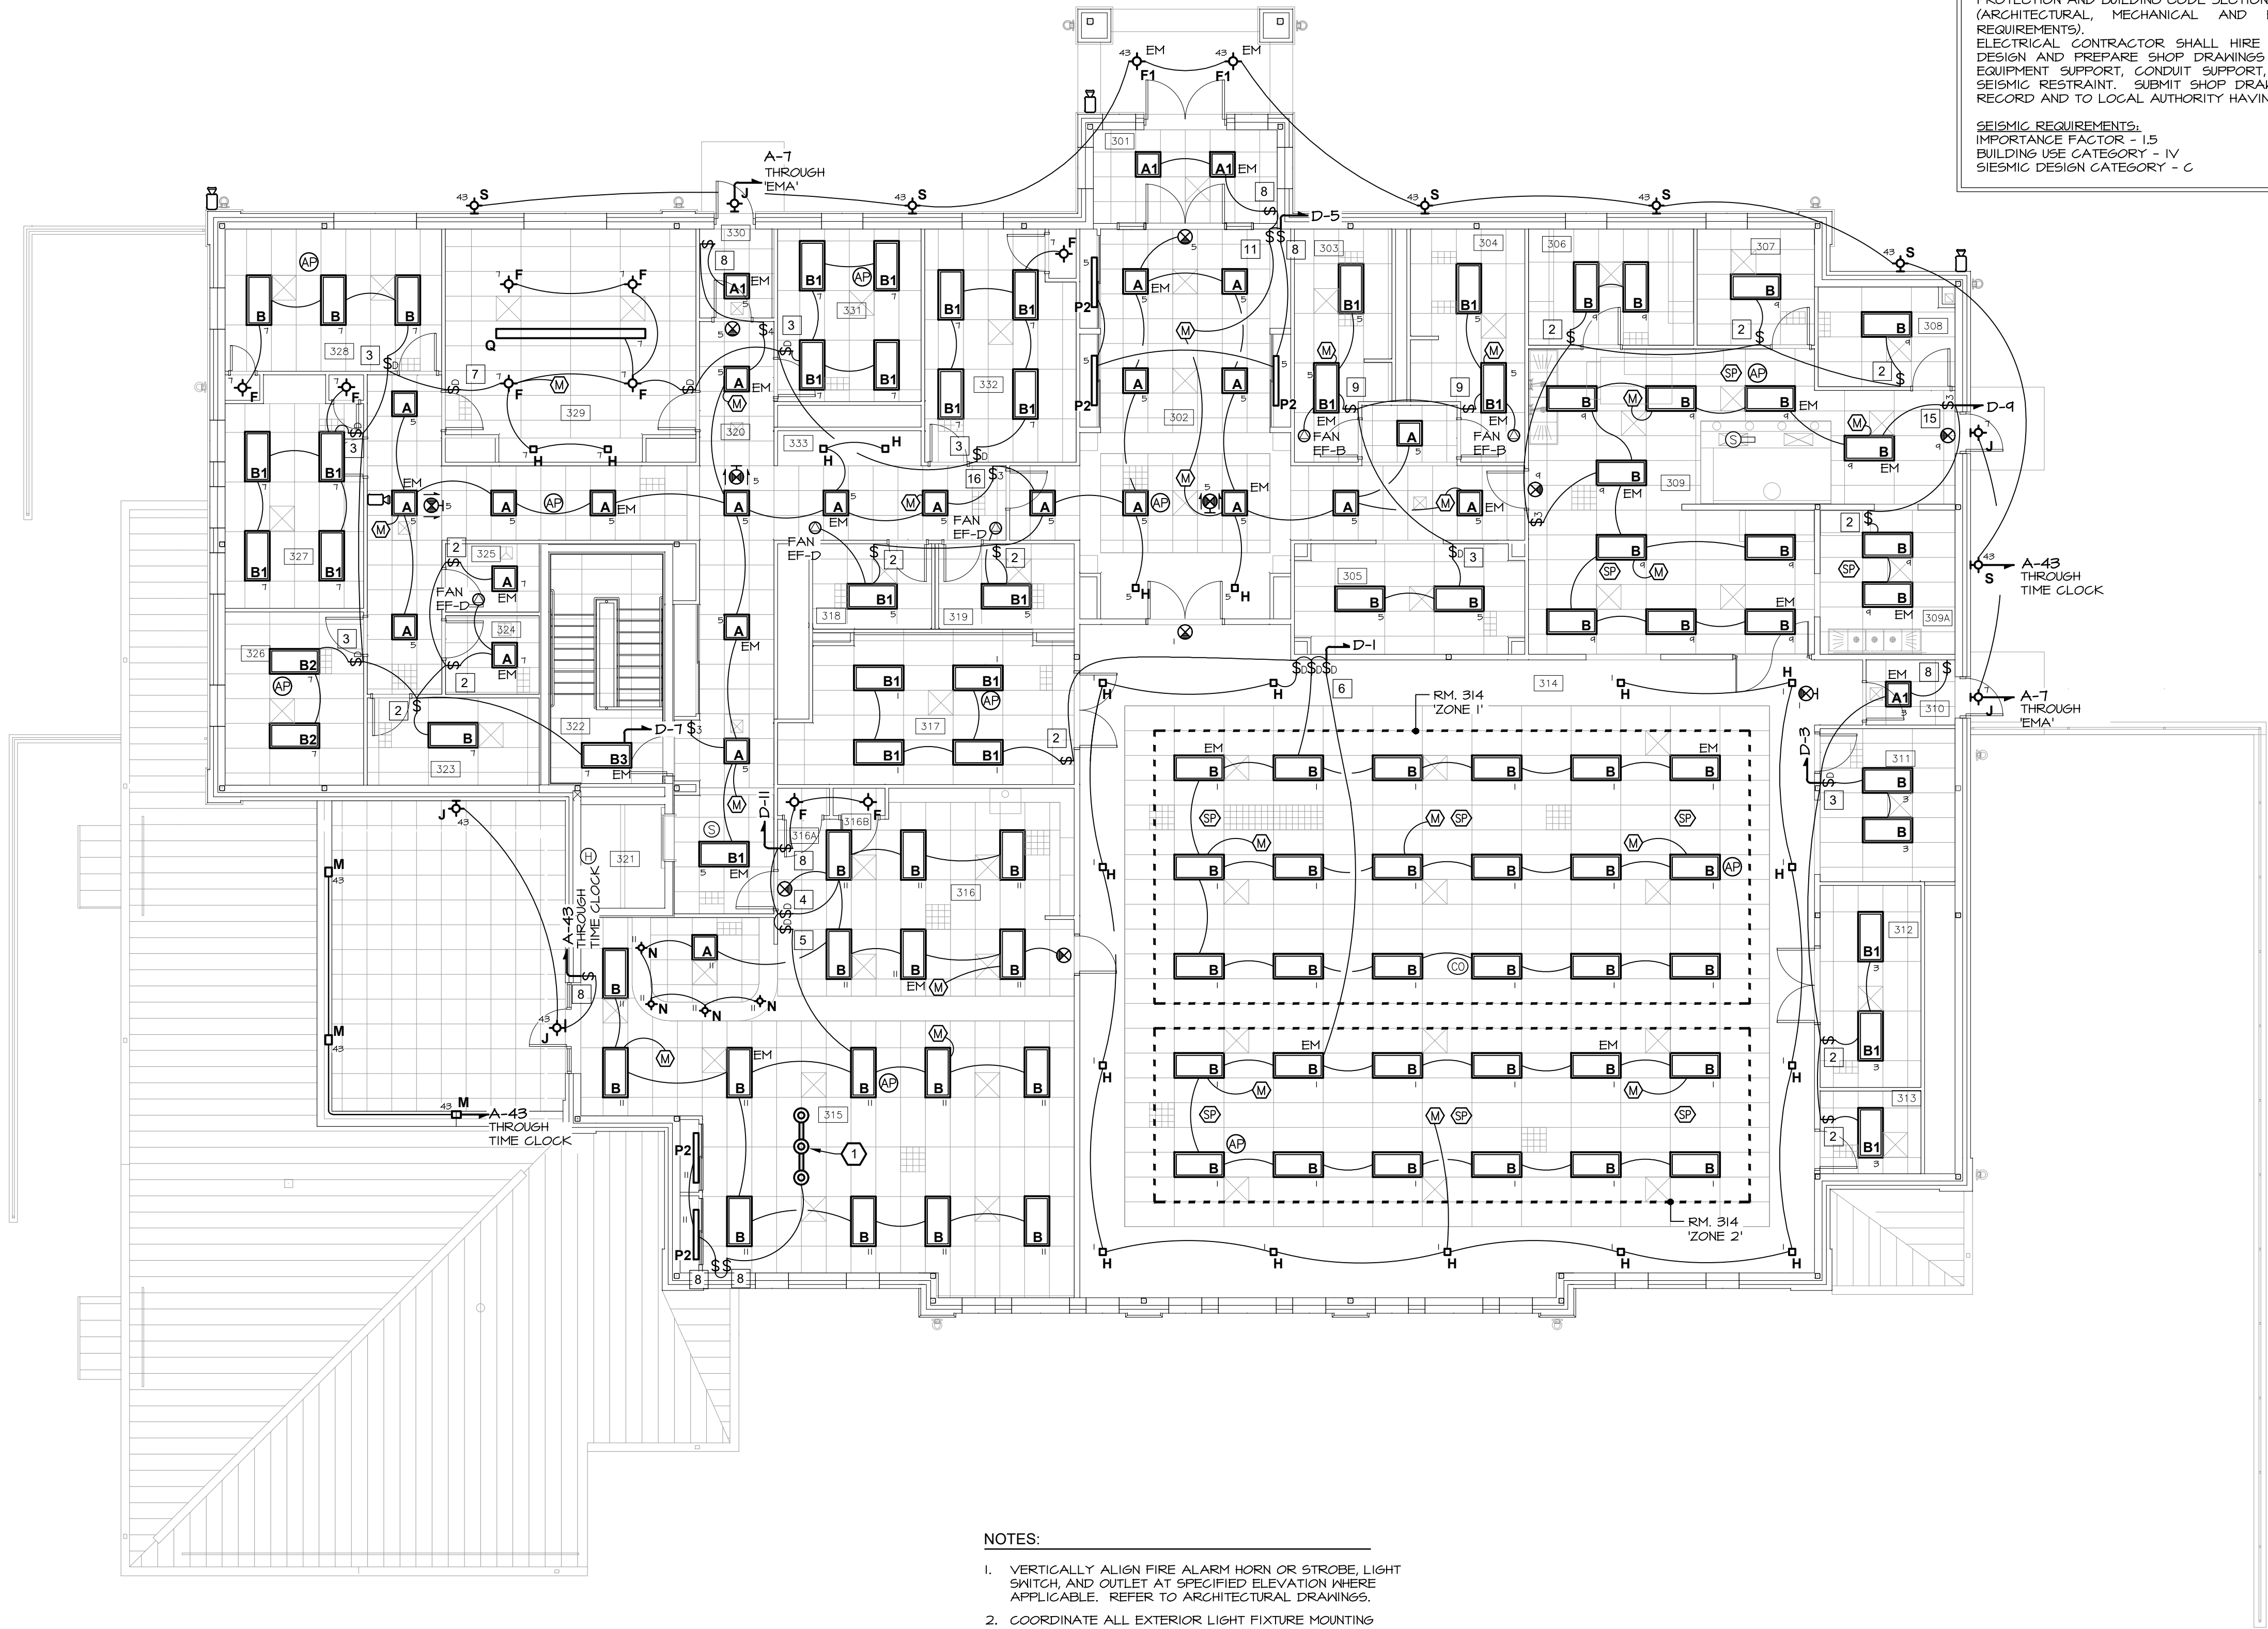

SEISMIC DESIGN FOR ELECTRICAL EQUIPMENT

THE ELECTRICAL SYSTEM SHALL COMPLY WITH THE NEW YORK STATE UNIFORM FIRE PROTECTION AND BUILDING CODE SECTION 1613 AND APPLICABLE PROVISIONS OF ASCE 7 (ARCHITECTURAL, MECHANICAL AND ELECTRICAL COMPONENT SEISMIC DESIGN REQUIREMENTS). ELECTRICAL CONTRACTOR SHALL HIRE NYS LICENSED PROFESSIONAL ENGINEER TO DESIGN AND PREPARE SHOP DRAWINGS WITH CALCULATIONS FOR EACH ELECTRICAL EQUIPMENT SUPPORT, CONDUIT SUPPORT, MULTIPLE CONDUIT SUPPORT, TRAPEZE AND SEISMIC RESTRAINT. SUBMIT SHOP DRAWINGS WITH CALCULATIONS TO ENGINEER FOR RECORD AND TO LOCAL AUTHORITY HAVING JURISDICTION FOR APPROVAL.

SEISMIC REQUIREMENTS:
IMPORTANCE FACTOR - 1.5
BUILDING USE CATEGORY - IV
SEISMIC DESIGN CATEGORY - C

- NOTES:
1. VERTICALLY ALIGN FIRE ALARM HORN OR STROBE LIGHT SWITCH AND OUTLET AT SPECIFIED ELEVATION WHERE APPLICABLE. REFER TO ARCHITECTURAL DRAWINGS.
 2. COORDINATE ALL EXTERIOR LIGHT FIXTURE MOUNTING LOCATIONS WITH ARCHITECTURAL ELEVATION DRAWINGS.


NOTES

REFER TO LIGHTING CONTROL ROOM SCHEDULE FOR LIGHTING CONTROL EQUIPMENT SPECIFICATION AND OPERATION MODE.


KEYED NOTES (APPLIES TO THIS SHEET ONLY)

1 PENDANT BILLIARD LIGHT FIXTURE PROVIDED BY OWNER. ELECTRICAL CONTRACTOR SHALL INSTALL AND WIRE FIXTURE. VERIFY FIXTURE LOCATION IN FIELD.

3rd FLOOR
REFLECTED CEILING PLAN
SCALE: 1/8" = 1'-0"

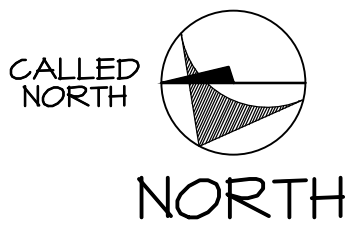

3rd FLOOR ROOM LEGEND			
NO.	NAME	NO.	NAME
301	VESTIBULE	316B	CLOSET
302	LOBBY	317	TABLE/CHAIR STORAGE
303	PUBLIC MEN'S LAVATORY	318	WOMEN'S LAVATORY
304	PUBLIC WOMEN'S LAVATORY	319	MEN'S LAVATORY
305	COAT ROOM	320	CORRIDOR
306	PANTRY	321	ELEVATOR
307	REFRIGERATED STORAGE	322	STAIR
308	DISH STORAGE	323	FIRE PREVENTION STOR.
309	KITCHEN	324	JANITOR
309A	DISH WASHING	325	HOUSE KEEPING
310	VESTIBULE	326	ASSISTANT CHIEF'S
311	SERVICE CENTER	327	JUNIOR OFFICERS
312	STORAGE	328	CHIEF'S OFFICE
313	AV	329	CONFERENCE ROOM
314	MEETING/TRAINING	330	VESTIBULE
315	MEMBERS ROOM	331	PRESIDENT/VP OFFICE
316	KITCHENETTE	332	BUSINESS OFFICE
316A	CLOSET	333	WORK AREA

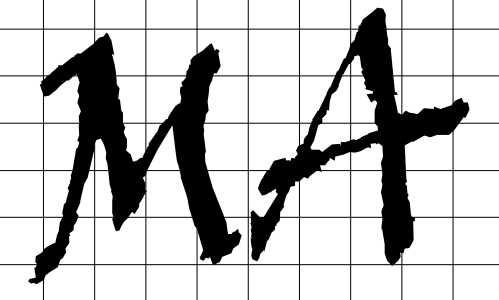

MITCHELL
ASSOCIATES
ARCHITECTS

29 THACHER PARK ROAD
VOORHEESVILLE, NY 12186
(518) 765-4511 FAX (518) 765-2150
WWW.MITCHELL-ARCHITECTS.COM

EMERGENCY
SERVICE

FACILITIES

CONSULTANTS:

INSITE ENGINEERING SURVEYING
& LANDSCAPE ARCHITECTURE, P.C.
3 GARRET PLACE
CARMEL, NY 10512
(845) 225-9640 FAX: (845) 225-4717

CRAIG A. MALONEY P.E.
STRUCTURAL ENGINEERING CONSULTANT
3 BENEDICT COURT
BALLSTON SPA, NY 12020
(518) 584-9844 FAX: (518) 584-9855

GERARD ASSOCIATES
CONSULTING ENGINEERS, P.C.
MECHANICAL, PLUMBING
AND ELECTRICAL
223 MAIN STREET
GOSHEN, NY 10924
(845) 241-1212
GARD011

COPYRIGHT 2012
MITCHELL ASSOCIATES ARCHITECTS
UNAUTHORIZED ALTERATION OR ADDITION
TO THIS DOCUMENT IS A VIOLATION OF LAW

NEW STATION
FOR
PUTNAM VALLEY
FIRE STATION #1

OSCAWANA LAKE ROAD
PUTNAM VALLEY, NEW YORK

REVISION HISTORY		
	DATE	DESCRIPTION
1		
2		
3		
4		
5		
6		
7		
8		

ELECTRICAL:
3rd FLOOR
REFLECTED CEILING PLAN

SCALE: AS NOTED
DWG. BY: KC
DWG. DATE: 8/14/2020
STATUS: BID DRAWINGS

E602