




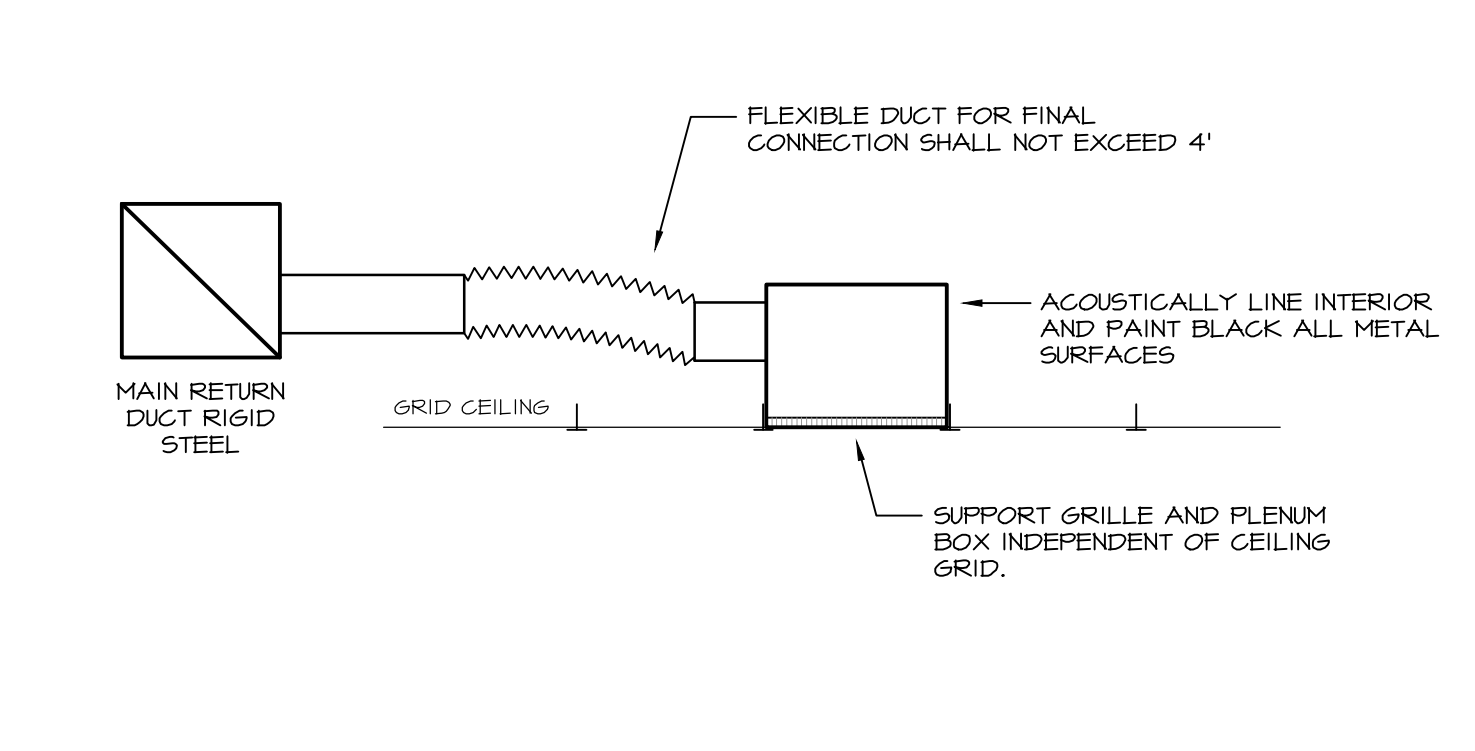


1 RETURN GRILLE LAY-IN DETAIL
M201 NOT TO SCALE

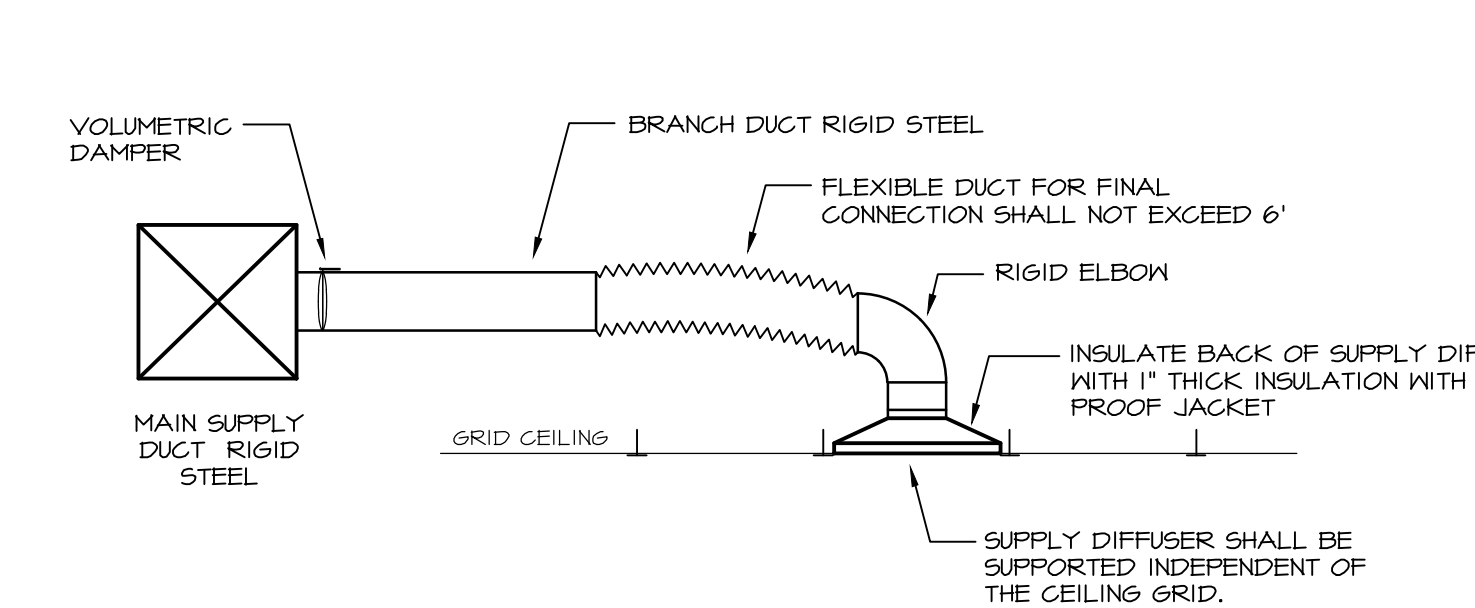

4 SUPPLY DIFFUSER LAY-IN DETAIL
M201 NOT TO SCALE

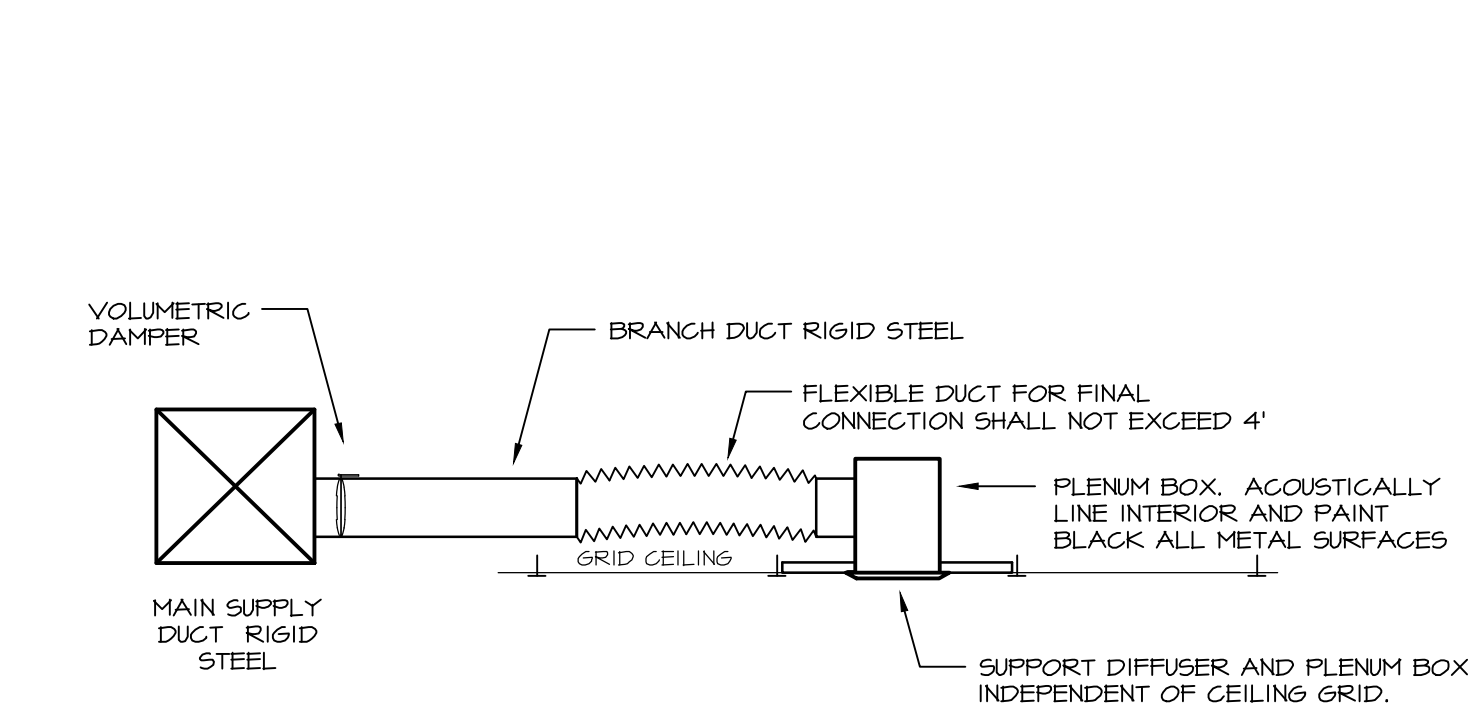


7 SUPPLY DIFFUSER PANEL LAY-IN DETAIL
M201 NOT TO SCALE

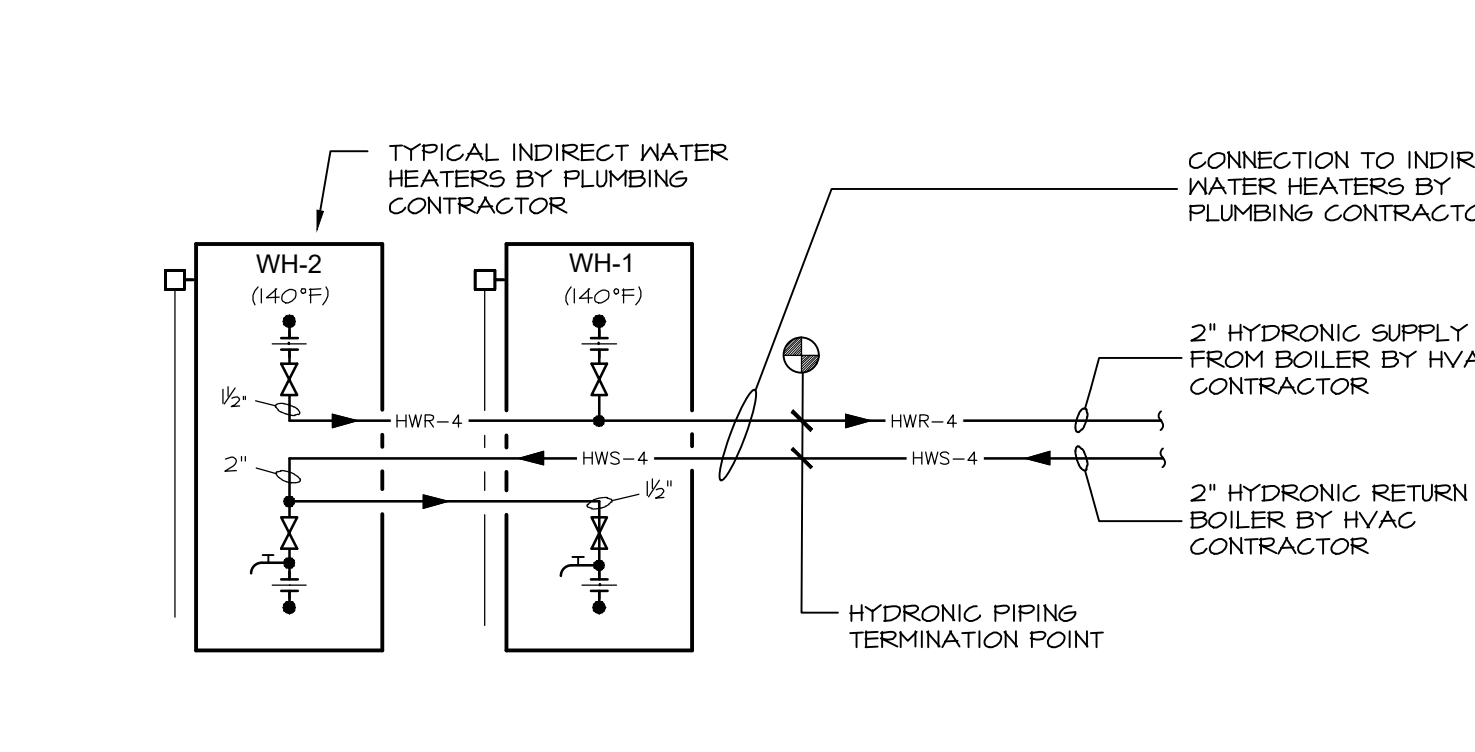


NOTE:
HVAC CONTRACTOR SHALL RUN HYDRONIC PIPING FROM BOILER UP TO INDIRECT WATER HEATERS. PLUMBING CONTRACTOR SHALL MAKE FINAL HYDRONIC PIPING CONNECTIONS TO INDIRECT HEATERS. COORDINATE HYDRONIC PIPING TERMINATION POINT WITH PLUMBING CONTRACTOR.


10 INDIRECT WATER HEATER DETAIL
M201 NOT TO SCALE

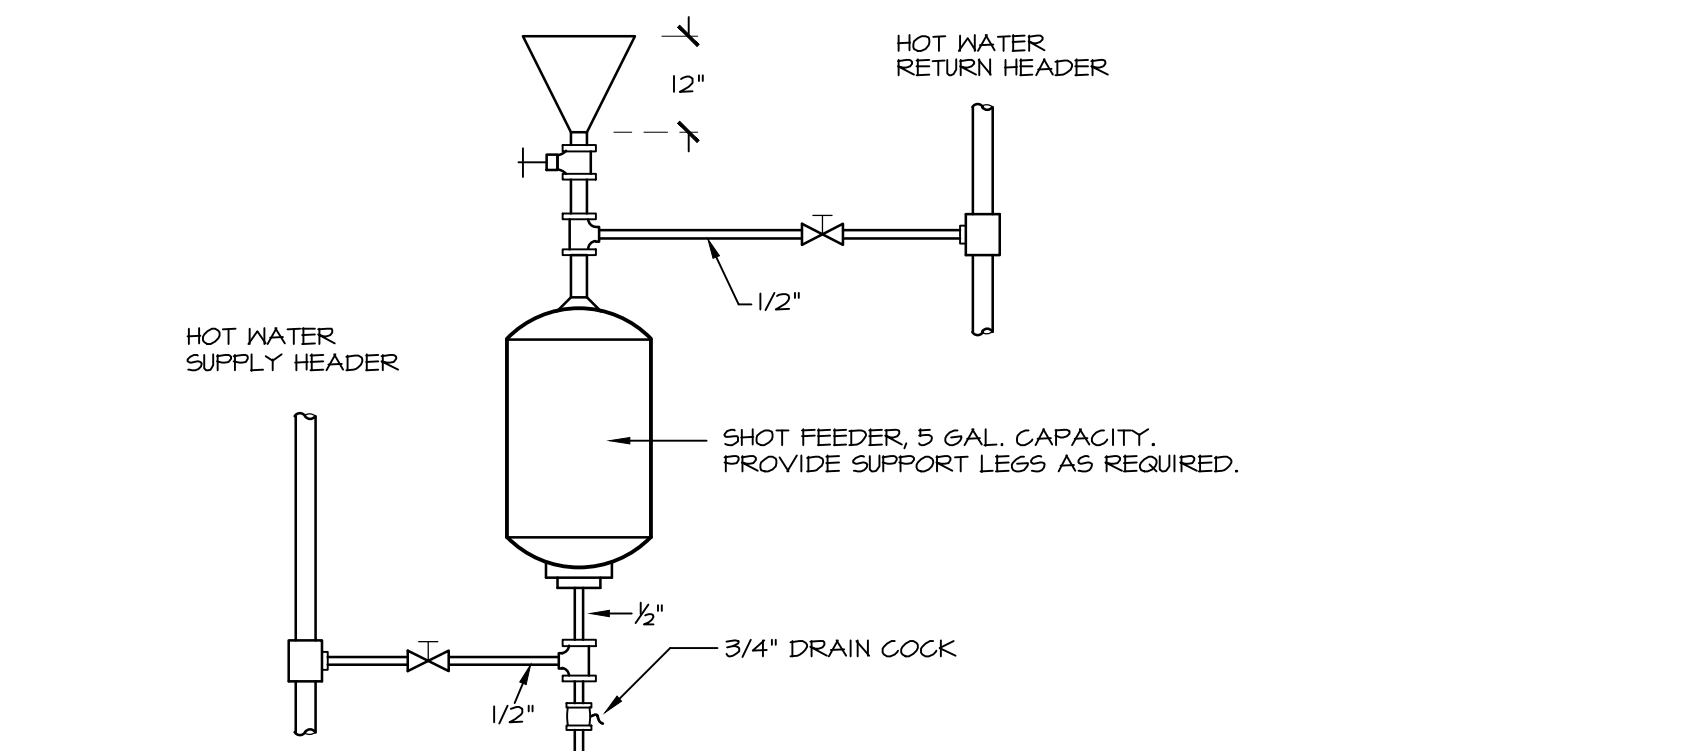

2 SHOT FEEDER (SF-1) PIPING DETAIL
M201 NOT TO SCALE

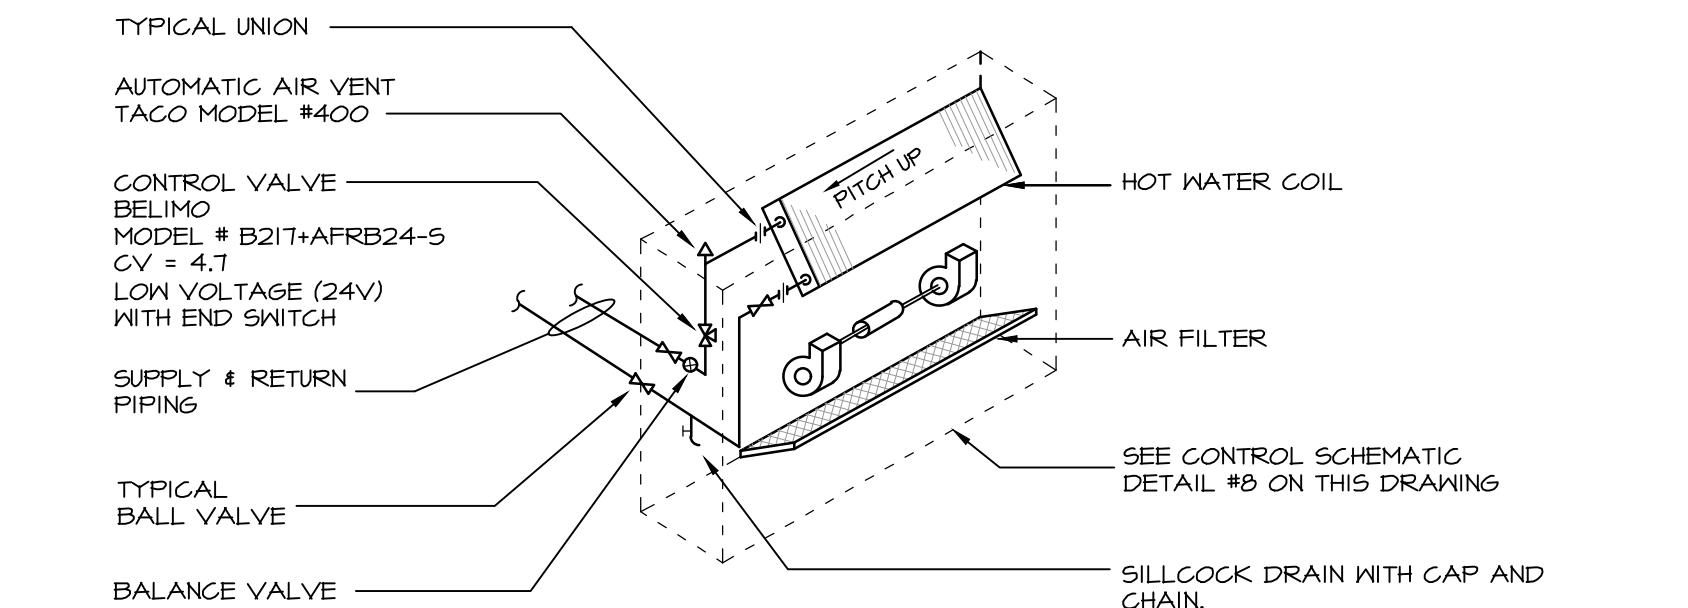

5 VERTICAL CABINET HEATER DETAIL
M201 NOT TO SCALE

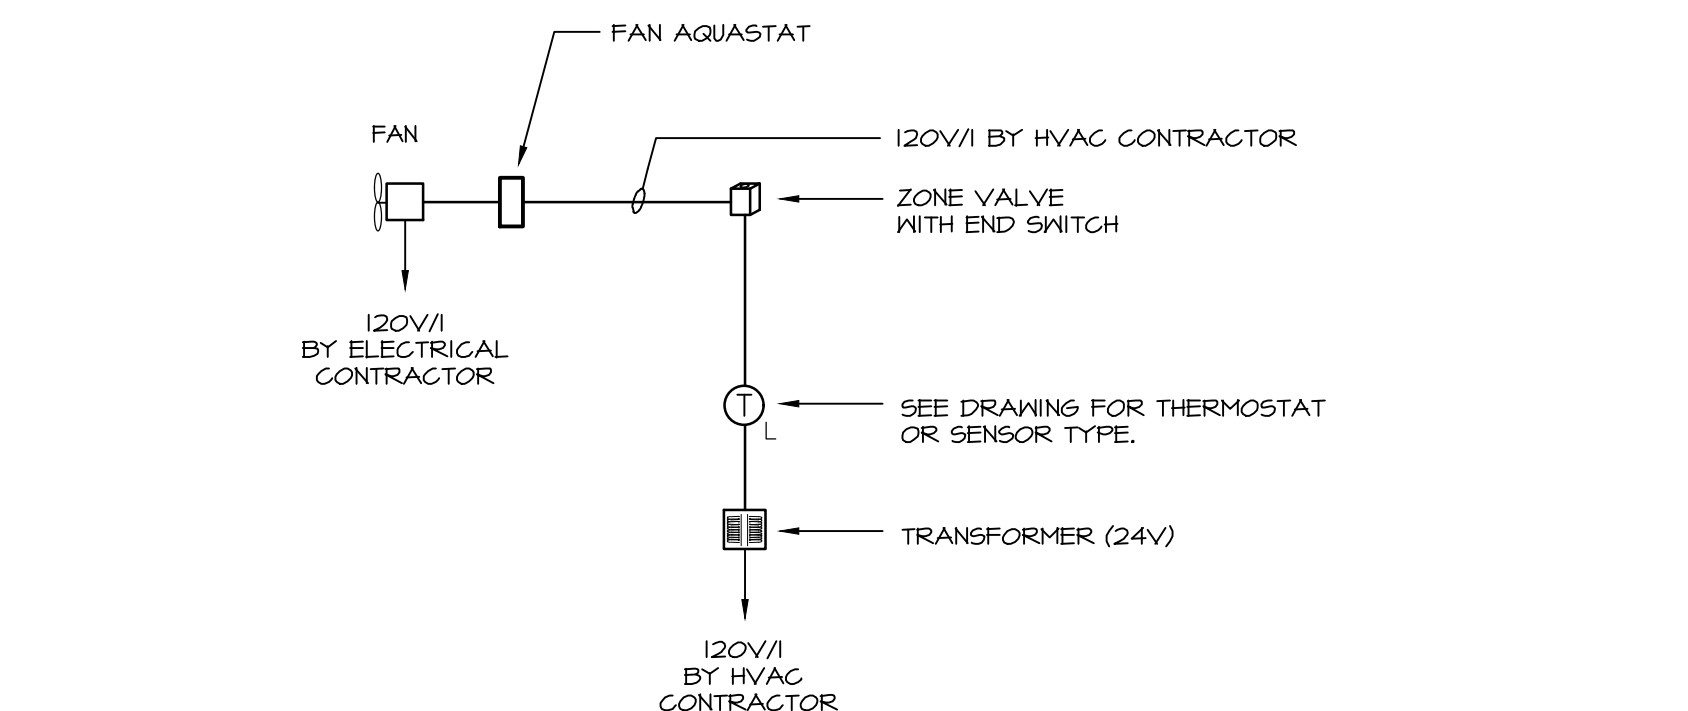


8 CABINET/UNIT HEATER CONTROL SCHEMATIC
M201 NOT TO SCALE




NOTE:
THIS DETAIL CONTAINS THE BASIC ELEMENTS AND EQUIPMENT FOR VERTICAL AIR HANDLERS. THE CONFIGURATION OF DUCTS, DUCT SIZES AND CONNECTIONS TO AIR HANDLERS WILL VARY. SEE HVAC DRAWINGS.

6 VERTICAL AIR HANDLER UNIT DETAIL
M201 NOT TO SCALE

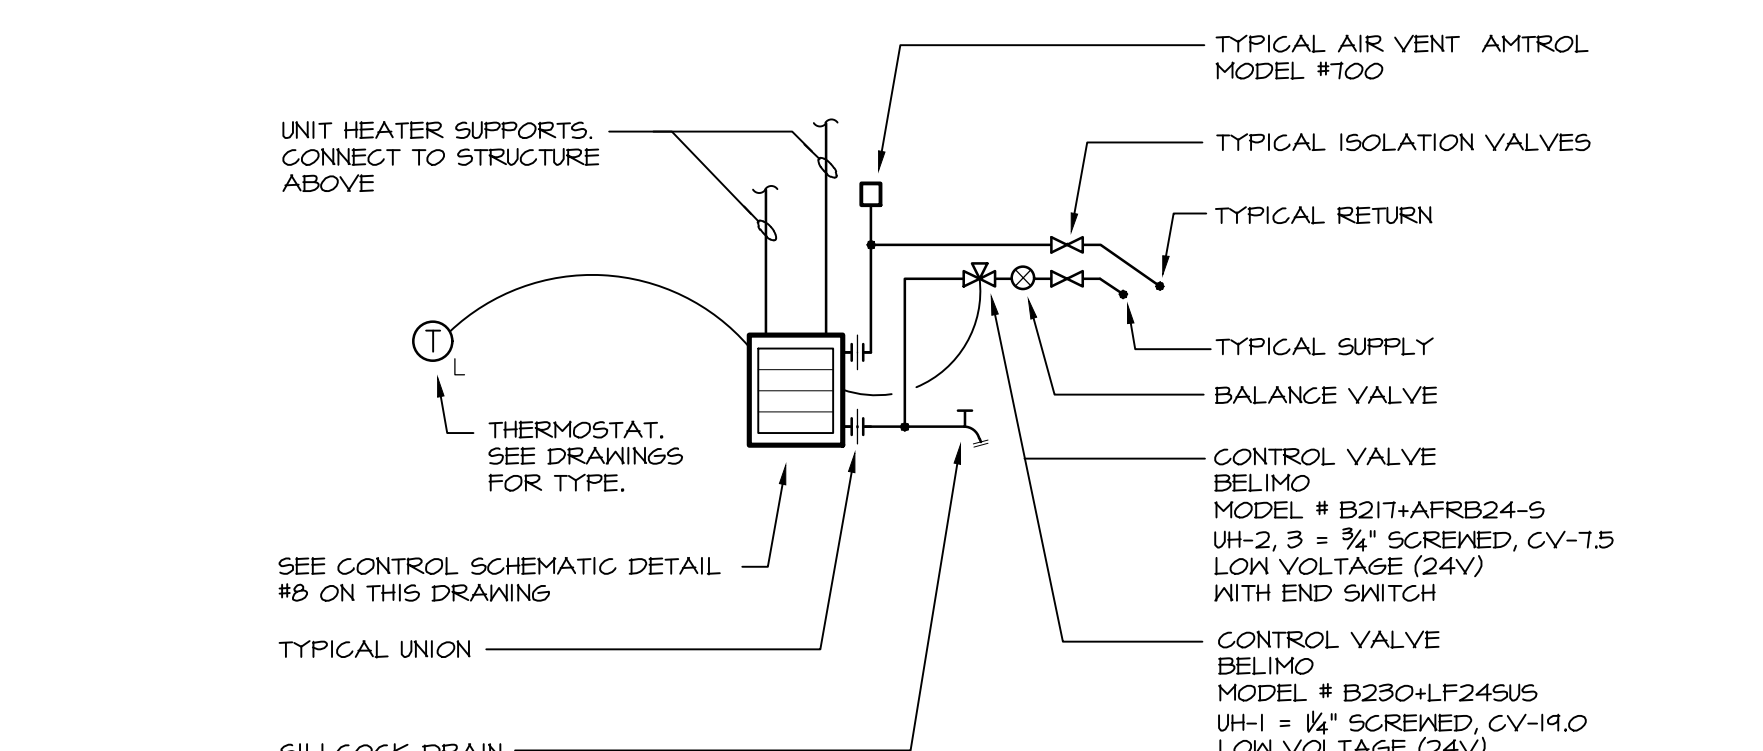

NOTE:
EXACT ELEVATION OF UNIT HEATER SHALL BE DETERMINED IN FIELD AND APPROVED BY ARCHITECT/ENGINEER PRIOR TO INSTALLATION.

3 UNIT HEATER DETAIL
M201 NOT TO SCALE

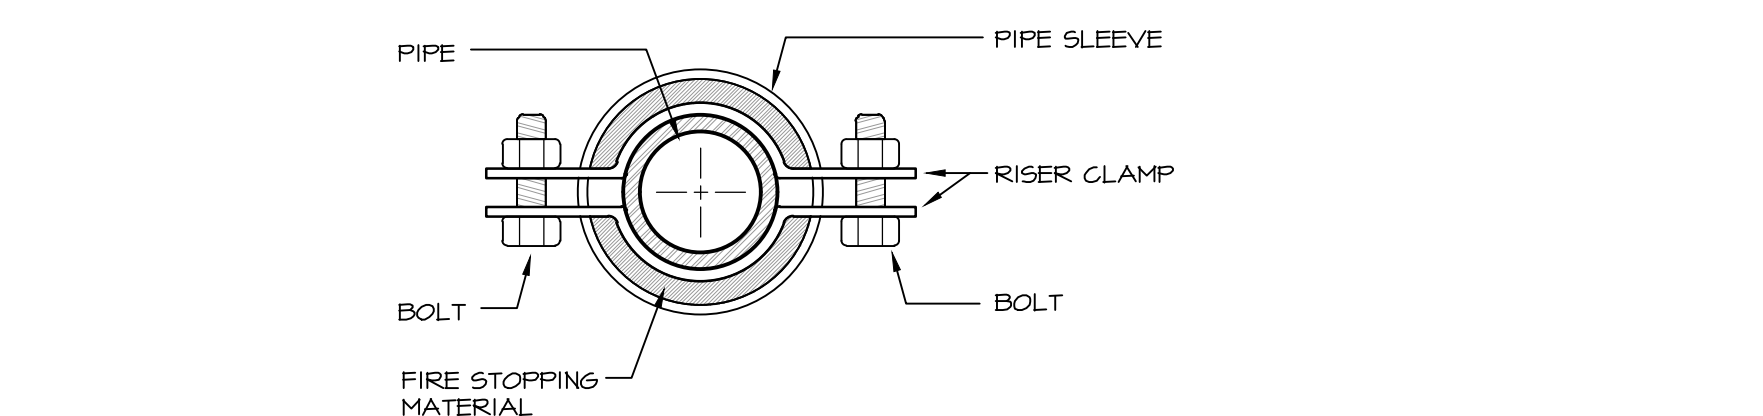

9 SUPPORT ANCHOR PIPE RISERS
M201 NOT TO SCALE

MA
MITCHELL ASSOCIATES ARCHITECTS
29 THACHER PARK ROAD
VOORHEESVILLE, NY 12186
(518) 765-4511 FAX (518) 765-2150
WWW.MITCHELL-ARCHITECTS.COM

EMERGENCY SERVICE
FACILITIES

CONSULTANTS:
INSITE ENGINEERING SURVEYING
& LANDSCAPE ARCHITECTURE, P.C.
3 GARRET PLACE
CARMEL, NY 10512
(845) 225-9640 FAX: (845) 225-9717

CRAIG A. MALONEY P.E.
STRUCTURAL ENGINEERING CONSULTANT
3 BENEDICT COURT
BALLSTON SPA, NY 12020
(518) 584-4844 FAX: (518) 584-4855

GERARD ASSOCIATES
CONSULTING ENGINEERS, P.C.
MECHANICAL, PLUMBING
AND ELECTRICAL
223 MAIN STREET
GOSHEN, NY 10924
(845) 241-1212
GARD011

COPYRIGHT 2012
MITCHELL ASSOCIATES ARCHITECTS
UNAUTHORIZED ALTERATION OR ADDITION
TO THIS DOCUMENT IS A VIOLATION OF LAW

NEW STATION FOR PUTNAM VALLEY FIRE STATION #1

OSCAWANA LAKE ROAD
PUTNAM VALLEY, NEW YORK

REVISION HISTORY		
DATE	DESCRIPTION	
△		
△		
△		
△		
△		
△		
△		

MECHANICAL: DETAILS

SCALE: AS NOTED
DWG. BY: KC
DWG. DATE: 8/14/2020
STATUS: BID DRAWINGS

M201