


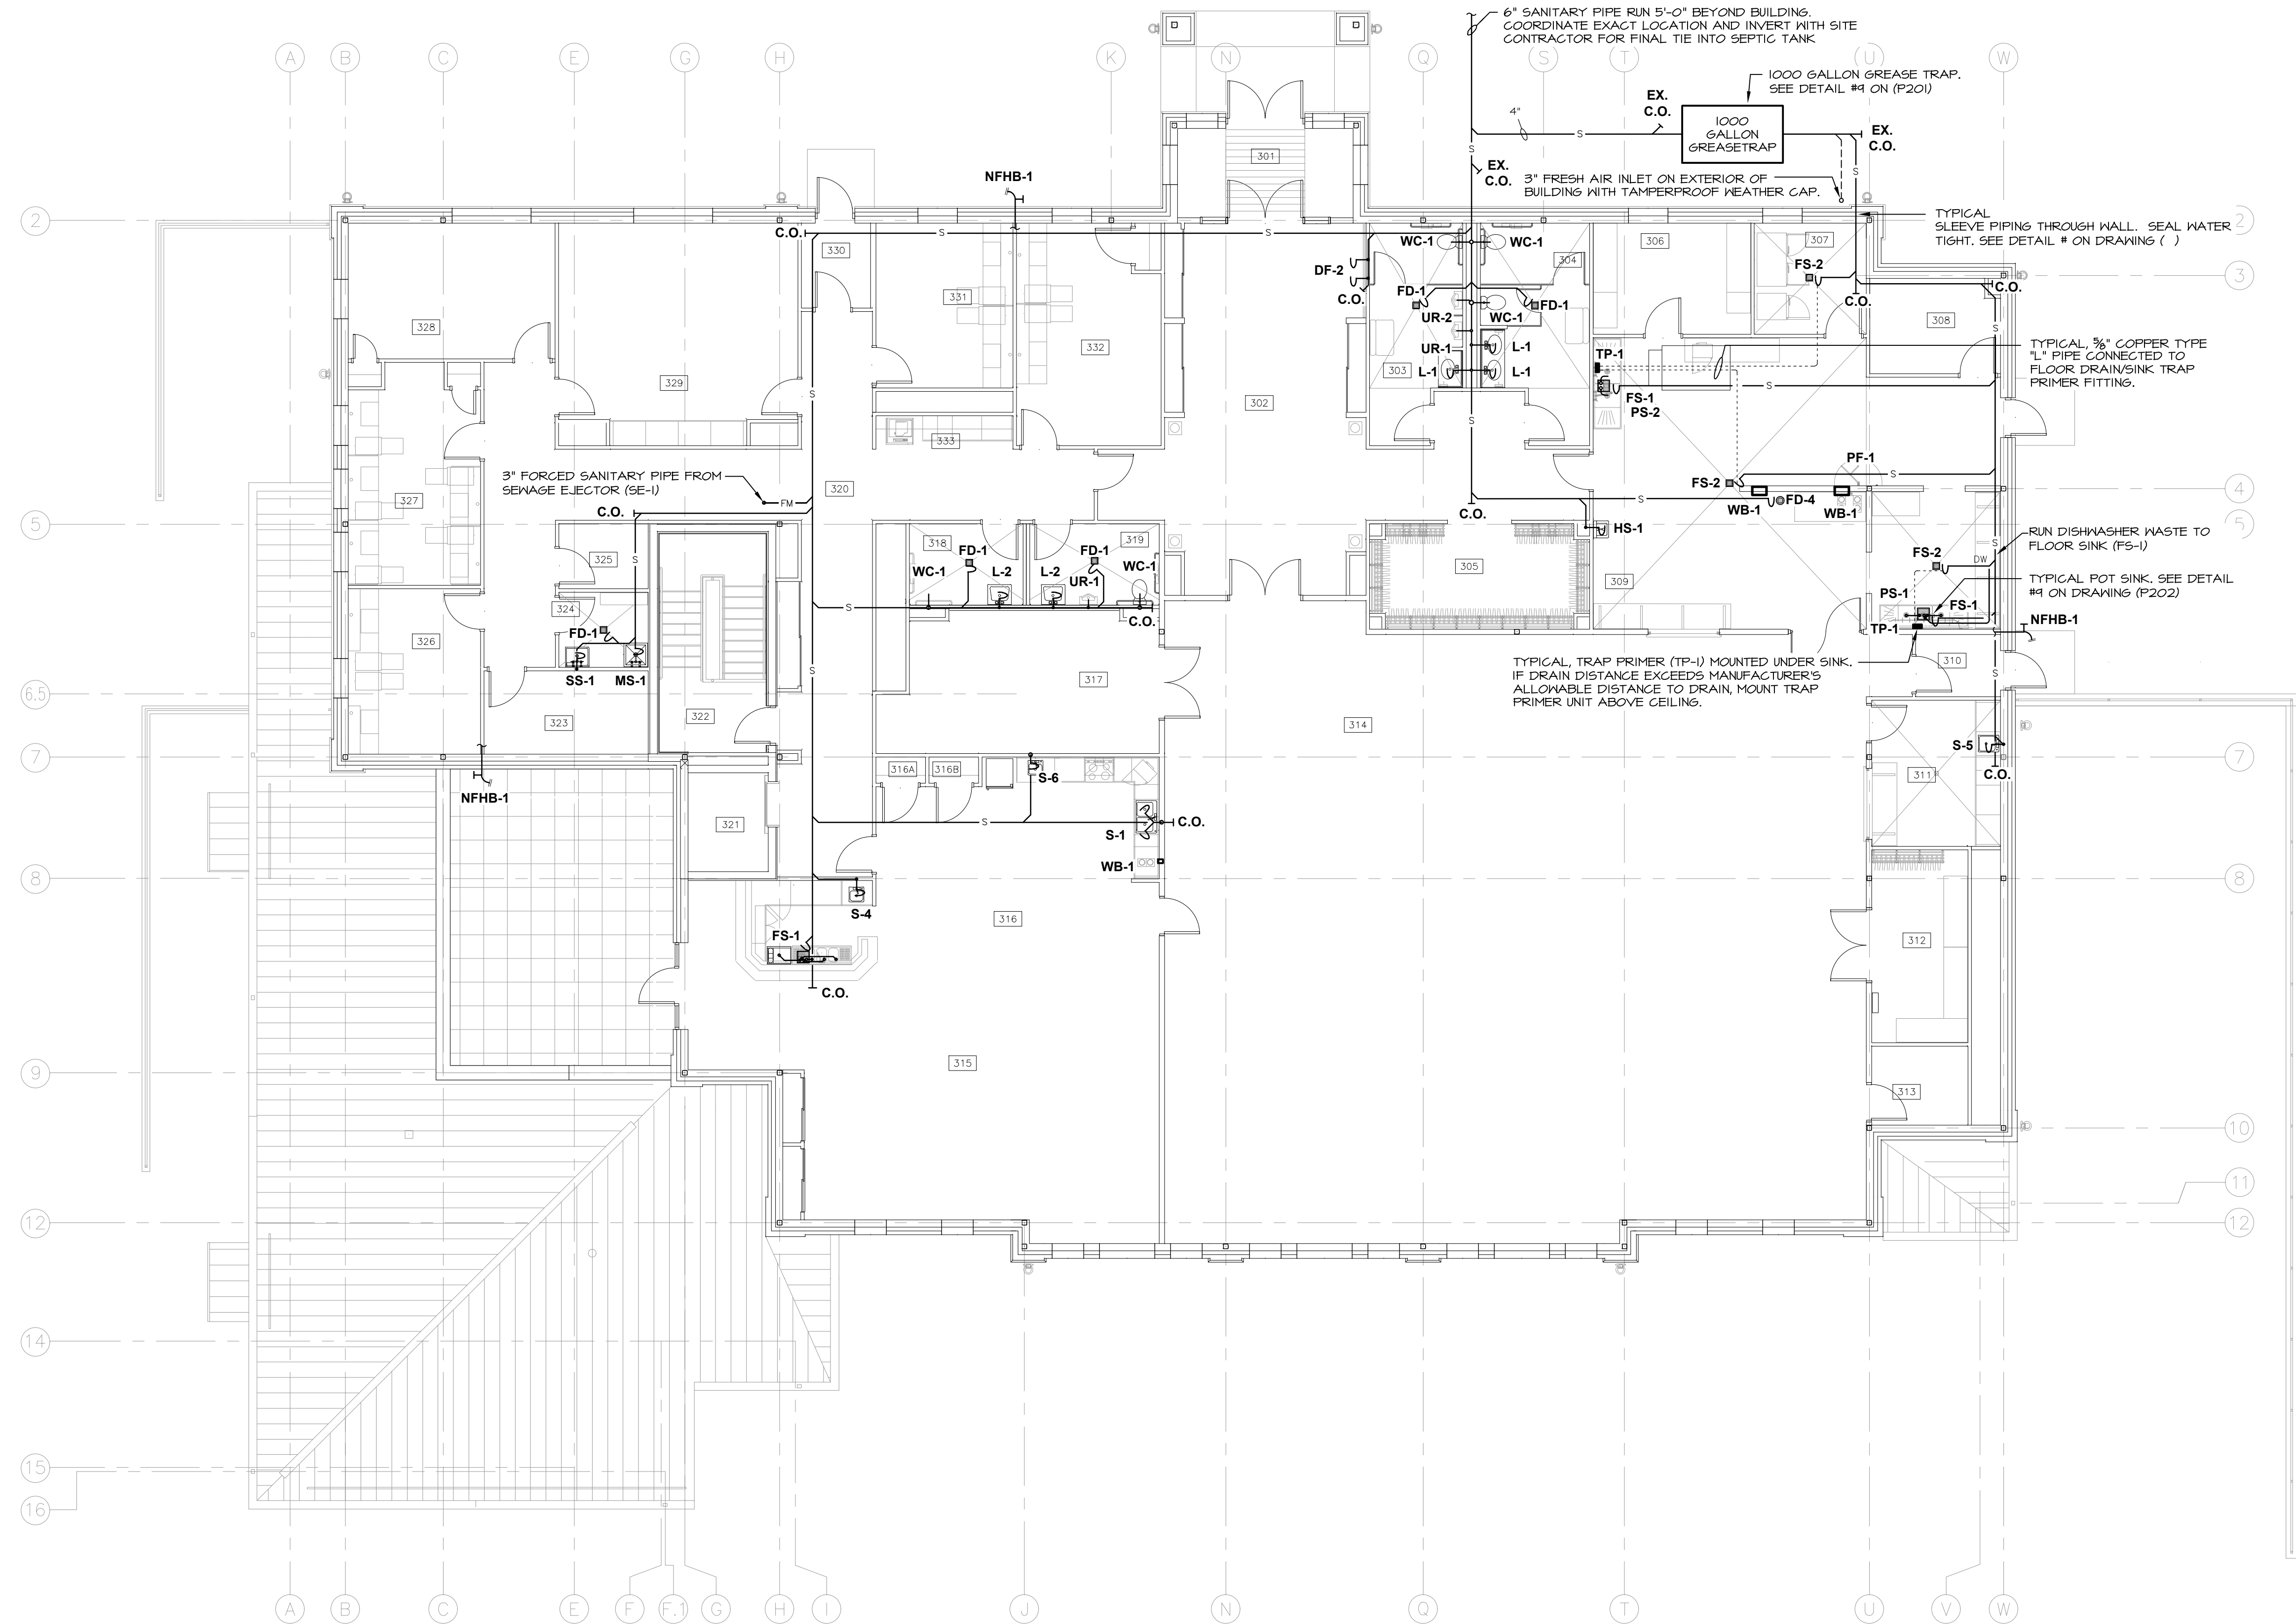


**SEISMIC EQUIPMENT AND PIPE HANGER DESIGN**

THE PLUMBING SYSTEM SHALL COMPLY WITH THE NEW YORK STATE UNIFORM FIRE PROTECTION AND BUILDING CODE SECTION 1613 AND APPLICABLE PROVISIONS OF ASCE 7 (ARCHITECTURAL, MECHANICAL AND ELECTRICAL COMPONENT SEISMIC DESIGN REQUIREMENTS). PLUMBING CONTRACTOR SHALL HIRE NYS LICENSED PROFESSIONAL ENGINEER TO DESIGN AND PREPARE SHOP DRAWINGS WITH CALCULATIONS FOR EACH EQUIPMENT SUPPORT, PIPE SUPPORT, MULTIPLE PIPE SUPPORT, TRAPEZE AND SEISMIC RESTRAINT. SUBMIT SHOP DRAWINGS WITH CALCULATIONS TO ENGINEER FOR RECORD AND TO LOCAL AUTHORITY HAVING JURISDICTION FOR APPROVAL.

SEISMIC REQUIREMENTS:  
BUILDING USE CATEGORY - IV  
SEISMIC DESIGN CATEGORY - C

**3rd FLOOR PLAN**  
SCALE: 1/8" = 1'-0"

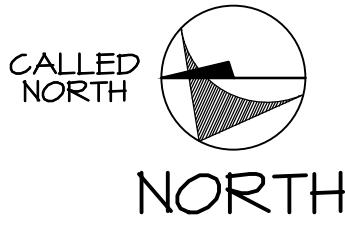

| 3rd FLOOR ROOM LEGEND |                         |      |                       |
|-----------------------|-------------------------|------|-----------------------|
| NO.                   | NAME                    | NO.  | NAME                  |
| 301                   | VESTIBULE               | 316B | CLOSET                |
| 302                   | LOBBY                   | 317  | TABLE/CHAIR STORAGE   |
| 303                   | PUBLIC MEN'S LAVATORY   | 318  | WOMEN'S LAVATORY      |
| 304                   | PUBLIC WOMEN'S LAVATORY | 319  | MEN'S LAVATORY        |
| 305                   | COAT ROOM               | 320  | CORRIDOR              |
| 306                   | PANTRY                  | 321  | ELEVATOR              |
| 307                   | REFRIGERATED STORAGE    | 322  | STAIR                 |
| 308                   | DISH STORAGE            | 323  | FIRE PREVENTION STOR. |
| 309                   | KITCHEN                 | 324  | JANITOR               |
| 309A                  | DISH WASHING            | 325  | HOUSE KEEPING         |
| 310                   | VESTIBULE               | 326  | ASSISTANT CHIEF'S     |
| 311                   | SERVICE CENTER          | 327  | JUNIOR OFFICERS       |
| 312                   | STORAGE                 | 328  | CHIEF'S OFFICE        |
| 313                   | AV                      | 329  | CONFERENCE ROOM       |
| 314                   | MEETING/TRAINING        | 330  | VESTIBULE             |
| 315                   | MEMBERS ROOM            | 331  | PRESIDENT/VP OFFICE   |
| 316                   | KITCHENETTE             | 332  | BUSINESS OFFICE       |
| 316A                  | CLOSET                  | 333  | WORK AREA             |

MA

**MITCHELL ASSOCIATES ARCHITECTS**  
29 THACHER PARK ROAD  
VOORHEESVILLE, NY 12186  
(518) 765-4511 FAX (518) 765-2150  
WWW.MITCHELL-ARCHITECTS.COM

**EMERGENCY SERVICE**  
FACILITIES

CONSULTANTS:  
**INSITE ENGINEERING SURVEYING & LANDSCAPE ARCHITECTURE, P.C.**  
3 GARRET PLACE  
CARMEL, NY 10512  
(845) 225-9640 FAX: (845) 225-9717

**CRAIG A. MALONEY P.E.**  
STRUCTURAL ENGINEERING CONSULTANT  
3 BENEDICT COURT  
BALLSTON SPA, NY 12020  
(518) 584-9844 FAX: (518) 584-9855

**GERARD ASSOCIATES**  
CONSULTING ENGINEERS, P.C.  
MECHANICAL, PLUMBING AND ELECTRICAL  
223 MAIN STREET  
GOSHEN, NY 10924  
(845) 241-1212  
GARD011

COPYRIGHT 2012  
MITCHELL ASSOCIATES ARCHITECTS  
UNAUTHORIZED ALTERATION OR ADDITION  
TO THIS DOCUMENT IS A VIOLATION OF LAW

**NEW STATION FOR PUTNAM VALLEY FIRE STATION #1**

OSCAWANA LAKE ROAD  
PUTNAM VALLEY, NEW YORK

| REVISION HISTORY |             |  |
|------------------|-------------|--|
| DATE             | DESCRIPTION |  |
|                  |             |  |
|                  |             |  |
|                  |             |  |
|                  |             |  |
|                  |             |  |
|                  |             |  |
|                  |             |  |

**PLUMBING: 3rd FLOOR PLAN**

SCALE: AS NOTED  
DWG. BY: KC  
DWG. DATE: 8/14/2020  
STATUS: BID DRAWINGS

P102