


6/4/2021 3:59:06 PM

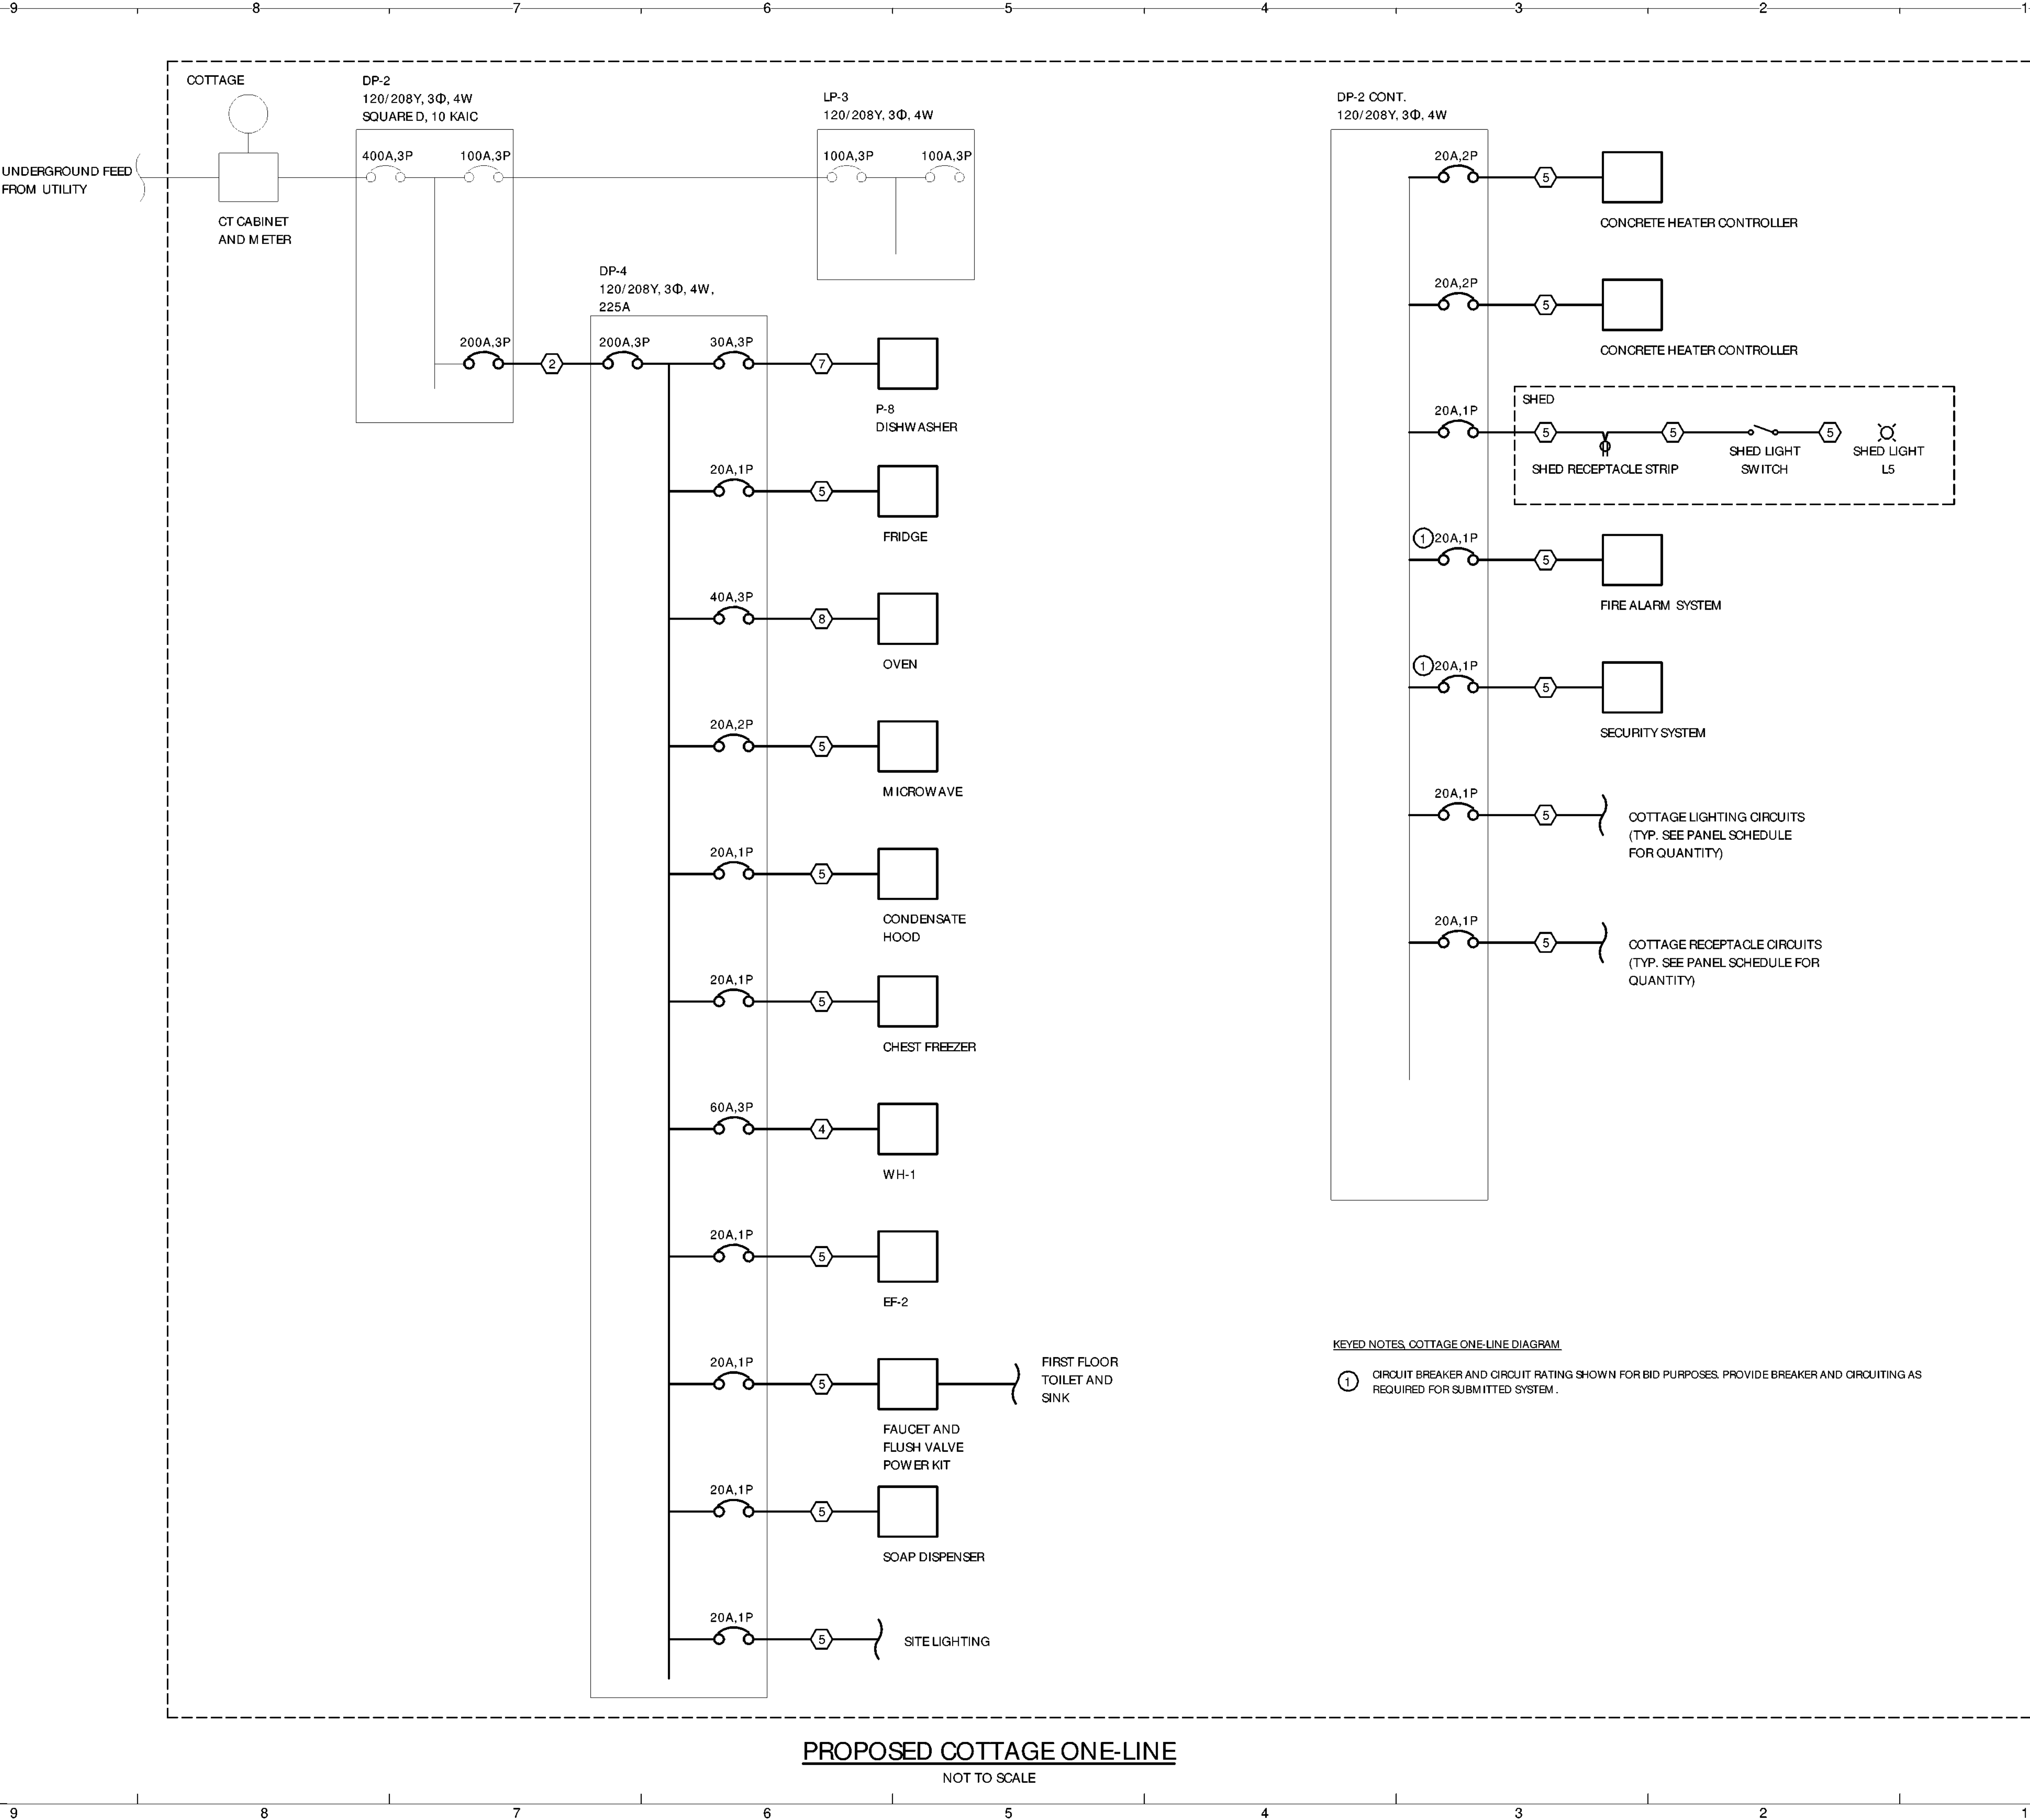

PROPOSED COTTAGE ONE-LINE
NOT TO SCALE

KEYED NOTES, COTTAGE ONE-LINE DIAGRAM

- ① CIRCUIT BREAKER AND CIRCUIT RATING SHOWN FOR BID PURPOSES. PROVIDE BREAKER AND CIRCUITING AS REQUIRED FOR SUBMITTED SYSTEM.

NEW YORK
STATE OF
OPPORTUNITY.

**Parks, Recreation
and Historic Preservation**

Governor Andrew M. Cuomo

Commissioner Erik Kulesseid

Architect:
Saratoga Associates
21 Congress Street, Suite 201
Saratoga Springs, NY 12866

Engineer:
Barton and Loguidice
443 Electronics Parkway
Liverpool, NY 13088

Exhibit Designer:
AMAZE DESIGN
PO Box 51905
Boston, MA 02205-9761

SARATOGA ASSOCIATES
Landscape Architects, Architects,
Engineers, and Planners, P.C.

Barton & Loguidice

amaze DESIGN

NYS OPRHP Taconic Region
9 Old Post Rd, PO Box 308
Staatsburg, New York 12580
(845) 889-4100
Regional Director: Linda Cooper
District Manager: Garrett Jobson

Project Title:
Philipse Manor Hall State Historic Site
Construction of Elevator/Restroom
Addition, Interior and Exterior
Rehabilitation and Site Enhancements

Project Location:
29 Warburton Ave, Yonkers, NY, 10701

Key Plan

REVISIONS		
Rev No	Description	Date

Drawn By:
TRL

Design By:
TRL

Checked By:
JWC

Approved By:
TWB

Date:
5/28/2021

Seal and Signature

E100

Sheet Title:
ELECTRICAL
COTTAGE
ONE-LINE
DIAGRAM

Bid Documents

Project Number:
1299.029.001

Sheet: