



Commissioner Erik Kulleseid

IT IS A VIOLATION OF STATE EDUCATION LAW FOR ANY PERSON, UNLESS UNDER THE DIRECTION OF A LICENSED ARCHITECT/ENGINEER TO ALTER THIS DOCUMENT IN ANYWAY. ALTERATIONS MUST HAVE THE SEAL AFFIXED ALONG WITH A DESCRIPTION OF THE ALTERATIONS, DATE AND ARCHITECT'S/ENGINEER'S SIGNATURE.  
COPYRIGHT © 2021

**SARATOGA ASSOCIATES**  
Landscape Architects, Architects,  
Engineers, and Planners, P.C.

**Barton  
& Loguidice**

amaze DESIGN

**NYC Office - Atlantic Region**  
9 Old Post Rd, PO Box 308  
Staatsburg, New York 12580  
(845) 889-4100  
Regional Director: Linda Cooper  
District Manager: Garrett Jobson

**Project Title:**  
Philipse Manor Hall State Historic Site  
Construction of Elevator/Restroom  
Addition, Interior and Exterior  
Rehabilitation and Site Enhancements

**Project Location:**  
29 Warburton Ave, Yonkers, NY, 10701

### Key Plan

## REVISIONS

[illegible]

*TRL*

*TRL*

JWC

TWB

5/28/

Sheet Title:

LESTER  
COTTAGE


ALARM

[illegible]

	Bid Doc
--	---------

1299.02

100

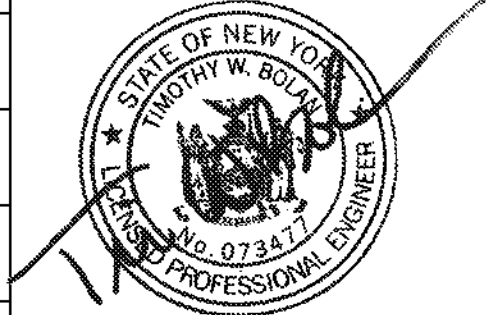

Drawing Number.


1. *Journal of the American Medical Association*, 2000; 284: 2689-2695.

# EIC

 1. *Journal of the American Medical Association*, 2000; 284: 2689-2695.

1. *Journal of the American Medical Association*, 2000; 284: 2689-2695.

\_\_\_\_\_



## COTTAGE BASEMENT FIRE ALARM PLANS

SCALE: 1/4" = 1'-0"

## COTTAGE FIRE ALARM PLAN

SCALE: 1/4" = 1'-0"

GENERAL NOTES, COTTAGE ATTIC AREA

1. PROVIDE 4 SMOKE DETECTORS IN COTTAGE ATTICE AREA