



H
G
F
E
D
C
B
A

 
6/4/2021 3:59:10 PM

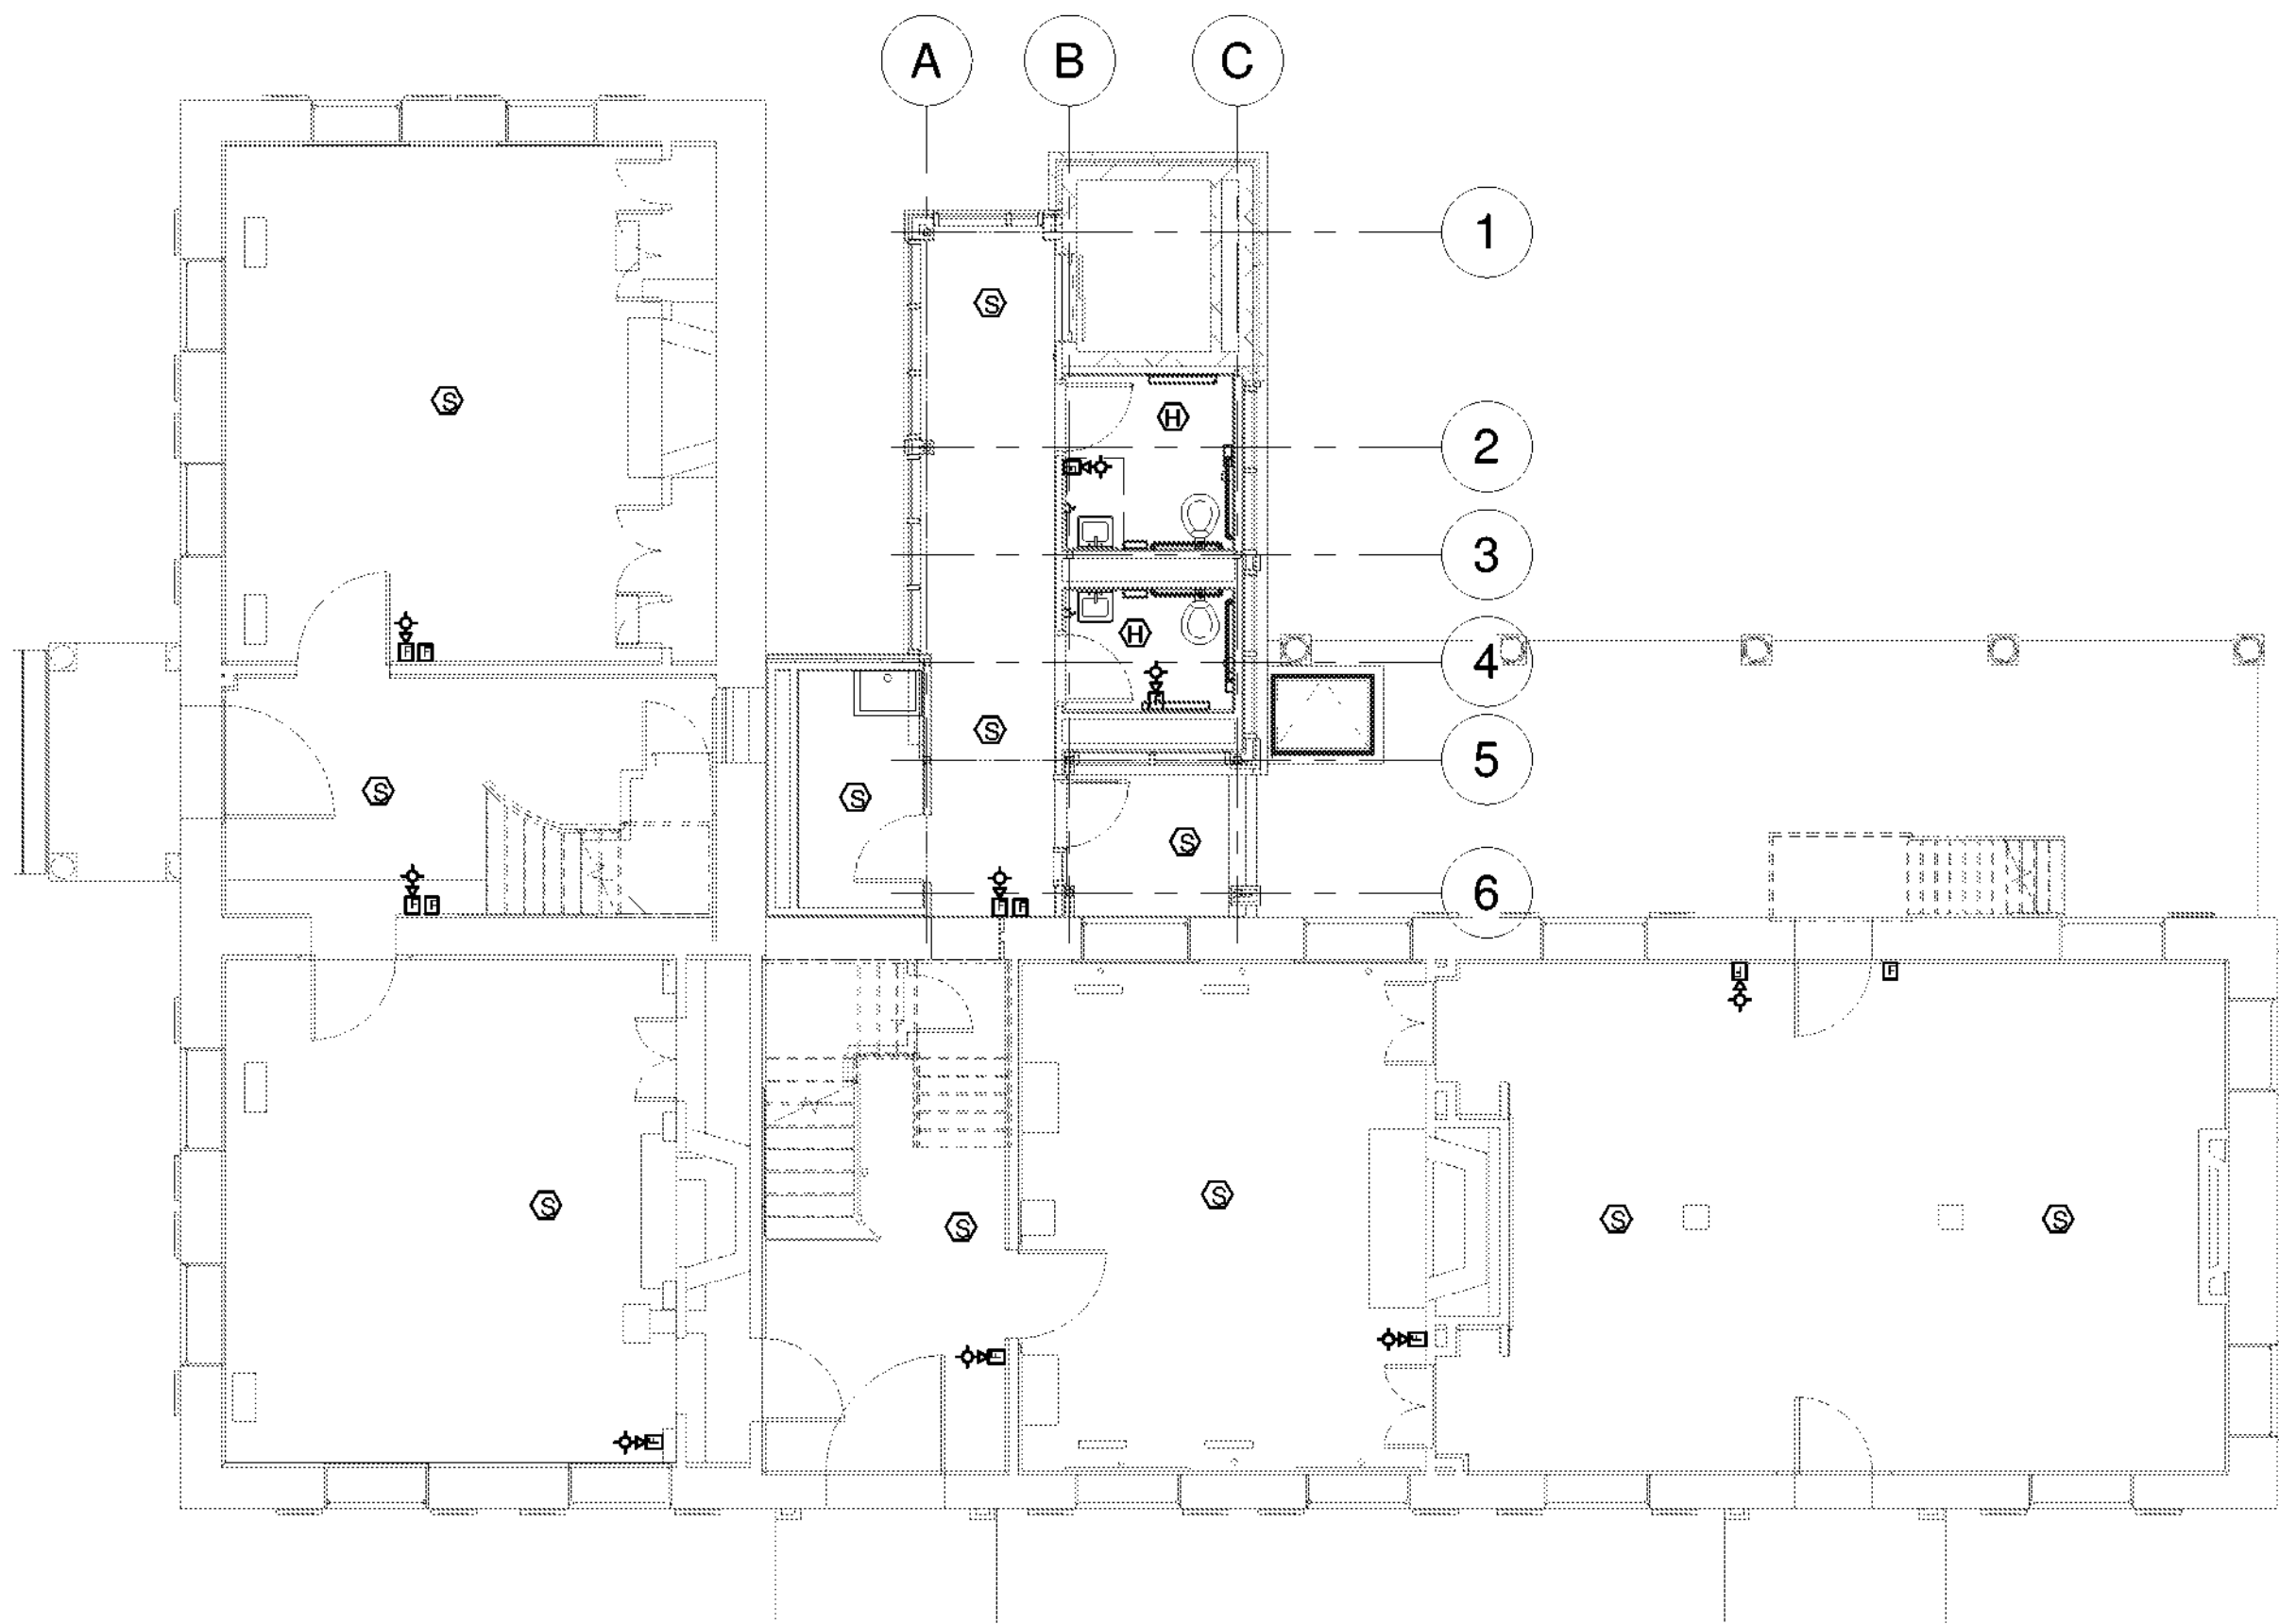

FIRST FLOOR FIRE ALARM PLAN
SCALE: 1/8" = 1'-0"

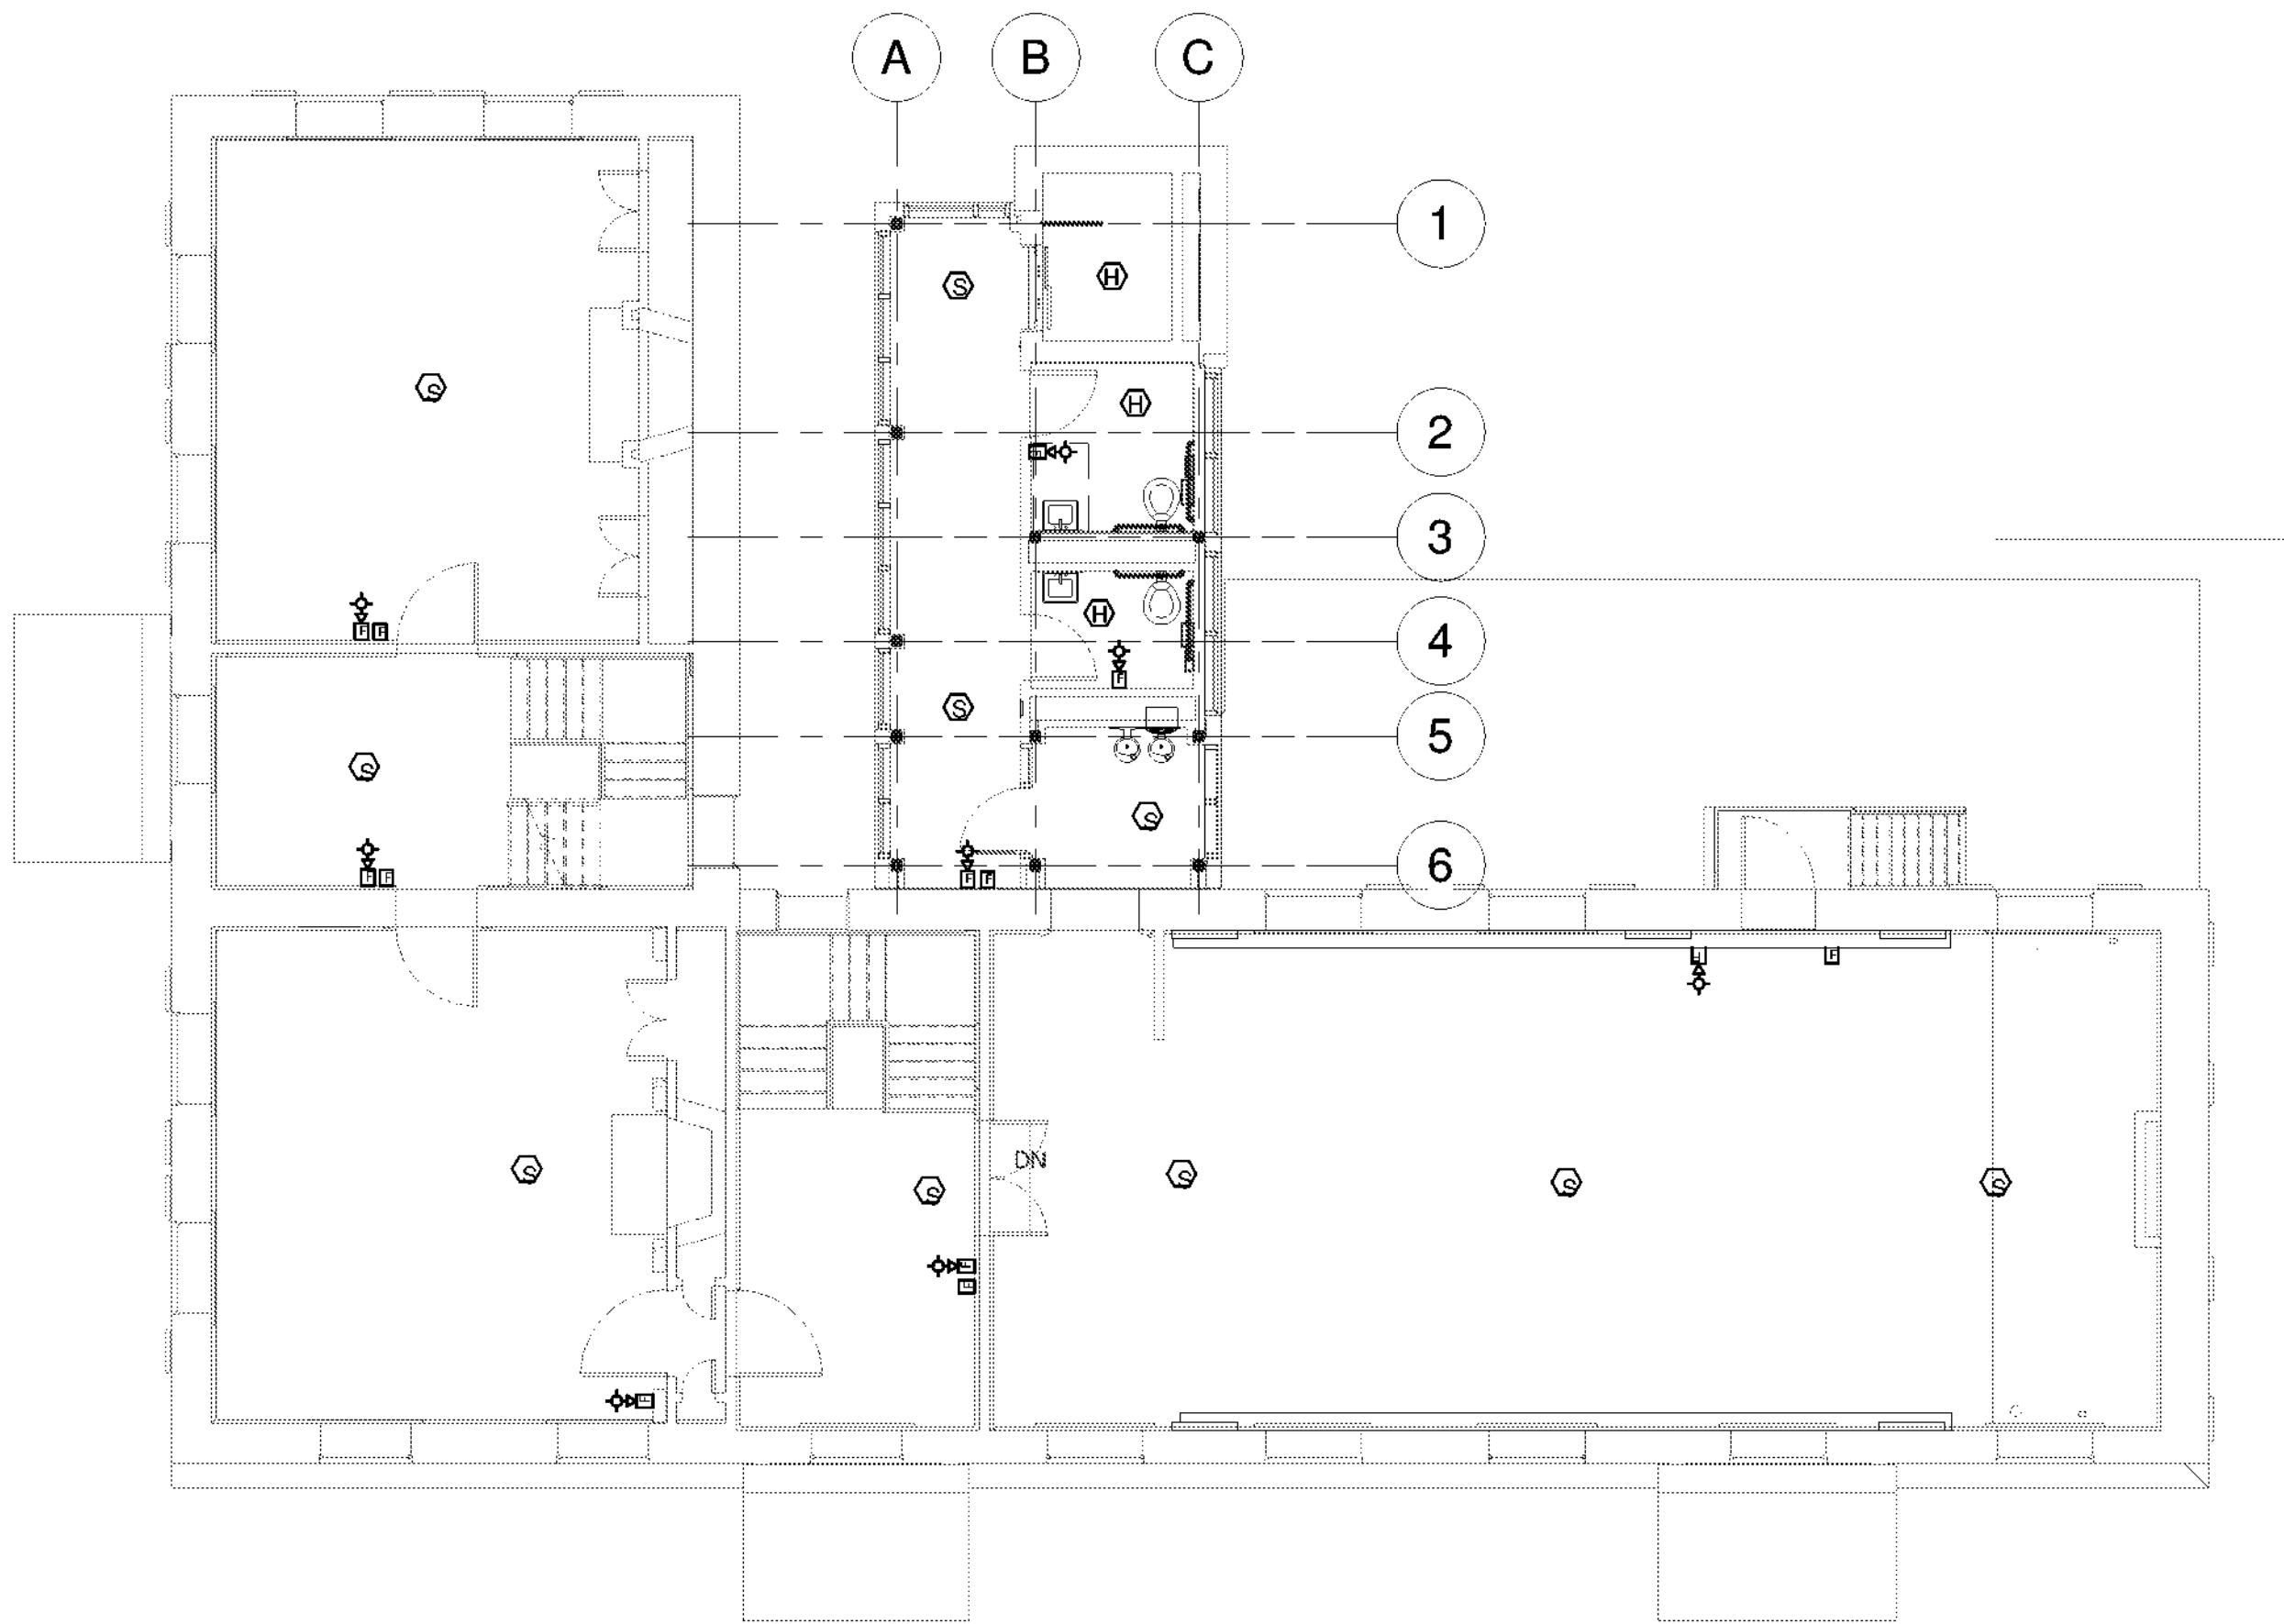

SECOND FLOOR FIRE ALARM PLAN
SCALE: 1/8" = 1'-0"



Architect:
Saratoga Associates
21 Congress Street, Suite 201
Saratoga Springs, NY 12866

SARATOGA ASSOCIATES
Landscape Architects, Architects,
Engineers, and Planners, P.C.

Engineer:
Barton and Loguidice
443 Electronics Parkway
Liverpool, NY 13088

Barton & Loguidice

Exhibit Designer:
AMAZE DESIGN
PO Box 51905
Boston, MA 02205-9761

amaze DESIGN

NYS OPRHP Taconic Region
9 Old Post Rd, PO Box 308
Staatsburg, New York 12580
(845) 889-4100
Regional Director: Linda Cooper
District Manager: Garrett Jobson

Project Title:
Philipse Manor Hall State Historic Site
Construction of Elevator/Restroom
Addition, Interior and Exterior
Rehabilitation and Site Enhancements

Project Location:
29 Warburton Ave, Yonkers, NY, 10701

Key Plan

REVISIONS

Rev No	Description	Date

Drawn By:
TRL

Design By:
TRL

Checked By:
JWC

Approved By:
TWB

Date:
5/28/2021

Sheet Title:
**ELECTRICAL
MUSEUM FIRE
ALARM PLANS 2**

Bid Documents

Seal and Signature


Drawing Number:
E115

Project Number:
1299.029.001

Sheet: