


GENERAL NOTES:

A. ALL CONDENSATE PIPING TO BE 3/4" UNLESS OTHERWISE NOTED

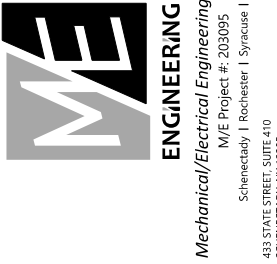

DATE: 9/17/2020
REVISION: 10/11/2020
ADDENDUM 1

PROJECT NO. 2020095
DESIGNED BY: CUE
DRAWN BY: CUE
CHECKED BY: PCA
SCALE: AS NOTED
NOTES:


FIRST FLOOR
MECHANICAL PIPING PLAN

HARRIS A. SANDERS
ARCHITECTS, P.C.
252 WASHINGTON AVENUE, ALBANY, NEW YORK 12210

L'DOR ADULT CARE FACILITY
156 WEST CLARKSTOWN ROAD
NEW CITY, N.Y. 10956

SHEET NO.

M202

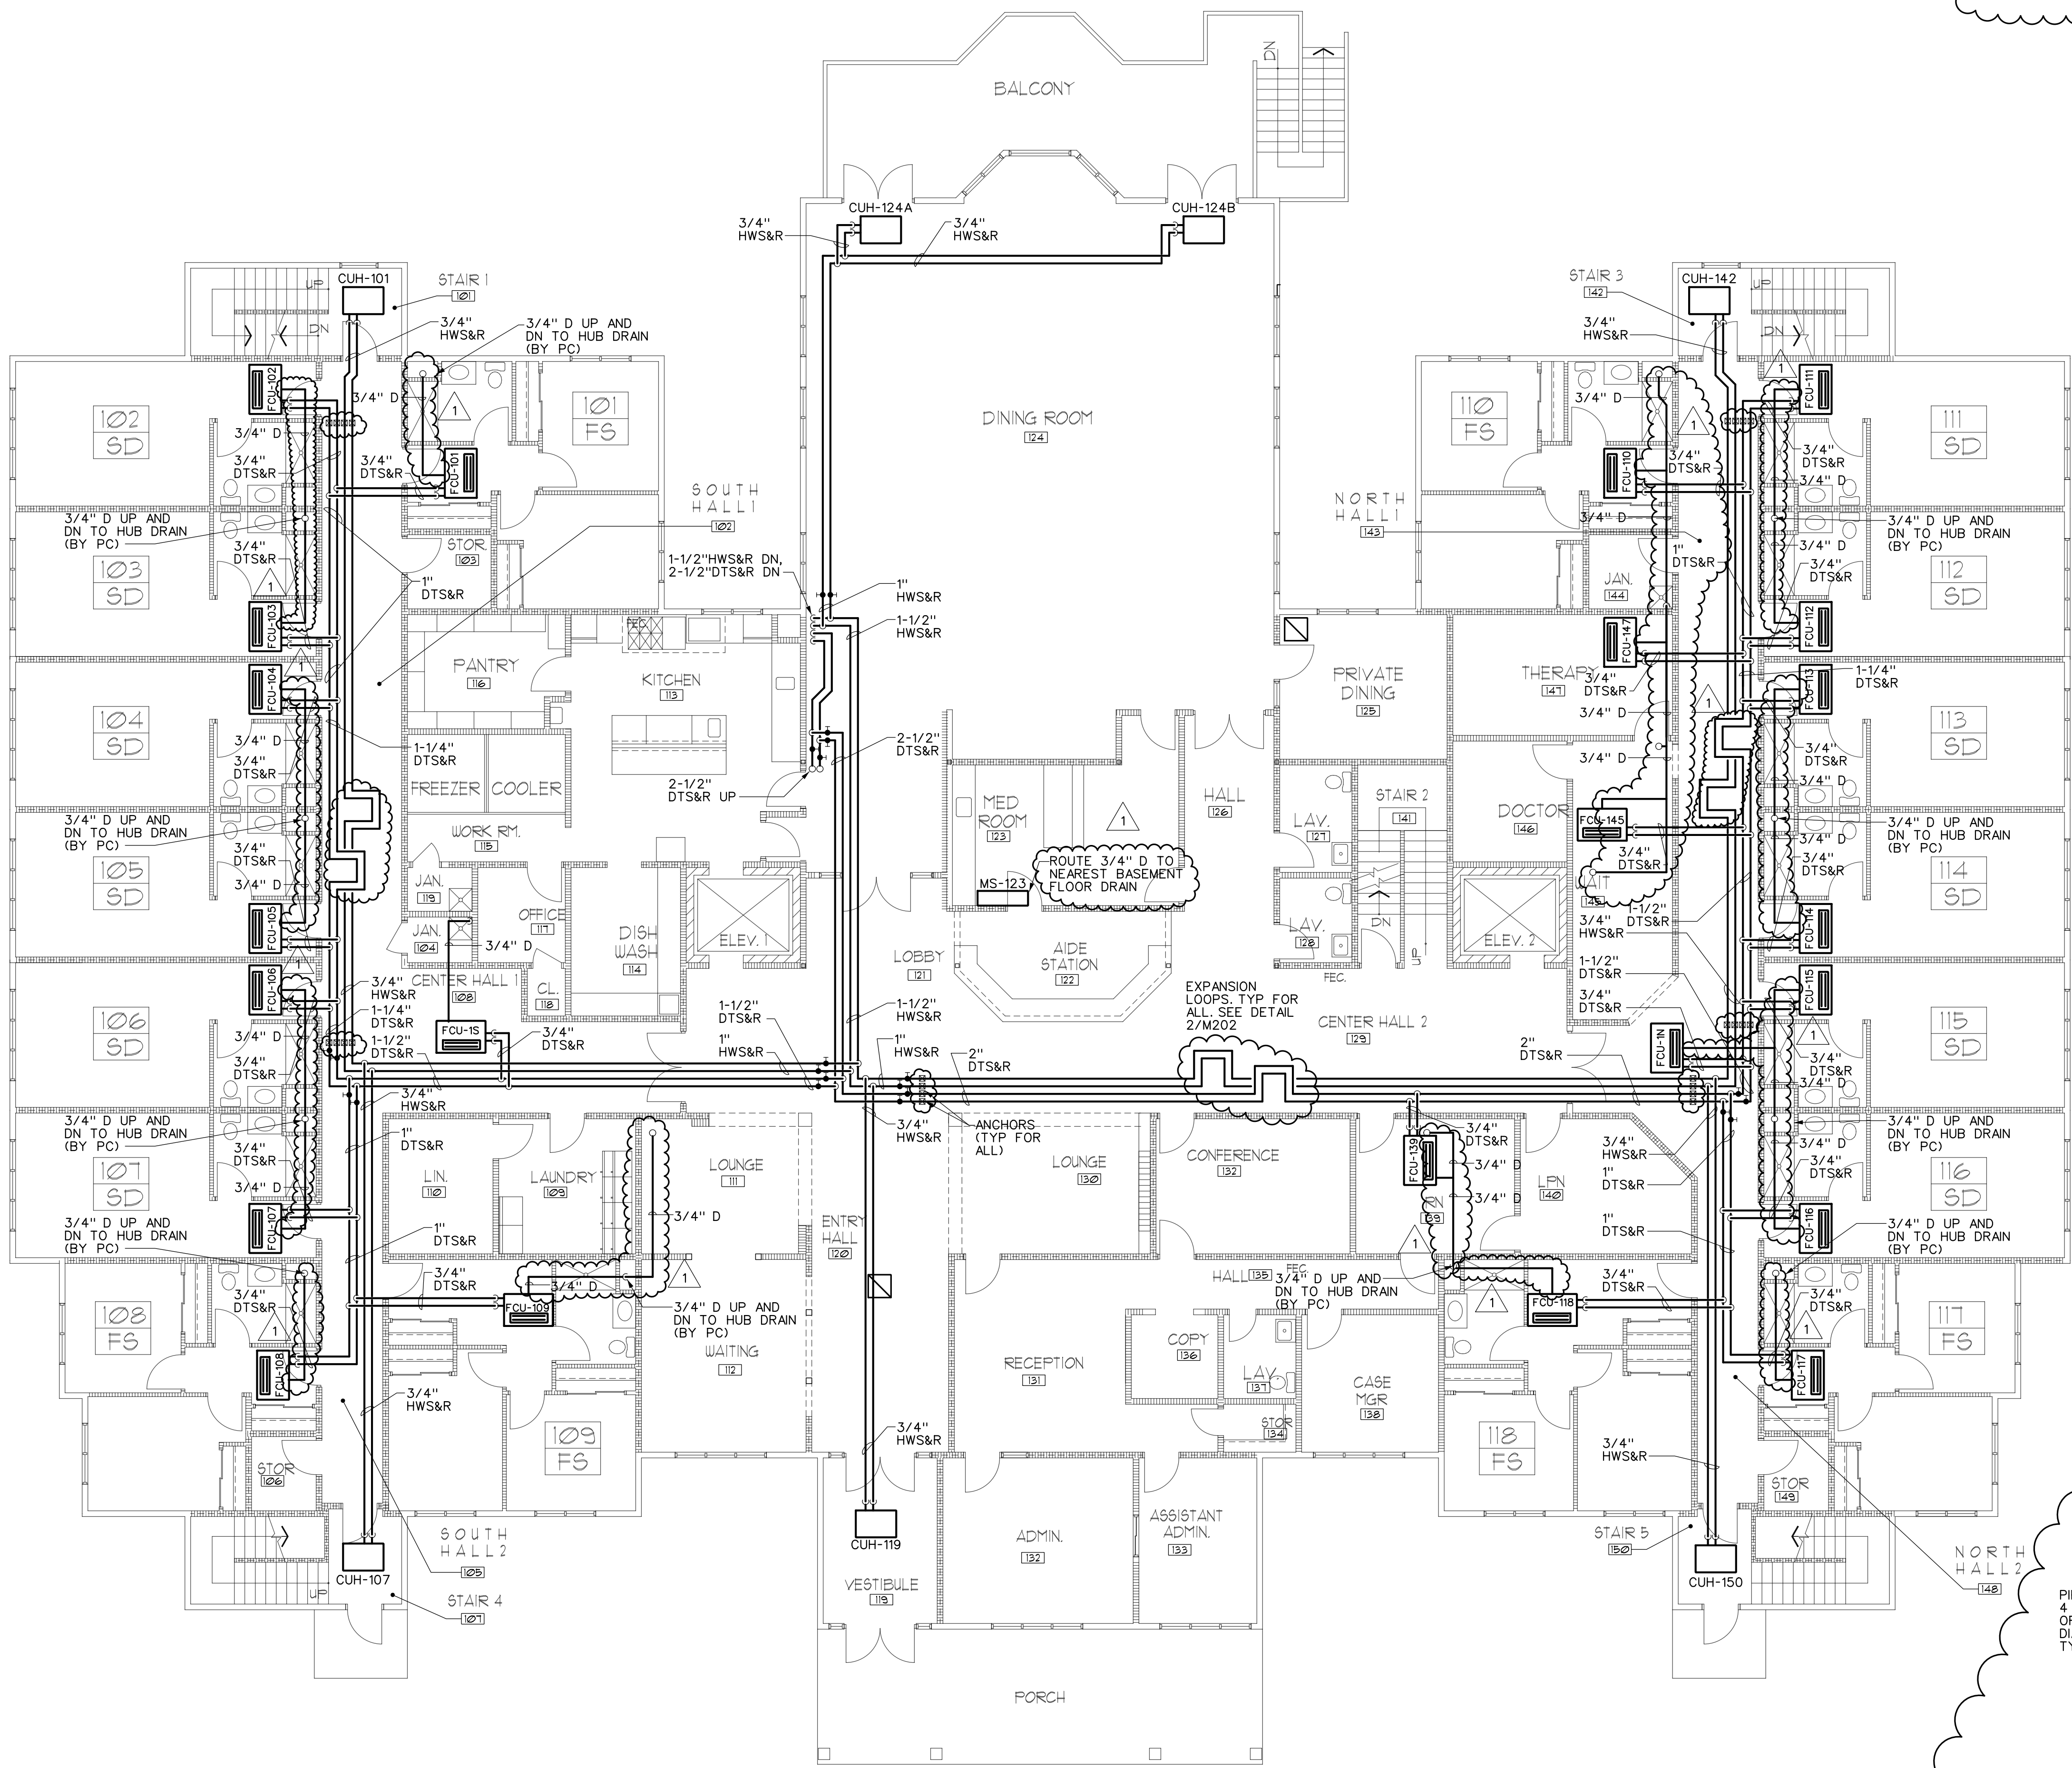

1 FIRST FLOOR MECHANICAL PIPING PLAN
SCALE: 1/8"=1'-0"

2 PRE-FAB EXPANSION LOOP DETAIL
SCALE: NTS

PIPE GUIDE WITHIN
4 PIPE DIAMETERS
OF LOOP AND 14 PIPE
DIAMETERS OF LOOP
TYP. BOTH SIDES.

PLAN VIEW

NOTES:
1. EXPANSION LOOP SHALL BE METRALOOP BY
METRAFLEX, OR APPROVED EQUAL, ALLOWING
FOR AXIAL MOVEMENT OF 1/4". INSTALL PER
MANUFACTURER'S RECOMMENDATIONS.

BID SET 9-18-20