



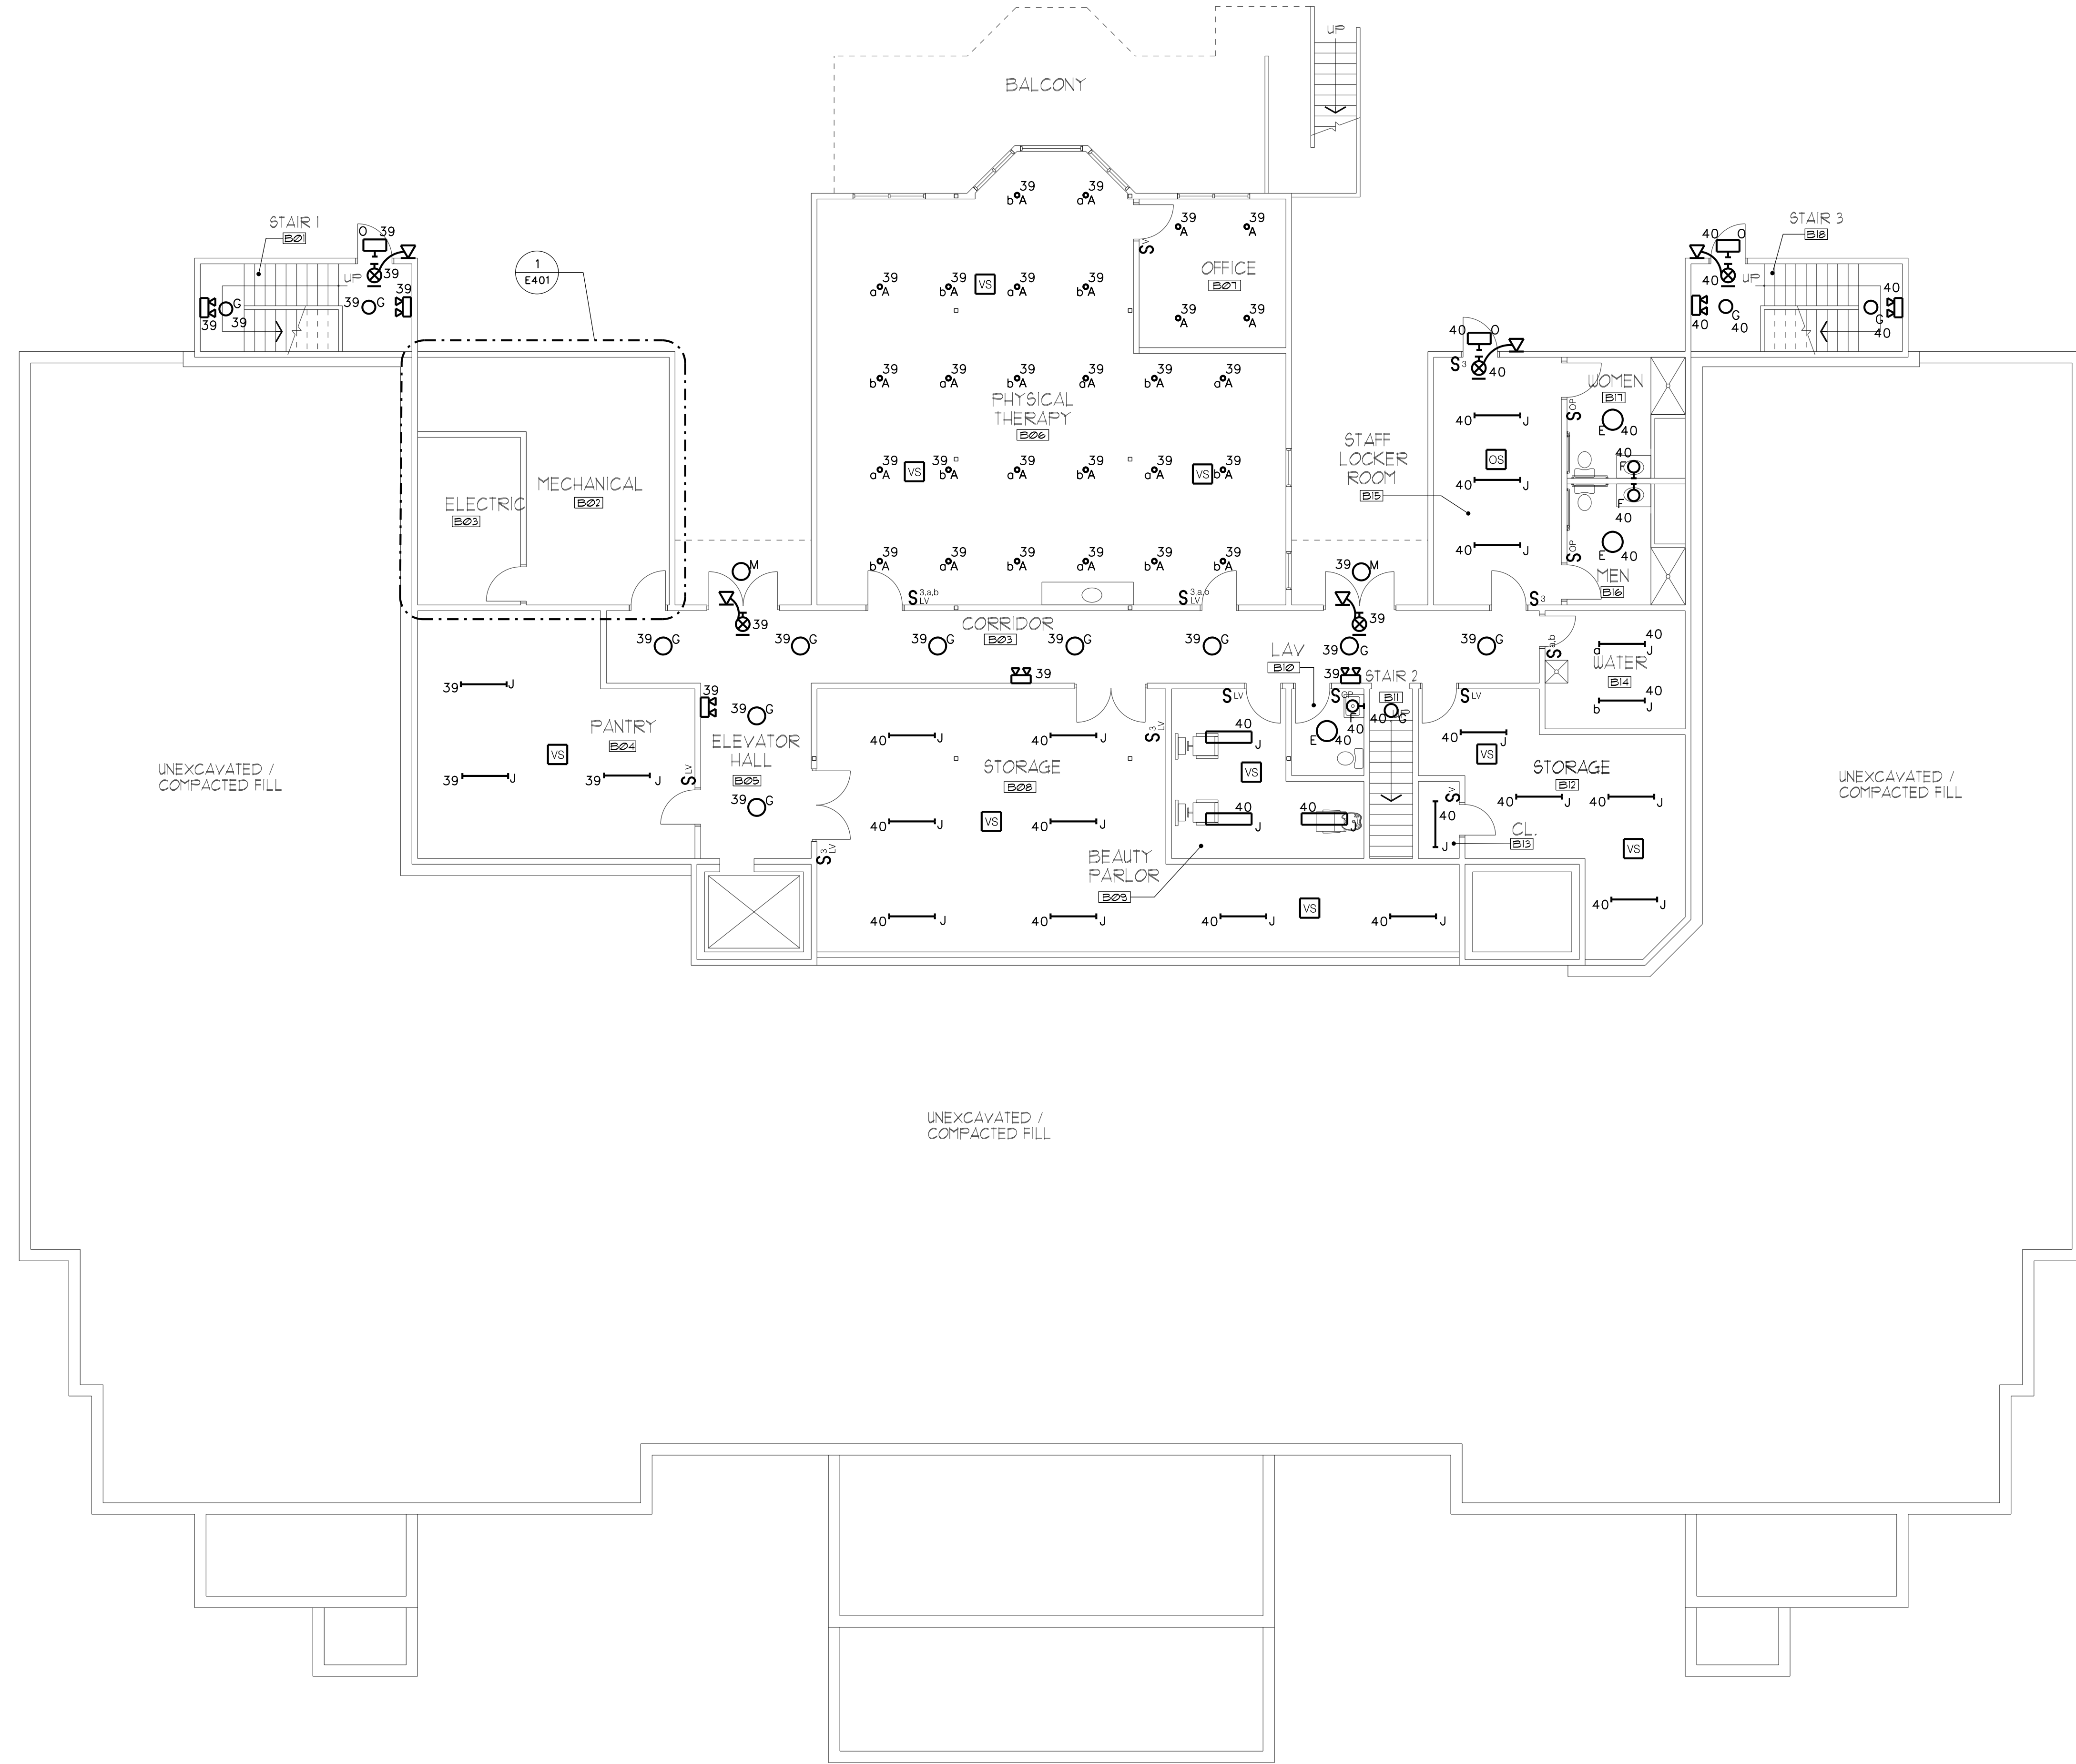

- GENERAL NOTES:
- A. UNLESS OTHERWISE NOTED, ALL BRANCH CIRCUIT WIRING SHALL BE (2)-12 WITH (1)-12 GROUND, TYPE NM CABLE CIRCUIT TO PANEL 'PB-1'. ALL BRANCH CIRCUIT WIRING WITHIN MECH/ELEC SPACES AND OTHER UNFINISHED SPACES SHALL BE TYPE MC CABLE.
 - B. REFER TO ONE-LINE DIAGRAM, SCHEDULES AND DETAILS FOR ADDITIONAL INFORMATION AND REQUIREMENTS.
 - C. ALL EXTERIOR BUILDING MOUNTED LIGHT FIXTURES SHALL BE CIRCUITED TO PANEL 'PB-1' AND CONNECTED TO TIME CLOCK CONTROLS.
 - D. REFER TO ENLARGED PLANS FOR TYPICAL DEVICE LAYOUT AND ADDITIONAL REQUIREMENTS.
 - E. ALL LUMINAIRES SHALL BE CIRCUITED TO PANEL 'PB-1', UNLESS OTHERWISE NOTED.

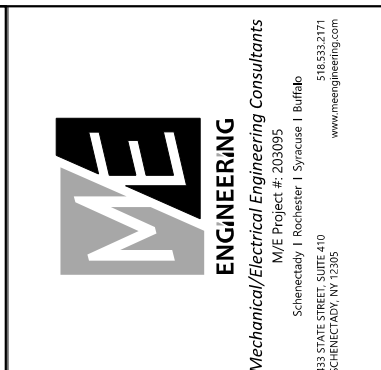

DATE	9/18/2020
REVISION	
PROJECT NO.	2020095
DESIGNED BY	CUE
DRAWN BY	CUE
CHECKED BY	PSA
SCALE	AS NOTED
NOTES	

BASEMENT ELECTRICAL
LIGHTING PLAN

HARRIS A. SANDERS
ARCHITECTS, P.C.
252 WASHINGTON AVENUE, ALBANY, NEW YORK 12210

L'DOR ADULT CARE FACILITY
156 WEST CLARKSTOWN ROAD
NEW CITY, N.Y. 10956



SHEET NO.
E201

1 BASEMENT FLOOR PLAN
E201 SCALE: 1/8"=1'-0"

0 4' 8' 16'

NORTH